


# BARAYONG ELEM. SCHOOL CLASSROOM 1

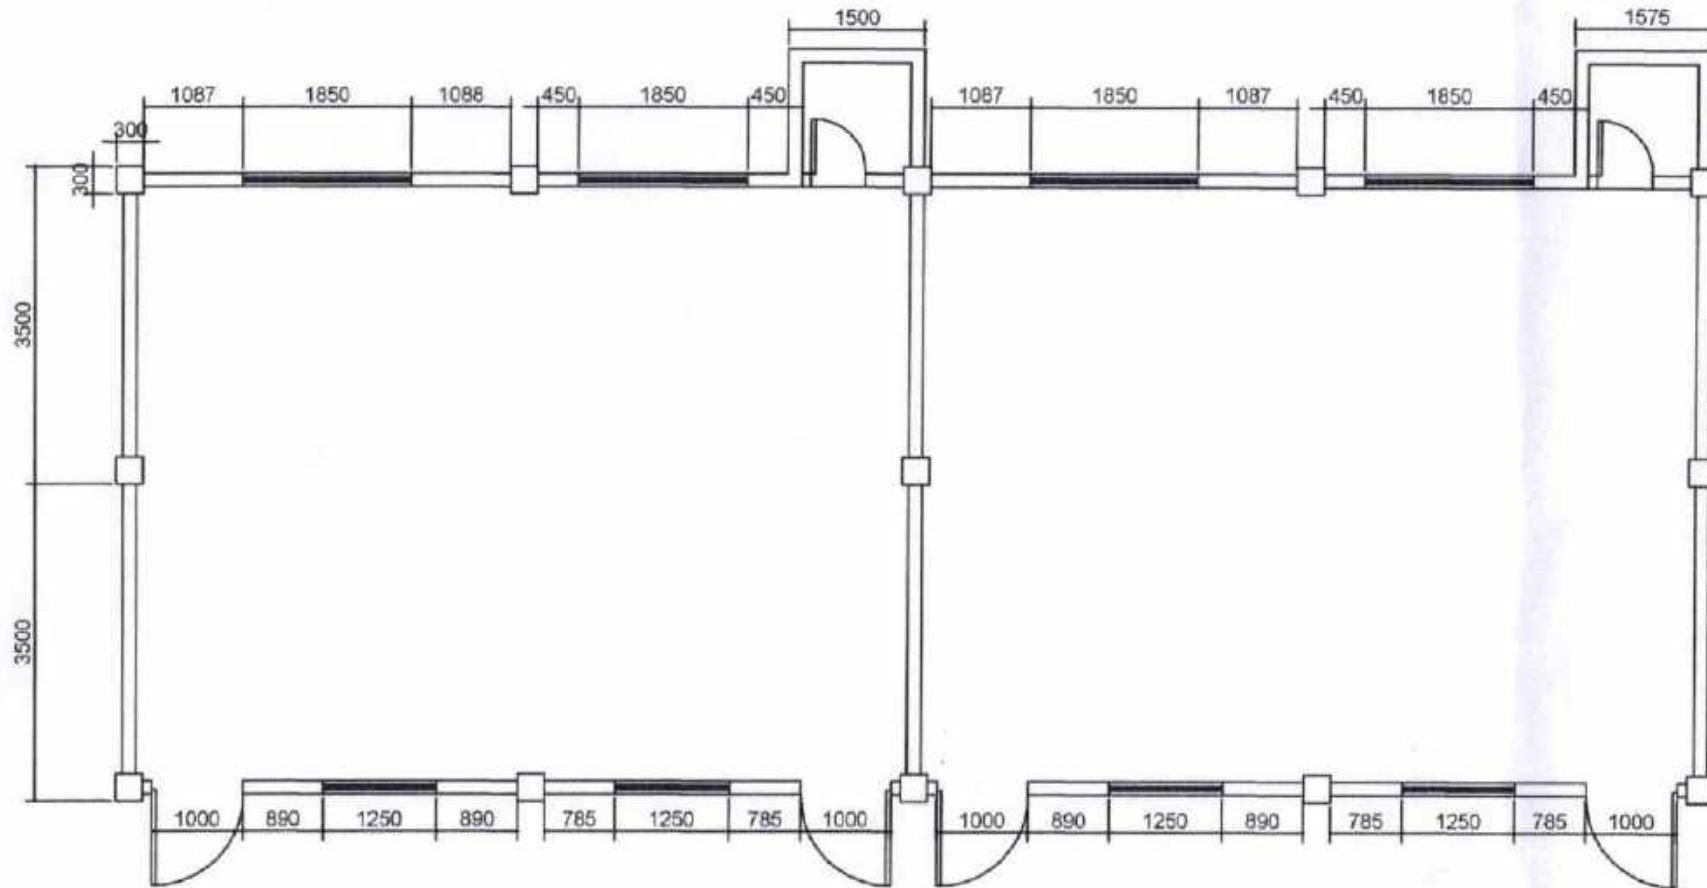

**FLOOR PLAN (EXISTING)**  
SCALE: N T S




SORSOGON CITY


**CITY ENGINEER'S  
OFFICE**

PROJECT TITLE:	DRAWN BY:	RECOMMENDING APPROVAL	APPROVED BY:
REPAIR/ IMPROVEMENT OF MULTI PURPOSE HALL (CLASSROOM 1) BARAYONG ES			
LOCATION: BRGY. BARAYONG, WEST DISTRICT, SORSOGON CITY		ROBERTO DOMESTICO CIC-CEO	HON. MA. ESTER E. HAMOR CITY MAYOR




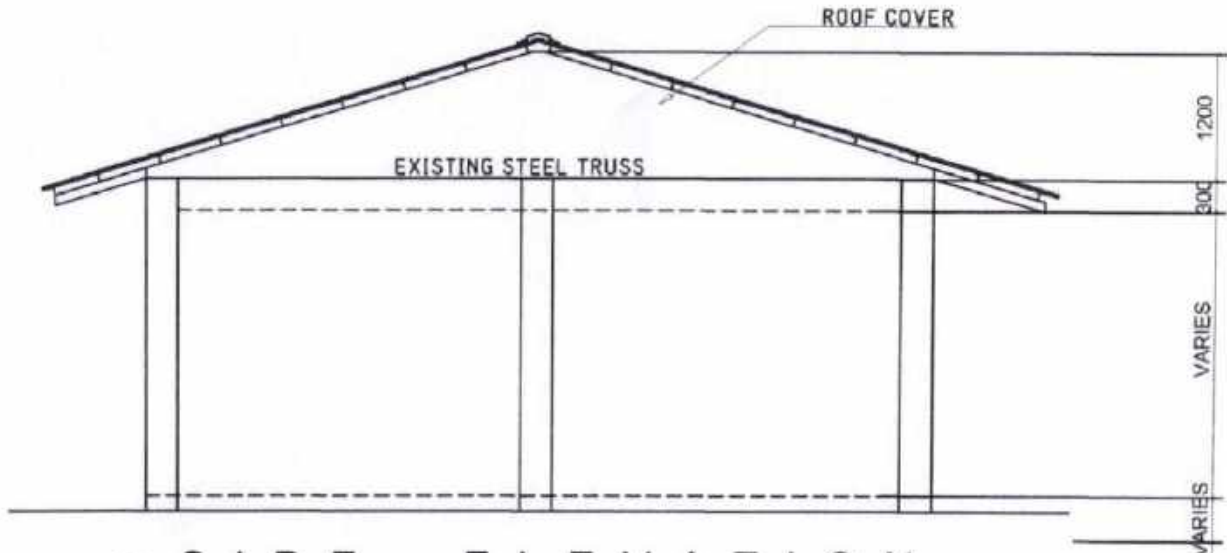

**SIDE ELEVATION**  
SCALE: N T S

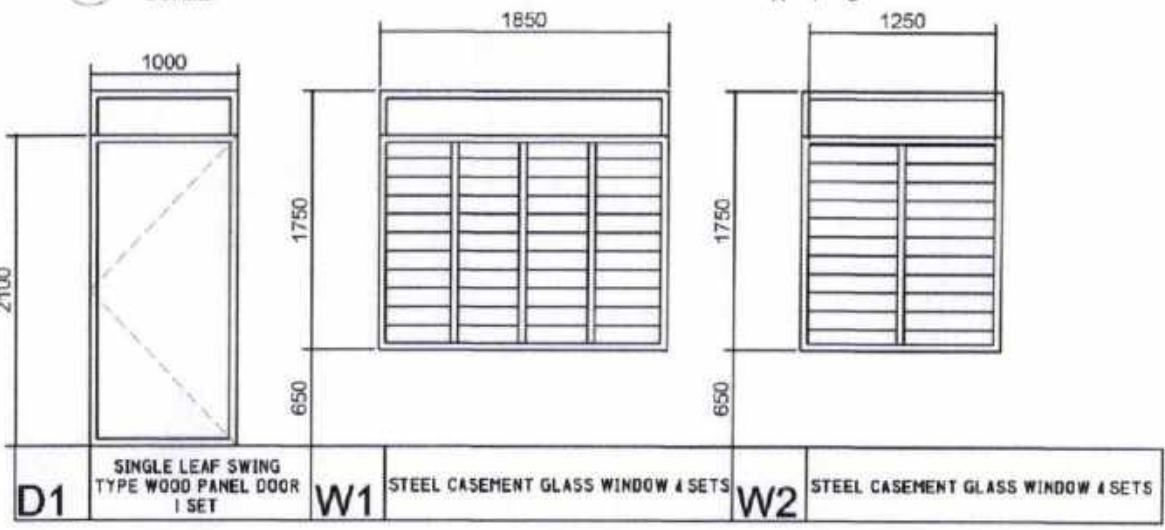

**DOOR & WINDOW SCHEDULE**  
SCALE: N T S

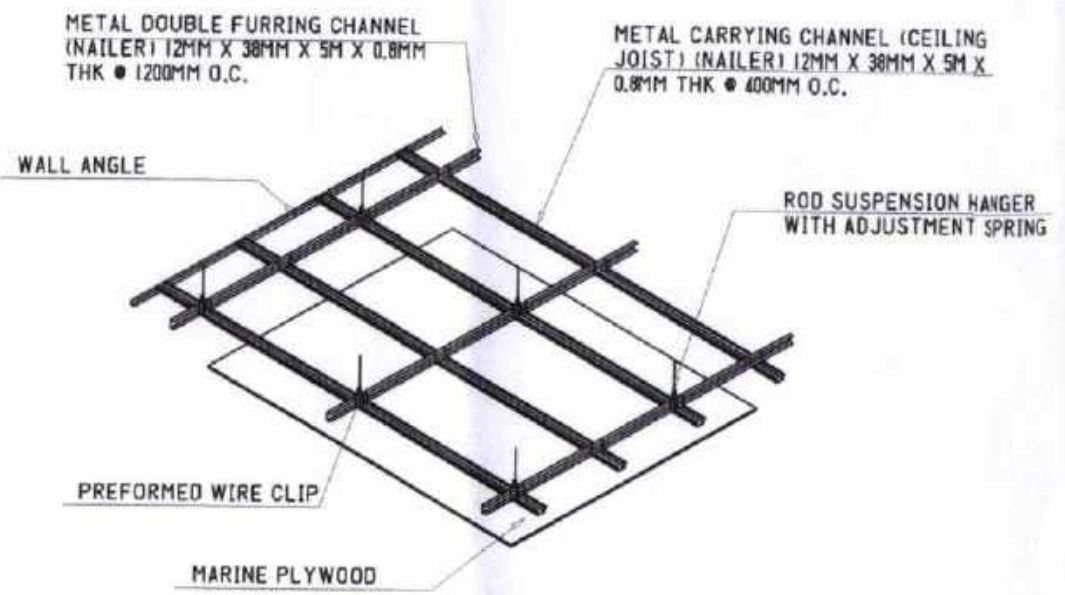



**CEILING DET.**  
SCALE: N T S



SORSOGON CITY  
**CITY ENGINEER'S OFFICE**

PROJECT TITLE:	DRAWN BY:	RECOMMENDING APPROVAL	APPROVED BY:
REPAIR/ IMPROVEMENT OF MULTI PURPOSE HALL (CLASSROOM 1) BARAYONG ES			
LOCATION: BRGY. BARAYONG, WEST DISTRICT, SORSOGON CITY		PROJ. & DESIGNER, CE OIC-CEO	HON. MA. ESTER E. HAMOR CITY MAYOR

PLEASE

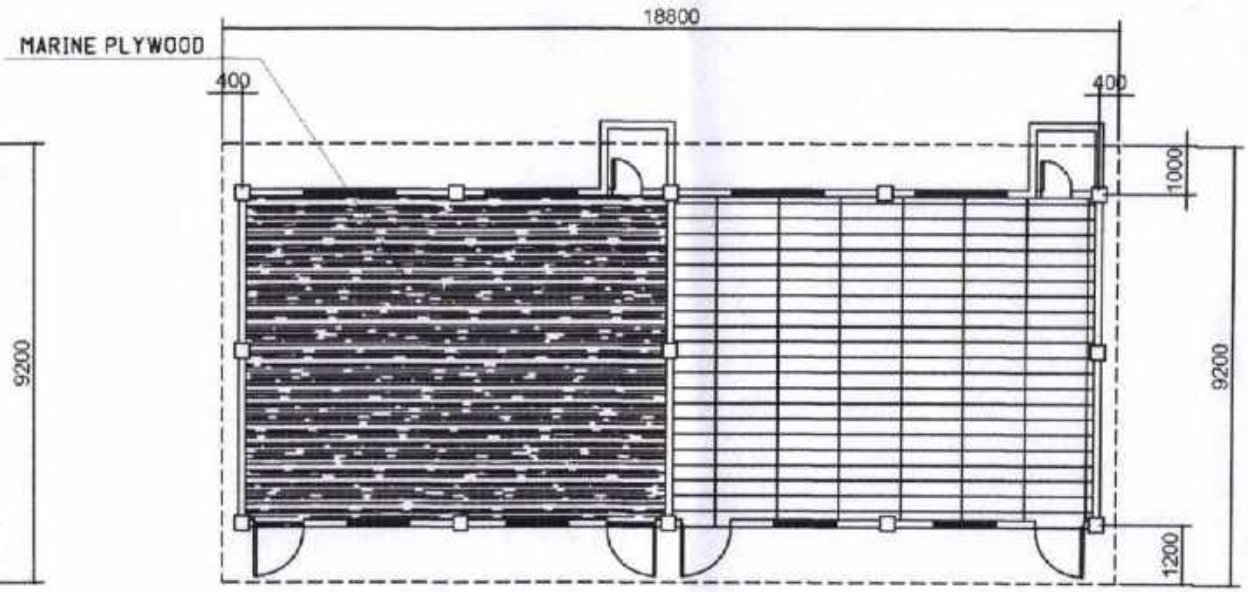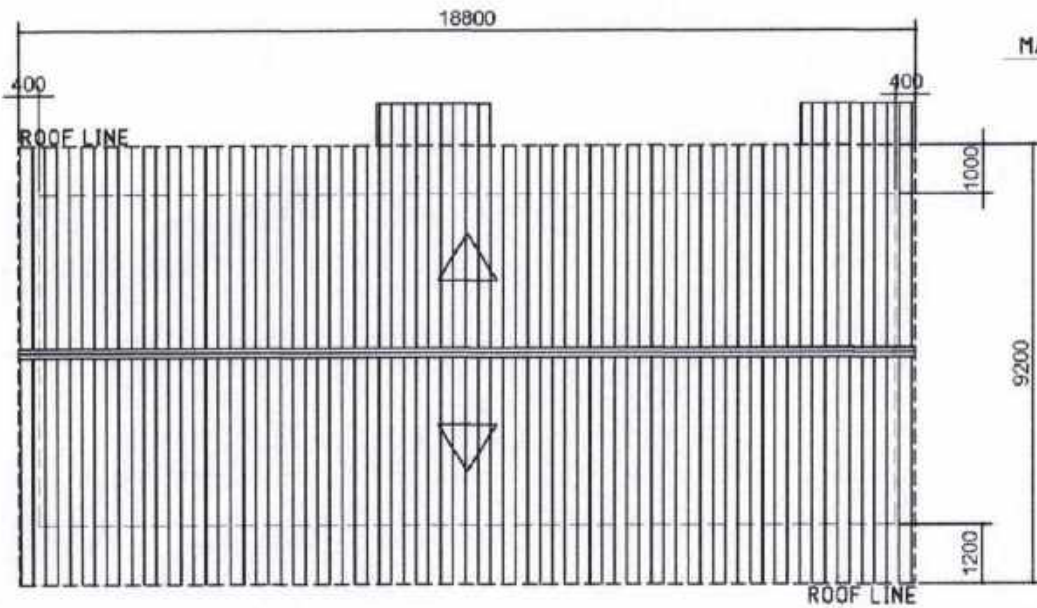



ROOF PLAN  
SCALE: N T S


ROOF FRAMING PLAN  
SCALE: N T S



SORSOGON CITY  
CITY ENGINEER'S  
OFFICE

PROJECT TITLE:	DRAWN BY:	RECOMMENDING APPROVAL	APPROVED BY:
REPAIR/ IMPROVEMENT OF MULTI PURPOSE HALL (CLASSROOM 1) BARAYONG ES		 ENGR. D. DAMER, CE OIC-CEO	 HON. MA. ESTER E. HAMOR CITY MAYOR
LOCATION: BRGY. BARAYONG, WEST DISTRICT, SORSOGON CITY			

PLEASE

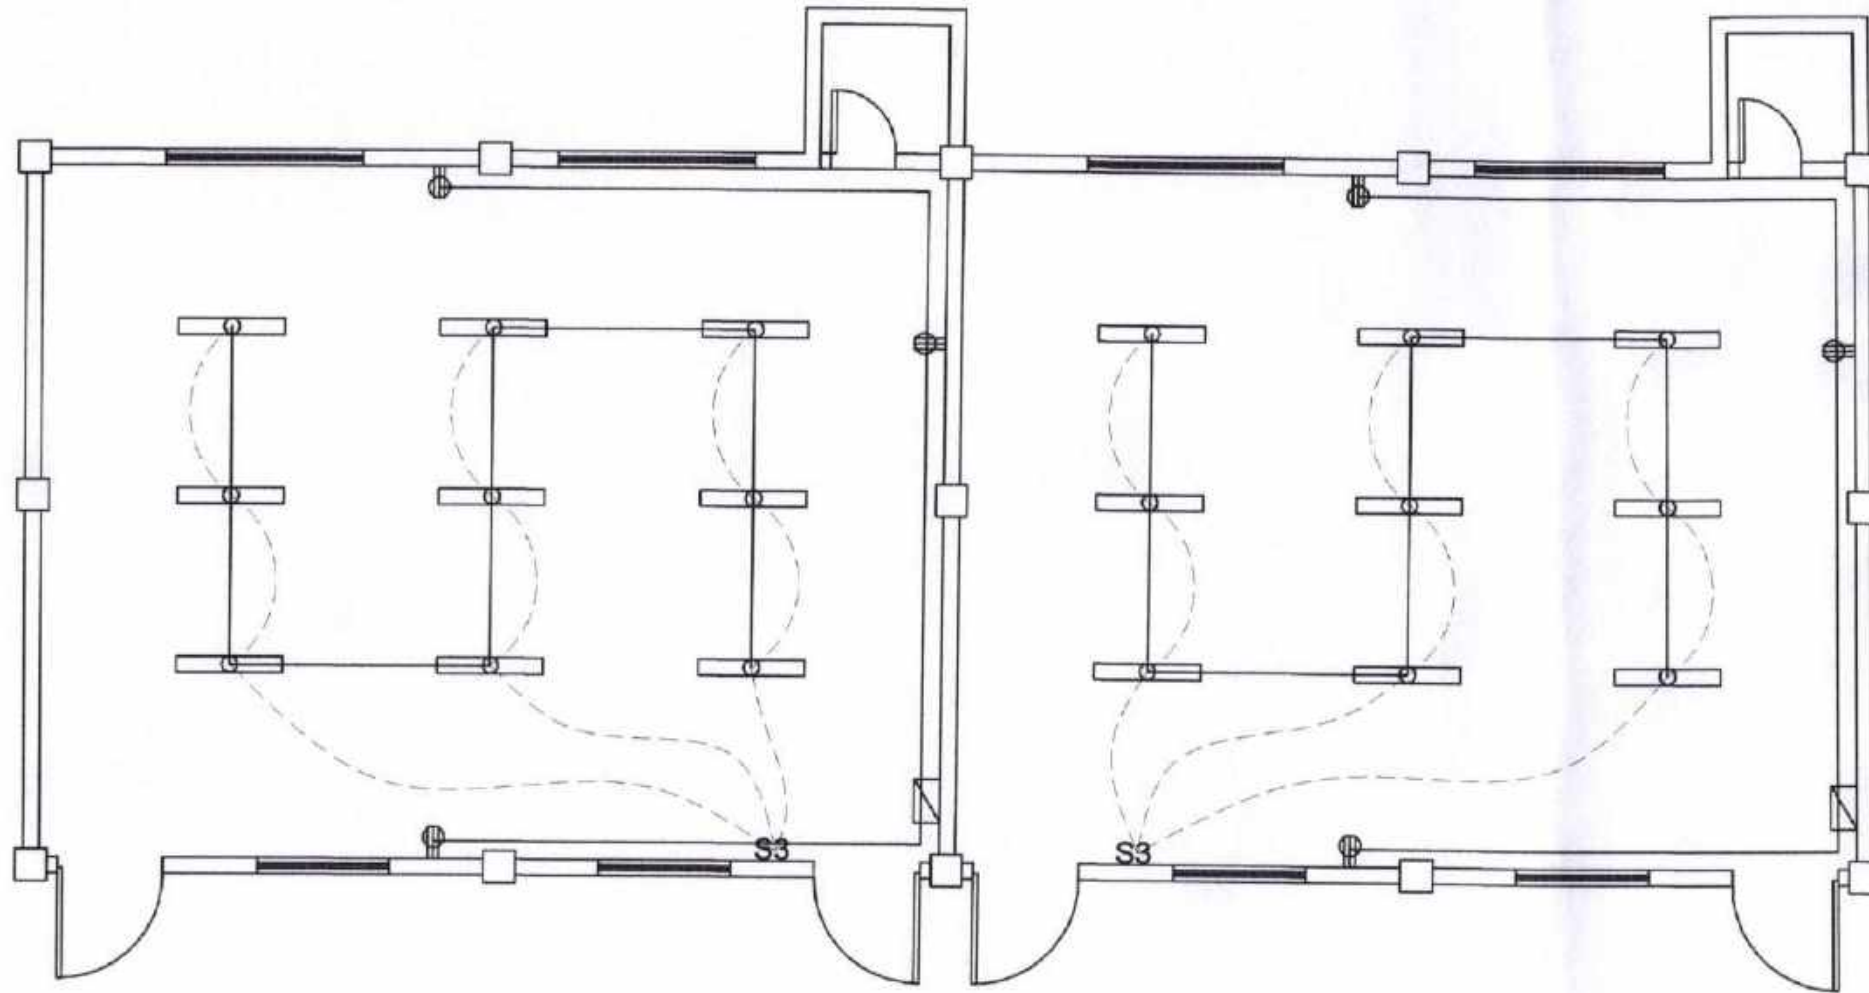


○ LIGHTING LAYOUT  
SCALE: N T S





SORSOGON CITY  
CITY ENGINEER'S  
O F F I C E

PROJECT TITLE:	DRAWN BY:	RECOMMENDING APPROVAL	APPROVED BY:
REPAIR/ IMPROVEMENT OF MULTI PURPOSE HALL (CLASSROOM 1) BARAYONG ES			
LOCATION: BRGY. BARAYONG, WEST DISTRICT, SORSOGON CITY		ROSEL D. DOMER, CE OIC-CEO	HON. MA. ESTER E. HAMOR CITY MAYOR

**BARAYONG ELEMENTARY SCHOOL**  
**CLASSROOM 1 (2UNITS)**

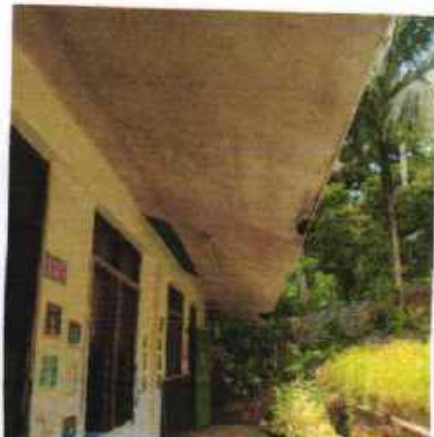

# BARAYONG ELEM. SCHOOL CLASSROOM 2

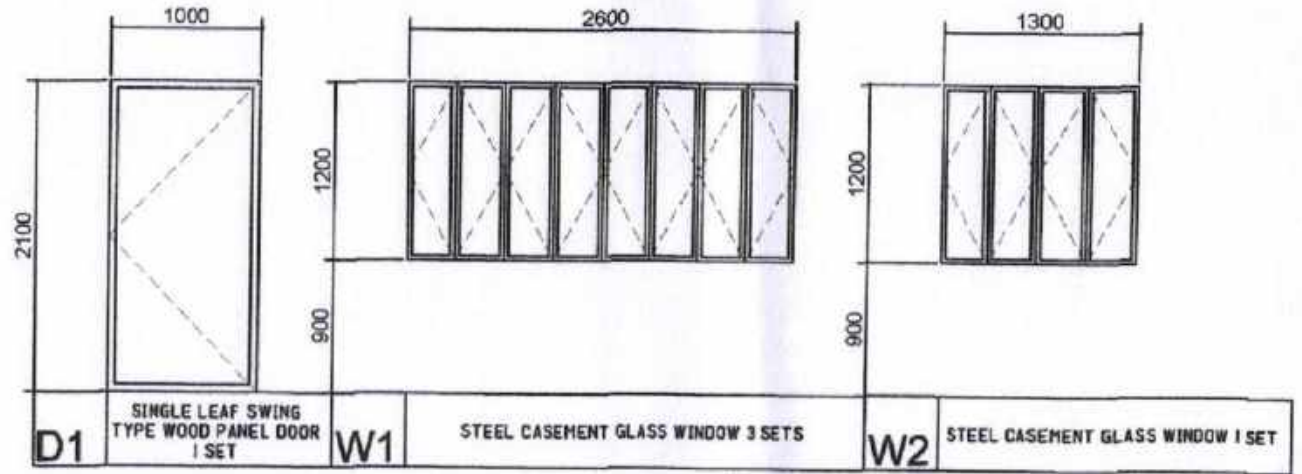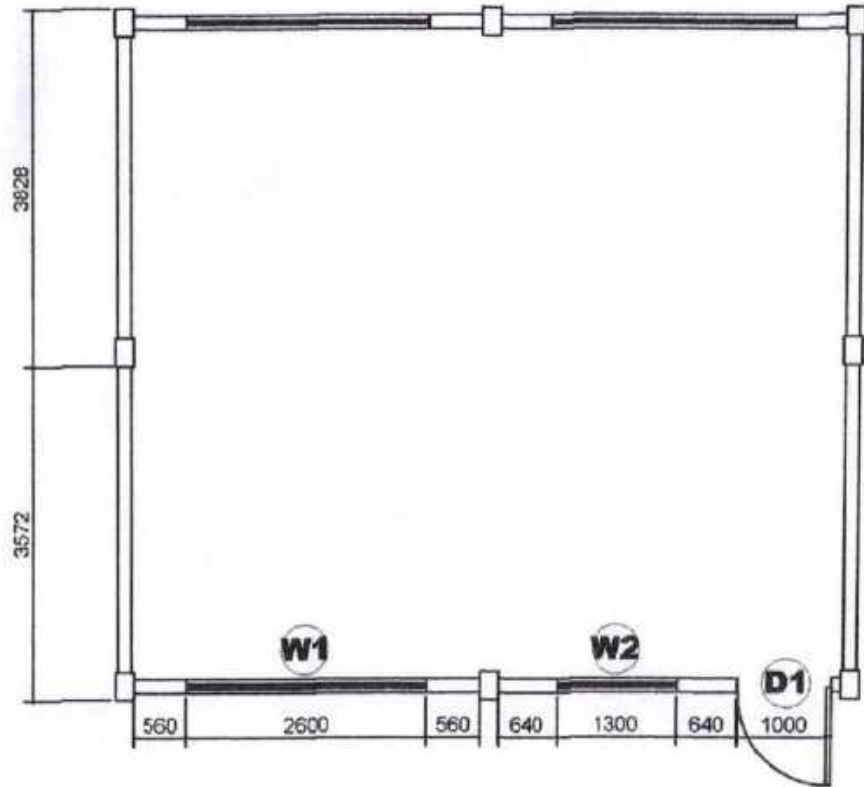

DOOR & WINDOW SCHEDULE  
SCALE: N T S



FLOOR PLAN (EXISTING)  
SCALE: N T S



SORSOGON CITY  
CITY ENGINEER'S  
OFFICE

PROJECT TITLE:	DRAWN BY:	RECOMMENDING APPROVAL:	APPROVED BY:
REPAIR/ IMPROVEMENT OF MULTI PURPOSE HALL (CLASSROOM 2) BARAYONG ES			
LOCATION: BRGY. BARAYONG WEST DISTRICT, SORSOGON CITY		ROEL D. DEBER, CE DIC-CRO	HON. MA. ESTER E. HAMOR CITY MAYOR

PLEASE SIGN

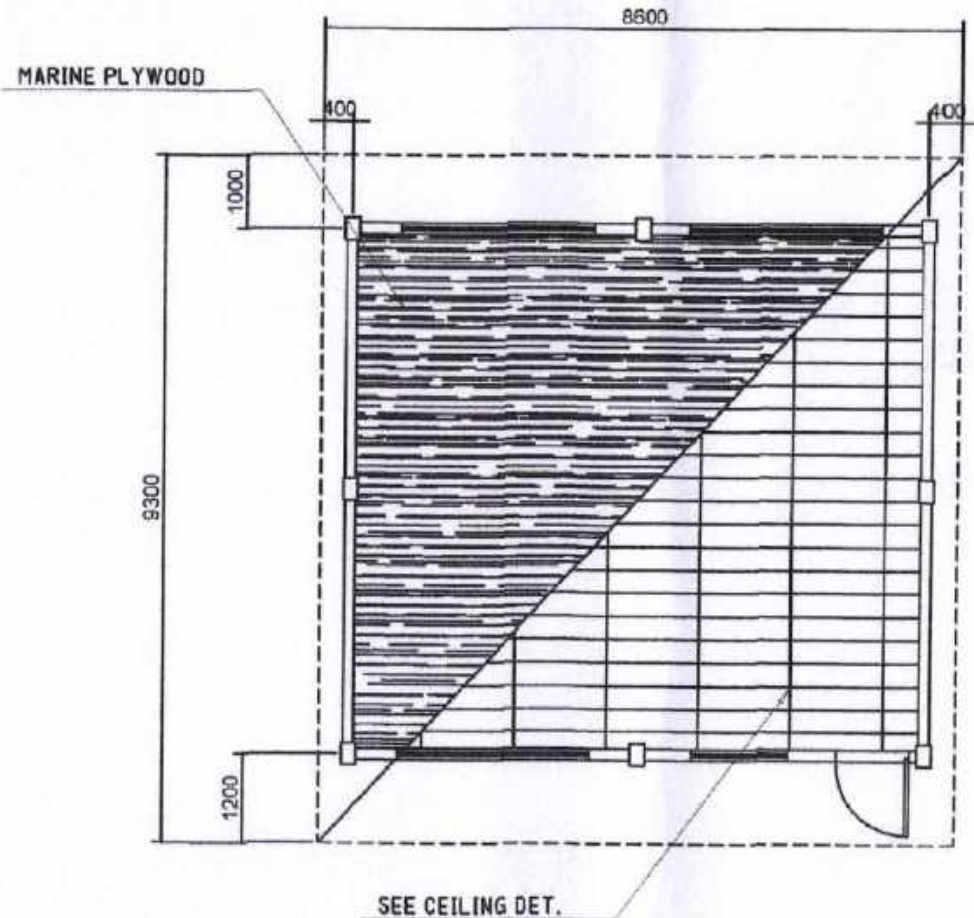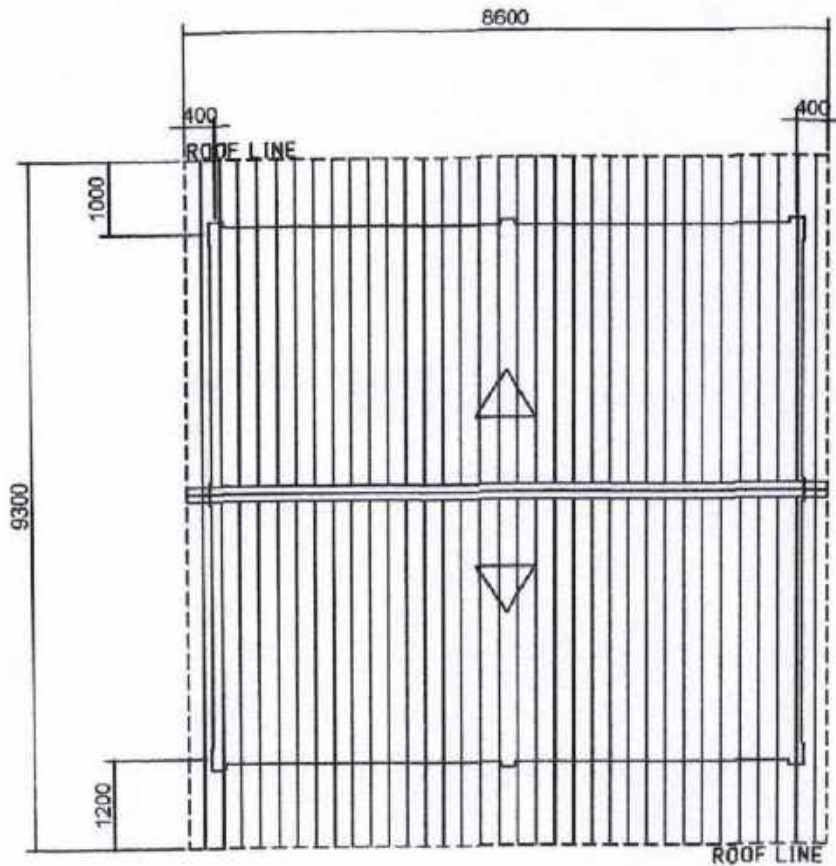

ROOF PLAN  
SCALE: N T S

ROOF FRAMING PLAN  
SCALE: N T S



SORSOGON CITY  
CITY ENGINEER'S  
OFFICE

PROJECT TITLE:	DRAWN BY:	RECOMMENDING APPROVAL:	APPROVED BY:
REPAIR/IMPROVEMENT OF MULTI PURPOSE HALL (CLASSROOM 2) BARAYONG ES			
LOCATION: BRGY. BARAYONG, WEST DISTRICT, SORSOGON CITY		ROBE D. DOMER, CE OIC-CEO	HON. MA. ESTER E. HAMOR CITY MAYOR


METAL DOUBLE FURRING CHANNEL  
(NAILER) 12MM X 38MM X 5M X 0.8MM  
THK @ 1200MM O.C.

METAL CARRYING CHANNEL (CEILING  
JOIST) (NAILER) 12MM X 38MM X 5M X  
0.8MM THK @ 400MM O.C.

ROD SUSPENSION HANGER  
WITH ADJUSTMENT SPRING

PREFORMED WIRE CLIP


MARINE PLYWOOD

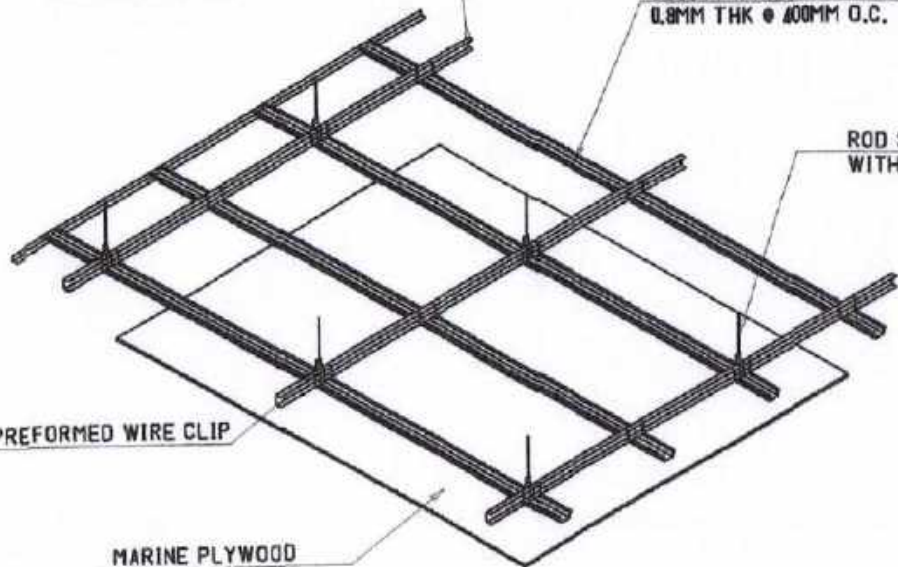

ROOF COVER

EXISTING STEEL TRUSS

CEILING LINE

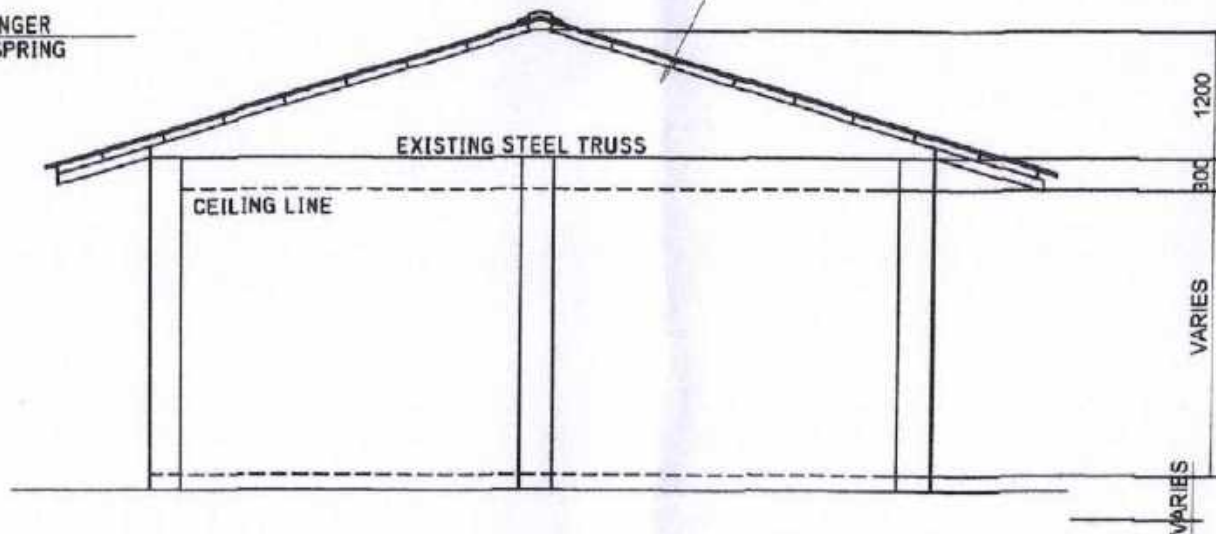

CEILING DET. N T S  
SCALE:

SIDE ELEVATION N T S  
SCALE:




SORSOGON CITY  
CITY ENGINEER'S  
OFFICE

PROJECT TITLE:	DRAWN BY:	RECOMMENDING APPROVAL:	APPROVED BY:
REPAIR/IMPROVEMENT OF MULTI PURPOSE HALL (CLASSROOM 2) BARAYONG ES			
LOCATION: BRGY. BARAYONG, WEST DISTRICT, SORSOGON CITY LOCATION		ROB. D. DOMER, CE OIC-CE	HON. MA. ESTER E. HAMOR CITY MAYOR

PLEASE SIGN



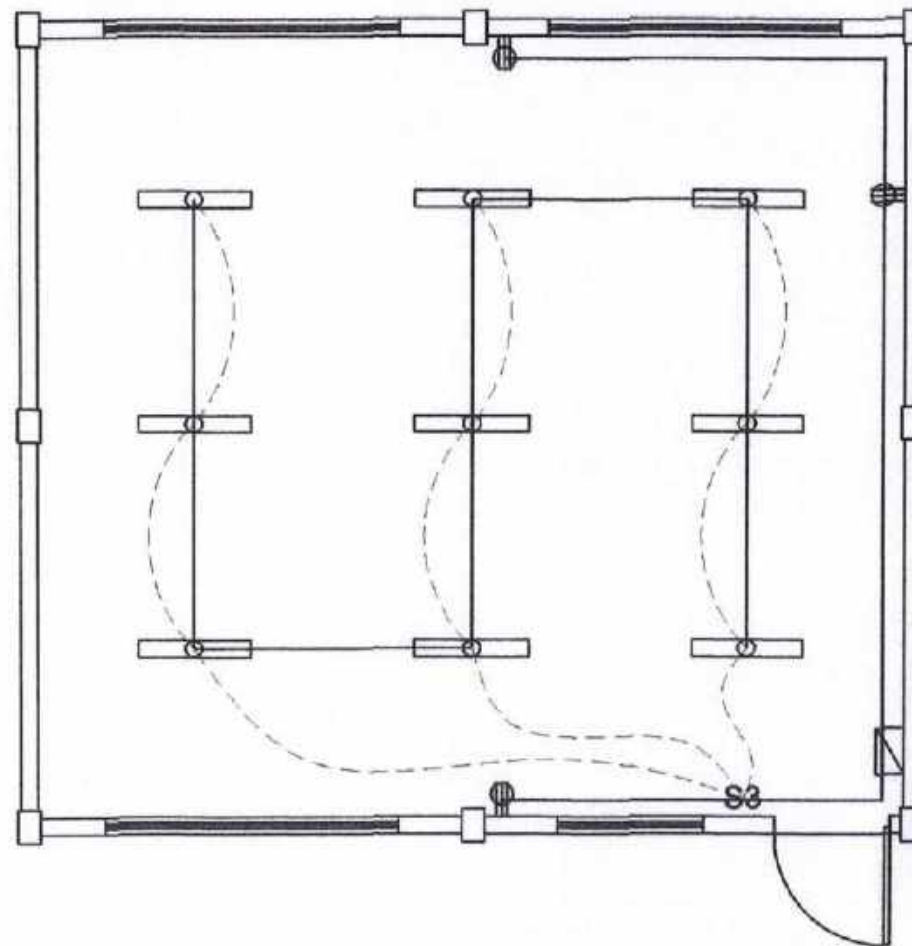


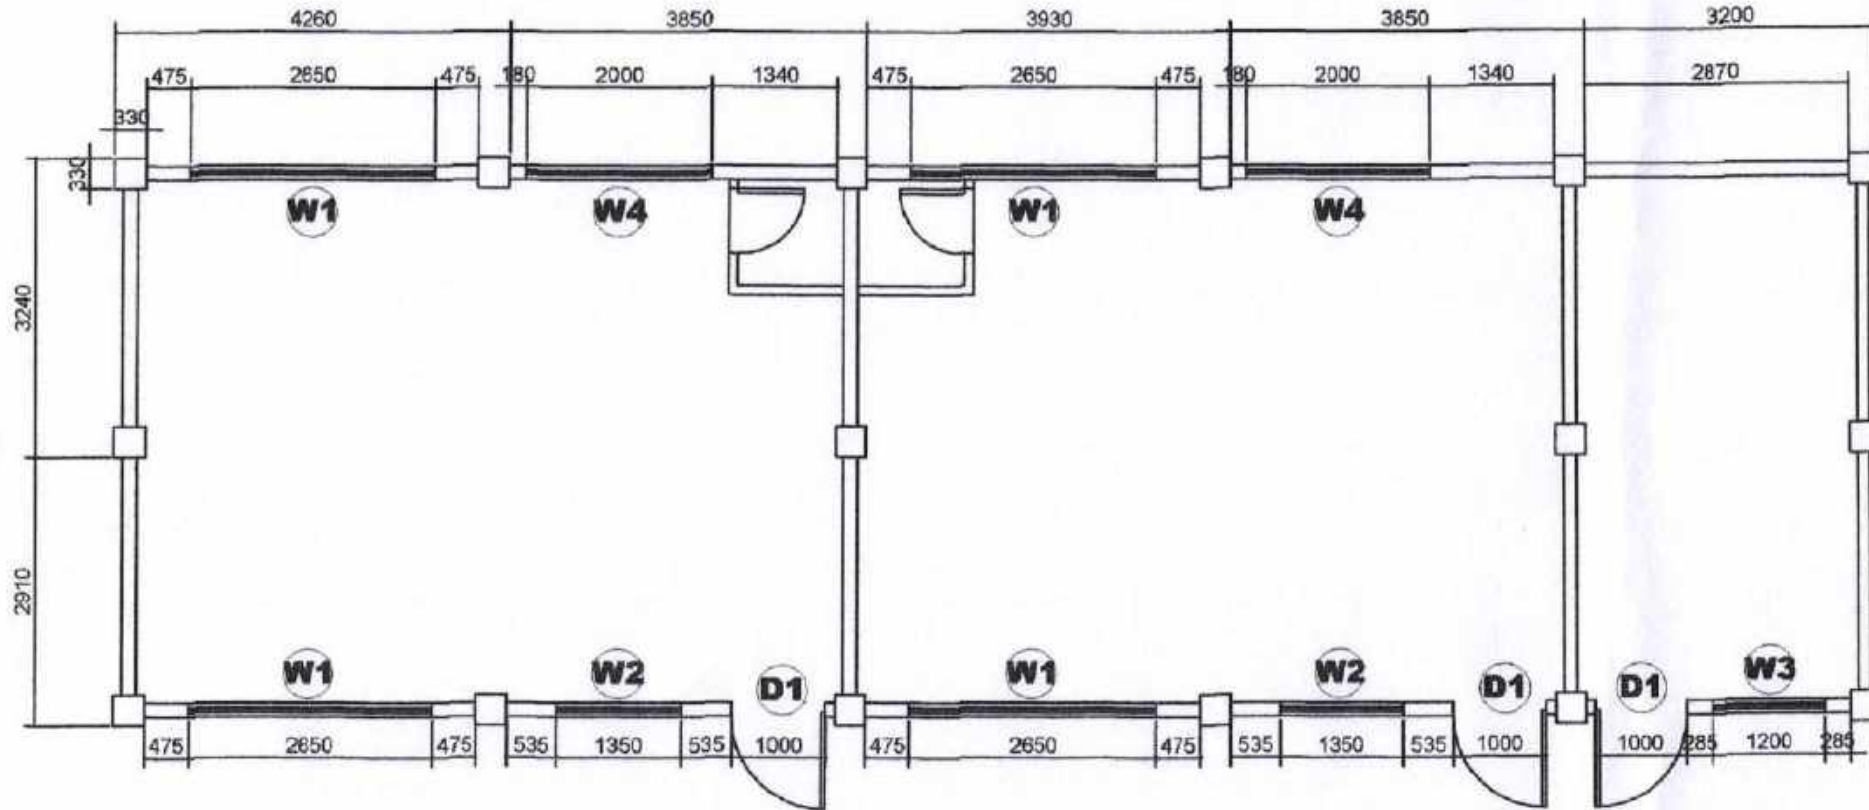
○ LIGHTING LAYOUT  
SCALE: N T S



SORSOGON CITY  
CITY ENGINEER'S  
OFFICE

PROJECT TITLE:	DRAWN BY:	RECOMMENDING APPROVAL:	APPROVED BY:
REPAIR/ IMPROVEMENT OF MULTI PURPOSE HALL (CLASSROOM 2) BARAYONG ES			
LOCATION: BRGY. BARAYONG, WEST DISTRICT, SORSOGON CITY EDUCATION		RUEL D. DOMAN, CE OIC-CEO	HON. MA. ESTER E. HAMOR CITY MAYOR

# BARAYONG ELEM. SCHOOL RRL BLDG.



SORSOGON CITY

**CITY ENGINEER'S  
OFFICE**

PROJECT TITLE:

REPAIR/ IMPROVEMENT OF MULTI PURPOSE  
HALL (RRL BLDG) BARAYONG ES

LOCATION: BRGY. BARAYONG, WEST  
DISTRICT, SORSOGON CITY



DRAWN BY:

RECOMMENDING APPROVAL:

ROEL D. DOMER, CE  
OIC-CEO


APPROVED BY:

HON. MA. ESTER E. HAMOR  
CITY MAYOR

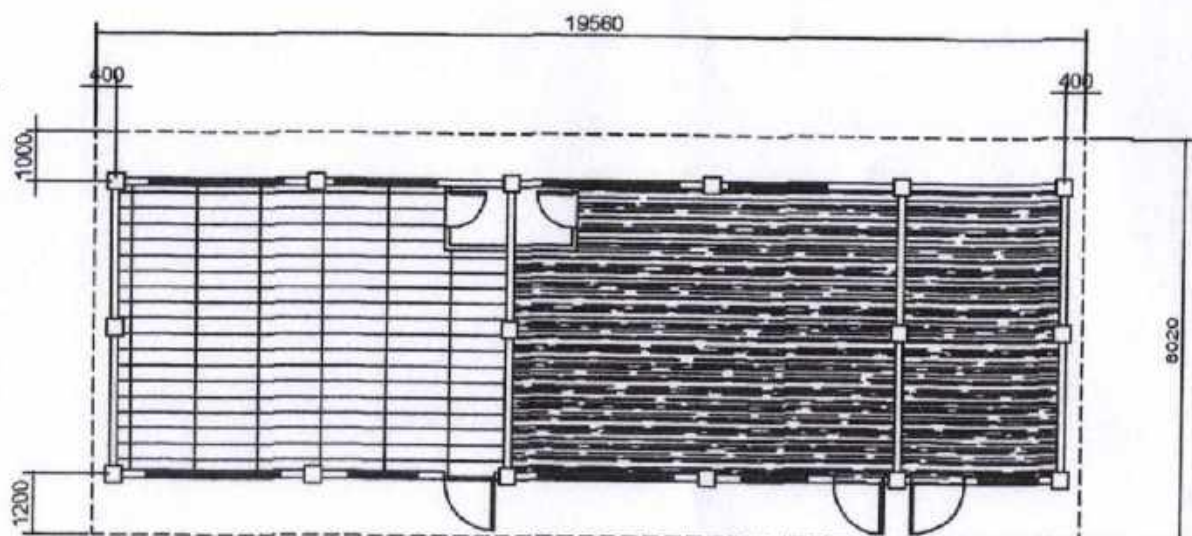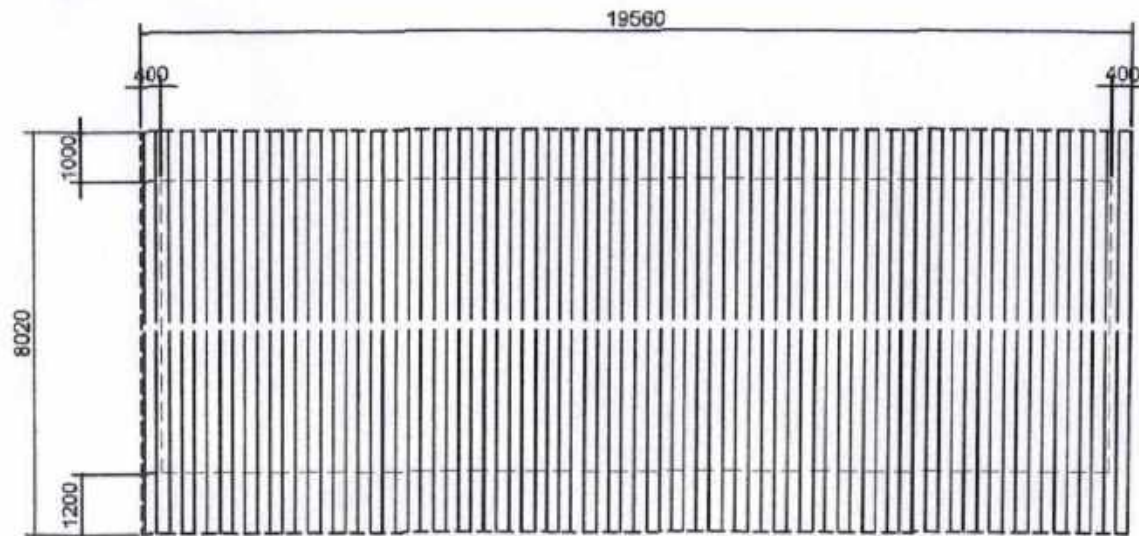

**R O O F P L A N**  
SCALE: N T S

**R O O F F R A M I N G P L A N**  
SCALE: N T S

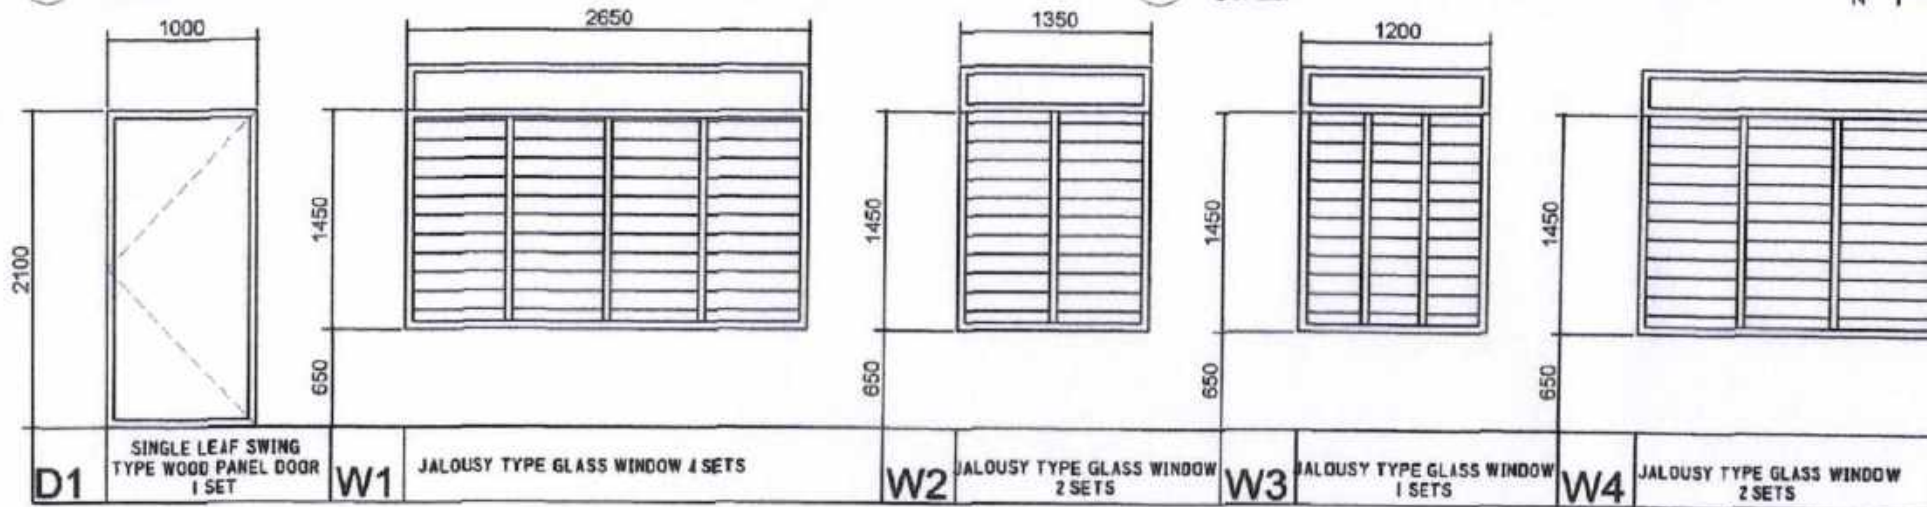

**D O O R & W I N D O W S C H E D U L E**  
SCALE: N T S



S O R S O G O N C I T Y  
**CITY ENGINEER'S  
O F F I C E**

PROJECT TITLE:	DRAWN BY:	NOTED BY:	APPROVED BY:
REPAIR/IMPROVEMENT OF MULTI PURPOSE HALL (RRL BLDG) BARAYONG ES			
LOCATION: BRGY. BARAYONG, WEST DISTRICT, SORSOGON CITY		ROYL D. DOMER, CE OIC-CEO	HON. MA. ESTER E. HAMOR CITY MAYOR



METAL DOUBLE FURRING CHANNEL  
(NAILER) 12MM X 38MM X 5M X 0.8MM  
THK @ 1200MM O.C.

METAL CARRYING CHANNEL (CEILING  
JOIST) (NAILER) 12MM X 38MM X 5M X  
0.8MM THK @ 400MM O.C.

ROD SUSPENSION HANGER  
WITH ADJUSTMENT SPRING

PREFORMED WIRE CLIP

MARINE PLYWOOD

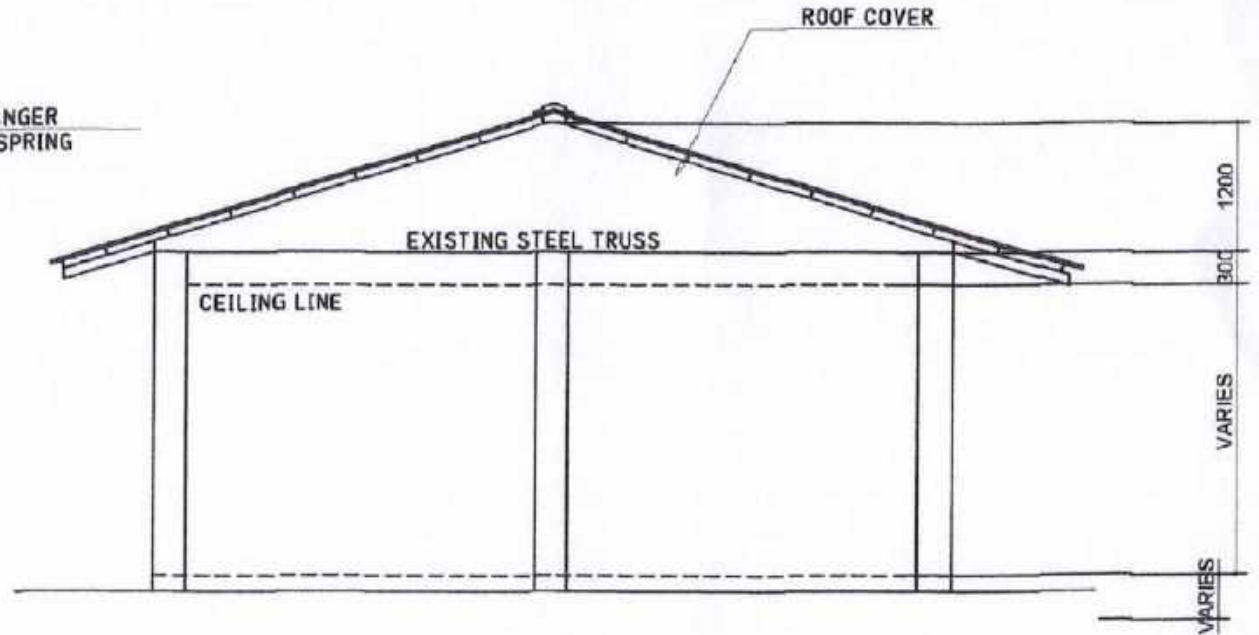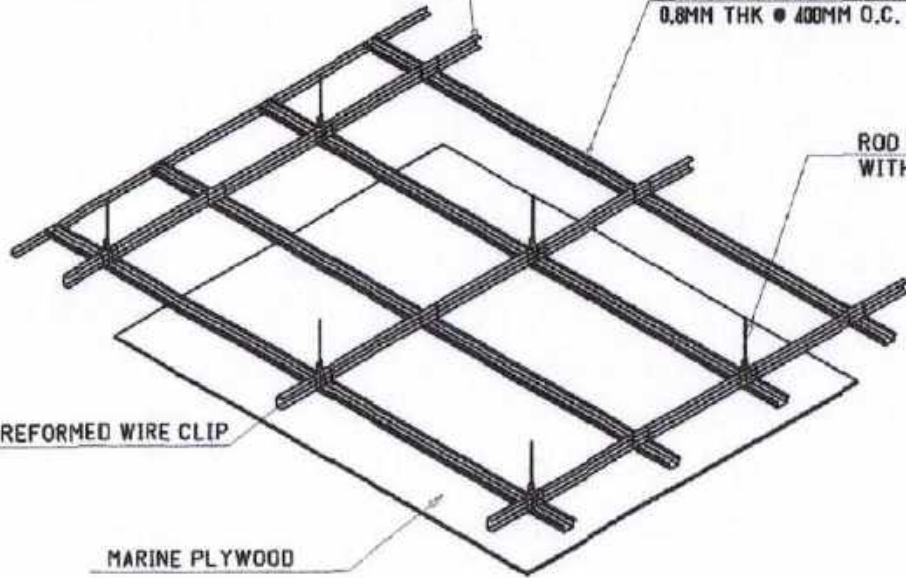

CEILING DET. SCALE: N T S

SIDE ELEVATION SCALE: N T S



SORSOGON CITY

CITY ENGINEER'S  
OFFICE

PROJECT TITLE:

REPAIR/IMPROVEMENT OF MULTI PURPOSE  
HALL (RRL BLDG) BARAYONG ES

LOCATION: BRGY. BARAYONG, WEST  
DISTRICT, SORSOGON CITY


DRAWN BY:

NOTED BY:

ROSEB. DOMER, CE  
OIC-CEO

APPROVED BY:

HON. MA. ESTER E. HAMOR  
CITY MAYOR

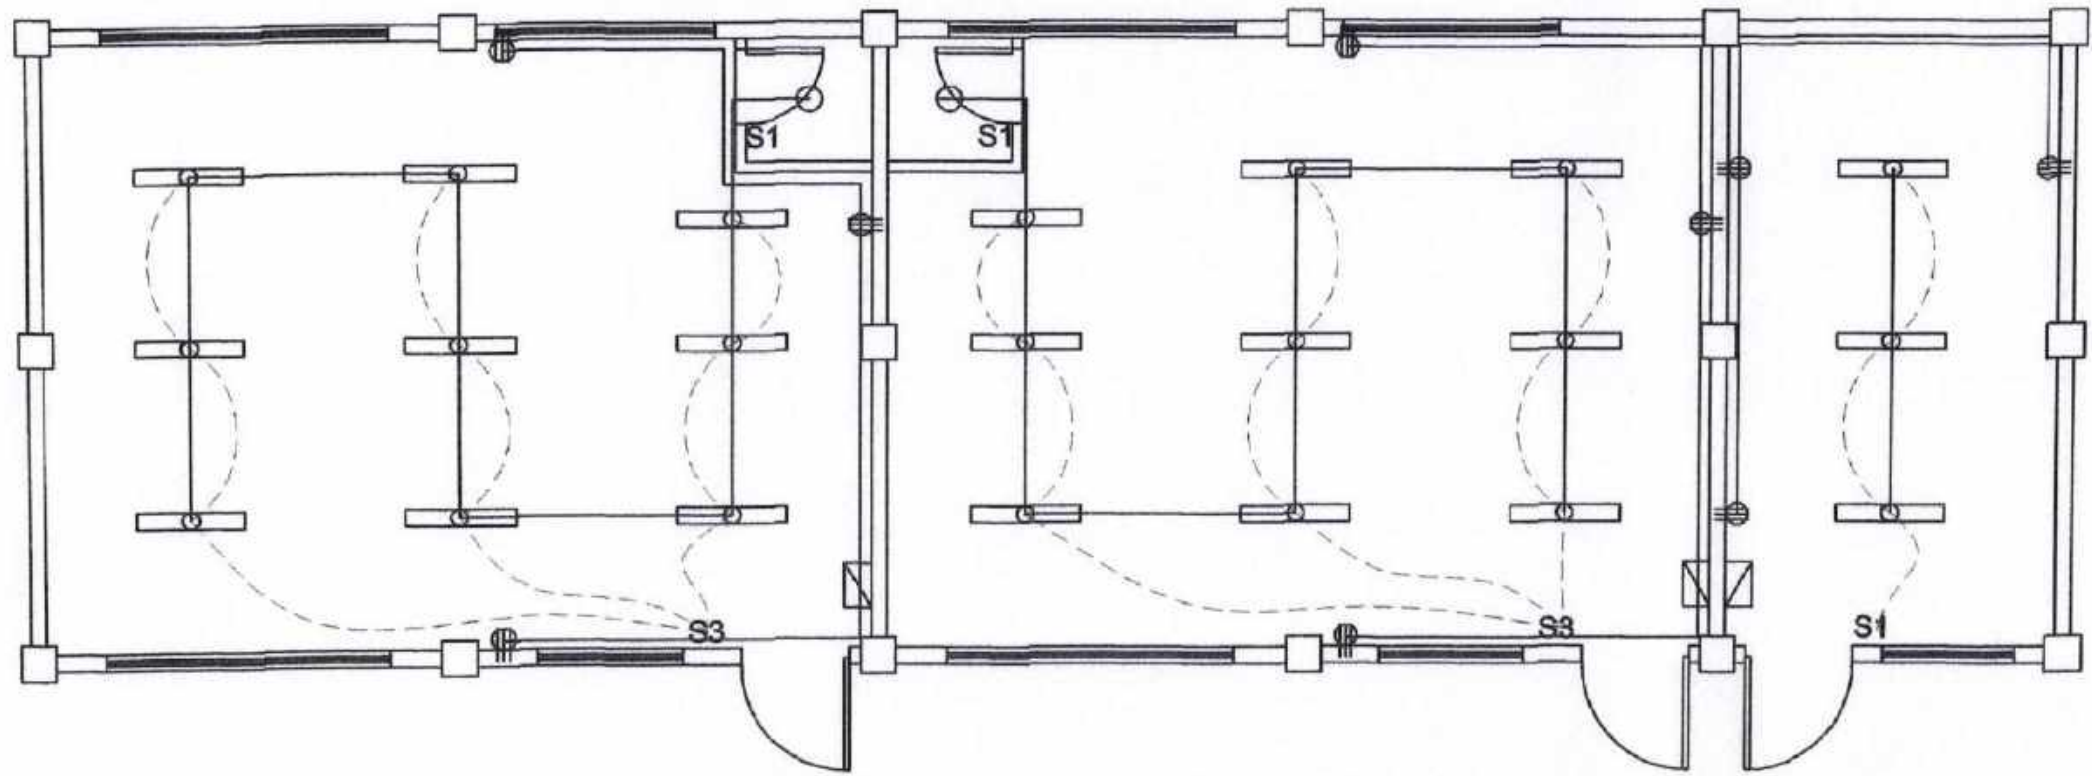

○ LIGHTING LAYOUT  
SCALE: N T S



SORSOGON CITY  
CITY ENGINEER'S  
OFFICE

PROJECT TITLE:	DRAWN BY:	NOTED BY:	APPROVED BY:
REPAIR/IMPROVEMENT OF MULTI PURPOSE HALL (RRL BLDG) BARAYONG ES			
LOCATION: BRGY. BARAYONG, WEST DISTRICT, SORSOGON CITY		ROCEL D. DOMER, CE OIC-CEO	HON. MA. ESTER E. HAMOR CITY MAYOR


**BARAYONG ELEMENTARY SCHOOL**  
**CLASSROOM 2 (1UNIT)**




**BARAYONG ELEMENTARY SCHOOL**

**RRL BUILDING**




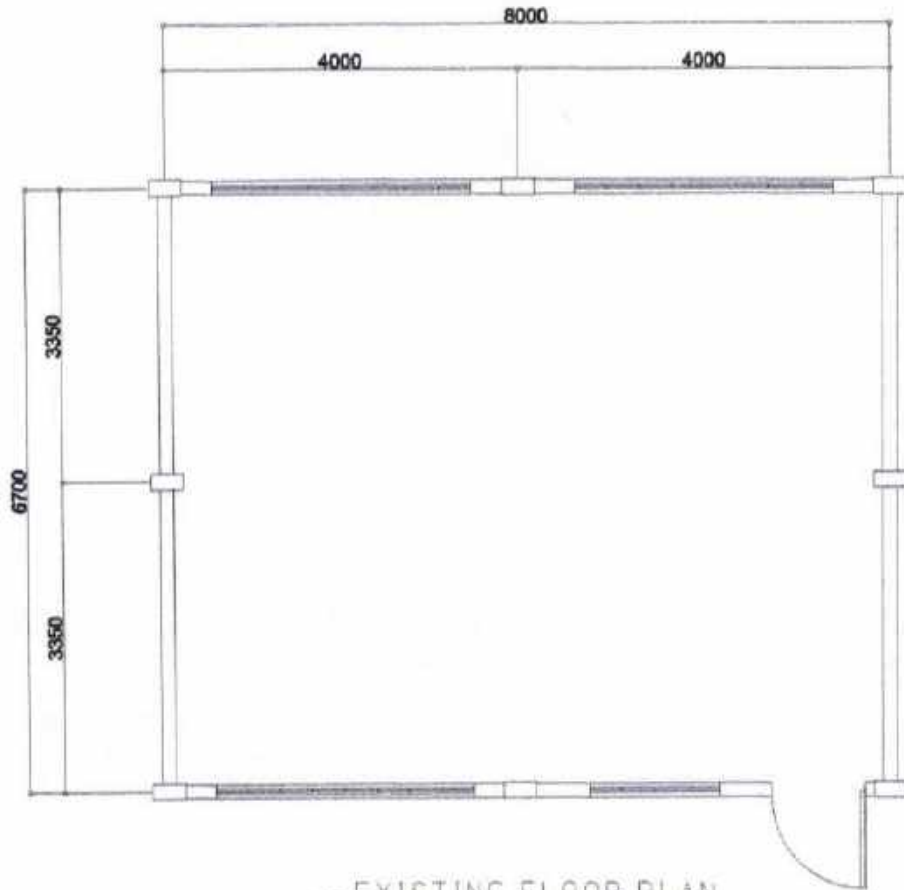

EXISTING FLOOR PLAN  
SCALE: 1/8"=1'-0"

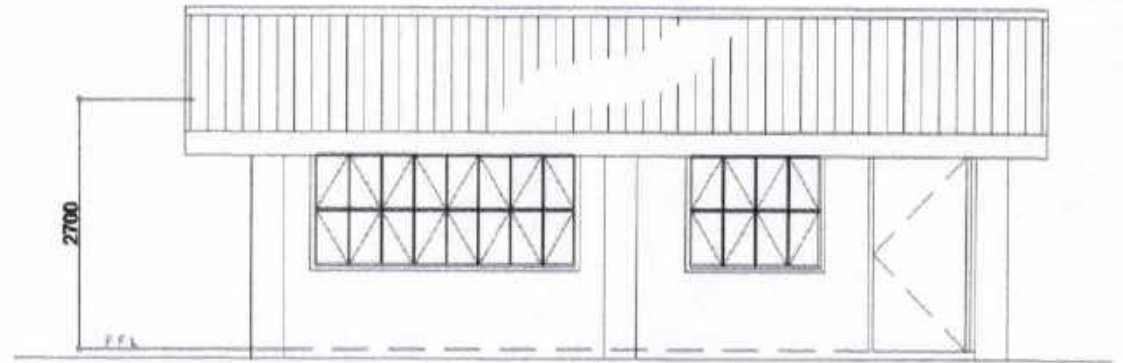

FRONT ELEVATION  
SCALE: 1/8"=1'-0"

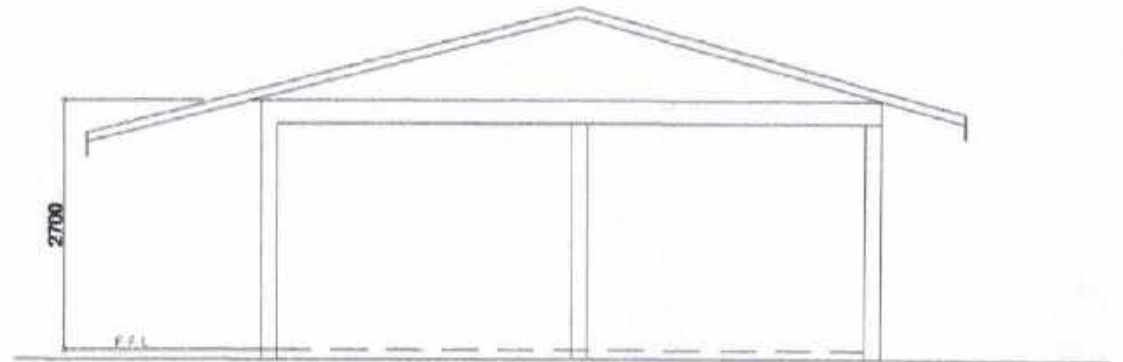


RIGHT SIDE ELEV.  
SCALE: 1/8"=1'-0"




SORSOGON CITY  
CITY ENGINEER'S  
OFFICE

PROJECT TITLE:	DRAWN BY:	RECOMMENDING APPROVAL:	APPROVED BY:
REPAIR/IMPROV. OF MULTI-PURPOSE HALL (IMELDA TYPE 3 BLDG.), ROSA T ARELLANO ES	Ma Pamela L. Legaspi	ROELDO DOMER, C.E./RMP CITY ENGINEER	MA. ESTER E. HAMOR CITY MAYOR
LOC: BRGY. MACABOG, WEST DISTRICT SORSOGON CITY	DRAFTING AIDE		



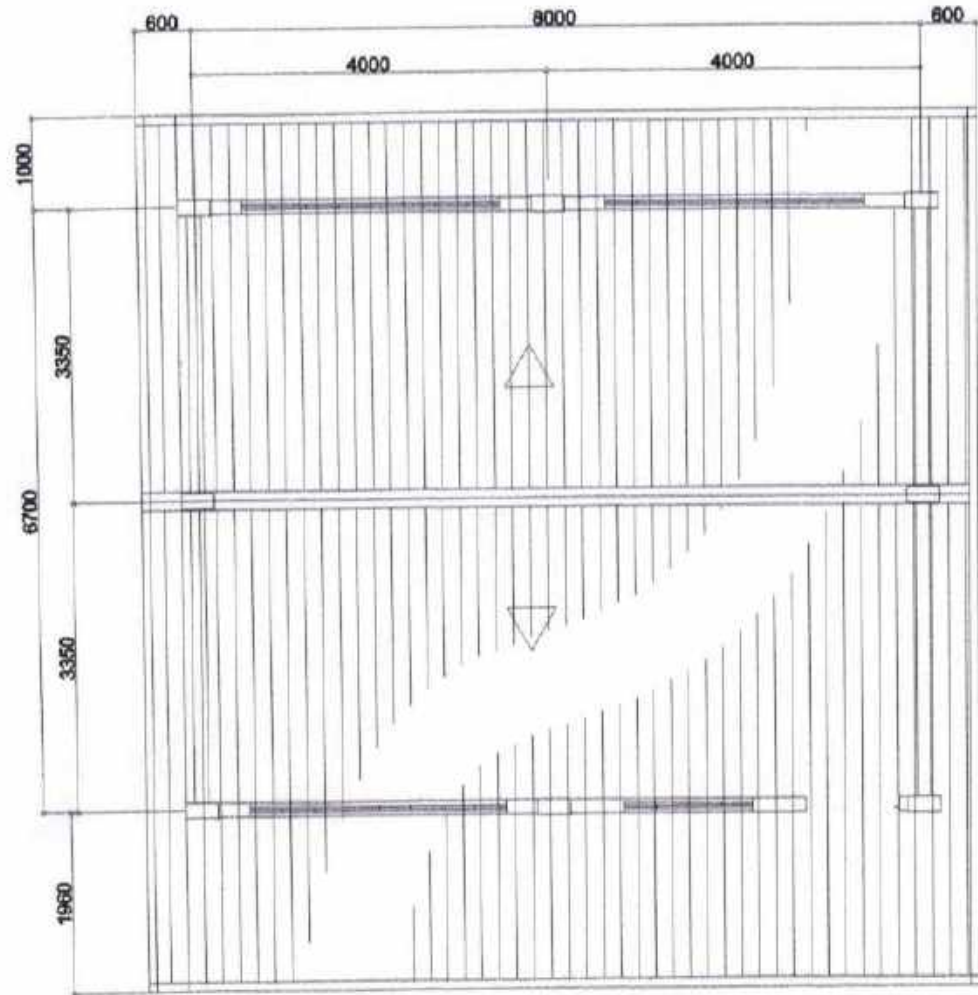

ROOF PLAN  
SCALE: 1/8"=1'-0"

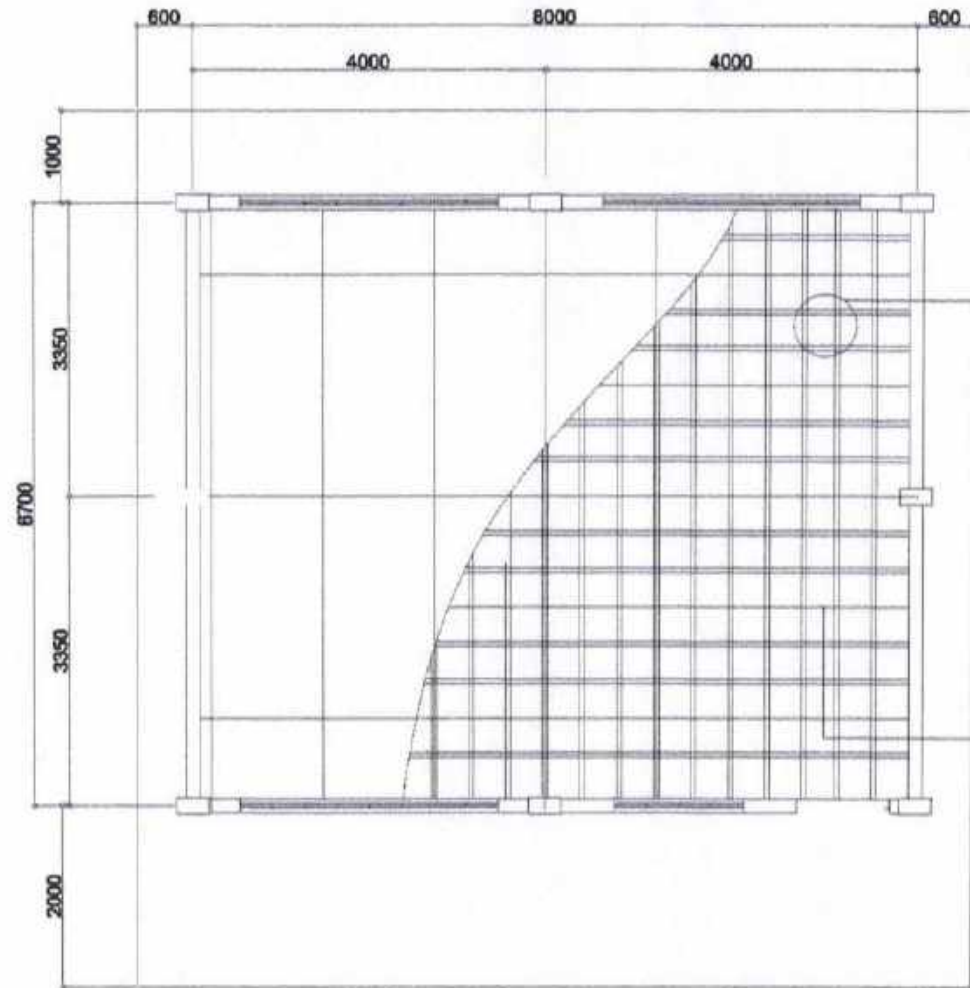

ROOF PLAN  
SCALE: 1/8"=1'-0"



SORSOGON CITY  
CITY ENGINEER'S  
OFFICE



PROJECT TITLE:  
REPAIR/IMPROV. OF MULTI-PURPOSE HALL (IMELDA  
TYPE 3 BLDG.), ROSA T ARELLANO ES  
LOC: BRGY. MACABOG, WEST DISTRICT  
SORSOGON CITY

DRAWN BY:  
Ma Pamela Legaspi  
DRAFTING AIDE

RECOMMENDING APPROVAL:  
ROEL D. DOMES, C.E./RMP  
CITY ENGINEER


APPROVED BY:  
MA. ESTER E. HAMOR  
CITY MAYOR

PLEASE SIGN

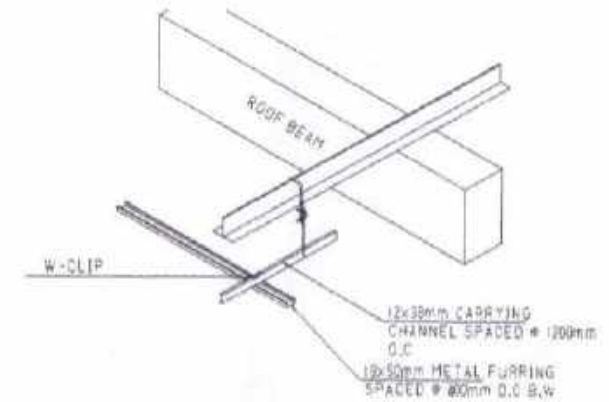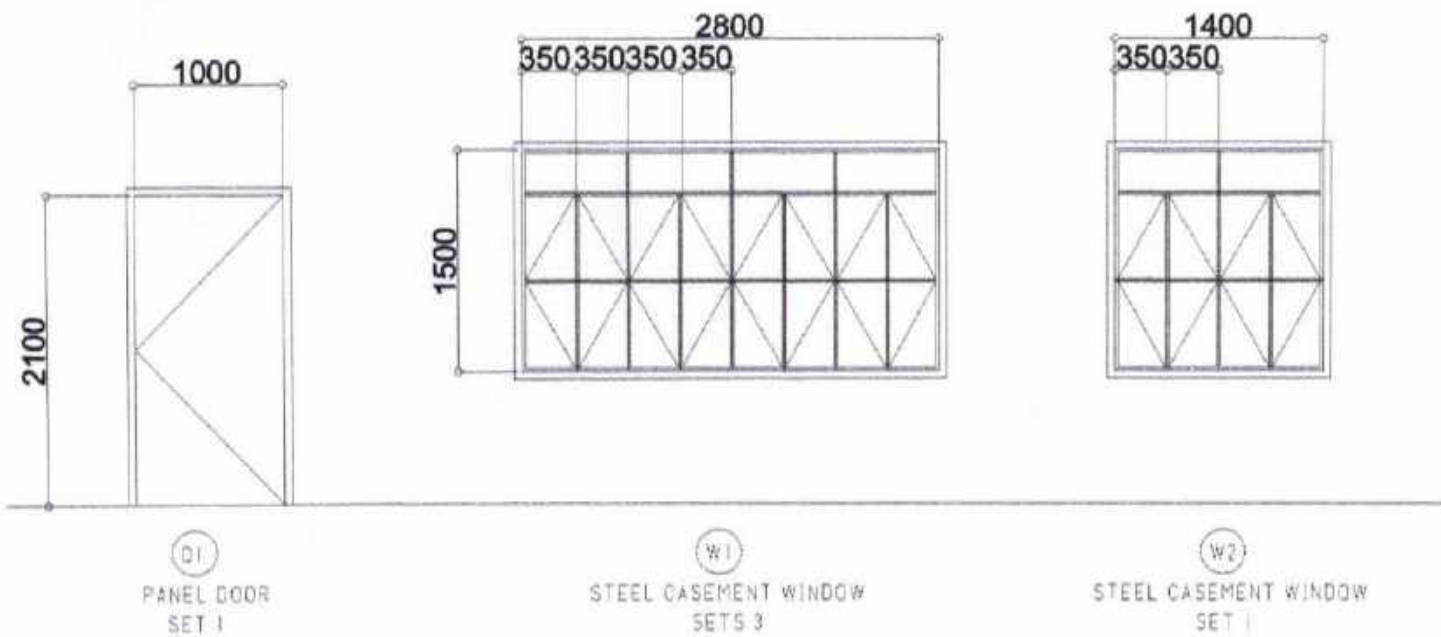

ISOMETRIC DRAWING

DOORS & WINDOWS SCHEDULE  
SCALE: 1:25M.T.S

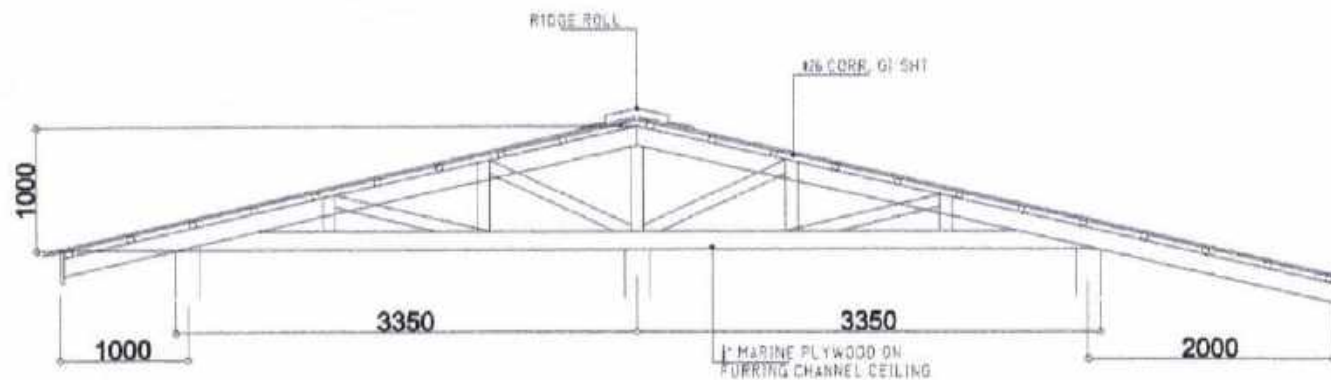


TRUSS DET.  
SCALE: 1:25M.T.S



SORSOGON CITY  
CITY ENGINEER'S  
OFFICE

PROJECT TITLE: REPAIR/IMPROV. OF MULTI-PURPOSE HALL (IMELDA TYPE 3 BLDG.), ROSA T ARELLANO ES	DRAWN BY: MaPamelaLegaspil DRAFTING AIDE	RECOMMENDING APPROVAL: ROEL D. DOMER, C.E./RMP CITY ENGINEER	APPROVED BY: MA. ESTER E. HAMOR CITY MAYOR
LOC: BRGY. MACABOG, WEST DISTRICT SORSOGON CITY			

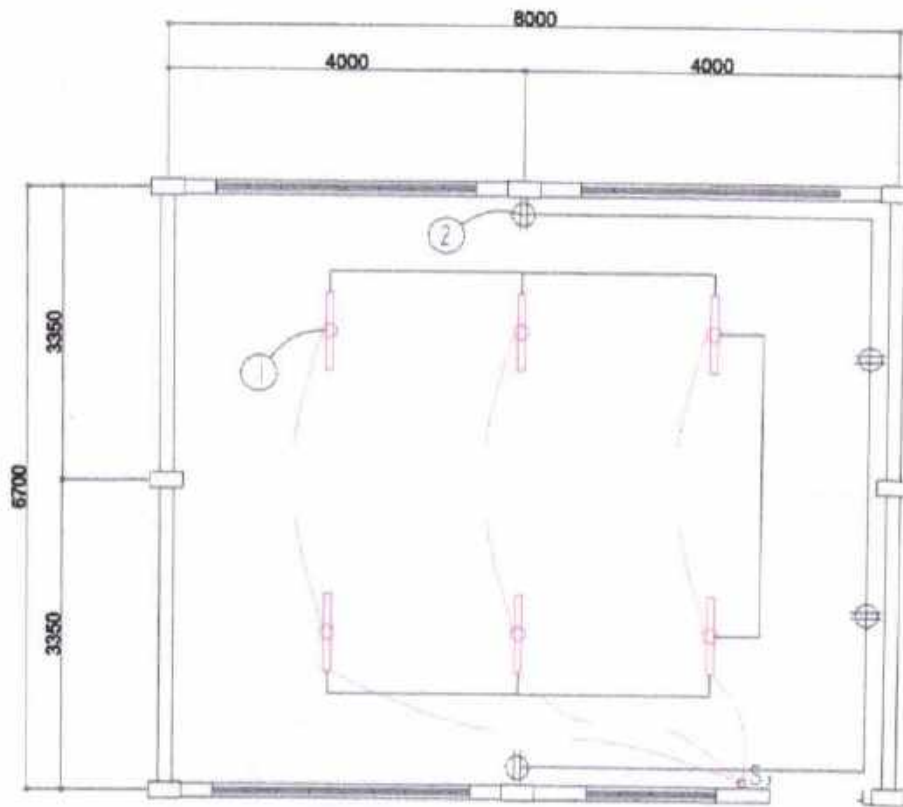

ELECTRICAL PLAN

### ELECTRICAL NOTES

ALL ELECTRICAL WORKS SHALL BE DONE IN ACCORDANCE WITH THE LATEST RULES AND REGULATIONS OF THE PHIL. ELECTRICAL CODE AS WELL AS THE LOCAL AUTHORITY CONCERNED AND THE LOCAL POWER COMPANY.

ALL ELECTRICAL MATERIALS TO BE USED SHALL BE NEED & APPROVED TYPE FOR LOCATION & PURPOSE

MOUNTING HEIGHTS SHALL BE AS FOLLOWS:

- a. LIGHT CONTROL SWITCH- 1.35M ABOVE FIN. FLR. LINE AT CENTER
- b. CONVENIENCE OUTLET-ABOVE 1.0M ABOVE FIN. FLR. LINE AT CENTER
- c. PANEL BOARD- 2.0 M ABOVE FIN. FLR. LINE

ALL ELECTRICAL WORKS SHALL BE UNDER THE DIRECT & IMMEDIATE SUPERVISION OF A DULY LICENSED ELECTRICAL ENGINEER OR REGISTERED MASTER ELECTRICIAN

### SCHEDULE OF LOADS

CIRCUIT NO.	DESCRIPTION	NO. OF LOADS	VOLTS	WATTS	AMP	SIZE OF WIRE	SIZE OF CONDUIT
1	LIGHTING OUTLET	6	230	600	2.60	2-2.0mm <sup>2</sup> THW	15mmØ
2	CONVENIENCE OUTLET	4	230	720	3.13	2-3.5mm <sup>2</sup> THW	20mmØ
	<b>TOTAL</b>				<b>5.73</b>		




SORSOGON CITY  
CITY ENGINEER'S  
OFFICE

PROJECT TITLE:  
REPAIR/IMPROV. OF MULTI-PURPOSE HALL (MELDA  
TYPE 3 BLDG.), ROSA T ARELLANO ES  
LOC: BRGY. MACABOG, WEST DISTRICT  
SORSOGON CITY

DRAWN BY:  
MaPamela Legaspi  
DRAFTING A/DE

RECOMMENDING APPROVAL:  
ROEL D. DOMER, C.E./RMP  
CITY ENGINEER

APPROVED BY:  
MA. ESTER E. HAMOR  
CITY MAYOR

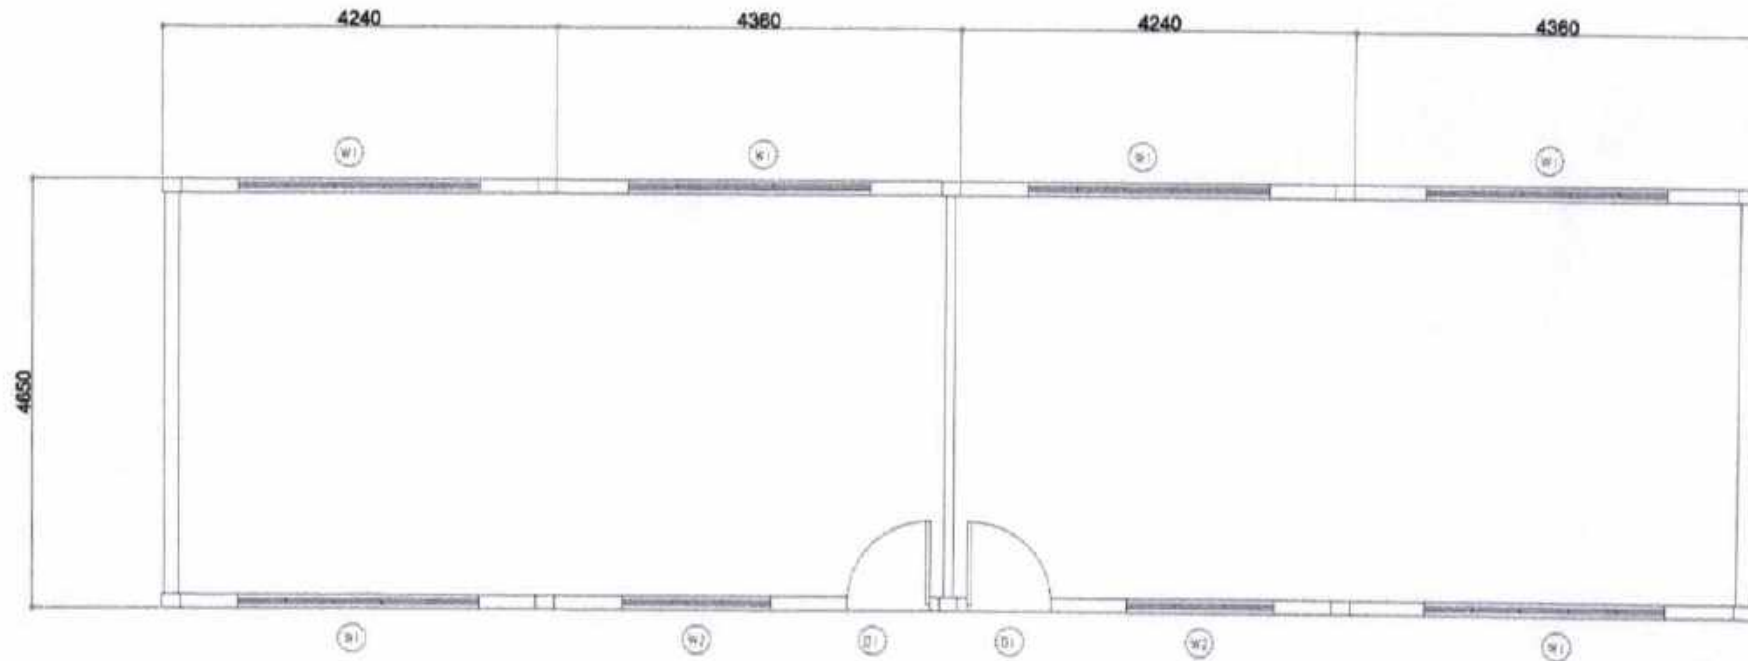

EXISTING FLOOR PLAN  
SCALE 1:200




SORSOGON CITY  
CITY ENGINEER'S  
OFFICE

PROJECT TITLE:  
REPAIR/IMPROV. OF MULTI-PURPOSE HALL  
(CLASSROOM-MAKESHIFT), ROSA T ARELLANO ES  
LOC: BRGY. MACABOG, WEST DISTRICT  
SORSOGON CITY


DRAWN BY:  
Ma Pamela Legaspi  
DRAFTING AIDE

RECOMMENDING APPROVAL:  
ROEL D. DOMER, C.E./RMP  
CITY ENGINEER

APPROVED BY:  
MA. ESTER E. HAMOR  
CITY MAYOR

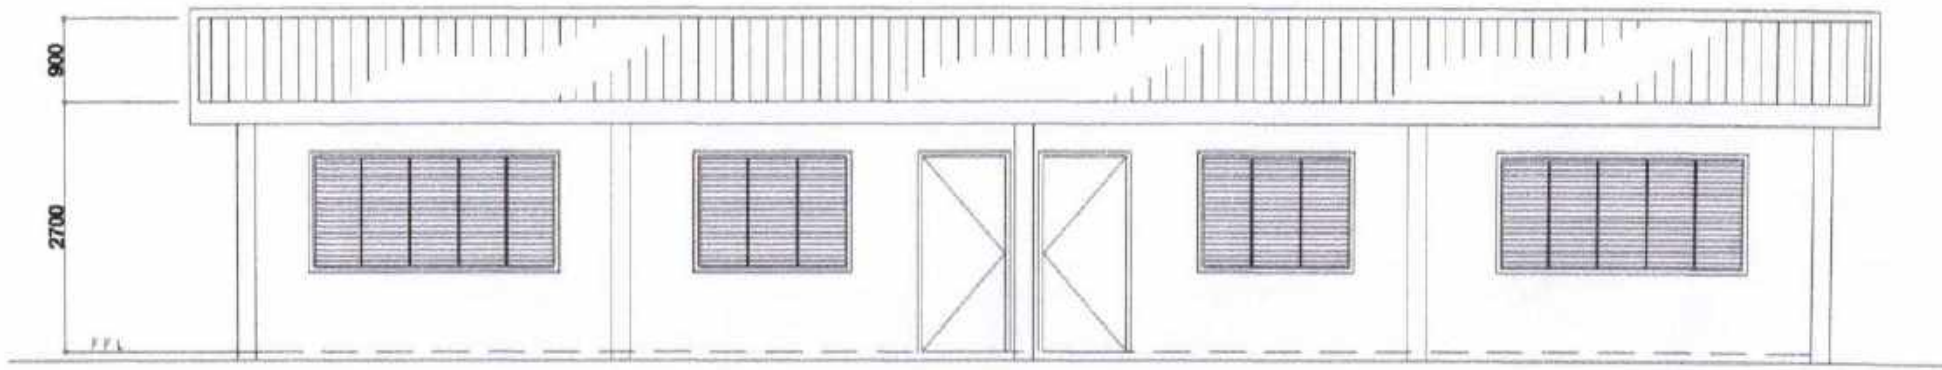

FRONT ELEVATION  
SCALE: 1/250

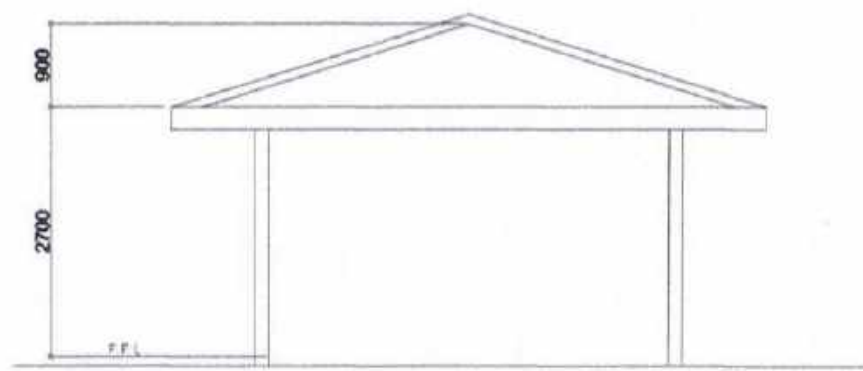


RIGHT SIDE ELEV.  
SCALE: 1/250



SORSOGON CITY  
CITY ENGINEER'S  
OFFICE

PROJECT TITLE: REPAIR/IMPROV. OF MULTI-PURPOSE HALL (CLASSROOM-MAKESHIFT), ROSA T ARELLANO ES	DRAWN BY: Ma Pamela Lagaspi	RECOMMENDING APPROVAL: ROEL D. DOMER, C.E./RMP CIC-CITY ENGINEER	APPROVED BY: MA. ESTER E. HAMOR CITY MAYOR
LOC: BRGY. MACABOG, WEST DISTRICT SORSOGON CITY	DRAFTING AIDE		



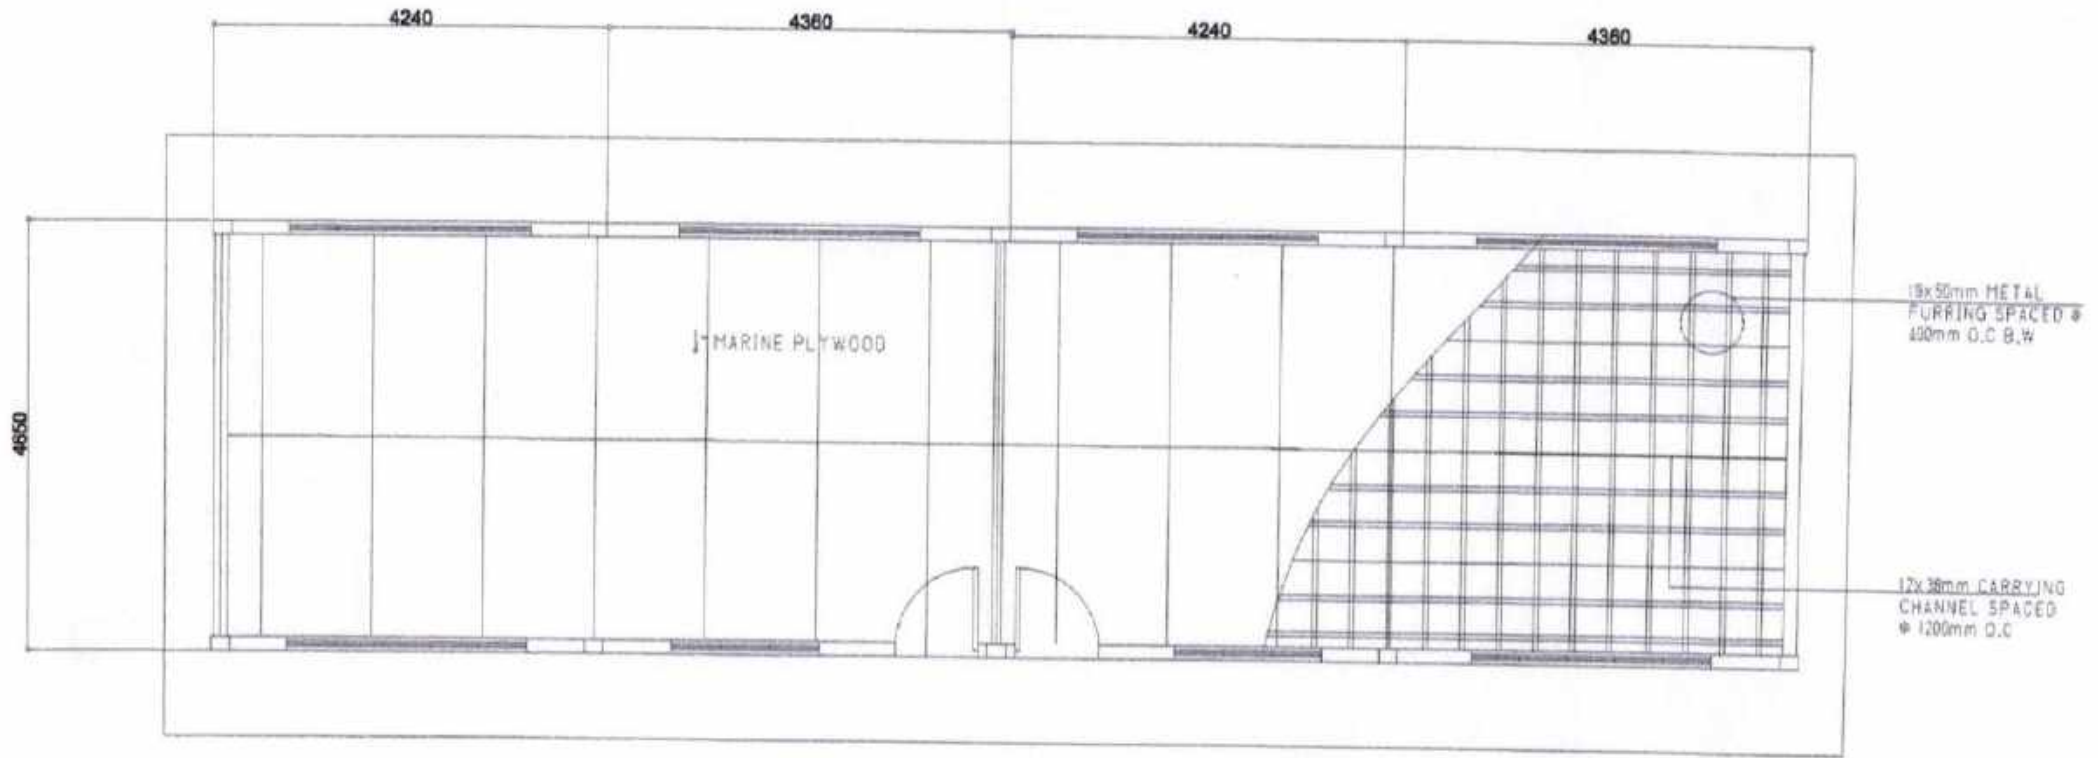


CEILING PLAN  
SCALE: 1/2011




SORSOGON CITY  
CITY ENGINEER'S  
OFFICE

PROJECT TITLE: REPAIR/IMPROV. OF MULTI-PURPOSE HALL (CLASSROOM-MAKESHIFT), ROSA T ARELLANO ES	DRAWN BY: Ma Pamela Legaspi DRAFTING AIDE	RECOMMENDING APPROVAL: ROEL D. DOMER, C.E./RMP CIC-CITY ENGINEER	APPROVED BY: MA. ESTER E. HAMOR CITY MAYOR
LOC: BRGY. MACABOG, WEST DISTRICT SORSOGON CITY			


PLEASE SIGN

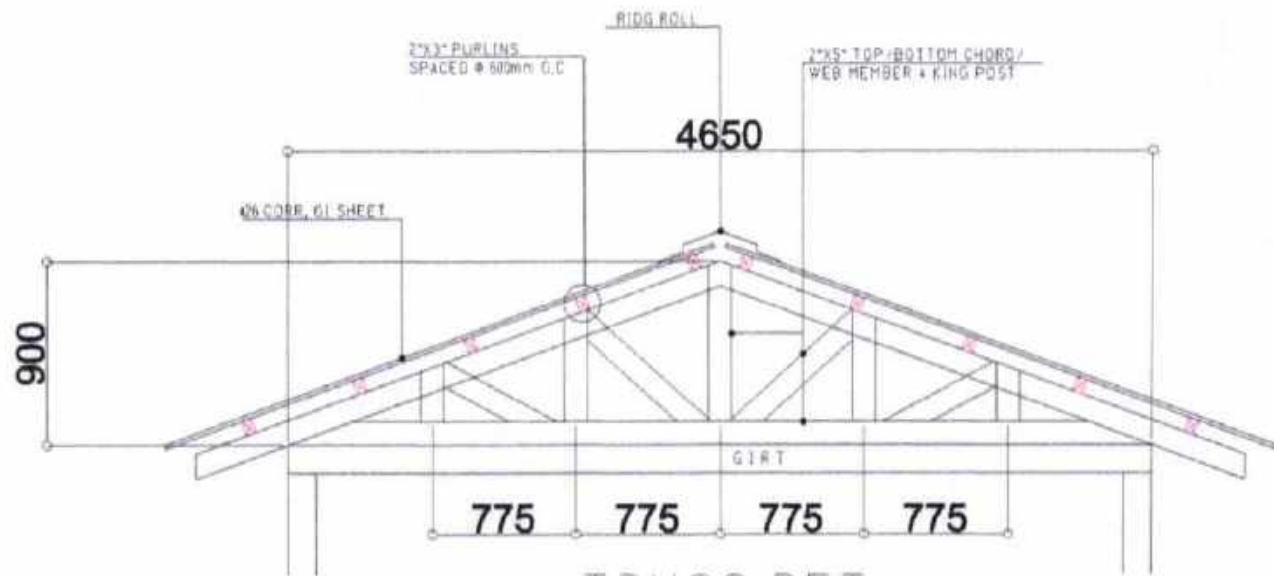


TRUSS DET.  
SCALE: 1:25MTS

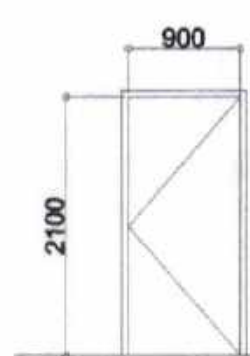


DI  
FLUSH DOOR  
SETS 2

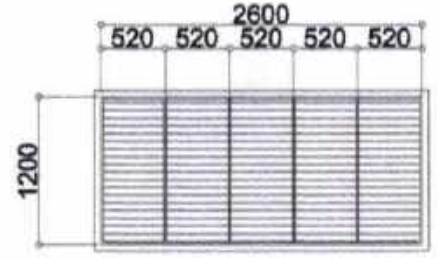

WI  
GLASS JALOUSIE WINDOW  
SETS 6

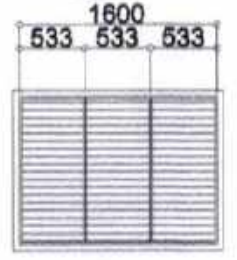

W2  
GLASS JALOUSIE WINDOW  
SETS 2

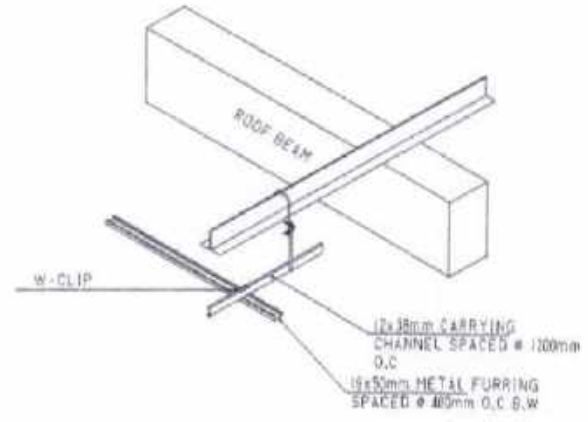

ISOMETRIC DRAWING


DOORS & WINDOWS SCHEDULE  
SCALE: 1:25MTS



SORSOGON CITY  
CITY ENGINEER'S  
OFFICE

PROJECT TITLE:	DRAWN BY:	RECOMMENDING APPROVAL:	APPROVED BY:
REPAIR/IMPROV. OF MULTI-PURPOSE HALL (CLASSROOM-MAKESHIFT), ROSA T ARELLANO ES			
LOC: BRGY. MACABOG, WEST DISTRICT SORSOGON CITY	Va Pamela Legespil DRAFTING AIDE	ROEL D. DOMER, C.E./RMP OIC-CITY ENGINEER	MA. ESTER E. HAMOR CITY MAYOR

PLEASE SIGN

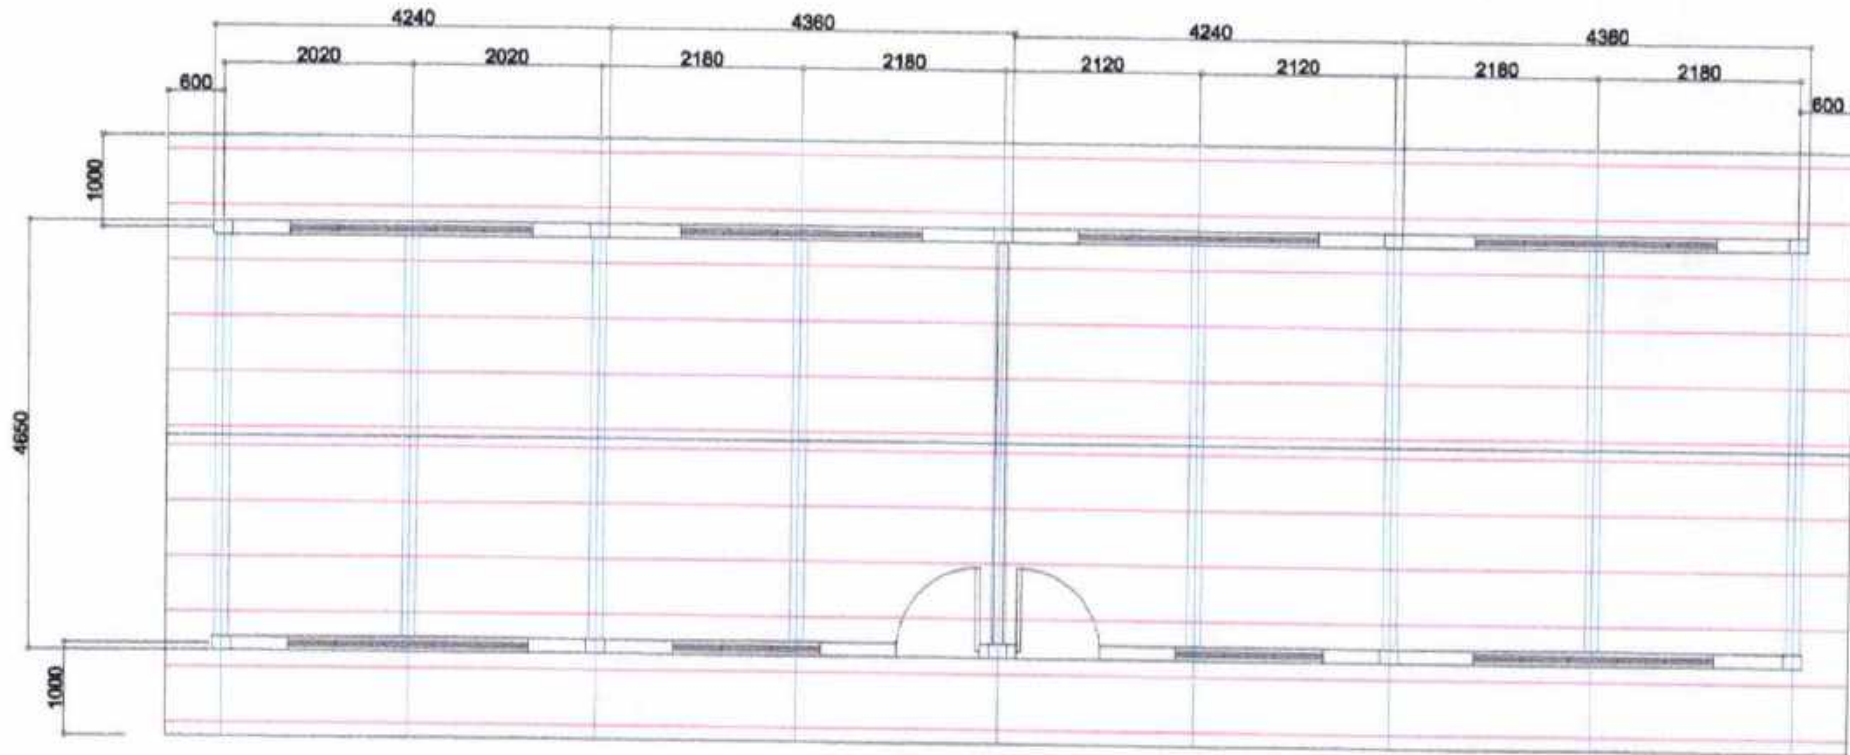

ROOF FRAMING PLAN  
SCALE: 1/8"=1'-0"



SORSOGON CITY  
CITY ENGINEER'S  
OFFICE


PROJECT TITLE:  
REPAIR/IMPROV. OF MULTI-PURPOSE HALL  
(CLASSROOM-MAKESHIFT), ROSA T ARELLANO ES  
LOC: BRGY. MACABOG, WEST DISTRICT  
SORSOGON CITY

DRAWN BY:  
Ma Pamela Legaspi  
DRAFTING AIDE

RECOMMENDING APPROVAL:  
ROEL D. DOMER, C.E./RMP  
CITY ENGINEER

APPROVED BY:  
MA. ESTER E. HAMOR  
CITY MAYOR



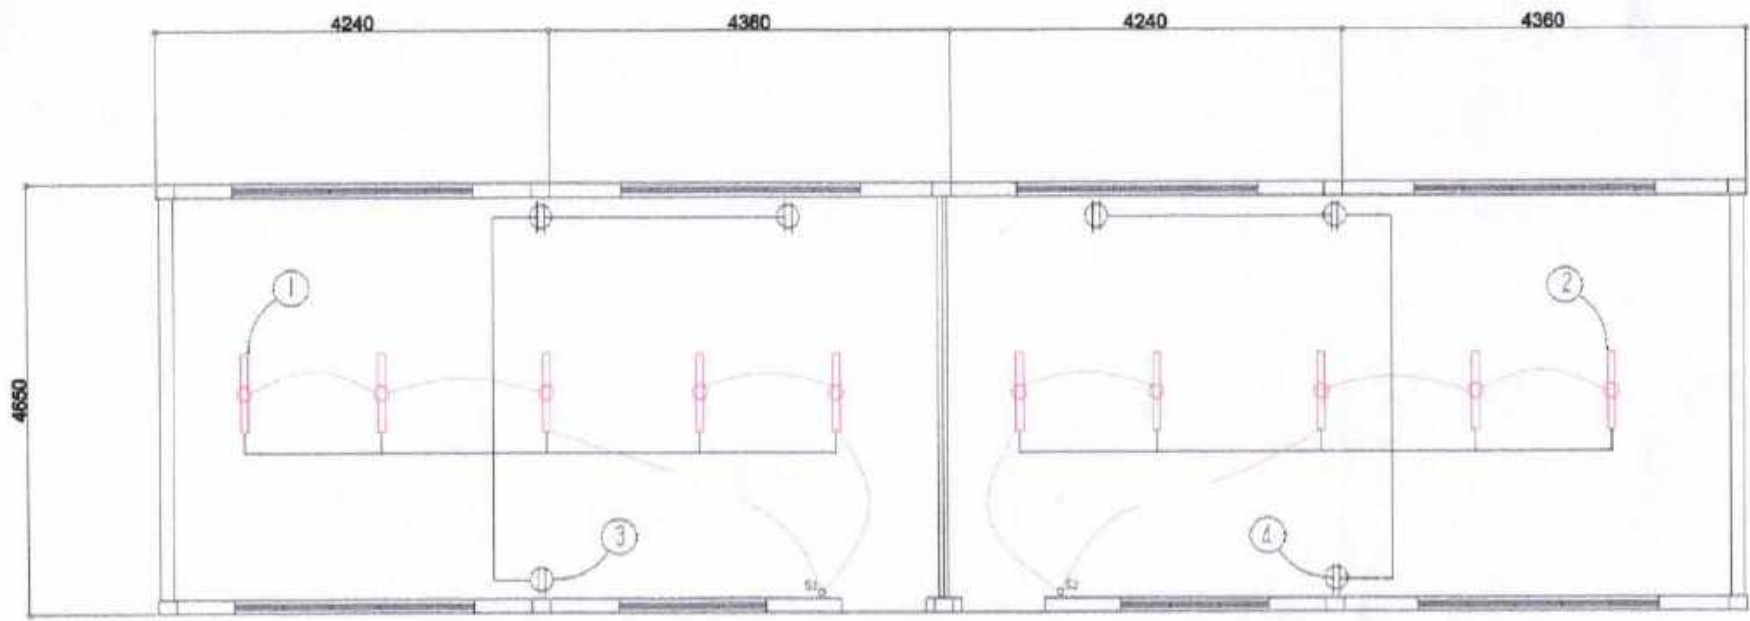

**ELECTRICAL PLAN**  
SCALE: \_\_\_\_\_ METERS

**ELECTRICAL NOTES**

ALL ELECTRICAL WORKS SHALL BE DONE IN ACCORDANCE WITH THE LATEST RULES AND REGULATIONS OF THE PHIL. ELECTRICAL CODE AS WELL AS THE LOCAL AUTHORITY CONCERNED AND THE LOCAL POWER COMPANY.

ALL ELECTRICAL MATERIALS TO BE USED SHALL BE NEED & APPROVED TYPE FOR LOCATION & PURPOSE

- MOUNTING HEIGHTS SHALL BE AS FOLLOWS:
- a. LIGHT CONTROL SWITCH- 1.35M ABOVE FIN. FLR. LINE AT CENTER
  - b. CONVENIENCE OUTLET-ABOVE 1.0M ABOVE FIN. FLR. LINE AT CENTER
  - c. PANEL BOARD- 2.0 M ABOVE FIN. FLR. LINE

ALL ELECTRICAL WORKS SHALL BE UNDER THE DIRECT & IMMEDIATE SUPERVISION OF A DULY LICENSED ELECTRICAL ENGINEER OR REGISTERED MASTER ELECTRICIAN

**SCHEDULE OF LOADS**

CIRCUIT NO.	DESCRIPTION	NO. OF LOADS	VOLTS	WATTS	AMP	SIZE OF WIRE	SIZE OF CONDUIT
1	LIGHTING OUTLET	5	230	500	2.17	2-2.0mm <sup>2</sup> THW	15mm $\emptyset$
2	LIGHTING OUTLET	5	230	500	2.17	2-2.0mm <sup>2</sup> THW	15mm $\emptyset$
3	CONVENIENCE OUTLET	3	230	540	2.34	2-3.5mm <sup>2</sup> THW	20mm $\emptyset$
4	CONVENIENCE OUTLET	3	230	540	2.34	2-3.5mm <sup>2</sup> THW	20mm $\emptyset$
	<b>TOTAL</b>				<b>9.02</b>		



SORSOGON CITY  
**CITY ENGINEER'S  
OFFICE**

PROJECT TITLE: REPAIR/IMPROV. OF MULTI-PURPOSE HALL (CLASSROOM-MAKESHIFT), ROSA T ARELLANO ES	DRAWN BY: MaPame (Alegaspi)	RECOMMENDING APPROVAL: ROEL D. DOMER, C.E./RMP CITY ENGINEER	APPROVED BY: MA. ESTER E. HAMCR CITY MAYOR
LOC: BRGY. MACABOG, WEST DISTRICT SORSOGON CITY	DRAFTING AIDE		

PLEASE STOP

**ROSA T. ARELLANO ELEMENTARY SCHOOL**


**MAKE SHIFT/TEMPORARY BUILDING**



**ROSA T. ARELLANO ELEMENTARY SCHOOL**

**IMLEDA TYPE 3 BUILDING**



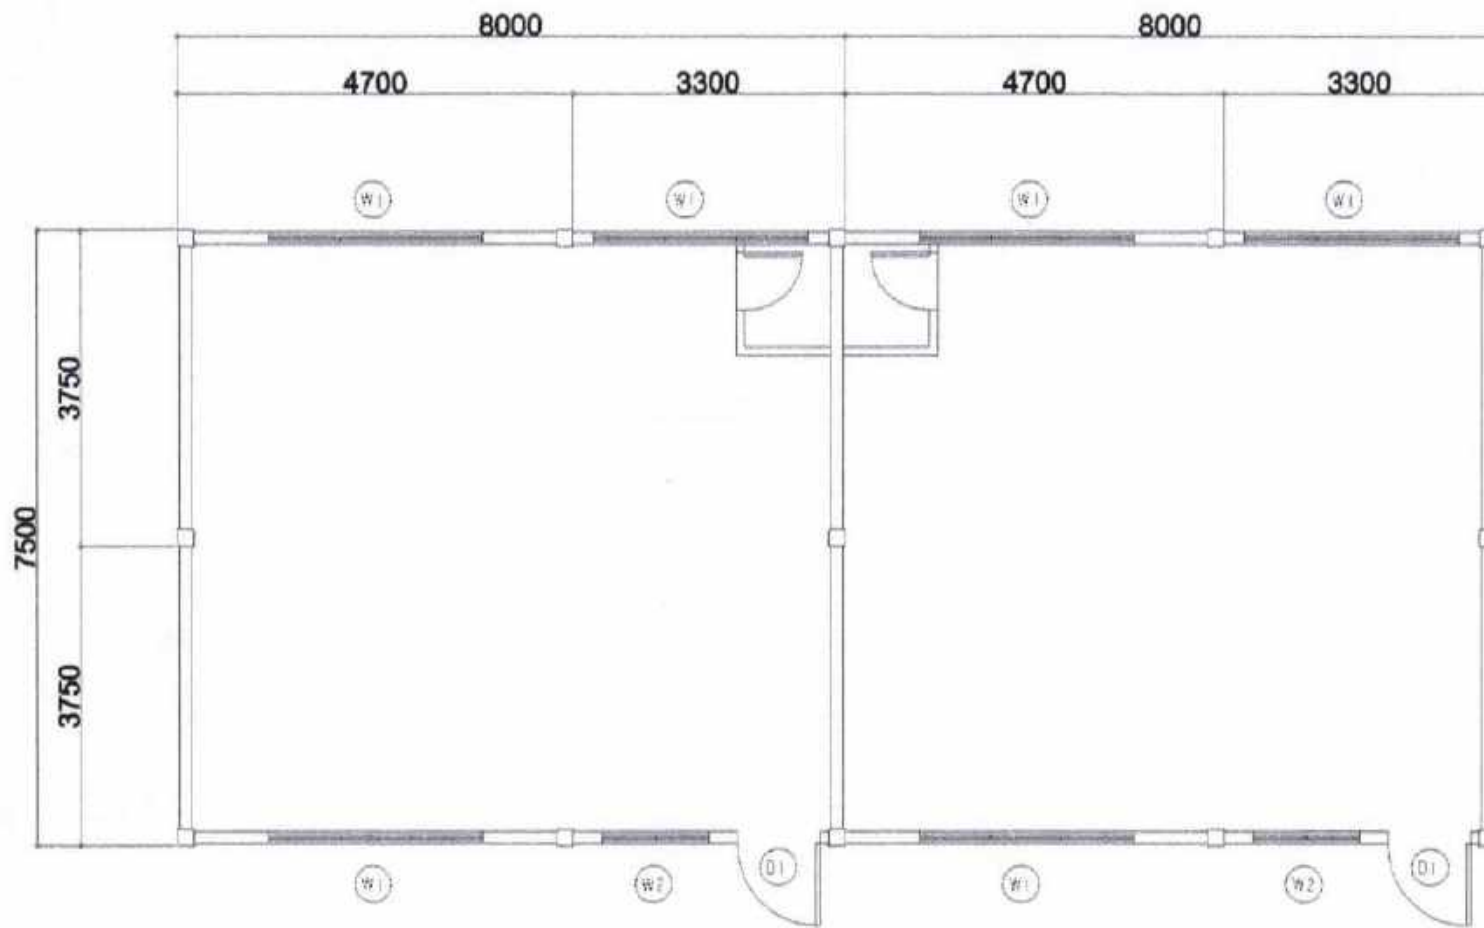

EXISTING FLOOR PLAN  
SCALE: 1:50



CITY ENGINEER'S  
OFFICE

PROJECT TITLE:

REPAIR/IMPROV. OF MULTI-PURPOSE HALL (IMELDA  
TYPE 2 BLDG.), ROSA T ARELLANO ES

LOC: BRGY. MACABOG, WEST DISTRICT  
SORSOGON CITY

DRAWN BY:


MaPanelaLagasci  
DRAFTING AIDE

RECOMMENDING APPROVAL:


ROEL P. DOMER, C.E./RMP  
CITY ENGINEER

APPROVED BY:

MA. ESTER E. HAMOR  
CITY MAYOR

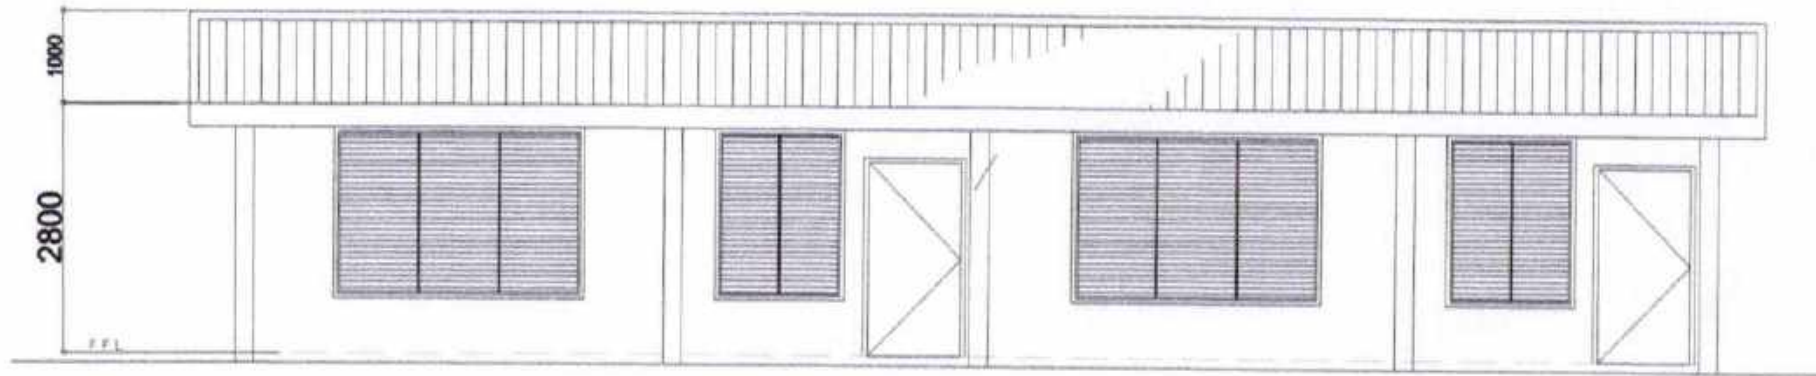

FRONT ELEVATION  
SCALE: 1:200

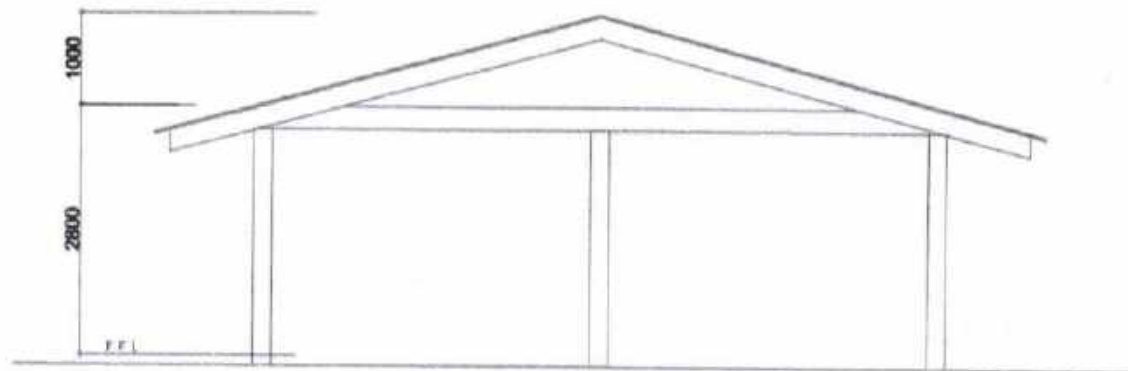


RIGHT SIDE ELEV.  
SCALE: 1:200



CITY ENGINEER'S  
OFFICE

PROJECT TITLE:	DRAWN BY:	RECOMMENDING APPROVAL:	APPROVED BY:
REPAIR/IMPROV. OF MULTI-PURPOSE HALL (IMELDA TYPE 2 BLDG.), ROSA T ARELLANO ES	Ma Pamela Legaspi	ROEL D. DOMER, C.E./RMP	MA. ESTER E. HAMOR
LOC: BRGY. MACABOG, WEST DISTRICT SORSOGON CITY	DRAFTING AIDE	CITY ENGINEER	CITY MAYOR

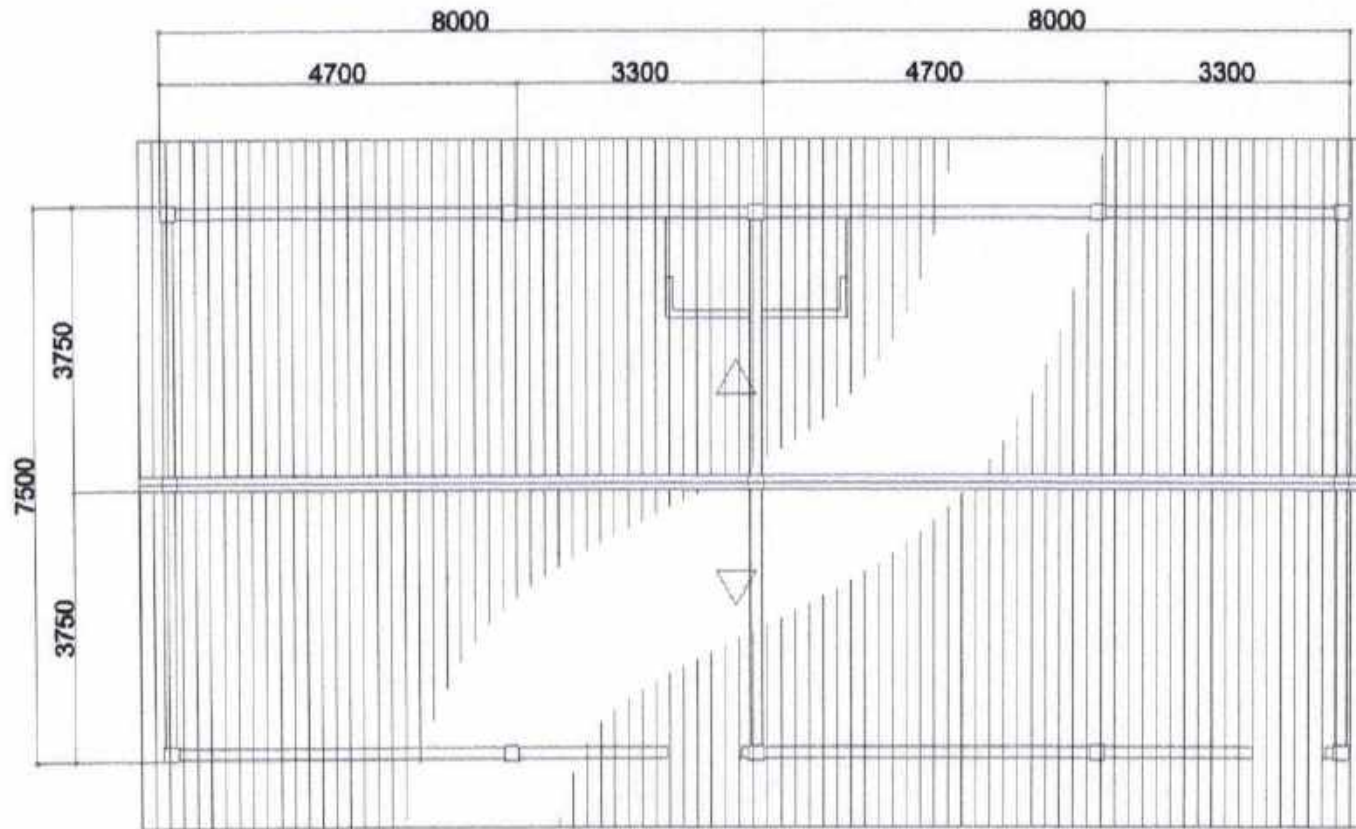


ROOF PLAN  
SCALE: 1/8" = 1'-0"




CITY ENGINEER'S  
OFFICE

PROJECT TITLE:	DRAWN BY:	RECOMMENDING APPROVAL:	APPROVED BY:
REPAIR/IMPROV. OF MULTI-PURPOSE HALL (MELDA TYPE 2 BLDG.), ROSA T ARELLANO ES	Ma Pamela I. ege sp1	ROEL D. DOMER, C.E./RMP	MA. ESTER E. HAMOR
LOC: BRGY. MACABOG, WEST DISTRICT SORSOGON CITY	DRAFTING AIDE	CIC-CITY ENGINEER	CITY MAYOR

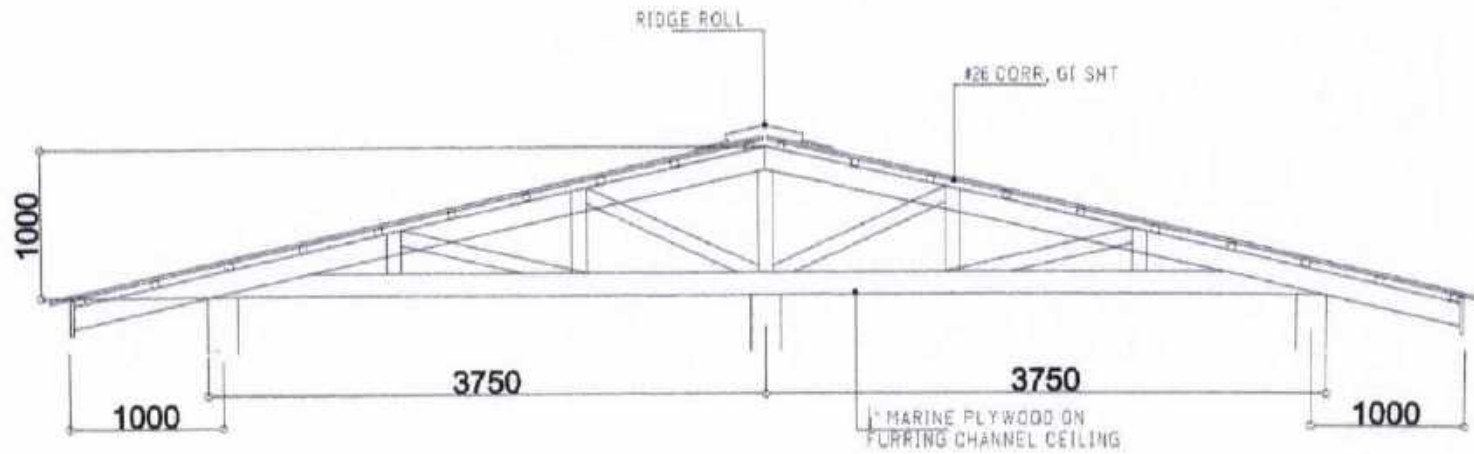

TRUSS DET.  
SCALE: 1:25M.T.S

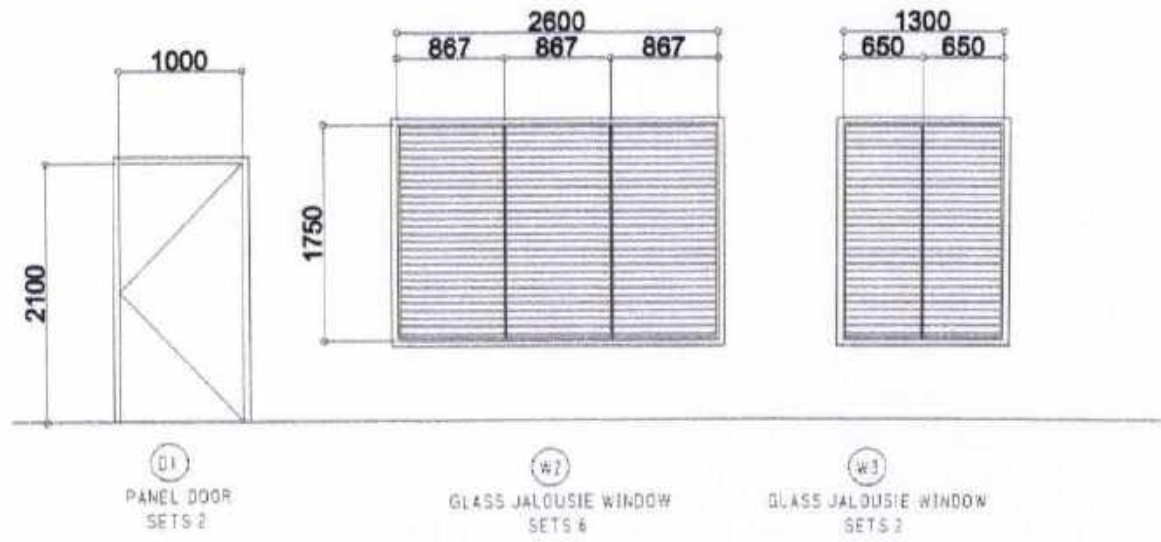



DOORS & WINDOWS SCHEDULE  
SCALE: 1:25M.T.S



CITY ENGINEER'S  
OFFICE

PROJECT TITLE:	DRAWN BY:	RECOMMENDING APPROVAL:	APPROVED BY:
REPAIR/IMPROV. OF MULTI-PURPOSE HALL (IMELDA TYPE 2 BLDG.), ROSA T ARELLANO ES	Ma Pamela Legaspi	ROEL D. DOMER, C.E., R.M.P.	MA. ESTER E. HAMOR
LOC: BRGY. MACABOG, WEST DISTRICT SORSOGON CITY	DRAFTING AIDE	CIC-CITY ENGINEER	CITY MAYOR

PLEASE SIGN

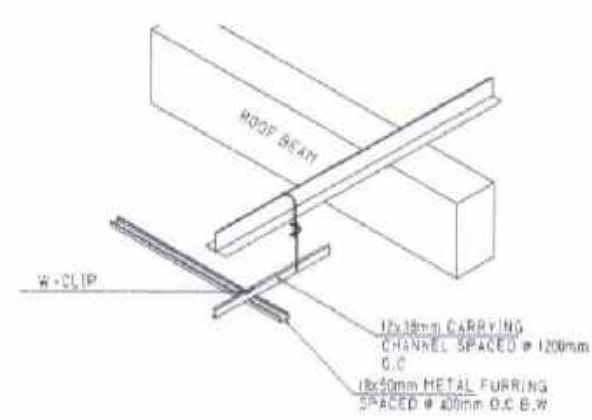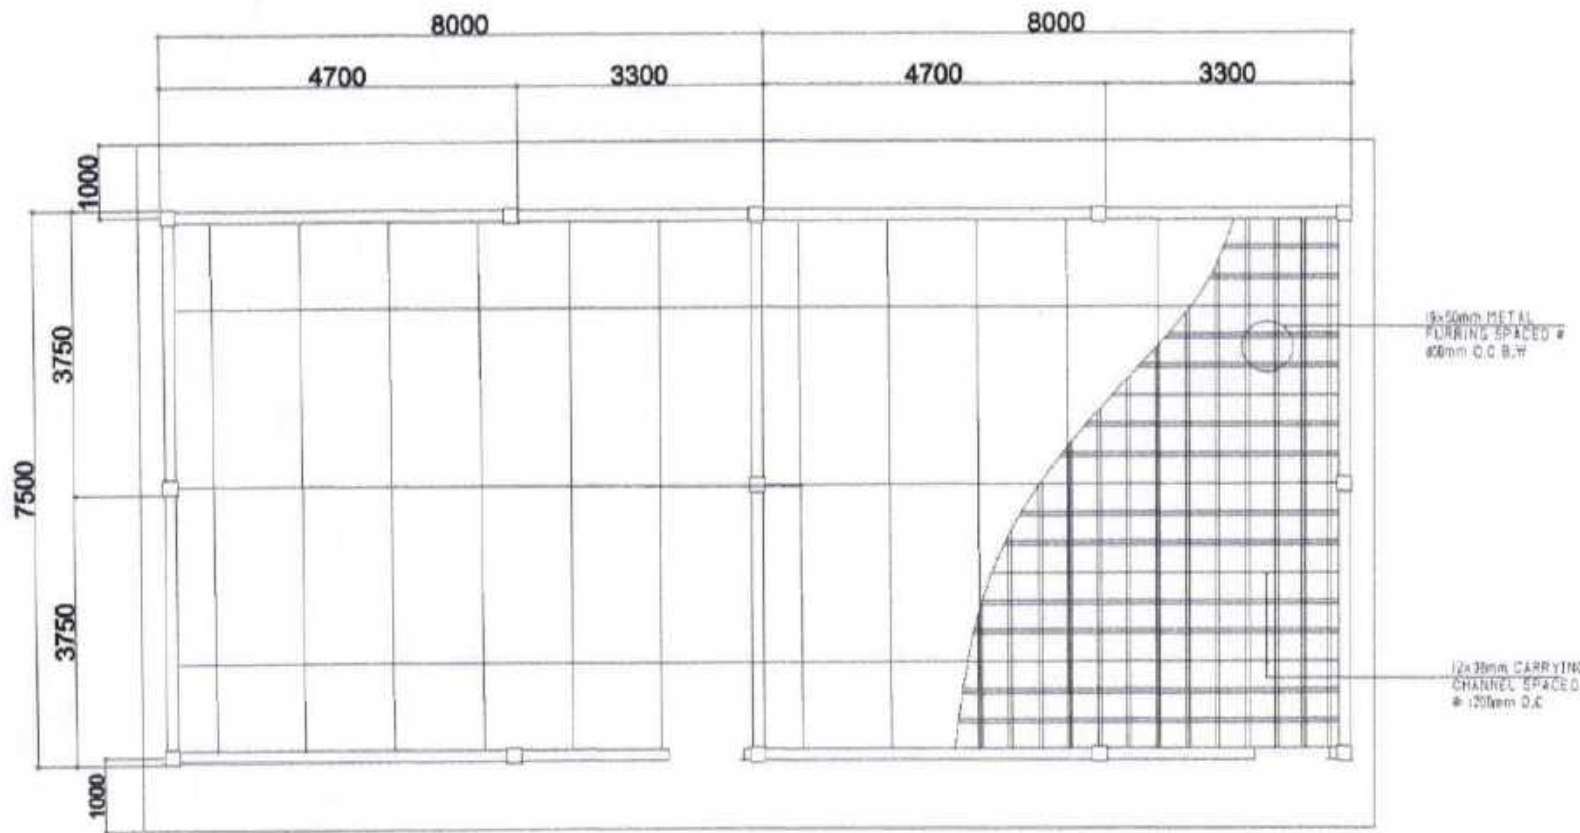

ISOMETRIC DRAWING

CEILING PLAN  
SCALE: 1:50



CITY ENGINEER'S  
OFFICE

PROJECT TITLE:  
REPAIR/IMPROV. OF MULTI-PURPOSE HALL (IMELDA  
TYPE 2 BLDG.), ROSA T ARELLANO ES  
LOC: BRGY. MACABOG, WEST DISTRICT  
SORSOGON CITY


DRAWN BY:  
Ma Pamela Legaspi  
DRAFTING AIDE

RECOMMENDING APPROVAL:  
ROEL D. DOMER, C.E./RMP  
CITY ENGINEER

APPROVED BY:  
MA. ESTER E. HAMOR  
CITY MAYOR

PLEASE SIGN



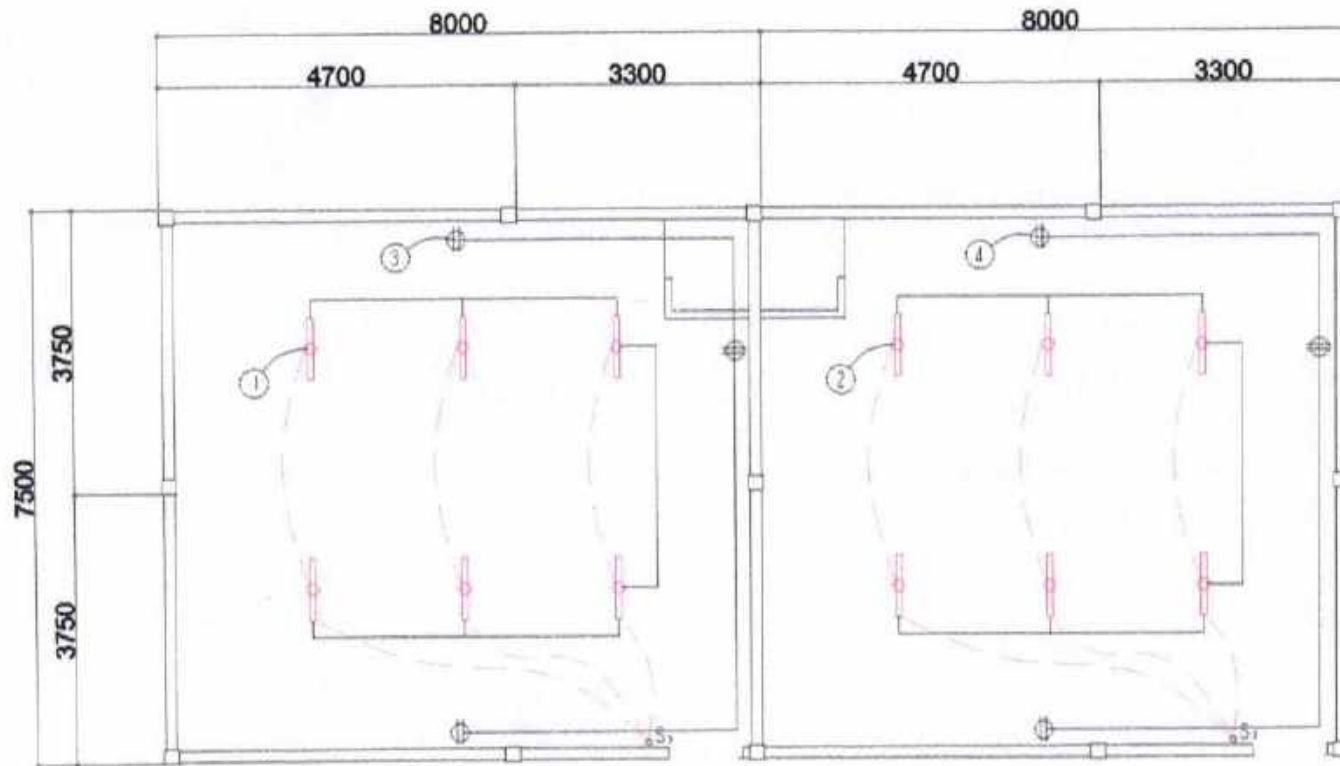

ELECTRICAL PLAN  
SCALE: 1/8" = 1'-0"

**ELECTRICAL NOTES**

ALL ELECTRICAL WORKS SHALL BE DONE IN ACCORDANCE WITH THE LATEST RULES AND REGULATIONS OF THE PHIL. ELECTRICAL CODE AS WELL AS THE LOCAL AUTHORITY CONCERNED AND THE LOCAL POWER COMPANY.

ALL ELECTRICAL MATERIALS TO BE USED SHALL BE NEED & APPROVED TYPE FOR LOCATION & PURPOSE

MOUNTING HEIGHTS SHALL BE AS FOLLOWS:

- a. LIGHT CONTROL SWITCH- 1.35M ABOVE FIN. FLR. LINE AT CENTER
- b. CONVENIENCE OUTLET-ABOVE 1.0M ABOVE FIN. FLR. LINE AT CENTER
- c. PANEL BOARD- 2.0 M ABOVE FIN. FLR. LINE

ALL ELECTRICAL WORKS SHALL BE UNDER THE DIRECT & IMMEDIATE SUPERVISION OF A DULY LICENSED ELECTRICAL ENGINEER OR REGISTERED MASTER ELECTRICIAN

**SCHEDULE OF LOADS**

CIRCUIT NO.	DESCRIPTION	NO. OF LOADS	VOLTS	WATTS	AMP	SIZE OF WIRE	SIZE OF CONDUIT
1	LIGHTING OUTLET	6	230	600	2.60	2-2.0mm <sup>2</sup> THW	15mm $\emptyset$
2	LIGHTING OUTLET	6	230	600	2.60	2-2.0mm <sup>2</sup> THW	15mm $\emptyset$
3	CONVENIENCE OUTLET	3	230	540	2.34	2-3.5mm <sup>2</sup> THW	20mm $\emptyset$
4	CONVENIENCE OUTLET	3	230	540	2.34	2-3.5mm <sup>2</sup> THW	20mm $\emptyset$
TOTAL					9.88		






**CITY ENGINEER'S  
OFFICE**

PROJECT TITLE:  
REPAIR/IMPROV. OF MULTI-PURPOSE HALL (IMELDA  
TYPE 2 BLDG.), ROSA T ARELLANO ES  
LOC: BRGY. MACABOG, WEST DISTRICT  
SORSOGON CITY

DRAWN BY:  
MaPamela Legaspi  
DRAFTING AIDE

RECOMMENDING APPROVAL :  
ROEL D. DOMER, C.E./RMB  
CIC-CITY ENGINEER

APPROVED BY:  
MA. ESTER E. HAMOR  
CITY MAYOR

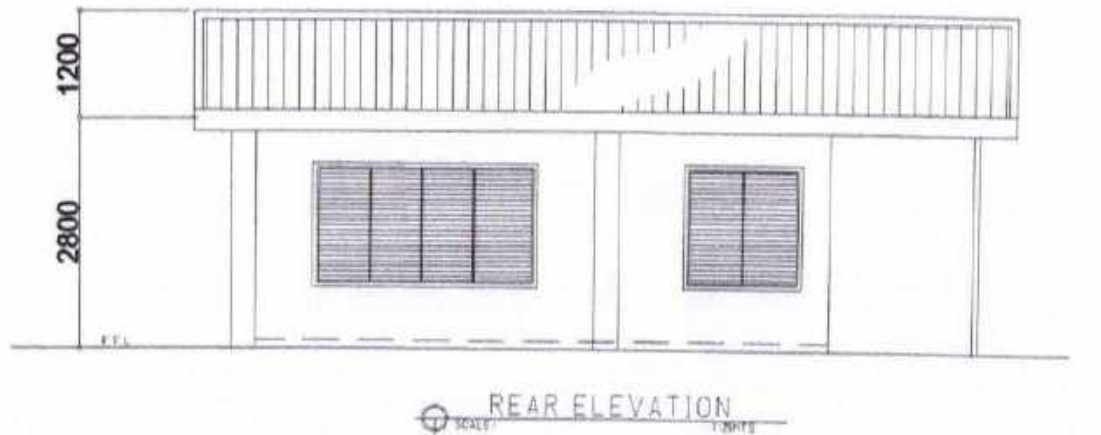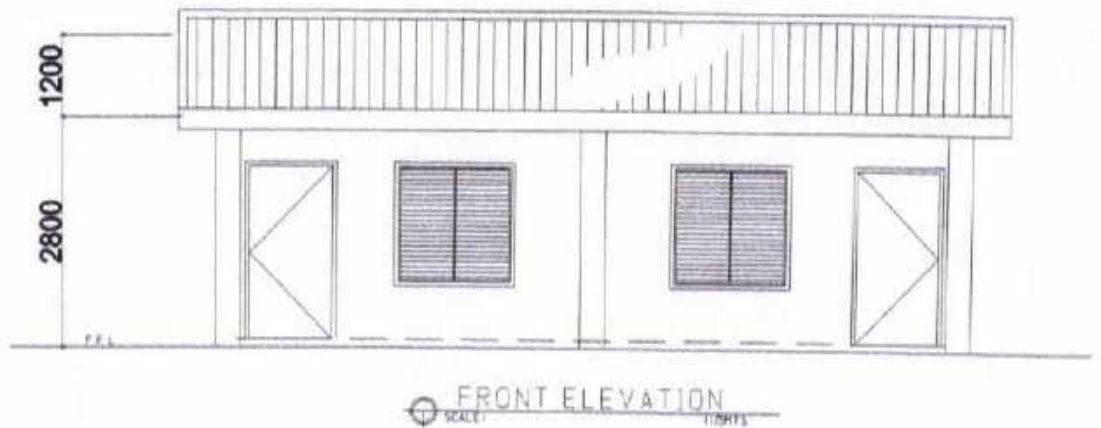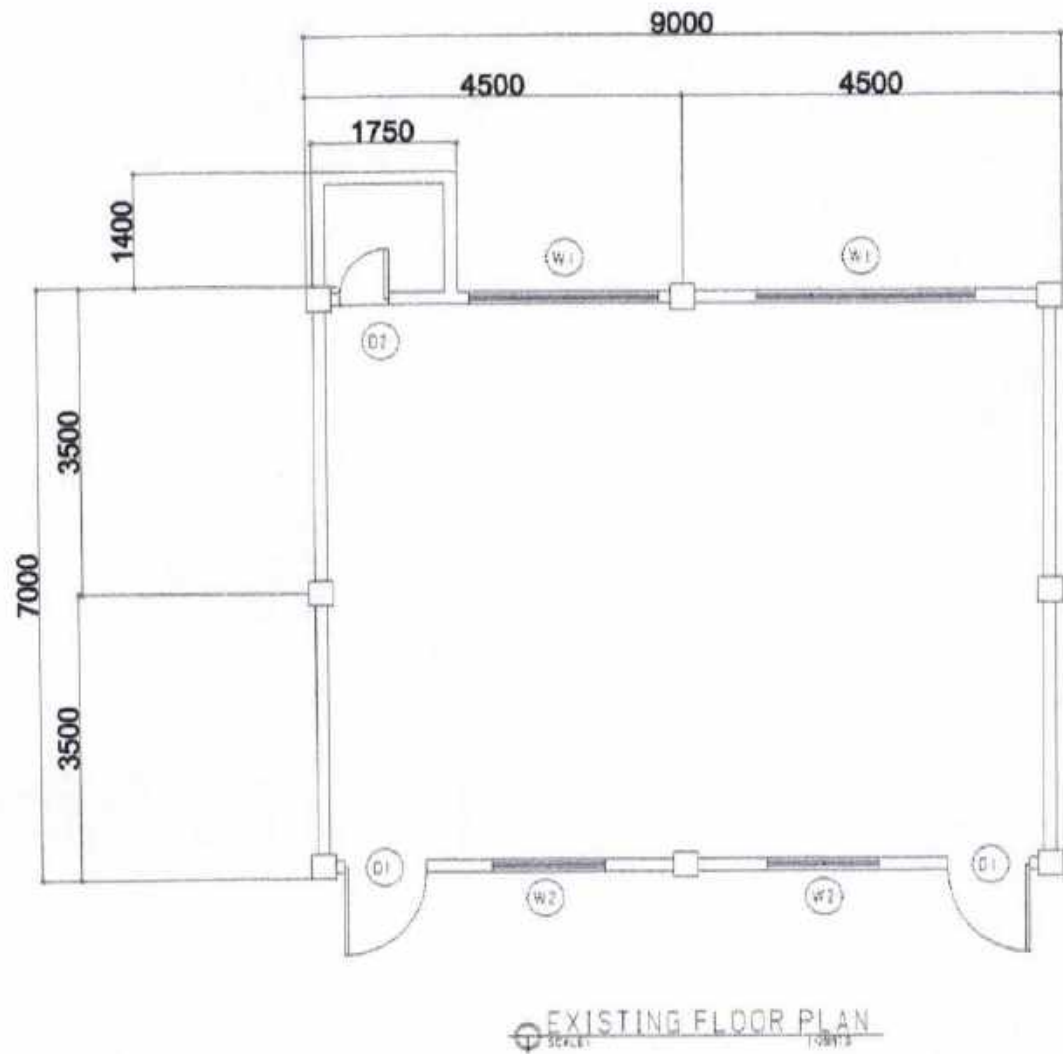

SORSOGON CITY  
**CITY ENGINEER'S  
 OFFICE**


PROJECT TITLE:  
 REPAIR/IMPROV. OF MULTI-PURPOSE HALL (PRE  
 SCHOOL KINDERGARTEN BLDG.), ROSA T  
 ARELLANO ES  
 LOC: BRGY. MACABOG, WEST DISTRICT  
 SORSOGON CITY

DRAWN BY:  
 MaPamela Legaspi  
 DRAFTING AIDE



RECOMMENDING APPROVAL:  
 ROEL D. DOMER, C.E./RMP  
 DIC-CITY ENGINEER

APPROVED BY:  
 MA. ESTER E. HAMOR  
 CITY MAYOR

PLEASE SIGN

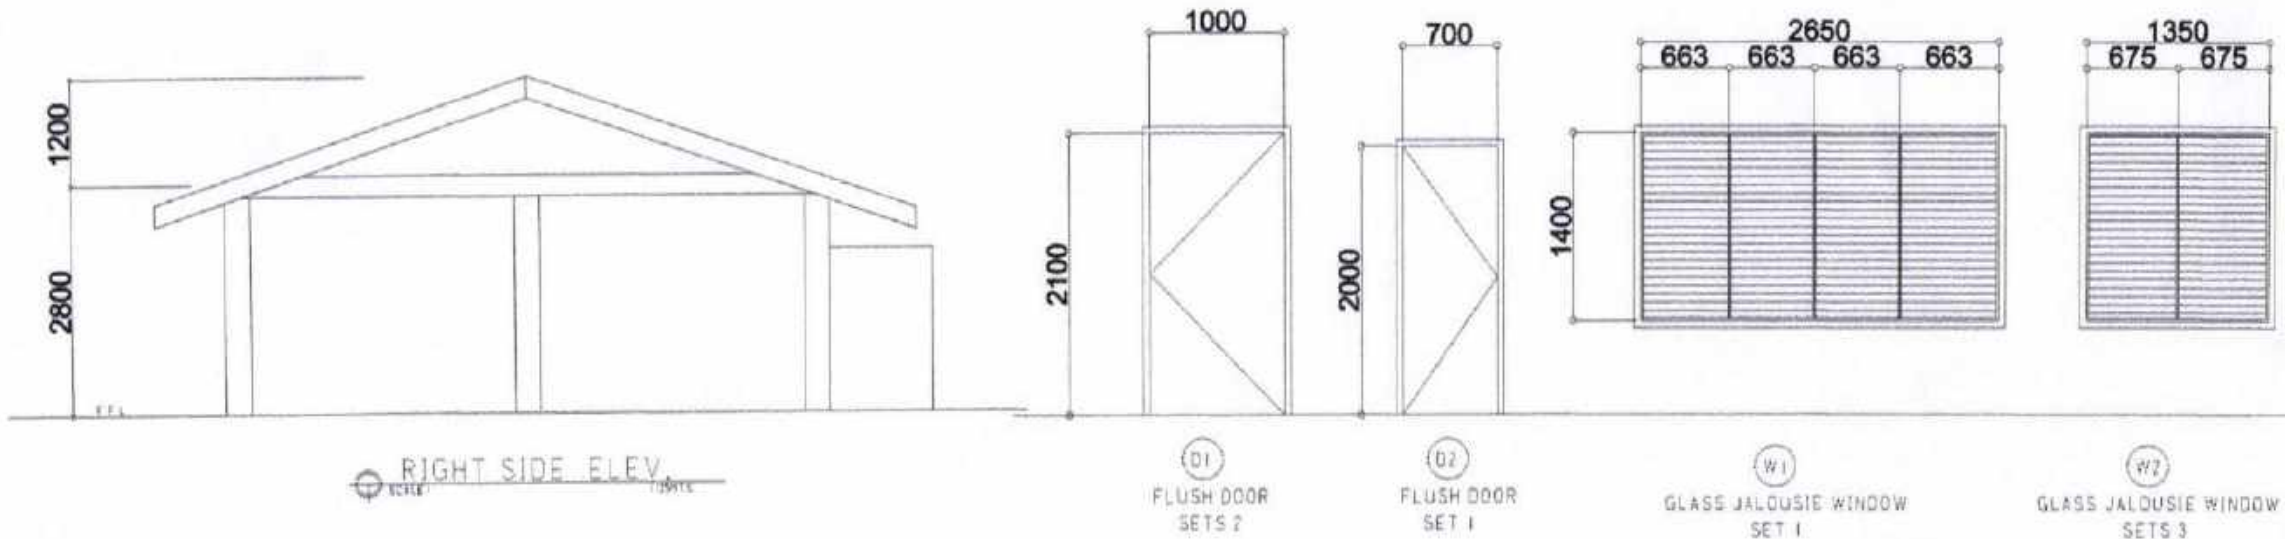


**DOORS & WINDOWS SCHEDULE**  
SCALE: 1:25MTS

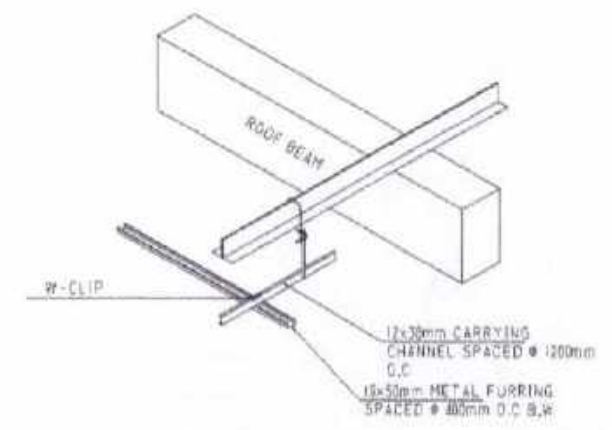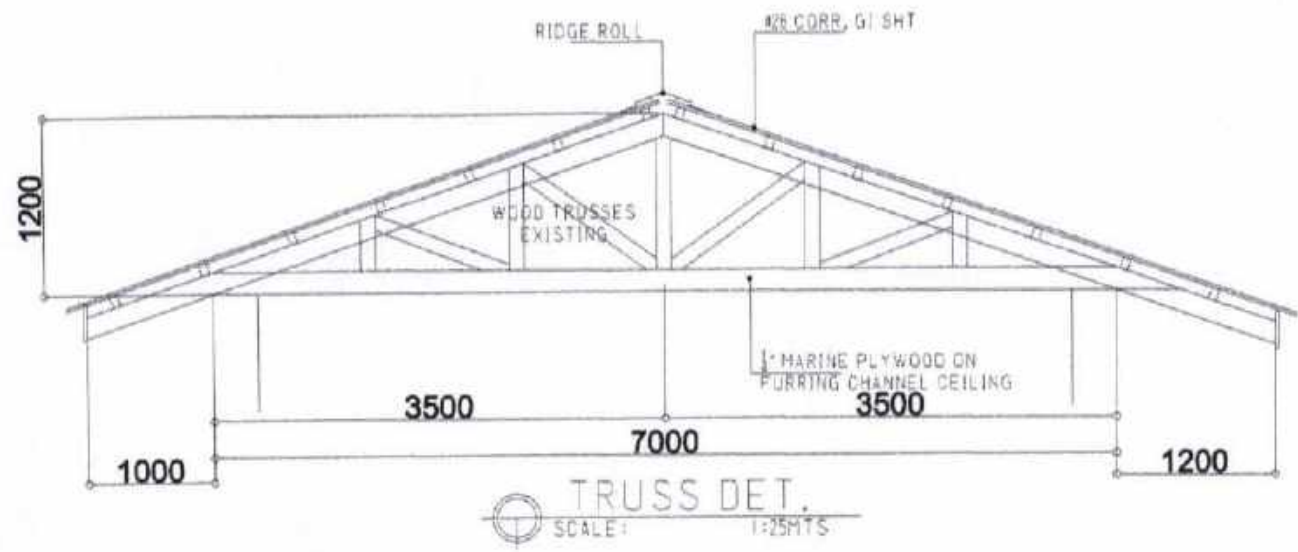


SORSOGON CITY  
**CITY ENGINEER'S OFFICE**

PROJECT TITLE: REPAIR/IMPROV. OF MULTI-PURPOSE HALL (PRE SCHOOL KINDERGARTEN BLDG.), ROSA T ARELLANO ES	DRAWN BY: MaPana (aLegasp)	RECOMMENDING APPROVAL: ROEL D. DOMER, CE/RMP CIC-CITY ENGINEER	APPROVED BY: MA. ESTER E. HAMOR CITY MAYOR
LOC: BRGY. MACABOG, WEST DISTRICT SORSOGON CITY	DRAFTING AIDE		



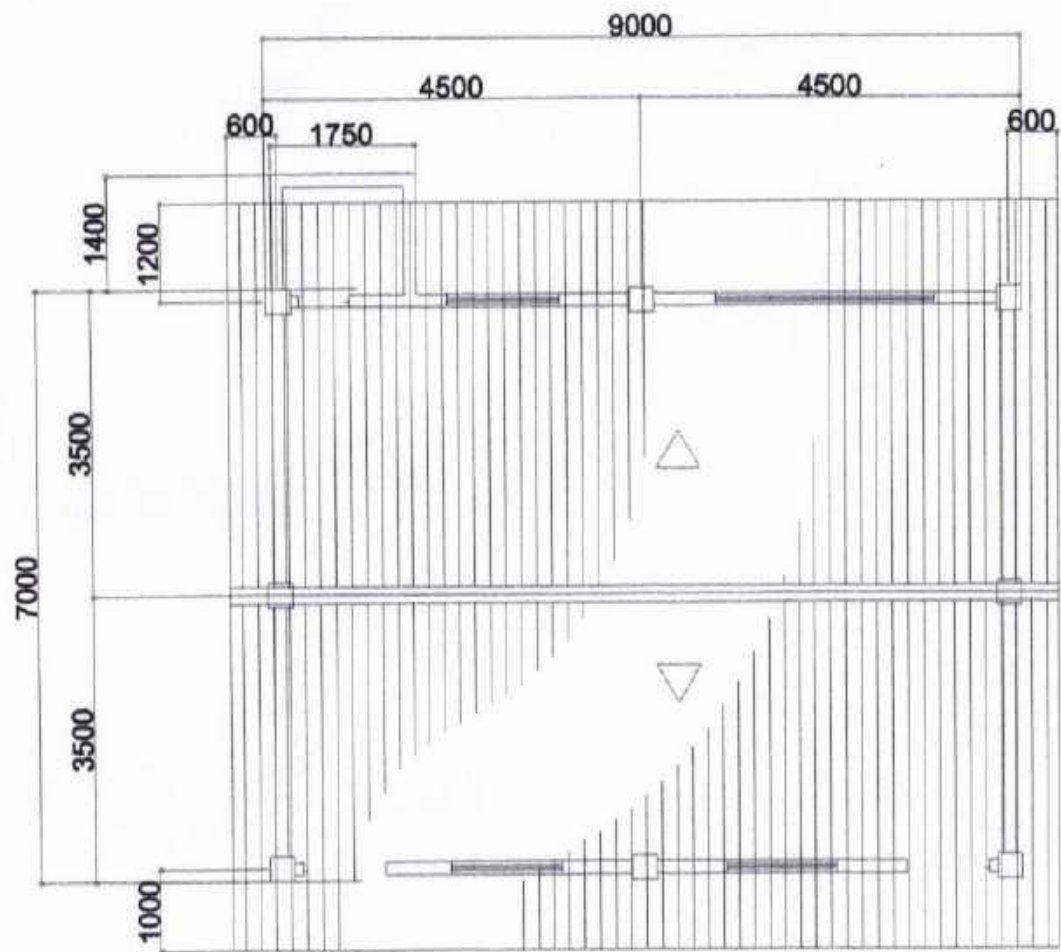

ROOF PLAN  
SCALE: 1/8"=1'-0"

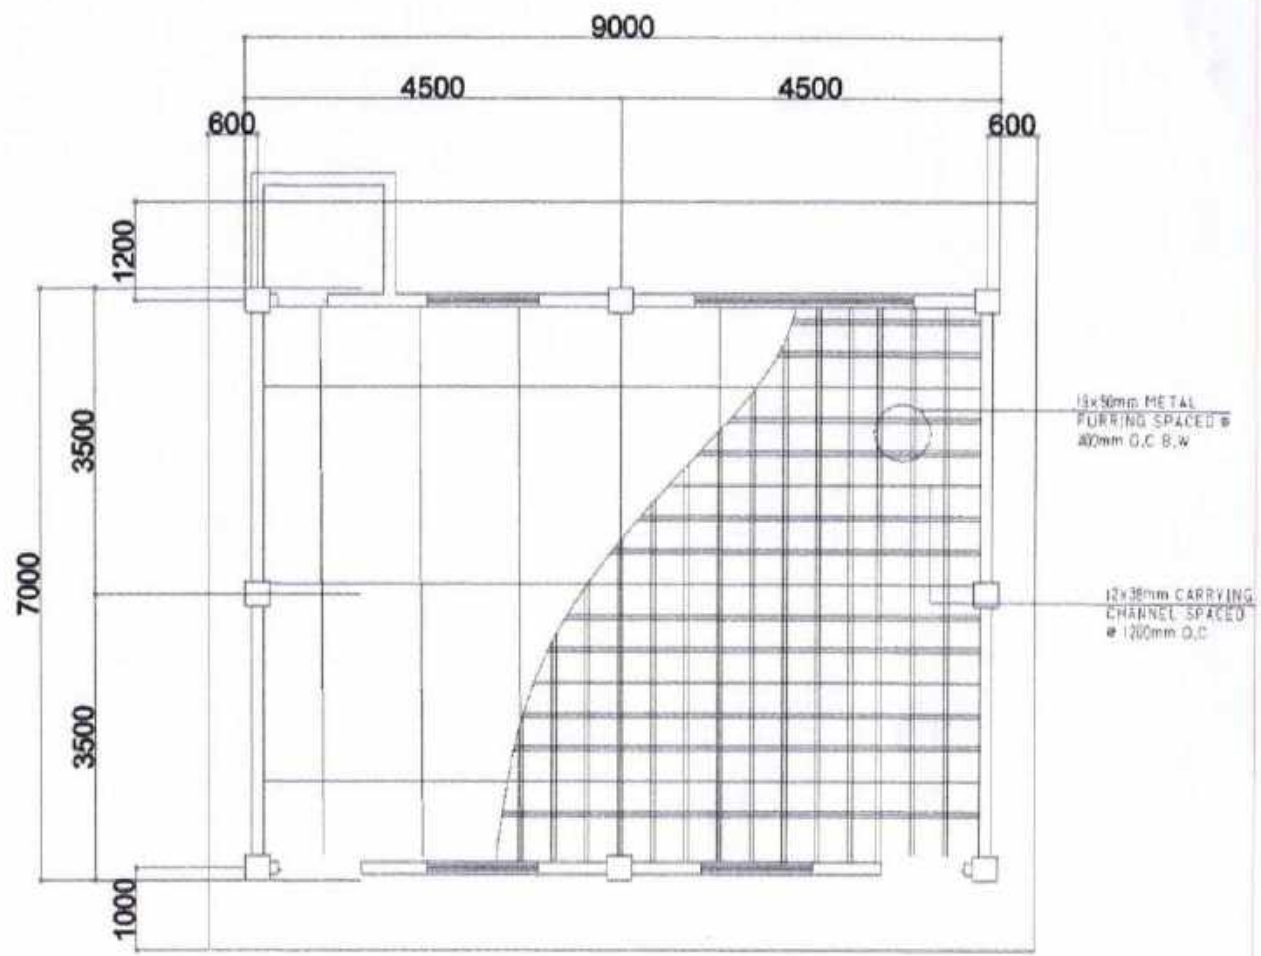

CEILING PLAN  
SCALE: 1/8"=1'-0"



SORSOGON CITY  
CITY ENGINEER'S  
OFFICE


PROJECT TITLE:  
REPAIR/IMPROV. OF MULTI-PURPOSE HALL (PRE  
SCHOOL KINDERGARTEN BLDG.), ROSA T  
ARELLANO ES  
LOC: BRGY. MACABOG, WEST DISTRICT  
SORSOGON CITY

DRAWN BY:  
Ma Pamela S. Legaspi  
DRAFTING AIDE

RECOMMENDING APPROVAL:  
ROEL D. DOMER, C.E., RMP  
OIC-CITY ENGINEER

APPROVED BY:  
MA. ESTER E. HAMOR  
CITY MAYOR

PLEASE SIGN

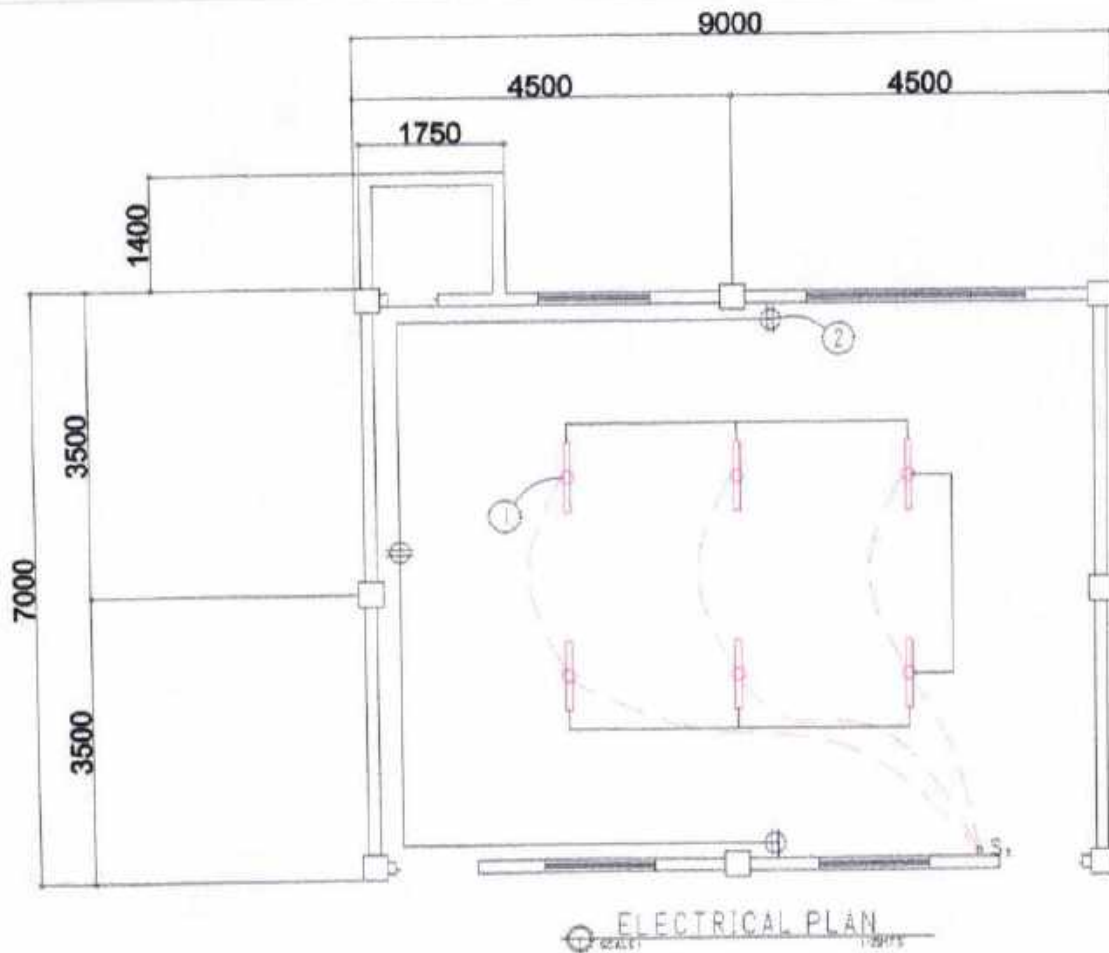

### ELECTRICAL NOTES

ALL ELECTRICAL WORKS SHALL BE DONE IN ACCORDANCE WITH THE LATEST RULES AND REGULATIONS OF THE PHIL. ELECTRICAL CODE AS WELL AS THE LOCAL AUTHORITY CONCERNED AND THE LOCAL POWER COMPANY.

ALL ELECTRICAL MATERIALS TO BE USED SHALL BE NEED & APPROVED TYPE FOR LOCATION & PURPOSE

MOUNTING HEIGHTS SHALL BE AS FOLLOWS:

- LIGHT CONTROL SWITCH- 1.35M ABOVE FIN. FLR. LINE AT CENTER
- CONVENIENCE OUTLET-ABOVE 1.0M ABOVE FIN. FLR. LINE AT CENTER
- PANEL BOARD- 2.0 M ABOVE FIN. FLR. LINE

ALL ELECTRICAL WORKS SHALL BE UNDER THE DIRECT & IMMEDIATE SUPERVISION OF A DULY LICENSED ELECTRICAL ENGINEER OR REGISTERED MASTER ELECTRICIAN

### SCHEDULE OF LOADS

CIRCUIT NO.	DESCRIPTION	NO. OF LOADS	VOLTS	WATTS	AMP	SIZE OF WIRE	SIZE OF CONDUIT
1	LIGHTING OUTLET	6	230	600	2.60	2-2.0mm <sup>2</sup> THW	15mmØ
2	CONVENIENCE OUTLET	3	230	540	2.34	2-3.5mm <sup>2</sup> THW	20mmØ
	<b>TOTAL</b>				<b>4.94</b>		



SORSOGON CITY  
CITY ENGINEER'S  
OFFICE

PROJECT TITLE:  
REPAIR/IMPROV. OF MULTI-PURPOSE HALL (PRE  
SCHOOL KINDERGARTEN BLDG.), ROSA T  
ARELLANO ES

LOC: BRGY. MACABOG, WEST DISTRICT  
SORSOGON CITY

DRAWN BY:  
MaPansia Legaspi  
DRAFTING AIDE

RECOMMENDING APPROVAL:  
ROEL D. DOMER, CE TRMP  
CIC-CITY ENGINEER

APPROVED BY:  
MA. ESTER E. HAMOR  
CITY MAYOR

**ROSA T. ARELLANO ELEMENTARY SCHOOL**


**PRE SCHOOL KINDERGARTEN BUILDING**



**ROSA T. ARELLANO ELEMENTARY SCHOOL**

**IMELDA TYPE 2 BUILDING**



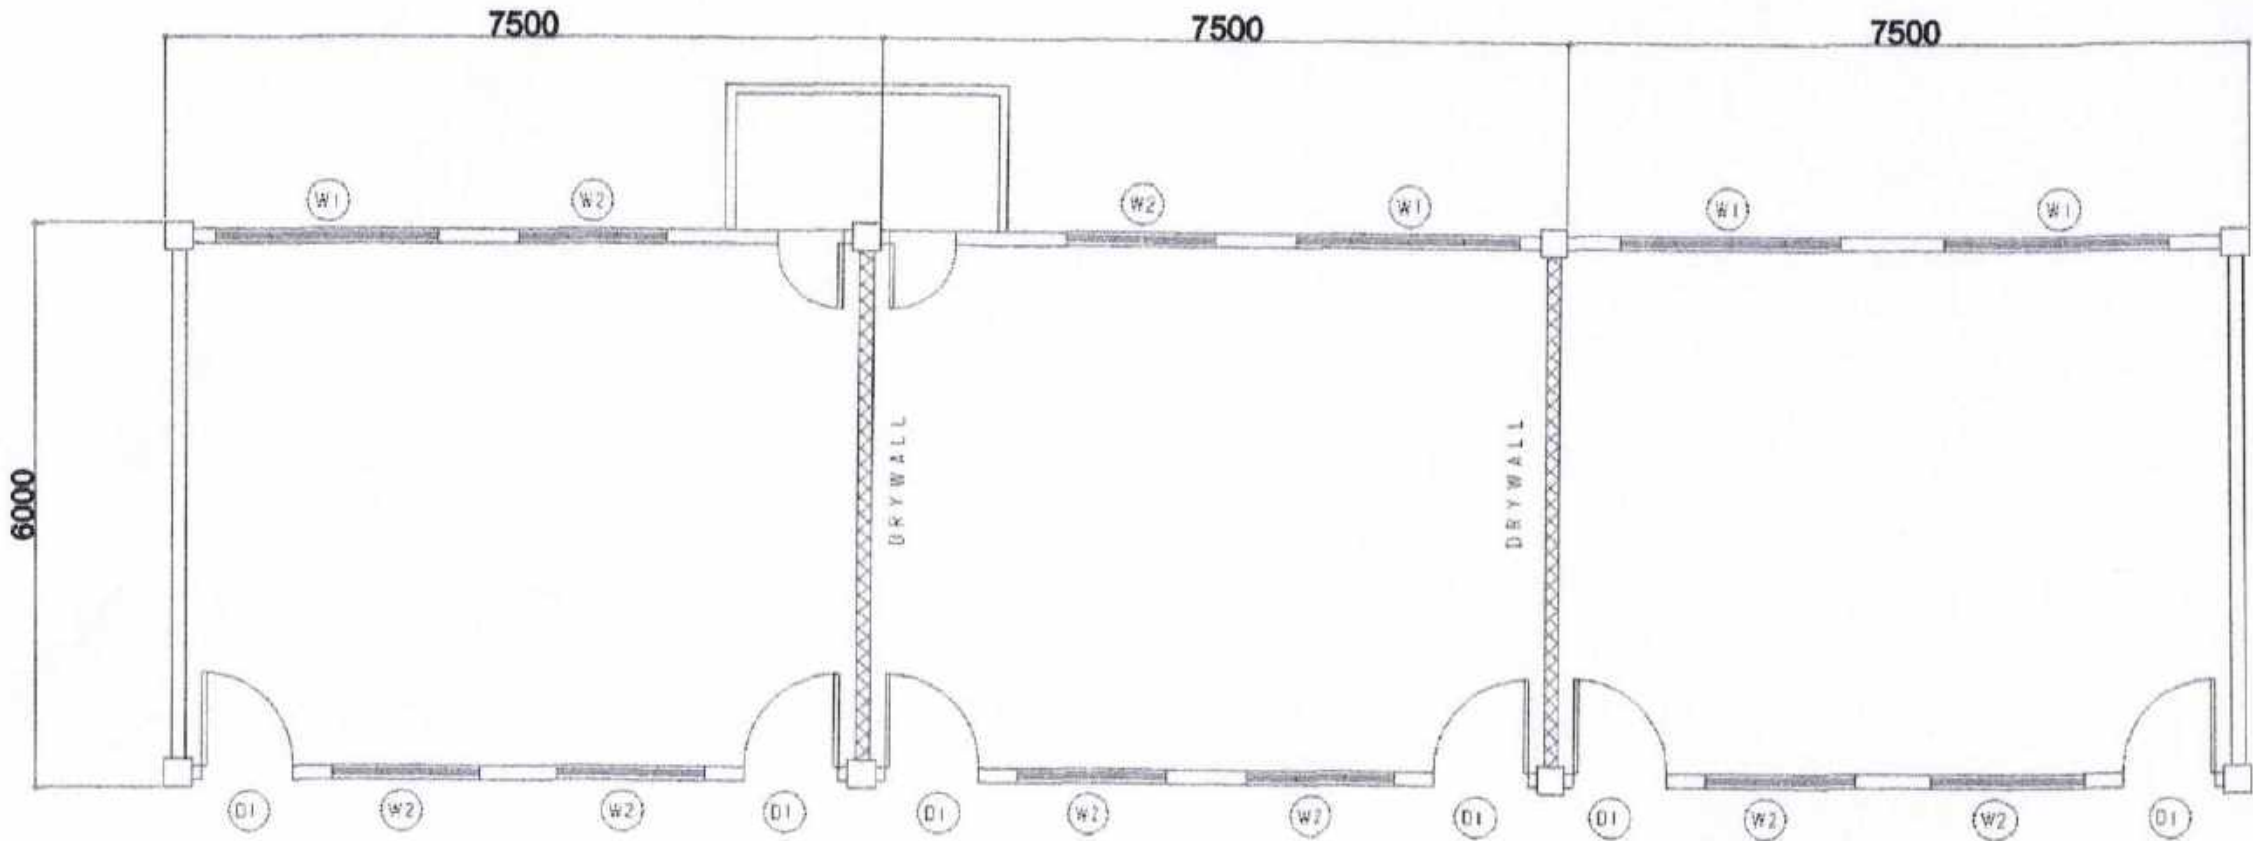

EXISTING FLOOR PLAN  
SCALE: 1/8" = 1'-0"

 


SORSOGON CITY  
CITY ENGINEER'S  
OFFICE

PROJECT TITLE:  
REPAIR/IMPROV. OF MULTI-PURPOSE HALL  
(MARCOS TYPE 1 BLDG.), ROSA T ARELLANO ES  
LOC: BRGY. MACABOG, WEST DISTRICT  
SORSOGON CITY


DRAWN BY:  
Ma Pamela Legaspi  
DRAFTING AIDE

RECOMMENDING APPROVAL:  
  
ROEL D. DIMER, P.E./RMP  
CIC-CITY ENGINEER


APPROVED BY:  
  
MA. ESTER E. HAMOR  
CITY MAYOR

PLEASE SIGN



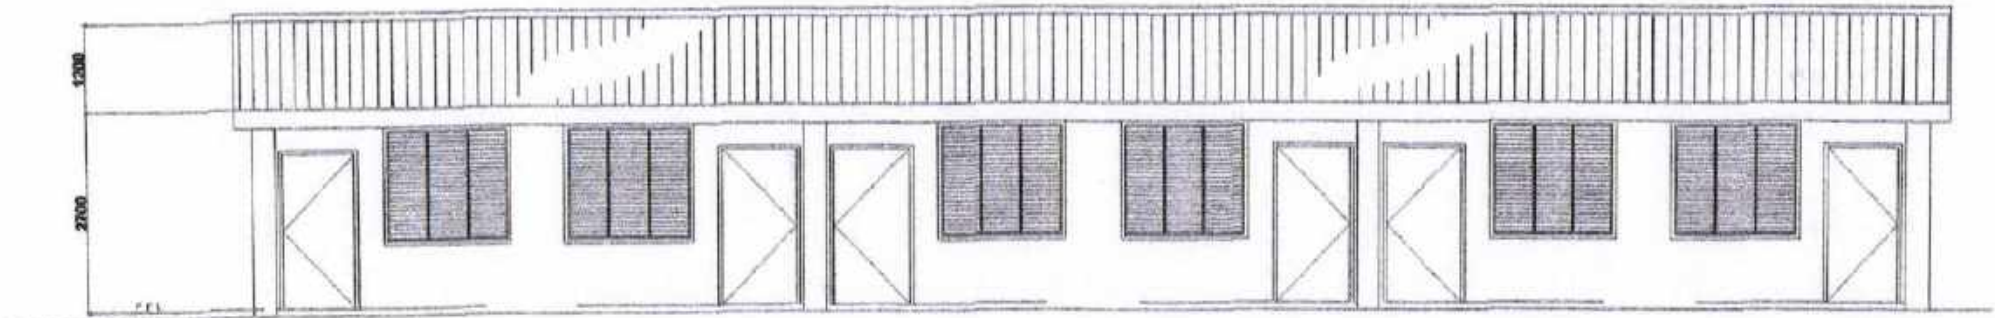

FRONT ELEVATION

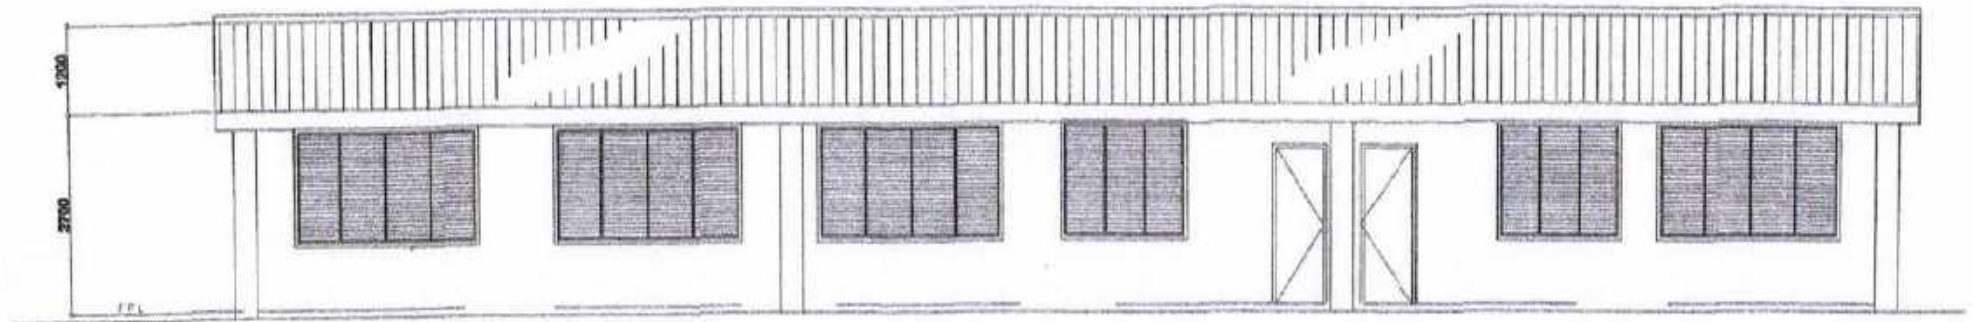

REAR ELEVATION



SORSOGON CITY  
CITY ENGINEER'S  
OFFICE


PROJECT TITLE:  
REPAIR/IMPROV. OF MULTI-PURPOSE HALL  
(MARCOS TYPE 1 BLDG.), ROSA T ARELLANO ES  
LOC: BRGY. MACABOG, WEST DISTRICT  
SORSOGON CITY

DRAWN BY:  
Ma Pamela Legaspi  
DRAFTING AIDE


RECOMMENDING APPROVAL :  
ROEL D. BOMER, C.E./RMP  
OIC CITY ENGINEER

APPROVED BY:  
MA. ESTER E. HAMOR  
CITY MAYOR




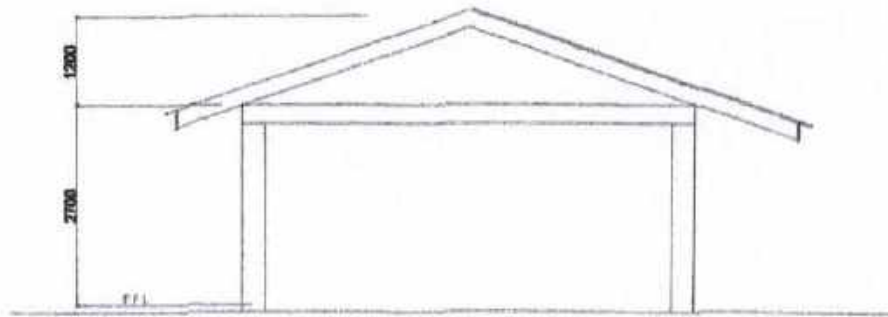

RIGHT SIDE ELEV.  
SCALE: 1:25MTS

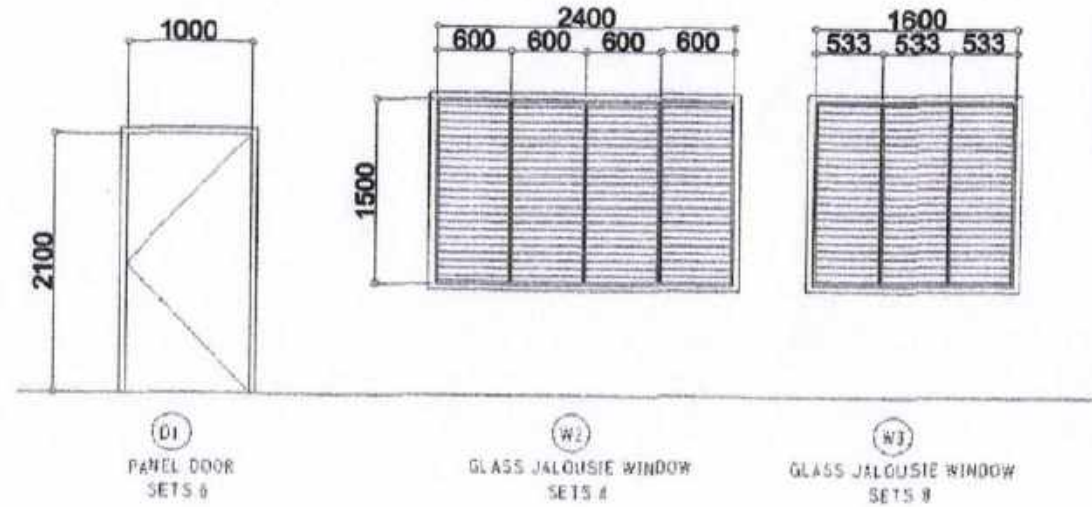

DOORS & WINDOWS SCHEDULE  
SCALE: 1:25MTS

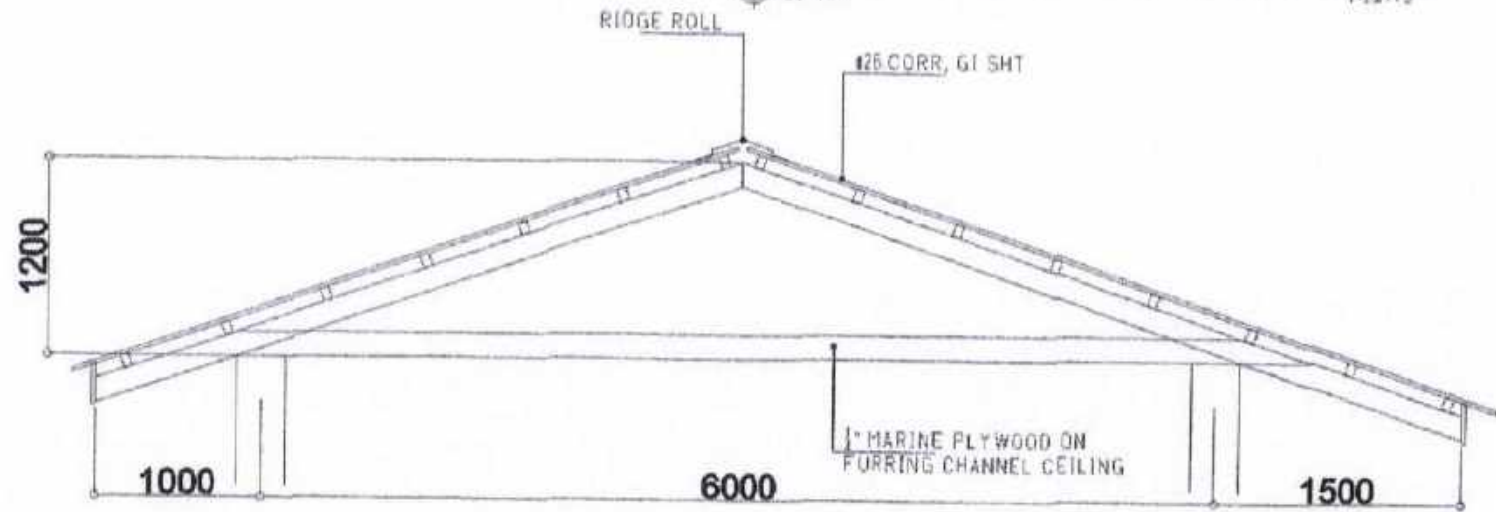

TRUSS DET.  
SCALE: 1:25MTS



SORSOGON CITY  
CITY ENGINEER'S  
OFFICE

PROJECT TITLE:  
REPAIR/IMPROV. OF MULTI-PURPOSE HALL  
(MARCOS TYPE 1 BLDG.), ROSA T ARELLANO ES  
LOC: BRGY. MACABOG, WEST DISTRICT  
SORSOGON CITY

DRAWN BY:

Mo Pamela Legaspi  
DRAFTING AIDE


RECOMMENDING APPROVAL:

ROEL D. DOMER, C.E./RMP  
CITY ENGINEER

APPROVED BY:

MA. ESTER E. HAMOR  
CITYMAYOR

PLEASE SIGN

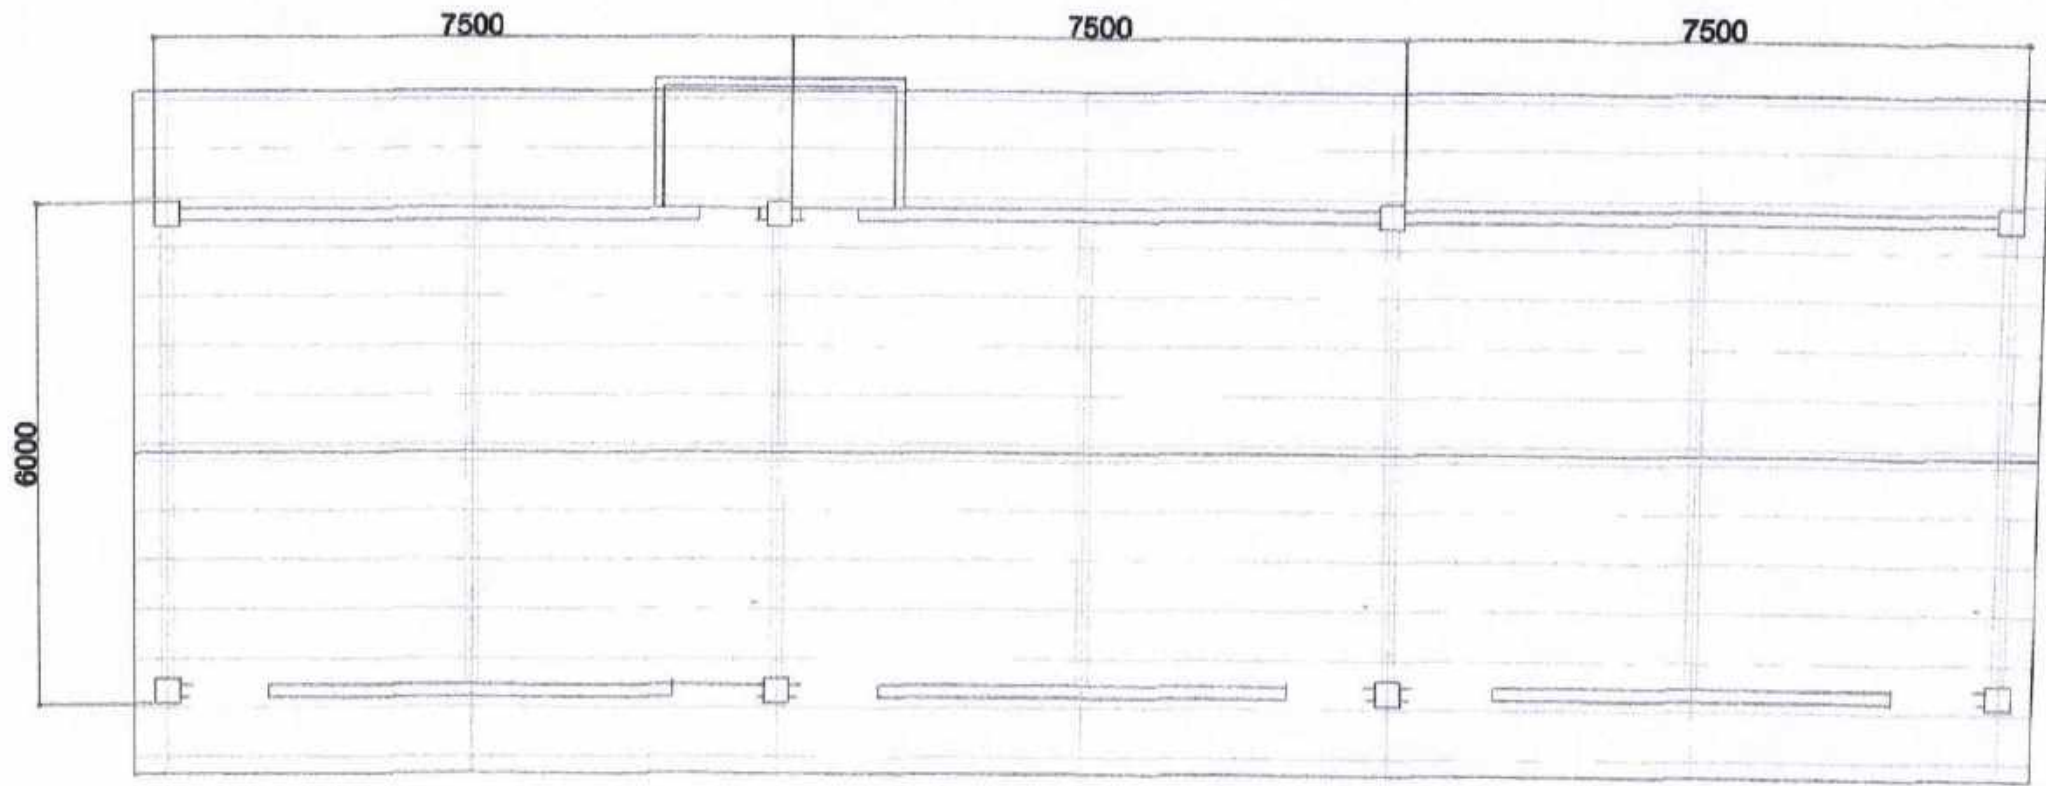

ROOF FRAMING PLAN  
SCALE: 1/200



SORSOGON CITY  
CITY ENGINEER'S  
OFFICE


PROJECT TITLE:  
REPAIR/IMPROV. OF MULTI-PURPOSE HALL  
(MARCOS TYPE 1 BLDG.), ROSA T ARELLANO ES  
LOC: BRGY. MACABOG, WEST DISTRICT  
SORSOGON CITY

DRAWN BY:  
Ma Pamela Legaspi  
DRAFTING AIDE

RECOMMENDING APPROVAL:  
ROEL D. DOMER, C.E./RMP  
CITY ENGINEER

APPROVED BY:  
MA. ESTER E. HAMOR  
CITY MAYOR

PLEASE SIGN

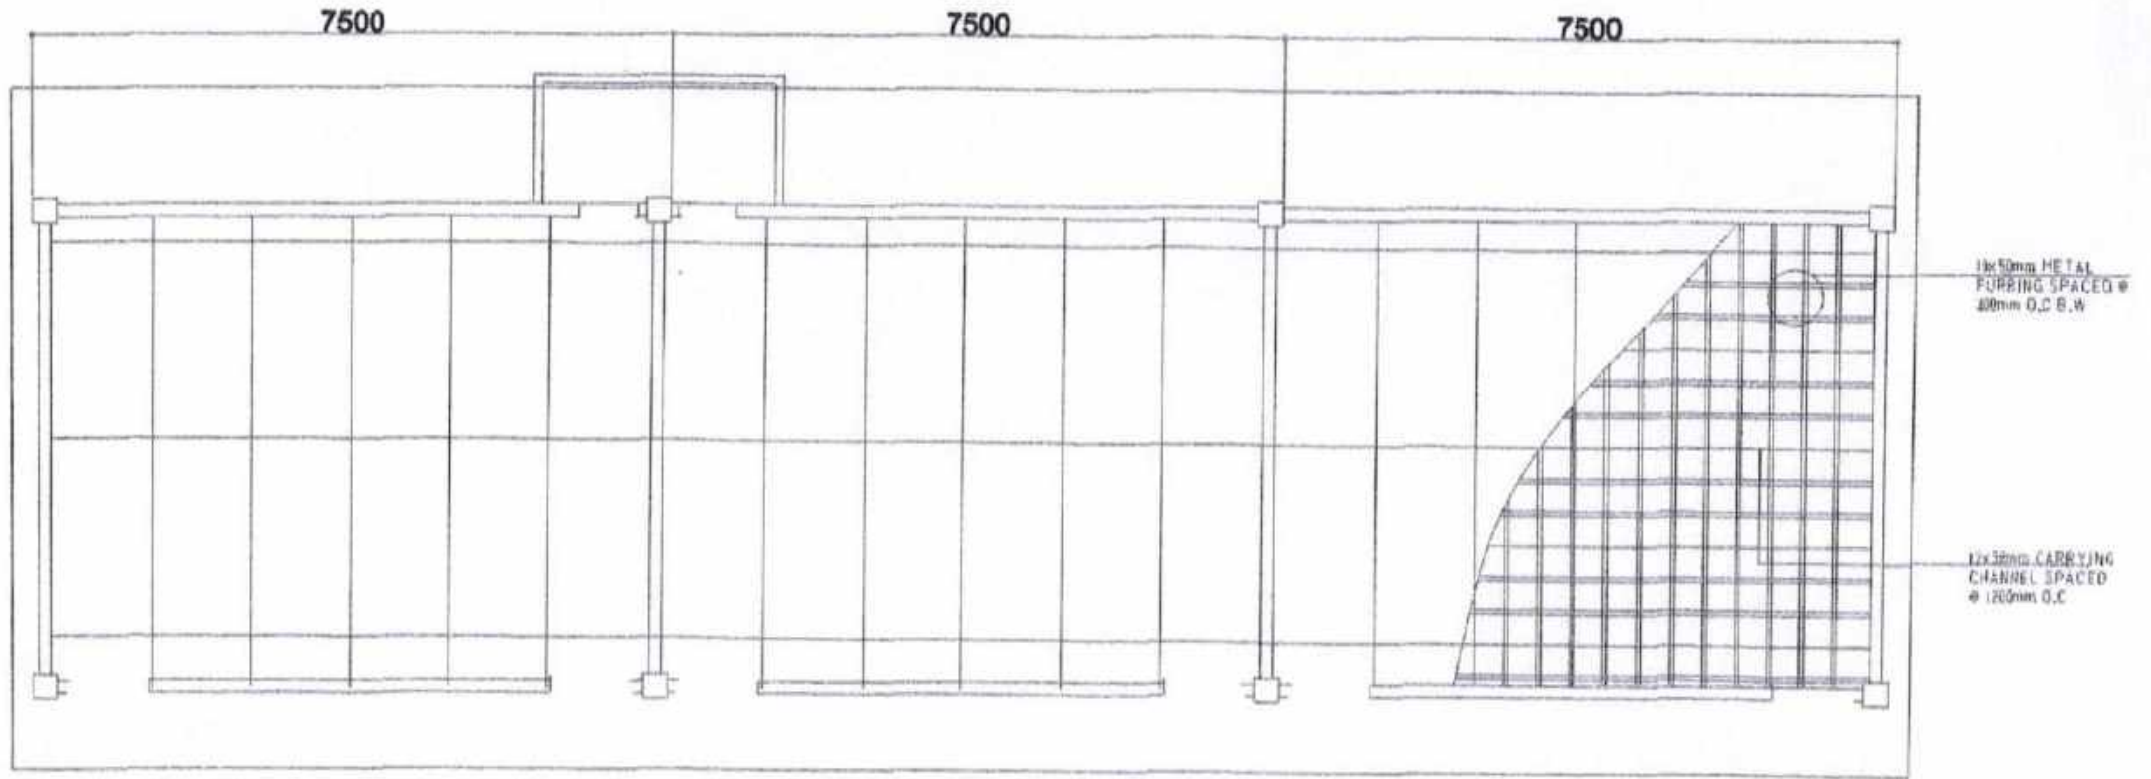

CEILING PLAN  
SCALE      UNITS



SORSOGON CITY  
CITY ENGINEER'S  
OFFICE


PROJECT TITLE:  
REPAIR/IMPROV. OF MULTI-PURPOSE HALL  
(MARCOS TYPE 1 BLDG.), ROSA T ARELLANO ES  
LOC: BRGY. MACABOG, WEST DISTRICT  
SORSOGON CITY

DRAWN BY:  
Ma Pamela Legaspi  
DRAFTING AIDE

RECOMMENDING APPROVAL:  
ROEL D. DOMER, C.E./RMP  
CITY ENGINEER

APPROVED BY:  
MA. ESTER E. HAMOR  
CITY MAYOR

PLEASE SIGN

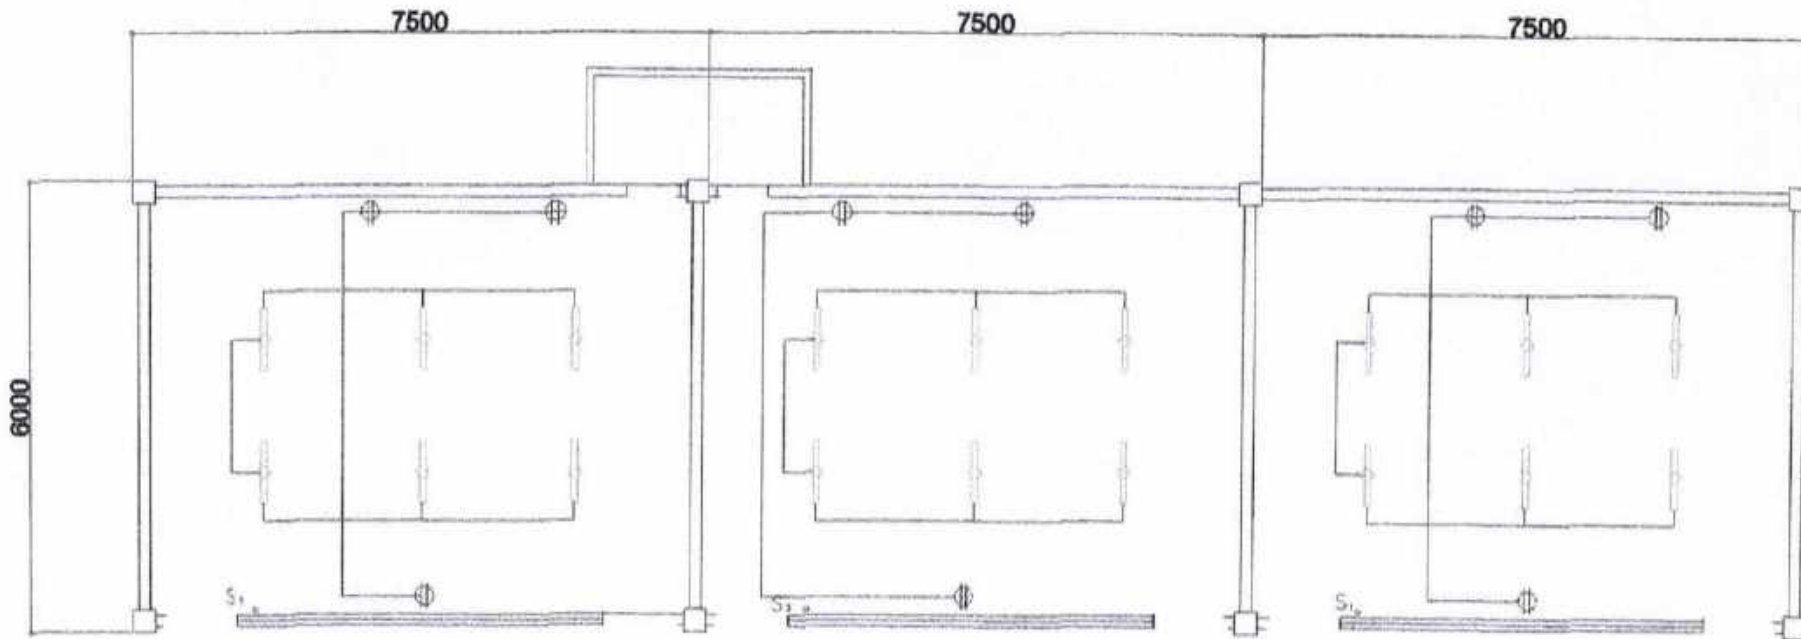

ELECTRICAL PLAN

SCHEDULE OF LOADS

CIRCUIT NO.	DESCRIPTION	NO. OF LOADS	VOLTS	WATTS	AMP	SIZE OF WIRE	SIZE OF CONDUIT
1	LIGHTING OUTLET	6	230	600	2.60	2-2.0mm <sup>2</sup> THW	15mm $\varnothing$
2	LIGHTING OUTLET	6	230	600	2.60	2-2.0mm <sup>2</sup> THW	15mm $\varnothing$
3	LIGHTING OUTLET	6	230	600	2.60	2-2.0mm <sup>2</sup> THW	15mm $\varnothing$
4	CONVENIENCE OUTLET	3	230	540	2.34	2-3.5mm <sup>2</sup> THW	20mm $\varnothing$
5	CONVENIENCE OUTLET	3	230	540	2.34	2-3.5mm <sup>2</sup> THW	20mm $\varnothing$
6	CONVENIENCE OUTLET	3	230	540	2.34	2-3.5mm <sup>2</sup> THW	20mm $\varnothing$
TOTAL					14.82		

ELECTRICAL NOTES

ALL ELECTRICAL WORKS SHALL BE DONE IN ACCORDANCE WITH THE LATEST RULES AND REGULATIONS OF THE PHIL. ELECTRICAL CODE AS WELL AS THE LOCAL AUTHORITY CONCERNED AND THE LOCAL POWER COMPANY.

ALL ELECTRICAL MATERIALS TO BE USED SHALL BE NEED & APPROVED TYPE FOR LOCATION & PURPOSE

MOUNTING HEIGHTS SHALL BE AS FOLLOWS:

- a. LIGHT CONTROL SWITCH- 1.36M ABOVE FIN. FLR. LINE AT CENTER
- b. CONVENIENCE OUTLET-ABOVE 1.0M ABOVE FIN. FLR. LINE AT CENTER
- c. PANEL BOARD- 2.0 M ABOVE FIN. FLR. LINE

ALL ELECTRICAL WORKS SHALL BE UNDER THE DIRECT & IMMEDIATE SUPERVISION OF A DULY LICENSED ELECTRICAL ENGINEER OR REGISTERED MASTER ELECTRICIAN



SORSOGON CITY  
CITY ENGINEER'S  
OFFICE

PROJECT TITLE:  
REPAIR/IMPROV. OF MULTI-PURPOSE HALL  
(MARCOS TYPE 1 BLDG.), ROSA T ARELLANO ES  
LOC: BRGY. MACABOG, WEST DISTRICT  
SORSOGON CITY

DRAWN BY:

No Pamela Legaspi  
DRAFTING AIDE


RECOMMENDING APPROVAL :

ROEL D. DOMER, C.E./RMP  
CITY ENGINEER


APPROVED BY:

MA. ESTER E. HAMOR  
CITY MAYOR




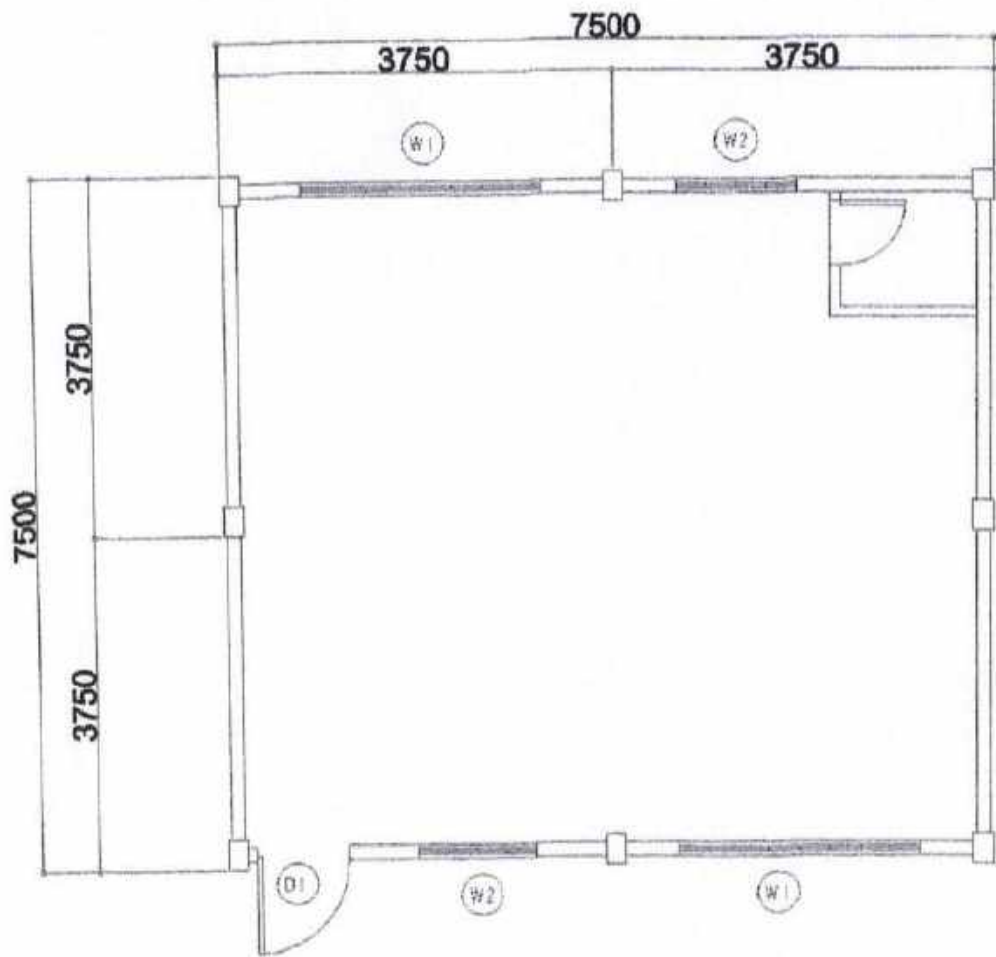

EXISTING FLOOR PLAN  
SCALE: 1/8"=1'-0"

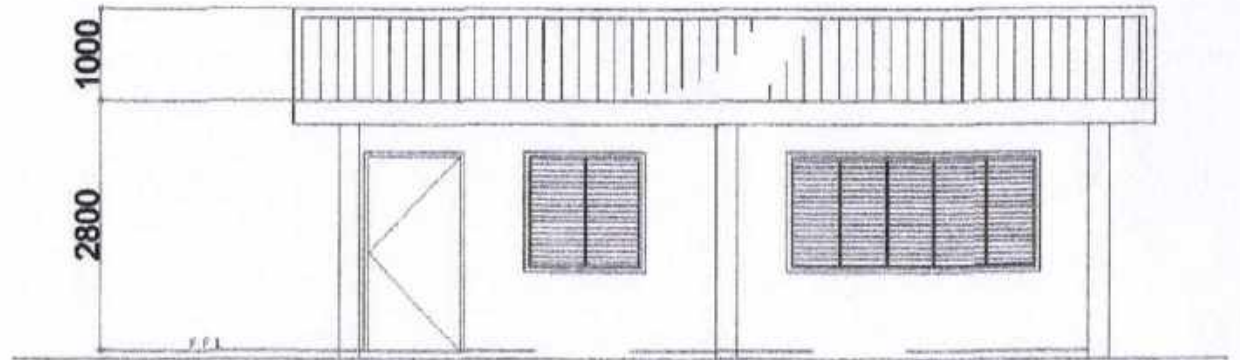

FRONT ELEVATION  
SCALE: 1/8"=1'-0"

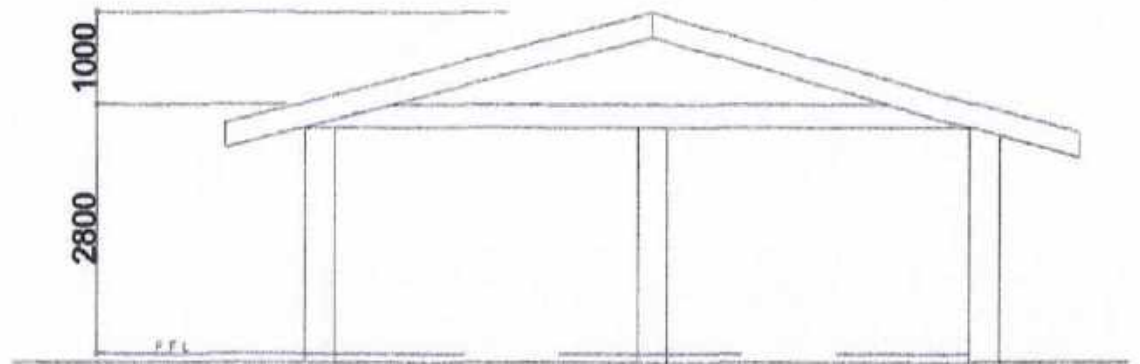

RIGHT SIDE ELEV.  
SCALE: 1/8"=1'-0"



SORSOGON CITY  
CITY ENGINEER'S  
OFFICE


PROJECT TITLE:  
REPAIR/IMPROV. OF MULTI-PURPOSE HALL (LGU  
FUNDED BLDG.), ROSA T ARELLANO ES  
LOC: BRGY. MACABOG, WEST DISTRICT  
SORSOGON CITY

DRAWN BY:  
Ma Pamela Legaspi  
DRAFTING AIDE


RECOMMENDING APPROVAL:  
ROEL D. DOMER, C.E./RMP  
CIC CITY ENGINEER

APPROVED BY:  
MA. ESTER E. HAMOR  
CITY MAYOR



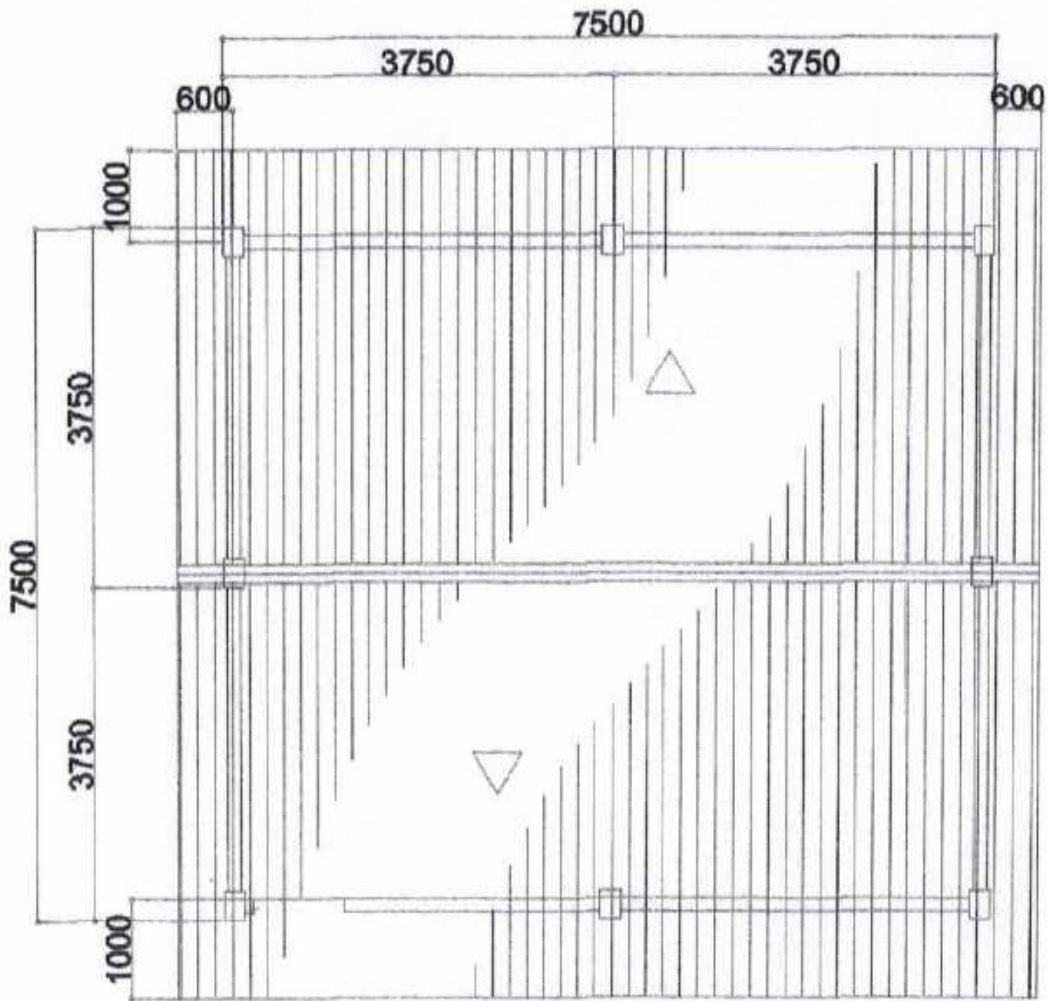

ROOF PLAN  
SCALE: 1/8"=1'-0"

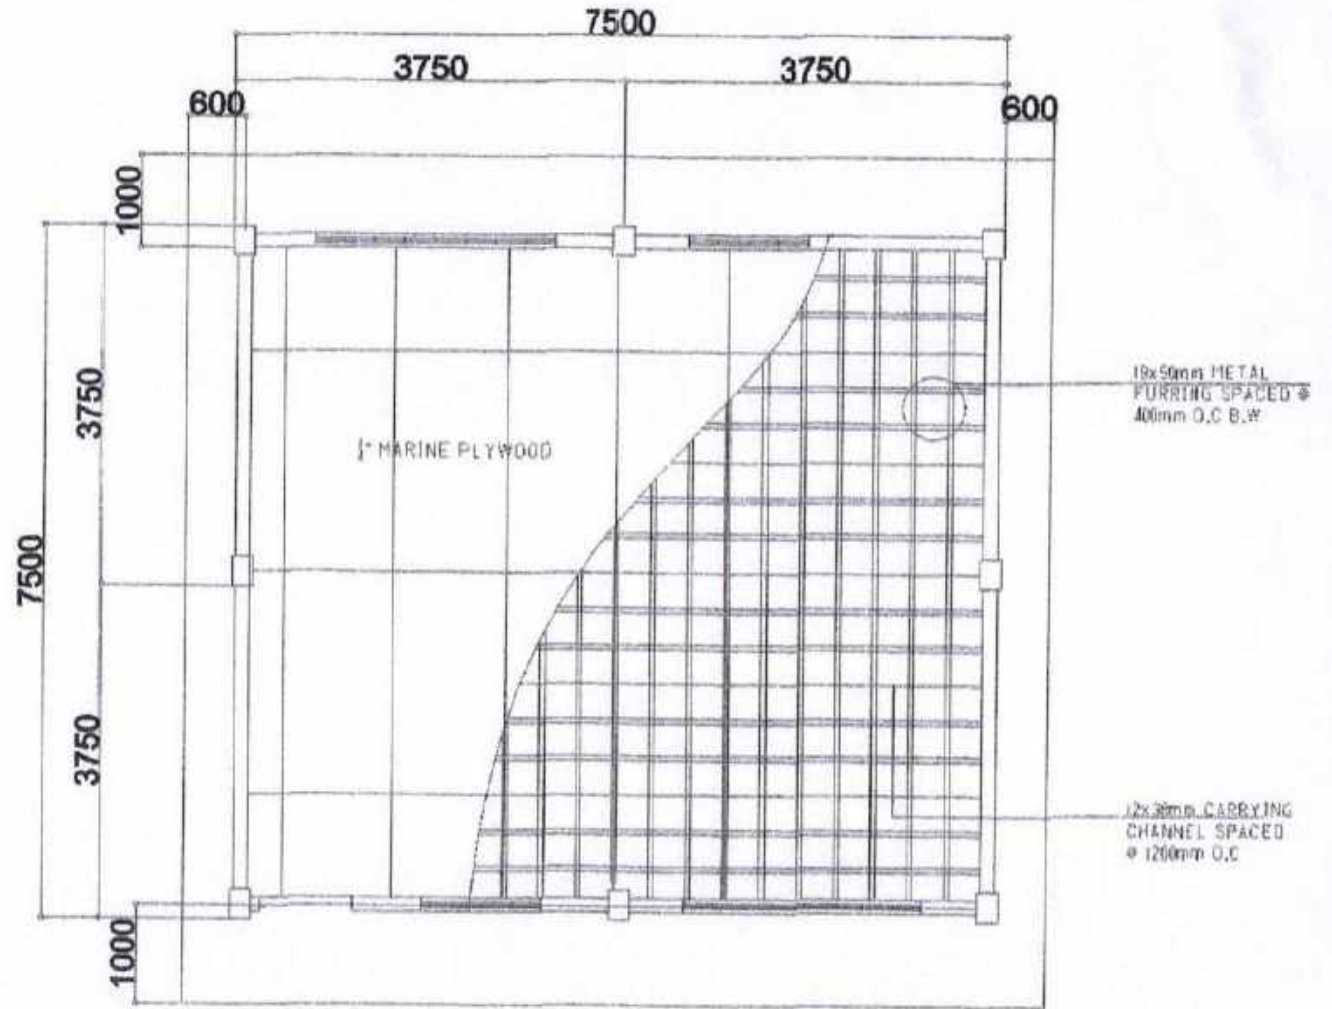

CEILING PLAN  
SCALE: 1/8"=1'-0"






SORSOGON CITY  
CITY ENGINEER'S  
OFFICE

PROJECT TITLE:  
REPAIR/IMPROV. OF MULTI-PURPOSE HALL (LGU  
FUNDED BLDG.), ROSA T ARELLANO ES  
LOC: BRGY. MACABOG, WEST DISTRICT  
SORSOGON CITY

DRAWN BY:  
MaPamela Legaspi  
DRAFTING AIDE

RECOMMENDING APPROVAL:  
ROEL D. DOMER, C.E./RMP  
CITY ENGINEER

APPROVED BY:  
MA. ESTER E. HAMOR  
CITY MAYOR

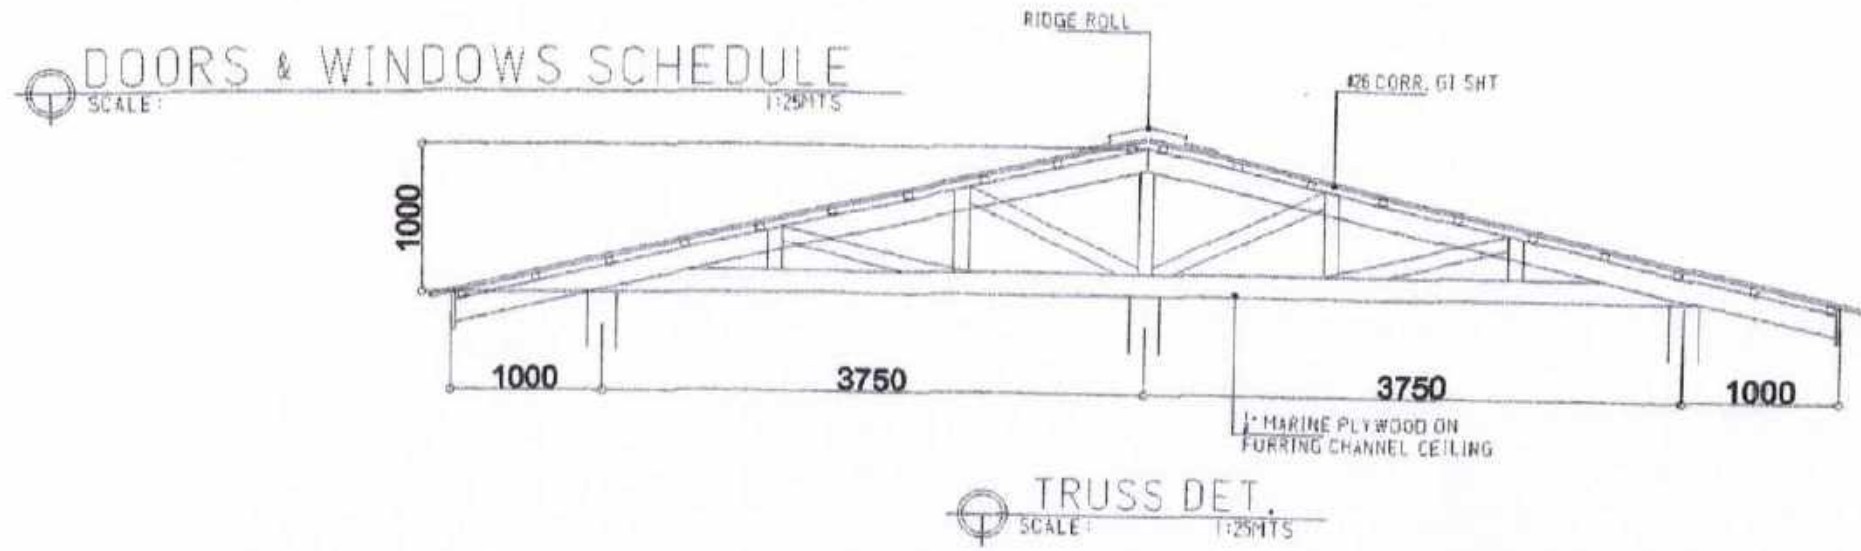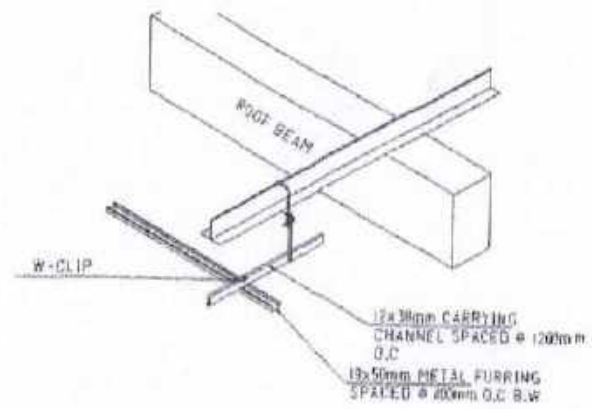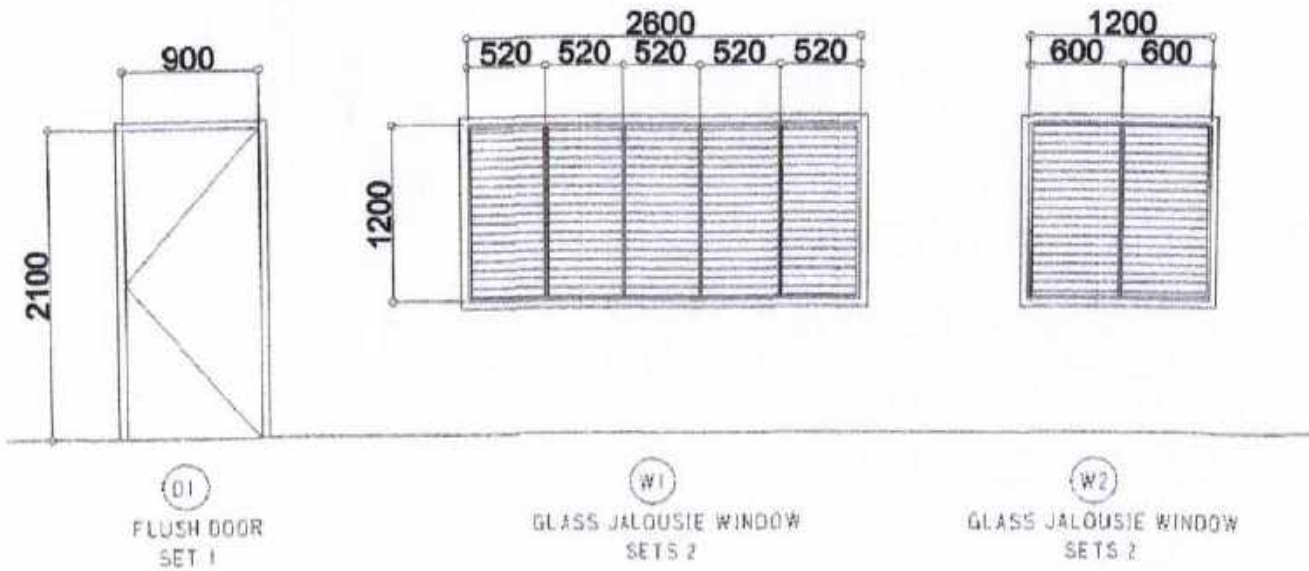

SORSOGON CITY  
CITY ENGINEER'S  
OFFICE

PROJECT TITLE:  
REPAIR/IMPROV. OF MULTI-PURPOSE HALL (LGU FUNDED BLDG.), ROSA T ARELLANO ES

LOC: BRGY. MACABOG, WEST DISTRICT  
SORSOGON CITY


DRAWN BY:  
Ma Pamela Legaspi  
DRAFTING AIDE

RECOMMENDING APPROVAL:  
ROEL D. DOMER, C.E./RMP  
CITY ENGINEER

APPROVED BY:  
MA. ESTER E. HAMOR  
CITY MAYOR

PLEASE SIGN



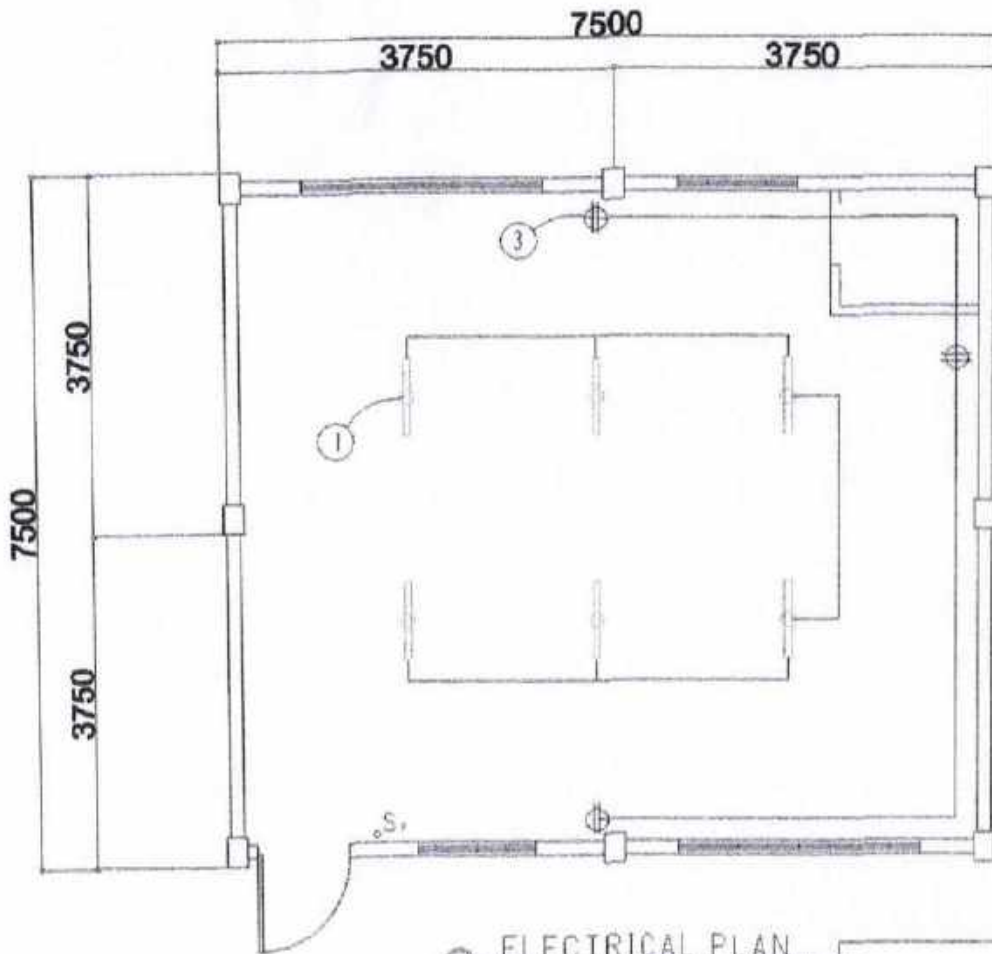

**ELECTRICAL NOTES**

ALL ELECTRICAL WORKS SHALL BE DONE IN ACCORDANCE WITH THE LATEST RULES AND REGULATIONS OF THE PHIL. ELECTRICAL CODE AS WELL AS THE LOCAL AUTHORITY CONCERNED AND THE LOCAL POWER COMPANY.

ALL ELECTRICAL MATERIALS TO BE USED SHALL BE NEED & APPROVED TYPE FOR LOCATION & PURPOSE

MOUNTING HEIGHTS SHALL BE AS FOLLOWS:

- a. LIGHT CONTROL SWITCH- 1.35M ABOVE FIN. FLR. LINE AT CENTER
- b. CONVENIENCE OUTLET-ABOVE 1.0M ABOVE FIN. FLR. LINE AT CENTER
- c. PANEL BOARD- 2.0 M ABOVE FIN. FLR. LINE

ALL ELECTRICAL WORKS SHALL BE UNDER THE DIRECT & IMMEDIATE SUPERVISION OF A DULY LICENSED ELECTRICAL ENGINEER OR REGISTERED MASTER ELECTRICIAN

**ELECTRICAL PLAN**  
SCALE: 1/2500

**SCHEDULE OF LOADS**

CIRCUIT NO.	DESCRIPTION	NO. OF LOADS	VOLTS	WATTS	AMP	SIZE OF WIRE	SIZE OF CONDUIT
1	LIGHTING OUTLET	6	230	600	2.60	2-2.0mm <sup>2</sup> THW	15mm $\varnothing$
2	CONVENIENCE OUTLET	3	230	540	2.34	2-3.5mm <sup>2</sup> THW	20mm $\varnothing$
	<b>TOTAL</b>				<b>4.94</b>		




SORSOGON CITY  
**CITY ENGINEER'S OFFICE**

PROJECT TITLE:  
REPAIR/IMPROV. OF MULTI-PURPOSE HALL (LGU FUNDED BLDG.), ROSA T ARELLANO ES  
LOC: BRGY. MACABOG, WEST DISTRICT  
SORSOGON CITY

DRAWN BY:  
MaPaola Legaspi  
DRAFTING AIDE


RECOMMENDING APPROVAL:  
  
ROEL D. BONER, C.E./RMP  
CITY ENGINEER

APPROVED BY:  
  
MA. ESTER E. HAMOR  
CITY MAYOR

PLEASE SIGN

# ROSA T. ARELLANO ELEMENTARY SCHOOL


## MARCOS TYPE BUILDING

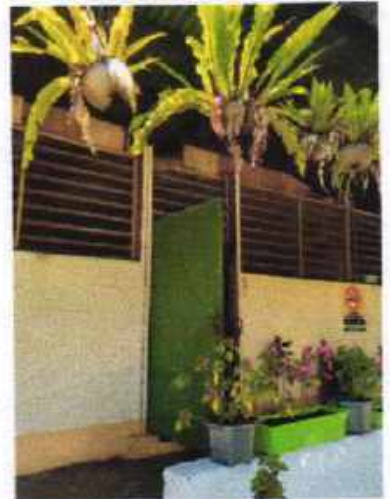

**ROSA T. ARELLANO ELEMENTARY SCHOOL**

**LGU FUNDED SCHOOL BUILDING**



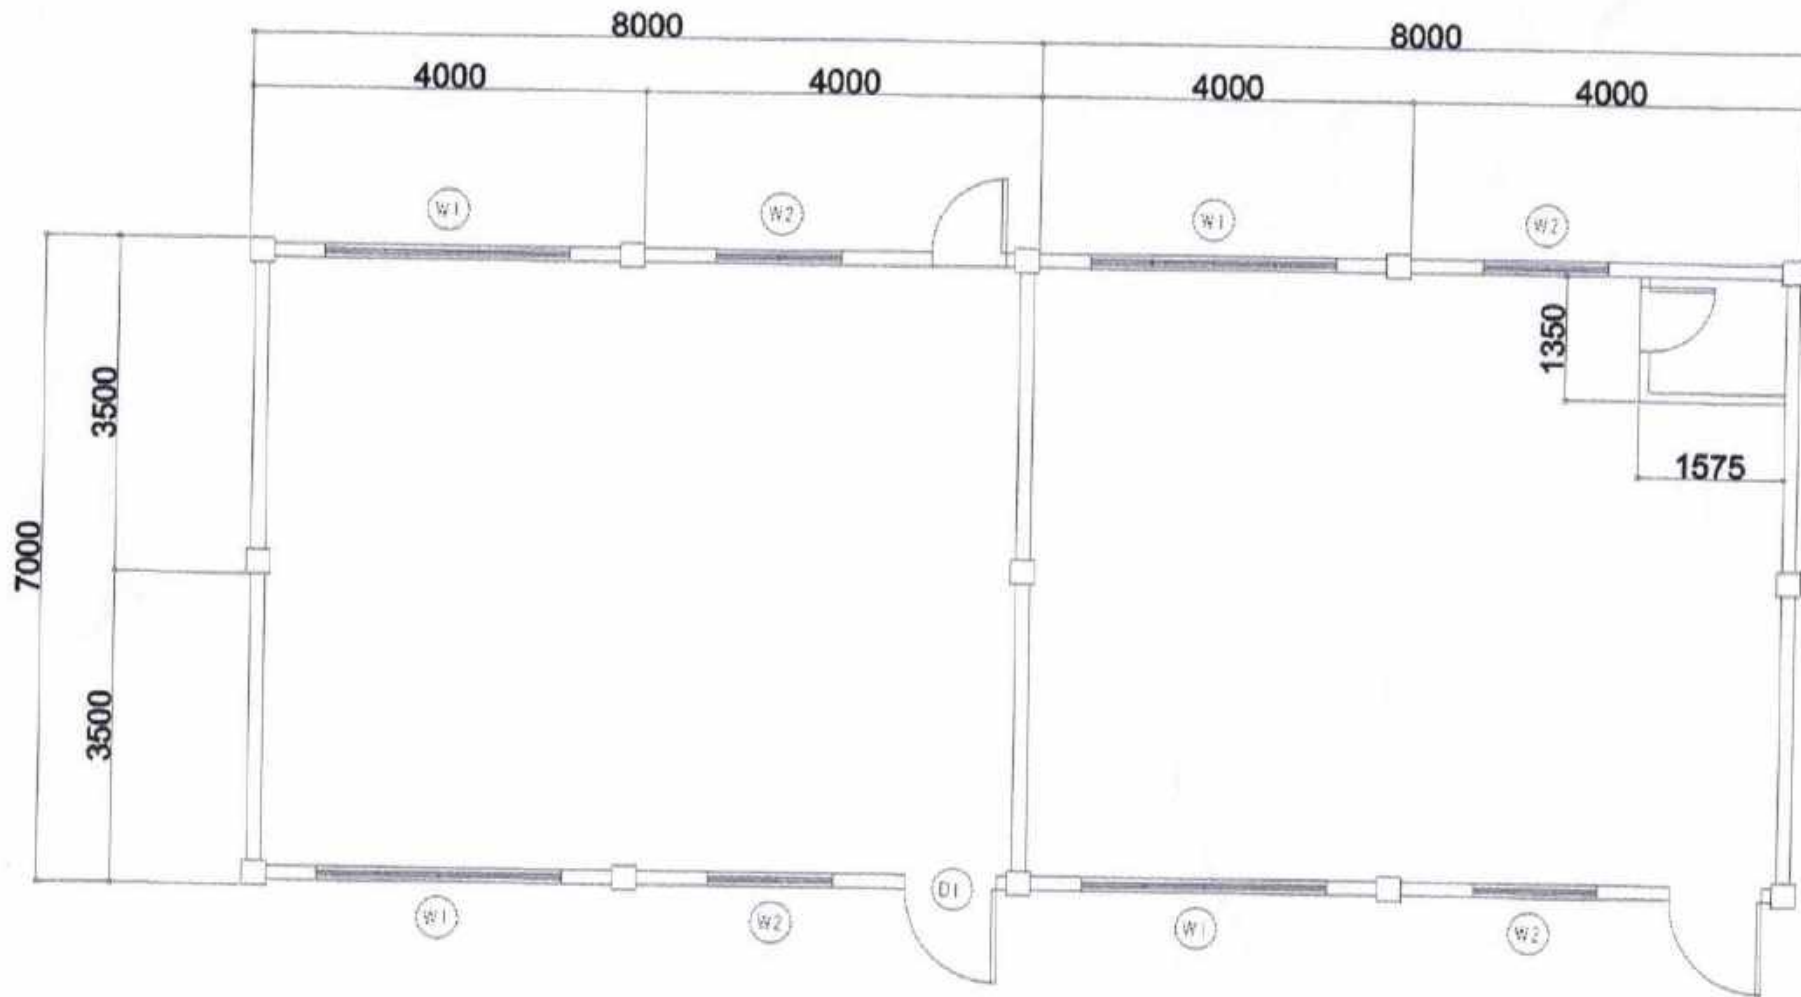

EXISTING FLOOR PLAN  
SCALE: 1:200



CITY ENGINEER'S  
O F F I C E

PROJECT TITLE:

REPAIR/IMPROV. OF MULTI-PURPOSE HALL  
(BAGONG LIPUNAN BLDG.), ROSA T ARELLANO ES

LOC: BRGY. MACABOG, WEST DISTRICT  
SORSOGON CITY

DRAWN BY:


Ma Pamela Legaspi  
DRAFTING AIDE

RECOMMENDING APPROVAL:


ROEL D. BOMER, C.E./RMP  
CITY ENGINEER

APPROVED BY:


MA. ESTER E. HAMOR  
CITY MAYOR

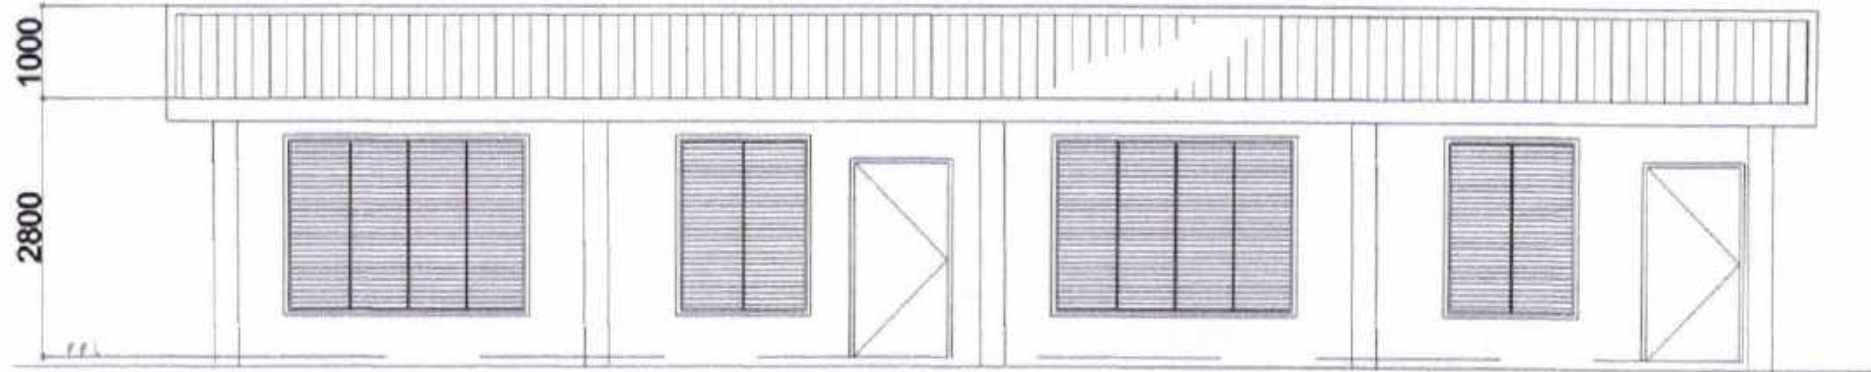

FRONT ELEVATION  
SCALE: 1/8"=1'-0"

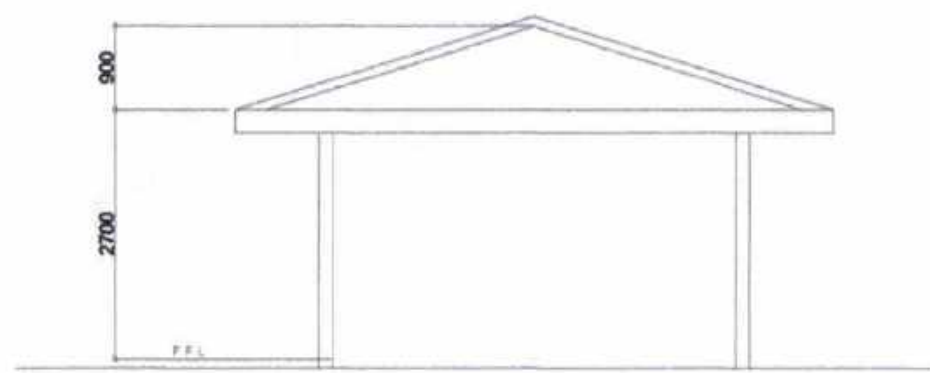

RIGHT SIDE ELEV.  
SCALE: 1/8"=1'-0"

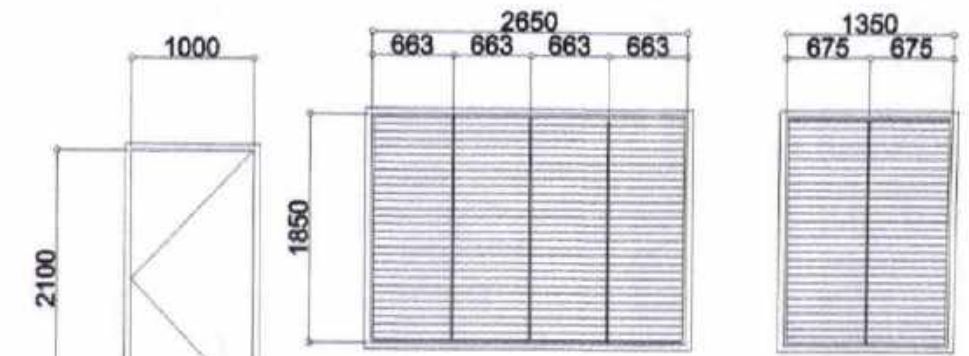

D1 PANEL DOOR SETS 2  
W1 GLASS JALOUSIE WINDOW SETS 4  
W2 GLASS JALOUSIE WINDOW SETS 4


DOORS & WINDOWS SCHEDULE  
SCALE: 1/8"=1'-0"



CITY ENGINEER'S  
OFFICE

PROJECT TITLE: REPAIR/IMPROV. OF MULTI-PURPOSE HALL (BAGONG LIPUNAN BLDG.), ROSA T ARELLANO ES	DRAWN BY: Ma Pamela Legaspi DRAFTING AIDE	RECOMMENDING APPROVAL: ROEL D. DOMER, C.E./RMP CITY ENGINEER	APPROVED BY: MA. ESTER E. HAMOR CITY MAYOR
LOC: BRGY. MACABOG, WEST DISTRICT SORSOGON CITY			

PLEASE SIGN

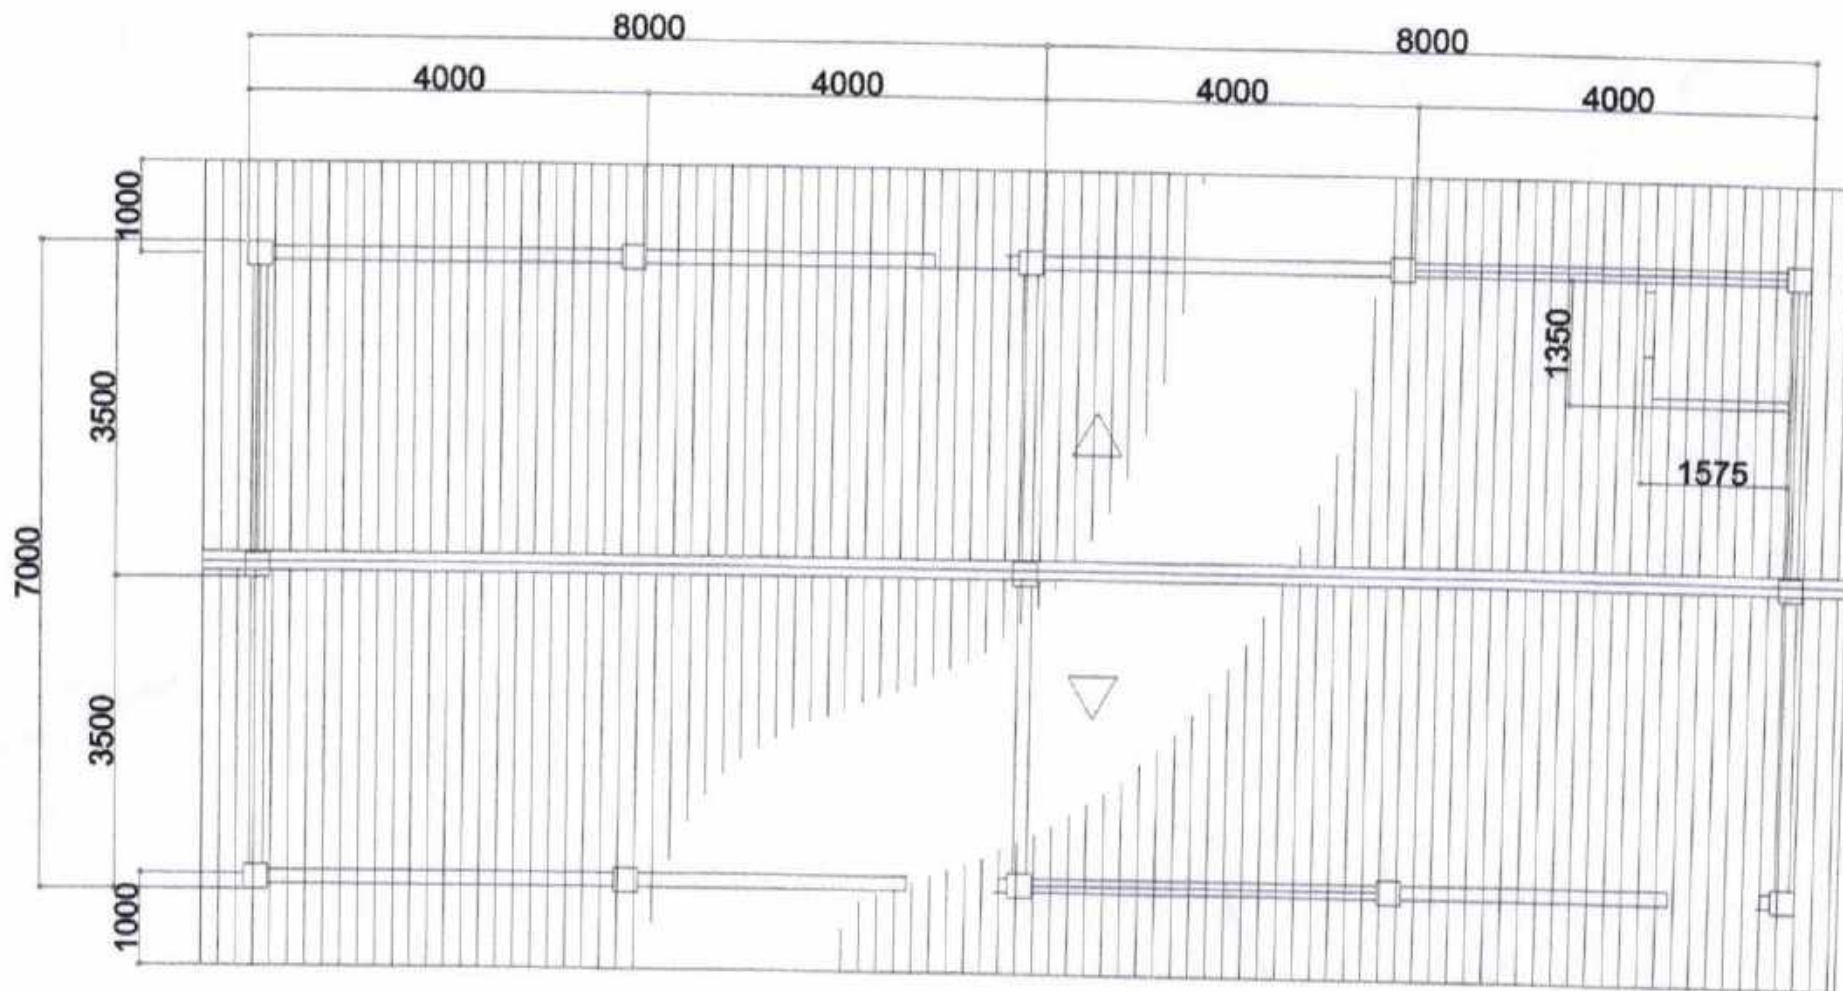


ROOF PLAN  
SCALE: 1:200




CITY ENGINEER'S  
OFFICE


PROJECT TITLE: REPAIR/IMPROV. OF MULTI-PURPOSE HALL (BAGONG LIPUNAN BLDG.), ROSA T ARELLANO ES	DRAWN BY: MaPamela Legaspi DRAFTING AIDE	RECOMMENDING APPROVAL :  ROEL D. DOMERT, C.E./RMP CITY ENGINEER	APPROVED BY:  MA. ESTER E. HAMOR CITY MAYOR
LOC: BRGY. MACABOG, WEST DISTRICT SORSOGON CITY			

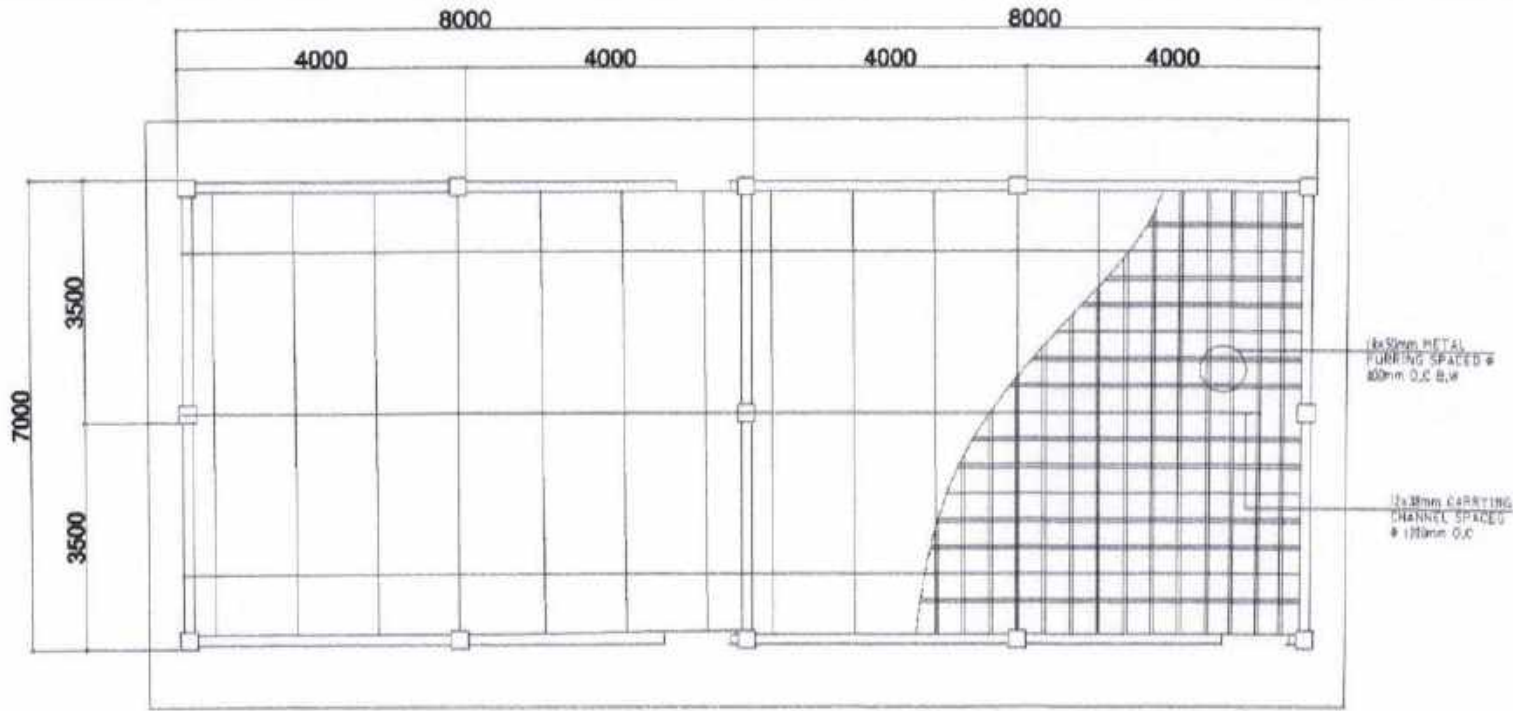

CEILING PLAN  
SCALE: 1:25 H.T.S.

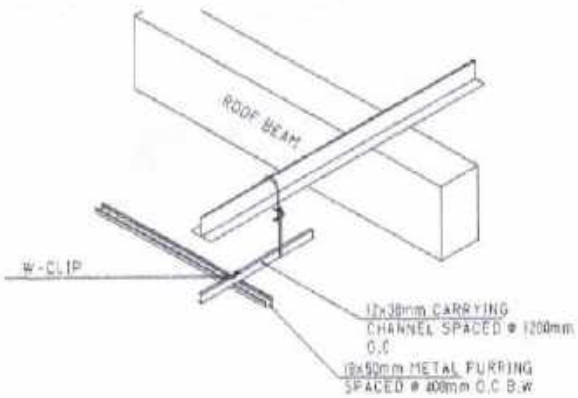

ISOMETRIC DRAWING

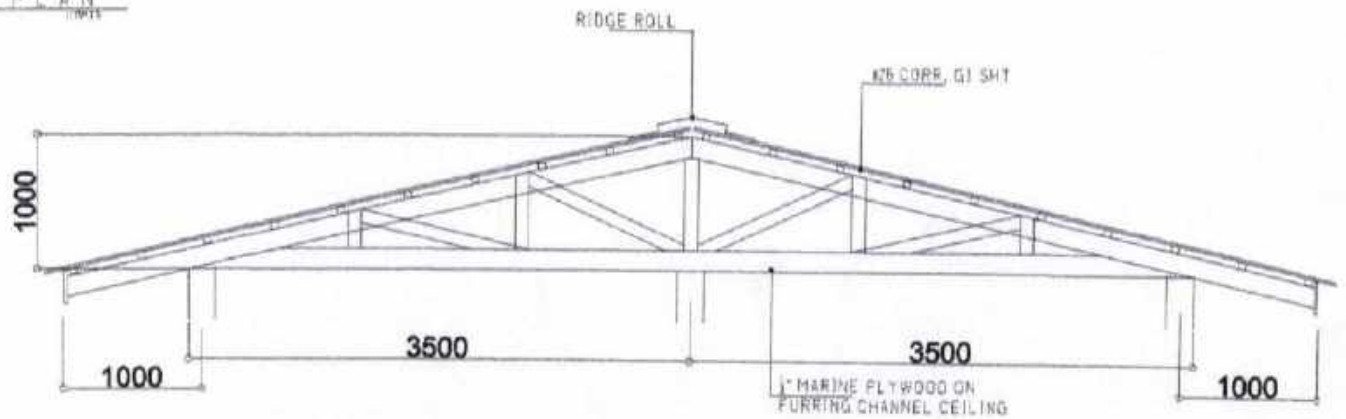

TRUSS DET.  
SCALE: 1:25 H.T.S.




**CITY ENGINEER'S  
OFFICE**

PROJECT TITLE:  
REPAIR/IMPROV. OF MULTI-PURPOSE HALL  
(BAGONG LIPUNAN BLDG.), ROSA T ARELLANO ES  
LOC: BRGY. MACABOG, WEST DISTRICT  
SORSOGON CITY

DRAWN BY:  
Ma Pamela Legaspi  
DRAFTING AIDE

RECOMMENDING APPROVAL:  
ROEL B. DOMER, C.E./RMP  
CITY ENGINEER

APPROVED BY:  
MA. ESTER E. HAMOR  
CITY MAYOR

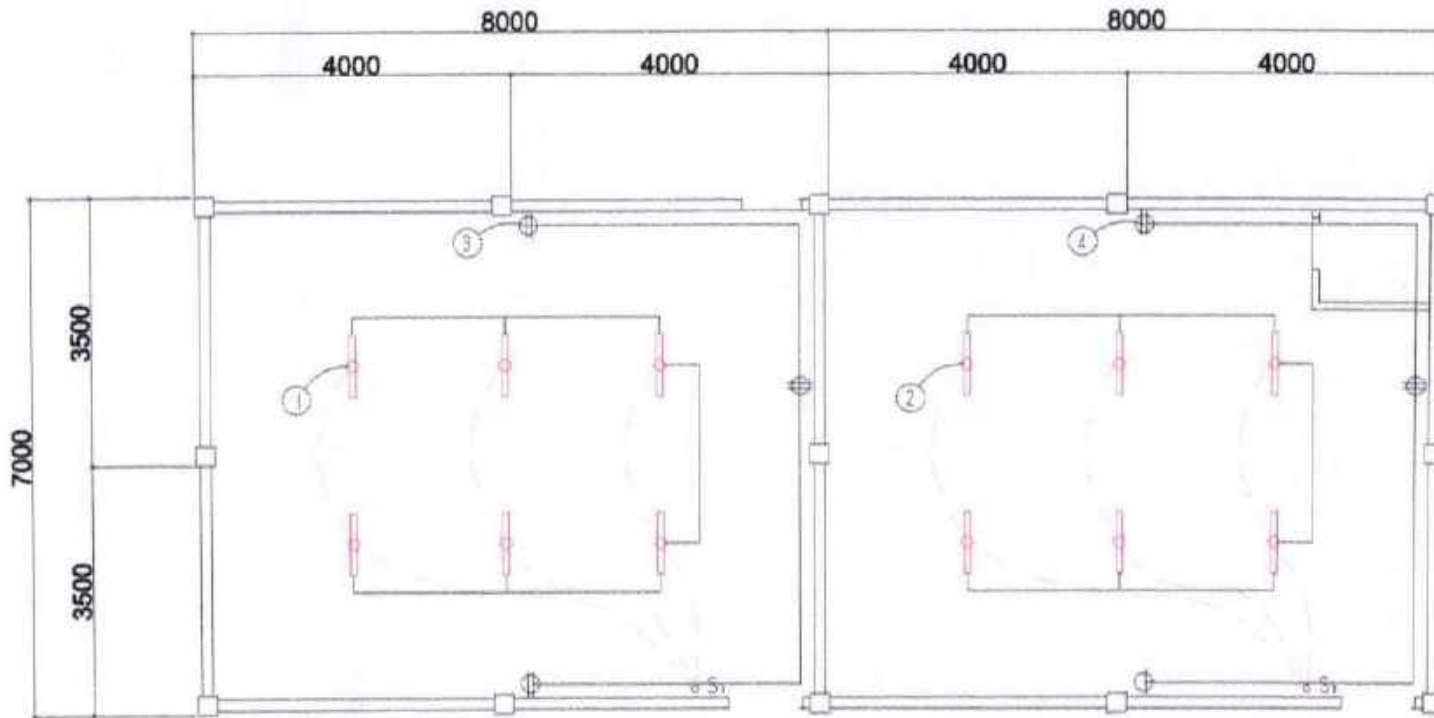

ELECTRICAL PLAN

**SCHEDULE OF LOADS**

CIRCUIT NO.	DESCRIPTION	NO. OF LOADS	VOLTS	WATTS	AMP	SIZE OF WIRE	SIZE OF CONDUIT
1	LIGHTING OUTLET	6	230	600	2.60	2-2.0mm <sup>2</sup> THW	15mm $\varnothing$
2	LIGHTING OUTLET	6	230	600	2.60	2-2.0mm <sup>2</sup> THW	15mm $\varnothing$
3	CONVENIENCE OUTLET	3	230	540	2.34	2-3.5mm <sup>2</sup> THW	20mm $\varnothing$
4	CONVENIENCE OUTLET	3	230	540	2.34	2-3.5mm <sup>2</sup> THW	20mm $\varnothing$
	<b>TOTAL</b>				<b>9.88</b>		

**ELECTRICAL NOTES**

ALL ELECTRICAL WORKS SHALL BE DONE IN ACCORDANCE WITH THE LATEST RULES AND REGULATIONS OF THE PHIL. ELECTRICAL CODE AS WELL AS THE LOCAL AUTHORITY CONCERNED AND THE LOCAL POWER COMPANY.

ALL ELECTRICAL MATERIALS TO BE USED SHALL BE NEED & APPROVED TYPE FOR LOCATION & PURPOSE

MOUNTING HEIGHTS SHALL BE AS FOLLOWS:

- a. LIGHT CONTROL SWITCH- 1.35M ABOVE FIN. FLR. LINE AT CENTER
- b. CONVENIENCE OUTLET- ABOVE 1.0M ABOVE FIN. FLR. LINE AT CENTER
- c. PANEL BOARD- 2.0 M ABOVE FIN. FLR. LINE

ALL ELECTRICAL WORKS SHALL BE UNDER THE DIRECT & IMMEDIATE SUPERVISION OF A DULY LICENSED ELECTRICAL ENGINEER OR REGISTERED MASTER ELECTRICIAN



**CITY ENGINEER'S  
OFFICE**

PROJECT TITLE:  
REPAIR/IMPROV. OF MULTI-PURPOSE HALL  
(BAGONG LIPUNAN BLDG.), ROSA T ARELLANO ES


LOC: BRGY. MACABOG, WEST DISTRICT  
SORSOGON CITY

DRAWN BY:  
Ma Pamela Legaspi  
DRAFTING AIDE

RECOMMENDING APPROVAL:  
ROEL B. DOMER, C.E./RMP  
CITY ENGINEER

APPROVED BY:  
MA. ESTER E. HAMOR  
CITY MAYOR



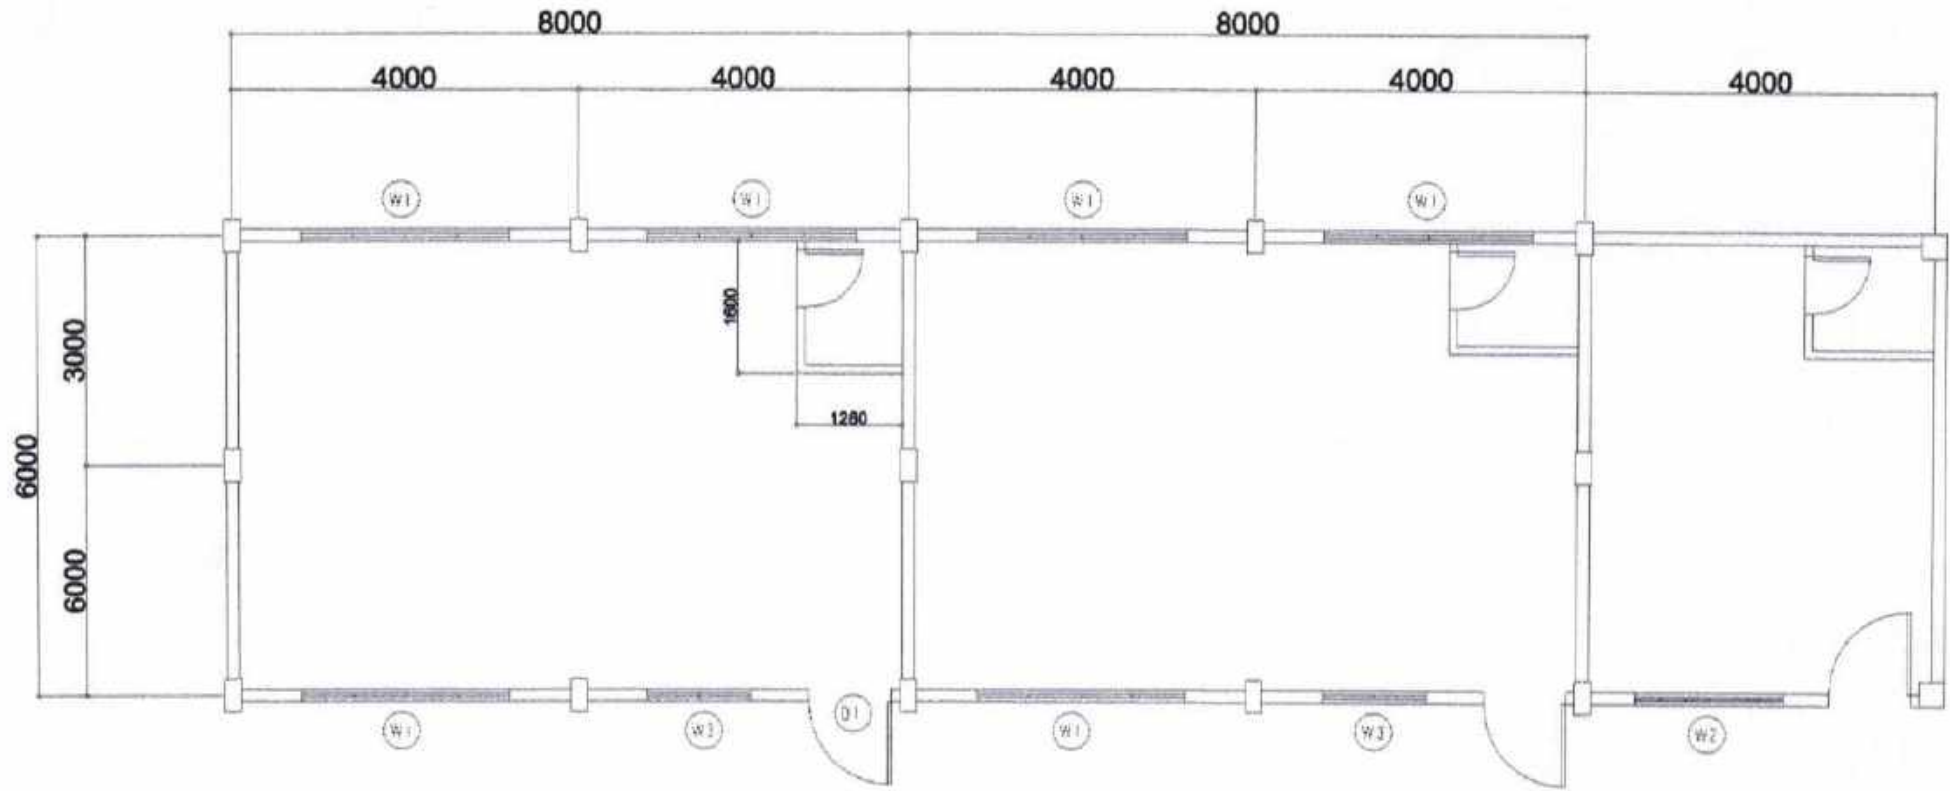

EXISTING FLOOR PLAN  
SCALE: 1/8"=1'-0"




**CITY ENGINEER'S  
OFFICE**

PROJECT TITLE:  
REPAIR/IMPROV. OF MULTI-PURPOSE HALL (MELDA  
TYPE 1 BLDG.), ROSA T ARELLANO ES  
LOC: BRGY. MACABOG, WEST DISTRICT  
SORSOGON CITY


DRAWN BY:  
Ma Pamela Legaspi  
DRAFTING AIDE

RECOMMENDING APPROVAL:  
ROEL D. DOMER, C.E./RMP  
CITY ENGINEER


APPROVED BY:  
MA. ESTER E. HAMCR  
CITY MAYOR

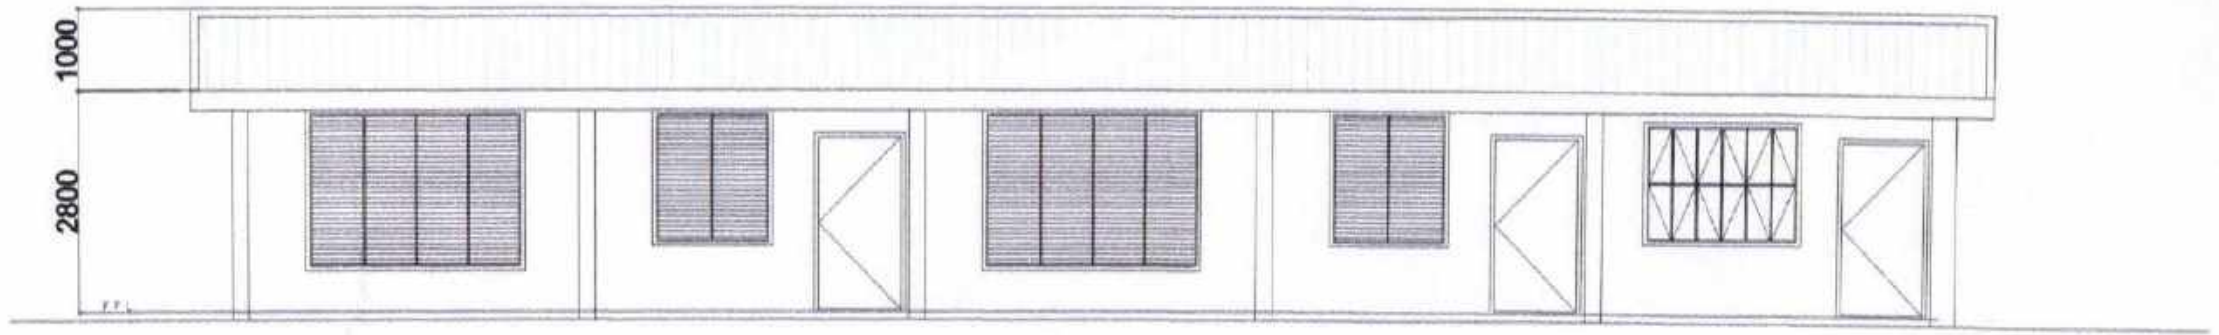

FRONT ELEVATION  
SCALE: 1/8"=1'-0"

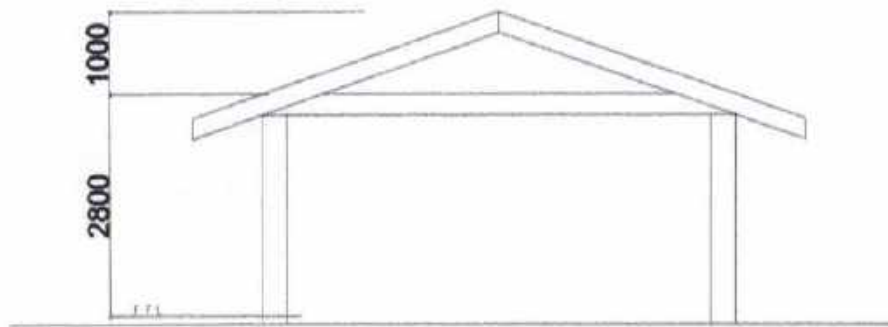

RIGHT SIDE ELEV.  
SCALE: 1/8"=1'-0"

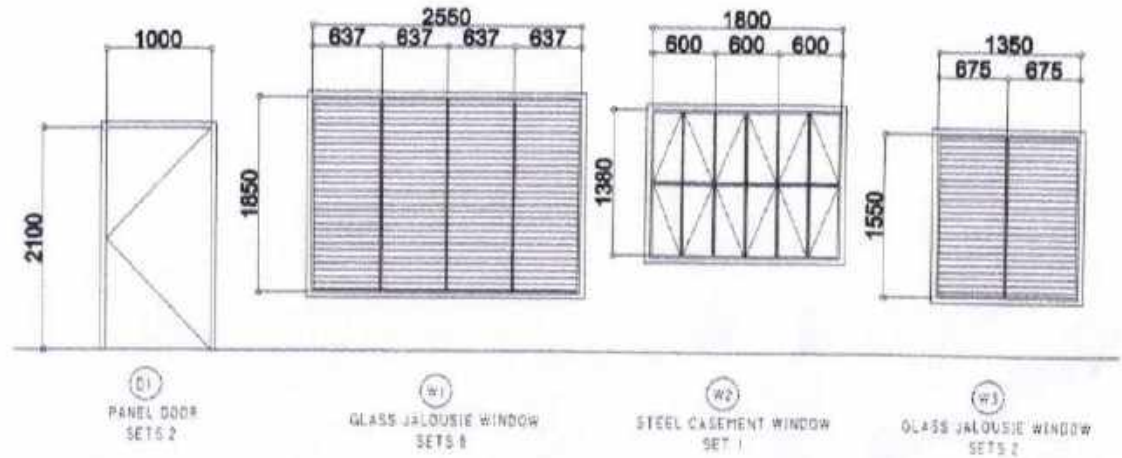


DOORS & WINDOWS SCHEDULE  
SCALE: 1/8"=1'-0"



CITY ENGINEER'S  
OFFICE

PROJECT TITLE: REPAIR/IMPROV. OF MULTI-PURPOSE HALL (IMELDA TYPE 1 BLDG ), ROSA T ARELLANO ES	DRAWN BY: MaPamelaLegaspi DRAFTING AIDE	RECOMMENDING APPROVAL: ROELDOMER, C.E./RMP CITY ENGINEER	APPROVED BY: MA. ESTER E. HAMOR CITY MAYOR
LOC: BRGY. MACABOG, WEST DISTRICT SORSOGON CITY			



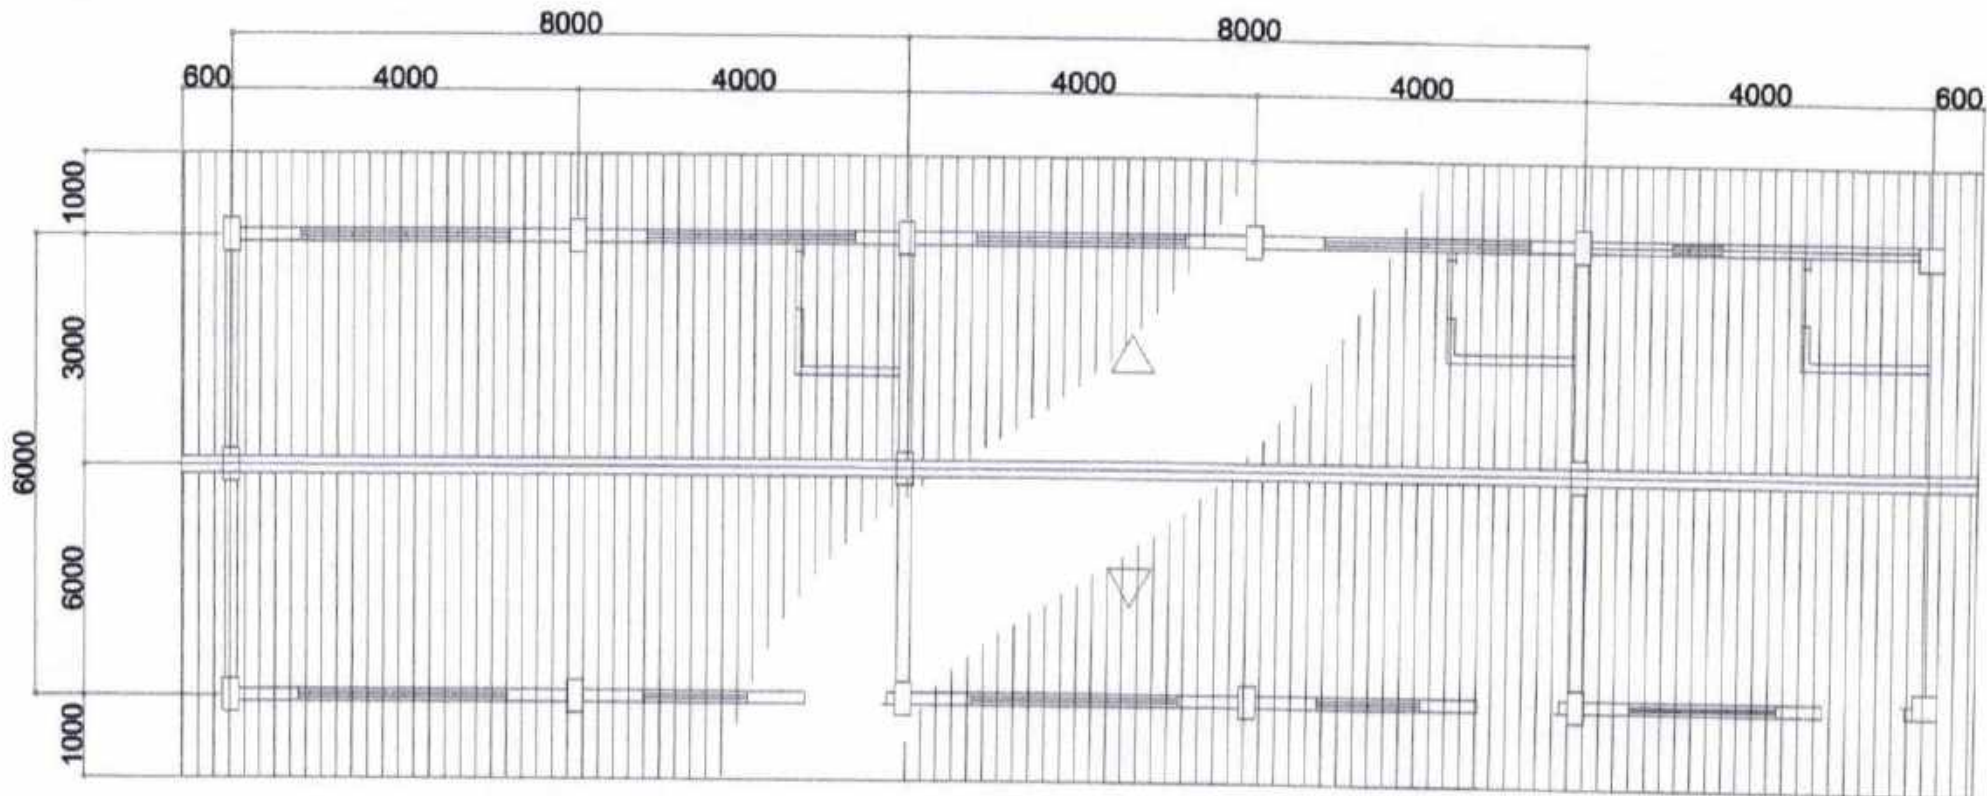


ROOF PLAN  
SCALE: 1/8" = 1'-0"



CITY ENGINEER'S  
OFFICE

PROJECT TITLE: REPAIR/IMPROV. OF MULTI-PURPOSE HALL (IMELDA TYPE 1 BLDG.), ROSA T ARELLANO ES	DRAWN BY: MaPamelaLegaspi DRAFTING AIDE	RECOMMENDING APPROVAL: ROEL D. COMET, C.E./RMP CITY ENGINEER	APPROVED BY: MA. ESTER E. HAMOR CITY MAYOR
LOC: BRGY. MACABOG, WEST DISTRICT SORSOGON CITY			

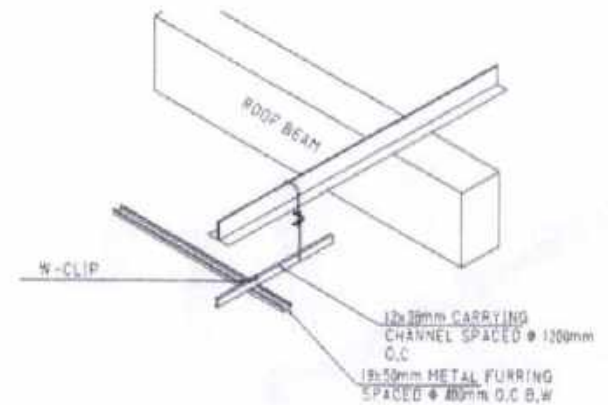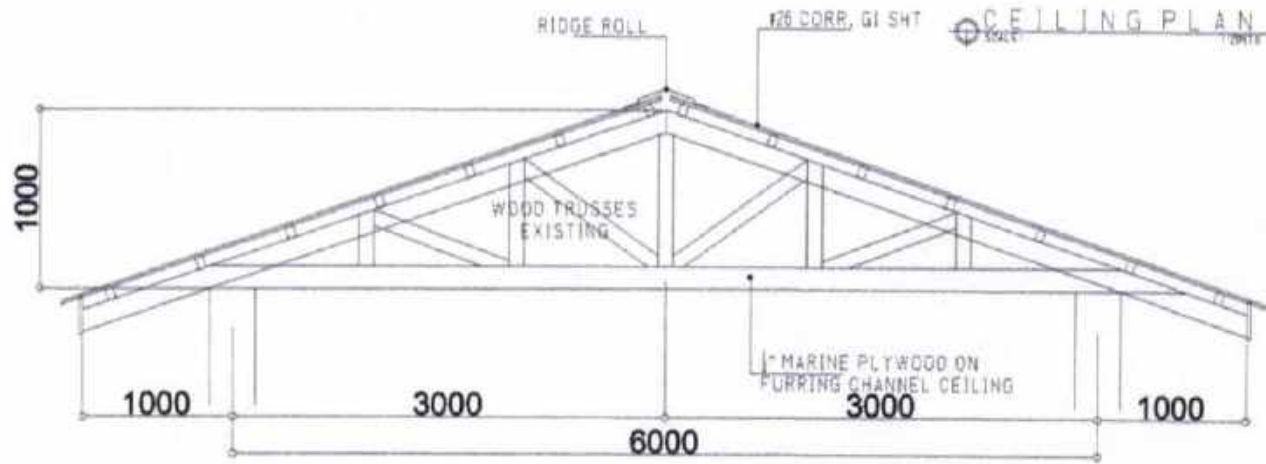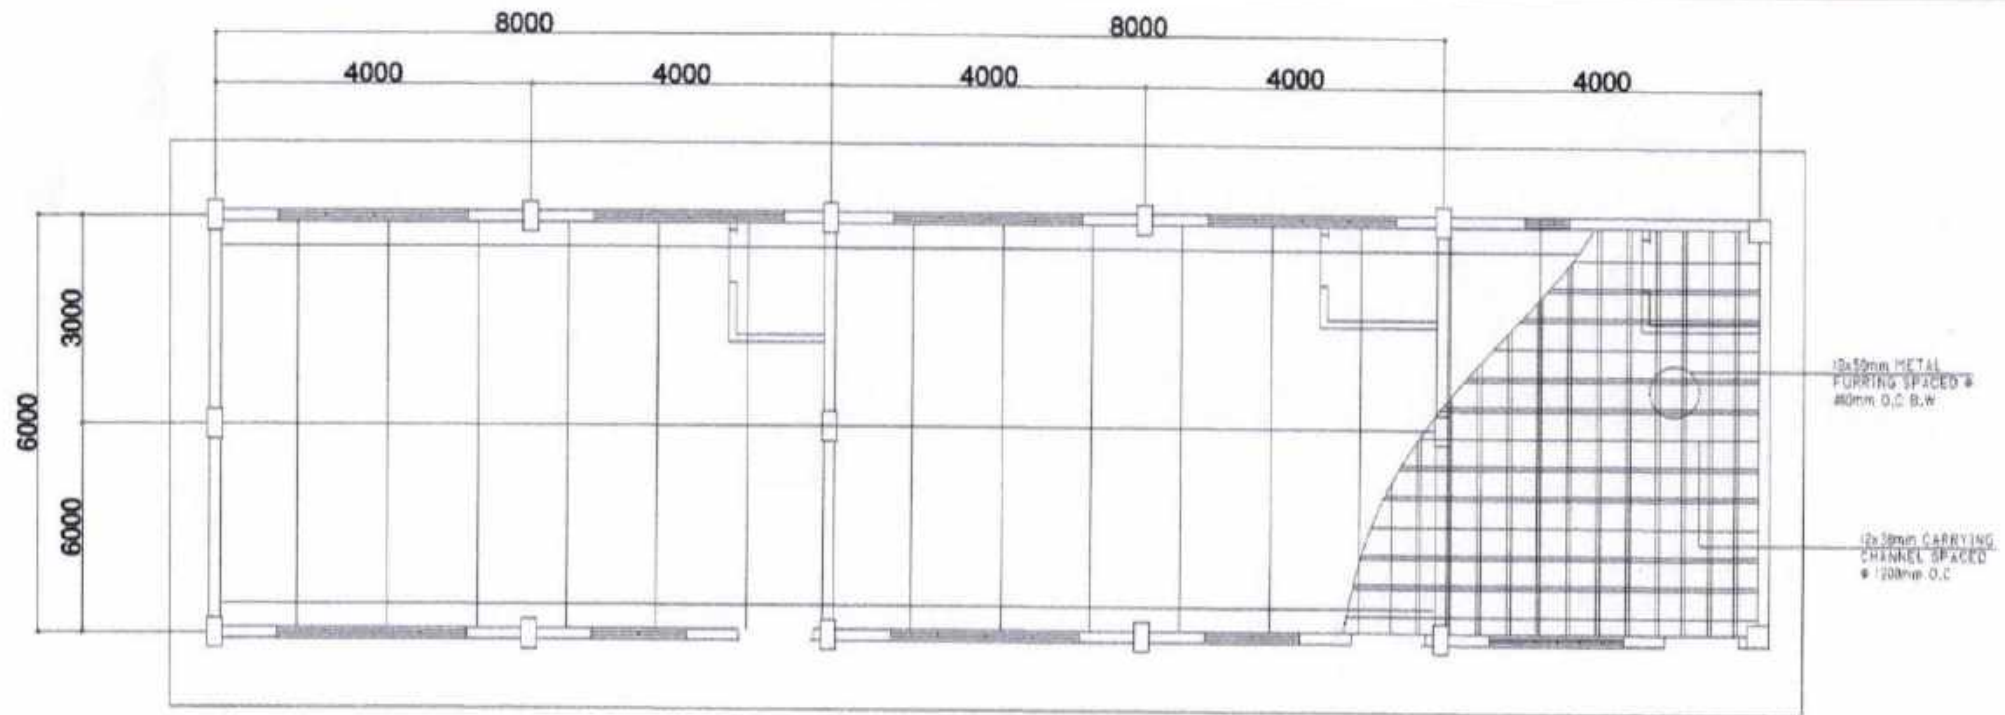

TRUSS DET.  
SCALE: 1:25PTS

ISOMETRIC DRAWING




CITY ENGINEER'S  
OFFICE

PROJECT TITLE  
REPAIR/IMPROV. OF MULTI-PURPOSE HALL (IMELDA  
TYPE 1 BLDG.), ROSA T ARELLANO ES  
LOC: BRGY. MACABOG, WEST DISTRICT  
SORSOGON CITY

DRAWN BY:  
Ma Pamela Legaspi  
DRAFTING AIDE

RECOMMENDING APPROVAL:  
ROEL B. DOMER, C.E./RMP  
CITY ENGINEER

APPROVED BY:  
MA. ESTER E. HAMOR  
CITY MAYOR

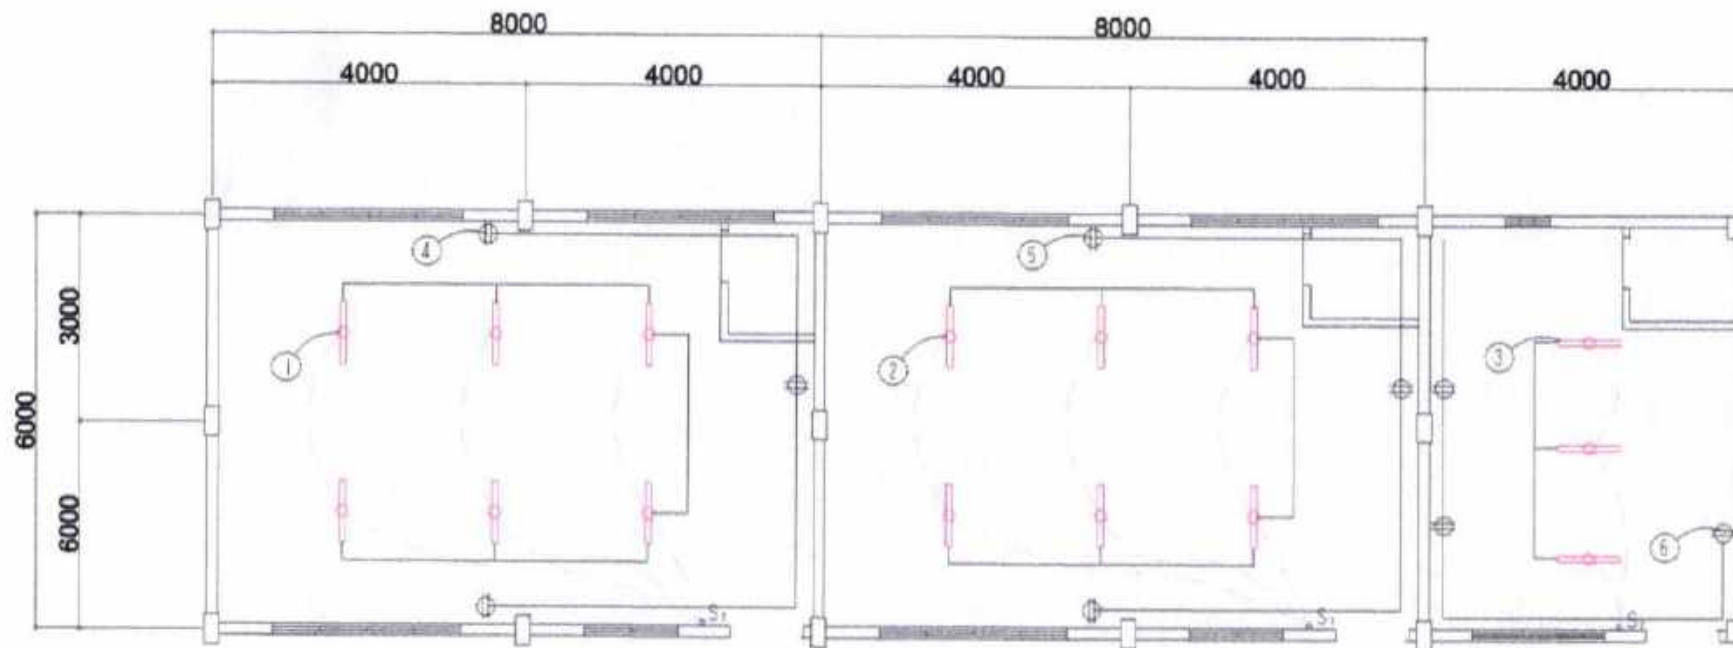

ELECTRICAL PLAN

**SCHEDULE OF LOADS**

CIRCUIT NO.	DESCRIPTION	NO. OF LOADS	VOLTS	WATTS	AMP	SIZE OF WIRE	SIZE OF CONDUIT
1	LIGHTING OUTLET	6	230	600	2.60	2-2.0mm <sup>2</sup> THW	15mmØ
2	LIGHTING OUTLET	6	230	600	2.60	2-2.0mm <sup>2</sup> THW	15mmØ
3	LIGHTING OUTLET	3	230	300	1.30	2-2.0mm <sup>2</sup> THW	15mmØ
4	CONVENIENCE OUTLET	3	230	540	2.34	2-3.5mm <sup>2</sup> THW	20mmØ
5	CONVENIENCE OUTLET	3	230	540	2.34	2-3.5mm <sup>2</sup> THW	20mmØ
6	CONVENIENCE OUTLET	3	230	540	2.34	2-3.5mm <sup>2</sup> THW	20mmØ
<b>TOTAL</b>					<b>13.52</b>		

**ELECTRICAL NOTES**

ALL ELECTRICAL WORKS SHALL BE DONE IN ACCORDANCE WITH THE LATEST RULES AND REGULATIONS OF THE PHIL. ELECTRICAL CODE AS WELL AS THE LOCAL AUTHORITY CONCERNED AND THE LOCAL POWER COMPANY.

ALL ELECTRICAL MATERIALS TO BE USED SHALL BE NEED & APPROVED TYPE FOR LOCATION & PURPOSE

MOUNTING HEIGHTS SHALL BE AS FOLLOWS:

- a. LIGHT CONTROL SWITCH- 1.35M ABOVE FIN. FLR. LINE AT CENTER
- b. CONVENIENCE OUTLET-ABOVE 1.0M ABOVE FIN. FLR. LINE AT CENTER
- c. PANEL BOARD- 2.0 M ABOVE FIN. FLR. LINE

ALL ELECTRICAL WORKS SHALL BE UNDER THE DIRECT & IMMEDIATE SUPERVISION OF A DULY LICENSED ELECTRICAL ENGINEER OR REGISTERED MASTER ELECTRICIAN



**CITY ENGINEER'S  
OFFICE**

PROJECT TITLE:  
REPAIR/IMPROV. OF MULTI-PURPOSE HALL (IMELDA  
TYPE 1 BLDG.), ROSA T ARELLANO ES  
LOC: BRGY. MACABOG, WEST DISTRICT  
SORSOGON CITY


DRAWN BY:  
MaPenela Legaspi  
DRAFTING AIDE

RECOMMENDING APPROVAL:  
ROEL D. DOMER, C.E./RMP  
CITY ENGINEER

APPROVED BY:  
MA. ESTERIE HAMOR  
CITY MAYOR

**ROSA T. ARELLANO ELEMENTARY SCHOOL**

**IMELDA TYPE 1 BUILDING**

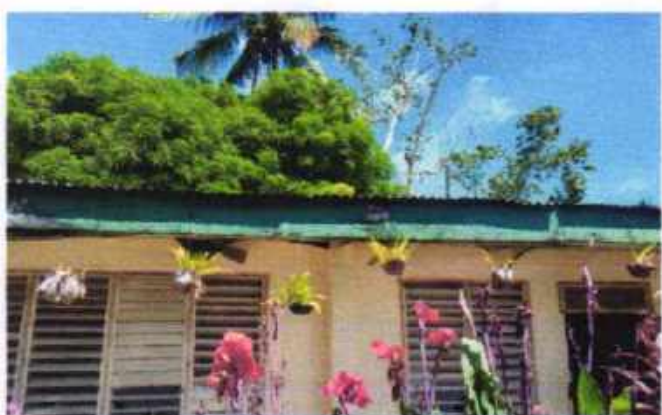


**ROSA T. ARELLANO ELEMENTARY SCHOOL**

**BLSB BUILDING**




# LYDIA D. MARTINEZ MEMORIAL HIGH SCHOOL A2 BUILDING

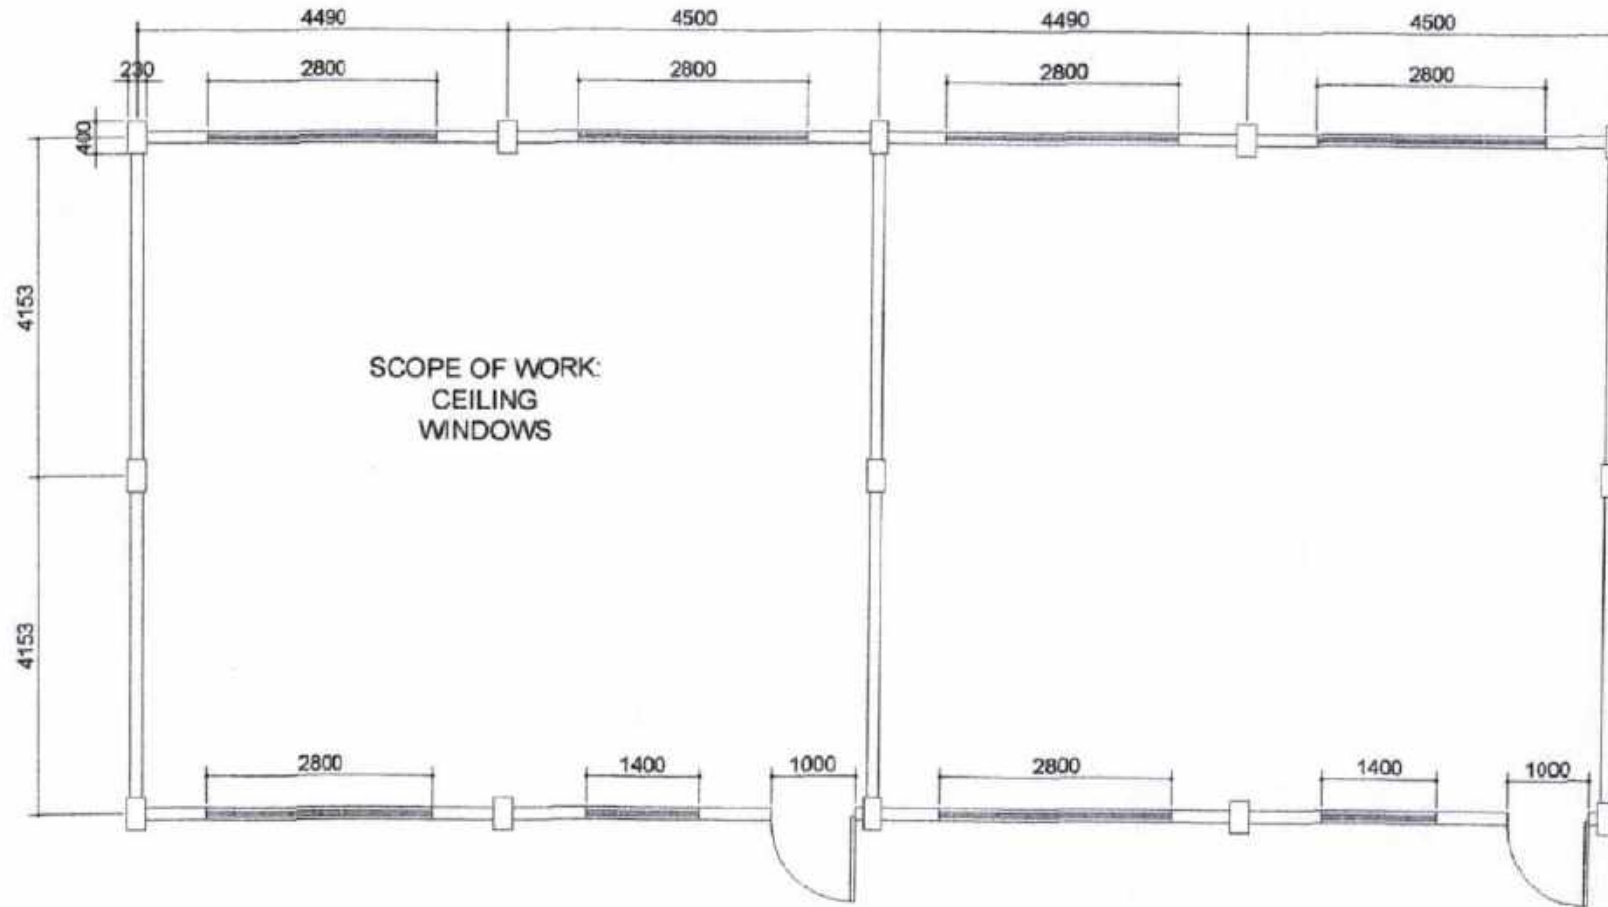


SORSOGON CITY  
CITY ENGINEER'S  
OFFICE

PROJECT TITLE:	DRAWN BY:	RECOMMENDING APPROVAL:	APPROVED BY:
REPAIR/ IMPROVEMENT OF MULTI PURPOSE HALL (A2 BUILDING)			
LOCATION: BRGY. SUGOD, BACON DISTRICT, SORSOGON CITY		ROEL D. DOMER, CE CIC-CEC	MA. ESTER E. HAMOR CITY MAYOR



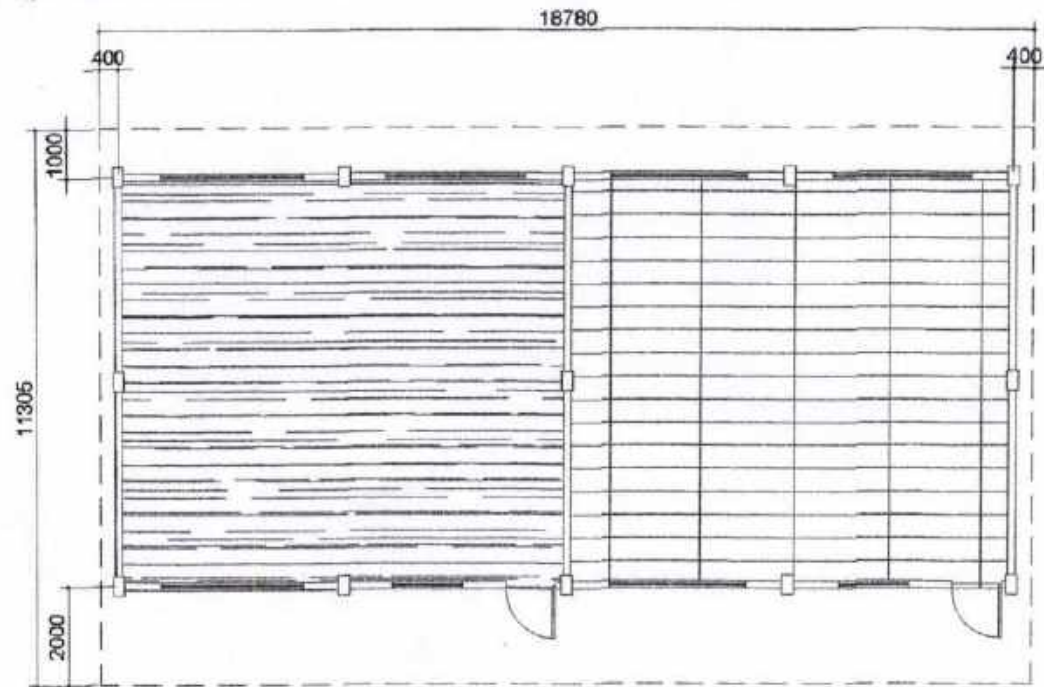


**CEILING PLAN**  
SCALE: N T S

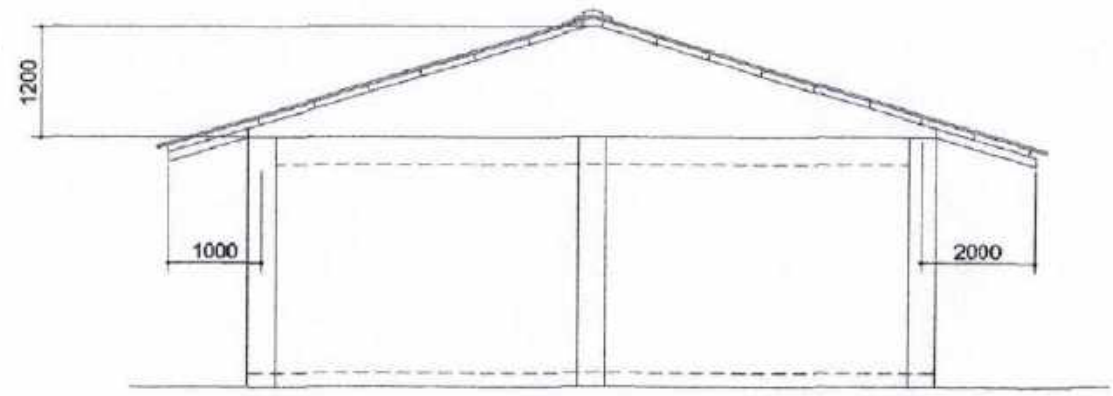

**SIDE ELEVATION**  
SCALE: N T S

METAL DOUBLE FURRING CHANNEL  
(NAILER) 12MM X 38MM X 5M X 0.8MM  
THK @ 1200MM O.C.

METAL CARRYING CHANNEL (CEILING  
JOIST) (NAILER) 12MM X 38MM X 5M X  
0.8MM THK @ 400MM O.C.

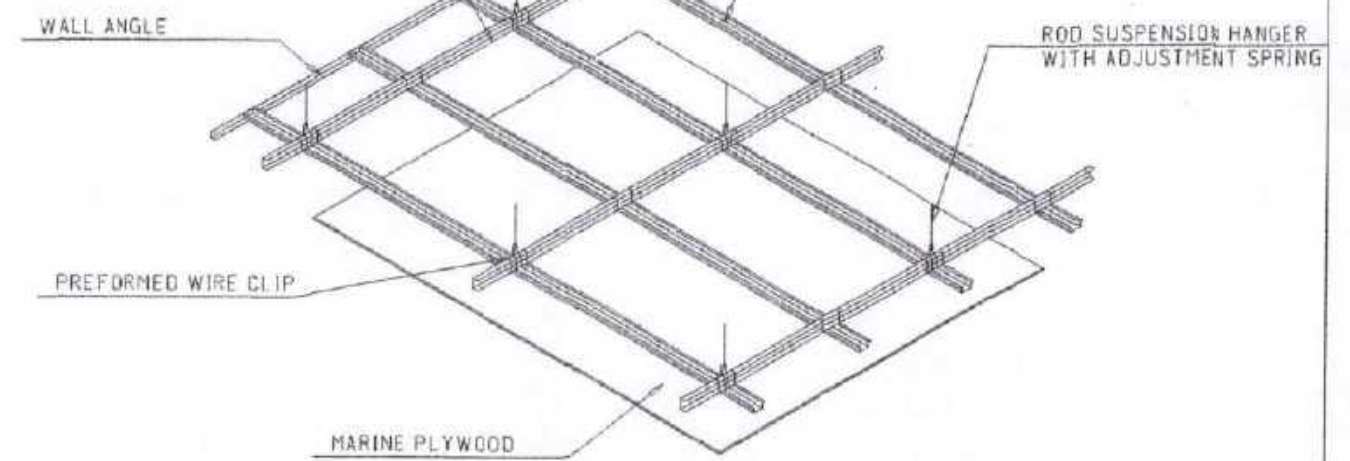


**CEILING DET.**  
SCALE: N T S



SORSOGON CITY  
**CITY ENGINEER'S  
OFFICE**

PROJECT TITLE:	DRAWN BY:	RECOMMENDING APPROVAL:	APPROVED BY:
REPAIR/ IMPROVEMENT OF MULTI PURPOSE HALL (A2 BUILDING) LDMHHS			
LOCATION: BRGY. SUGOD, BACON DISTRICT, SORSOGON CITY		ROEL B. DOMER, CE CIC-CEO	MA. ESTER E. HAMOR CITY MAYOR

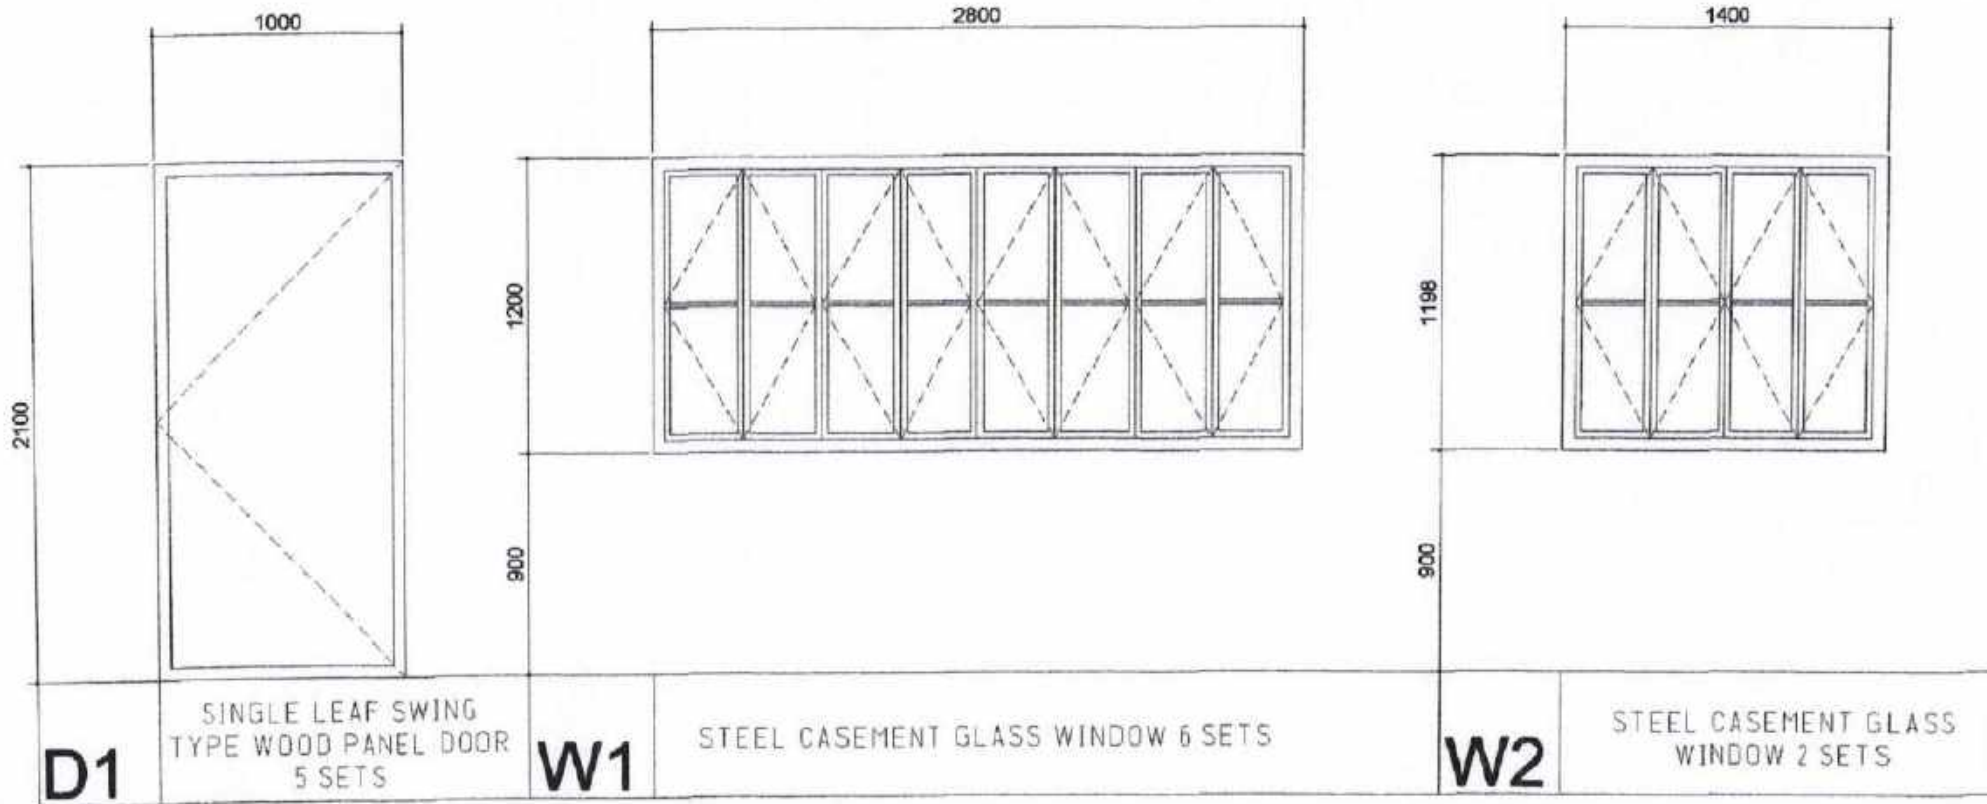

PLEASE SIGN



**DOORS & WINDOWS SCHEDULE**  
SCALE: N T S



SORSOGON CITY  
**CITY ENGINEER'S  
OFFICE**

PROJECT TITLE:	DRAWN BY:	RECOMMENDING APPROVAL:	APPROVED BY:
REPAIR/ IMPROVEMENT OF MULTI PURPOSE HALL (A2 BUILDING) LDMHHS		 ROEL D. DOMEZ, CE DIC-CEO	 MA. ESTER E. HAMOR CITY MAYOR
LOCATION: BRGY. SUGOD, BACON DISTRICT, SORSOGON CITY			

## ELECTRICAL NOTES


ALL ELECTRICAL WORKS SHALL BE DONE IN ACCORDANCE WITH THE LATEST RULES AND REGULATIONS OF THE PHIL. ELECTRICAL CODE AS WELL AS THE LOCAL AUTHORITY CONCERNED AND THE LOCAL POWER COMPANY.

ALL ELECTRICAL MATERIALS TO BE USED SHALL BE NEED & APPROVED TYPE FOR LOCATION & PURPOSE

MOUNTING HEIGHTS SHALL BE AS FOLLOWS:

- a. LIGHT CONTROL SWITCH- 1.35M ABOVE FIN. FLR. LINE AT CENTER
- b. CONVENIENCE OUTLET-ABOVE 1.0M ABOVE FIN. FLR. LINE AT CENTER
- c. PANEL BOARD- 2.0 M ABOVE FIN. FLR. LINE

ALL ELECTRICAL WORKS SHALL BE UNDER THE DIRECT & IMMEDIATE SUPERVISION OF A DULY LICENSED ELECTRICAL ENGINEER OR REGISTERED MASTER ELECTRICIAN

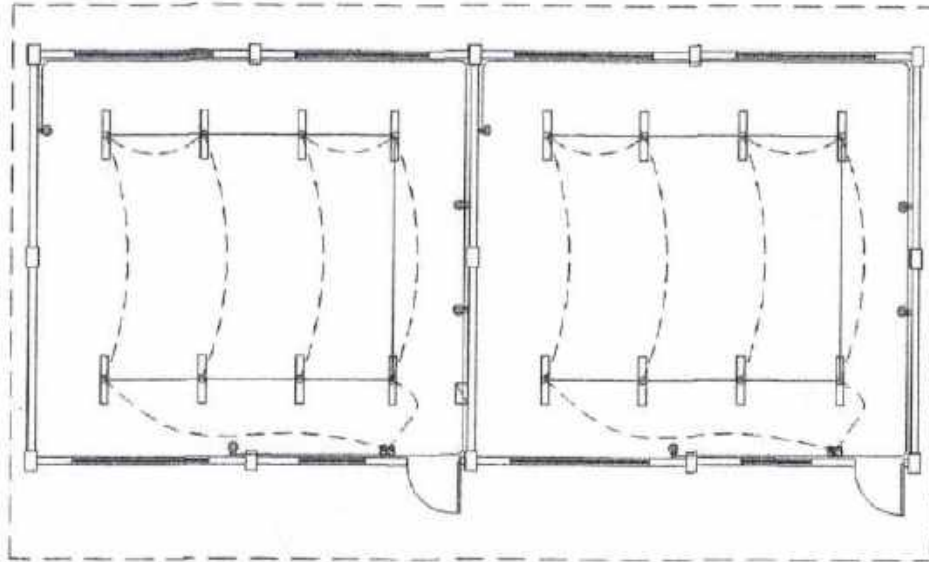

### SCHEDULE OF LOADS

CIRCUIT NO.	DESCRIPTION	NO. OF LOADS	VOLTS	WATTS	AMP	SIZE OF WIRE	SIZE OF CONDUIT
1	LIGHTING OUTLET	8	230	800	3.47	2-2.0mm <sup>2</sup> THW	15mm $\phi$
2	CONVENIENCE OUTLET	4	230	720	3.13	2-3.5mm <sup>2</sup> THW	20mm $\phi$
	TOTAL	12		1520	6.6		

TOTAL VA = 1520 VA

IT = 1520 VA ( 100 % ) DF  
230 V  
=6.60 A

## ELECTRICAL LAYOUT

SCALE

N T S

SORSOGON CITY

CITY ENGINEER'S  
OFFICE

PROJECT TITLE:

REPAIR/ IMPROVEMENT OF MULTI PURPOSE  
HALL (A2 BUILDING) LDMMHs

DRAWN BY:

RECOMMENDING APPROVAL:

APPROVED BY:


LOCATION: BRGY. SUGOD, BACON DISTRICT,  
SORSOGON CITY

ROEL D. DOMER, CE  
OIC-CEC



MA. ESTER E. HAMOR  
CITY MAYOR


PLEASE SIGN
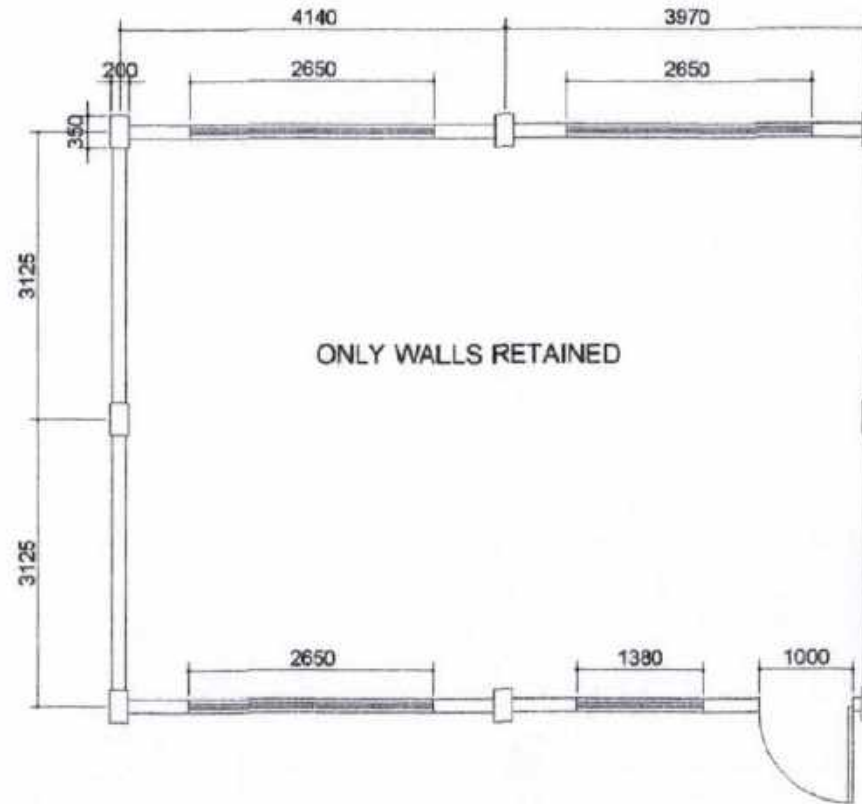
# LYDIA D. MARTINEZ MEMORIAL HIGH SCHOOL A5 BUILDING




SORSOGON CITY  
CITY ENGINEER'S  
OFFICE

PROJECT TITLE:	DRAWN BY:	RECOMMENDING APPROVAL:	APPROVED BY:
REPAIR/ IMPROVEMENT OF MULTI PURPOSE HALL (A5 BUILDING)			
LOCATION: BRGY. SUGOD, BACON DISTRICT, SORSOGON CITY		ENGR. D. DIMER, CE DIO-CEO	MA. ESTER E. HAMOR CITY MAYOR

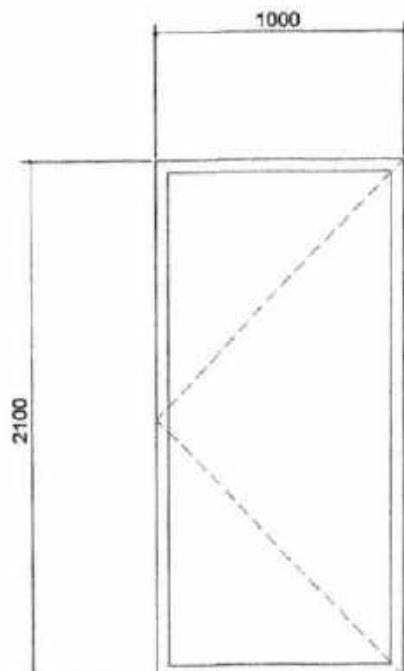

**D1** SINGLE LEAF SWING  
TYPE WOOD PANEL DOOR  
5 SETS

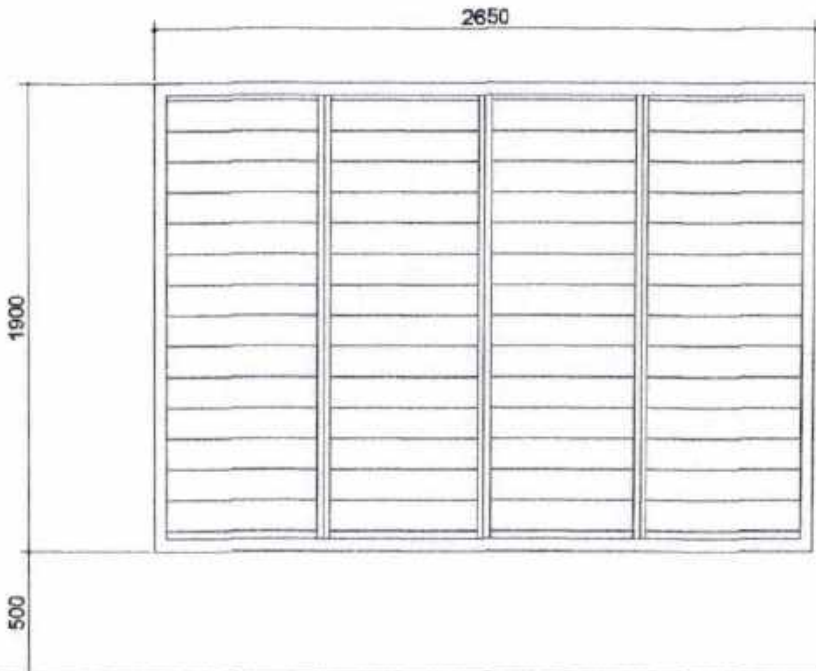

**W1** JALOUSY TYPE GLASS WINDOW 3 SETS





**W2** JALOUSY TYPE GLASS  
WINDOW 1 SETS

**DOORS & WINDOWS SCHEDULE**  
SCALE: N T S



SORSOGON CITY  
**CITY ENGINEER'S  
OFFICE**

PROJECT TITLE:	DRAWN BY:	RECOMMENDING APPROVAL:	APPROVED BY:
REPAIR/IMPROVEMENT OF MULTI PURPOSE HALL (A5 BUILDING)			
LOCATION: BRGY. SUGOD, BACON DISTRICT, SORSOGON CITY		ROEL D. DIMER, CE OIC-CEB	MA. ESTER E. HAMOR CITY MAYOR

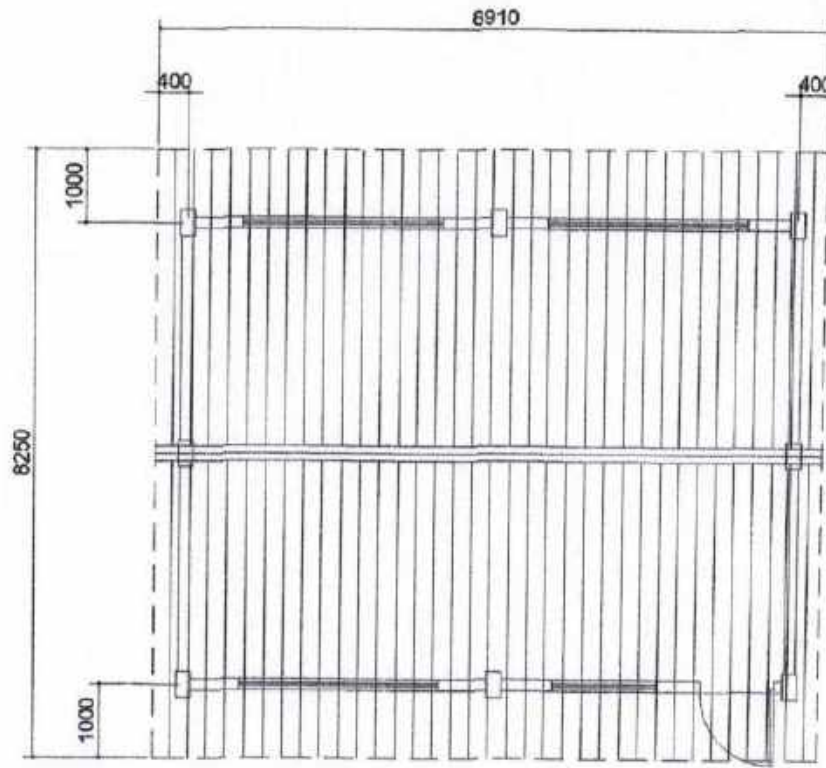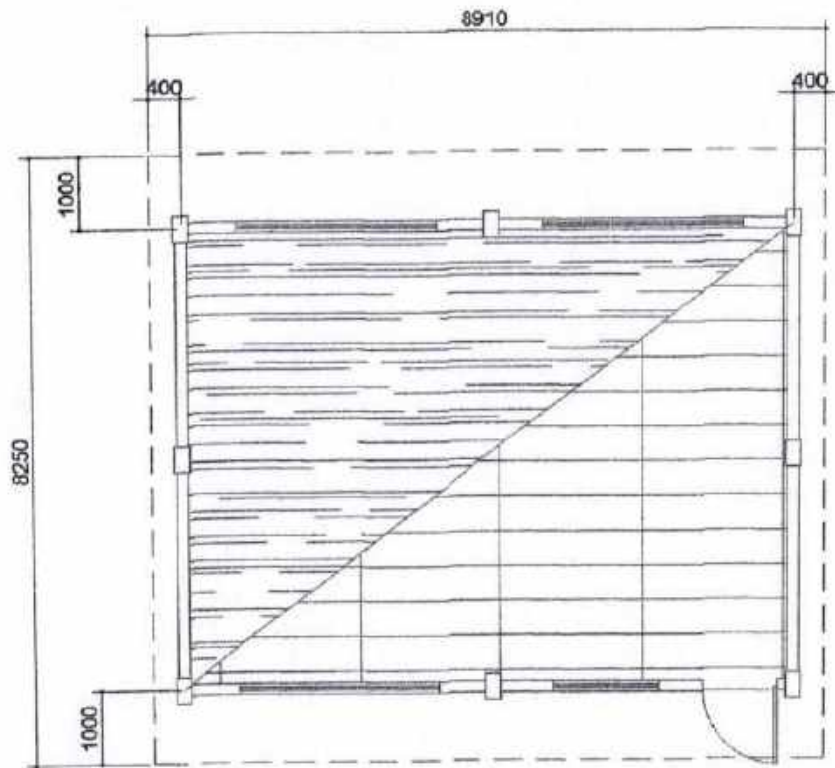

CEILING PLAN  
SCALE: N T S


ROOF PLAN  
SCALE: N T S



SORSOGON CITY  
CITY ENGINEER'S  
OFFICE


PROJECT TITLE:	DRAWN BY:	RECOMMENDING APPROVAL:	APPROVED BY:
REPAIR/ IMPROVEMENT OF MULTI PURPOSE HALL (A5 BUILDING)			
LOCATION: BRGY. SUGOD, BACON DISTRICT, SORSOGON CITY		ROEL D. DOMER, CE CIC-CEO	MA. ESTER E. HAMOR CITY MAYOR

# LYDIA D. MARTINEZ MEMORIAL HIGH SCHOOL A1 BUILDING

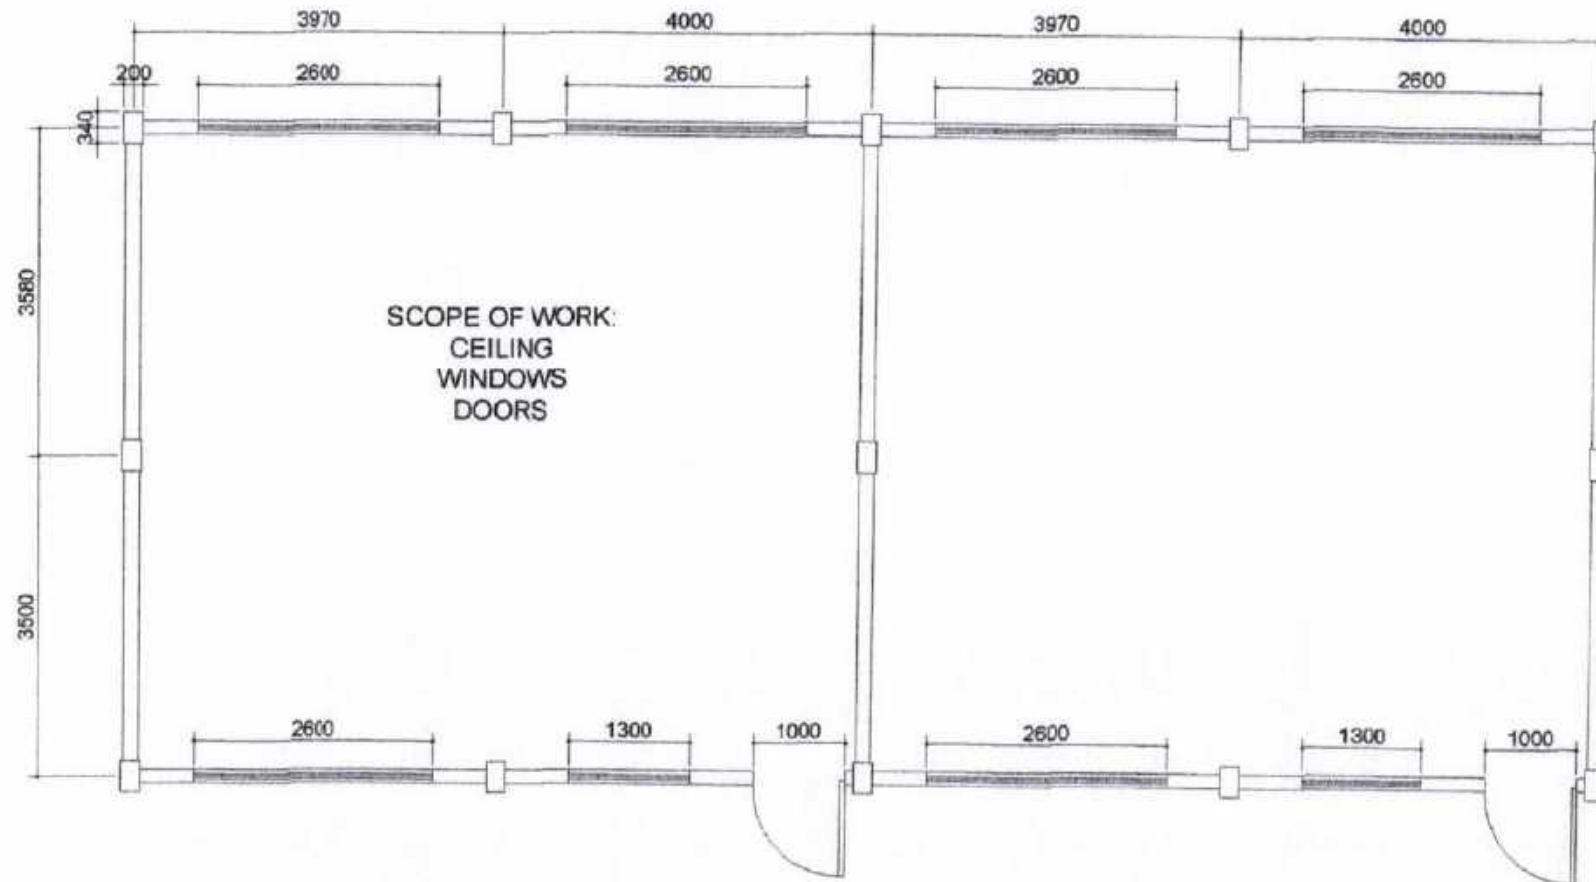


SORSOGON CITY  
CITY ENGINEER'S  
OFFICE

PROJECT TITLE:	DRAWN BY:	RECOMMENDING APPROVAL:	APPROVED BY:
REPAIR/ IMPROVEMENT OF MULTI PURPOSE HALL (A1 BUILDING)			
LOCATION: BRGY. SUGOD, BACON DISTRICT, SORSOGON CITY		ROEL D. BOMER, CE CIC-CEC	MA. ESTER E. HAMOR CITY MAYOR

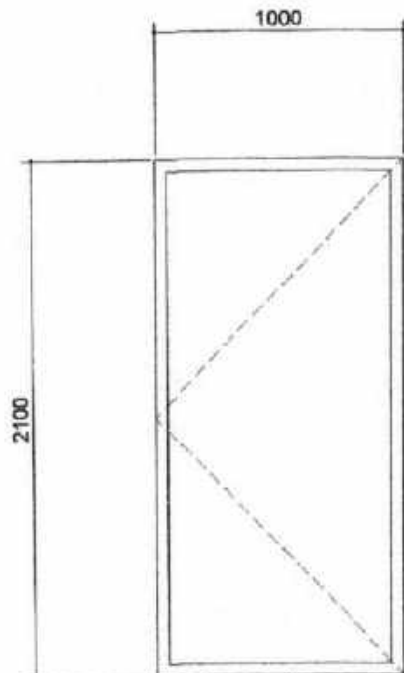


**D1**

SINGLE LEAF SWING  
TYPE WOOD PANEL DOOR  
2 SETS

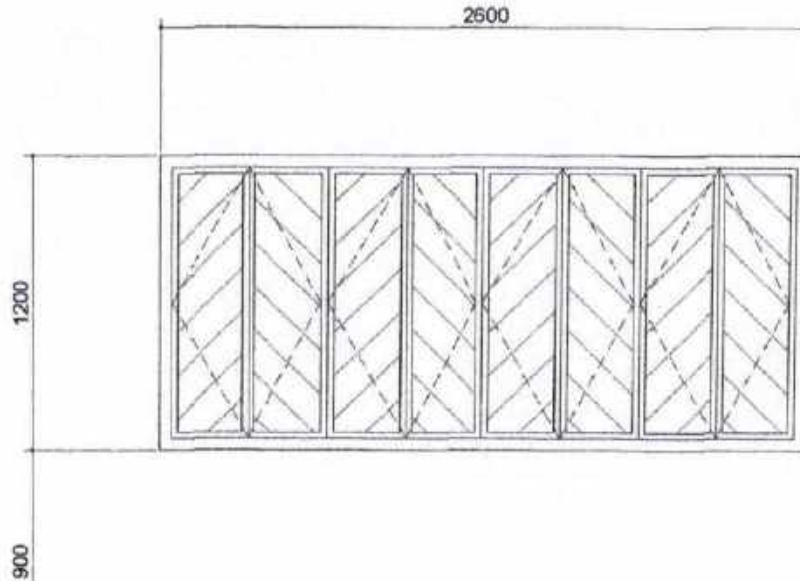

**W1**

STEEL CASEMENT GLASS WINDOW 6 SETS

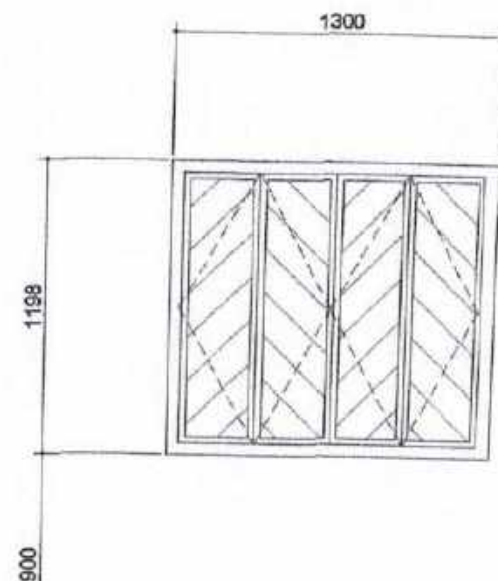

**W2**

STEEL CASEMENT GLASS  
WINDOW 2 SETS



SORSOGON CITY  
**CITY ENGINEER'S  
OFFICE**

PROJECT TITLE:  
REPAIR/ IMPROVEMENT OF MULTI PURPOSE  
HALL (A1 BUILDING)  
LOCATION: BRGY. SUGOD, BACON DISTRICT,  
SORSOGON CITY

DRAWN BY:

RECOMMENDING APPROVAL:


ROB. B. DOMESTICO, CE  
CIB-CEO

APPROVED BY:


MA. ESTER E. HAMOR  
CITY MAYOR

PLEASE **SIGN**




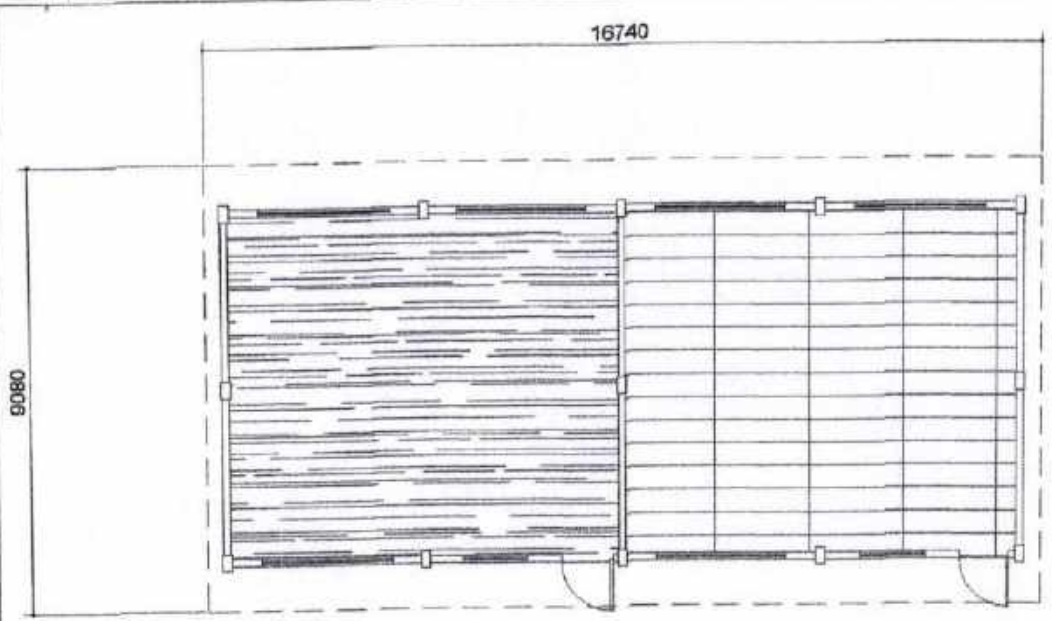

**C E I L I N G P L A N**  
SCALE: N T S

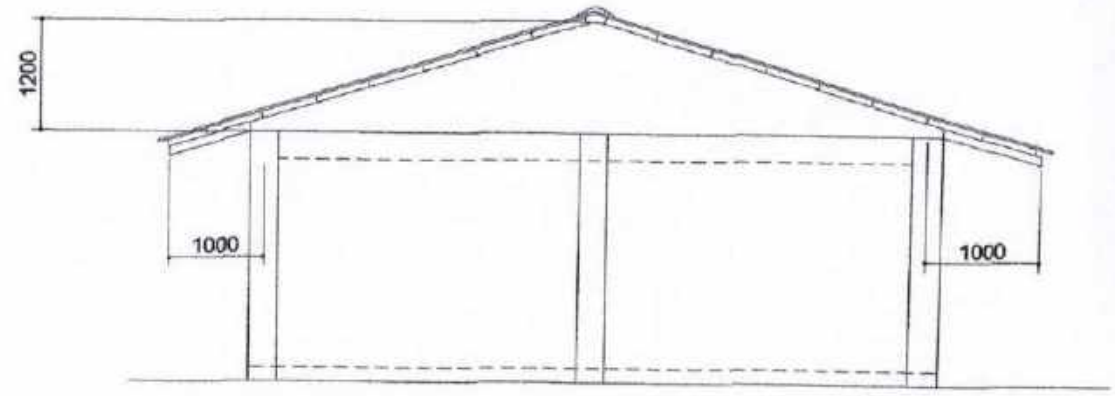

**S I D E E L E V A T I O N**  
SCALE: N T S

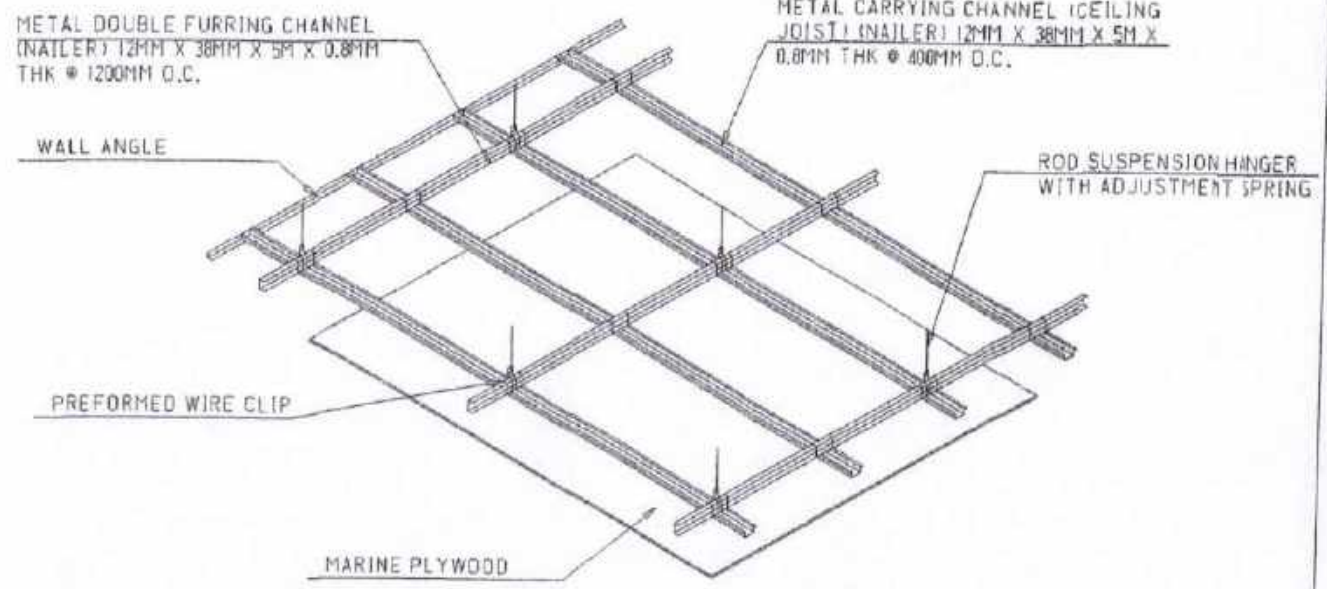

**C E I L I N G D E T .**  
SCALE: N T S



SORSOGON CITY  
**CITY ENGINEER'S  
OFFICE**

PROJECT TITLE:	DRAWN BY:	RECOMMENDING APPROVAL:	APPROVED BY:
REPAIR/ IMPROVEMENT OF MULTI PURPOSE HALL (A1 BUILDING)			
LOCATION: BRGY. SUGOD, BACON DISTRICT, SORSOGON CITY		JOEL D. DEMER, CE CIC-DEO	MA. ESTER E. HAMOR CITY MAYOR

PLEASE SIGN


# ELECTRICAL NOTES

ALL ELECTRICAL WORKS SHALL BE DONE IN ACCORDANCE WITH THE LATEST RULES AND REGULATIONS OF THE PHIL. ELECTRICAL CODE AS WELL AS THE LOCAL AUTHORITY CONCERNED AND THE LOCAL POWER COMPANY.

ALL ELECTRICAL MATERIALS TO BE USED SHALL BE NEED & APPROVED TYPE FOR LOCATION & PURPOSE

- MOUNTING HEIGHTS SHALL BE AS FOLLOWS:
- a. LIGHT CONTROL SWITCH- 1.35M ABOVE FIN. FLR. LINE AT CENTER
  - b. CONVENIENCE OUTLET-ABOVE 1.0M ABOVE FIN. FLR. LINE AT CENTER
  - c. PANEL BOARD- 2.0 M ABOVE FIN. FLR. LINE

ALL ELECTRICAL WORKS SHALL BE UNDER THE DIRECT & IMMEDIATE SUPERVISION OF A DULY LICENSED ELECTRICAL ENGINEER OR REGISTERED MASTER ELECTRICIAN

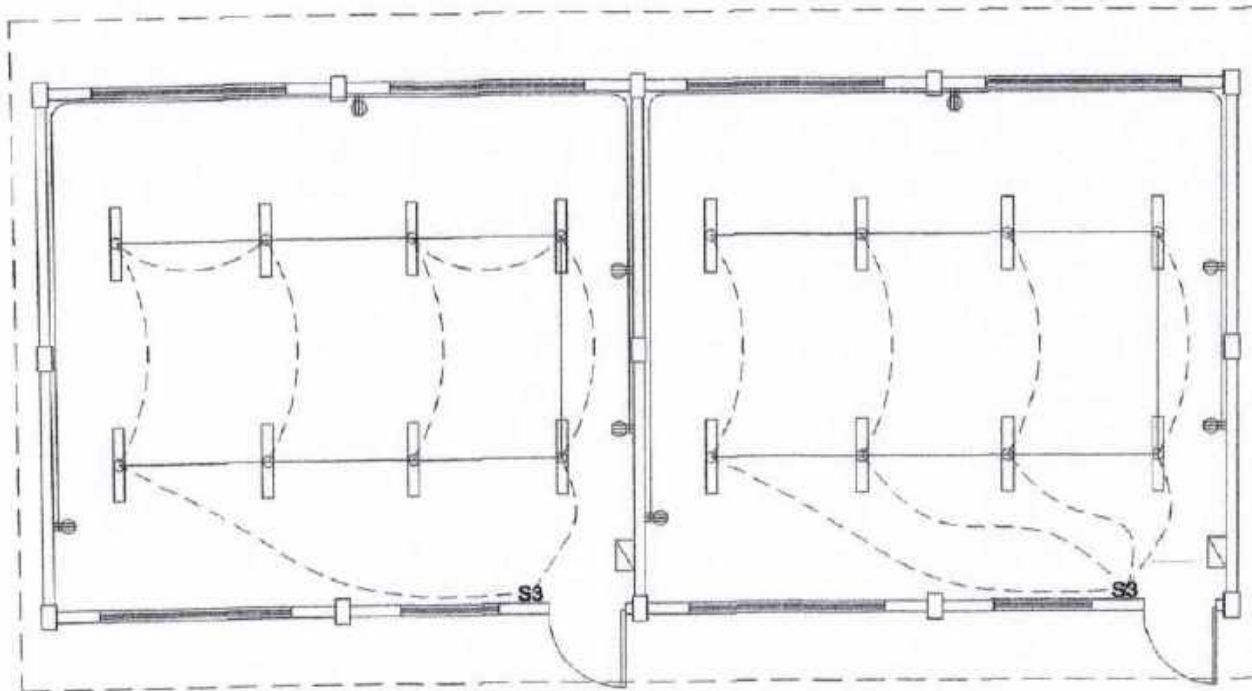

## SCHEDULE OF LOADS

CIRCUIT NO.	DESCRIPTION	NO OF LOADS	VOLTS	WATTS	AMP	SIZE OF WIRE	SIZE OF CONDUIT
1	LIGHTING OUTLET	8	230	800	3.47	2-2.0mm <sup>2</sup> THW	15mm <sup>∅</sup>
2	CONVENIENCE OUTLET	4	230	720	3.13	2-3.5mm <sup>2</sup> THW	20mm <sup>∅</sup>
	TOTAL	12		1520	6.6		

TOTAL VA = 1520 VA

IT = 1520 VA ( 100 % ) DF  
230 V  
=6.60 A

## ELECTRICAL LAYOUT N T S

SCALE:



SORSOGON CITY

CITY ENGINEER'S  
OFFICE

PROJECT TITLE:

REPAIR/ IMPROVEMENT OF MULTI PURPOSE HALL (A1 BUILDING)

LOCATION: BRGY. SUGOD, BACON DISTRICT, SORSOGON CITY

DRAWN BY:

RECOMMENDING APPROVAL:

APPROVED BY:

ROSEL D. DOVER, CE  
OIC-CEO

MA. ESTER E. HAMOR  
CITY MAYOR

# LYDIA D. MARTINEZ MEMORIAL HIGH SCHOOL

## A1 BUILDING (2 UNITS)




LYDIA D. MARTINEZ MEMORIAL HIGH SCHOOL

A2 BUILDING




LYDIA D. MARTINEZ MEMORIAL HIGH SCHOOL

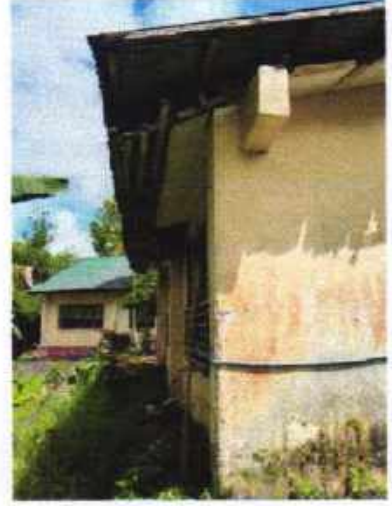

A5 BUILDING

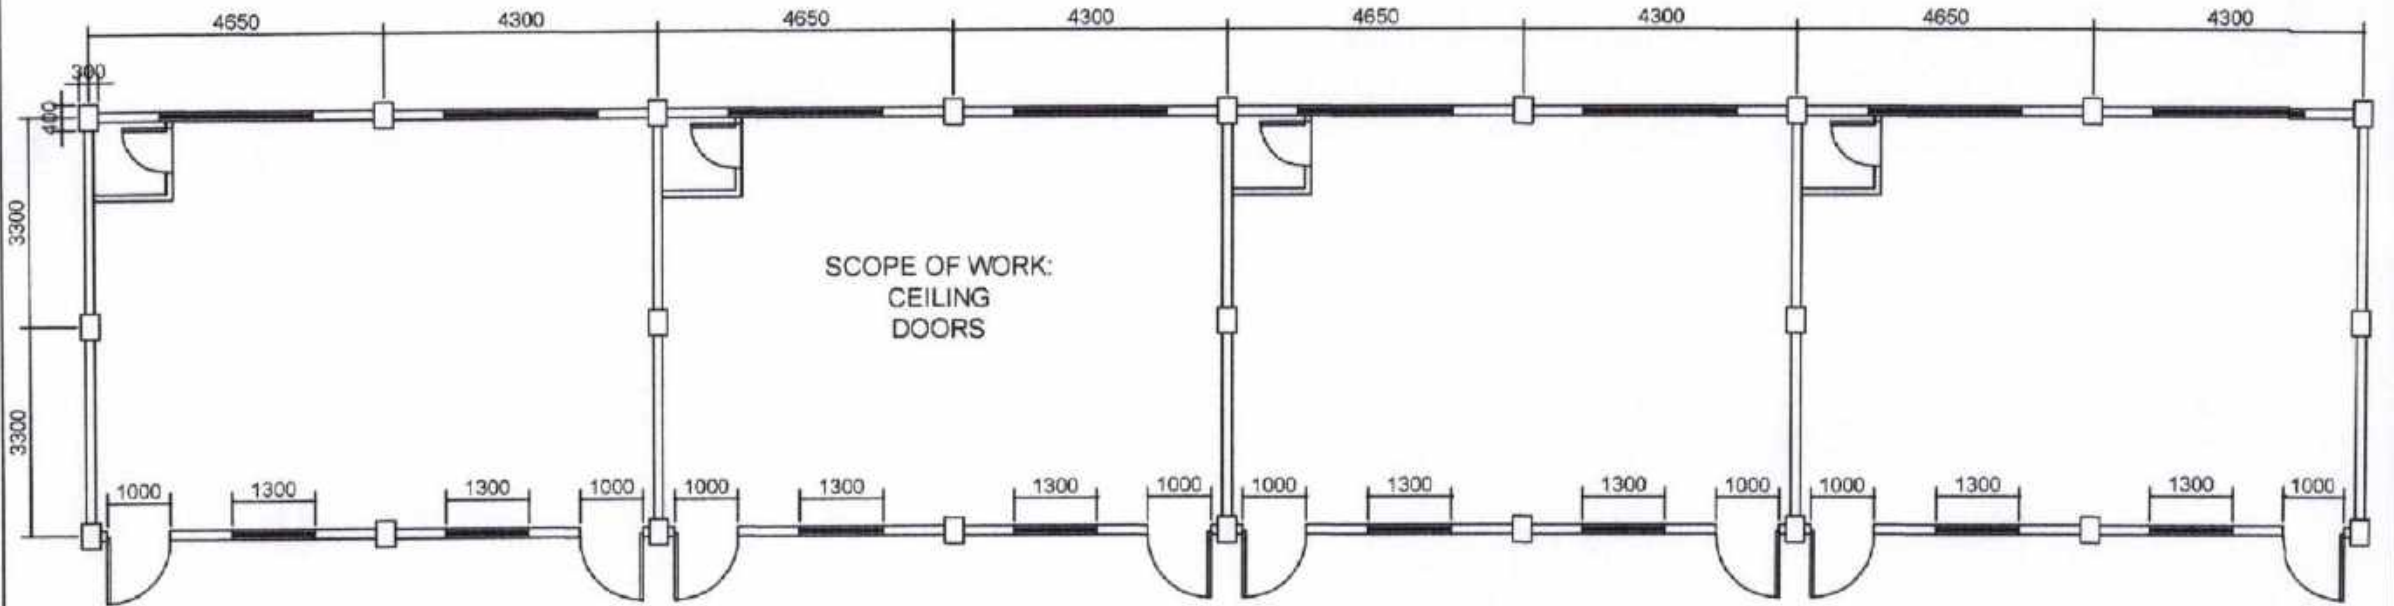


SUGOD ELEM. SCHOOL  
PROJECT CARE BLDG.




SORSOGON CITY  
CITY ENGINEER'S  
OFFICE

PROJECT TITLE:	DRAWN BY:	RECOMMENDING APPROVAL	APPROVED BY:
REPAIR/IMPROVEMENT OF MULTI-PURPOSE HALL (PROJECT CARE BLDG) SUGOD ES			
LOCATION: BRGY. SUGOD, BACON DIST SORSOGON CITY		JOEL D. POWER, CE DIC-C80	MA. ESTER E. HAMOR CITY MAYOR

PLEASE SIGN

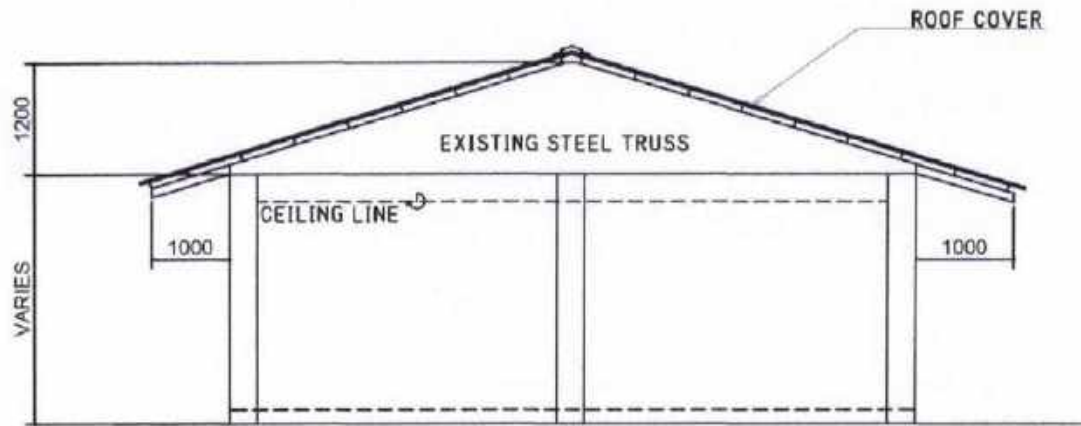

○ SIDE ELEVATION  
SCALE: N T S

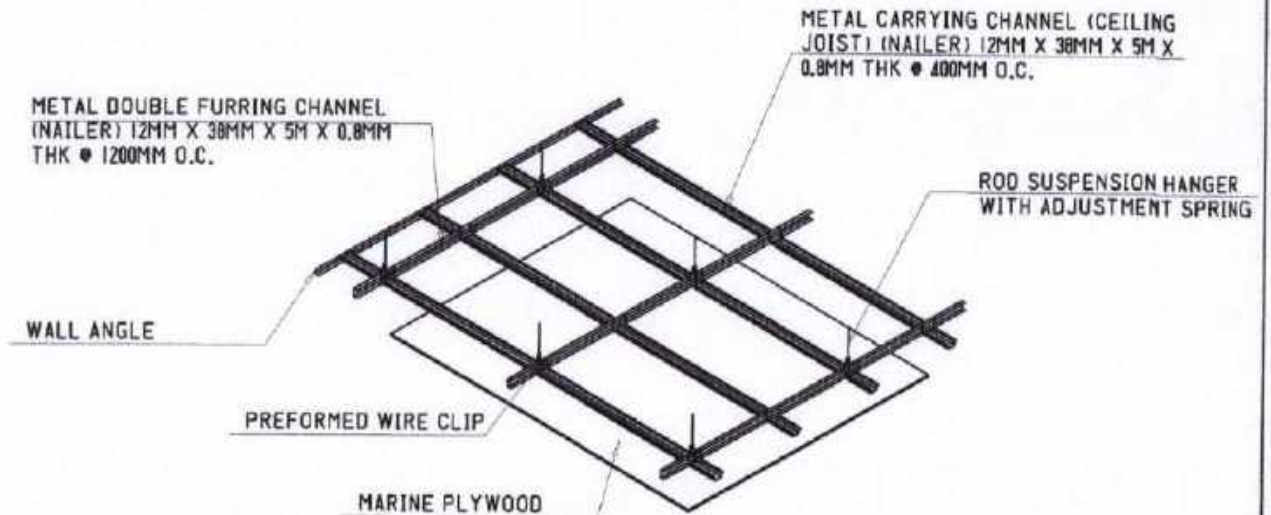


○ CEILING DET.  
SCALE: N T S




SORSOGON CITY  
CITY ENGINEER'S  
OFFICE

PROJECT TITLE	DRAWN BY:	RECOMMENDING APPROVAL	APPROVED BY:
REPAIR/IMPROVEMENT OF MULTI-PURPOSE HALL (PROJECT CARE BLDG) SUGOD ES			
LOCATION: BRGY. SUGOD, BACON DIST SORSOGON CITY		ROEL D. DOMER, CE OIC-CEO	MA. ESTER E. HAMOR CITY MAYOR

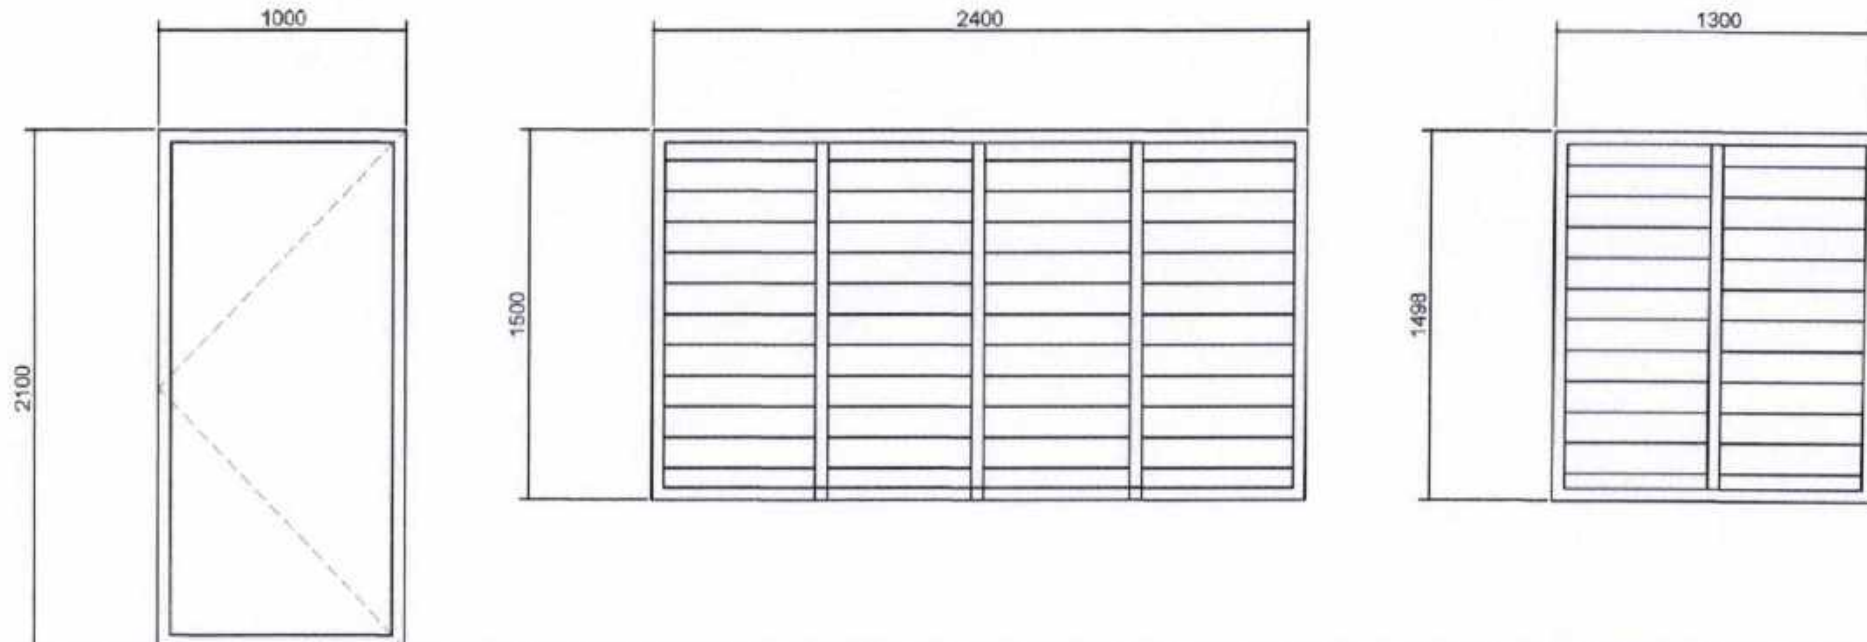



<b>D1</b>	SINGLE LEAF SWING TYPE WOOD PANEL DOOR 8 SETS	<b>W1</b>	JALOUSY TYPE GLASS WINDOW 6 SETS	<b>W2</b>	JALOUSY TYPE GLASS WINDOW 2 SETS
-----------	---	-----------	----------------------------------	-----------	-------------------------------------


**DOOR & WINDOW SCHEDULE**  
 SCALE: \_\_\_\_\_ N T S




SORSOGON CITY  
**CITY ENGINEER'S  
 OFFICE**


PROJECT TITLE: REPAIR/IMPROVEMENT OF MULTI-PURPOSE HALL (PROJECT CARE BLDG) SUGOD ES	DRAWN BY:	RECOMMENDING APPROVAL 	APPROVED BY: 
LOCATION: BRGY. SUGOD, BACON DIST SORSOGON CITY		JOEL D. DUMAR, CE PIC-CEO	MA. ESTER E. HAMOR CITY MAYOR

PLEASE SIGN



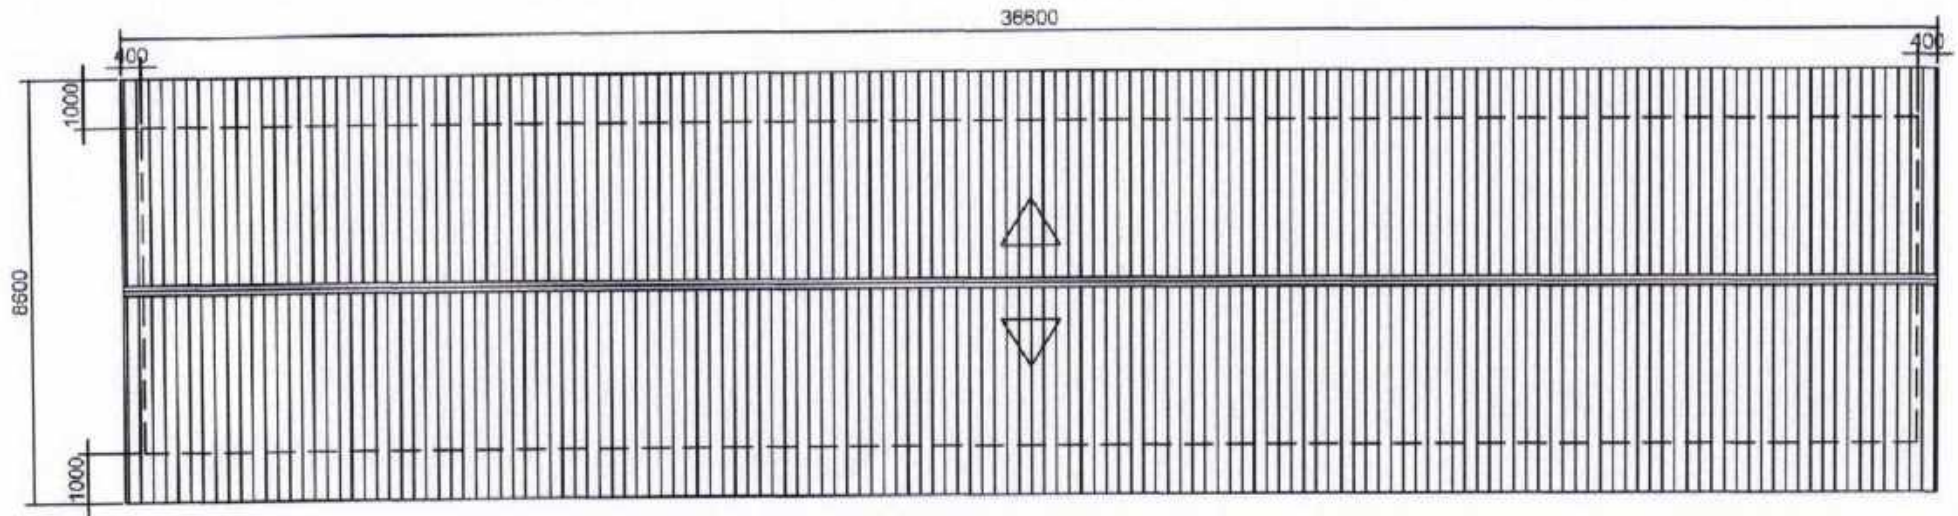

ROOF PLAN  
SCALE: N T S

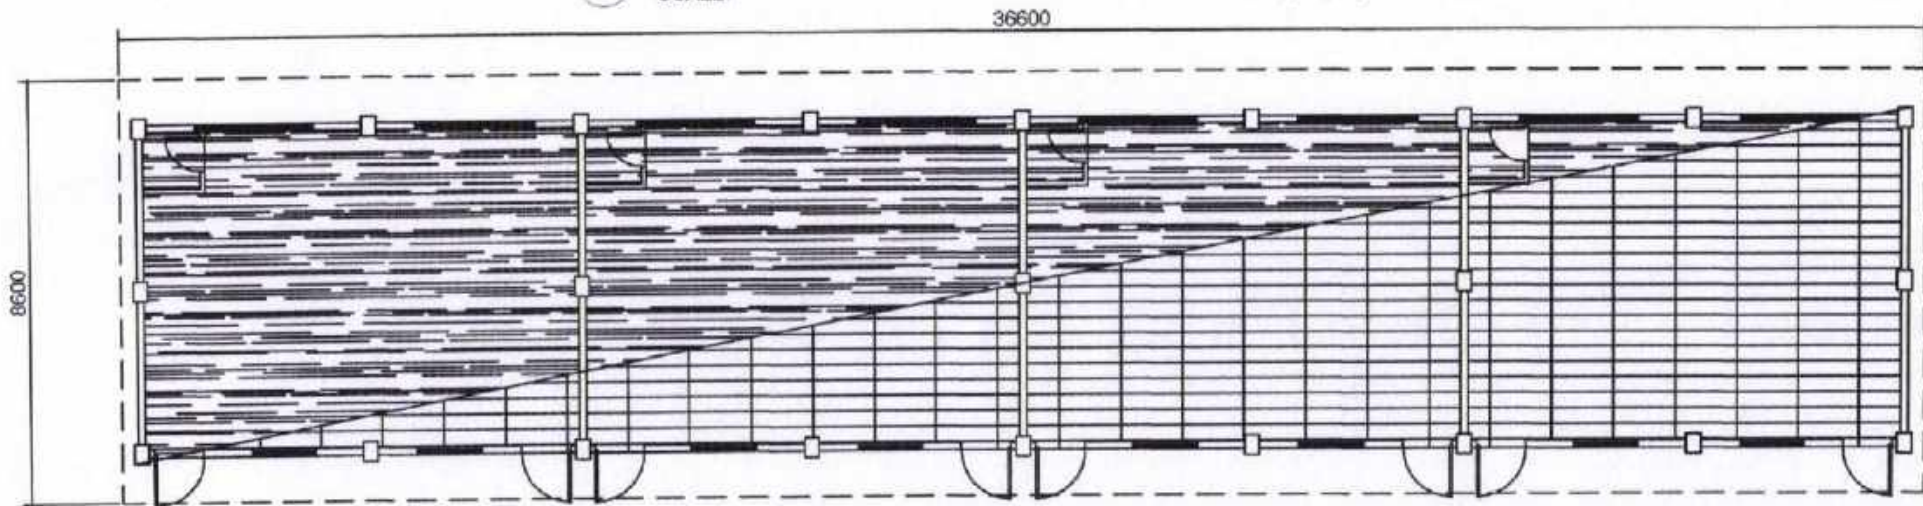


CEILING PLAN  
SCALE: N T S



SORSOGON CITY  
CITY ENGINEER'S  
OFFICE

PROJECT TITLE:	DRAWN BY:	RECOMMENDING APPROVAL	APPROVED BY:
REPAIR/IMPROVEMENT OF MULTI-PURPOSE HALL (PROJECT CARE BLDG) SUGOD ES			
LOCATION: BRGY. SUGOD, BACON DIST SORSOGON CITY		ROEL D. DOMER, CE CIC-CEO	MA. ESTER E. HAMOR CITY MAYOR

PLEASE S

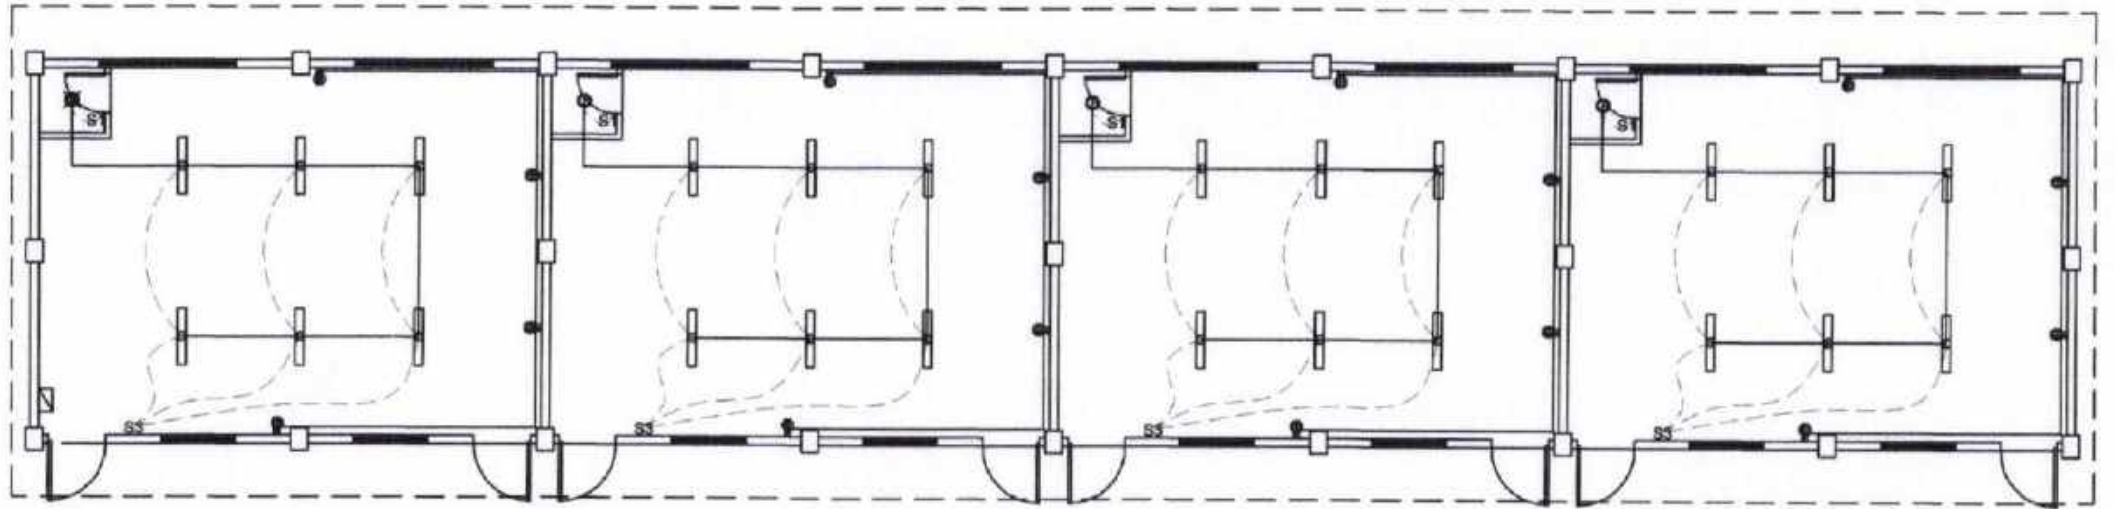

**ELECTRICAL LAYOUT**  
 SCALE: N T S



SORSOGON CITY  
**CITY ENGINEER'S  
 OFFICE**

PROJECT TITLE:	DRAWN BY:	RECOMMENDING APPROVAL	APPROVED BY:
REPAIR/IMPROVEMENT OF MULTI-PURPOSE HALL (PROJECT CARE BLDG) SUGOD ES		ROEL D. DIMER, CE OIC-CEO	MA. ESTER E. HAMOR CITY MAYOR
LOCATION: BRGY. SUGOD, BACON DIST SORSOGON CITY			


PLEASE

**SUGOD ELEMENTARY SCHOOL**

**PROJECT CARE BUILDING (4 UNITS)**




# SUGOD ELEM. SCHOOL BLSB BLDG.

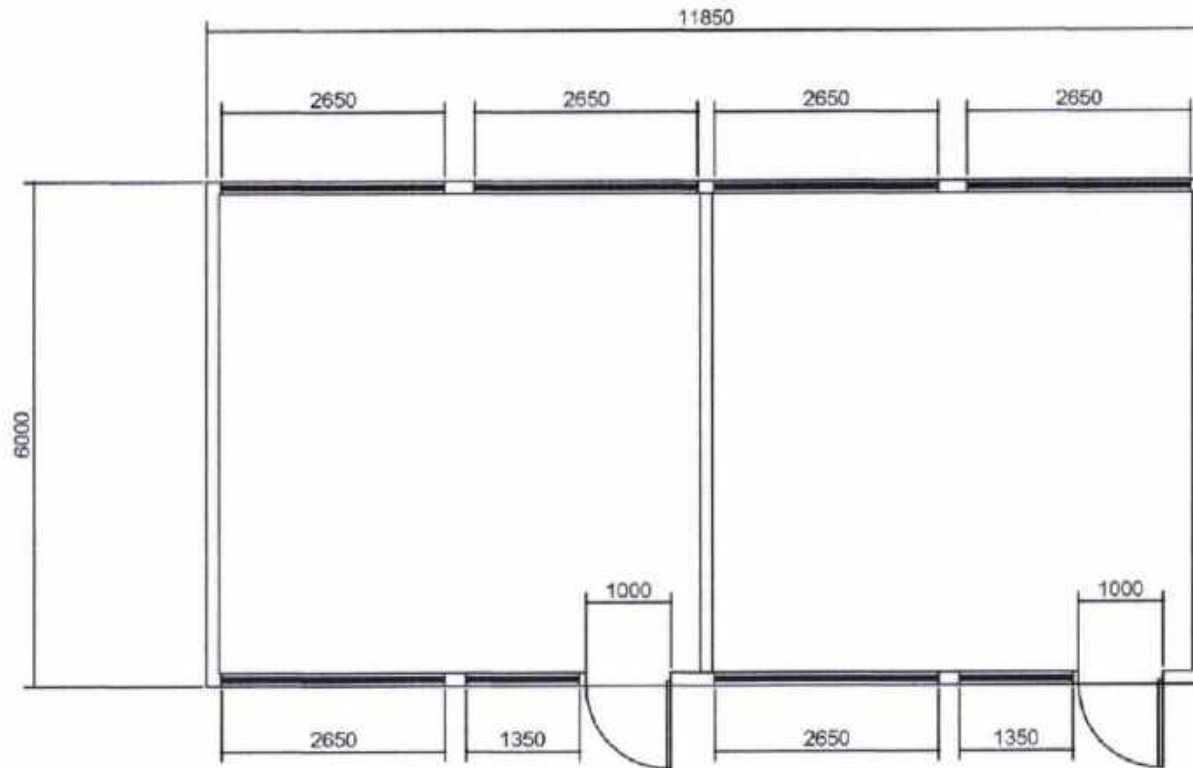


SORSOGON CITY  
CITY ENGINEER'S  
OFFICE

PROJECT TITLE:	DRAWN BY:	RECOMMENDING APPROVAL	APPROVED BY:
REPAIR/IMPROVEMENT OF MULTI-PURPOSE HALL (BLSB AND RP-US BLDG) SUGOD ES			
LOCATION: BRGY. SUGOD, BACON DIST SORSOGON CITY		ROSEL D. DOMER, CE CIC-CEO	MA. ESTER E. HAMOR CITY MAYOR

PLEASE

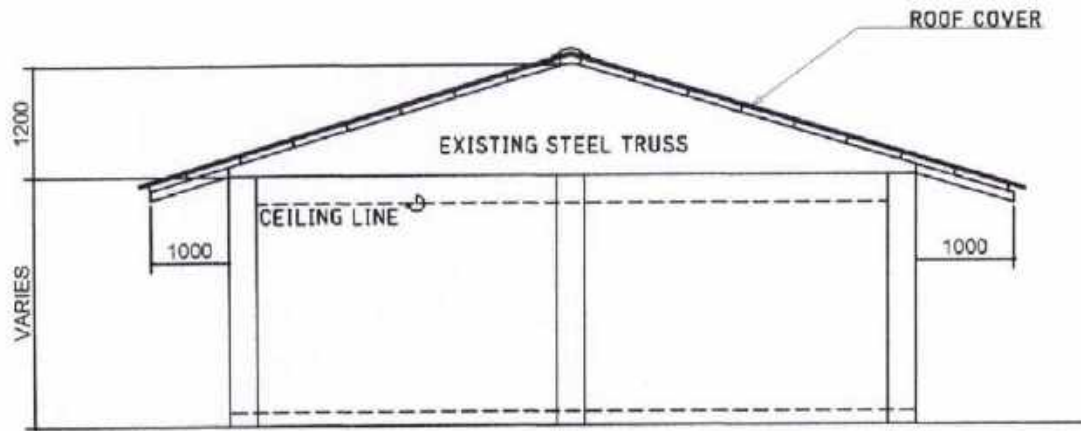

○ SIDE ELEVATION  
SCALE: N T S



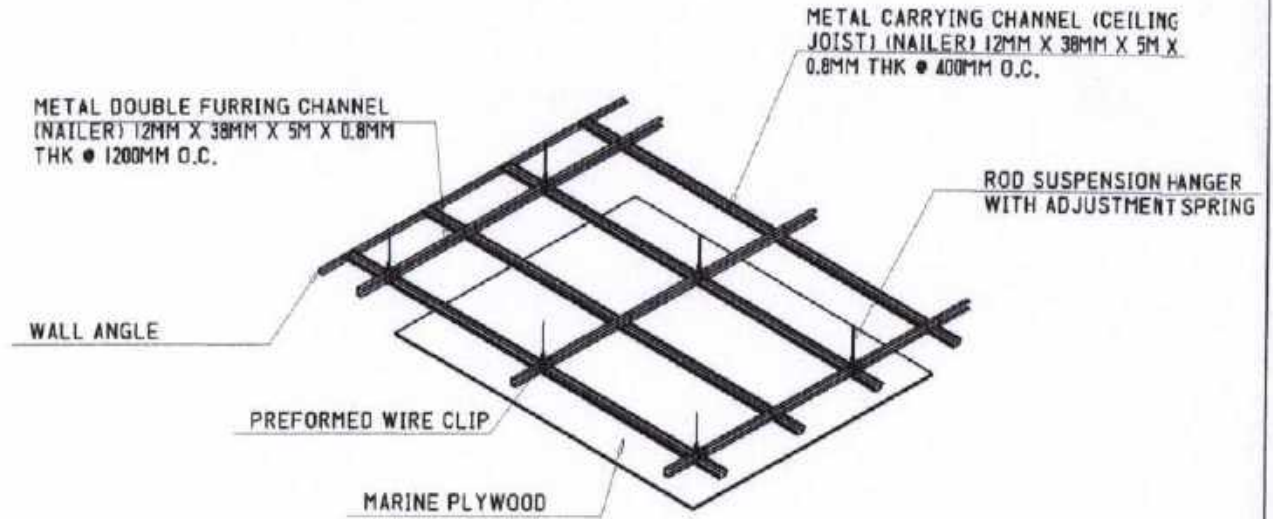


○ CEILING DET.  
SCALE: N T S



CITY ENGINEER'S  
OFFICE

PROJECT TITLE:	DRAWN BY:	RECOMMENDING APPROVAL	APPROVED BY:
REPAIR/IMPROVEMENT OF MULTI-PURPOSE HALL (BLSB AND RP-US BLDG) SUGOD ES			
LOCATION: BRGY. SUGOD, BACON DIST SORSOGON CITY		RONALD DOMEN, CE CIC-CEO	MA. ESTER E. HAMOR CITY MAYOR

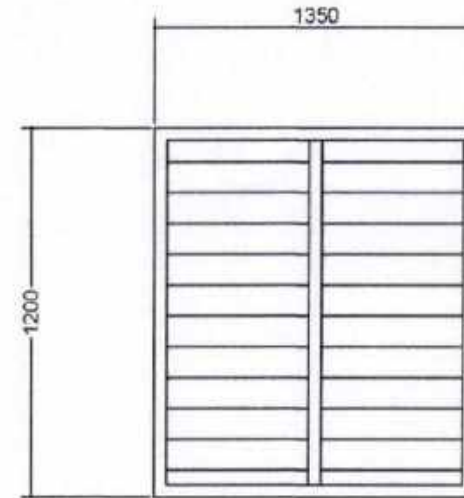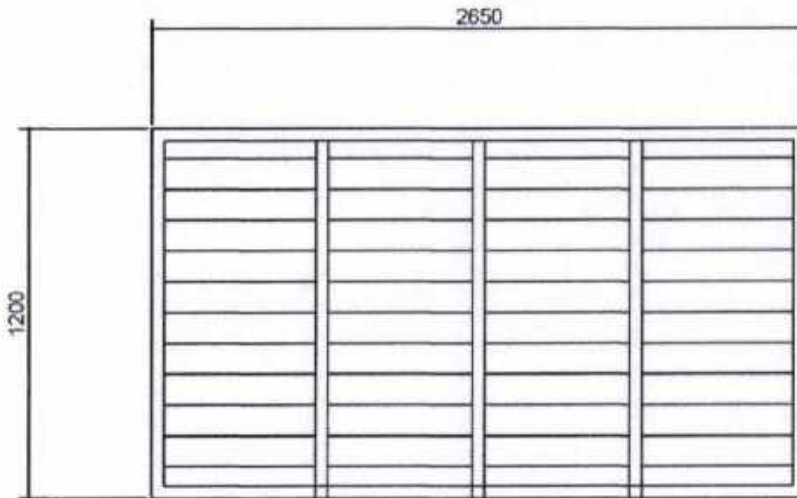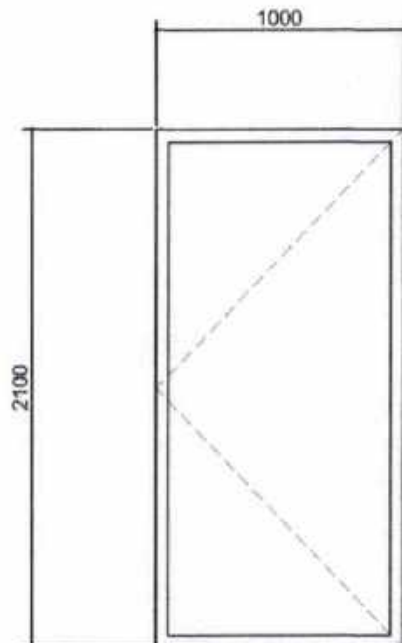

<b>D1</b>	SINGLE LEAF SWING TYPE WOOD PANEL DOOR 8 SETS	<b>W1</b>	JALOUSY TYPE GLASS WINDOW 6 SETS	<b>W2</b>	JALOUSY TYPE GLASS WINDOW 2 SETS
-----------	---	-----------	----------------------------------	-----------	-------------------------------------

**DOOR & WINDOW SCHEDULE**  
 SCALE: N T S




S O R S O G O N C I T Y  
**CITY ENGINEER'S  
 O F F I C E**


PROJECT TITLE:	DRAWN BY:	RECOMMENDING APPROVAL	APPROVED BY:
REPAIR/IMPROVEMENT OF MULTI-PURPOSE HALL (BLSB AND RP-US BLDG) SUGOD ES			
LOCATION: BRGY. SUGOD, BACON DIST SORSOGON CITY		ROEL D. DOHAR, CE OIC-CEO	MA. ESTER E. HAMOR CITY MAYOR

PLEASE

**SUGOD ELEM. SCHOOL  
BLSB BLDG.**

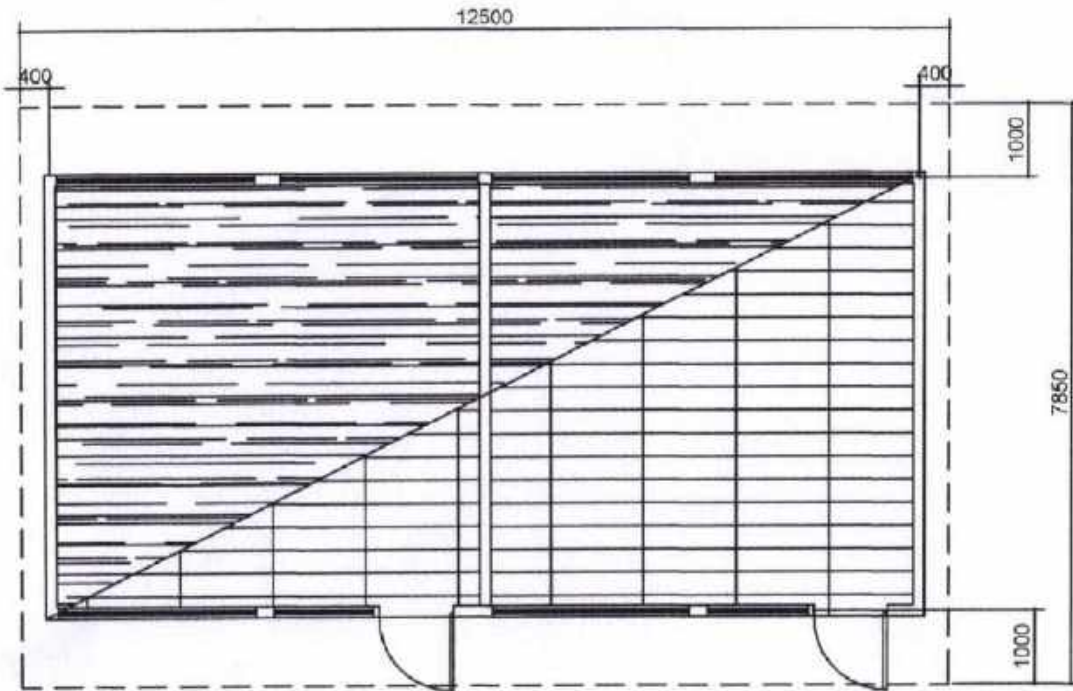


 
○ **C E I L I N G P L A N**  
SCALE: N T S

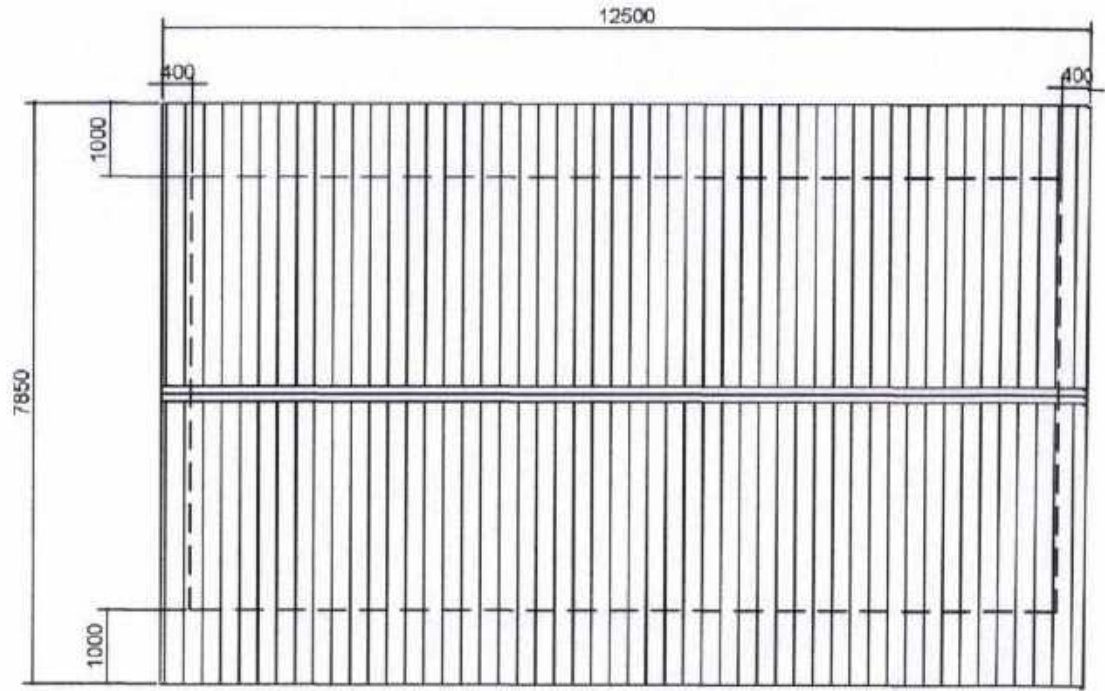


○ **R O O F P L A N**  
SCALE: N T S





SORSOGON CITY  
**CITY ENGINEER'S  
O F F I C E**

PROJECT TITLE:	DRAWN BY:	RECOMMENDING APPROVAL	APPROVED BY:
REPAIR/IMPROVEMENT OF MULTI-PURPOSE HALL (BLSB AND RP-US BLDG) SUGOD ES		 RUEL D. BORER, CE CIC-CEO	 MA. ESTER E. HAMOR CITY MAYOR
LOCATION: BRGY. SUGOD, BACON DIST SORSOGON CITY			

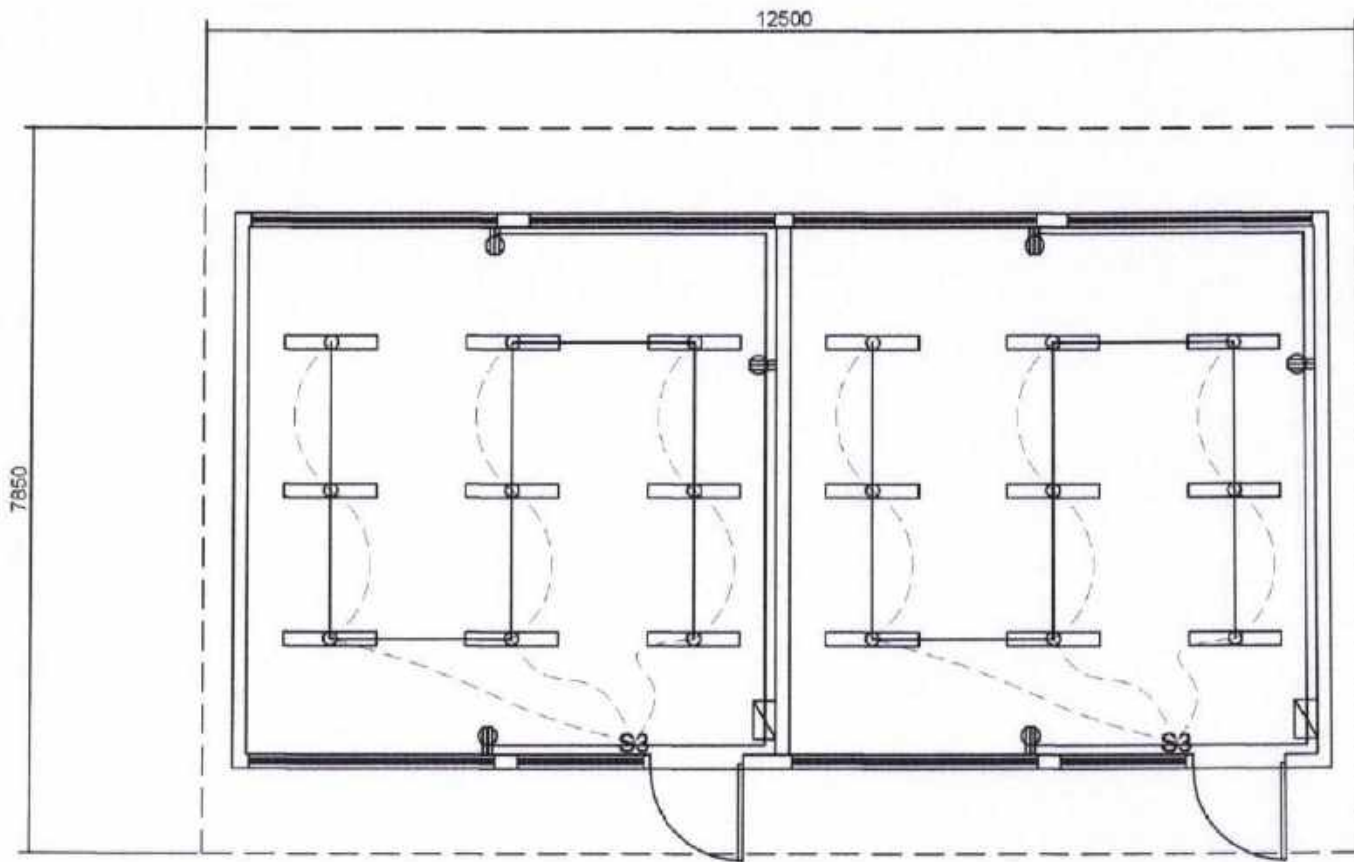PLEASE




**CITY ENGINEER'S  
OFFICE**

PROJECT TITLE:	DRAWN BY:	RECOMMENDING APPROVAL	APPROVED BY:
REPAIR/IMPROVEMENT OF MULTI-PURPOSE HALL (BLSB AND RP-US BLDG) SUGOD ES		 ROEL B. DOMARA, CE CHIEF ENGINEER	 MA. ESTER E. HAMOR CITY MAYOR
LOCATION: BRGY. SUGOD, BACON DIST SORSOGON CITY			

PLEASE



# SUGOD ELEM. SCHOOL RPUS BLDG.

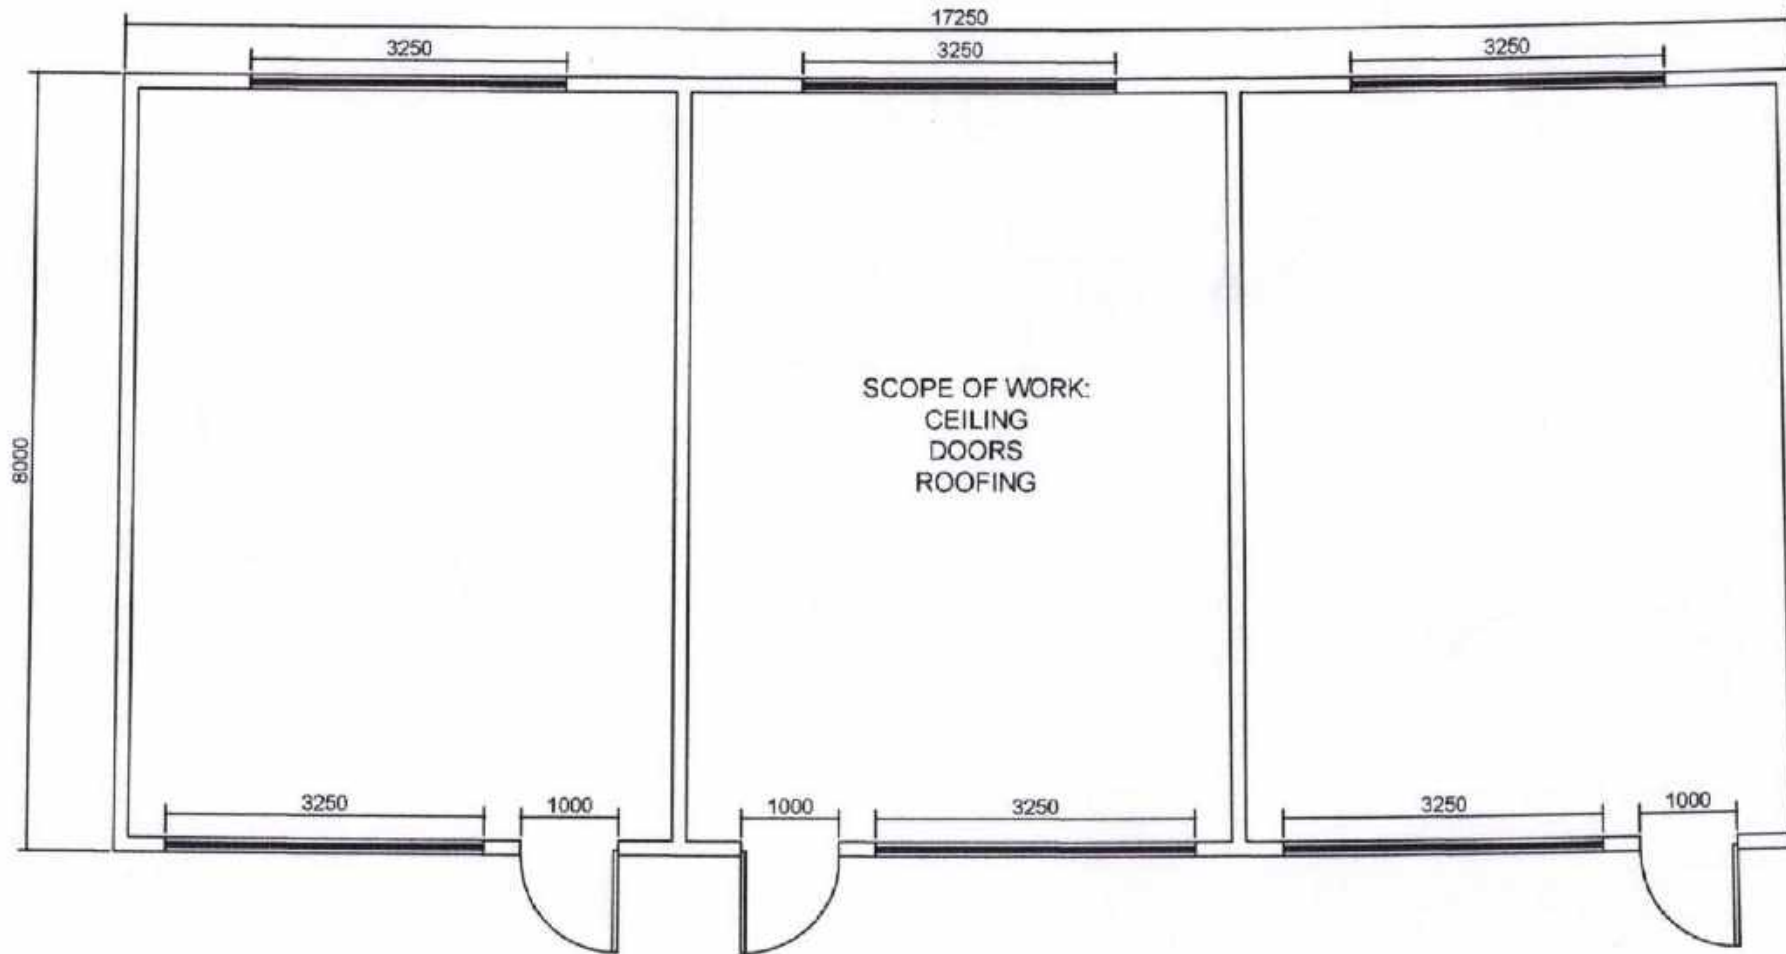

SORSOGON CITY  
CITY ENGINEER'S  
OFFICE

PROJECT TITLE

REPAIR/IMPROVEMENT OF MULTI-PURPOSE  
HALL (BLSB AND RP-US BLDG) SUGOD ES

LOCATION: BRGY. SUGOD, BACON DIST  
SORSOGON CITY

DRAWN BY:


RECOMMENDING APPROVAL

ROEL D. DOMER, CE  
CIC-CEO

APPROVED BY:

MA. ESTER E. HAMOR  
CITY MAYOR

PLEASE

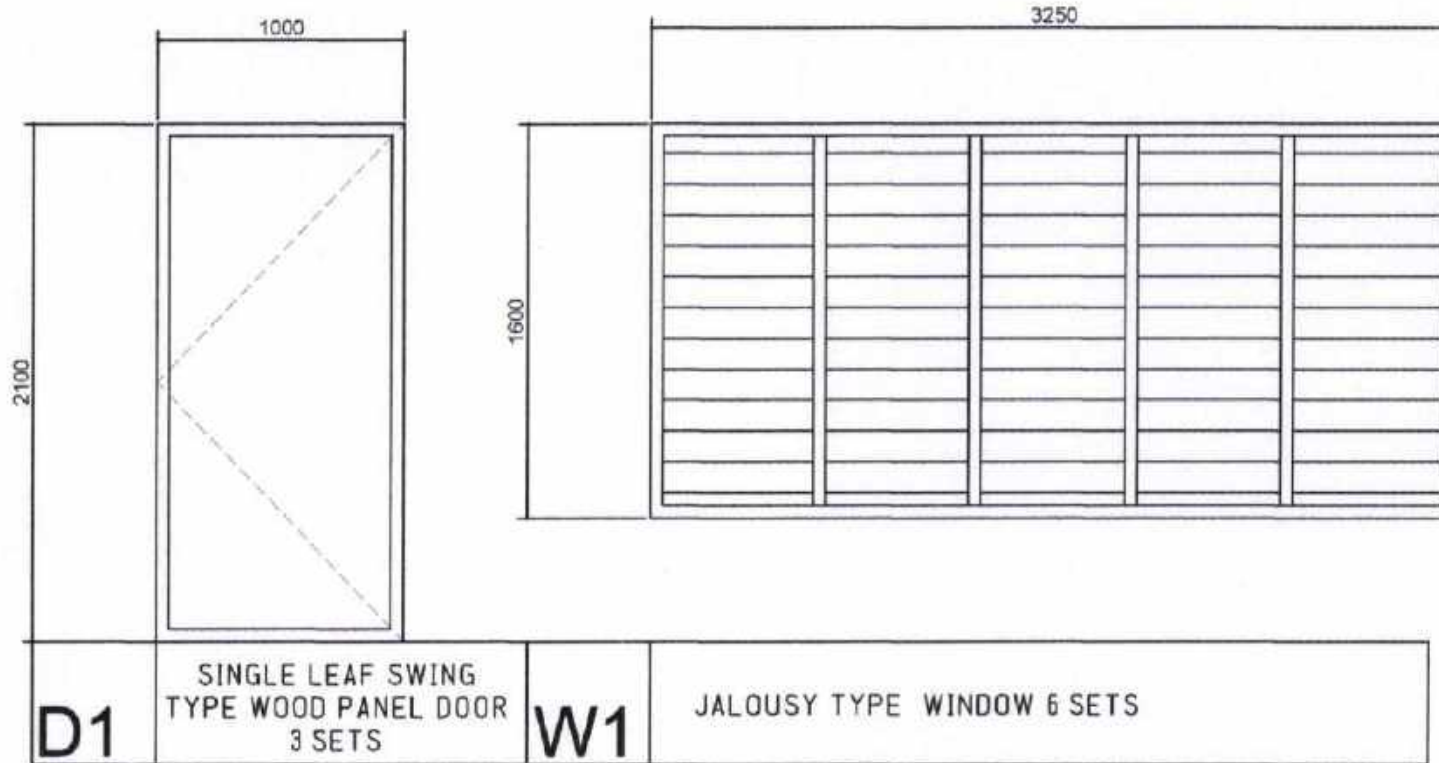

### DOOR & WINDOW SCHEDULE


SCALE: N T S




S O R S O G O N C I T Y  
**CITY ENGINEER'S  
O F F I C E**

PROJECT TITLE: REPAIR/IMPROVEMENT OF MULTI-PURPOSE HALL (BLSB AND RP-US BLDG) SUGOD ES.	DRAWN BY:	RECOMMENDING APPROVAL   ROEL D. DAMER, CE CIC-CEB	APPROVED BY:   MA. ESTER E. HAMOR CITY MAYOR
LOCATION: BRGY. SUGOD, BACON DIST SORSOGON CITY			


PLEASE S

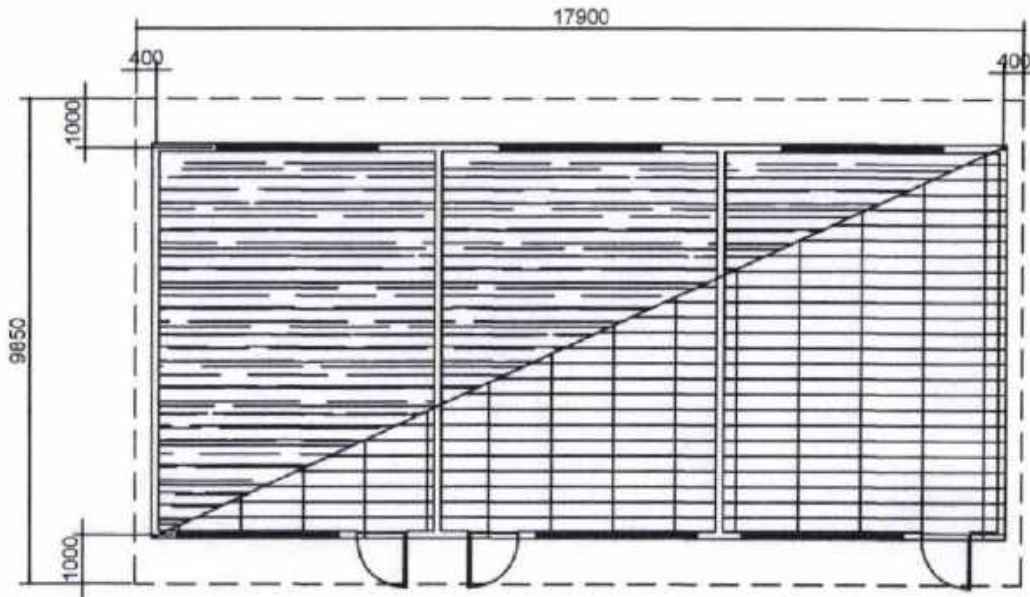

CEILING PLAN  
SCALE: N T S

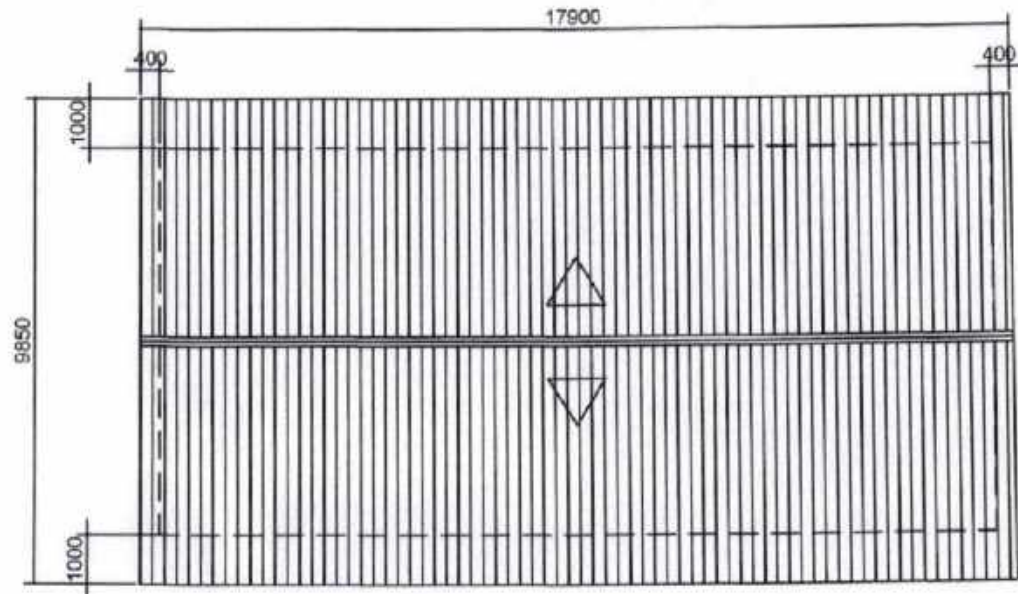


ROOF PLAN  
SCALE: N T S

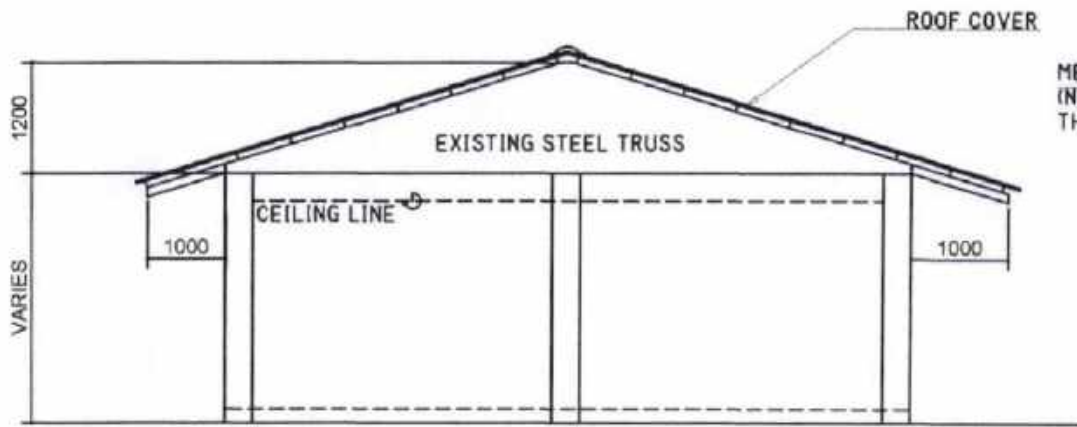

SIDE ELEVATION  
SCALE: N T S

METAL DOUBLE FURRING CHANNEL (NAILER) 12MM X 38MM X 5M X 0.8MM THK @ 1200MM O.C.

METAL CARRYING CHANNEL (CEILING JOIST) (NAILER) 12MM X 38MM X 5M X 0.8MM THK @ 400MM O.C.

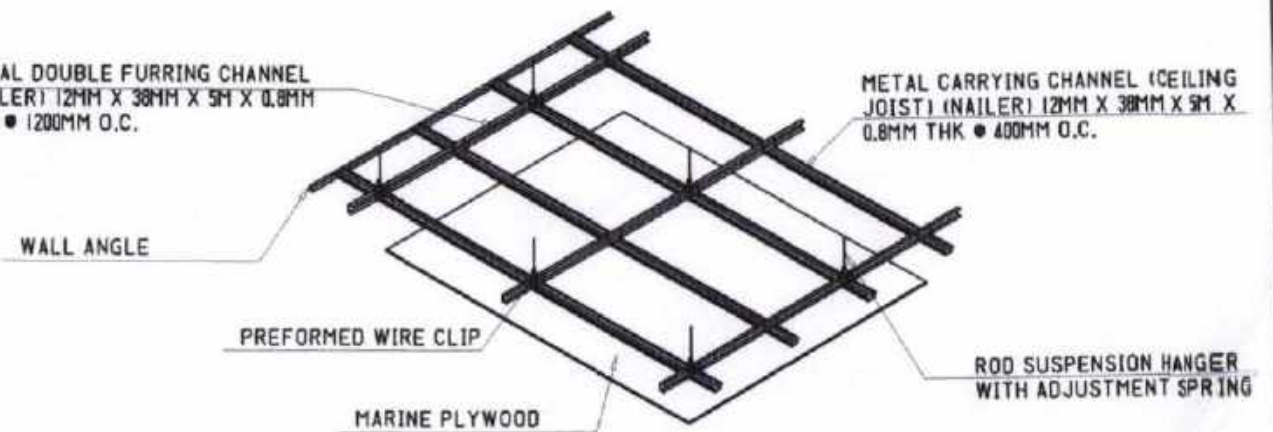


CEILING DET.  
SCALE: N T S




SORSOGON CITY  
CITY ENGINEER'S  
OFFICE

PROJECT TITLE:	DRAWN BY:	RECOMMENDING APPROVAL	APPROVED BY:
REPAIR/IMPROVEMENT OF MULTI-PURPOSE HALL (BL5B AND RP-US BLDG) SUGOD ES			
LOCATION: BRGY. SUGOD, BACON DIST SORSOGON CITY		ROEL S. DOMER, CE CIC-CEC	MA. ESTER E. RAMOR CITY MAYOR

PLEASE

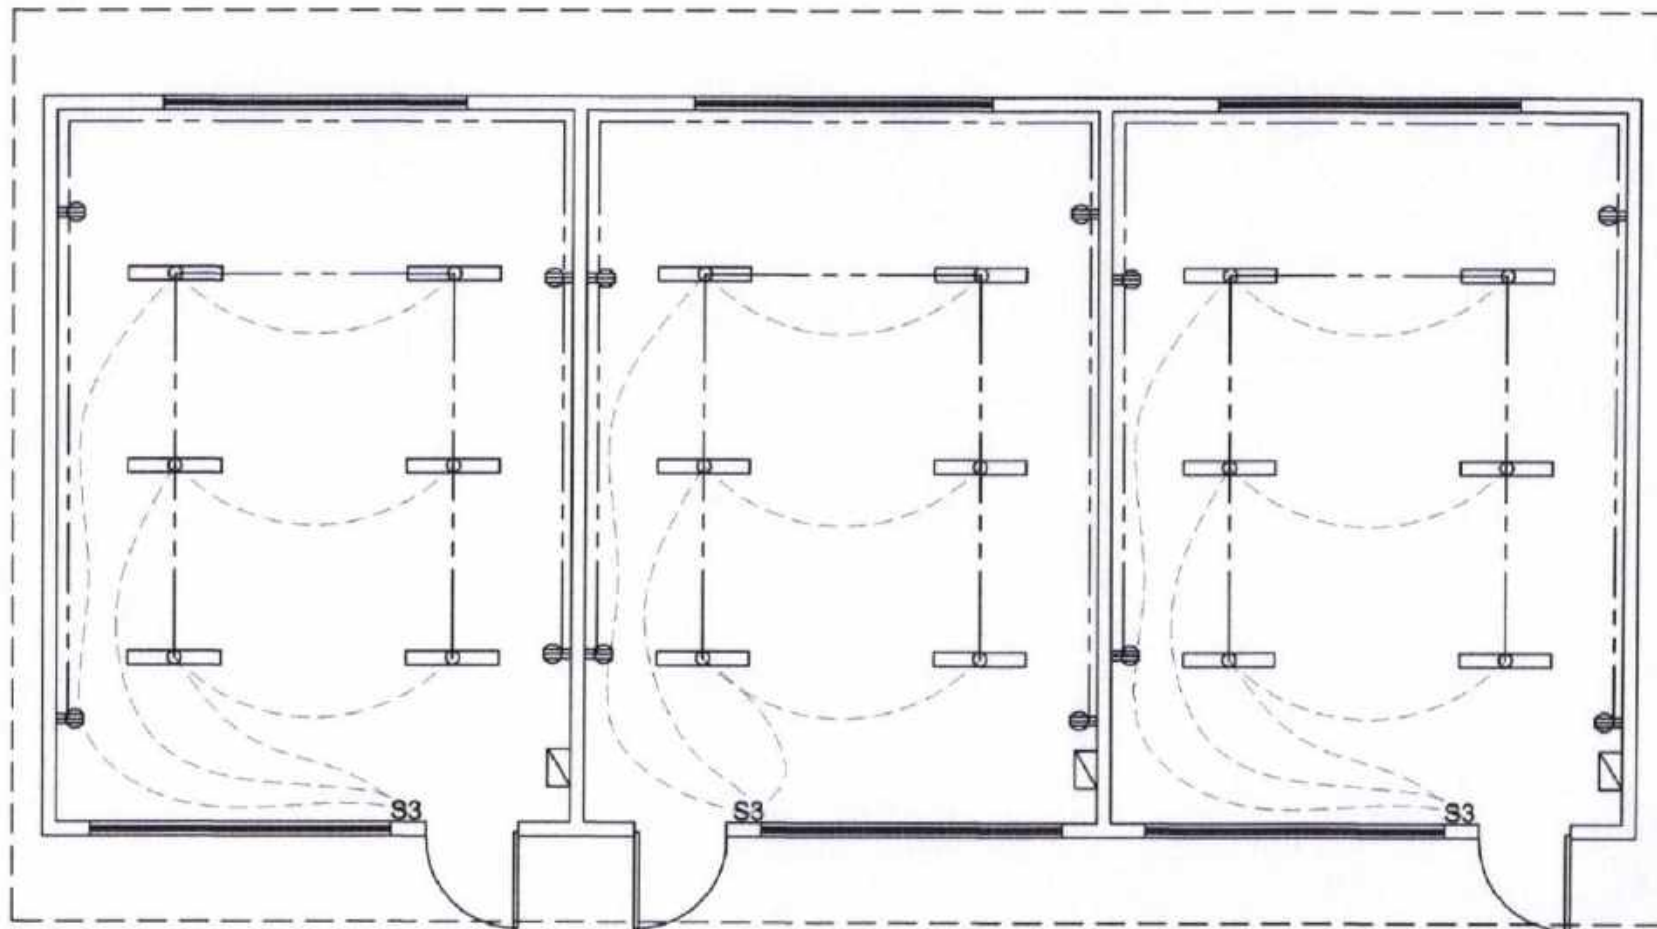



 **ELECTRICAL LAYOUT**  
SCALE: N T S



S O R S O G O N C I T Y


**CITY ENGINEER'S  
O F F I C E**

PROJECT TITLE	DRAWN BY:	RECOMMENDING APPROVAL	APPROVED BY:
REPAIR/IMPROVEMENT OF MULTI-PURPOSE HALL (BLSB AND RP-US BLDG) SUGOD ES			
LOCATION: BRGY. SUGOD, BACON DIST SORSOGON CITY			MA. ESTER E. HAMOR CITY MAYOR

PLEASE

**SUGOD ELEMENTARY SCHOOL**

**BLSB BUILDING (2UNITS)**

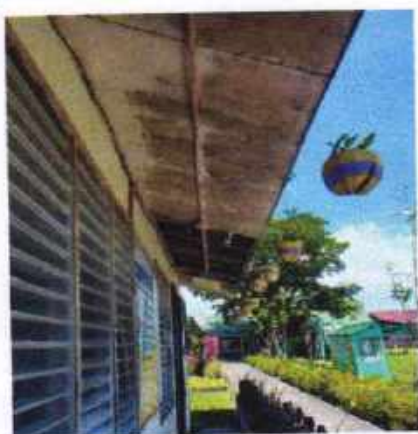


**SUGOD ELEMENTARY SCHOOL**

**RPUS BUILDING (3 UNITS)**



# LYDIA D. MARTINEZ MEMORIAL HIGH SCHOOL A3 BUILDING

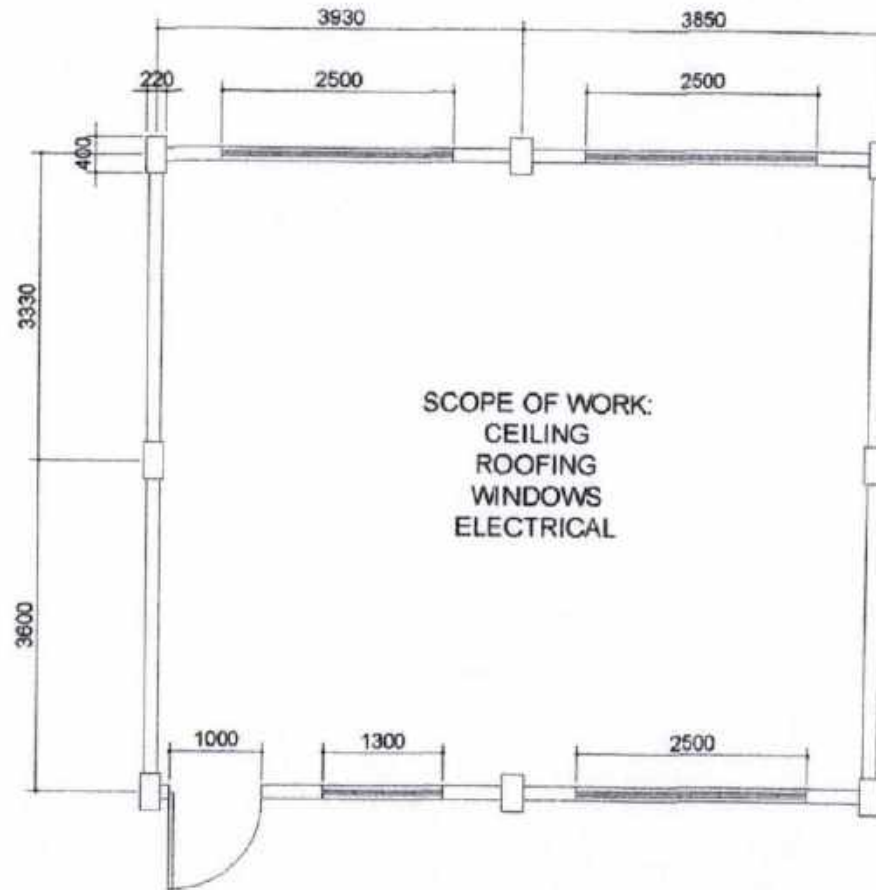

SORSOGON CITY

**CITY ENGINEER'S  
OFFICE**

PROJECT TITLE:

REPAIR/ IMPROVEMENT OF MULTI PURPOSE  
HALL (A3 & A4 BUILDING)

LOCATION: BRGY. SUGOD, BACON DISTRICT,  
SORSOGON CITY

DRAWN BY:


RECOMMENDING APPROVAL:

ROEL M. BOMERACE  
CIC-REG.


APPROVED BY:


MA. ESTER E. HAMOR  
CITY MAYOR

PLEASE S

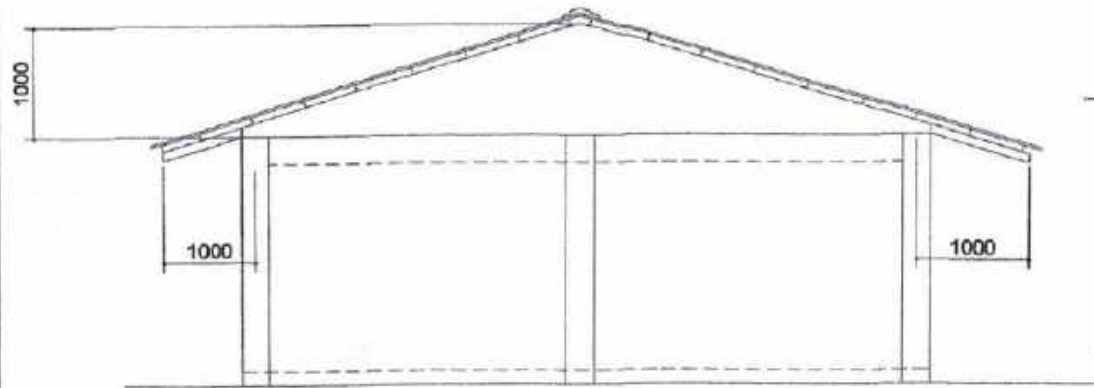


**S I D E E L E V A T I O N**  
 SCALE: N T S

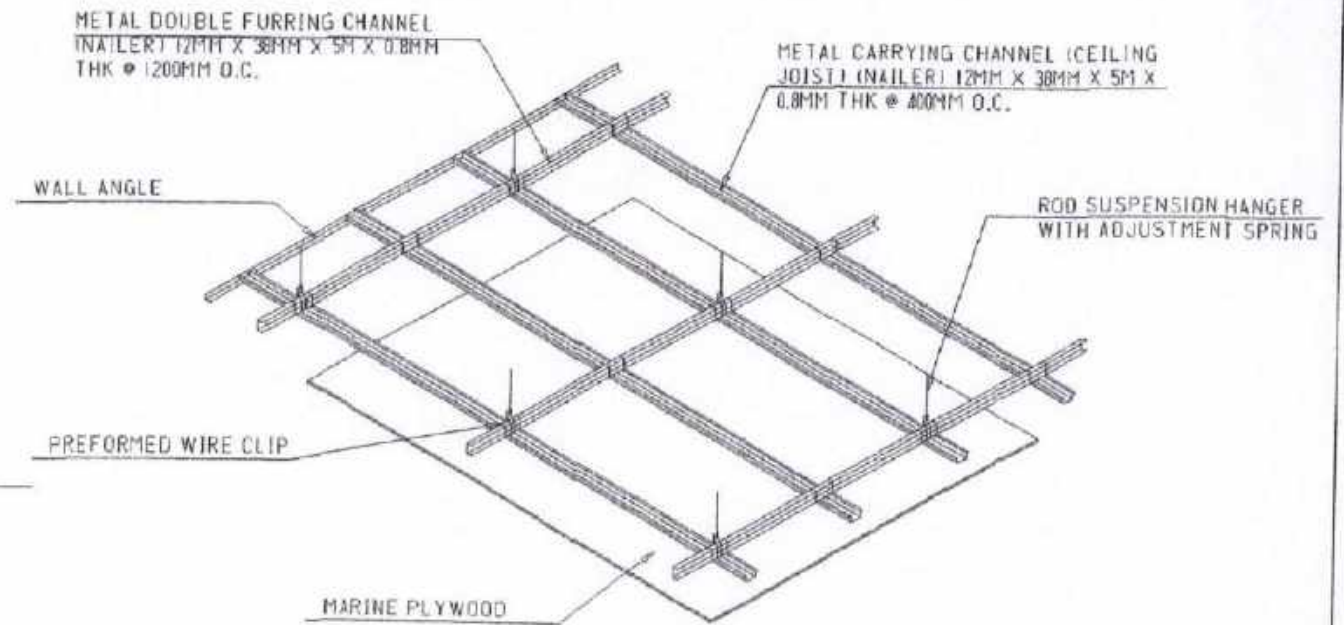


**C E I L I N G D E T .**  
 SCALE: N T S




SORSOGON CITY  
**CITY ENGINEER'S  
 O F F I C E**


PROJECT TITLE:  
 REPAIR/ IMPROVEMENT OF MULTI PURPOSE  
 HALL (A3 & A4 BUILDING) LDMMS  
 LOCATION: BRGY. SUGOD, BACON DISTRICT,  
 SORSOGON CITY

DRAWN BY:

RECOMMENDING APPROVAL:


  
 ROEL D. DAMER, CE  
 CEC-CEO

APPROVED BY:

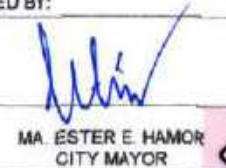  
 MA. ESTER E. HAMOR  
 CITY MAYOR

PLEASE SIGN



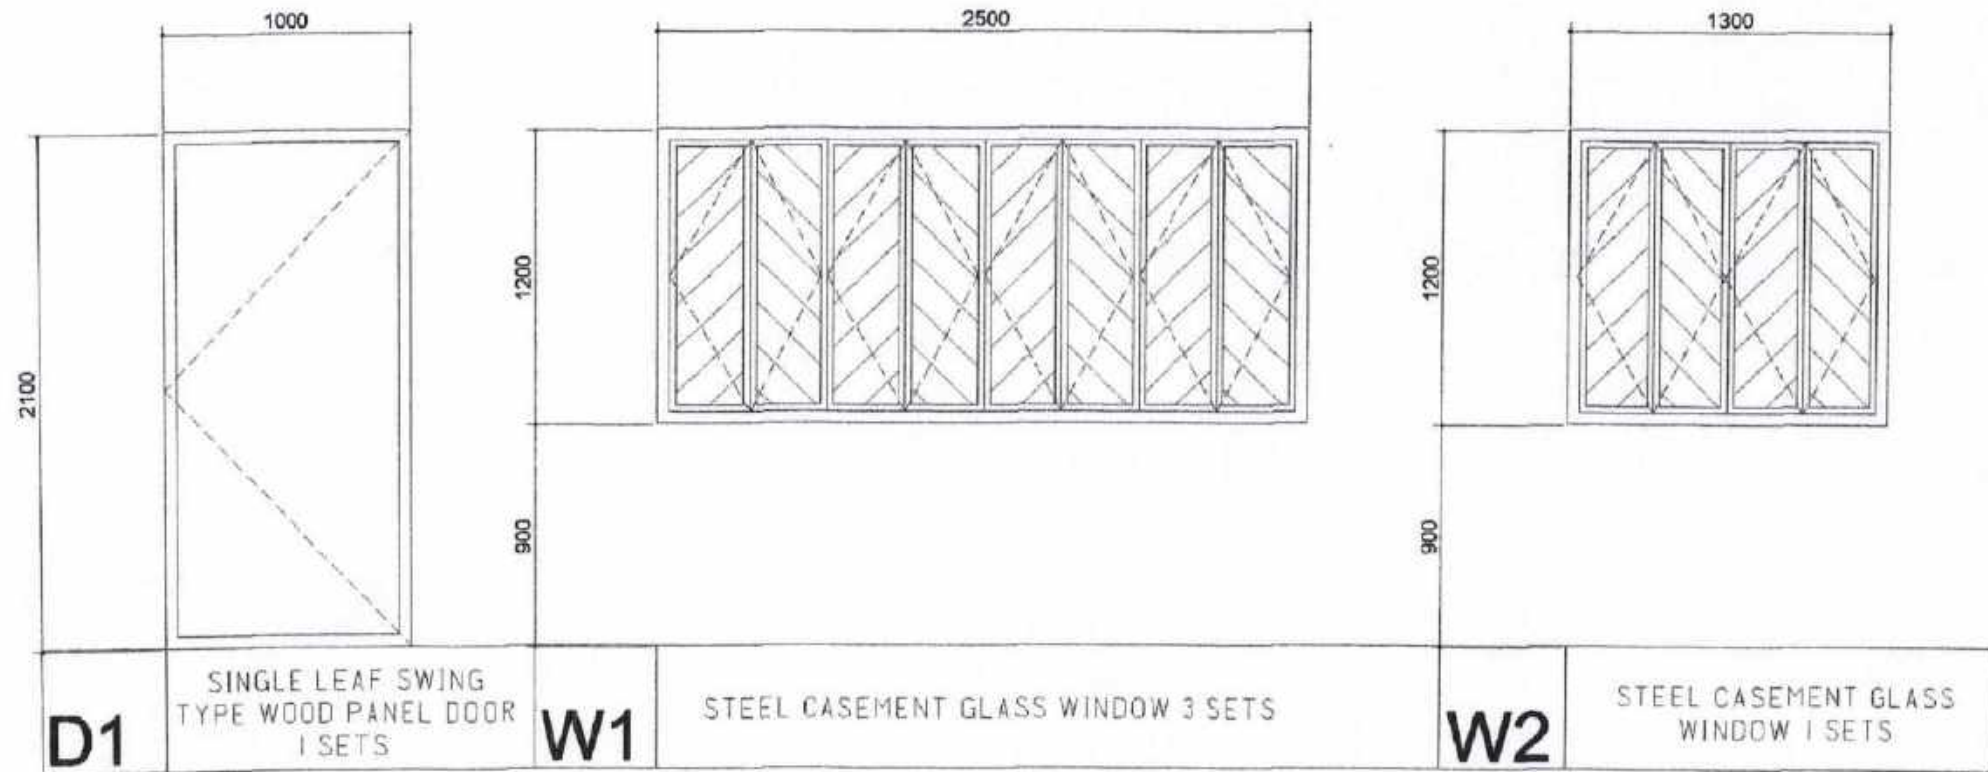



**DOORS & WINDOWS SCHEDULE**  
SCALE: N T S



SORSOGON CITY  
**CITY ENGINEER'S  
OFFICE**

PROJECT TITLE:	DRAWN BY:	RECOMMENDING APPROVAL:	APPROVED BY:
REPAIR/ IMPROVEMENT OF MULTI PURPOSE HALL (A3 & A4 BUILDING) LDMMHS			
LOCATION: BRGY. SUGOD, BACON DISTRICT, SORSOGON CITY		NOEL D. BOMER, CE OIC-CEO	MA. ESTER E. HAMOR CITY MAYOR

PLEASE

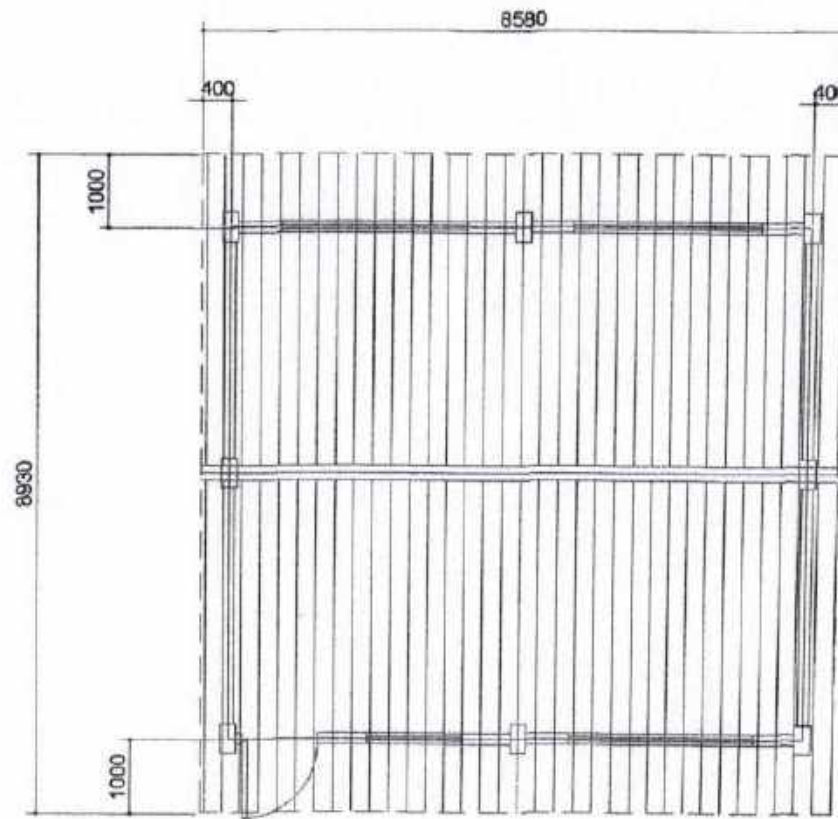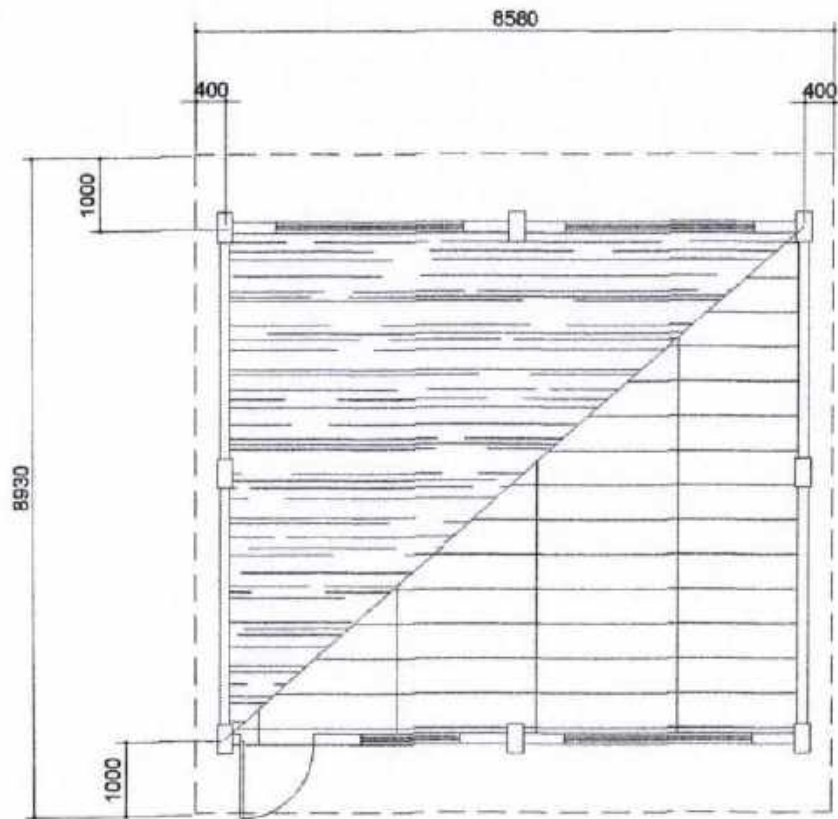

○ CEILING PLAN  
SCALE: N T S

○ ROOF PLAN  
SCALE: N T S



SORSOGON CITY  
CITY ENGINEER'S  
OFFICE

PROJECT TITLE:  
REPAIR/ IMPROVEMENT OF MULTI PURPOSE  
HALL (A3 & A4 BUILDING) LDMMS  
LOCATION: BRGY. SUGOD, BACON DISTRICT,  
SORSOGON CITY

DRAWN BY:

RECOMMENDING APPROVAL:

APPROVED BY:

*[Signature]*  
ROEL B. DOMER, CE  
CIC-CEO

*[Signature]*  
MA. ESTER E. HAMOR  
CITY MAYOR

PLEASE STIC

## ELECTRICAL NOTES


ALL ELECTRICAL WORKS SHALL BE DONE IN ACCORDANCE WITH THE LATEST RULES AND REGULATIONS OF THE PHIL. ELECTRICAL CODE AS WELL AS THE LOCAL AUTHORITY CONCERNED AND THE LOCAL POWER COMPANY.

ALL ELECTRICAL MATERIALS TO BE USED SHALL BE NEED & APPROVED TYPE FOR LOCATION & PURPOSE

MOUNTING HEIGHTS SHALL BE AS FOLLOWS:

- a. LIGHT CONTROL SWITCH- 1.35M ABOVE FIN. FLR. LINE AT CENTER
- b. CONVENIENCE OUTLET-ABOVE 1.0M ABOVE FIN. FLR. LINE AT CENTER
- c. PANEL BOARD- 2.0 M ABOVE FIN. FLR. LINE

ALL ELECTRICAL WORKS SHALL BE UNDER THE DIRECT & IMMEDIATE SUPERVISION OF A DULY LICENSED ELECTRICAL ENGINEER OR REGISTERED MASTER ELECTRICIAN

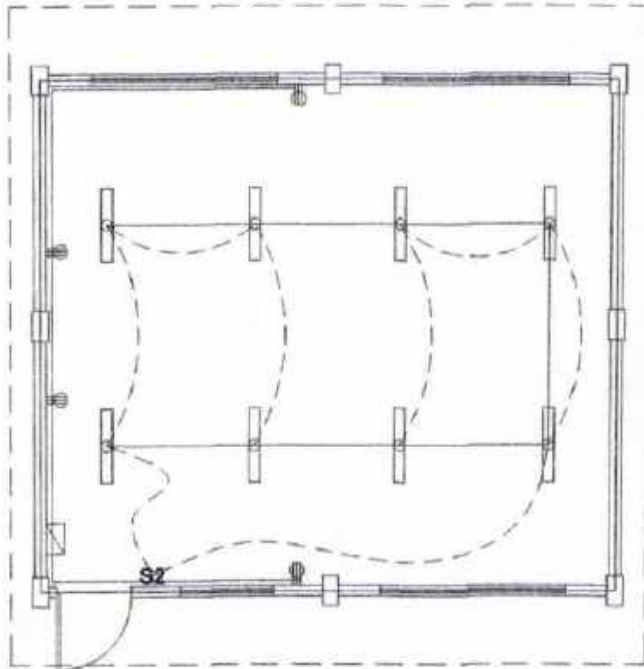

### SCHEDULE OF LOADS

CIRCUIT NO.	DESCRIPTION	NO. OF LOADS	VOLTS	WATTS	AMP	SIZE OF WIRE	SIZE OF CONDUIT
1	LIGHTING OUTLET	8	230	800	3.47	2-2.0mm <sup>2</sup> THW	15mm $\varnothing$
2	CONVENIENCE OUTLET	4	230	720	3.13	2-3.5mm <sup>2</sup> THW	20mm $\varnothing$
	TOTAL	12		1520	6.6		

TOTAL VA = 1520 VA

IT = 1520 VA ( 100 % ) DF  
230 V  
=6.60 A

## ELECTRICAL LAYOUT

SCALE

N T S

SORSOGON CITY

CITY ENGINEER'S  
OFFICE

PROJECT TITLE:

REPAIR/ IMPROVEMENT OF MULTI PURPOSE  
HALL (A3 & A4 BUILDING) LDMHHS

LOCATION: BRGY. SUGOD, BACON DISTRICT,  
SORSOGON CITY

DRAWN BY:

RECOMMENDING APPROVAL:


NOEL D. DOMER, CE  
OIC-DEO

APPROVED BY:

MA. ESTER E. HAMOR  
CITY MAYOR

PLEASE


# LYDIA D. MARTINEZ MEMORIAL HIGH SCHOOL A4 BUILDING

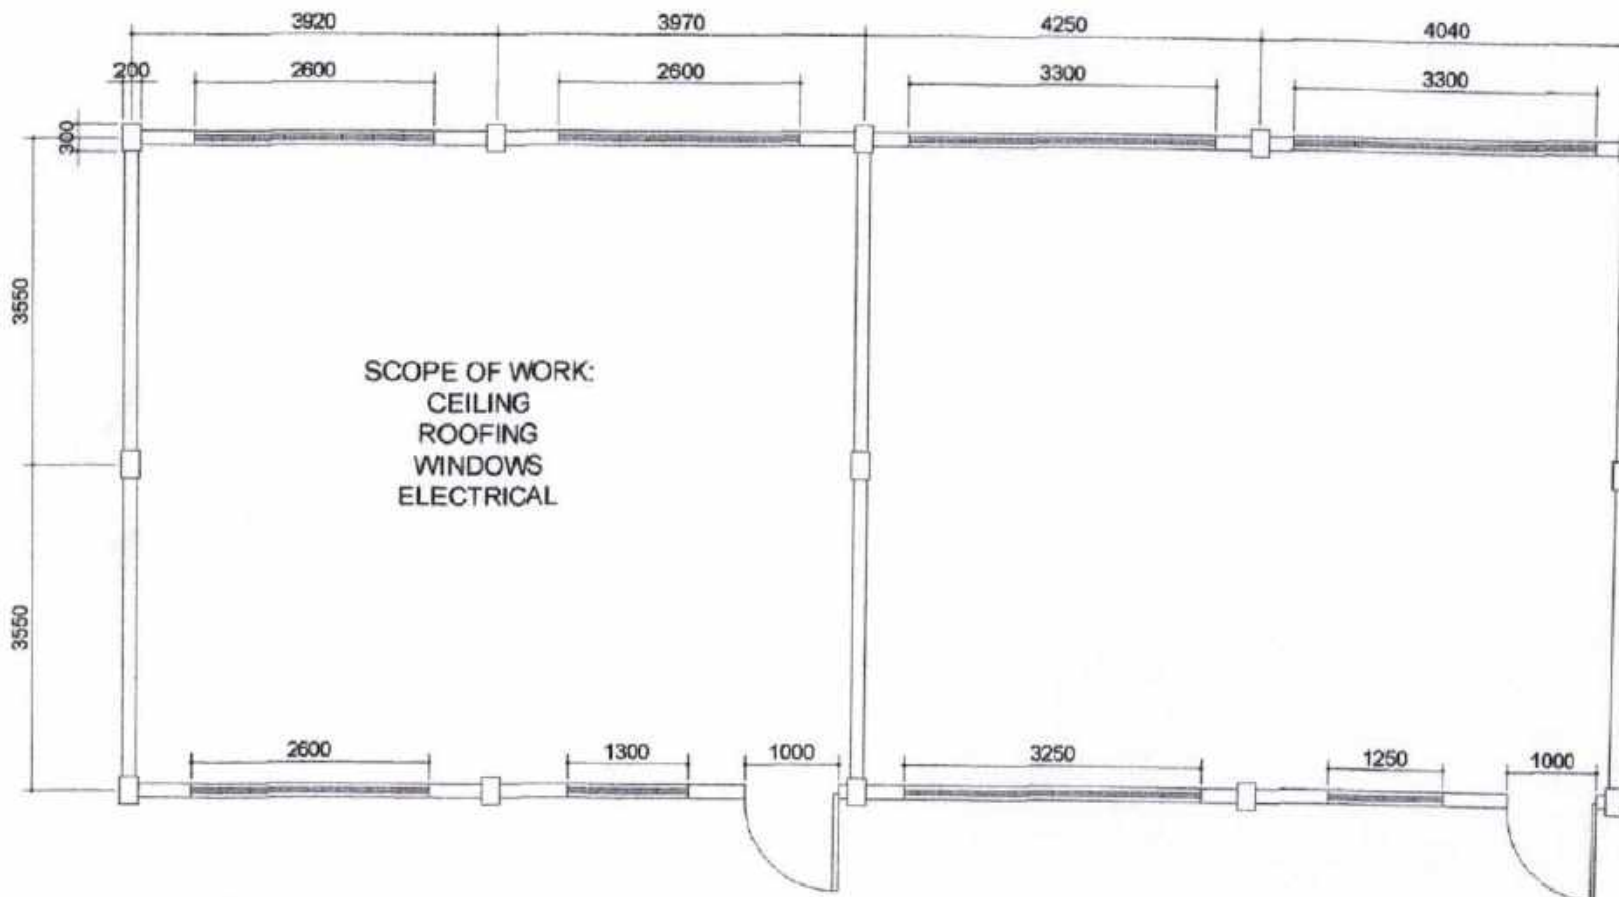

SORSOGON CITY  
CITY ENGINEER'S  
OFFICE

PROJECT TITLE	DRAWN BY:	RECOMMENDING APPROVAL:	APPROVED BY:
REPAIR/ IMPROVEMENT OF MULTI PURPOSE HALL. (A3 & A4 BUILDING)			
LOCATION: BRGY. SUGOD, BACON DISTRICT, SORSOGON CITY		ROEL D. DIMER, CE OIC-CEO	MA. ESTER E. HAMOR CITY MAYOR

PLEASE

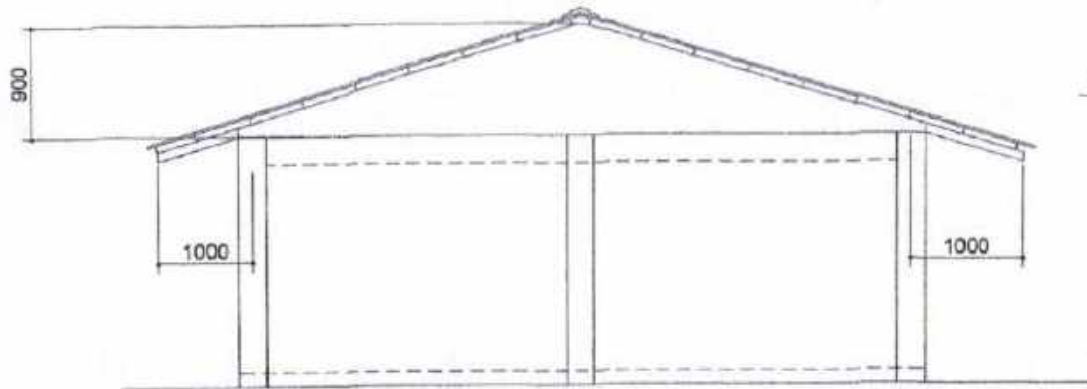

○ SIDE ELEVATION  
SCALE: N T S

METAL DOUBLE FURRING CHANNEL  
(NAILER) 12MM X 38MM X 5M X 0.8MM  
THK @ 1200MM O.C.

METAL CARRYING CHANNEL (CEILING  
JOIST) (NAILER) 12MM X 38MM X 5M X  
0.8MM THK @ 400MM O.C.

WALL ANGLE

ROD SUSPENSION HANGER  
WITH ADJUSTMENT SPRING

PREFORMED WIRE CLIP

MARINE PLYWOOD

○ CEILING DET.  
SCALE: N T S

SORSOGON CITY

CITY ENGINEER'S  
OFFICE

PROJECT TITLE:

REPAIR/ IMPROVEMENT OF MULTI PURPOSE  
HALL (A3 & A4 BUILDING)

LOCATION: BRGY. SUGOD, BACON DISTRICT,  
SORSOGON CITY

DRAWN BY:

RECOMMENDING APPROVAL:

ROEL D. SUMER, CE  
OIC-CEO


APPROVED BY:

MA. ESTER E. HAMOR  
CITY MAYOR


PLEASE



<b>D1</b>	SINGLE LEAF SWING TYPE WOOD PANEL DOOR 5 SETS	<b>W1</b>	JALOUSY TYPE GLASS WINDOW 2 SETS	<b>W2</b>	JALOUSY TYPE GLASS WINDOW 2 SETS
-----------	---	-----------	----------------------------------	-----------	----------------------------------

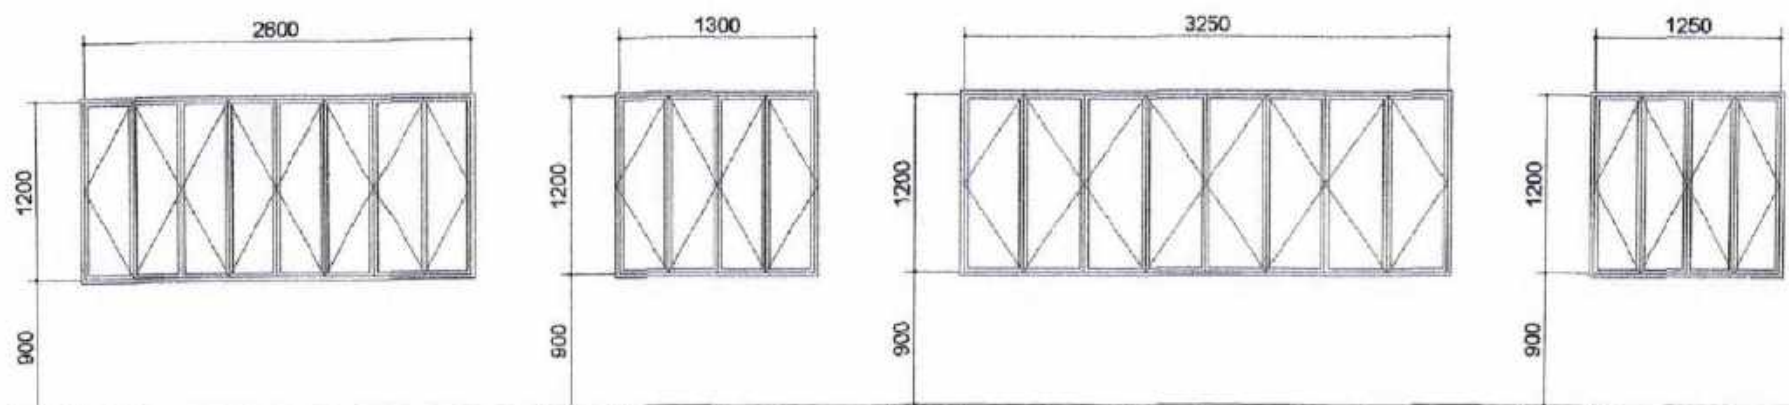

<b>W3</b>	STEEL CASEMENT GLASS WINDOW (GLASS REPLACEMENT ONLY)	<b>W4</b>	STEEL CASEMENT GLASS WINDOW (GLASS REPLACEMENT ONLY)	<b>W5</b>	STEEL CASEMENT GLASS WINDOW (GLASS REPLACEMENT ONLY)	<b>W6</b>	STEEL CASEMENT GLASS WINDOW (GLASS REPLACEMENT ONLY)
-----------	--	-----------	--	-----------	--	-----------	--




**DOORS & WINDOWS SCHEDULE**  
 SCALE: N T S



SORSOGON CITY  
**CITY ENGINEER'S  
 OFFICE**

PROJECT TITLE:	DRAWN BY:	RECOMMENDING APPROVAL:	APPROVED BY:
REPAIR/ IMPROVEMENT OF MULTI PURPOSE HALL (A3 & A4 BUILDING)			
LOCATION: BRGY. SUGOD, BACON DISTRICT, SORSOGON CITY		ROEL D. DOMER, CE OIC-CEC	MA. ESTER E. HAMOR CITY MAYOR

PLEASE SIGN

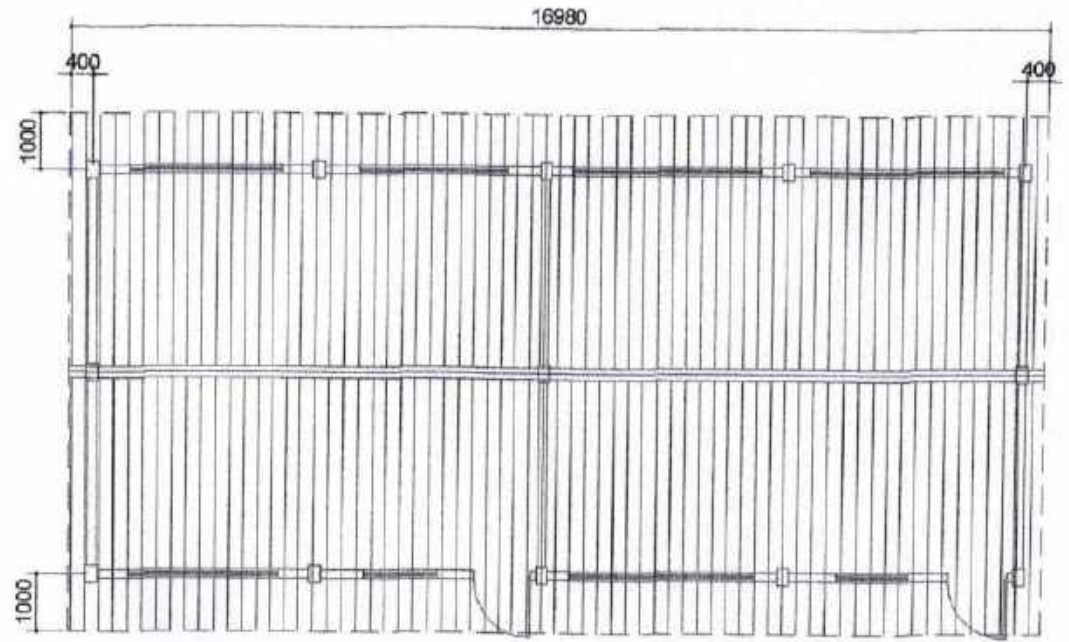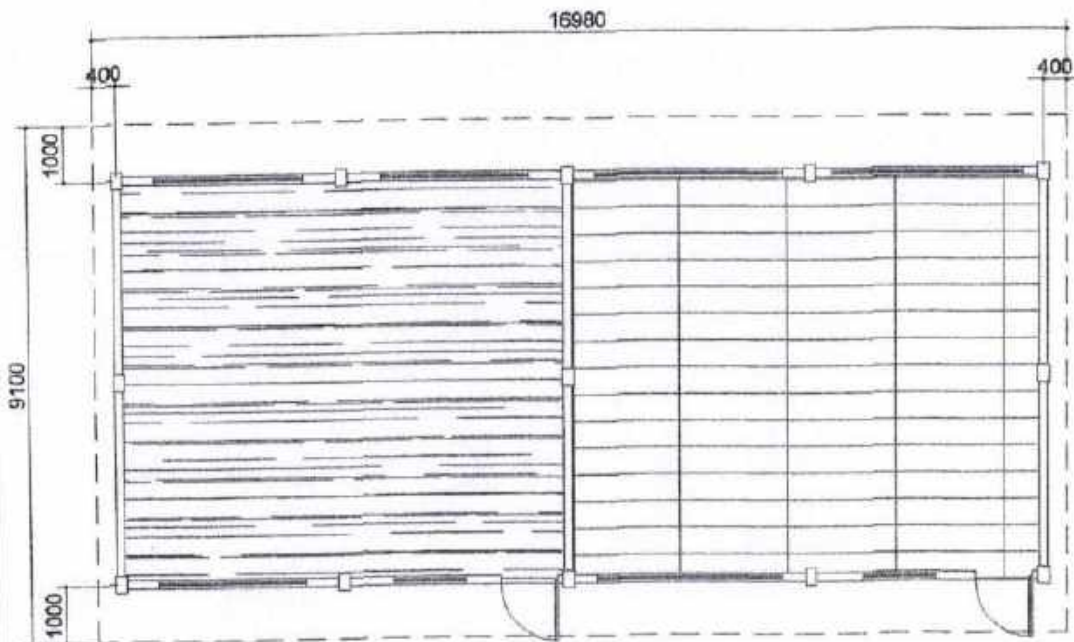

○ C E I L I N G P L A N  
SCALE: N T S

○ R O O F P L A N  
SCALE: N T S



SORSOGON CITY  
CITY ENGINEER'S  
O F F I C E

PROJECT TITLE:  
REPAIR/ IMPROVEMENT OF MULTI PURPOSE  
HALL (A3 & A4 BUILDING)  
LOCATION: BRGY. SUGOD, BACON DISTRICT,  
SORSOGON CITY

DRAWN BY:

RECOMMENDING APPROVAL:

APPROVED BY:

*[Signature]*  
ROEL D. DOMER, CE  
OIC-CEO

*[Signature]*  
MA. ESTER E. HAMOR  
CITY MAYOR

PLEASE SIGN


# ELECTRICAL NOTES

ALL ELECTRICAL WORKS SHALL BE DONE IN ACCORDANCE WITH THE LATEST RULES AND REGULATIONS OF THE PHIL. ELECTRICAL CODE AS WELL AS THE LOCAL AUTHORITY CONCERNED AND THE LOCAL POWER COMPANY.

ALL ELECTRICAL MATERIALS TO BE USED SHALL BE NEED & APPROVED TYPE FOR LOCATION & PURPOSE

- MOUNTING HEIGHTS SHALL BE AS FOLLOWS:
- a. LIGHT CONTROL SWITCH- 1.35M ABOVE FIN. FLR. LINE AT CENTER
  - b. CONVENIENCE OUTLET-ABOVE 1.0M ABOVE FIN. FLR. LINE AT CENTER
  - c. PANEL BOARD- 2.0 M ABOVE FIN. FLR. LINE

ALL ELECTRICAL WORKS SHALL BE UNDER THE DIRECT & IMMEDIATE SUPERVISION OF A DULY LICENSED ELECTRICAL ENGINEER OR REGISTERED MASTER ELECTRICIAN

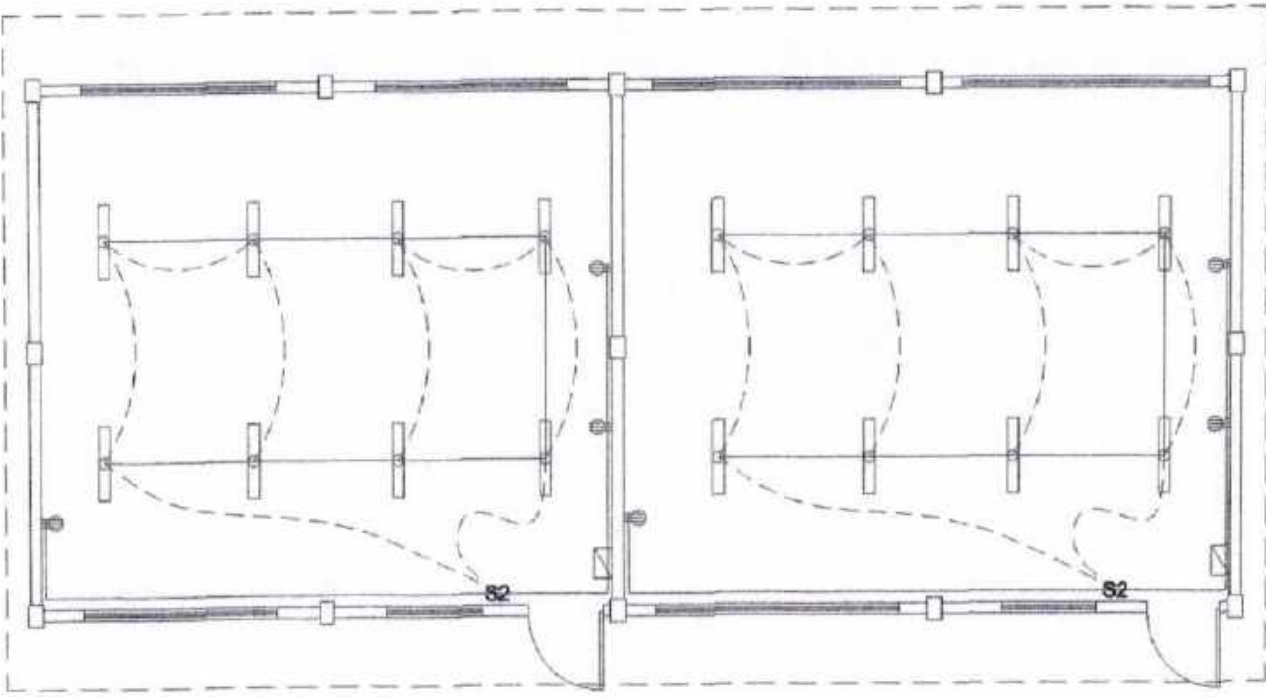

## SCHEDULE OF LOADS

CIRCUIT NO.	DESCRIPTION	NO. OF LOADS	VOLTS	WATTS	AMP	SIZE OF WIRE	SIZE OF CONDUIT
1	LIGHTING OUTLET	8	230	800	3.47	2-2.0mm <sup>2</sup> THW	15mm $\varnothing$
2	CONVENIENCE OUTLET	3	230	540	2.34	2-3.5mm <sup>2</sup> THW	20mm $\varnothing$
	<b>TOTAL</b>	<b>11</b>		<b>1340</b>	<b>5.81</b>		

TOTAL VA = 1340 VA

IT = 1340 VA ( 100 % ) DF  
 $\frac{1340}{230 V}$   
 =5.81 A

## ELECTRICAL LAYOUT

SCALE:

N T S



SORSOGON CITY  
**CITY ENGINEER'S  
 OFFICE**

PROJECT TITLE:  
 REPAIR/ IMPROVEMENT OF MULTI PURPOSE HALL (A3 & A4 BUILDING)  
 LOCATION: BRGY. SUGOD, BACON DISTRICT, SORSOGON CITY

DRAWN BY:

RECOMMENDING APPROVAL:

*[Signature]*  
 ROCEL D. DOMER, CE  
 OIC-CEO

APPROVED BY:

*[Signature]*  
 MA. ESTER E. HAMOR  
 CITY MAYOR

PLEASE SIGN



LYDIA D. MARTINEZ MEMORIAL HIGH SCHOOL

A3 BUILDING




LYDIA D. MARTINEZ MEMORIAL HIGH SCHOOL

A4 BUILDING



**BUENAVISTA ELEM. SCHOOL  
ACADEMIC BUILDING**

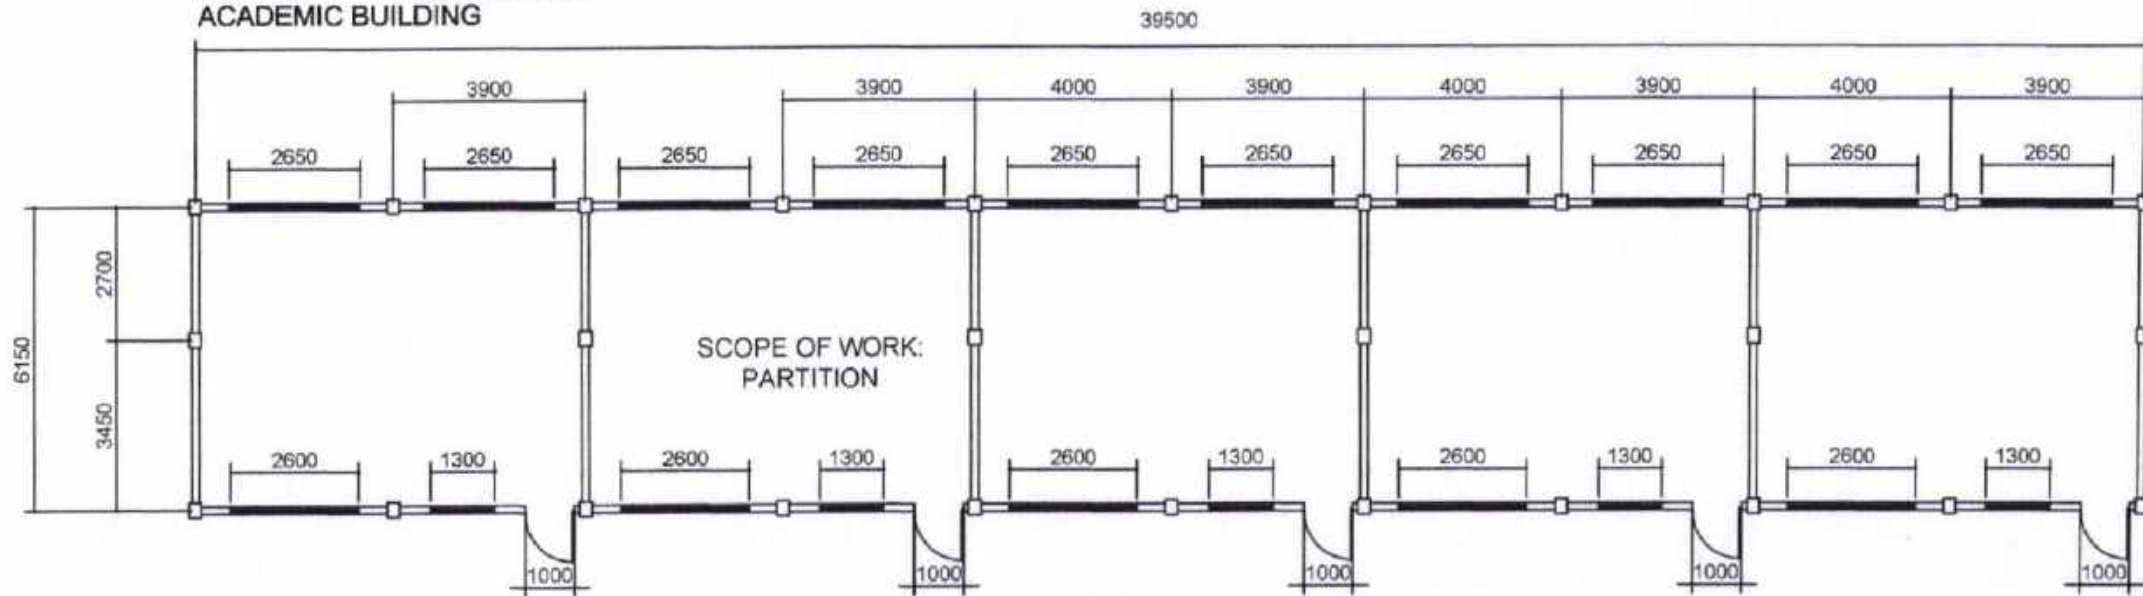

SORSOGON CITY

**CITY ENGINEER'S  
OFFICE**

PROJECT TITLE:

REPAIR/IMPROVEMENT OF MULTI-PURPOSE  
HALL (ACADEMIC BLDG) BUENAVISTA ES

LOCATION: BRGY. BUENAVISTA, BACON DIST  
SORSOGON CITY

DRAWN BY:


NOTED BY:

*[Signature]*  
ROSEL D. ROMER, CE  
CIC/CEO

APPROVED BY:

*[Signature]*  
MA. ESTER E. HAMOR  
CITY MAYOR

PLEASE SIGN

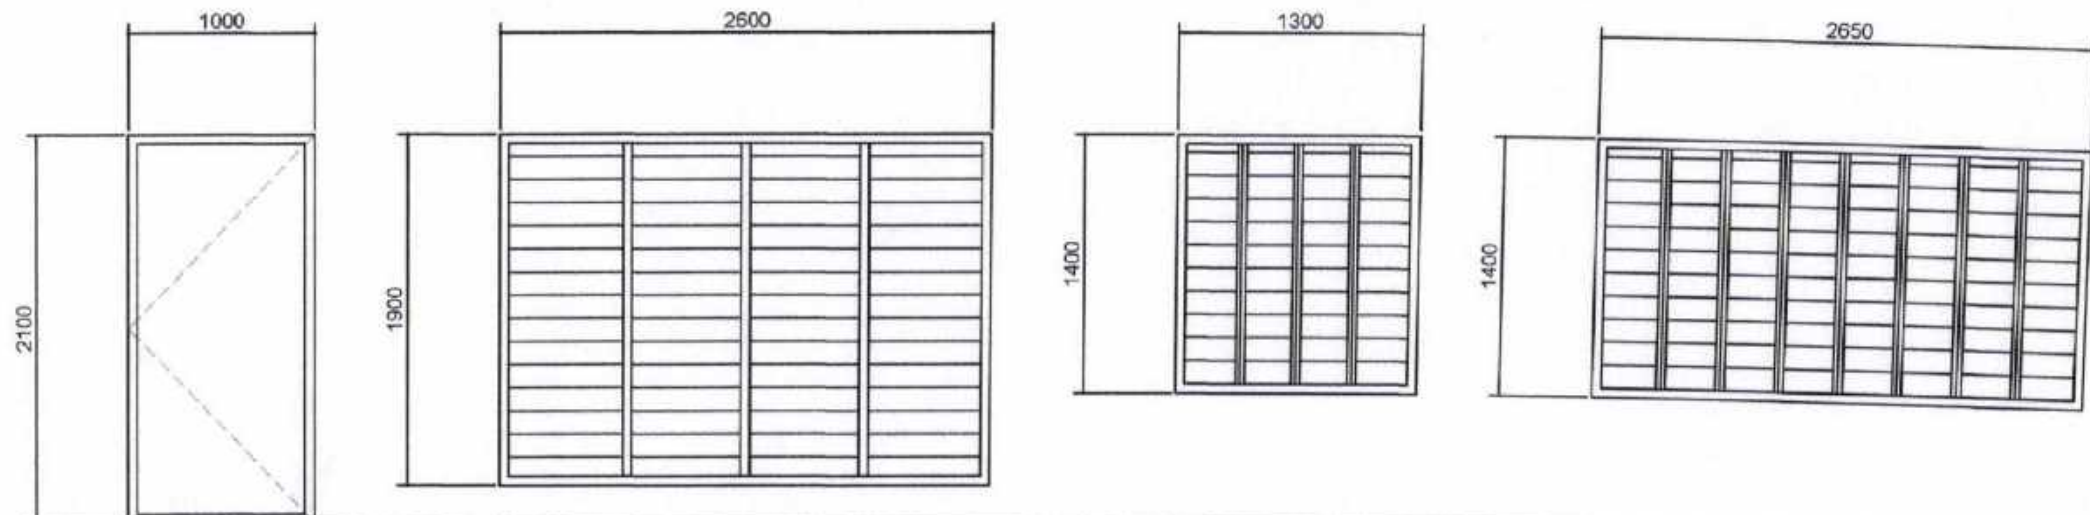


<b>D1</b>	SINGLE LEAF SWING TYPE WOOD PANEL DOOR 5 SETS	<b>W1</b>	JALOUSY TYPE GLASS WINDOW 10 SETS	<b>W2</b>	JALOUSY TYPE GLASS WINDOW 5 SETS	<b>W3</b>	JALOUSY TYPE GLASS WINDOW 5 SETS
-----------	---	-----------	-----------------------------------	-----------	-------------------------------------	-----------	----------------------------------




SORSOGON CITY  
CITY ENGINEER'S  
OFFICE

PROJECT TITLE: REPAIR/IMPROVEMENT OF MULTI-PURPOSE HALL (ACADEMIC BLDG) BUENAVISTA ES	DRAWN BY:	NOTED BY:	APPROVED BY:
LOCATION: BRGY. BUENAVISTA, BACON DIST SORSOGON CITY		JOEL D. DOMER, CE CIC-CEO	MA. ESTER E. HAMOR CITY MAYOR

PLEASE SIGN HERE

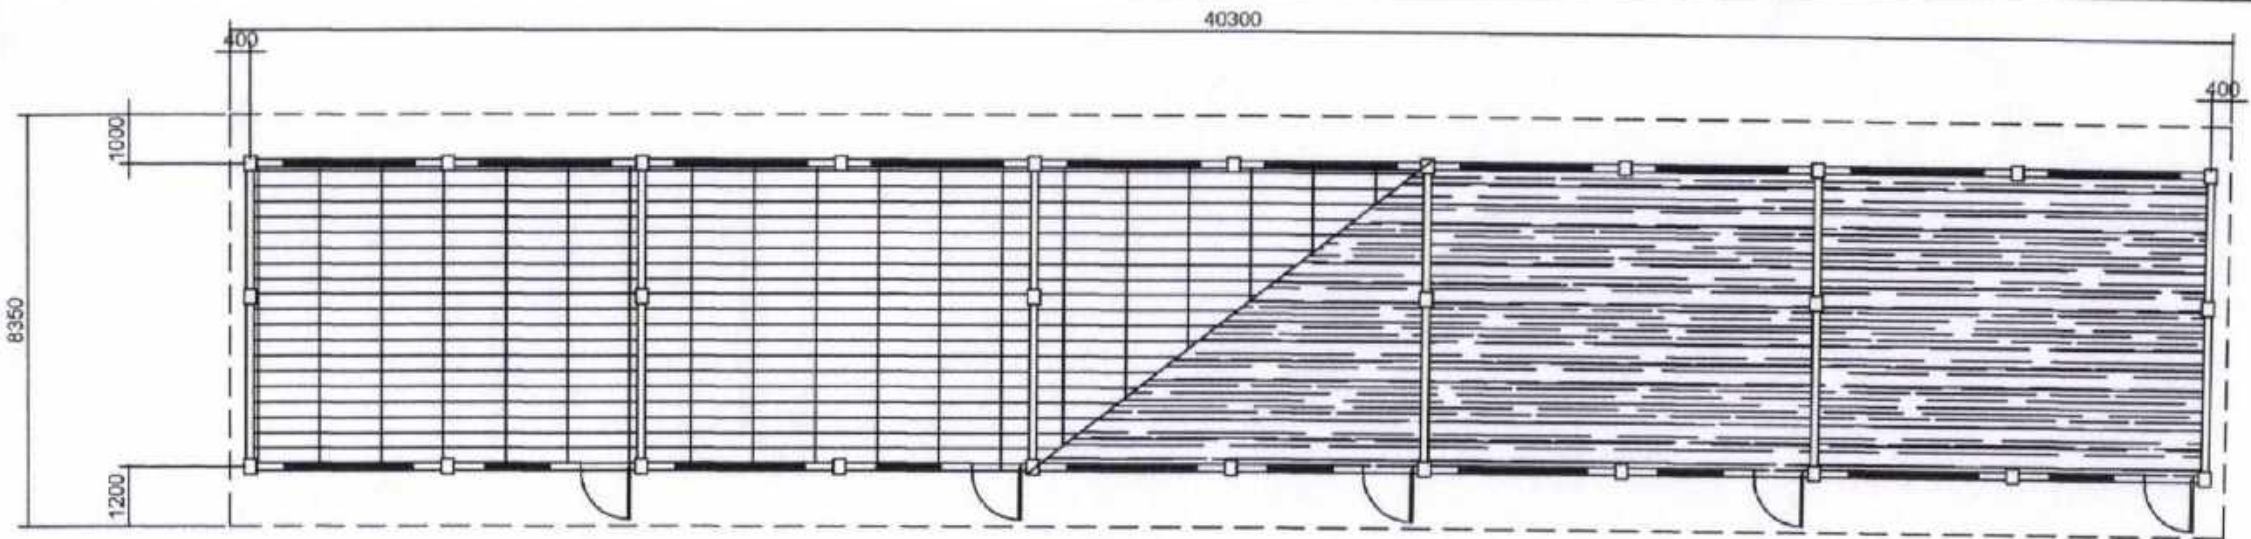

○ C E I L I N G P L A N  
SCALE: 40300 N T S

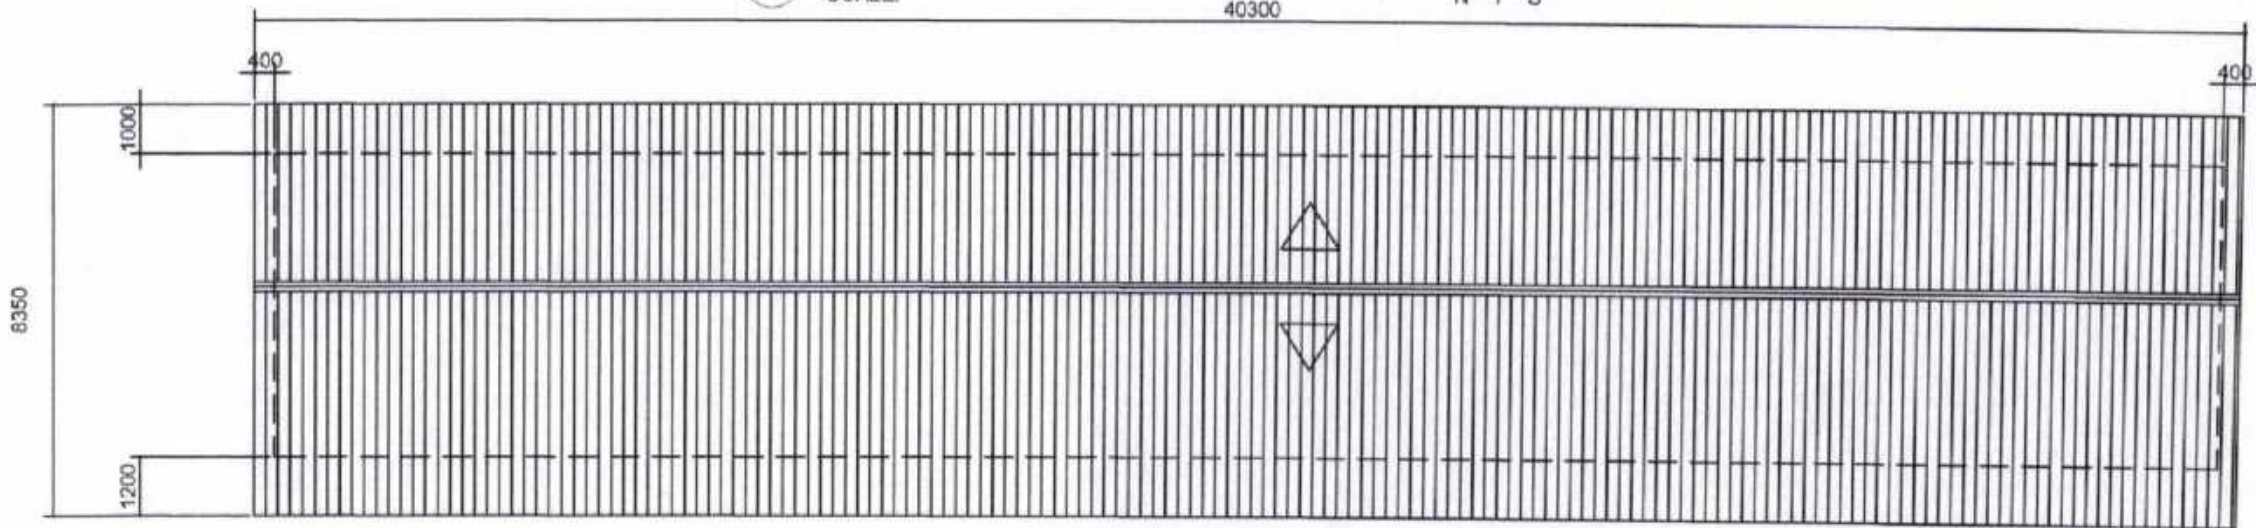

○ R O O F P L A N  
SCALE: 40300 N T S




SORSOGON CITY  
CITY ENGINEER'S  
O F F I C E


PROJECT TITLE:	DRAWN BY:	NOTED BY:	APPROVED BY:
REPAIR/IMPROVEMENT OF MULTI-PURPOSE HALL (ACADEMIC BLDG) BUENAVISTA ES			
LOCATION: BRGY. BUENAVISTA, BACON DIST SORSOGON CITY		WILL D. BOMER, CE OIC-CEO	MA. ESTER E. HAMOR CITY MAYOR

PLEASE SIGN


MARINE PLYWOOD

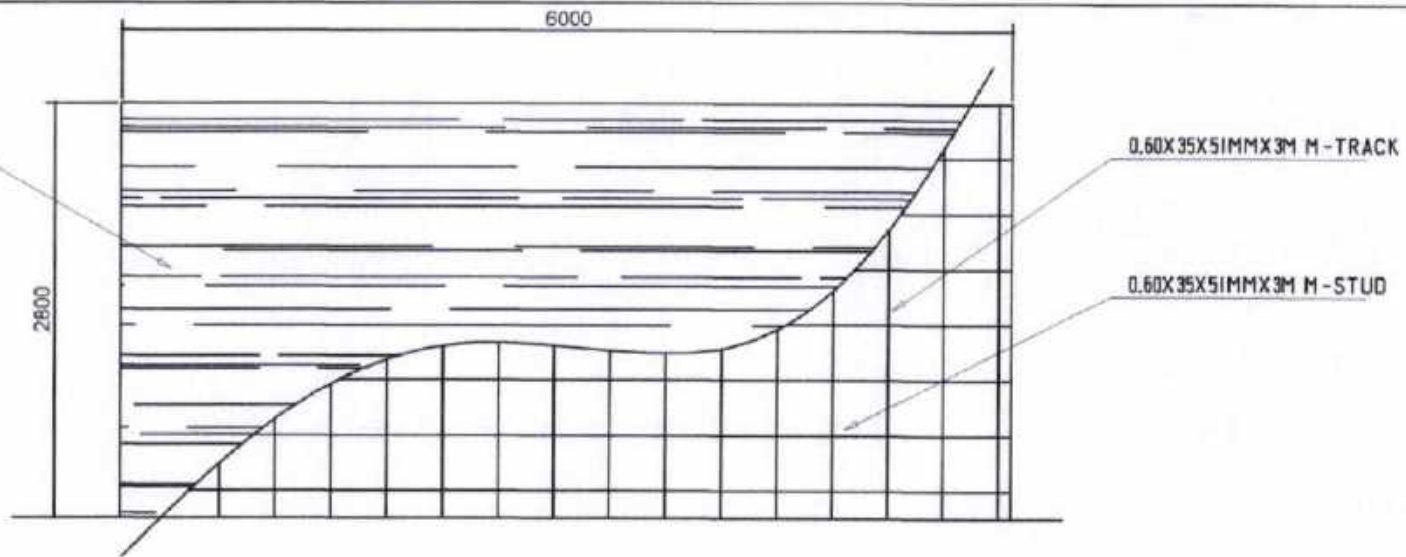

○ PARTITION DET.  
SCALE: N T S

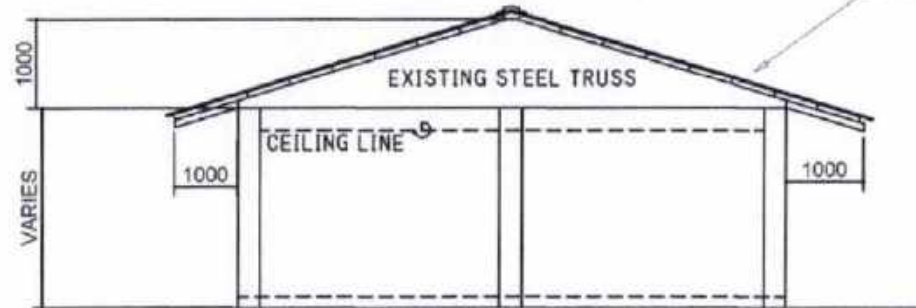

○ SIDE ELEVATION  
SCALE: N T S

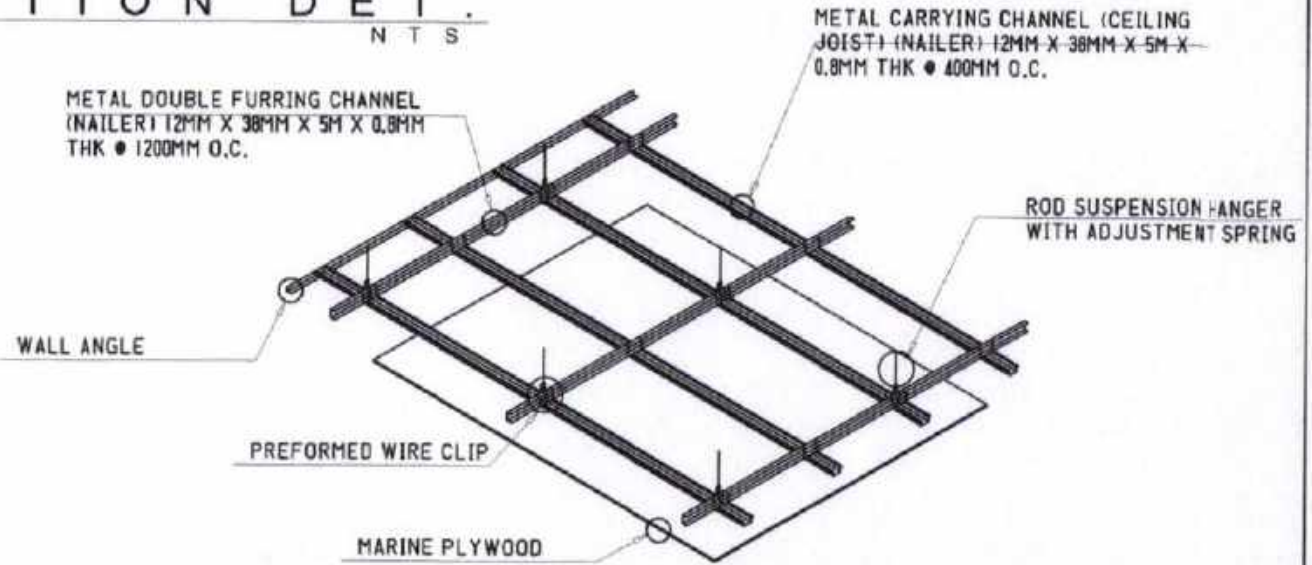



○ CEILING DET.  
SCALE: N T S



CITY ENGINEER'S  
OFFICE

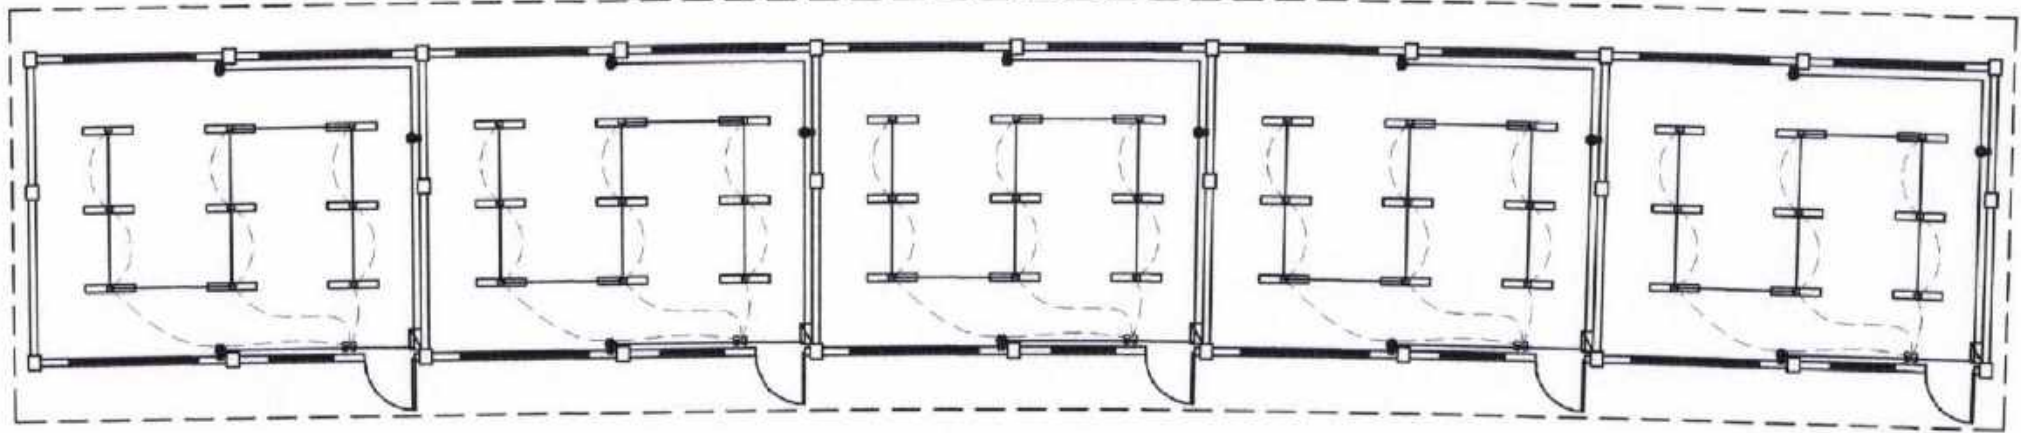

PROJECT TITLE	DRAWN BY:	NOTED BY:	APPROVED BY:
REPAIR/IMPROVEMENT OF MULTI-PURPOSE HALL (ACADEMIC BLDG) BUENAVISTA ES			
LOCATION: BRGY. BUENAVISTA, BACON DIST SORSOGON CITY		NOEL D. DOMER, CE CIC/CEO	MA. ESTER E. HAMOR CITY MAYOR




**ELECTRICAL LAYOUT**  
 SCALE: N T S



**CITY ENGINEER'S  
OFFICE**

PROJECT TITLE:	DRAWN BY:	NOTED BY:	APPROVED BY:
REPAIR/IMPROVEMENT OF MULTI-PURPOSE HALL (ACADEMIC BLDG) BUENAVISTA ES			
LOCATION: BRGY. BUENAVISTA, BACON DIST SORSOGON CITY		 NOEL D. DAMER, CE CJC-CEO	 MA. ESTER E. HAMOR CITY MAYOR


PLEASE SIGN

# BUENAVISTA ELEMENTARY SCHOOL

## ACADEMIC SCHOOL BUILDING





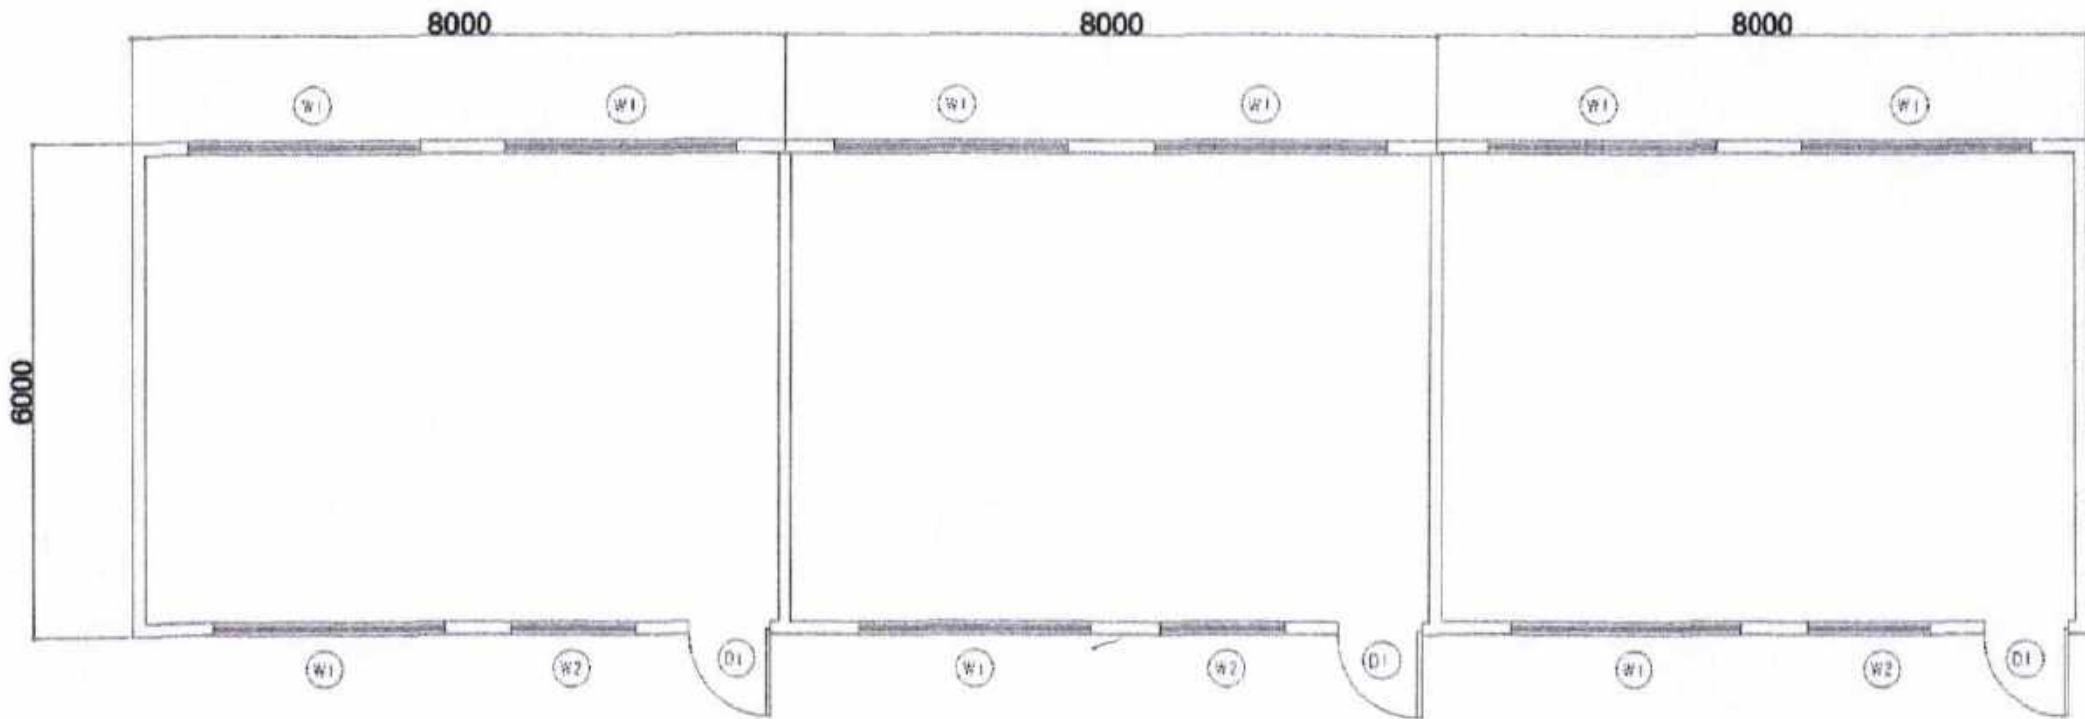

EXISTING FLOOR PLAN  
SCALE: 1/8"=1'-0"





**CITY ENGINEER'S  
OFFICE**

PROJECT TITLE:  
REPAIR/IMPROV. OF MULTI-PURPOSE HALL  
(BLSB BLDG.), SALVACION ES  
  
LOC: BRGY. SALVACION, BACON DISTRICT  
SORSOGON CITY

DRAWN BY:  
  
Ma Pamela Legaspi  
DRAFTING AIDE

RECOMMENDING APPROVAL:  
  
ROEL D. DOMER, CE/RMP  
CIC-CITY ENGINEER

APPROVED BY:  
  
MA. ESTER E. HAMOR  
CITY MAYOR

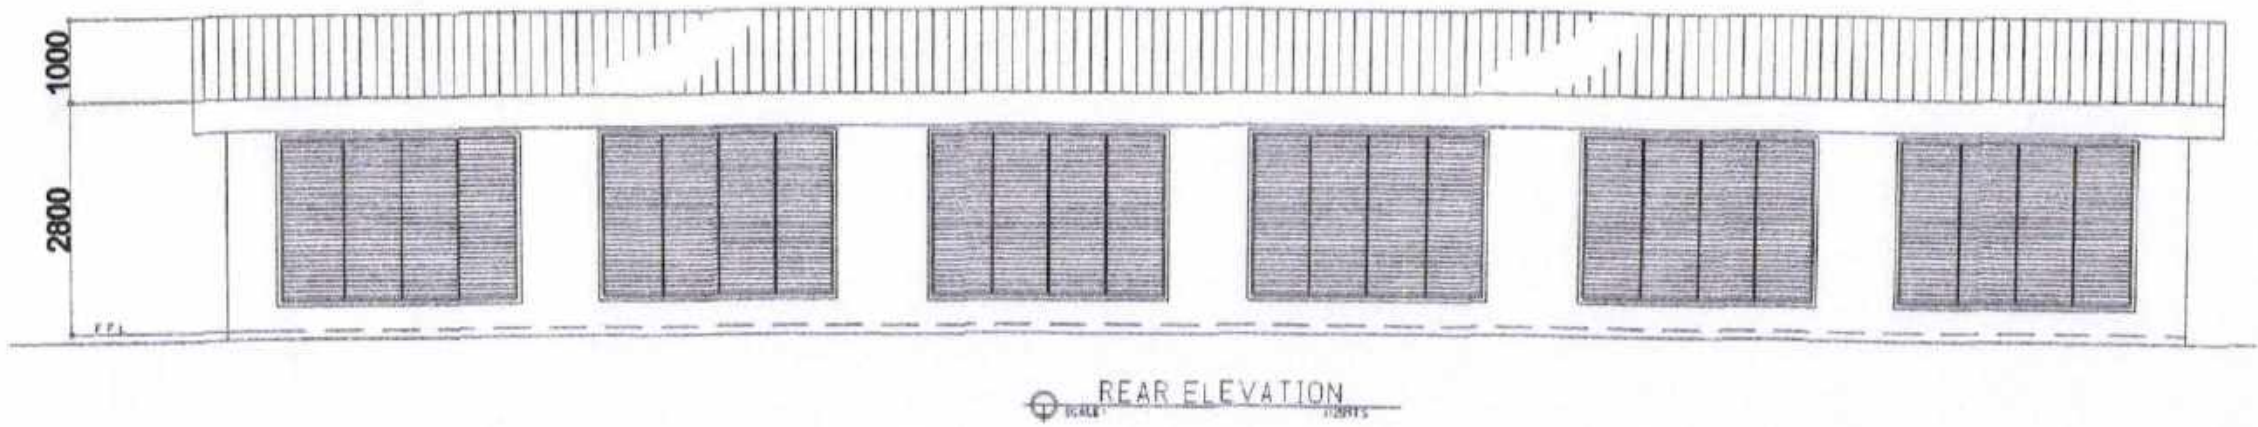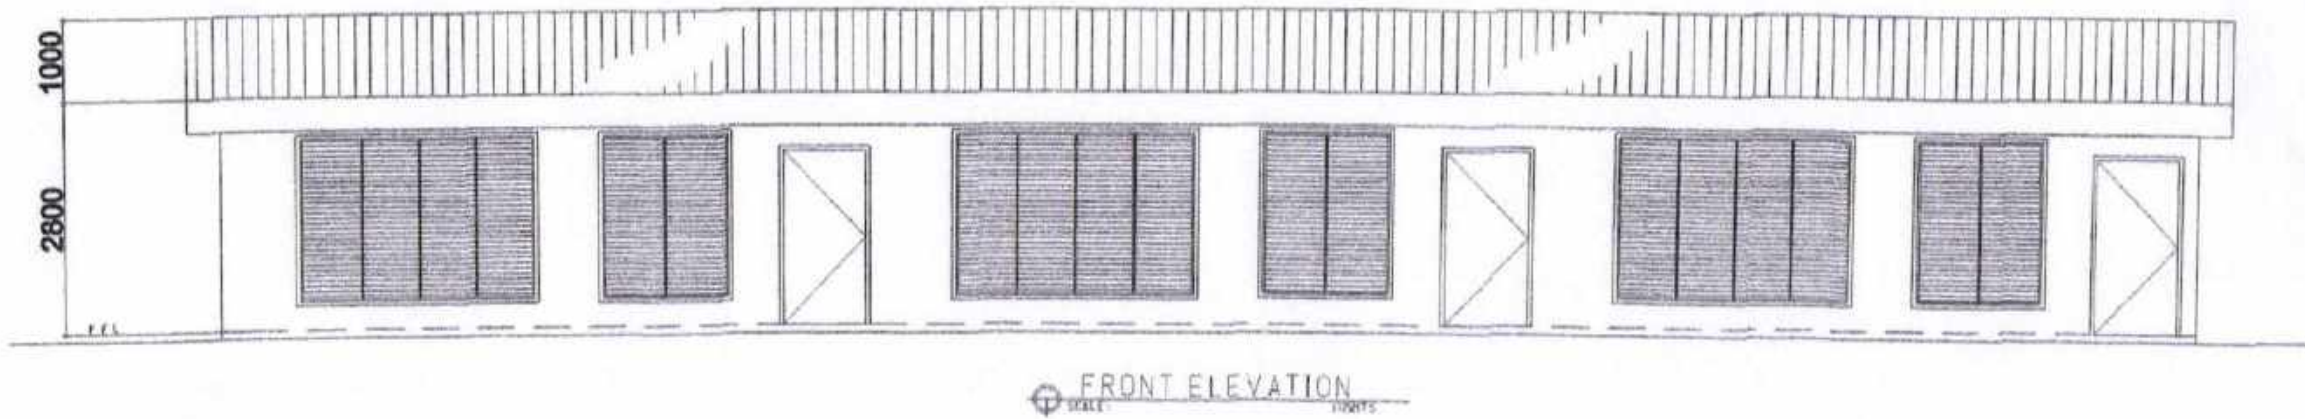

**CITY ENGINEER'S  
OFFICE**


PROJECT TITLE:  
REPAIR/IMPROV. OF MULTI-PURPOSE HALL  
(BLSB BLDG.), SALVACION ES  
LOC: BRGY. SALVACION, BACON DISTRICT  
SORSOGON CITY

DRAWN BY:  
MaPamela Legaspi  
DRAFTING AIDE


RECOMMENDING APPROVAL:  
ROEL D. BOMER, C.E./RMP  
CITY ENGINEER

APPROVED BY:  
MA. ESTER E. HAMOR  
CITY MAYOR


PLEASE SIGN

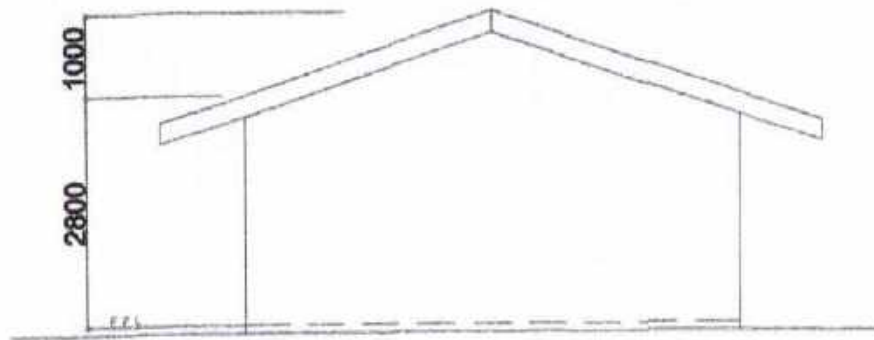


RIGHT SIDE ELEV.  
SCALE: 1/4"=1'-0"

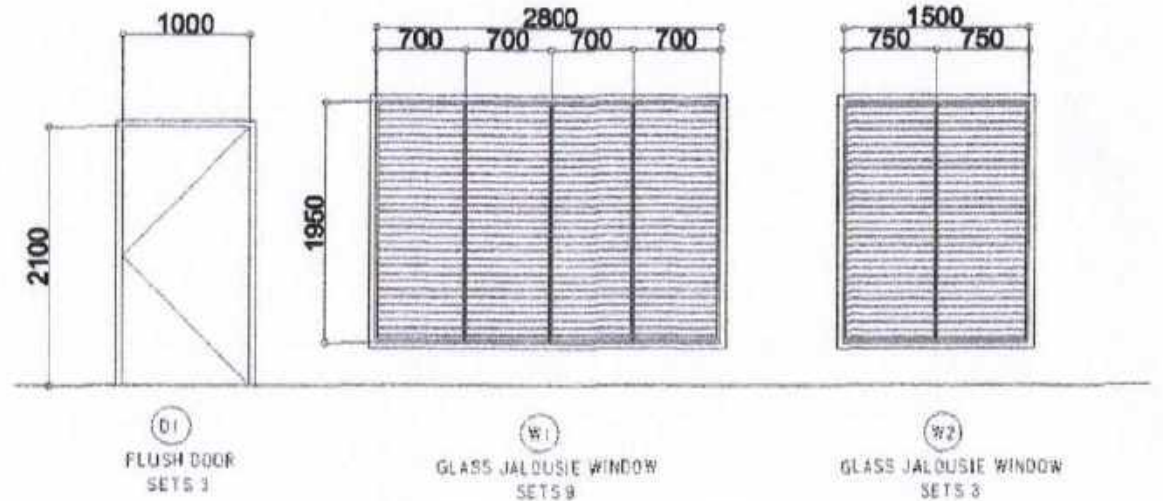

DOORS & WINDOWS SCHEDULE  
SCALE: 1/4"=1'-0"

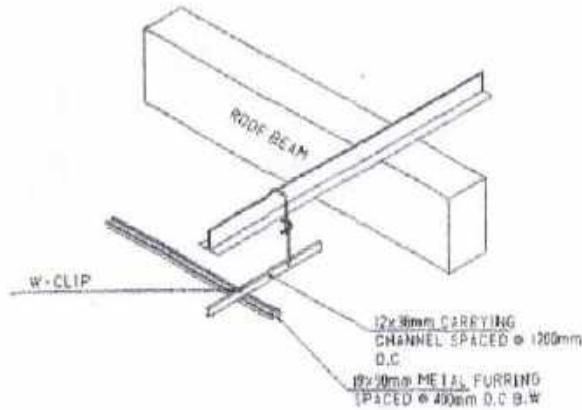

ISOMETRIC DRAWING

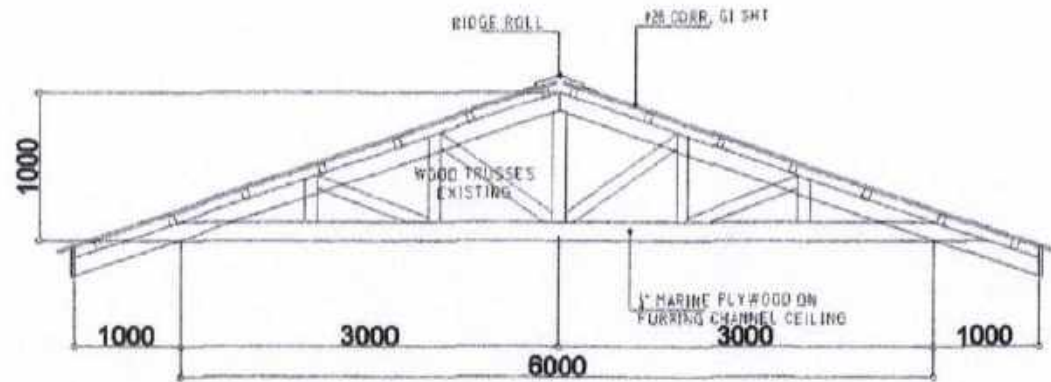

TRUSS DET.  
SCALE: 1/4"=1'-0"



**CITY ENGINEER'S  
OFFICE**

PROJECT TITLE:

REPAIR/IMPROV. OF MULTI-PURPOSE HALL  
(BLSS BLDG.), SALVACION ES

LOC: BRGY. SALVACION, BACON DISTRICT  
SORSOGON CITY

DRAWN BY:

Ma Pamela Legaspi  
DRAFTING AIDE


RECOMMENDING APPROVAL:

ROEL D. DOMER, C.E./RMP  
CITY ENGINEER

APPROVED BY:

MA. ESTER E. HAMOR  
CITY MAYOR

PLEASE STAMP

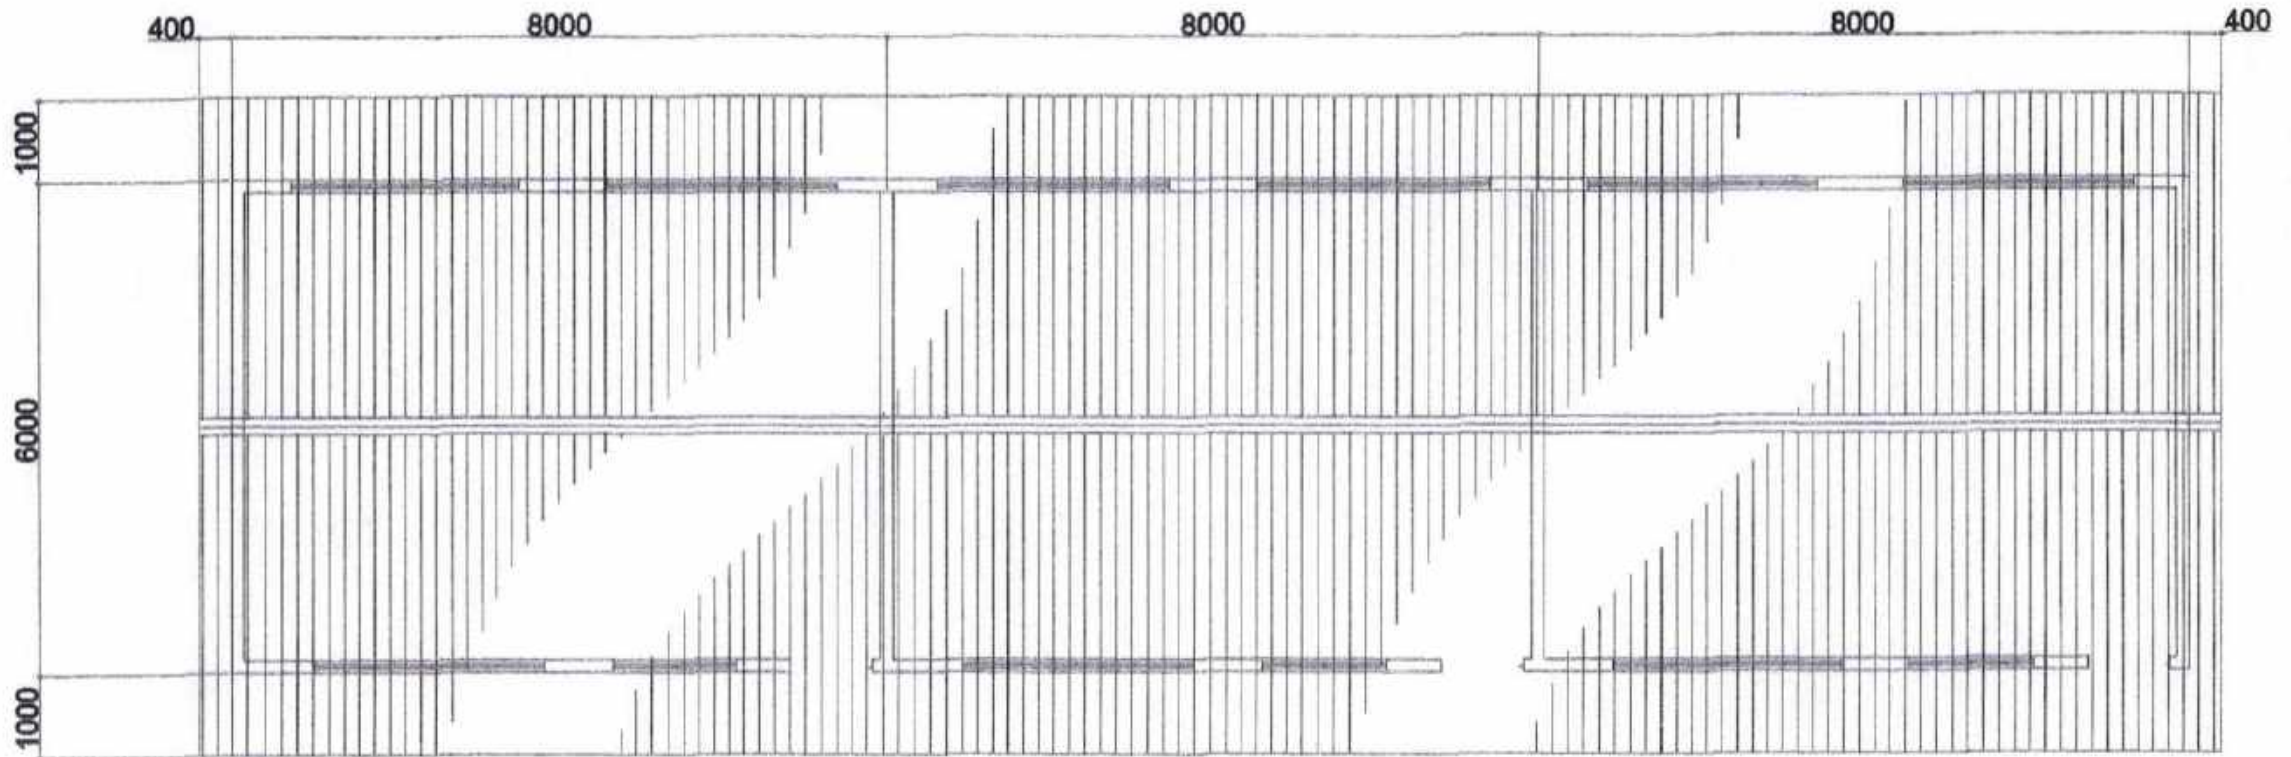

ROOF PLAN  
SCALE 1/2000



CITY ENGINEER'S  
O F F I C E

PROJECT TITLE:

REPAIR/IMPROV. OF MULTI-PURPOSE HALL  
(BLSB BLDG.), SALVACION ES

LOC: BRGY. SALVACION, BACON DISTRICT  
SORSOGON CITY

DRAWN BY:

MaPamela Legaspi  
DRAFTING AIDE


RECOMMENDING APPROVAL:

ROEL D. DOMER, C.E./RMP  
CIC-CITY ENGINEER

APPROVED BY:

MA. ESTER E. HAMOR  
CITY MAYOR

PLEASE

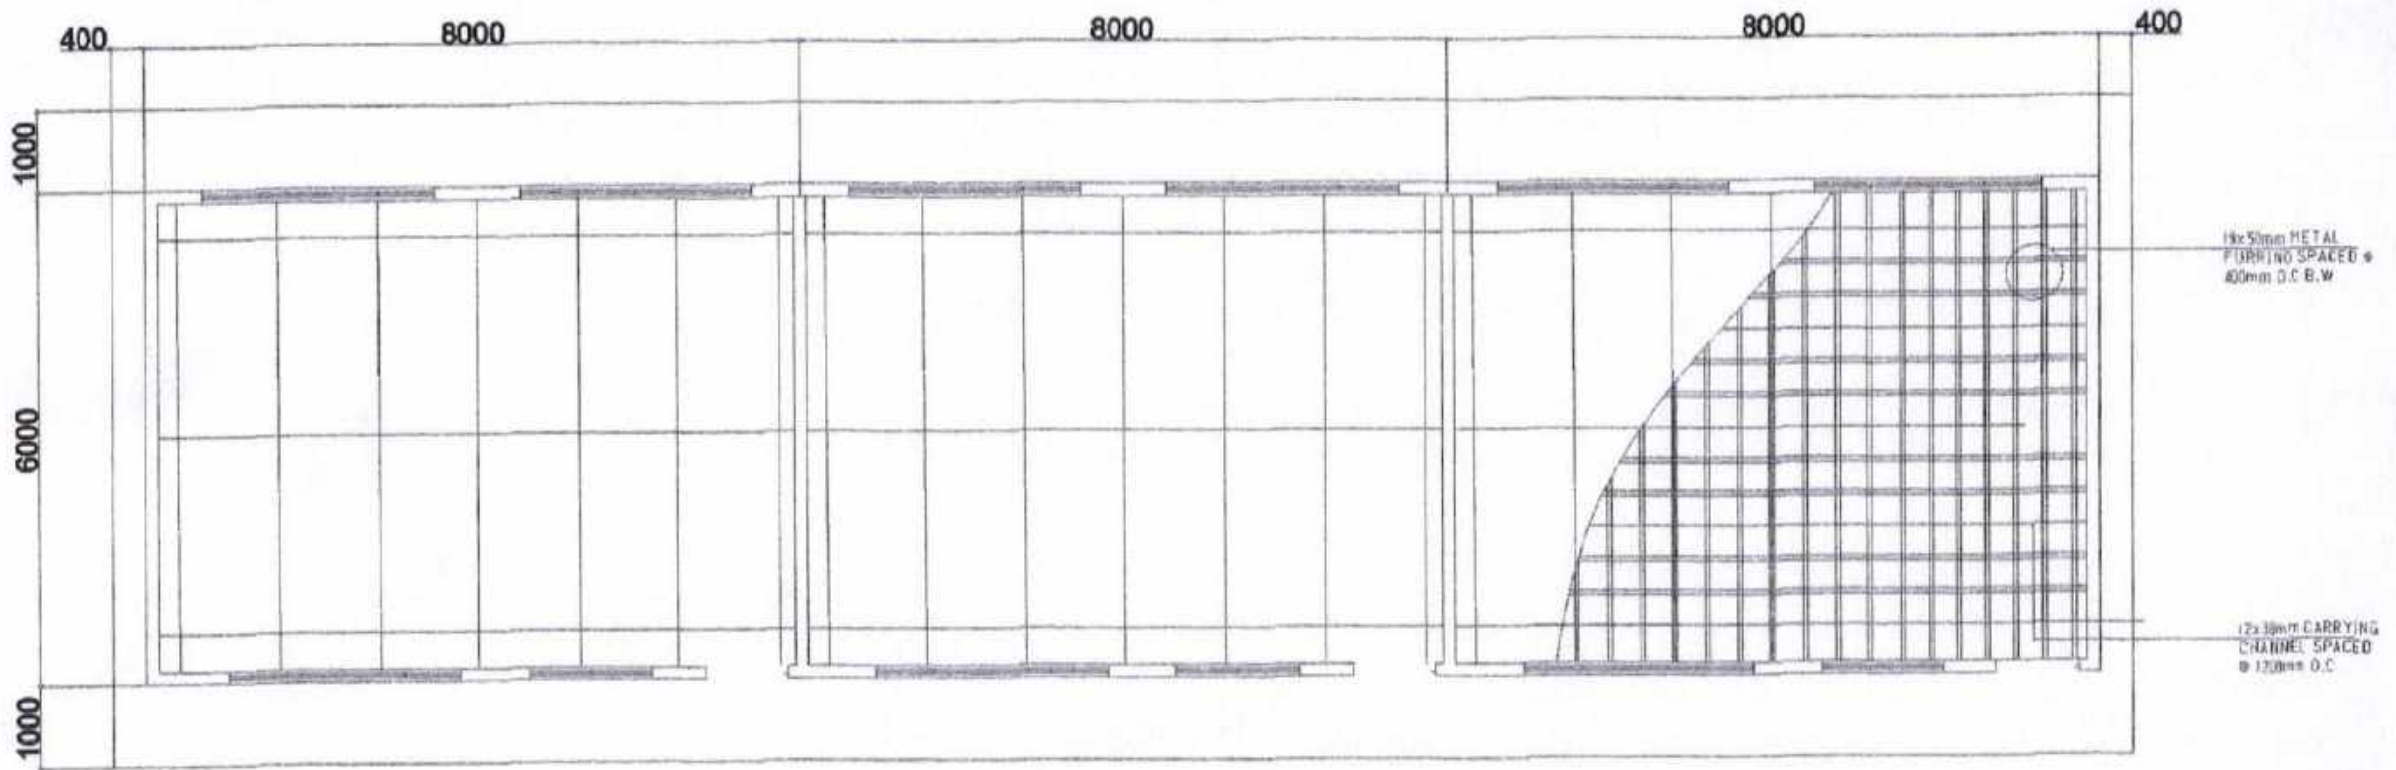

CEILING PLAN  
SCALE: 1/8"=1'-0"



CITY ENGINEER'S  
OFFICE

PROJECT TITLE:

REPAIR/IMPROV. OF MULTI-PURPOSE HALL  
(BLSB BLDG.), SALVACION ES

LOC: BRGY. SALVACION, BACON DISTRICT  
SORSOGON CITY

DRAWN BY:


MaPamelaLegaspi  
DRAFTING AIDE

RECOMMENDING APPROVAL:

ROEL B. DOMER, C.E./RMP  
CITY ENGINEER

APPROVED BY:

MA. ESTER E. HAMOR  
CITY MAYOR

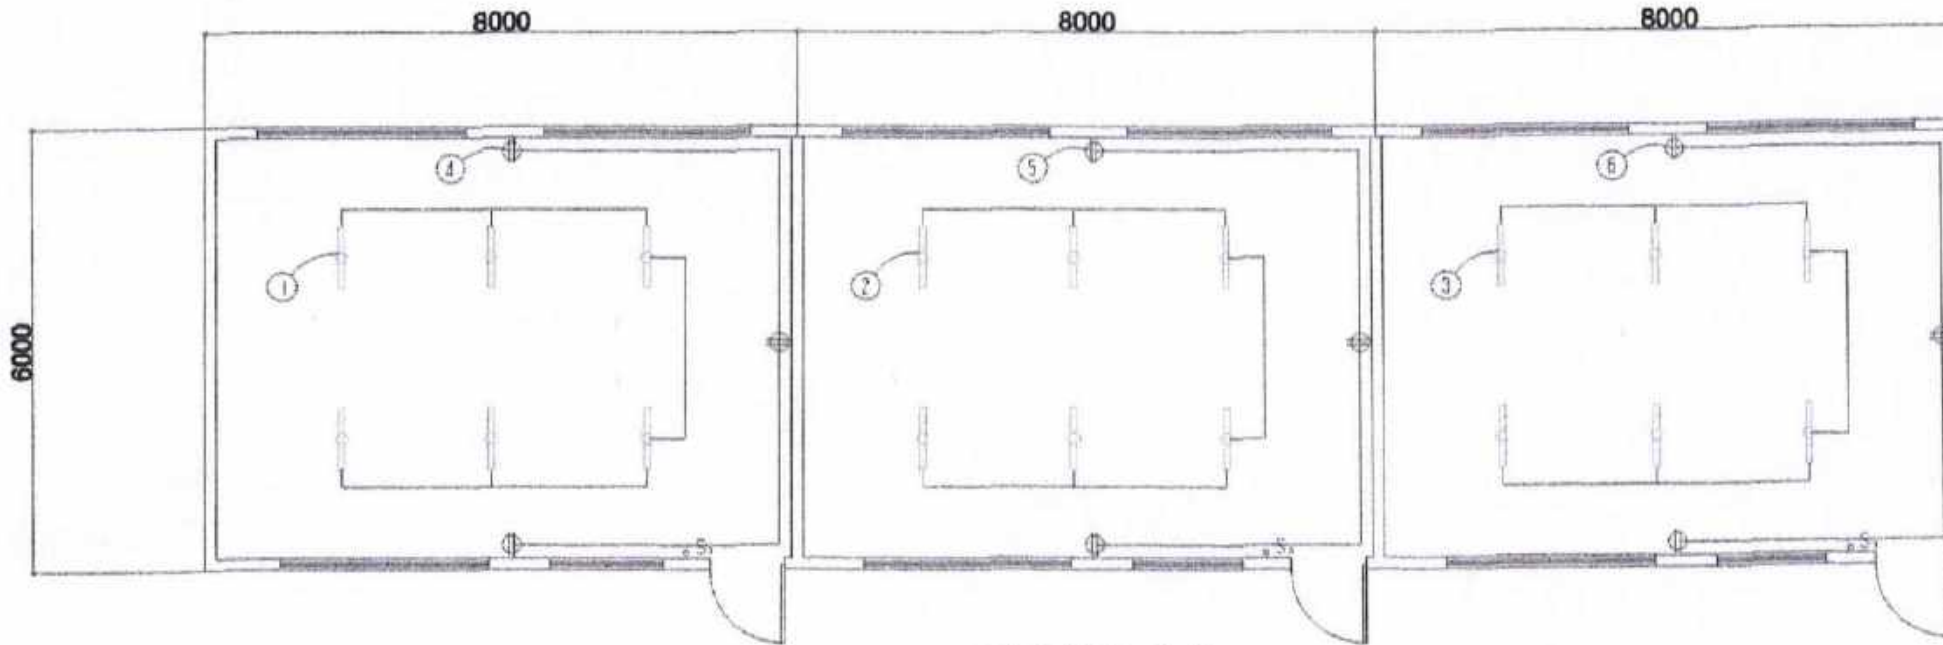

ELECTRICAL PLAN

**ELECTRICAL NOTES**

ALL ELECTRICAL WORKS SHALL BE DONE IN ACCORDANCE WITH THE LATEST RULES AND REGULATIONS OF THE PHIL. ELECTRICAL CODE AS WELL AS THE LOCAL AUTHORITY CONCERNED AND THE LOCAL POWER COMPANY.

ALL ELECTRICAL MATERIALS TO BE USED SHALL BE NEED & APPROVED TYPE FOR LOCATION & PURPOSE

MOUNTING HEIGHTS SHALL BE AS FOLLOWS:

- a. LIGHT CONTROL SWITCH- 1.35M ABOVE FIN. FLR. LINE AT CENTER
- b. CONVENIENCE OUTLET-ABOVE 1.0M ABOVE FIN. FLR. LINE AT CENTER
- c. PANEL BOARD- 2.0 M ABOVE FIN. FLR. LINE

ALL ELECTRICAL WORKS SHALL BE UNDER THE DIRECT & IMMEDIATE SUPERVISION OF A DULY LICENSED ELECTRICAL ENGINEER OR REGISTERED MASTER ELECTRICIAN

**SCHEDULE OF LOADS**

CIRCUIT NO.	DESCRIPTION	NO. OF LOADS	VOLTS	WATTS	AMP	SIZE OF WIRE	SIZE OF CONDUIT
1	LIGHTING OUTLET	6	230	600	2.60	2-2.0mm <sup>2</sup> THW	15mmØ
2	LIGHTING OUTLET	6	230	600	2.60	2-2.0mm <sup>2</sup> THW	15mmØ
3	LIGHTING OUTLET	6	230	600	2.60	2-2.0mm <sup>2</sup> THW	15mmØ
4	CONVENIENCE OUTLET	3	230	540	2.34	2-3.5mm <sup>2</sup> THW	20mmØ
5	CONVENIENCE OUTLET	3	230	540	2.34	2-3.5mm <sup>2</sup> THW	20mmØ
6	CONVENIENCE OUTLET	3	230	540	2.34	2-3.5mm <sup>2</sup> THW	20mmØ
	<b>TOTAL</b>				<b>14.82</b>		



**CITY ENGINEER'S  
OFFICE**

PROJECT TITLE:

REPAIR/IMPROV. OF MULTI-PURPOSE HALL  
(BLSB BLDG.), SALVACION ES

LOC: BRGY. SALVACION, BACON DISTRICT  
SORSOGON CITY

DRAWN BY:

Ma Pamela Legaspi  
DRAFTING AIDE

RECOMMENDING APPROVAL:

ROEL B. DOMER, C.E./RMP  
CITY ENGINEER


APPROVED BY:

MA. ESTER E. HAMOR  
CITY MAYOR

**SALVACION ELEMENTARY SCHOOL**

**BLSB BUILDING (3 UNITS)**



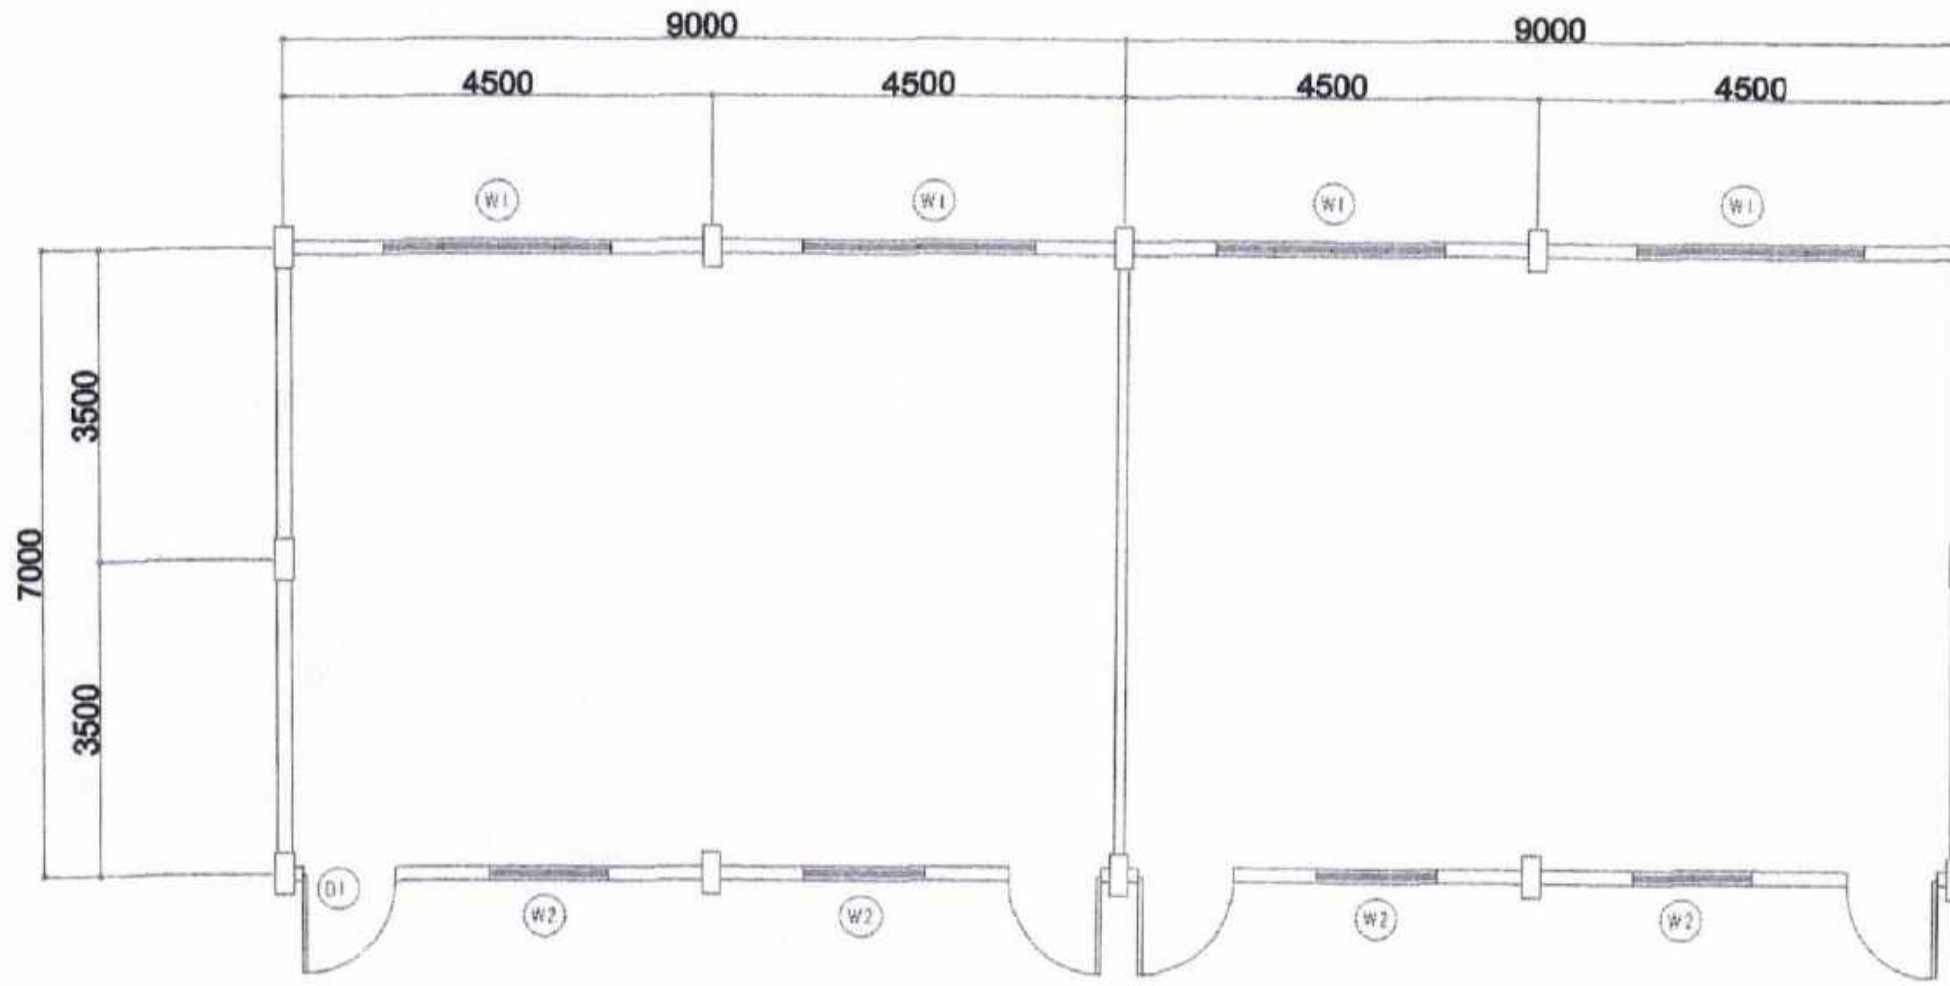

EXISTING FLOOR PLAN  
SCALE: 1/8" = 1'-0"

PLEASE SIGN HERE



CITY ENGINEER'S  
OFFICE


PROJECT TITLE:  
REPAIR/IMPROV. OF MULTI-PURPOSE HALL  
(PROJECT CARE BLDG.), SALVACION ES  
LOC: BRGY. SALVACION, BACON DISTRICT  
SORSGOGON CITY

DRAWN BY:  
Ma Pamela Legaspi  
DRAFTING AIDE


RECOMMENDING APPROVAL:  
ROEL D. BOMER, C.E./RMP  
CITY ENGINEER

APPROVED BY:  
MA. ESTER E. HANOR  
CITY MAYOR



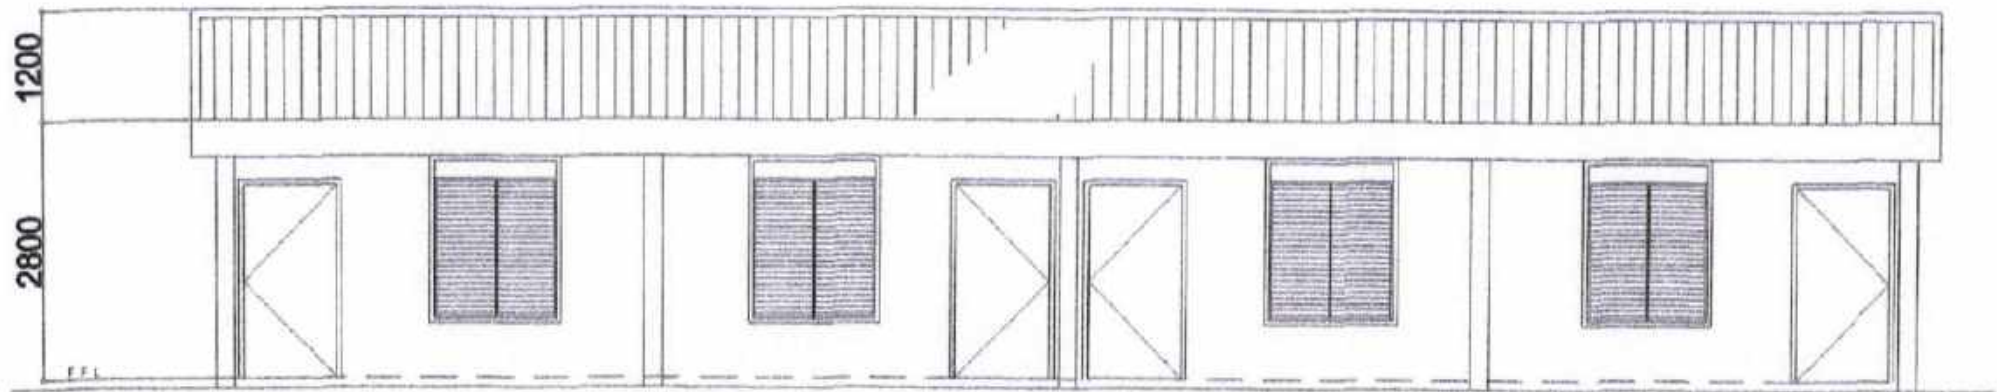

FRONT ELEVATION  
SCALE: 1/8"=1'-0"

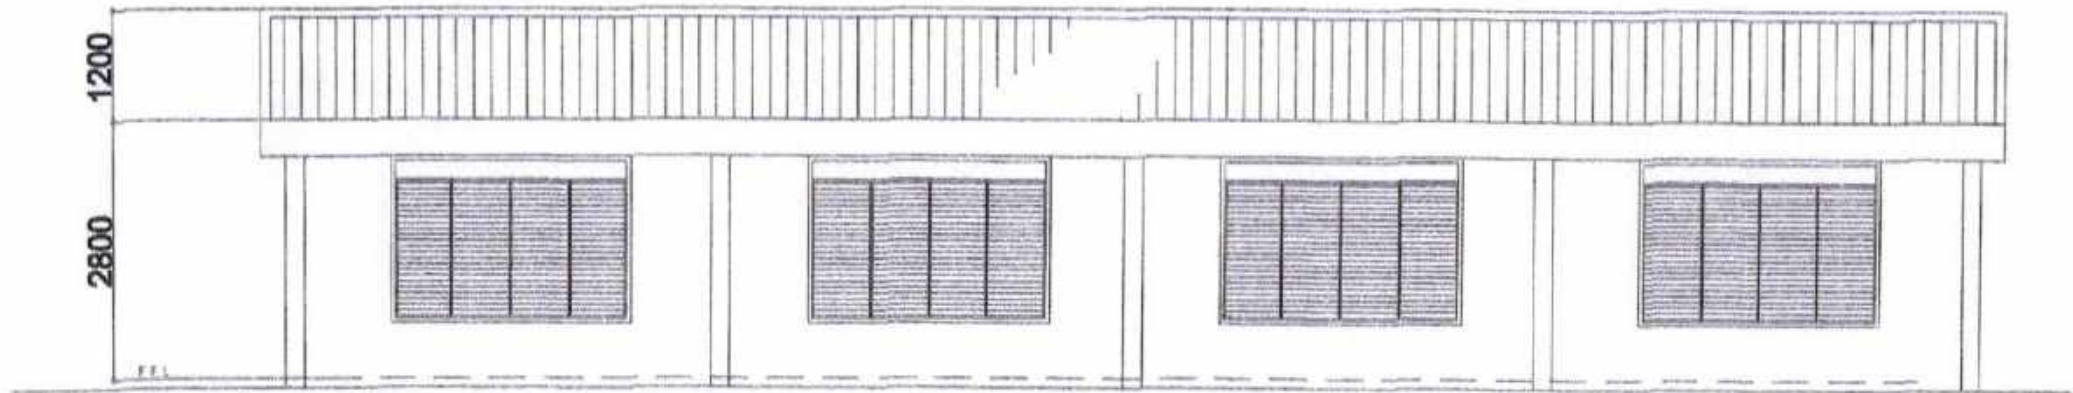

REAR ELEVATION  
SCALE: 1/8"=1'-0"

PLEASE SIGN



CITY ENGINEER'S  
O F F I C E

PROJECT TITLE:

REPAIR/IMPROV. OF MULTI-PURPOSE HALL  
(PROJECT CARE BLDG.), SALVACION ES

LOC: BRGY. SALVACION, BACON DISTRICT  
SORSOGON CITY

DRAWN BY:


MaPaas(aLegaspi  
DRAFTING AIDE

RECOMMENDING APPROVAL:


ROEL D. DOMER, C.E./RMP  
CITY ENGINEER

APPROVED BY:

MA. ESTER E. HAMOR  
CITY MAYOR

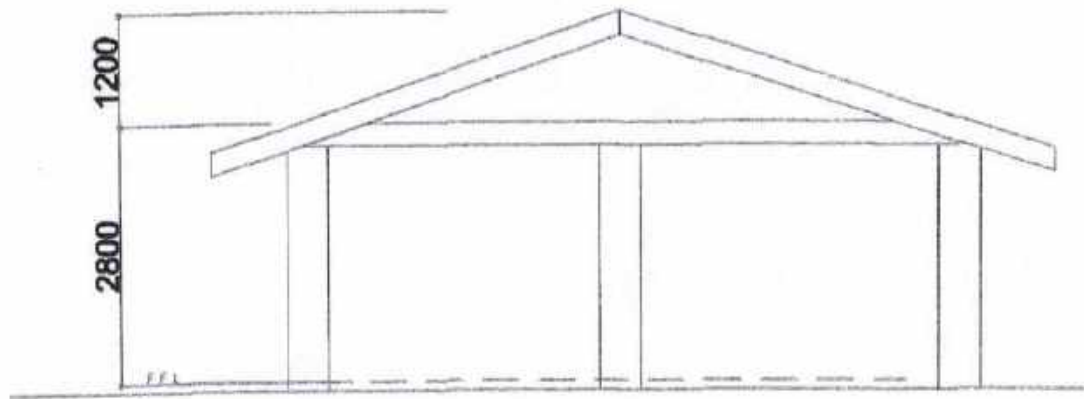


RIGHT SIDE ELEV.  
SCALE: 1/20PTS

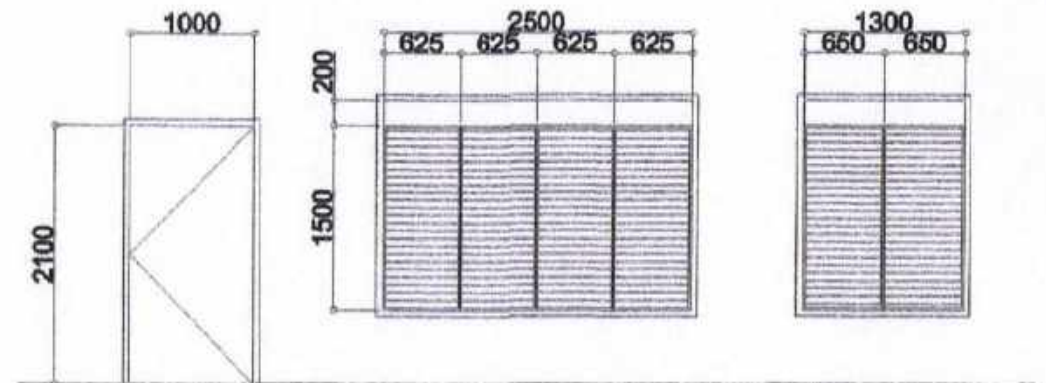


D1 FLUSH DOOR SETS 4  
R1 GLASS JALOUSIE WINDOW SETS 4  
W2 GLASS JALOUSIE WINDOW SETS 4

DOORS & WINDOWS SCHEDULE  
SCALE: 1/20PTS

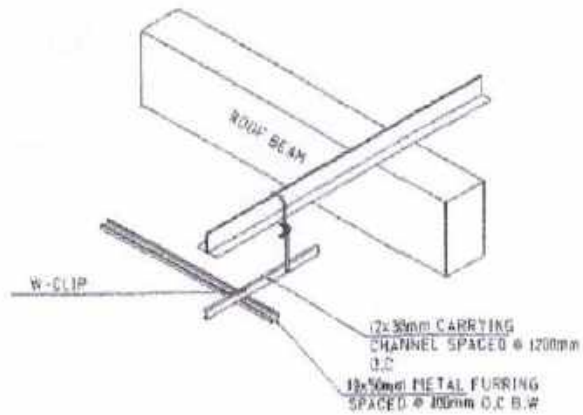

ISOMETRIC DRAWING

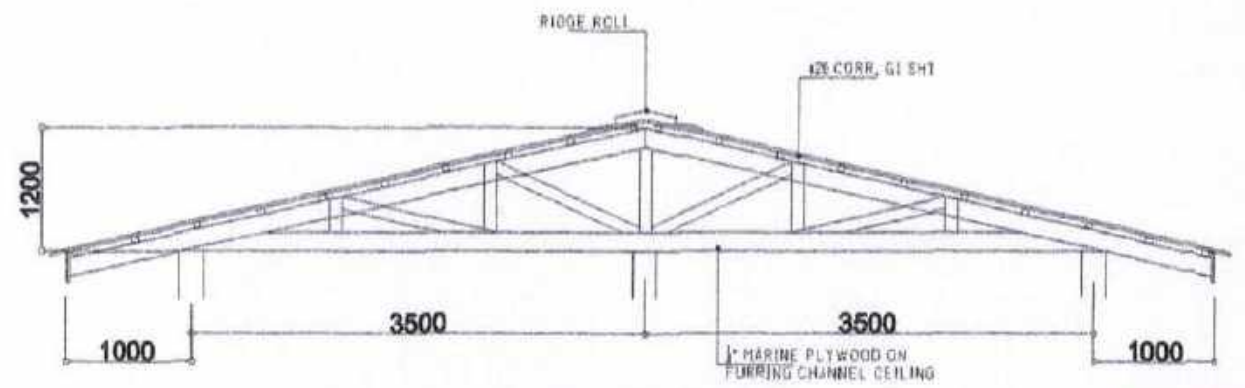

TRUSS DET.  
SCALE: 1/20PTS



CITY ENGINEER'S OFFICE


PROJECT TITLE:  
REPAIR/IMPROV. OF MULTI-PURPOSE HALL (PROJECT CARE BLDG.), SALVACION ES  
LOC: BRGY. SALVACION, BACON DISTRICT  
SORSOGON CITY

DRAWN BY:  
Ma Pamela Legaspi  
DRAFTING AIDE

RECOMMENDING APPROVAL:  
ROEL D. DOMER, C.E./RMP  
CIC CITY ENGINEER

APPROVED BY:  
MA. ESTER E. HAMOR  
CITY MAYOR

PLEASE SIGN

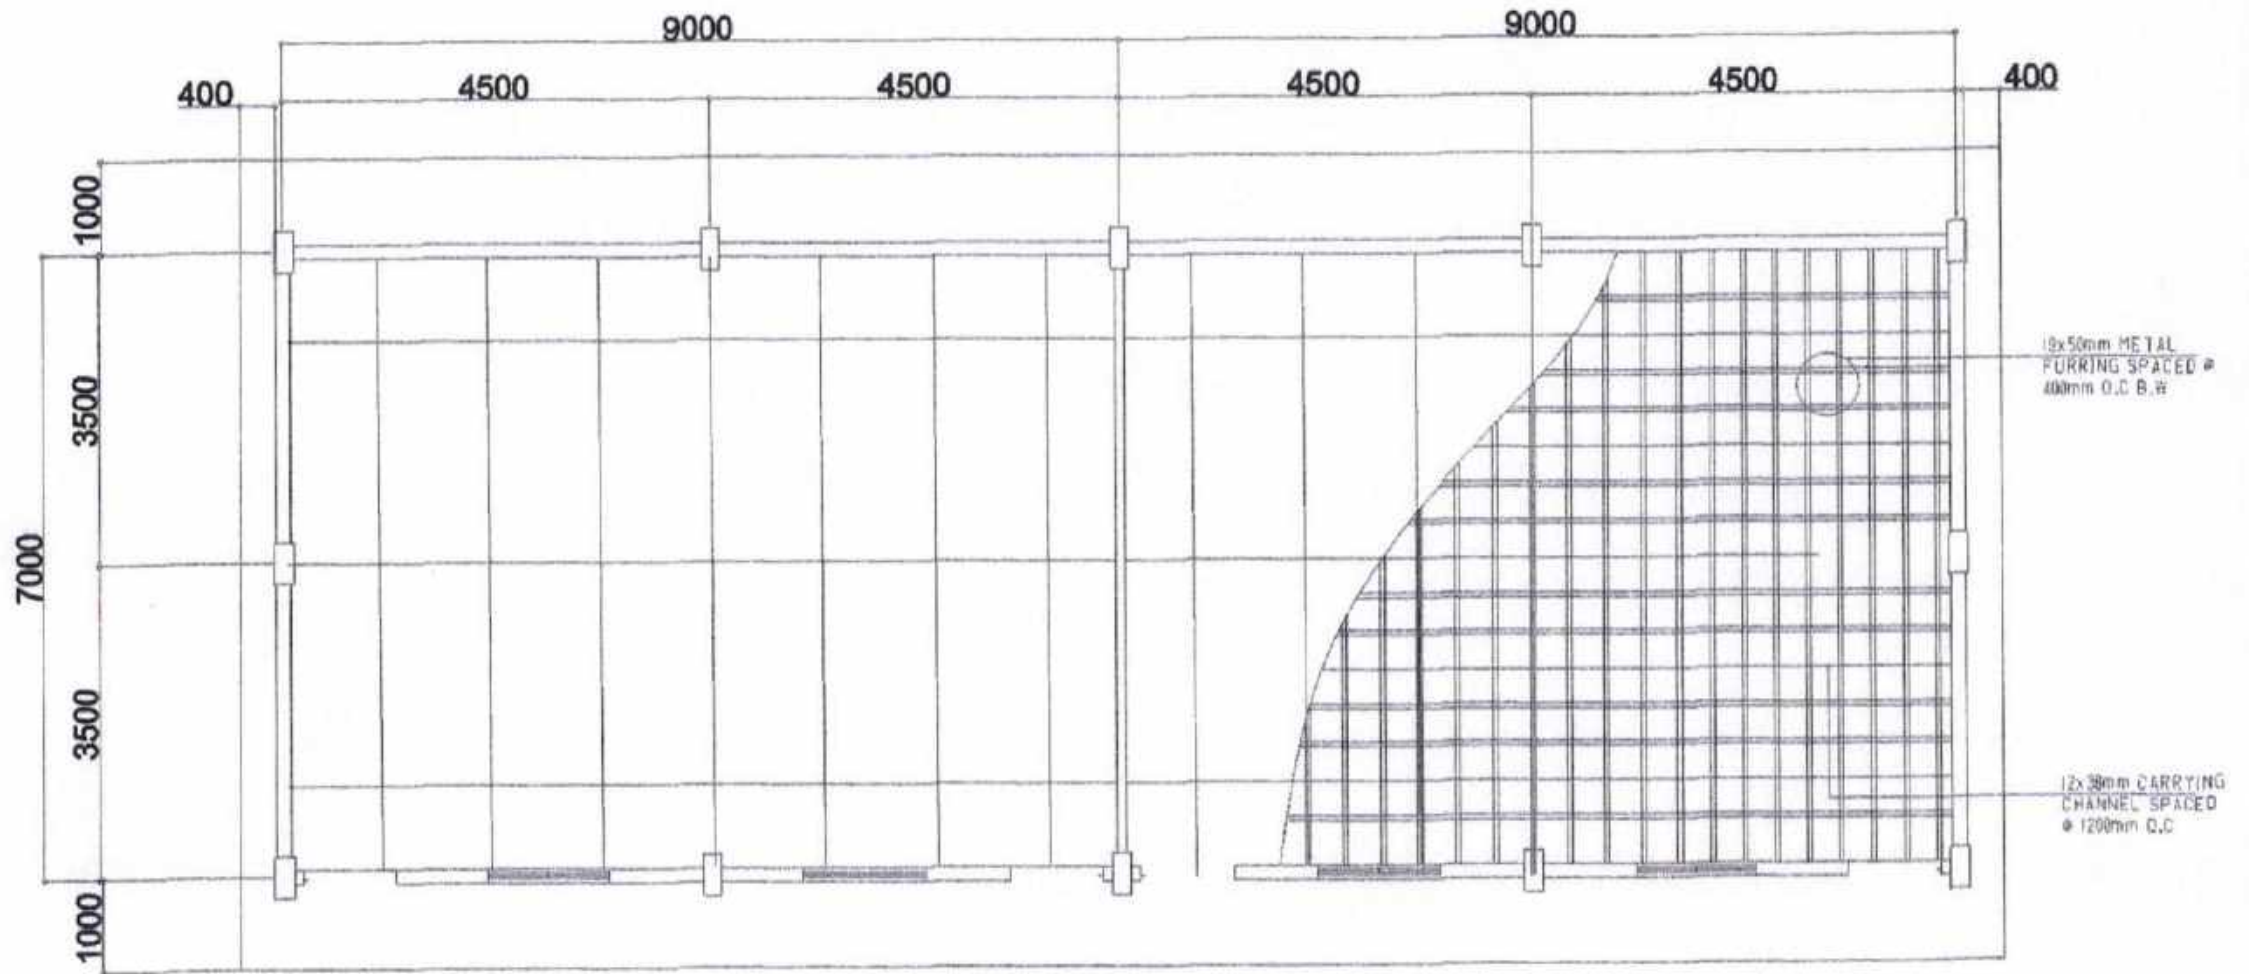

CEILING PLAN  
SCALE: 1:200



CITY ENGINEER'S  
OFFICE


PROJECT TITLE:  
REPAIR/IMPROV. OF MULTI-PURPOSE HALL  
(PROJECT CARE BLDG.), SALVACION ES  
LOC: BRGY. SALVACION, BACON DISTRICT  
SORSOGON CITY

DRAWN BY:  
Ma Pamela Legaspi  
DRAFTING AIDE

RECOMMENDING APPROVAL:  
ROEL D. DOMER, C.E./RMP  
CITY ENGINEER

APPROVED BY:  
MA. ESTER E. HAMOR  
CITY MAYOR

PLEASE

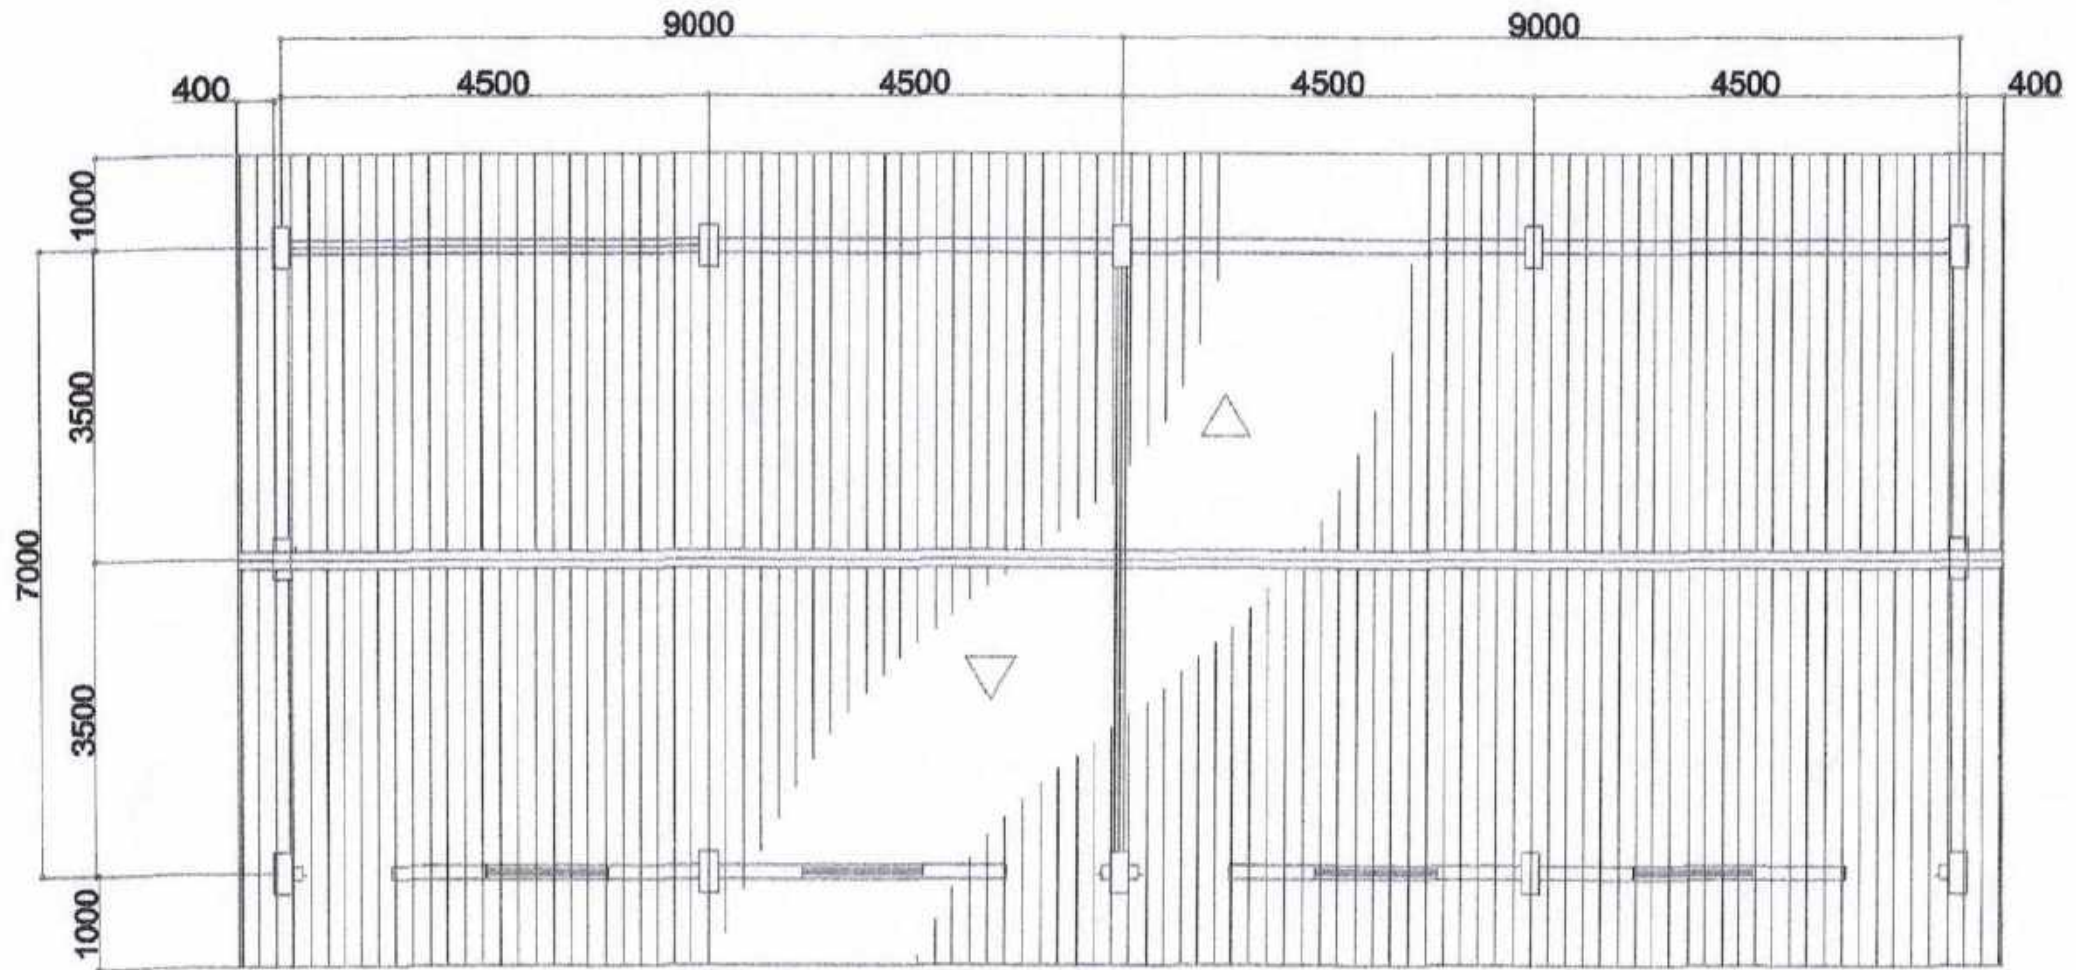

R O O F P L A N



CITY ENGINEER'S  
O F F I C E

PROJECT TITLE:  
 REPAIR/IMPROV. OF MULTI-PURPOSE HALL  
 (PROJECT CARE BLDG.), SALVACION ES  
 LOC: BRGY. SALVACION, BACON DISTRICT  
 SORSOGON CITY

DRAWN BY:  
 MaPame (aLegaspi)  
 DRAFTING AIDE


RECOMMENDING APPROVAL:  

 ROEL D. DIMER, C.E./RMP  
 C.I.C. ENGINEER

APPROVED BY:  

 MA. ESTER E. HAMOR  
 CITY MAYOR

PLEASE SEE

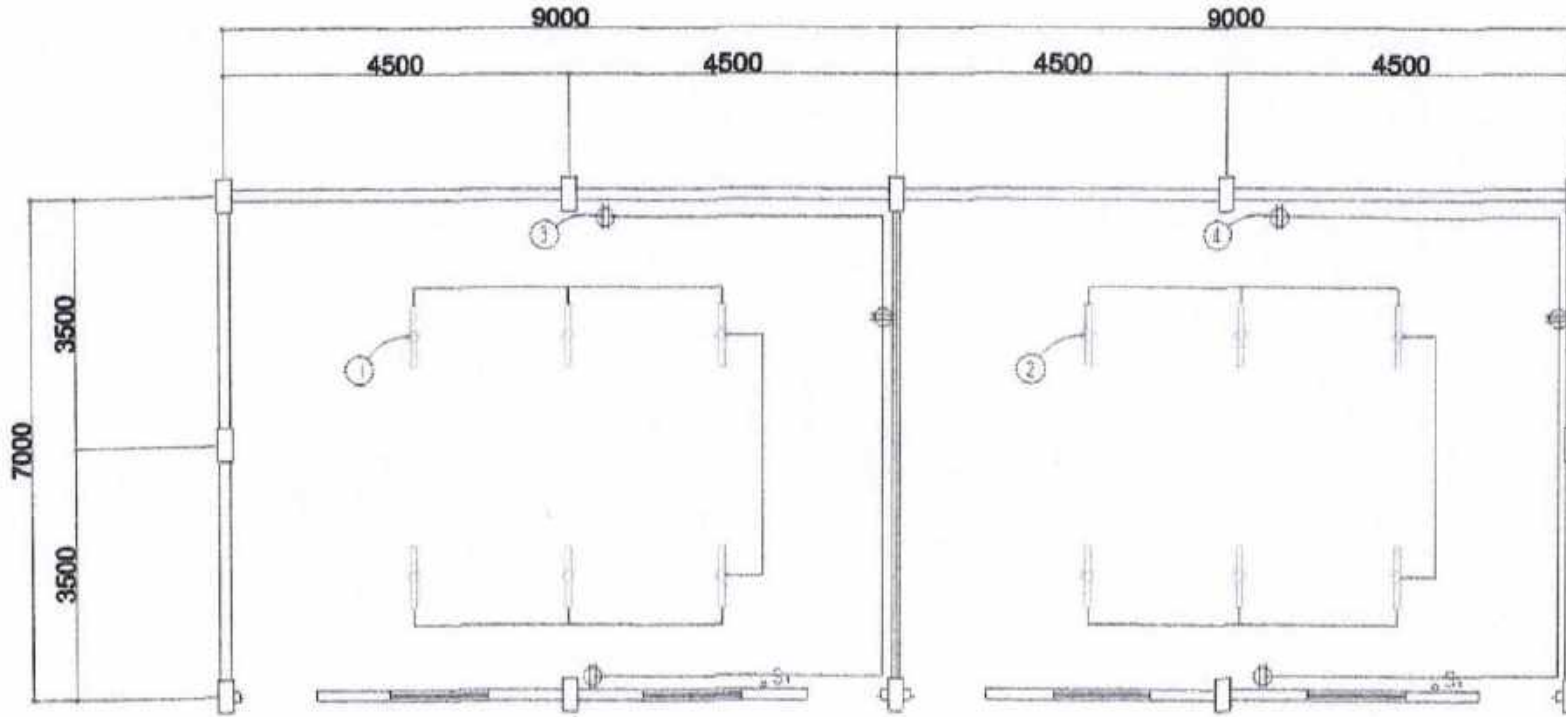

**ELECTRICAL NOTES**

ALL ELECTRICAL WORKS SHALL BE DONE IN ACCORDANCE WITH THE LATEST RULES AND REGULATIONS OF THE PHIL. ELECTRICAL CODE AS WELL AS THE LOCAL AUTHORITY CONCERNED AND THE LOCAL POWER COMPANY.

ALL ELECTRICAL MATERIALS TO BE USED SHALL BE NEED & APPROVED TYPE FOR LOCATION & PURPOSE

MOUNTING HEIGHTS SHALL BE AS FOLLOWS:

- a. LIGHT CONTROL SWITCH- 1.35M ABOVE FIN. FLR. LINE AT CENTER
- b. CONVENIENCE OUTLET-ABOVE 1.0M ABOVE FIN. FLR. LINE AT CENTER
- c. PANEL BOARD- 2.0 M ABOVE FIN. FLR. LINE

ALL ELECTRICAL WORKS SHALL BE UNDER THE DIRECT & IMMEDIATE SUPERVISION OF A DULY LICENSED ELECTRICAL ENGINEER OR REGISTERED MASTER ELECTRICIAN

**ELECTRICAL PLAN**  
SCALE: 1/32" = 1'-0"

**SCHEDULE OF LOADS**

CIRCUIT NO.	DESCRIPTION	NO. OF LOADS	VOLTS	WATTS	AMP	SIZE OF WIRE	SIZE OF CONDUIT
1	LIGHTING OUTLET	6	230	600	2.60	2-2.0mm <sup>2</sup> THW	15mm $\varnothing$
2	LIGHTING OUTLET	6	230	600	2.60	2-2.0mm <sup>2</sup> THW	15mm $\varnothing$
3	CONVENIENCE OUTLET	3	230	540	2.34	2-3.5mm <sup>2</sup> THW	20mm $\varnothing$
4	CONVENIENCE OUTLET	3	230	540	2.34	2-3.5mm <sup>2</sup> THW	20mm $\varnothing$
<b>TOTAL</b>					<b>9.88</b>		

PLEASE SIGN HERE




**CITY ENGINEER'S  
OFFICE**

PROJECT TITLE:  
REPAIR/IMPROV. OF MULTI-PURPOSE HALL  
(PROJECT CARE BLDG.), SALVACION ES  
LOC: BRGY. SALVACION, BACON DISTRICT  
SORSOGON CITY

DRAWN BY:  
MaPamela Legaspi  
DRAFTING AIDE

RECOMMENDING APPROVAL:  
ROEL D. DOMER-C.E./RMP  
CITY ENGINEER

APPROVED BY:  
MA. ESTER E. HAMOR  
CITY MAYOR

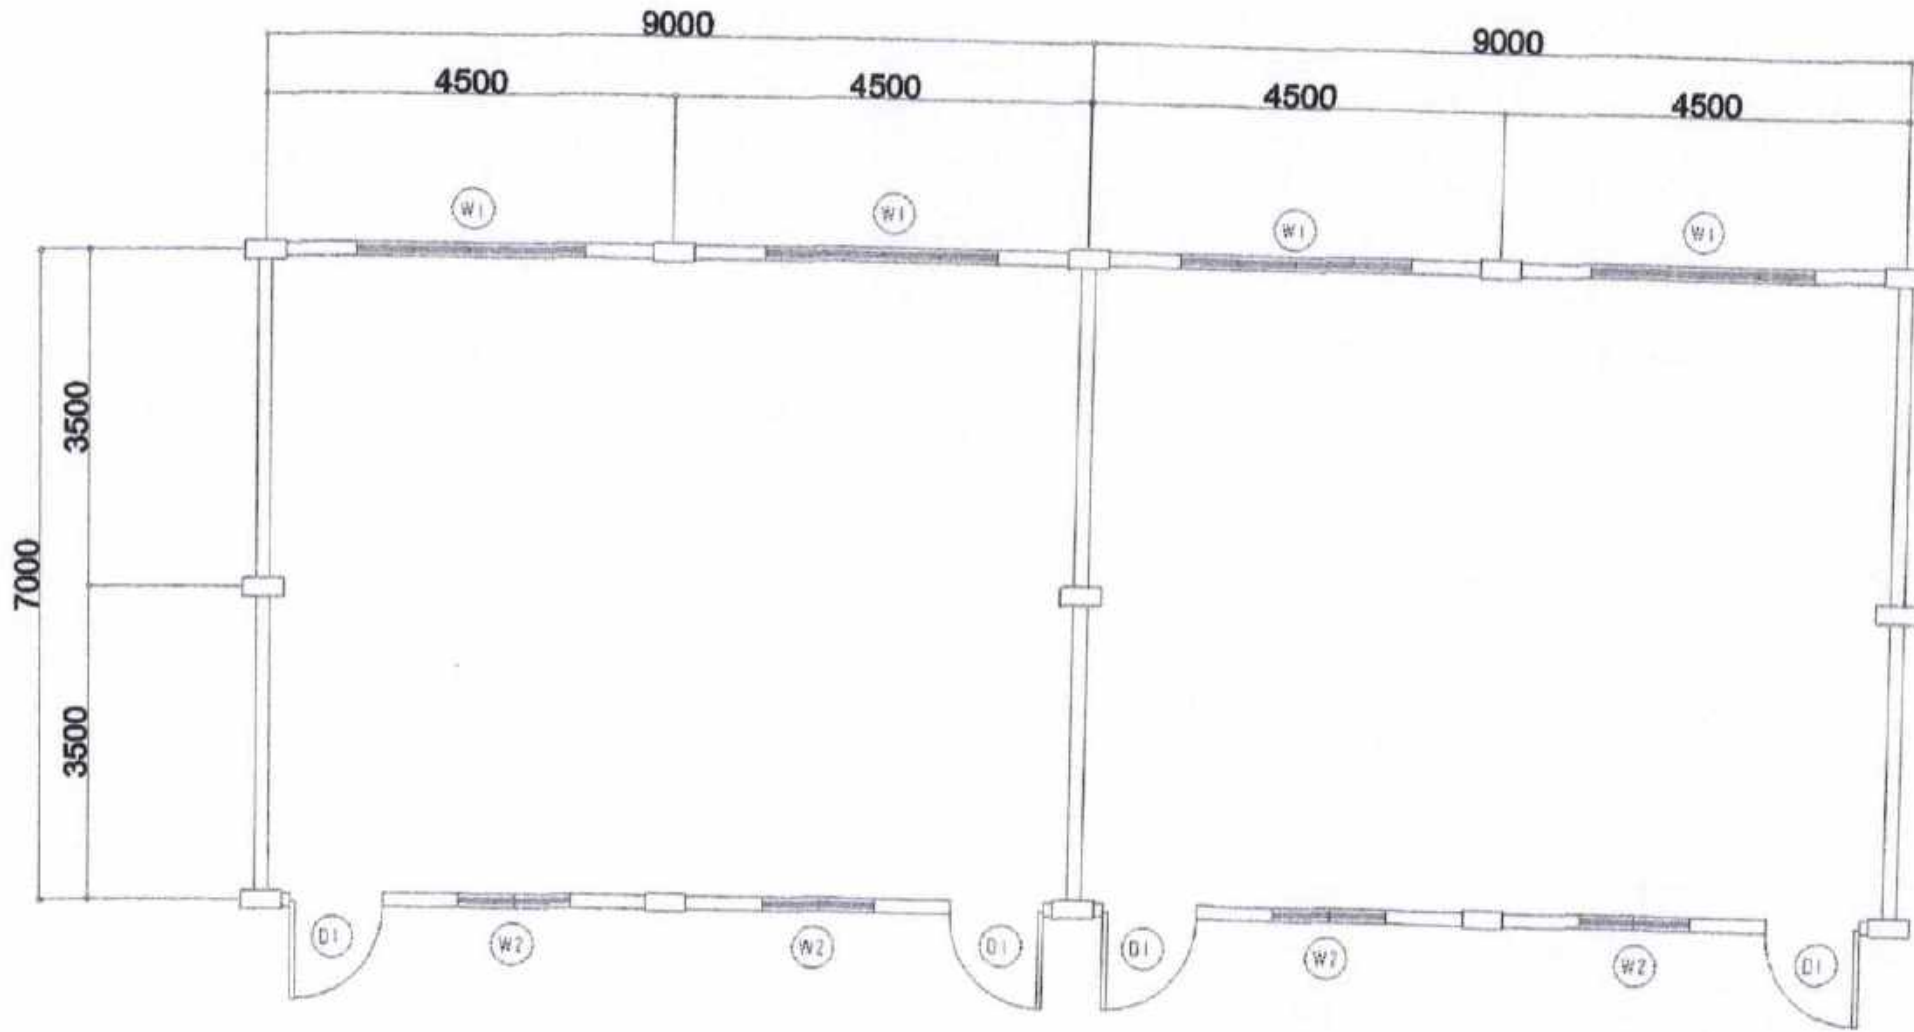

EXISTING FLOOR PLAN  
SCALE 1:300

PLEASE SIGN HERE




CITY ENGINEER'S  
OFFICE

PROJECT TITLE:  
REPAIR/IMPROV. OF MULTI-PURPOSE HALL  
(ACADEMIC BLDG.), SALVACION ES  
LOC: BRGY. SALVACION, BACON DISTRICT  
SORSOGON CITY


DRAWN BY:  
MaPangia Legaspi  
DRAFTING AIDE

RECOMMENDING APPROVAL:  
ROEL D. DOMER, C.E./RMP  
CITY ENGINEER

APPROVED BY:  
MA. ESTER E. HAMOR  
CITY MAYOR

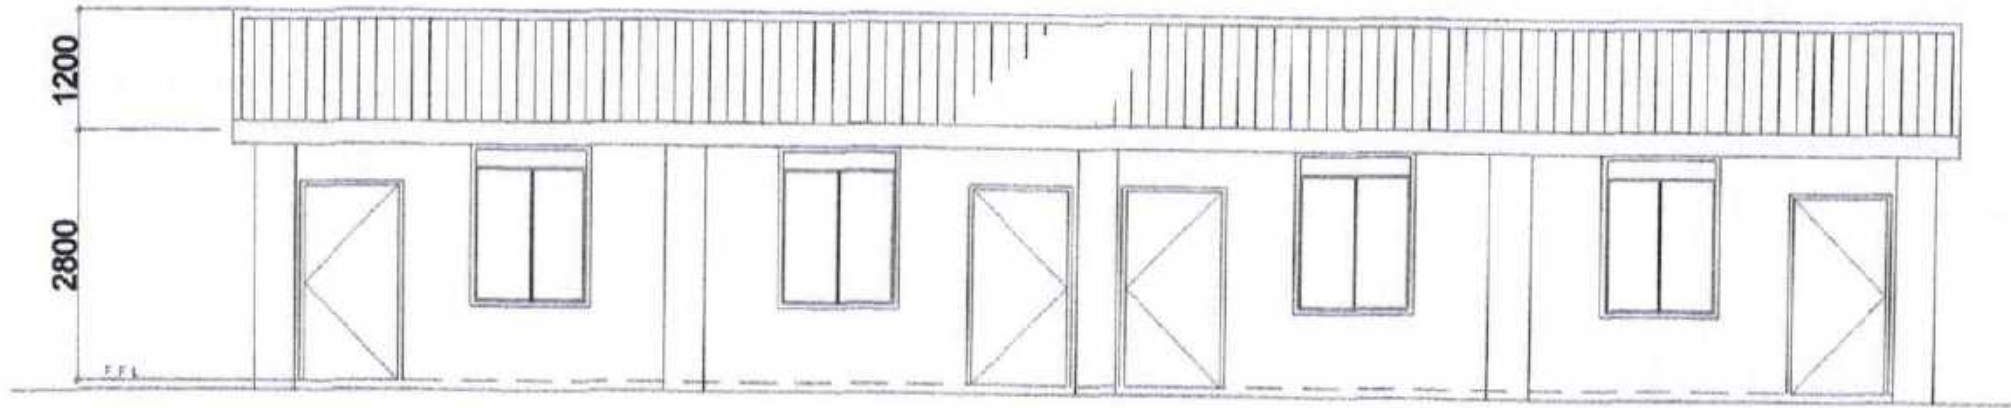

FRONT ELEVATION  
SCALE: 1/200

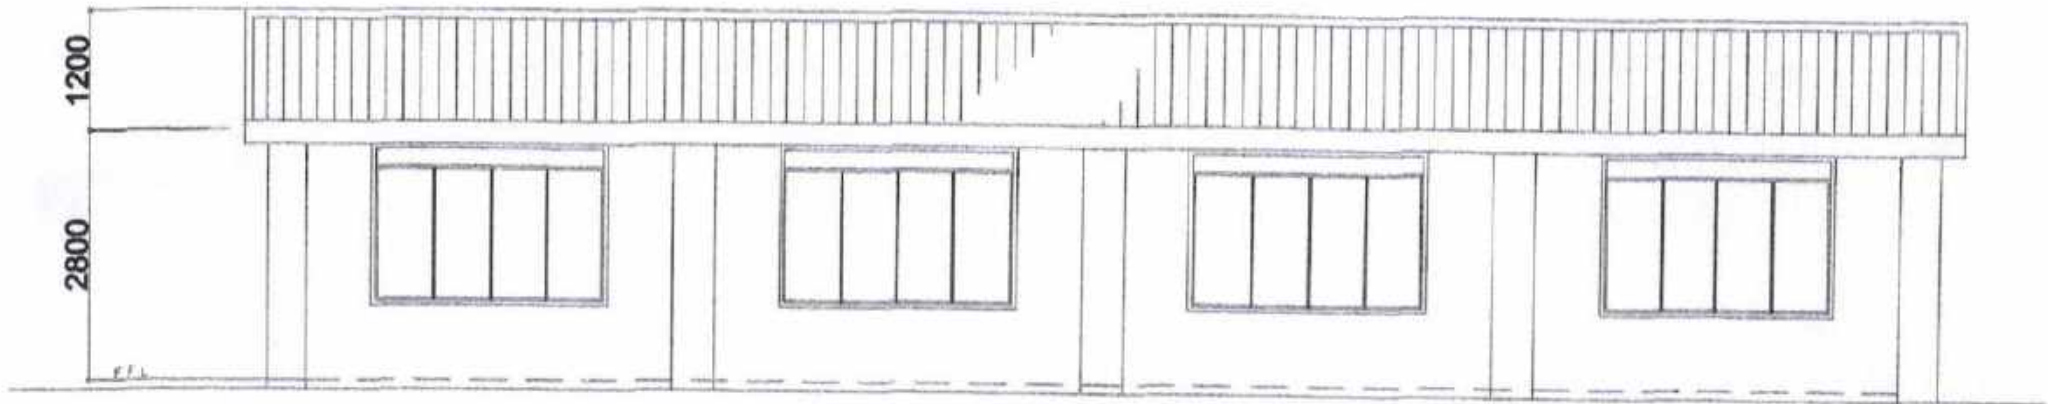

REAR ELEVATION  
SCALE: 1/200

PLEASE SIGN




CITY ENGINEER'S  
OFFICE

PROJECT TITLE:  
REPAIR/IMPROV. OF MULTI-PURPOSE HALL  
(ACADEMIC BLDG.), SALVACION ES  
LOC: BRGY. SALVACION, BACON DISTRICT  
SORSOGON CITY


DRAWN BY:  
Ma Pamela Legaspi  
DRAFTING AIDE

RECOMMENDING APPROVAL:  
ROELO D. DOMER, C.E./RMP  
CITY ENGINEER


APPROVED BY:  
MA. ESTER E. HAMOR  
CITY MAYOR

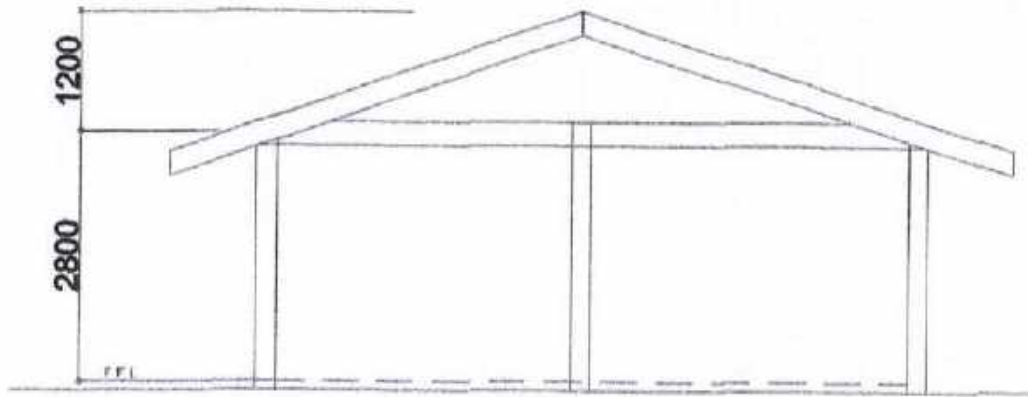


RIGHT SIDE ELEV.  
SCALE: 1:25RTS

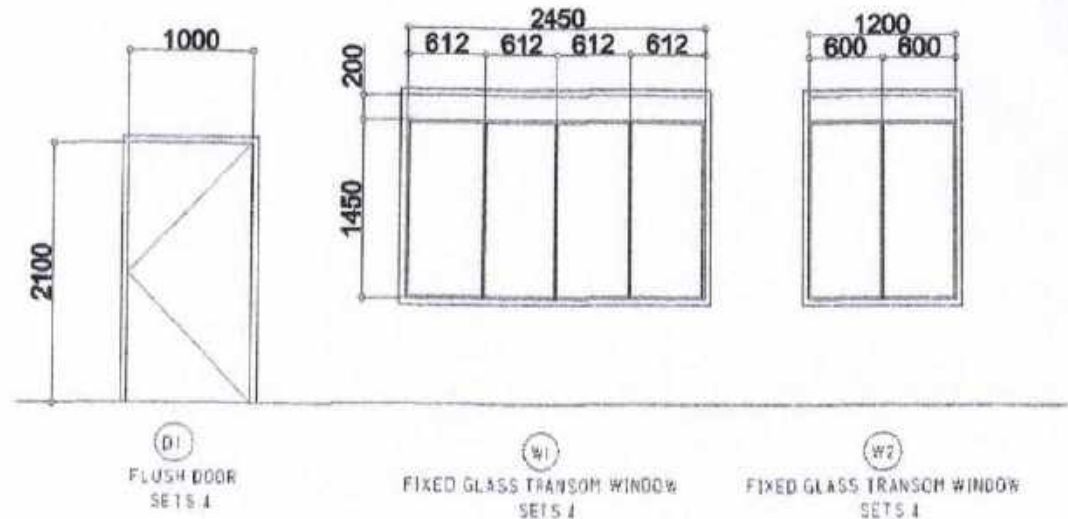

DOORS & WINDOWS SCHEDULE  
SCALE: 1:25RTS

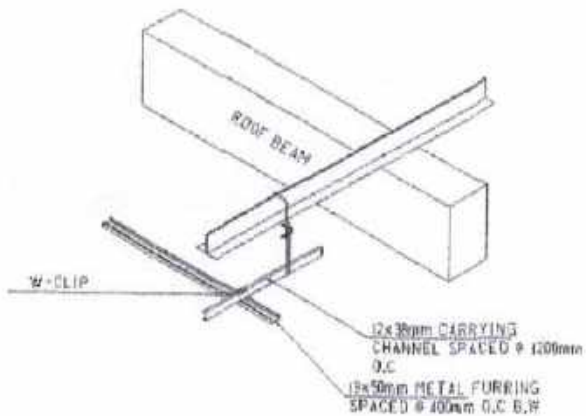

ISOMETRIC DRAWING

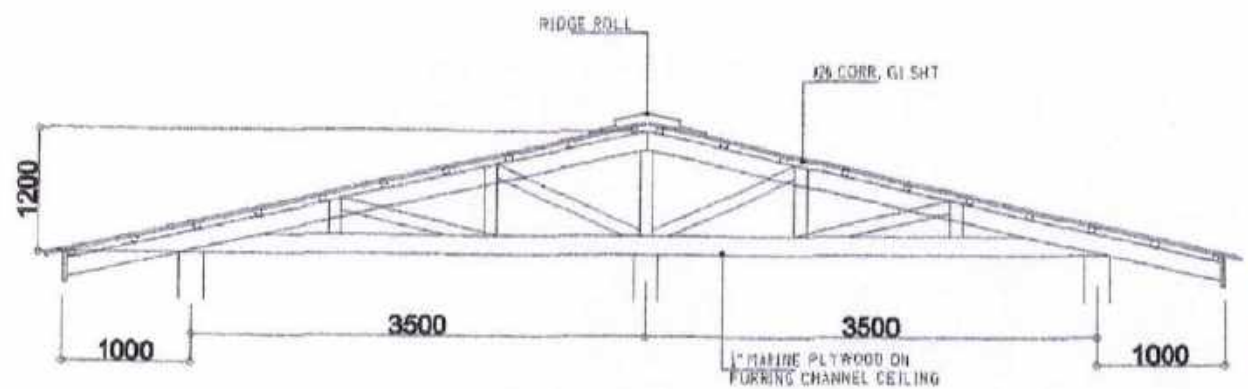

TRUSS DET.  
SCALE: 1:25RTS

PLEASE SIGN



CITY ENGINEER'S  
OFFICE


PROJECT TITLE:  
REPAIR/IMPROV. OF MULTI-PURPOSE HALL  
(ACADEMIC BLDG.), SALVACION ES  
LOC: BRGY. SALVACION, BACON DISTRICT  
SORSOGON CITY

DRAWN BY:  
Ma Pamela Legaspi  
DRAFTING AIDE

RECOMMENDING APPROVAL:  
ROEL D. DOMER, C.E./RMP  
CITY ENGINEER

APPROVED BY:  
MA. ESTER E. HAMOR  
CITY MAYOR



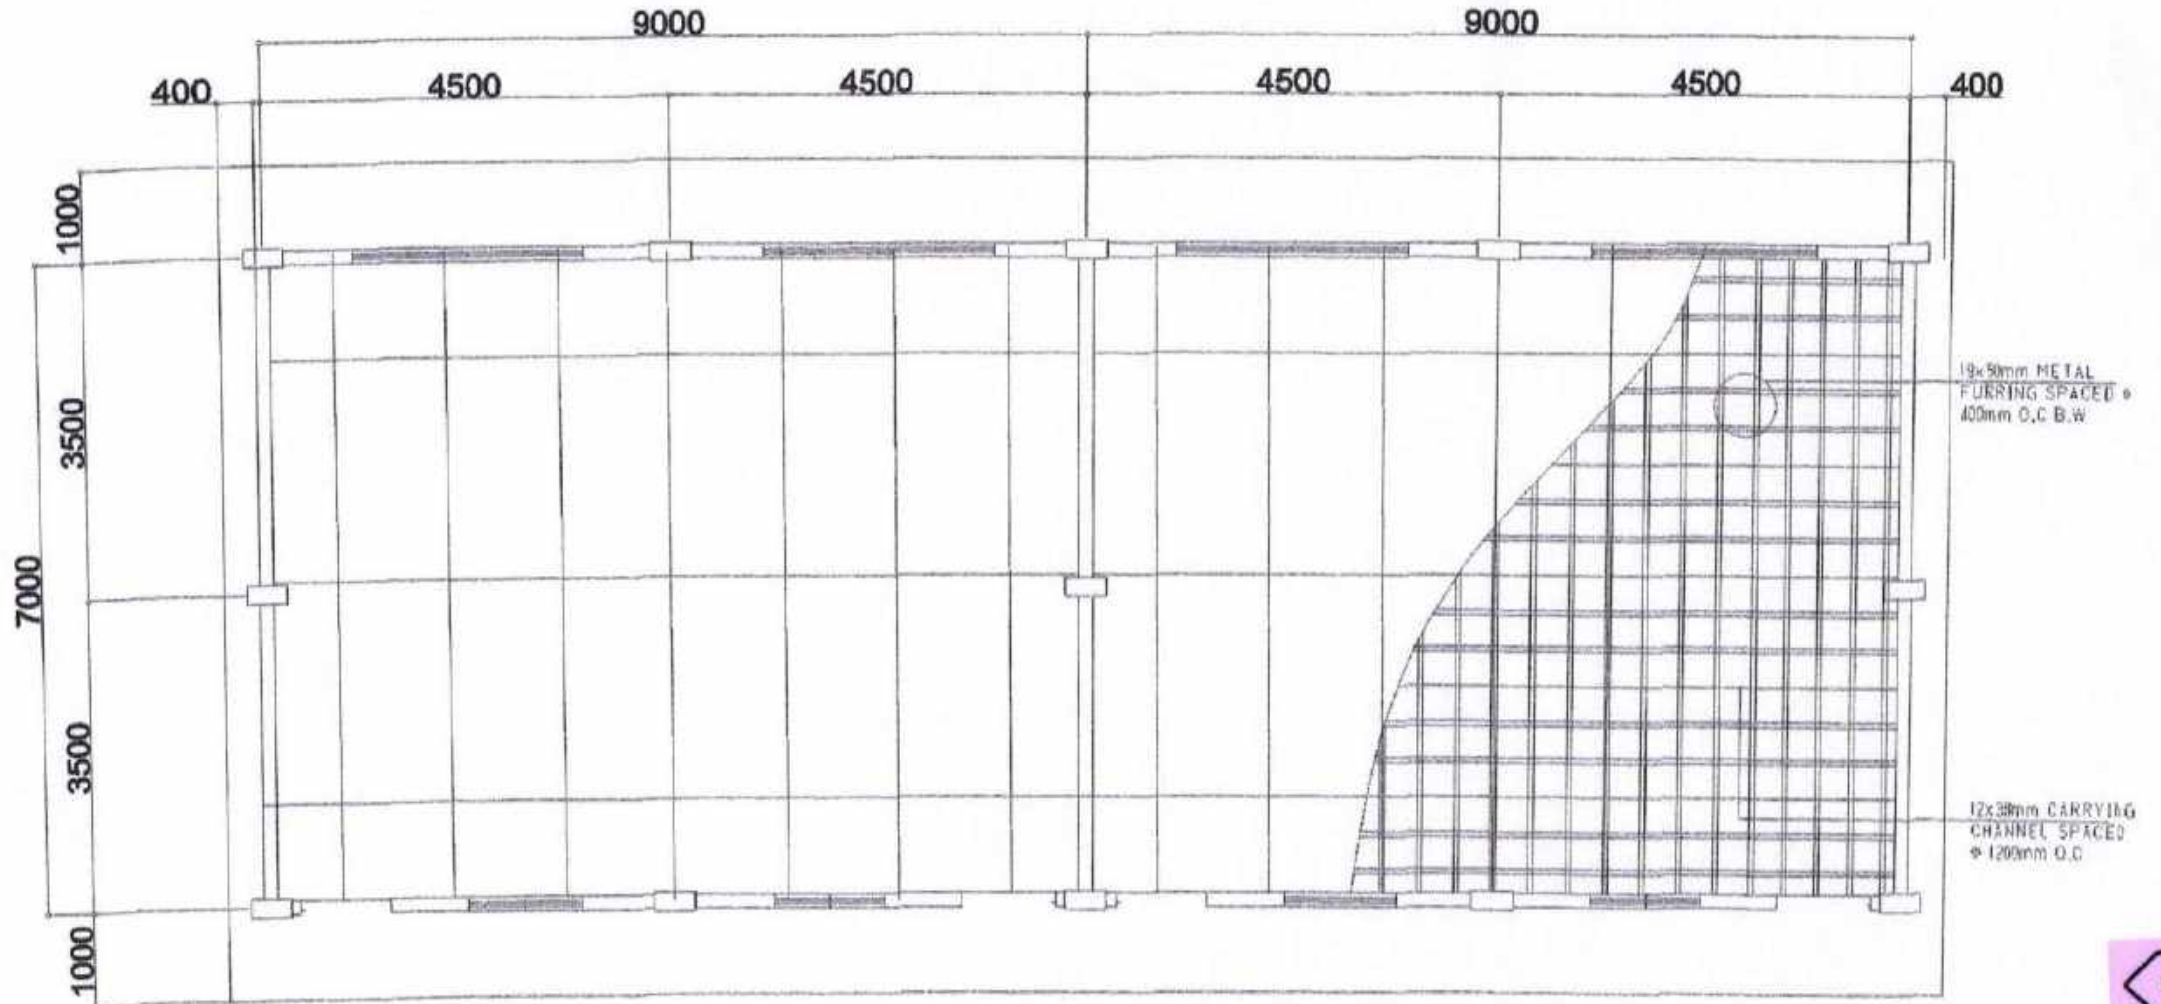

PLEASE SIGN

CEILING PLAN  
SCALE: 1/8"=1'-0"




CITY ENGINEER'S  
OFFICE

PROJECT TITLE:  
REPAIR/IMPROV. OF MULTI-PURPOSE HALL  
(ACADEMIC BLDG.), SALVACION ES  
LOC: BRGY. SALVACION, BACON DISTRICT  
SORSOGON CITY

DRAWN BY:  
Ma Pamela L. Legaspi  
DRAFTING AIDE

RECOMMENDING APPROVAL:  
ROEL D. DOMER, C.E./RMP  
CITY ENGINEER

APPROVED BY:  
MA. ESTER E. HAMOR  
CITY MAYOR

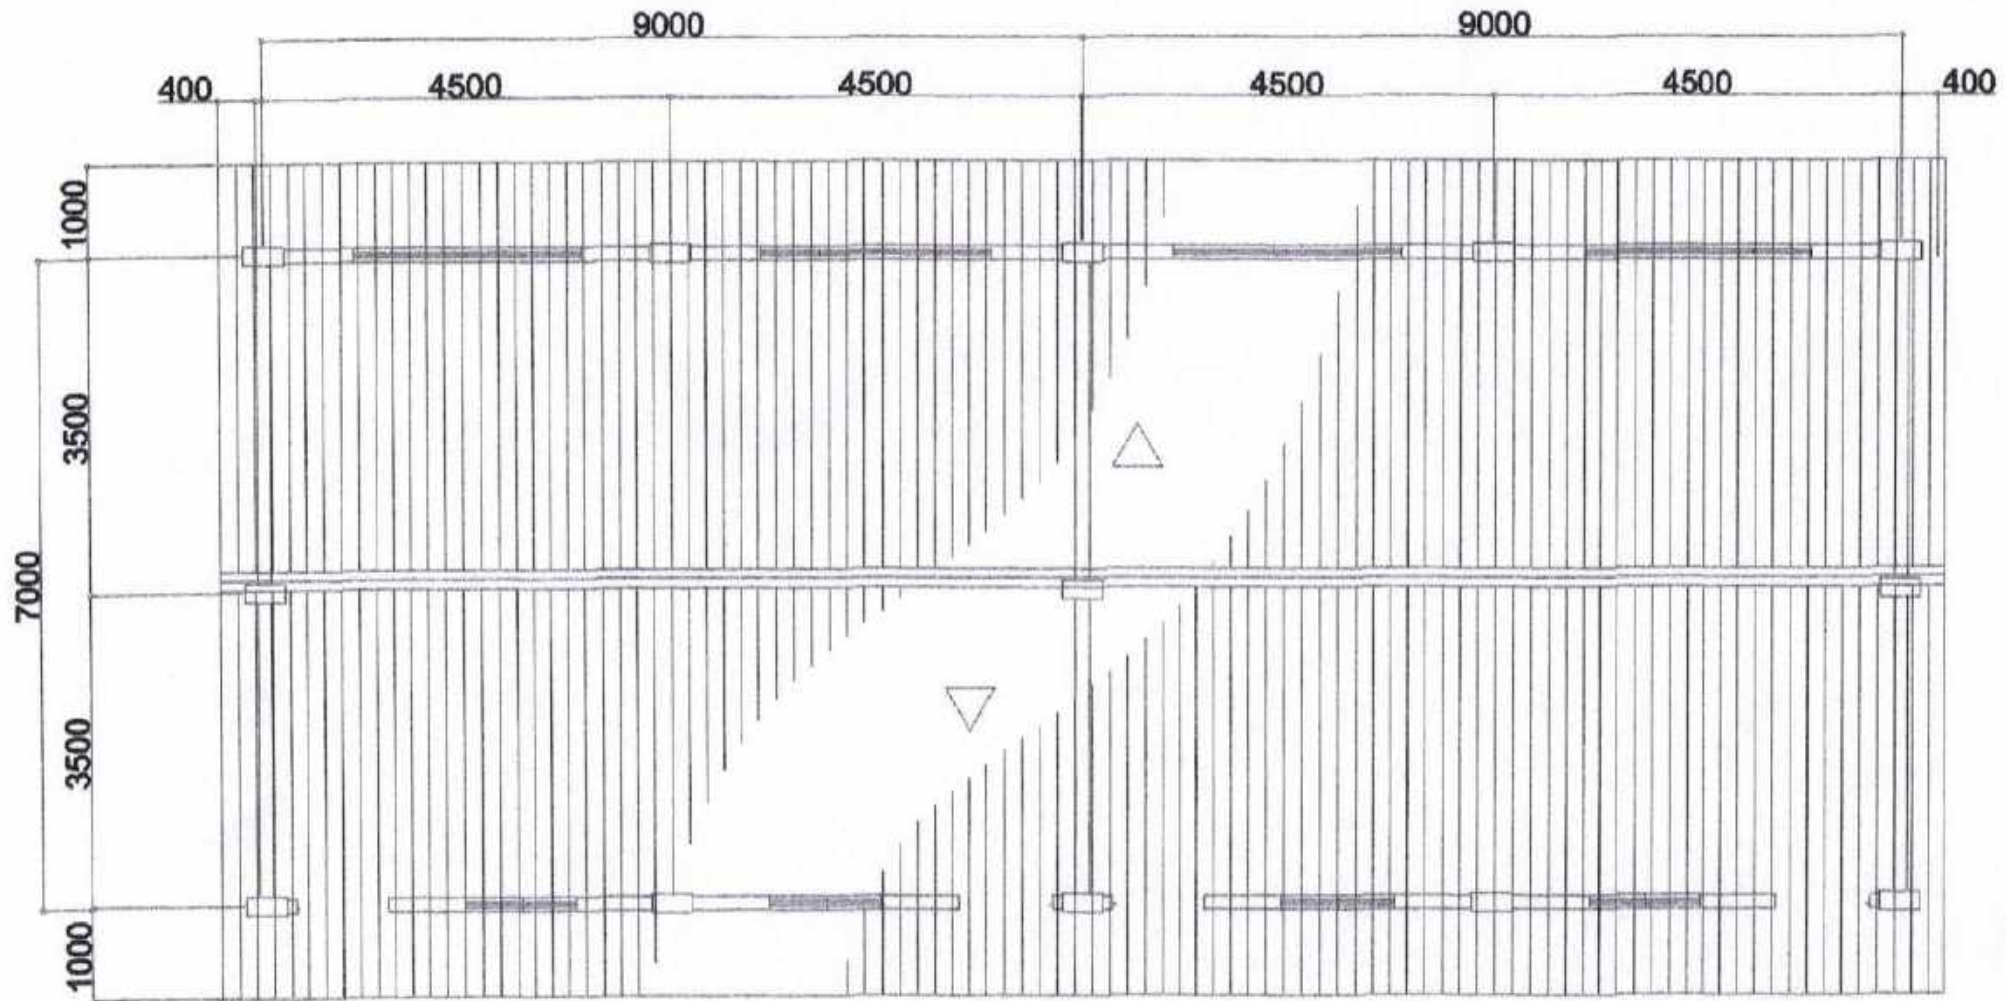

ROOF PLAN  
SCALE: 1/8" = 1'-0"

PLEASE SEE



**CITY ENGINEER'S  
OFFICE**

PROJECT TITLE:

REPAIR/IMPROV. OF MULTI-PURPOSE HALL  
(ACADEMIC BLDG.), SALVACION ES

LOC: BRGY. SALVACION, BACON DISTRICT  
SORSOGON CITY

DRAWN BY:


Ma Pamela Legaspi  
DRAFTING AIDE

RECOMMENDING APPROVAL:

*[Signature]*  
ROBERT D. DOMER, C.E./RMP  
CITY ENGINEER

APPROVED BY:

*[Signature]*  
MA. ESTER E. HAMOR  
CITY MAYOR

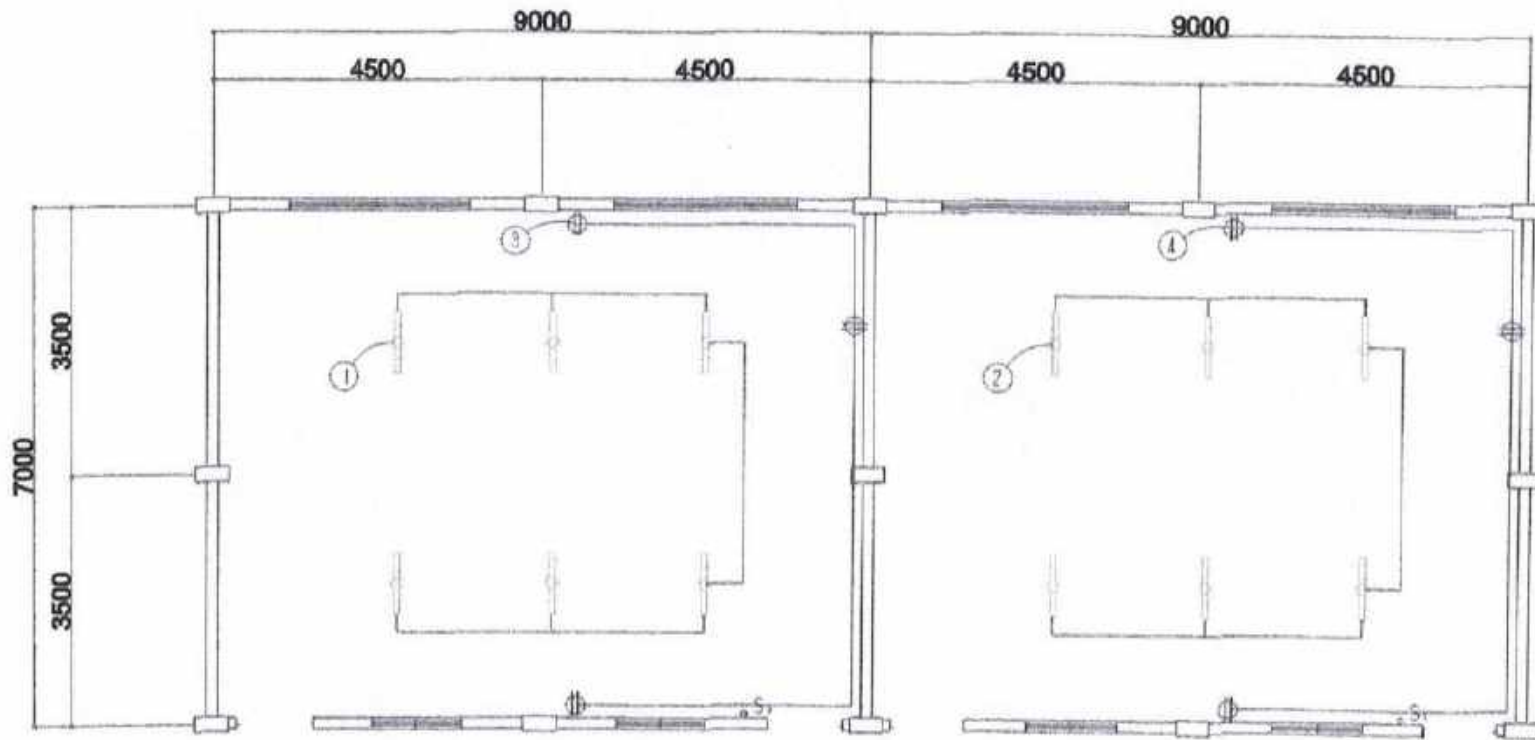

**ELECTRICAL NOTES**

ALL ELECTRICAL WORKS SHALL BE DONE IN ACCORDANCE WITH THE LATEST RULES AND REGULATIONS OF THE PHIL. ELECTRICAL CODE AS WELL AS THE LOCAL AUTHORITY CONCERNED AND THE LOCAL POWER COMPANY.

ALL ELECTRICAL MATERIALS TO BE USED SHALL BE NEED & APPROVED TYPE FOR LOCATION & PURPOSE

MOUNTING HEIGHTS SHALL BE AS FOLLOWS:

- a. LIGHT CONTROL SWITCH- 1.35M ABOVE FIN. FLR. LINE AT CENTER
- b. CONVENIENCE OUTLET-ABOVE 1.0M ABOVE FIN. FLR. LINE AT CENTER
- c. PANEL BOARD- 2.0 M ABOVE FIN. FLR. LINE

ALL ELECTRICAL WORKS SHALL BE UNDER THE DIRECT & IMMEDIATE SUPERVISION OF A DULY LICENSED ELECTRICAL ENGINEER OR REGISTERED MASTER ELECTRICIAN

**ELECTRICAL PLAN**

SCHEDULE OF LOADS							
CIRCUIT NO.	DESCRIPTION	NO. OF LOADS	VOLTS	WATTS	AMP	SIZE OF WIRE	SIZE OF CONDUIT
1	LIGHTING OUTLET	6	230	600	2.60	2-2.0mm <sup>2</sup> THW	15mm $\phi$
2	LIGHTING OUTLET	6	230	600	2.60	2-2.0mm <sup>2</sup> THW	15mm $\phi$
3	CONVENIENCE OUTLET	3	230	540	2.34	2-3.5mm <sup>2</sup> THW	20mm $\phi$
4	CONVENIENCE OUTLET	3	230	540	2.34	2-3.5mm <sup>2</sup> THW	20mm $\phi$
TOTAL					9.88		

PLEASE SIGN



**CITY ENGINEER'S OFFICE**


PROJECT TITLE:  
REPAIR/IMPROV. OF MULTI-PURPOSE HALL  
(ACADEMIC BLDG.), SALVACION ES  
LOC: BRGY. SALVACION, BACON DISTRICT  
SORSOGON CITY

DRAWN BY:  
Mo Pamela Legaspi  
DRAFTING AIDE

RECOMMENDING APPROVAL:  
  
ROEL D. DOMAN, C.E./RMP  
CITY ENGINEER


APPROVED BY:  
  
MA. ESTER E. HAMOR  
CITY MAYOR




**SALVACION ELEMENTARY SCHOOL  
ACADEMIC SCHOOL BUILDING (2 UNITS)**

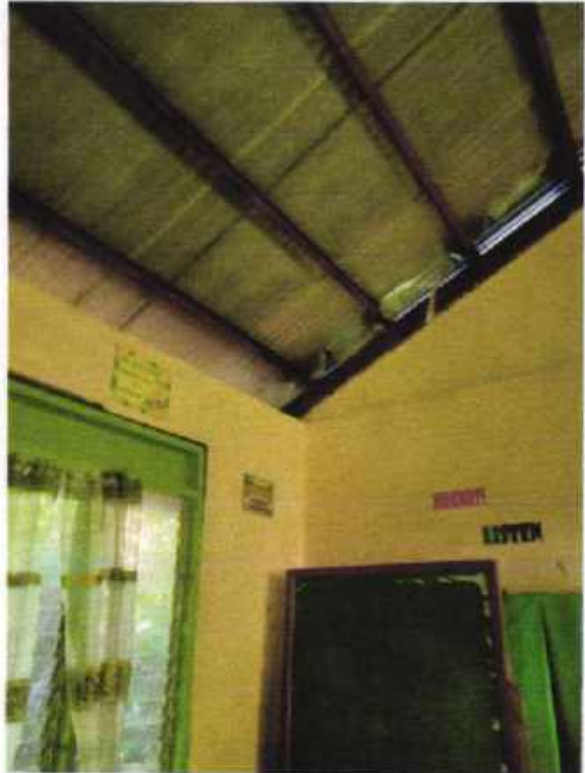

**SALVACION ELEMENTARY SCHOOL**

**PROJECT CARE BUILDING (2 UNITS)**

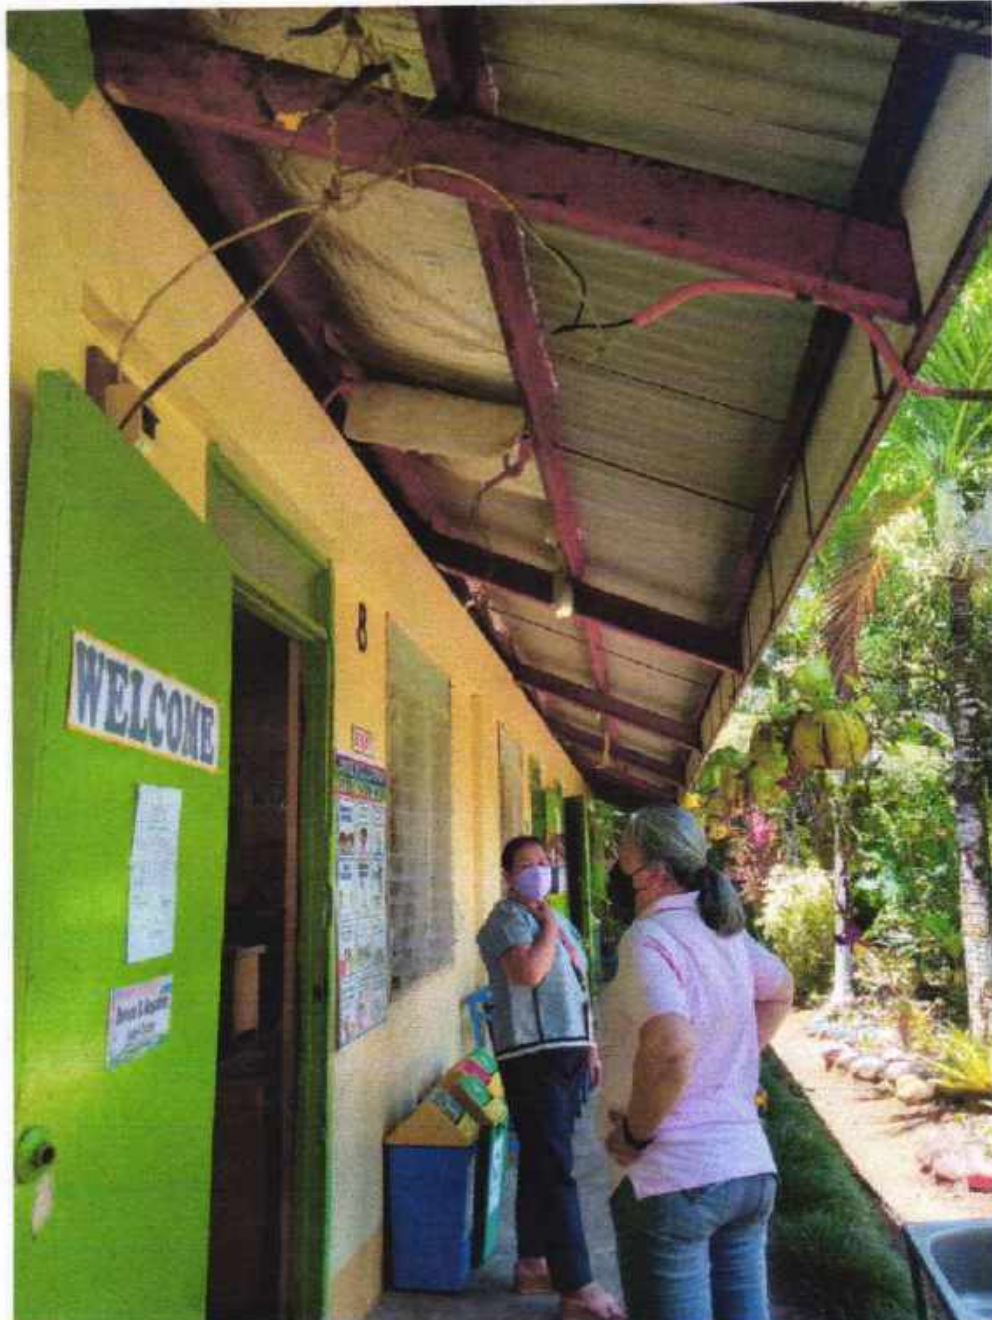

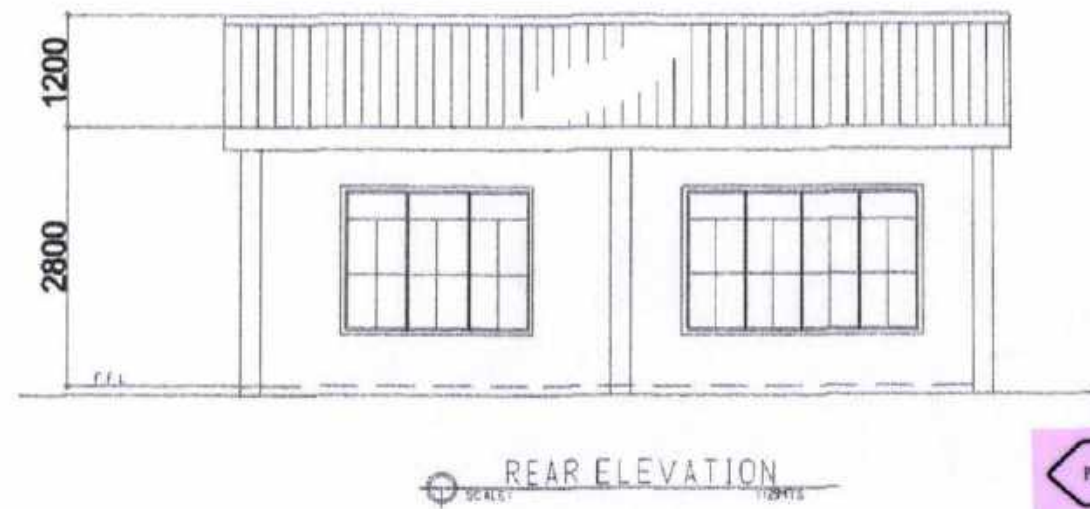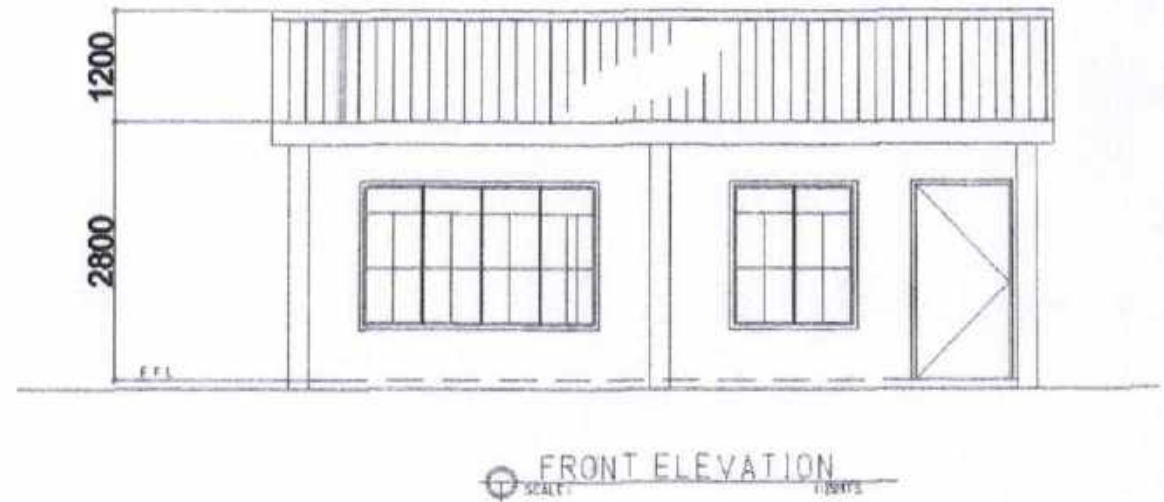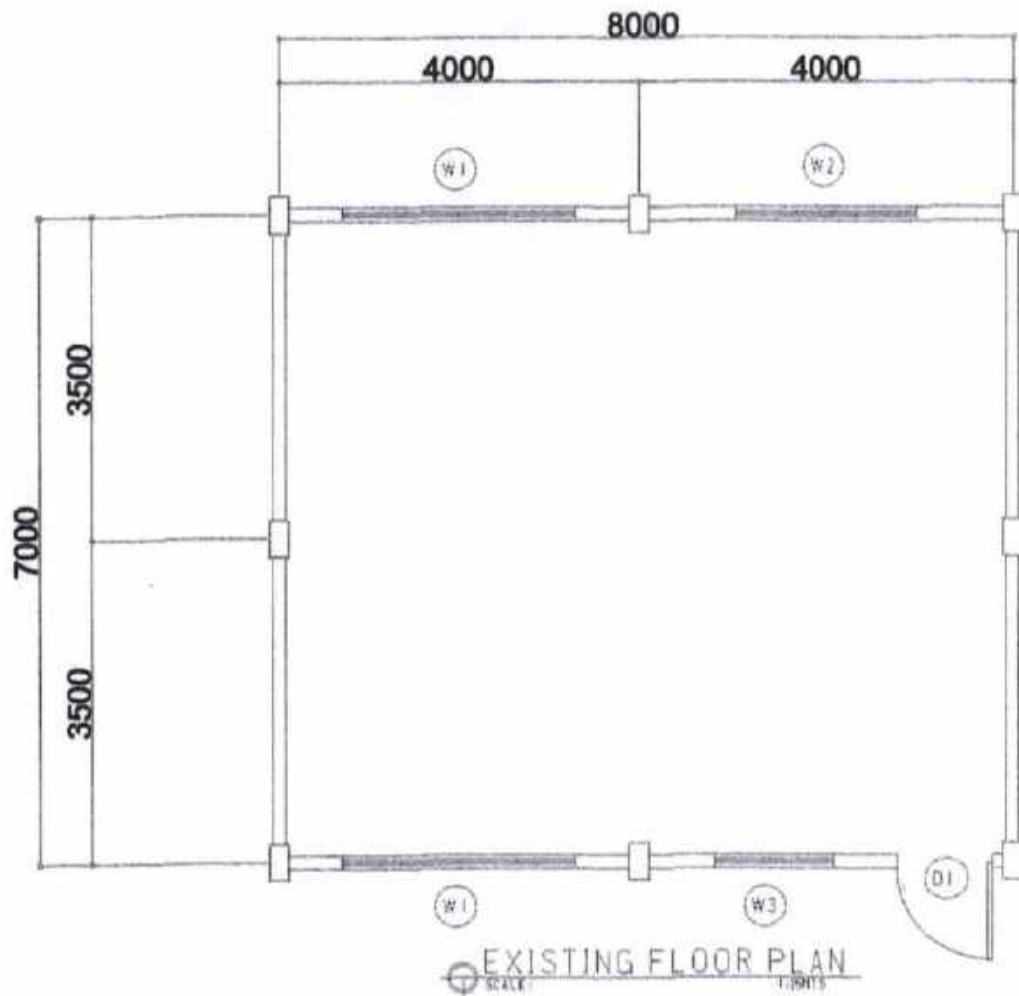


**CITY ENGINEER'S  
OFFICE**


PROJECT TITLE:  
REPAIR/IMPROV. OF MULTI-PURPOSE HALL  
(ROOM NO. 4), GATBO NATIONAL HS  
LOC: BRGY. GATBO, BACON DISTRICT  
SORSOGON CITY

DRAWN BY:  
Ma Pamela Lagaspi  
DRAFTING AIDE


RECOMMENDING APPROVAL:  
  
ROEL D. BOMAR, C.E./RMP  
CITY ENGINEER

APPROVED BY:  
  
MA. ESTER E. HAMOR  
CITY MAYOR


PLEASE SIGN

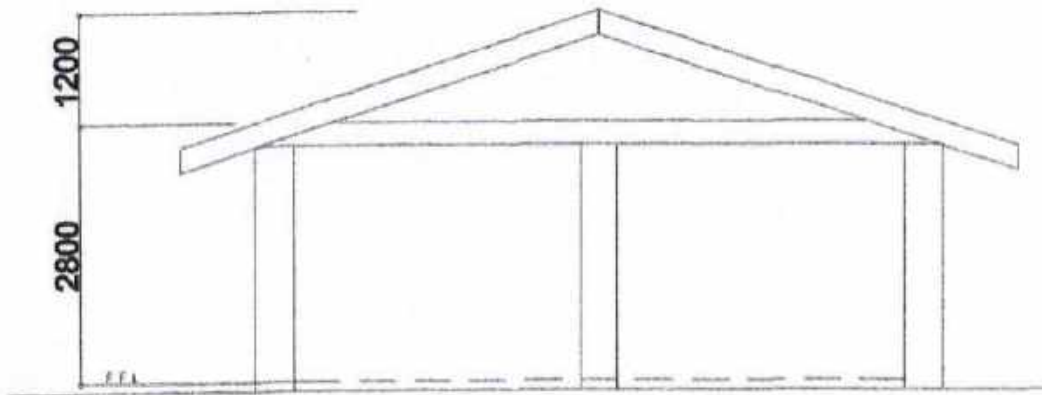

RIGHT SIDE ELEV.  
SCALE: 1/25HTS

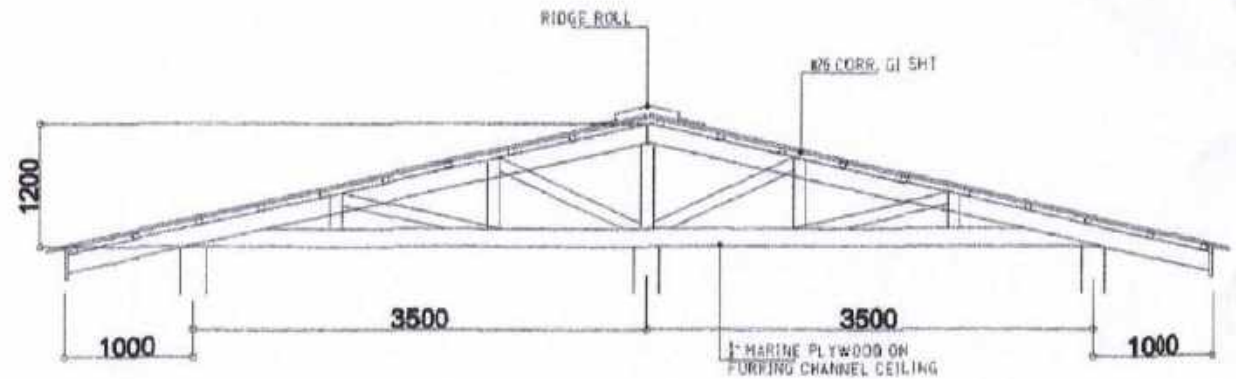


TRUSS DET.  
SCALE: 1/25HTS

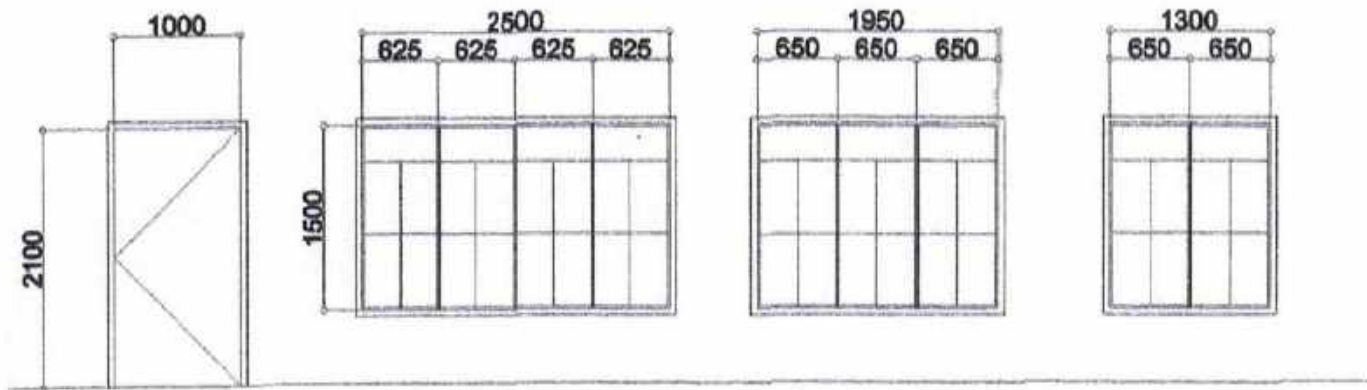

(D1) FLUSH DOOR SET 1  
(W1) STEEL CASEMENT WINDOW SETS 2  
(W2) STEEL CASEMENT WINDOW SET 1  
(W3) STEEL CASEMENT WINDOW SET 1

DOORS & WINDOWS SCHEDULE  
SCALE: 1/25HTS

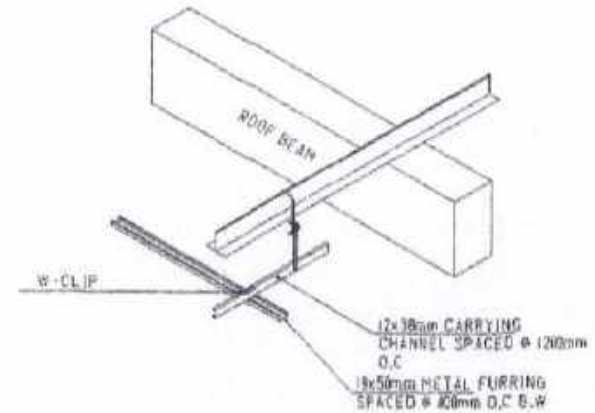

ISOMETRIC DRAWING

PLEASE SIGN




CITY ENGINEER'S  
OFFICE

PROJECT TITLE:  
REPAIR/IMPROV. OF MULTI-PURPOSE HALL  
(ROOM NO. 4), GATBO NATIONAL HS  
LOC: BRGY. GATBO, BACON DISTRICT  
SORSOGON CITY


DRAWN BY:  
MaPanale Legaspi  
DRAFTING AIDE

RECOMMENDING APPROVAL:  
ROEL D. DOMER, C.E./RMP  
CITY ENGINEER

APPROVED BY:  
MA. ESTER E. HAMOR  
CITY MAYOR

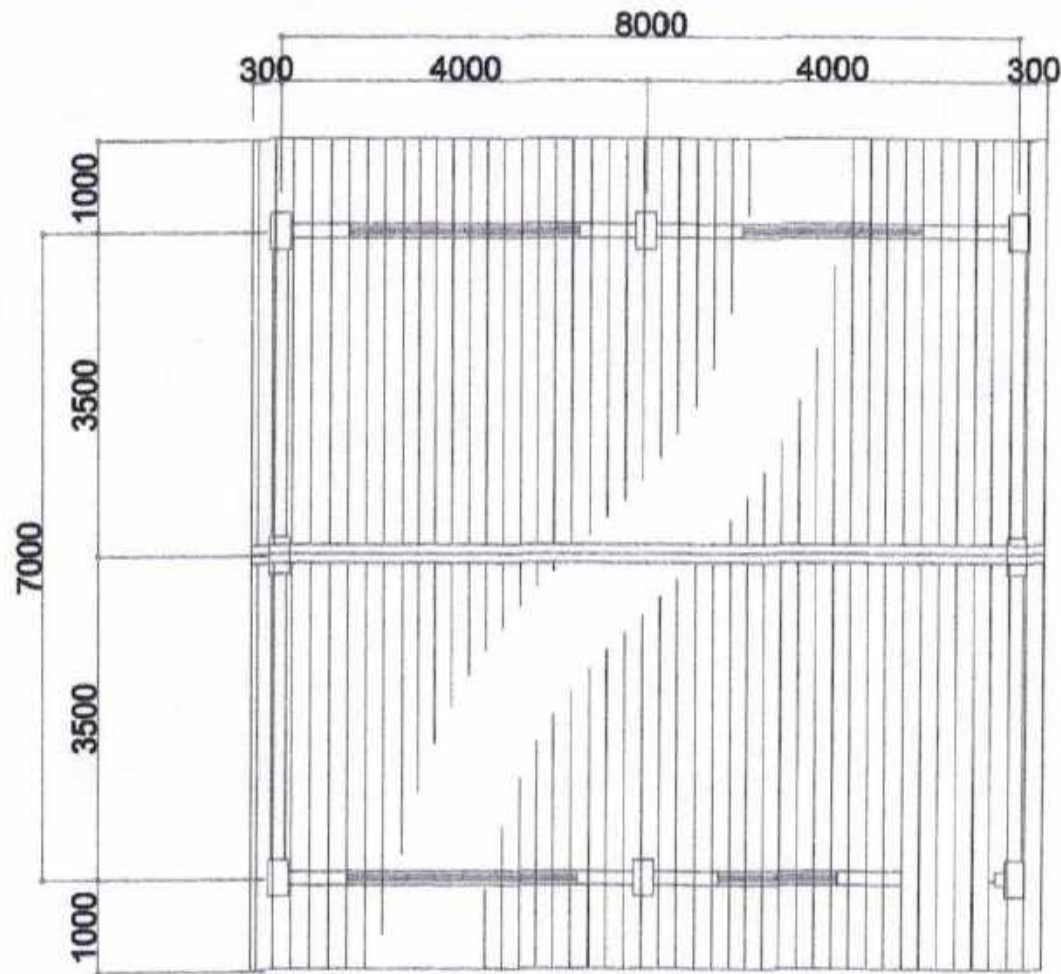

ROOF PLAN  
SCALE: 1/20PTS

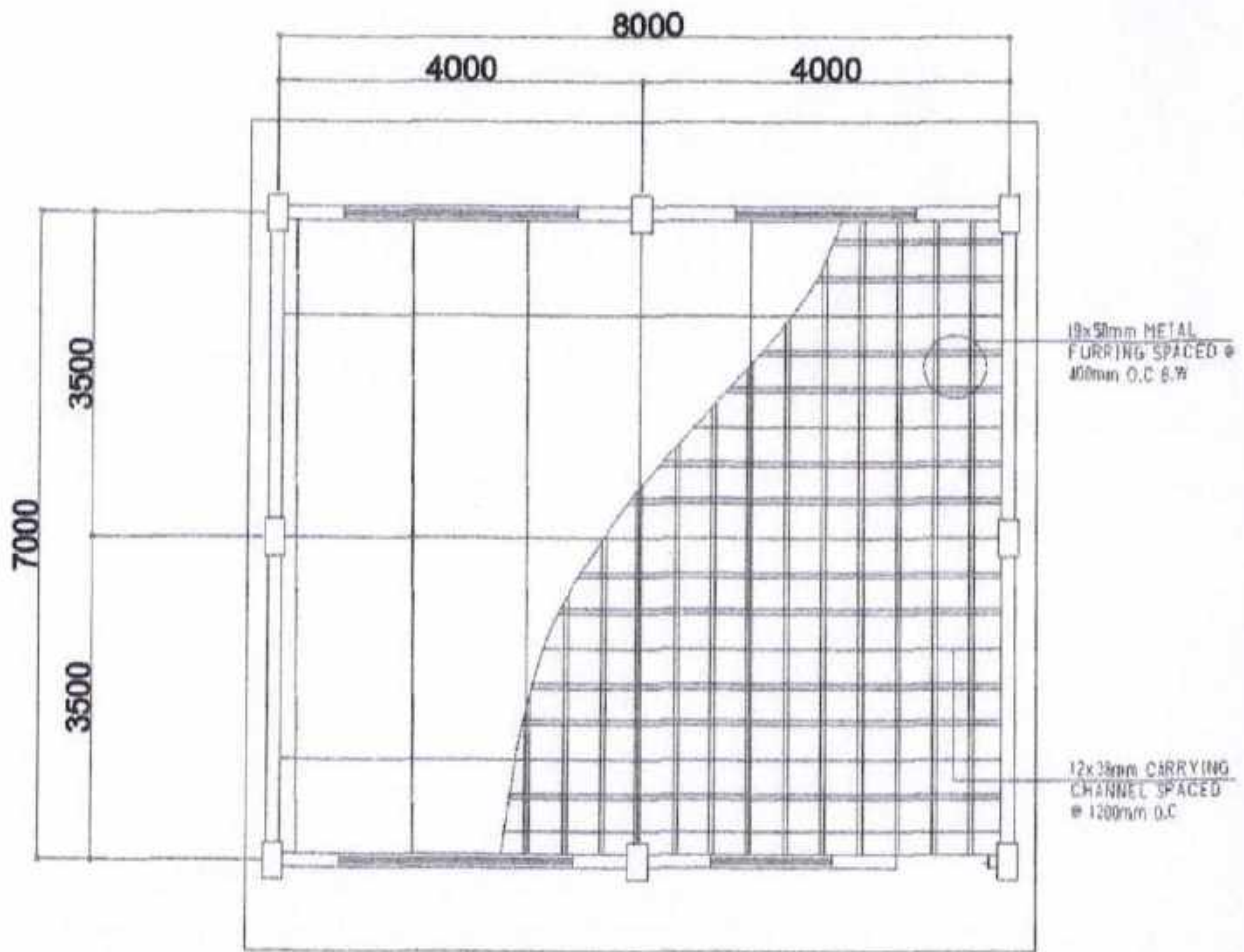

CEILING PLAN  
SCALE: 1/20PTS

PLEASE SIGN



CITY ENGINEER'S  
OFFICE


PROJECT TITLE:  
REPAIR/IMPROV. OF MULTI-PURPOSE HALL  
(ROOM NO. 4), GATBO NATIONAL HS  
LOC: BRGY. GATBO, BACON DISTRICT  
SORSOGON CITY

DRAWN BY:  
Ma Pamela Legaspi  
DRAFTING AIDE

RECOMMENDING APPROVAL:  
ROEL D. DOMER, C.E./RMP  
CIC-CITY ENGINEER

APPROVED BY:  
MA. ESTER E. HAMOR  
CITY MAYOR



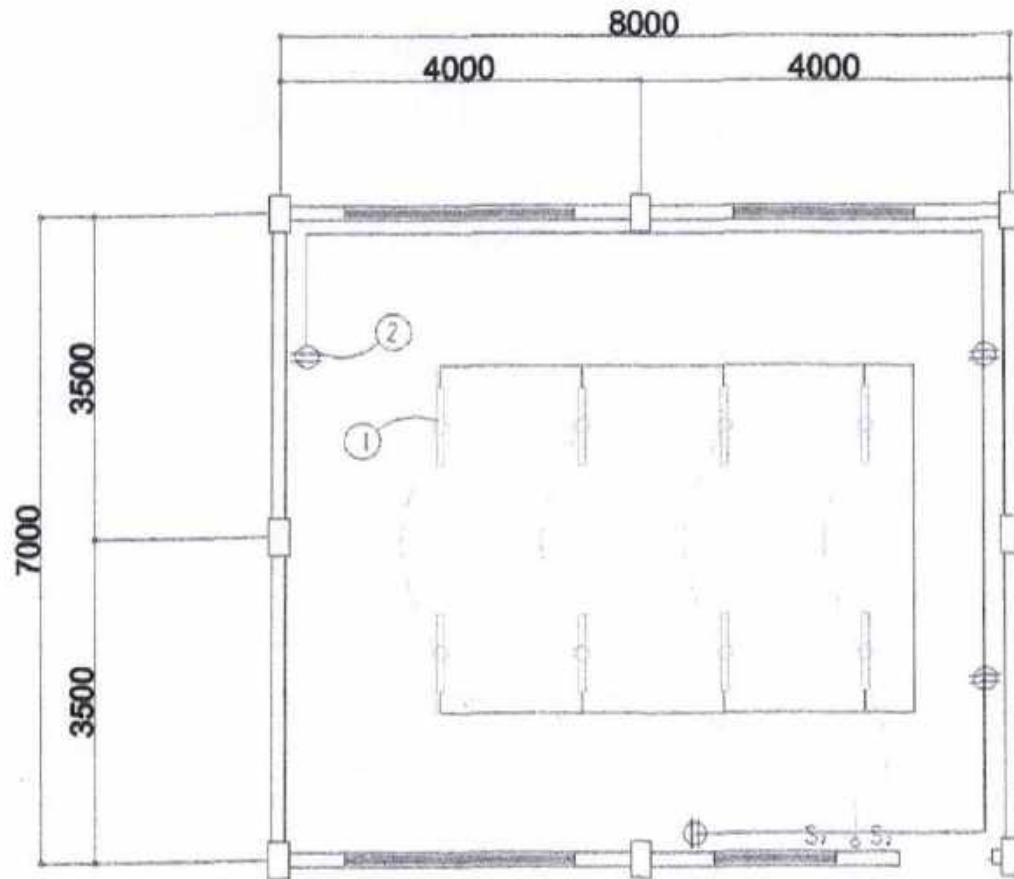

ELECTRICAL PLAN  
SCALE: 1:200

**ELECTRICAL NOTES**

ALL ELECTRICAL WORKS SHALL BE DONE IN ACCORDANCE WITH THE LATEST RULES AND REGULATIONS OF THE PHIL. ELECTRICAL CODE AS WELL AS THE LOCAL AUTHORITY CONCERNED AND THE LOCAL POWER COMPANY.

ALL ELECTRICAL MATERIALS TO BE USED SHALL BE NEED & APPROVED TYPE FOR LOCATION & PURPOSE

MOUNTING HEIGHTS SHALL BE AS FOLLOWS:

- a. LIGHT CONTROL SWITCH- 1.35M ABOVE FIN. FLR. LINE AT CENTER
- b. CONVENIENCE OUTLET-ABOVE 1.0M ABOVE FIN. FLR. LINE AT CENTER
- c. PANEL BOARD- 2.0 M ABOVE FIN. FLR. LINE

ALL ELECTRICAL WORKS SHALL BE UNDER THE DIRECT & IMMEDIATE SUPERVISION OF A DULY LICENSED ELECTRICAL ENGINEER OR REGISTERED MASTER ELECTRICIAN

**SCHEDULE OF LOADS**

CIRCUIT NO.	DESCRIPTION	NO. OF LOADS	VOLTS	WATTS	AMP	SIZE OF WIRE	SIZE OF CONDUIT
1	LIGHTING OUTLET	8	230	800	3.48	2-2.0mm <sup>2</sup> THW	15mm $\varnothing$
2	CONVENIENCE OUTLET	4	230	720	3.13	2-3.5mm <sup>2</sup> THW	20mm $\varnothing$
	<b>TOTAL</b>				<b>6.61</b>		



**CITY ENGINEER'S  
OFFICE**

PROJECT TITLE:

REPAIR/IMPROV. OF MULTI-PURPOSE HALL  
(ROOM NO. 4), GATBO NATIONAL HS

LOC: BRGY. GATBO, BACON DISTRICT  
SORSOGON CITY

DRAWN BY:

Ma Pamela Legaspi  
DRAFTING AIDE


RECOMMENDING APPROVAL:

ROEL D. DOMER, C.E./RMP  
CITY ENGINEER


APPROVED BY:

MA. ESTER E. HAMOR  
CITY MAYOR


PLEASE STAMP

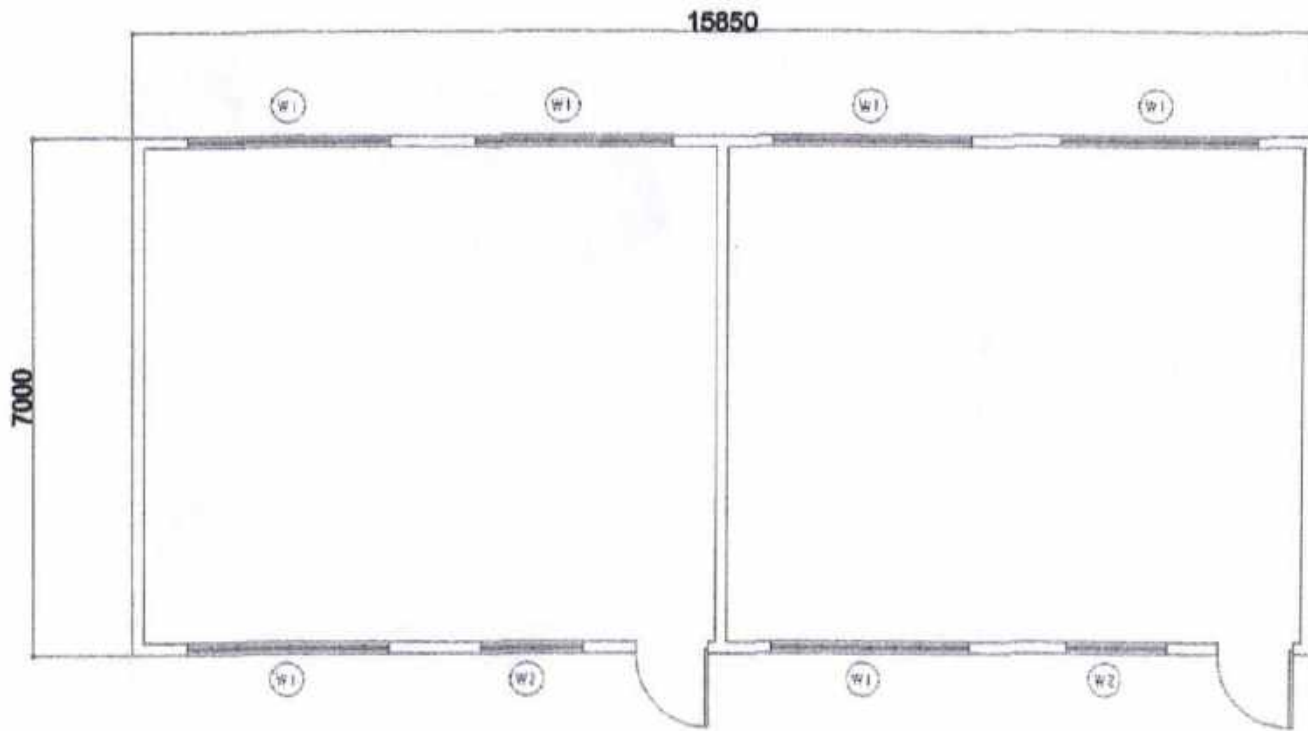

EXISTING FLOOR PLAN  
SCALE: 1/8"=1'-0"

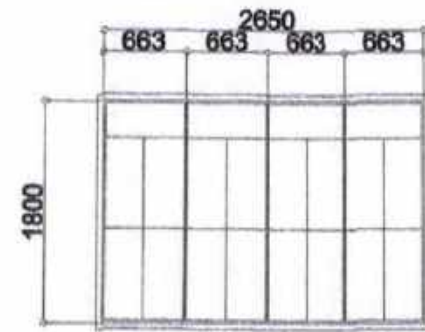

W1  
STEEL CASEMENT WINDOW SETS 6

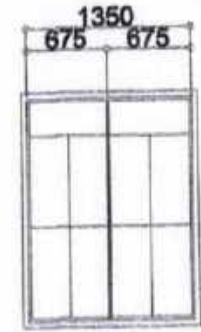

W2  
STEEL CASEMENT WINDOW SETS 2

WINDOWS SCHEDULE  
SCALE: 1/8"=1'-0"



CITY ENGINEER'S  
OFFICE




PROJECT TITLE:  
REPAIR/IMPROV. OF MULTI-PURPOSE HALL  
(GRADE 8 & 9 BLDG.), GATBO NATIONAL HS  
LOC: BRGY. GATBO, BACON DISTRICT  
SORSOGON CITY

DRAWN BY:  
MaPamela Legaspi  
DRAFTING AIDE

RECOMMENDING APPROVAL:  
ROEL D. DOMER, C.E./RMP  
CITY ENGINEER

APPROVED BY:  
MA. ESTER E. HAMOR  
CITY MAYOR

PLEASE SIGN

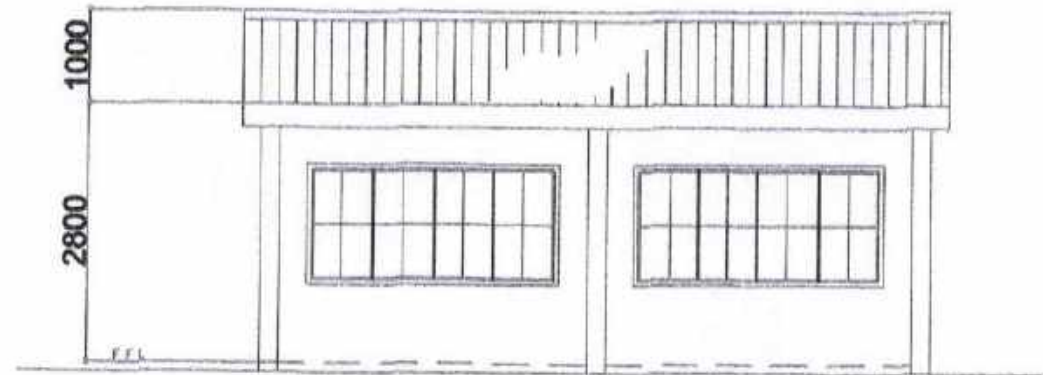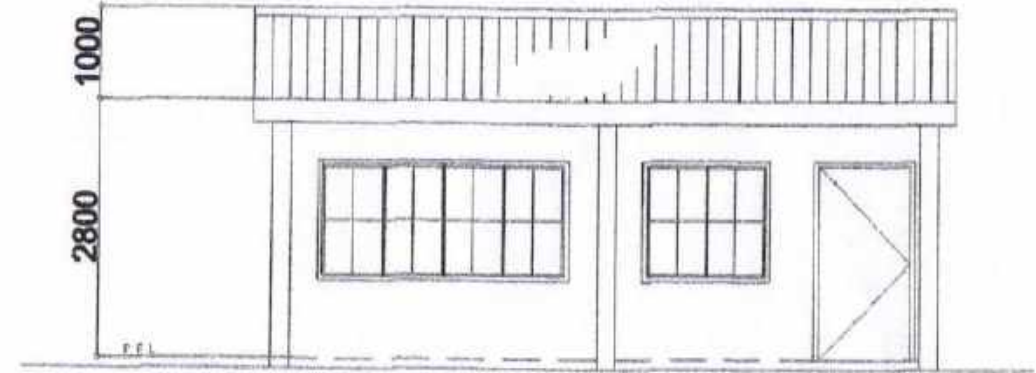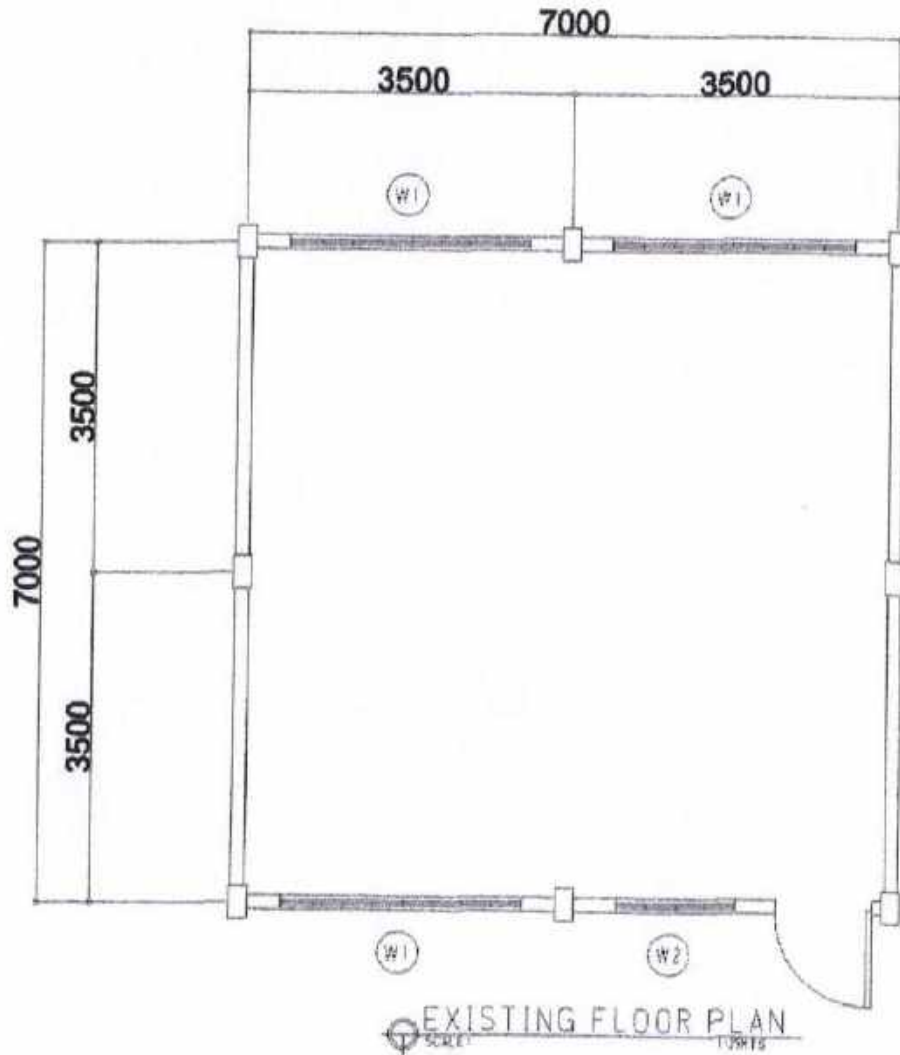

**CITY ENGINEER'S  
OFFICE**




PROJECT TITLE:  
REPAIR/IMPROV. OF MULTI-PURPOSE HALL  
(GRADE 10 BLDG.), GATBO NATIONAL HS  
LOC: BRGY. GATBO, BACON DISTRICT  
SORSOGON CITY

DRAWN BY:  
Ma Pamela Legaspi  
DRAFTING AIDE

RECOMMENDING APPROVAL:  
ROEL D. DOMER, C.E./RMP  
CITY ENGINEER

APPROVED BY:  
MA. ESTER E. HAMOR  
CITY MAYOR

PLEASE SIGN

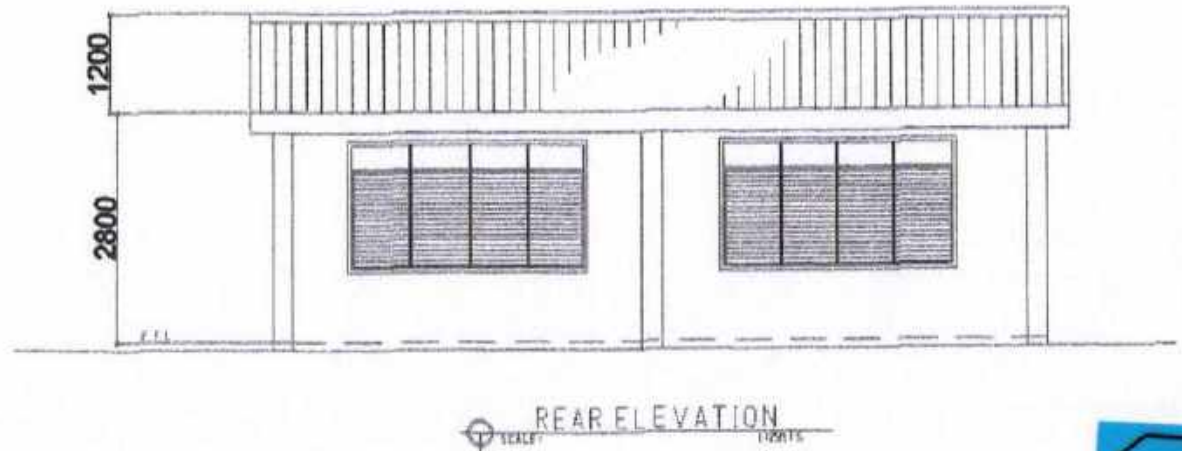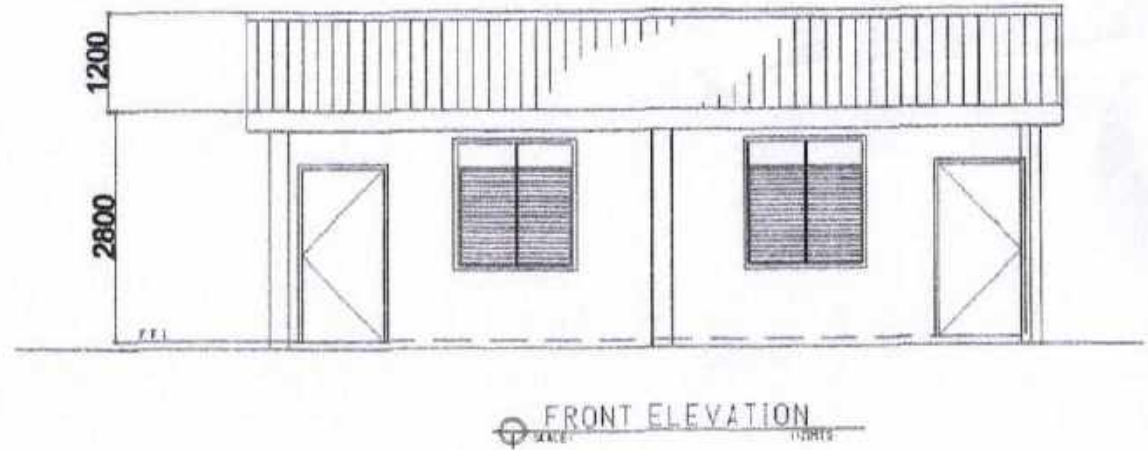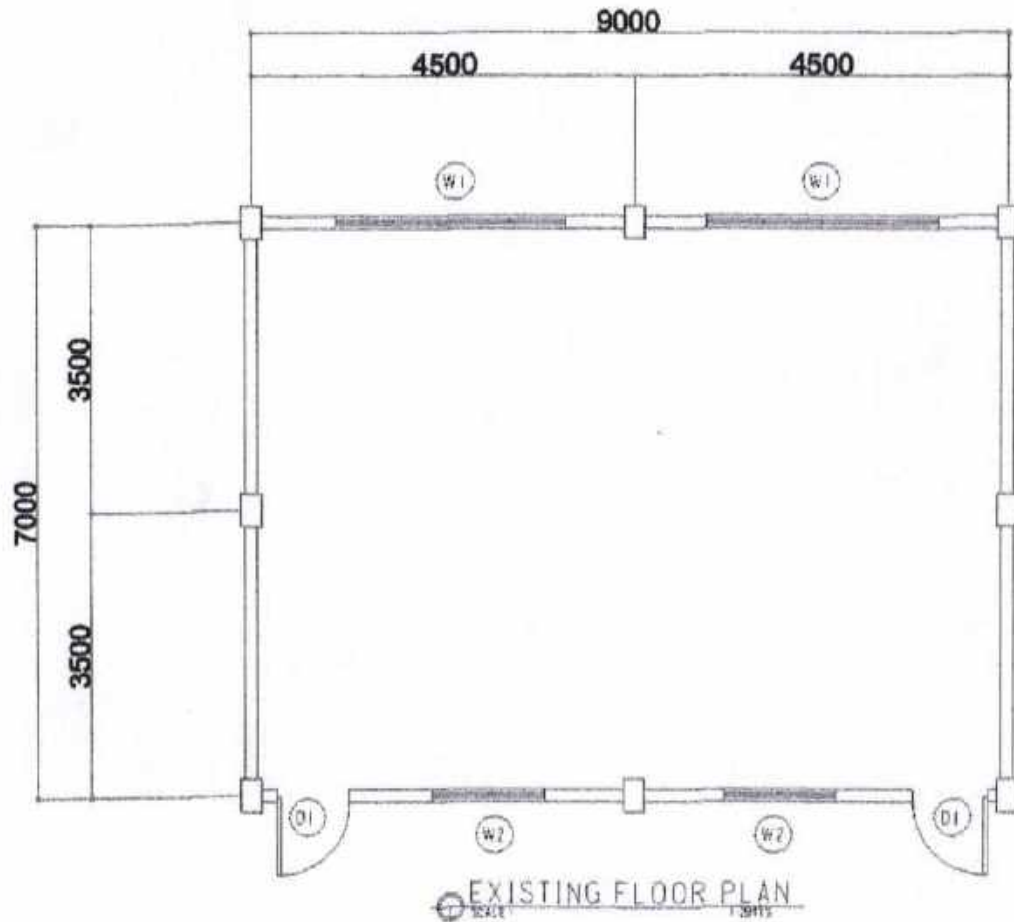

PLEASE SIGN HERE




CITY ENGINEER'S  
OFFICE

PROJECT TITLE:  
REPAIR/IMPROV. OF MULTI-PURPOSE HALL  
(GRADE 11 BLDG.), GATBO NATIONAL HS  
LOC: BRGY. GATBO, BACON DISTRICT  
SORSOGON CITY


DRAWN BY:  
Ma Pamela Legaspi  
DRAFTING AIDE

RECOMMENDING APPROVAL:  
ROEL D. DOMER, C.E./RMP  
CITY ENGINEER

APPROVED BY:  
MA. ESTER E. HAMOR  
CITY MAYOR

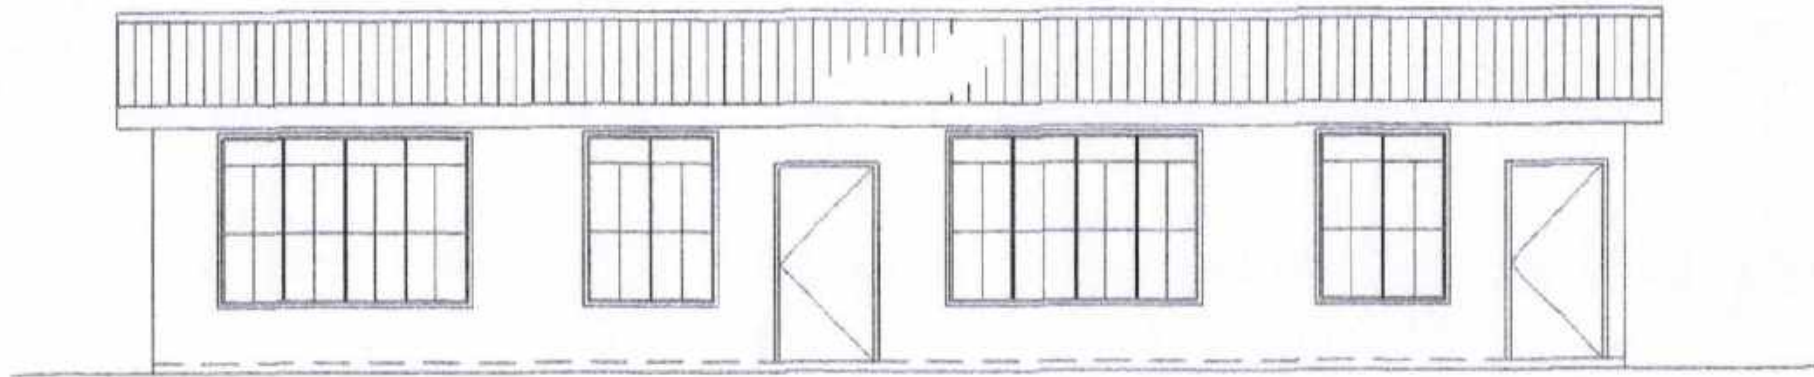

FRONT ELEVATION  
SCALE: 1/8"=1'-0"

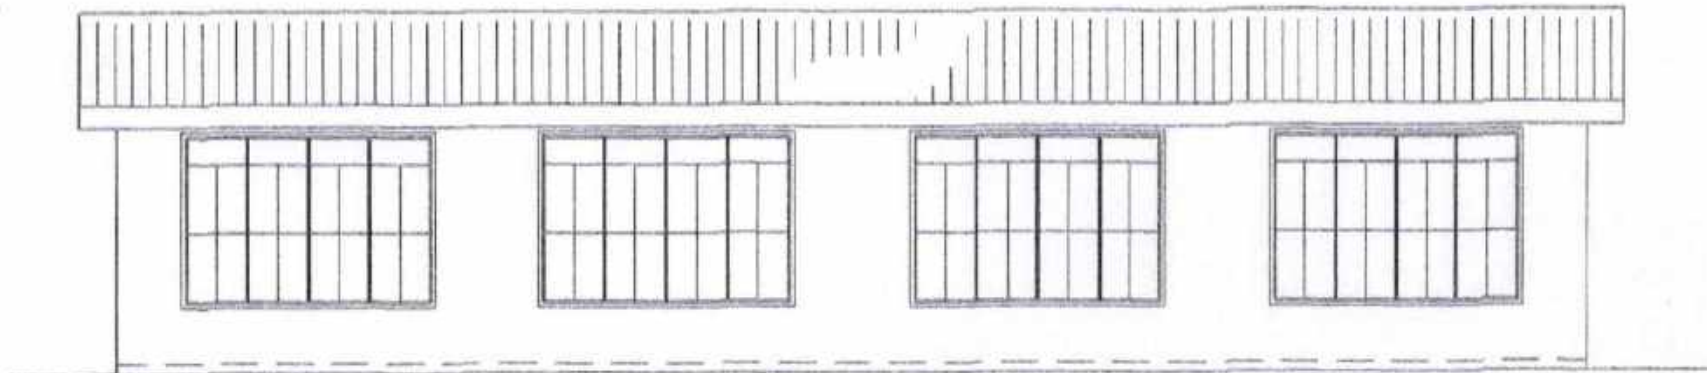

REAR ELEVATION  
SCALE: 1/8"=1'-0"

PLEASE SIGN



CITY ENGINEER'S  
OFFICE

PROJECT TITLE:

REPAIR/IMPROV. OF MULTI-PURPOSE HALL  
(GRADE 8 & 9 BLDG.), GATBO NATIONAL HS

LOC: BRGY. GATBO, BACON DISTRICT  
SORSOGON CITY

DRAWN BY:


Ma Pamela Legaspi  
DRAFTING AIDE

RECOMMENDING APPROVAL:


ROEL D. BOMER, C.E./RMP  
CITY ENGINEER

APPROVED BY:

MA. ESTER B. HAMOR  
CITY MAYOR

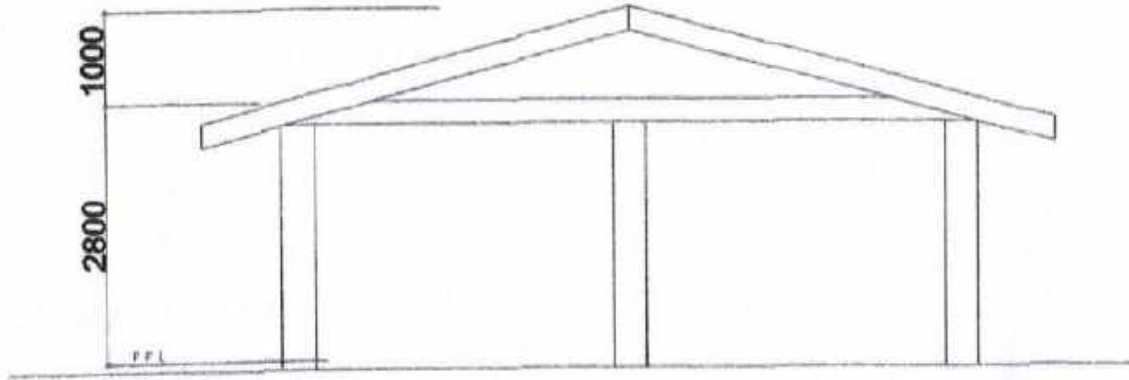


RIGHT SIDE ELEV.  
SCALE: 1:25HTS

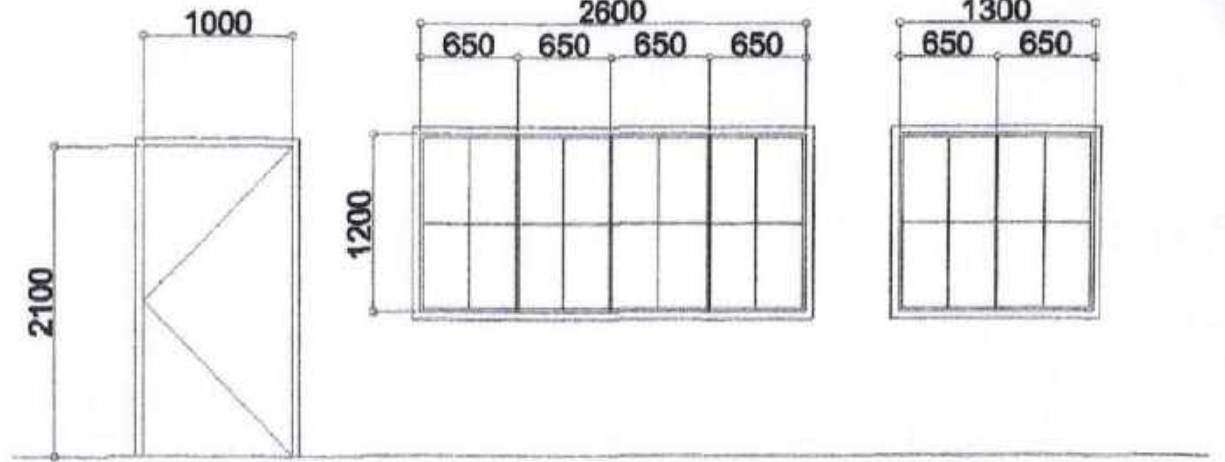


(D1) FLUSH DOOR SET 1  
(W1) STEEL CASEMENT WINDOW SETS 3  
(W2) STEEL CASEMENT WINDOW SET 1

DOORS & WINDOWS SCHEDULE  
SCALE: 1:25HTS

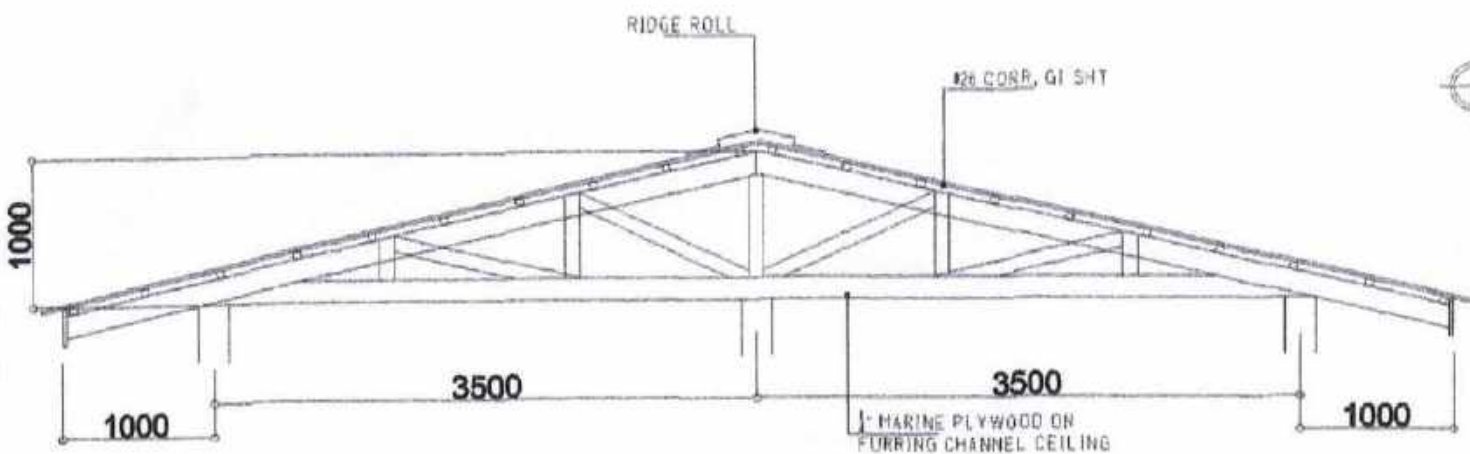

TRUSS DET.  
SCALE: 1:25HTS

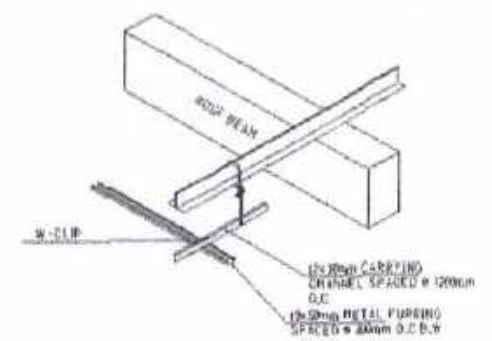

ISOMETRIC DRAWING



CITY ENGINEER'S  
OFFICE


PROJECT TITLE:  
REPAIR/IMPROV. OF MULTI-PURPOSE HALL  
(GRADE 10 BLDG.), GATBO NATIONAL HS  
LOC: BRGY. GATBO, BACON DISTRICT  
SORSOGON CITY

DRAWN BY:  
Ma Pamela Legaspi  
DRAFTING AIDE


RECOMMENDING APPROVAL:  
ROEL D. DOMER, C.E./RMP  
CITY ENGINEER

APPROVED BY:  
MA. ESTER E. HAMOR  
CITY MAYOR

PLEASE SIGN

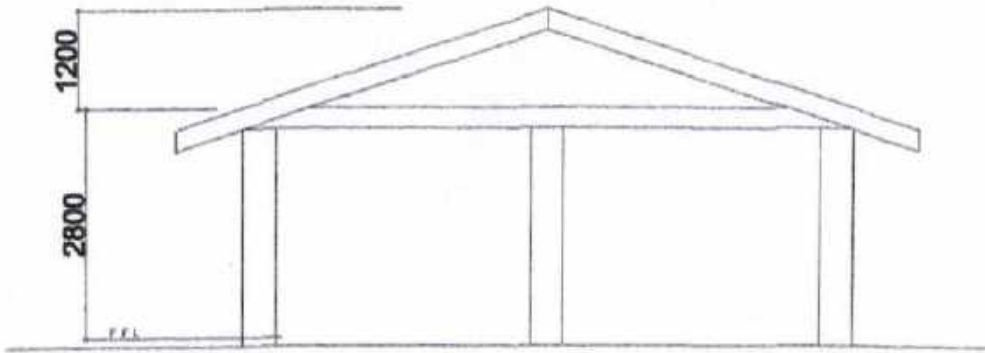


RIGHT SIDE ELEV.  
SCALE: 1:25MTS

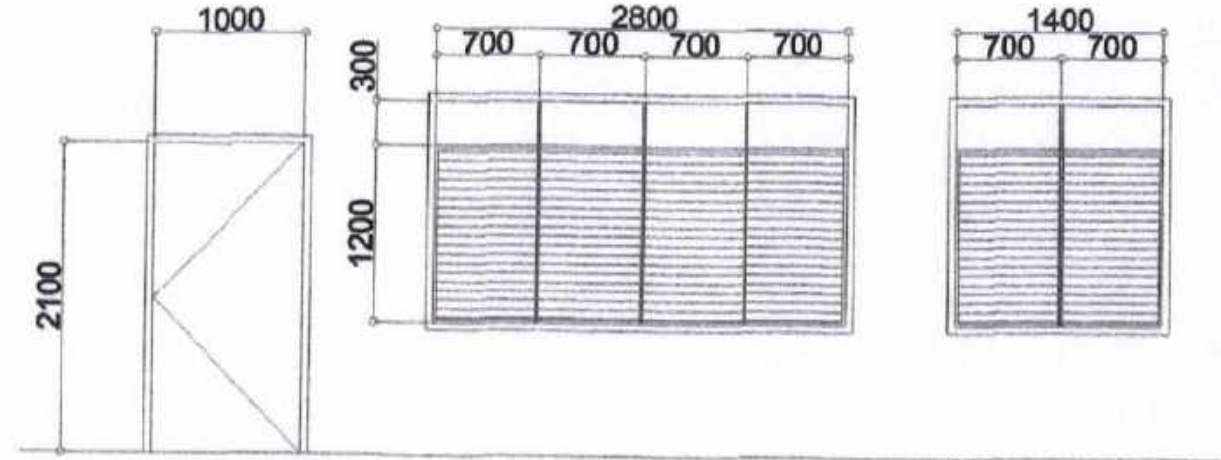

D1  
FLUSH DOOR  
SET 1


W1  
GLASS JALOUSIE WINDOW  
SETS 2

W2  
GLASS JALOUSIE WINDOW  
SETS 2

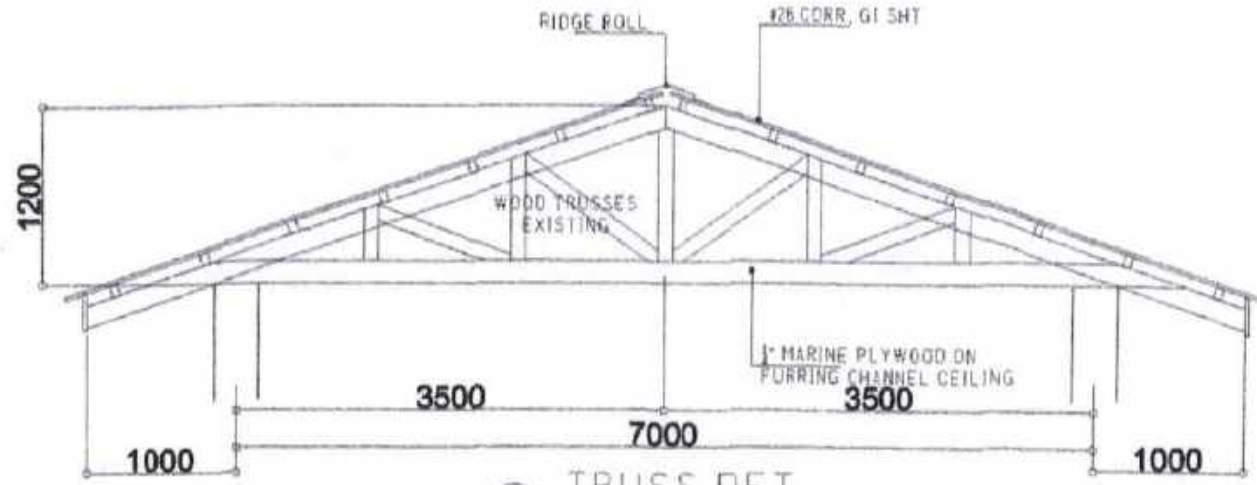

TRUSS DET.  
SCALE: 1:25MTS

DOORS & WINDOWS SCHEDULE  
SCALE: 1:25MTS

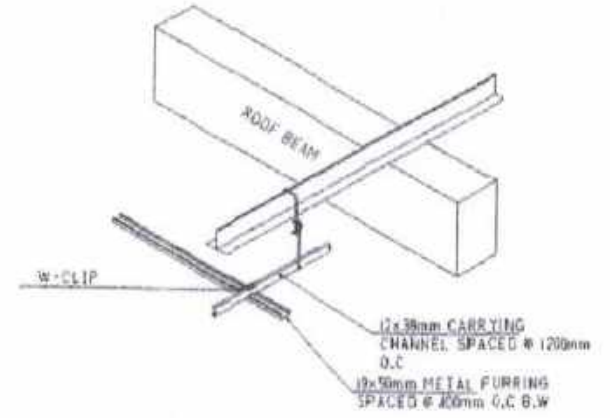

ISOMETRIC DRAWING



CITY ENGINEER'S  
OFFICE


PROJECT TITLE:  
REPAIR/IMPROV. OF MULTI-PURPOSE HALL  
(GRADE 11 BLDG.), GATBO NATIONAL HS  
LOC: BRGY. GATBO, BACON DISTRICT  
SORSOGON CITY

DRAWN BY:  
Ma Pamela Legaspi  
DRAFTING AIDE


RECOMMENDING APPROVAL:  
ROEL B. DOMER, C.E./RMP  
CITY ENGINEER

APPROVED BY:  
MA. ESTER E. HAMOR  
CITY MAYOR

PLEASE SIGN

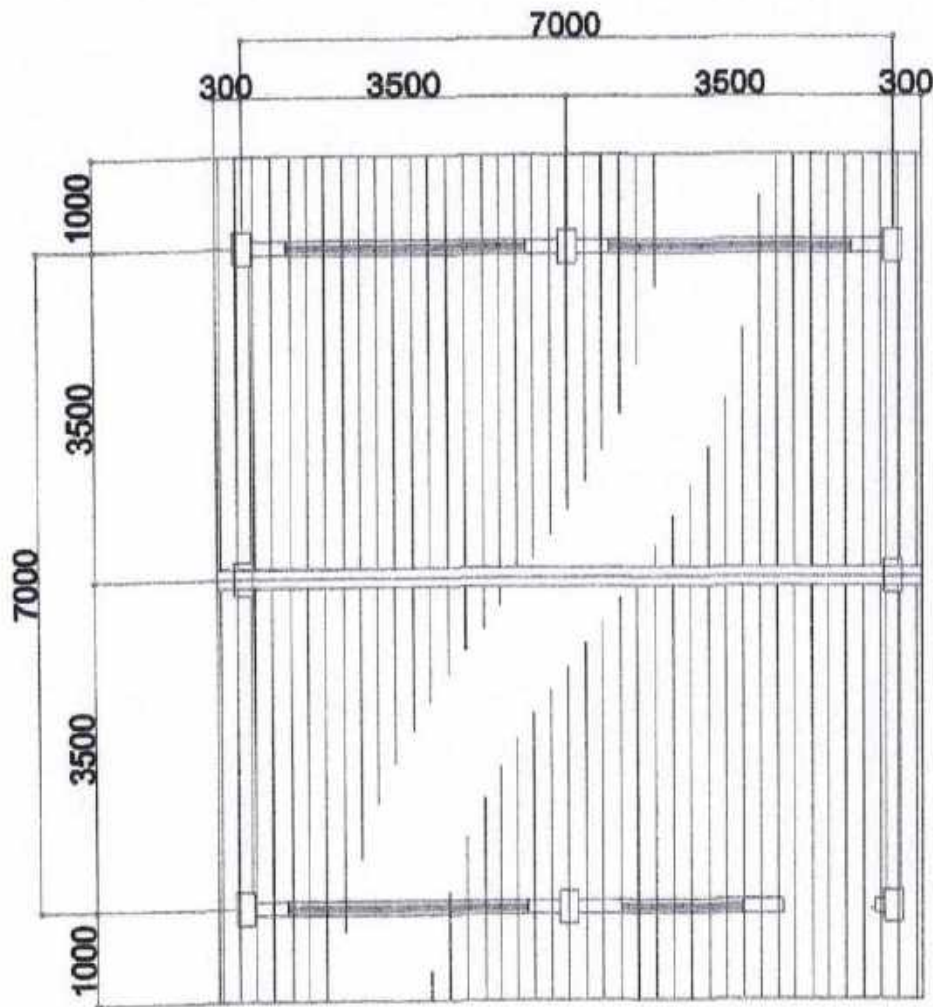

ROOF PLAN  
SCALE 1:200

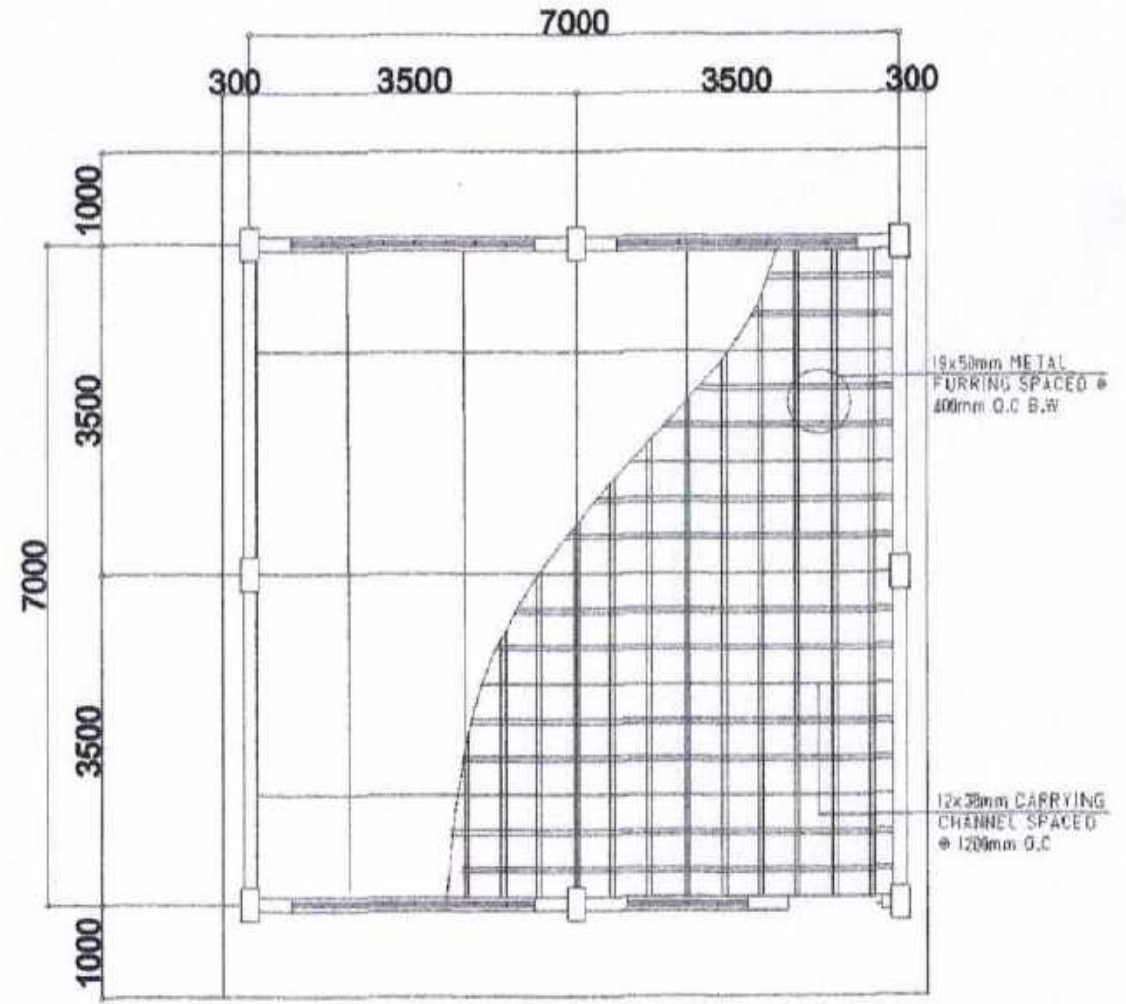

CEILING PLAN  
SCALE 1:200



**CITY ENGINEER'S  
OFFICE**

PROJECT TITLE:  
REPAIR/IMPROV. OF MULTI-PURPOSE HALL  
(GRADE 10 BLDG.), GATBO NATIONAL HS  
LOC. BRGY. GATBO, BACON DISTRICT  
SORSOGON CITY


DRAWN BY:  
MaFenelaLegaspi  
DRAFTING AIDE

RECOMMENDING APPROVAL :  
*[Signature]*  
ROEL D. BOMER, C.E./RMP  
CITY ENGINEER


APPROVED BY:  
*[Signature]*  
MA. ESTER E. HAMOR  
CITY MAYOR

PLEASE SIGN



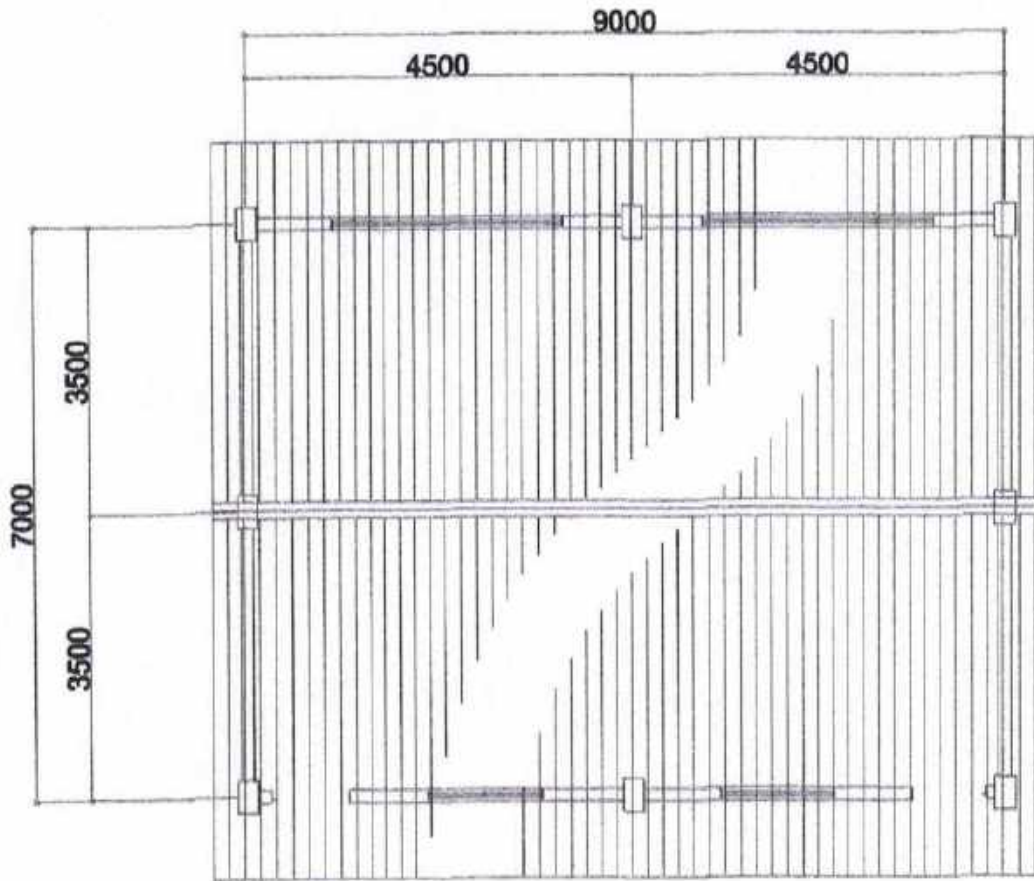

ROOF PLAN  
SCALE: 1:200

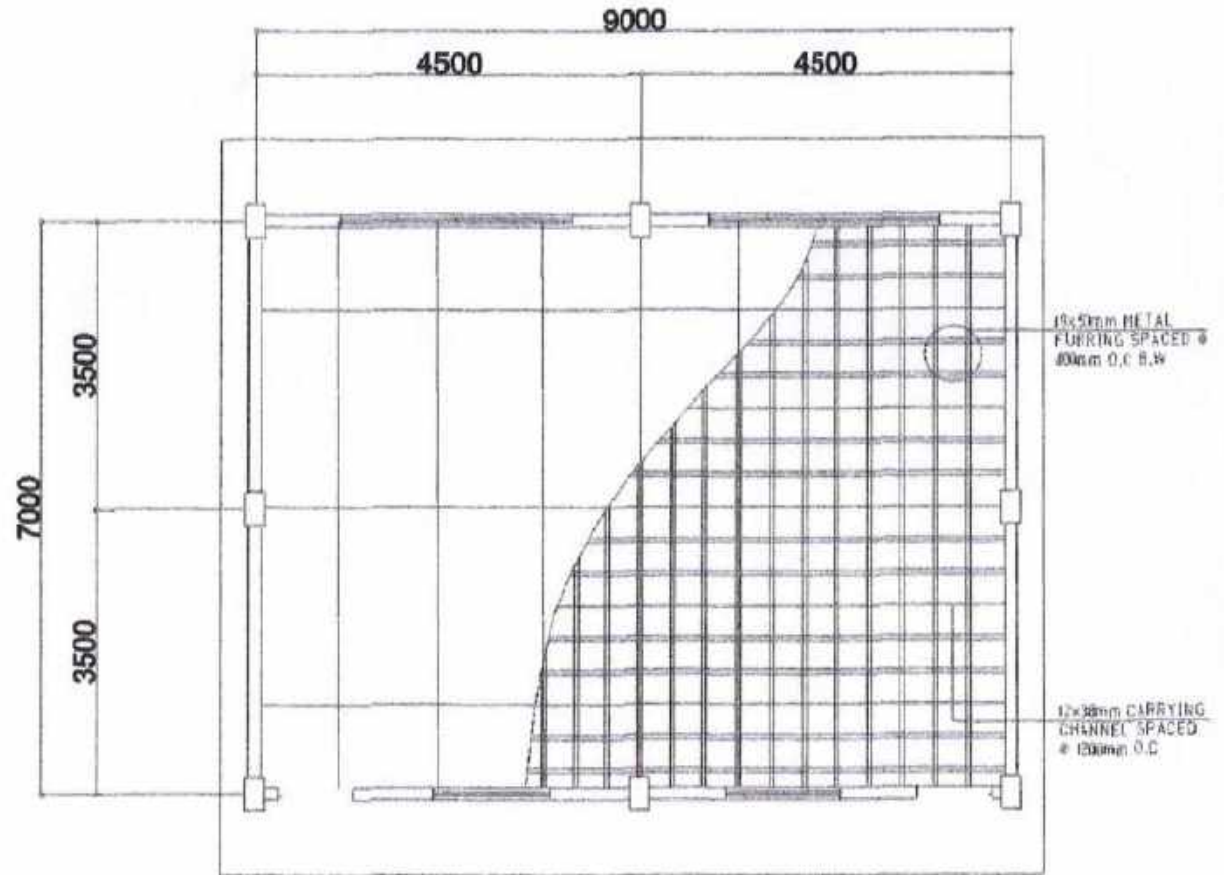

CEILING PLAN  
SCALE: 1:200



CITY ENGINEER'S  
OFFICE

PROJECT TITLE:

REPAIR/IMPROV. OF MULTI-PURPOSE HALL  
(GRADE 11 BLDG.), GATBO NATIONAL HS

LOC. BRGY. GATBO, BACON DISTRICT  
SORSOGON CITY

DRAWN BY:


Ma Pamela Legaspi  
DRAFTING AIDE

RECOMMENDING APPROVAL:

ROEL D. DOMER, C.E./RMP  
CITY ENGINEER

APPROVED BY:

MA. ESTER E. HAMOR  
CITY MAYOR

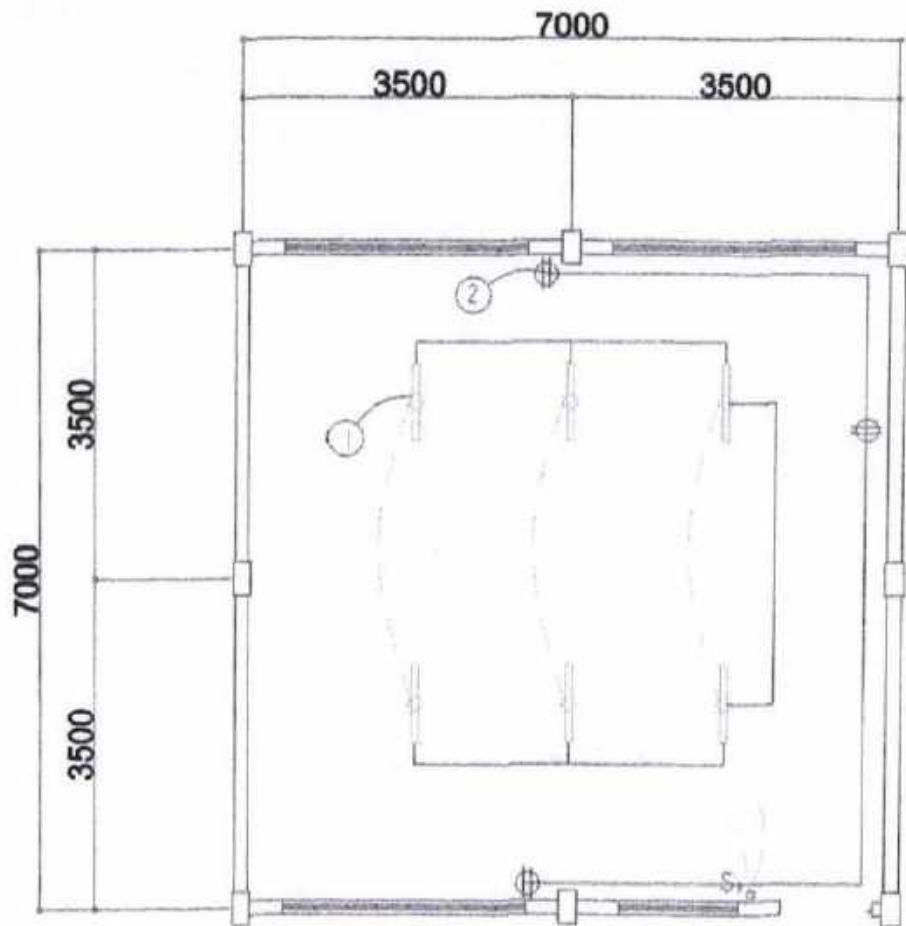

**ELECTRICAL NOTES**

ALL ELECTRICAL WORKS SHALL BE DONE IN ACCORDANCE WITH THE LATEST RULES AND REGULATIONS OF THE PHIL. ELECTRICAL CODE AS WELL AS THE LOCAL AUTHORITY CONCERNED AND THE LOCAL POWER COMPANY.

ALL ELECTRICAL MATERIALS TO BE USED SHALL BE NEED & APPROVED TYPE FOR LOCATION & PURPOSE

MOUNTING HEIGHTS SHALL BE AS FOLLOWS:

- a. LIGHT CONTROL SWITCH- 1.35M ABOVE FIN. FLR. LINE AT CENTER
- b. CONVENIENCE OUTLET- ABOVE 1.0M ABOVE FIN. FLR. LINE AT CENTER
- c. PANEL BOARD- 2.0 M ABOVE FIN. FLR. LINE

ALL ELECTRICAL WORKS SHALL BE UNDER THE DIRECT & IMMEDIATE SUPERVISION OF A DULY LICENSED ELECTRICAL ENGINEER OR REGISTERED MASTER ELECTRICIAN

ELECTRICAL PLAN

**SCHEDULE OF LOADS**

CIRCUIT NO.	DESCRIPTION	NO. OF LOADS	VOLTS	WATTS	AMP	SIZE OF WIRE	SIZE OF CONDUIT
1	LIGHTING OUTLET	6	230	600	2.60	2-2.0mm <sup>2</sup> THW	15mm $\varnothing$
2	CONVENIENCE OUTLET	3	230	540	2.34	2-3.5mm <sup>2</sup> THW	20mm $\varnothing$
	<b>TOTAL</b>				<b>4.94</b>		



**CITY ENGINEER'S OFFICE**


PROJECT TITLE:  
REPAIR/IMPROV. OF MULTI-PURPOSE HALL  
(GRADE 10 BLDG.), GATBO NATIONAL HS  
LOC: BRGY. GATBO, BACON DISTRICT  
SORSOGON CITY

DRAWN BY:  
Ma Pamela Legaspi  
DRAFTING AIDE

RECOMMENDING APPROVAL:  
ROEL D. DOMER, C.E./RMP  
CITY ENGINEER

APPROVED BY:  
MA. ESTER E. HAMOR  
CITY MAYOR

PLEASE SIGN

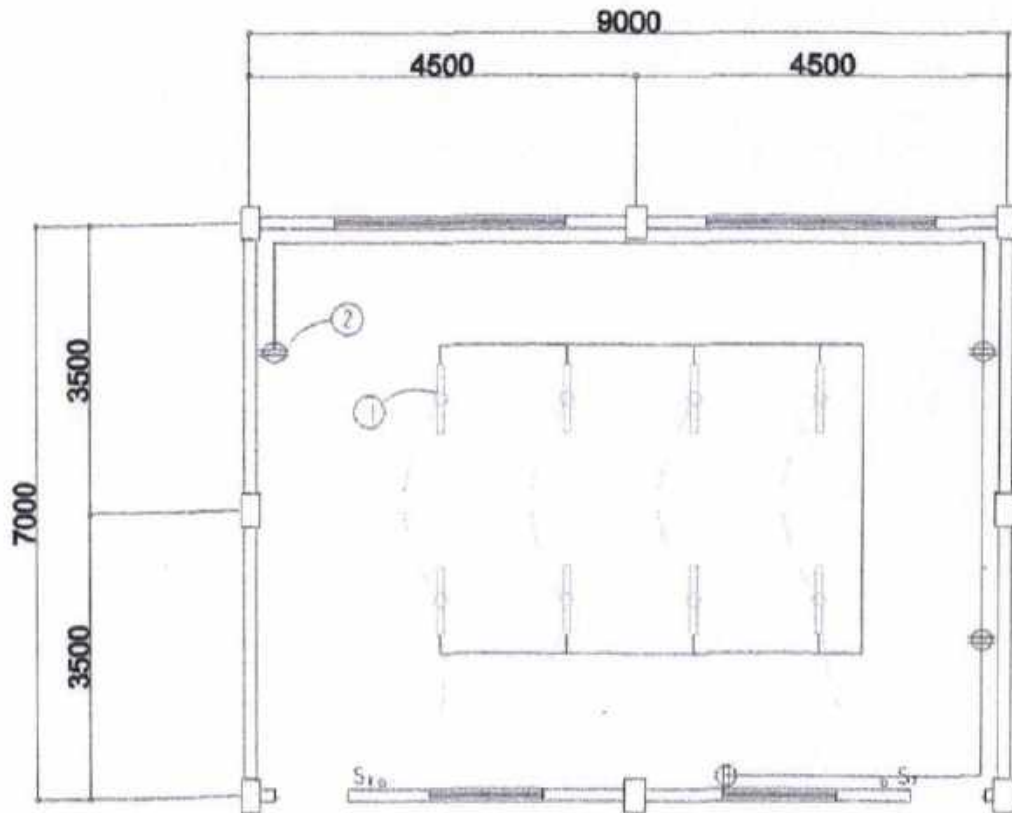

### ELECTRICAL NOTES

ALL ELECTRICAL WORKS SHALL BE DONE IN ACCORDANCE WITH THE LATEST RULES AND REGULATIONS OF THE PHIL. ELECTRICAL CODE AS WELL AS THE LOCAL AUTHORITY CONCERNED AND THE LOCAL POWER COMPANY.

ALL ELECTRICAL MATERIALS TO BE USED SHALL BE NEED & APPROVED TYPE FOR LOCATION & PURPOSE

MOUNTING HEIGHTS SHALL BE AS FOLLOWS:

- a. LIGHT CONTROL SWITCH- 1.35M ABOVE FIN. FLR. LINE AT CENTER
- b. CONVENIENCE OUTLET-ABOVE 1.0M ABOVE FIN. FLR. LINE AT CENTER
- c. PANEL BOARD- 2.0 M ABOVE FIN. FLR. LINE

ALL ELECTRICAL WORKS SHALL BE UNDER THE DIRECT & IMMEDIATE SUPERVISION OF A DULY LICENSED ELECTRICAL ENGINEER OR REGISTERED MASTER ELECTRICIAN

ELECTRICAL PLAN  
SCALE 1/8\"/>

### SCHEDULE OF LOADS

CIRCUIT NO.	DESCRIPTION	NO. OF LOADS	VOLTS	WATTS	AMP	SIZE OF WIRE	SIZE OF CONDUIT
1	LIGHTING OUTLET	8	230	800	3.48	2-2.0mm <sup>2</sup> THW	15mm $\varnothing$
2	CONVENIENCE OUTLET	4	230	720	3.13	2-3.5mm <sup>2</sup> THW	20mm $\varnothing$
	TOTAL				6.61		



CITY ENGINEER'S  
O F F I C E

PROJECT TITLE:

REPAIR/IMPROV. OF MULTI-PURPOSE HALL  
(GRADE 11 BLDG.), GATBO NATIONAL HS

LOC: BRGY. GATBO, SACON DISTRICT  
BORSOGON CITY

DRAWN BY:

MoPansal Legaspi  
DRAFTING AIDE

RECOMMENDING APPROVAL:

ROEL D. TOMER, C.E./RMP  
CITY ENGINEER

APPROVED BY:

MA. ESTER E. HAMCR  
CITY MAYOR

PLEASE SIGN

**GATBO NATIONAL HIGH SCHOOL**

**GRADE 10 BUILDING**



**GATBO NATIONAL HIGH SCHOOL**

**CLASSROOM NO. 4**



**GATBO NATIONAL HIGH SCHOOL**

**GRADE 8 & 9 BUILDING**



**GATBO NATIONAL HIGH SCHOOL**

**GRADE 11 BUILDING**

