

EXISTING FLOOR PLAN
SCALE: 1/2500



CITY ENGINEER'S
OFFICE

PROJECT TITLE:

REPAIR/IMPROV. OF MULTI-PURPOSE HALL
(BLSB BLDG.), STA. CRUZ ES

LOC: BRGY. STA. CRUZ, BACON DISTRICT
SORSOGON CITY

DRAWN BY:


MaPamelaLegaspi
DRAFTING AIDE

RECOMMENDING APPROVAL :


ROEL U. DOMER, C.E./RMP
OIC-CITY ENGINEER

APPROVED BY:

MA. ESTER E. HAMOR
CITY MAYOR

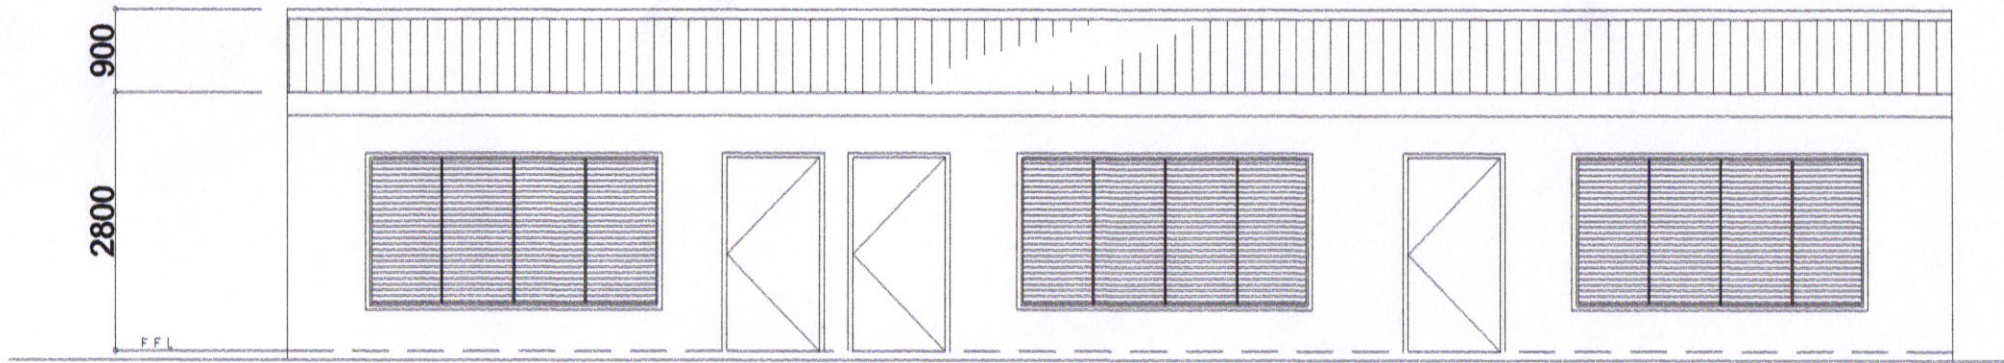

FRONT ELEVATION
SCALE: 1:250

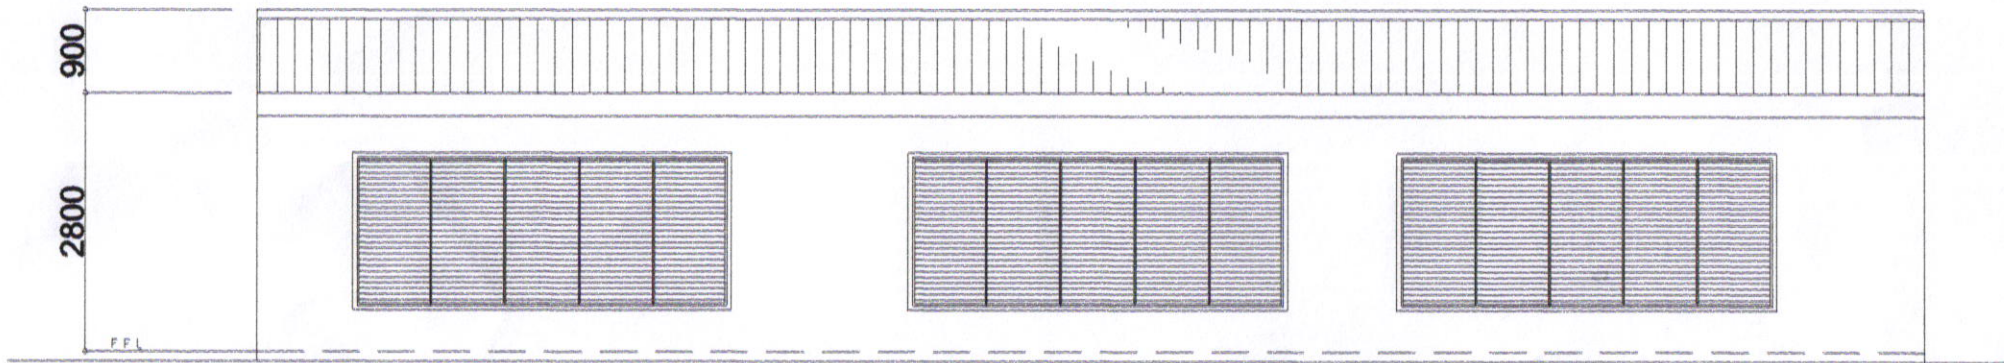


REAR ELEVATION
SCALE: 1:250




CITY ENGINEER'S
OFFICE

PROJECT TITLE:	DRAWN BY:	RECOMMENDING APPROVAL :	APPROVED BY:
REPAIR/IMPROV. OF MULTI-PURPOSE HALL (BLSB BLDG.), STA. CRUZ ES			
LOC: BRGY. STA. CRUZ, BACON DISTRICT SORSOGON CITY	MaPamela Legaspi DRAFTING AIDE	ROEL D. BOMER, C.E./RMP CIC-CITY ENGINEER	MA. ESTER E. HAMOR CITY MAYOR

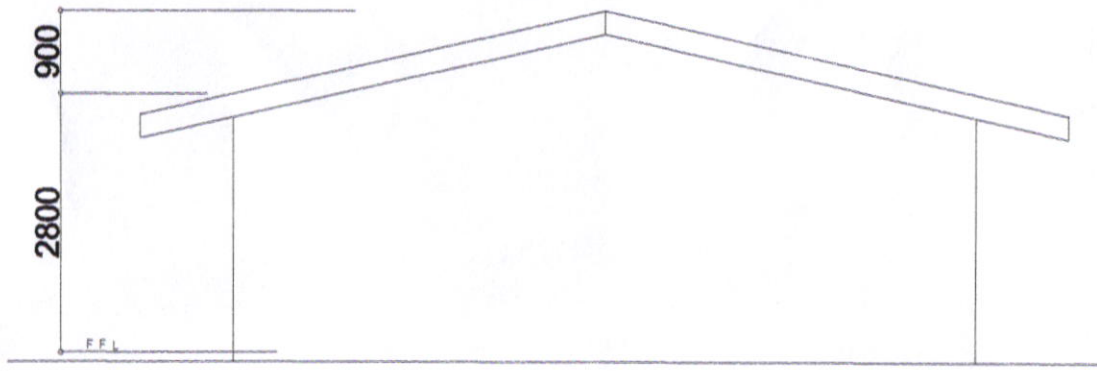

RIGHT SIDE ELEV.
SCALE: 1:25MTS

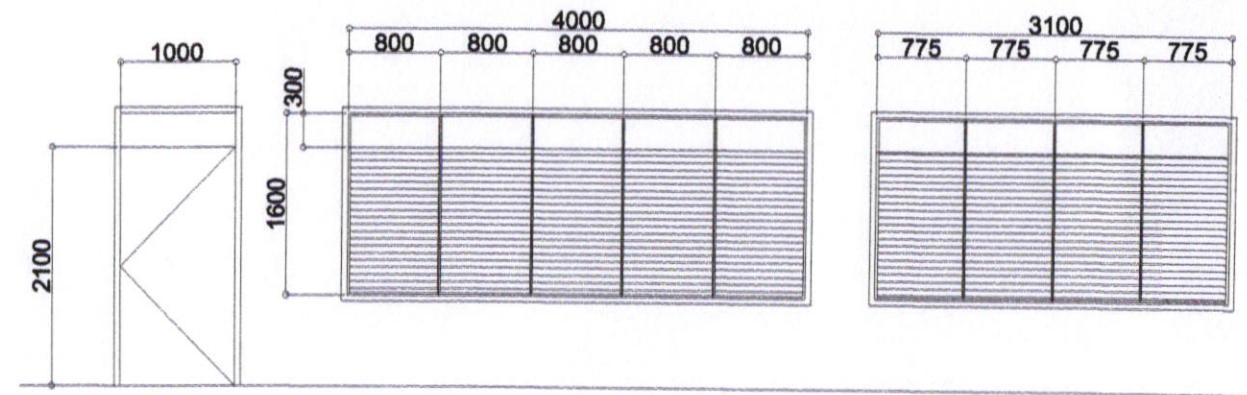


(D1)
FLUSH DOOR
SETS 3


(W1)
GLASS JALOUSIE WINDOW
SETS 3

(W2)
GLASS JALOUSIE WINDOW
SETS 3

DOORS & WINDOWS SCHEDULE
SCALE: 1:25MTS

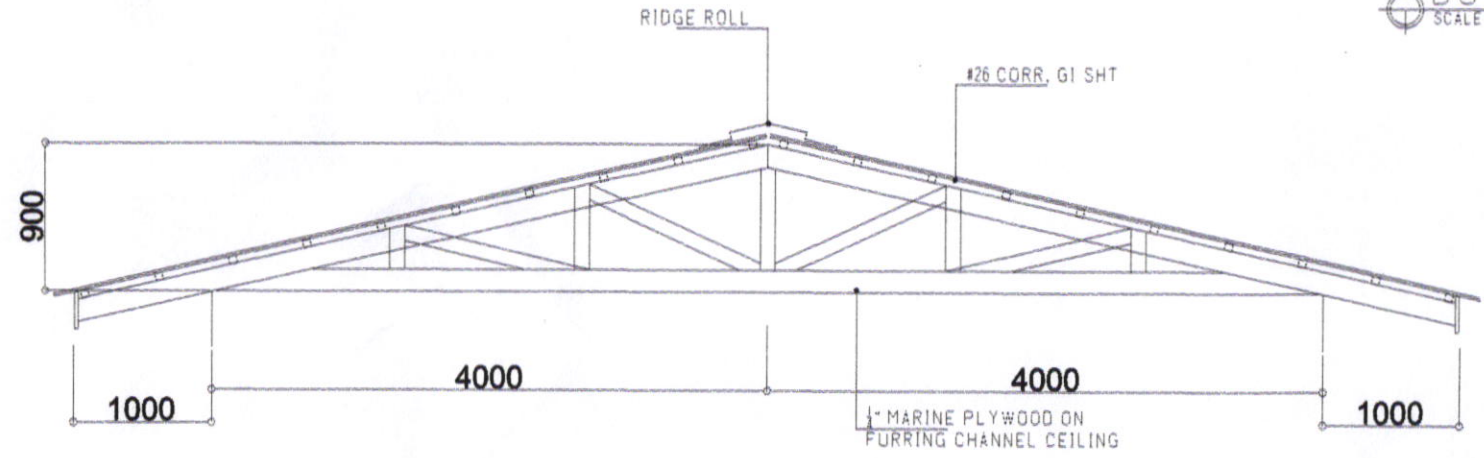

TRUSS DET.
SCALE: 1:25MTS

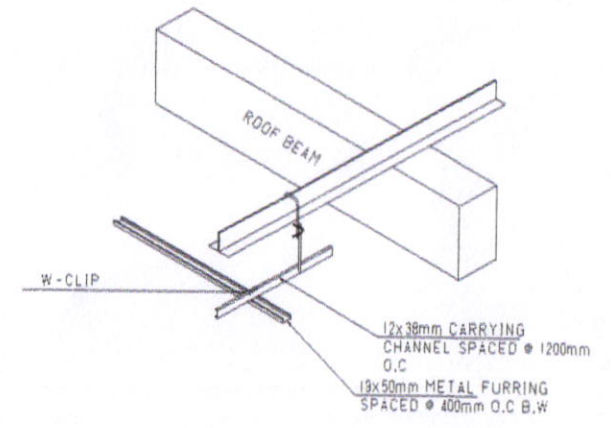


ISOMETRIC DRAWING



CITY ENGINEER'S
OFFICE

PROJECT TITLE: REPAIR/IMPROV. OF MULTI-PURPOSE HALL (BLSB BLDG.), STA. CRUZ ES	DRAWN BY: MaPamelaLegaspi DRAFTING AIDE	RECOMMENDING APPROVAL: ROEL D. DOMER, C.E./RMP OIC-CITY ENGINEER	APPROVED BY: MA. ESTER E. HAMOR CITY MAYOR
LOC: BRGY. STA. CRUZ, BACON DISTRICT SORSOGON CITY			

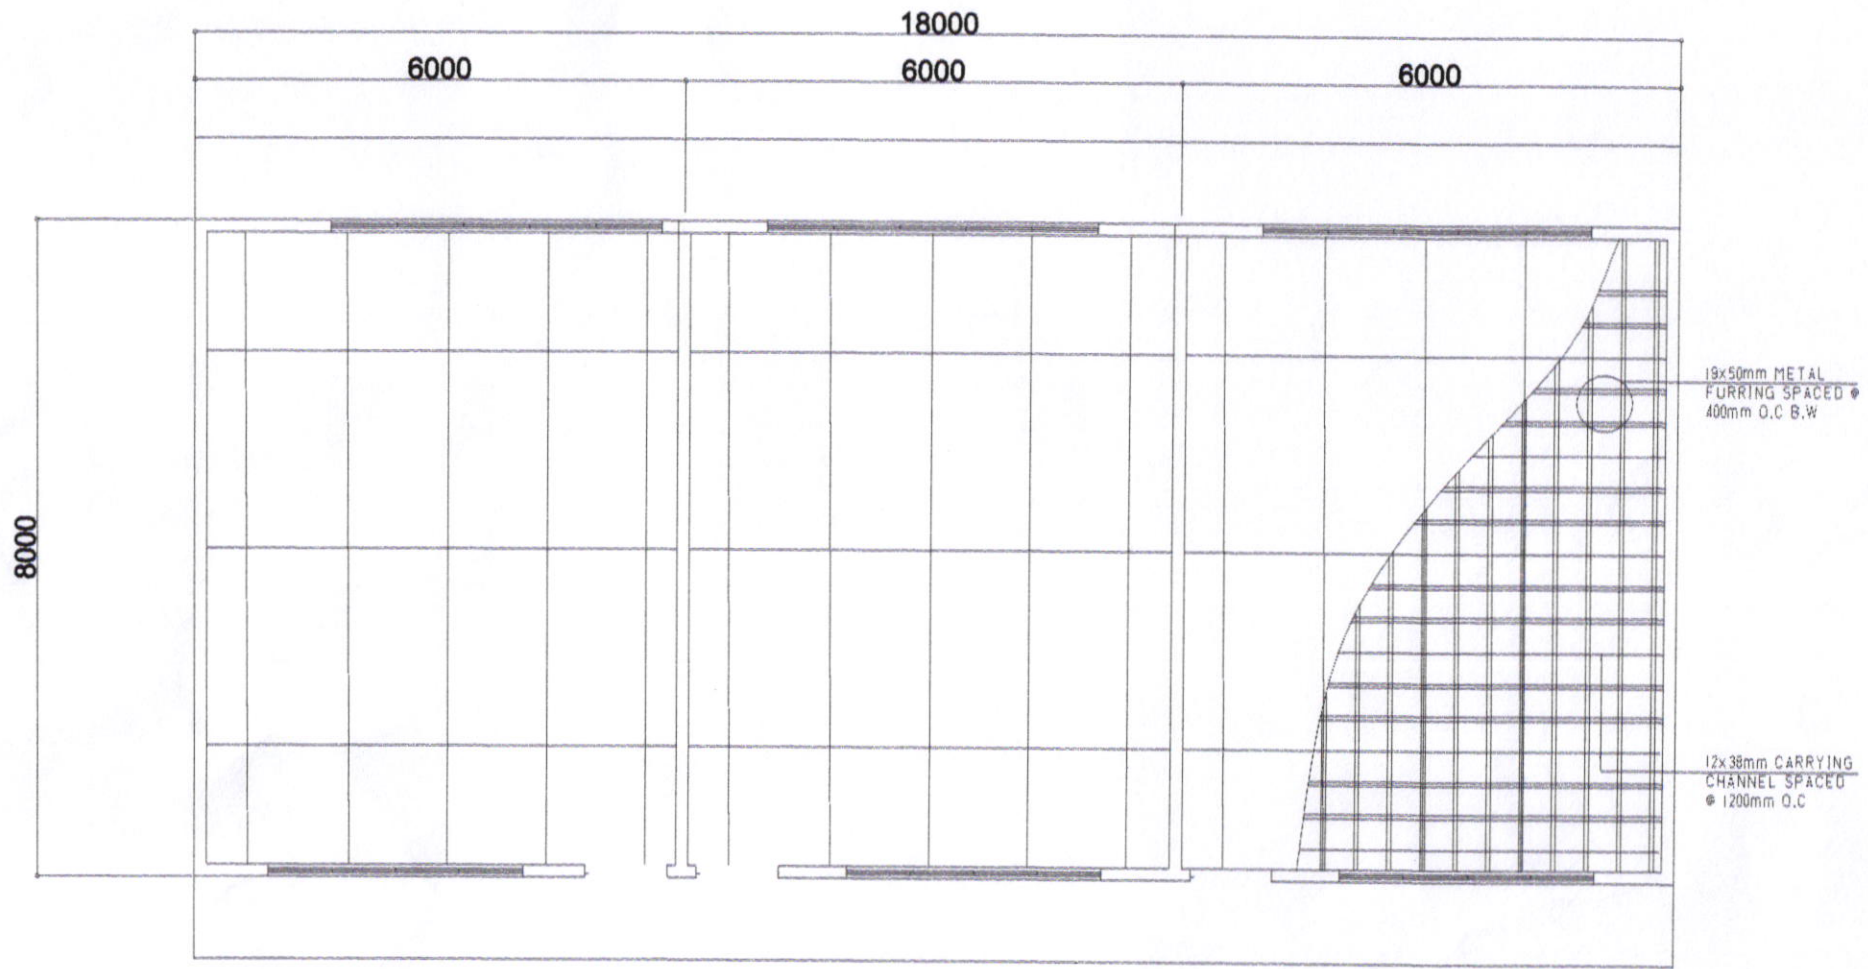


ROOF PLAN
SCALE: 1:250



**CITY ENGINEER'S
OFFICE**



PROJECT TITLE: REPAIR/IMPROV. OF MULTI-PURPOSE HALL (BLSB BLDG.), STA. CRUZ ES	DRAWN BY: 	RECOMMENDING APPROVAL : 	APPROVED BY:
LOC: BRGY. STA. CRUZ, BACON DISTRICT SORSOGON CITY	Ma Pamela Legaspi DRAFTING AIDE	ROEL D. DOMER, C.E./RMP OIC-CITY ENGINEER	MA. ESTER E. HAMOR CITY MAYOR

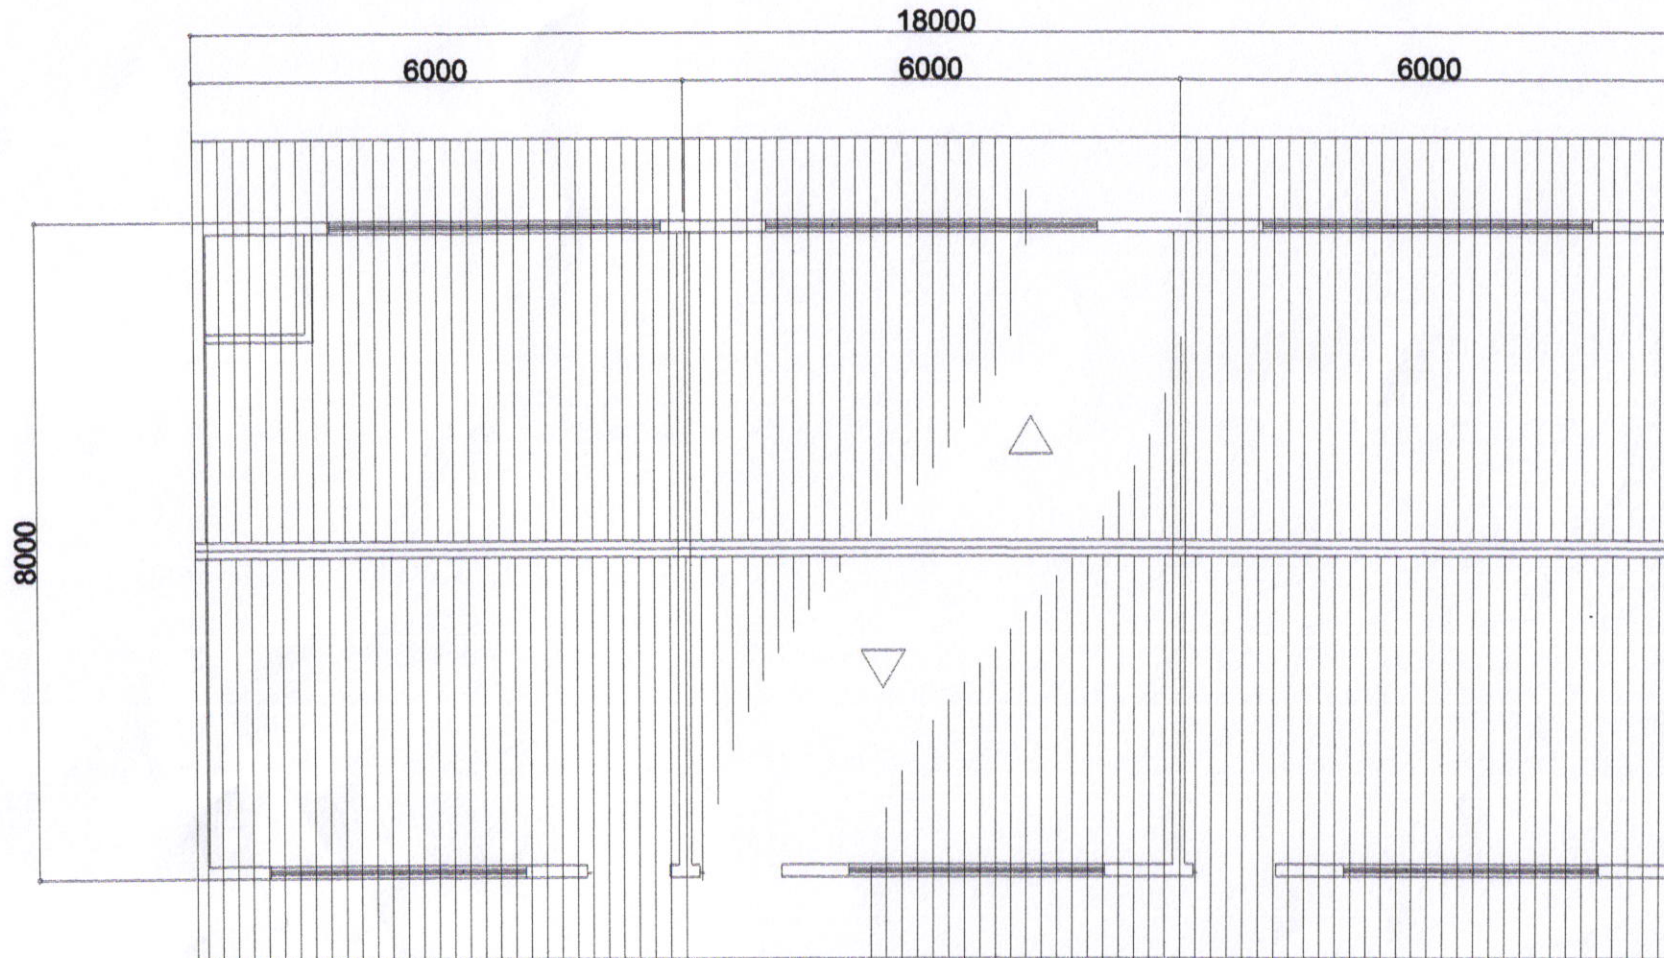


ROOF PLAN
SCALE: 1/200



 CITY ENGINEER'S
OFFICE
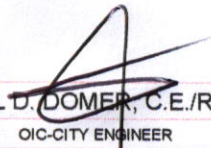
<p>PROJECT TITLE: REPAIR/IMPROV. OF MULTI-PURPOSE HALL (BLSB BLDG.), STA. CRUZ ES</p>	<p>DRAWN BY: Ma Pamela Legaspi DRAFTING AIDE</p>	<p>RECOMMENDING APPROVAL :  ROEL D. DOMER, C.E./RMP OIC-CITY ENGINEER</p>	<p>APPROVED BY:  MA. ESTER E. HAMOR CITY MAYOR</p>
<p>LOC: BRGY. STA. CRUZ, BACON DISTRICT SORSOGON CITY</p>			

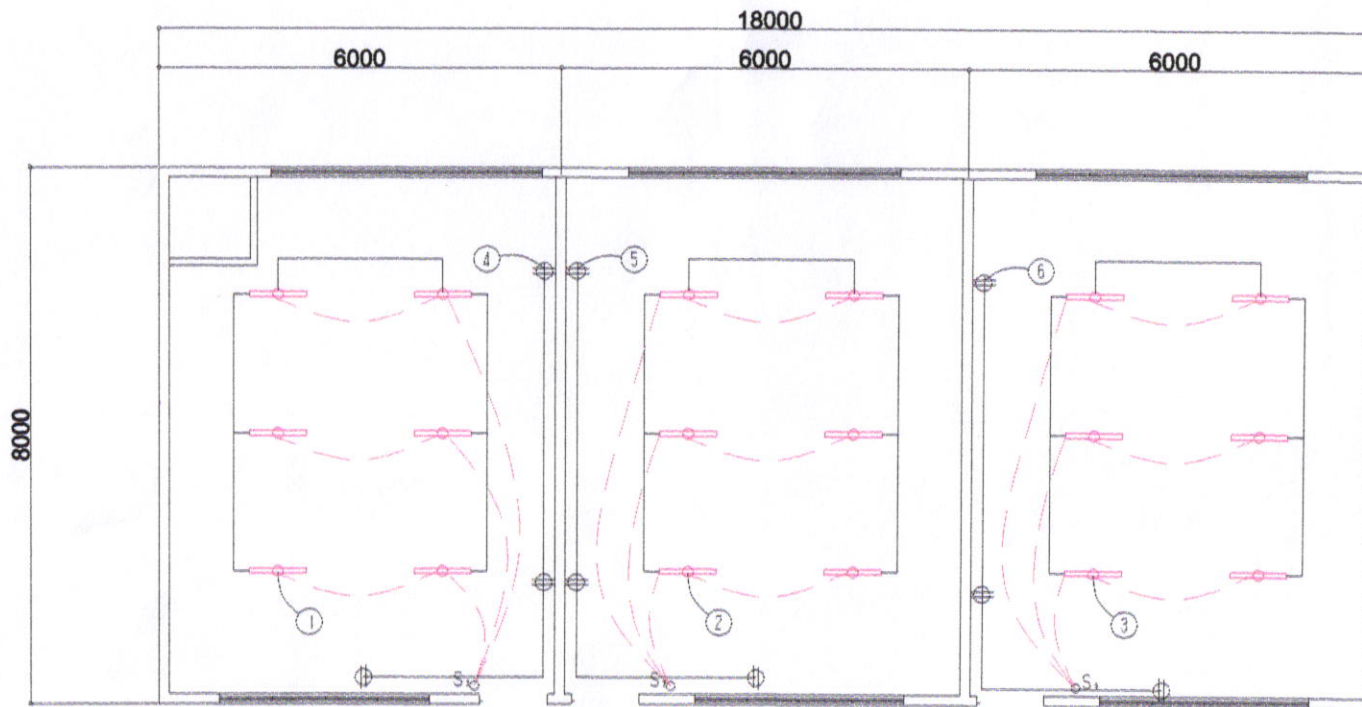

ELECTRICAL PLAN

ELECTRICAL NOTES

ALL ELECTRICAL WORKS SHALL BE DONE IN ACCORDANCE WITH THE LATEST RULES AND REGULATIONS OF THE PHIL. ELECTRICAL CODE AS WELL AS THE LOCAL AUTHORITY CONCERNED AND THE LOCAL POWER COMPANY.

ALL ELECTRICAL MATERIALS TO BE USED SHALL BE NEED & APPROVED TYPE FOR LOCATION & PURPOSE

MOUNTING HEIGHTS SHALL BE AS FOLLOWS:

- a. LIGHT CONTROL SWITCH- 1.35M ABOVE FIN. FLR. LINE AT CENTER
- b. CONVENIENCE OUTLET-ABOVE 1.0M ABOVE FIN. FLR. LINE AT CENTER
- c. PANEL BOARD- 2.0 M ABOVE FIN. FLR. LINE

ALL ELECTRICAL WORKS SHALL BE UNDER THE DIRECT & IMMEDIATE SUPERVISION OF A DULY LICENSED ELECTRICAL ENGINEER OR REGISTERED MASTER ELECTRICIAN

SCHEDULE OF LOADS

CIRCUIT NO.	DESCRIPTION	NO. OF LOADS	VOLTS	WATTS	AMP	SIZE OF WIRE	SIZE OF CONDUIT
1	LIGHTING OUTLET	6	230	600	2.60	2-2.0mm ² THW	15mmØ
2	LIGHTING OUTLET	6	230	600	2.60	2-2.0mm ² THW	15mmØ
3	LIGHTING OUTLET	6	230	600	2.60	2-2.0mm ² THW	15mmØ
4	CONVENIENCE OUTLET	3	230	540	2.34	2-3.5mm ² THW	20mmØ
5	CONVENIENCE OUTLET	3	230	540	2.34	2-3.5mm ² THW	20mmØ
6	CONVENIENCE OUTLET	3	230	540	2.34	2-3.5mm ² THW	20mmØ
TOTAL					14.82		



CITY ENGINEER'S
OFFICE

PROJECT TITLE:

REPAIR/IMPROV. OF MULTI-PURPOSE HALL
(BLSB BLDG.), STA. CRUZ ES

LOC: BRGY. STA. CRUZ, BACON DISTRICT
SORSOGON CITY

DRAWN BY:


MaPamela Legaspi
DRAFTING AIDE

RECOMMENDING APPROVAL :

ROEL D. DOMERA, C.E./RMP
CITY ENGINEER

APPROVED BY:

MA. ESTER E. HAMOR
CITY MAYOR

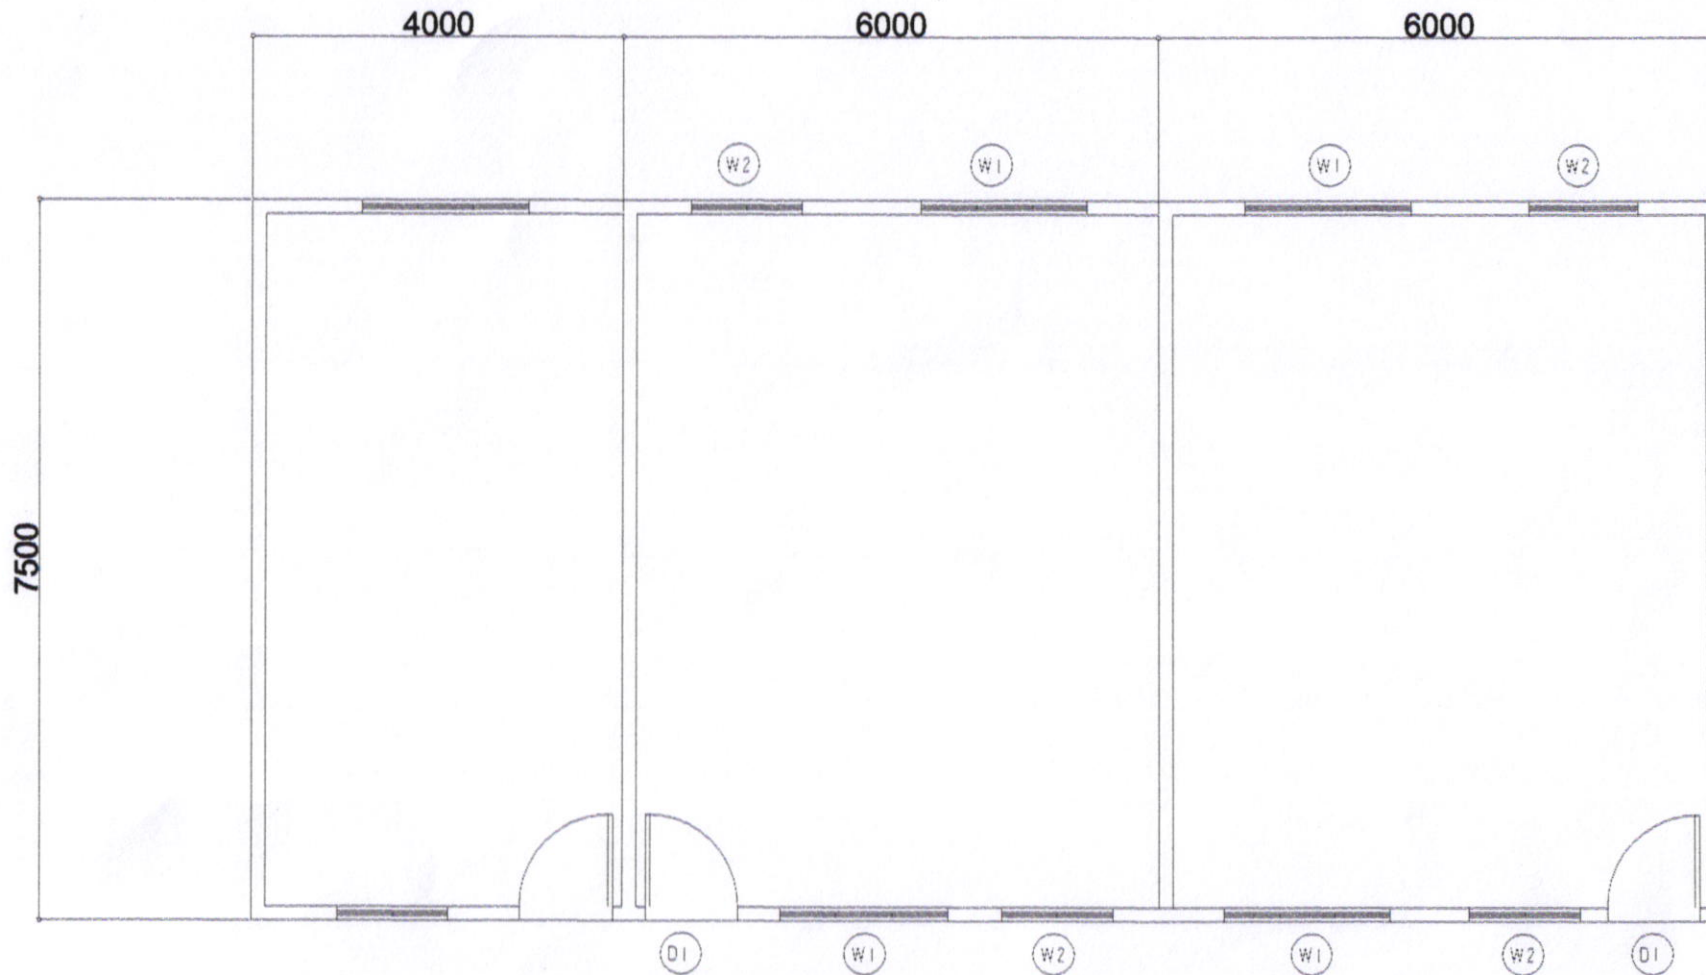


EXISTING FLOOR PLAN
SCALE: 1/25MTS




CITY ENGINEER'S
O F F I C E

PROJECT TITLE:	DRAWN BY:	RECOMMENDING APPROVAL :	APPROVED BY:
REPAIR/IMPROV. OF MULTI-PURPOSE HALL (MARCOS TYPE), STA. CRUZ ES			
LOC: BRGY. STA. CRUZ, BACON DISTRICT	MaPamela Legaspi	ROEL D. DOMERT C.E./RMP	MA. ESTER E. HAMOR
SORSOGON CITY	DRAFTING AIDE	CITY ENGINEER	CITY MAYOR

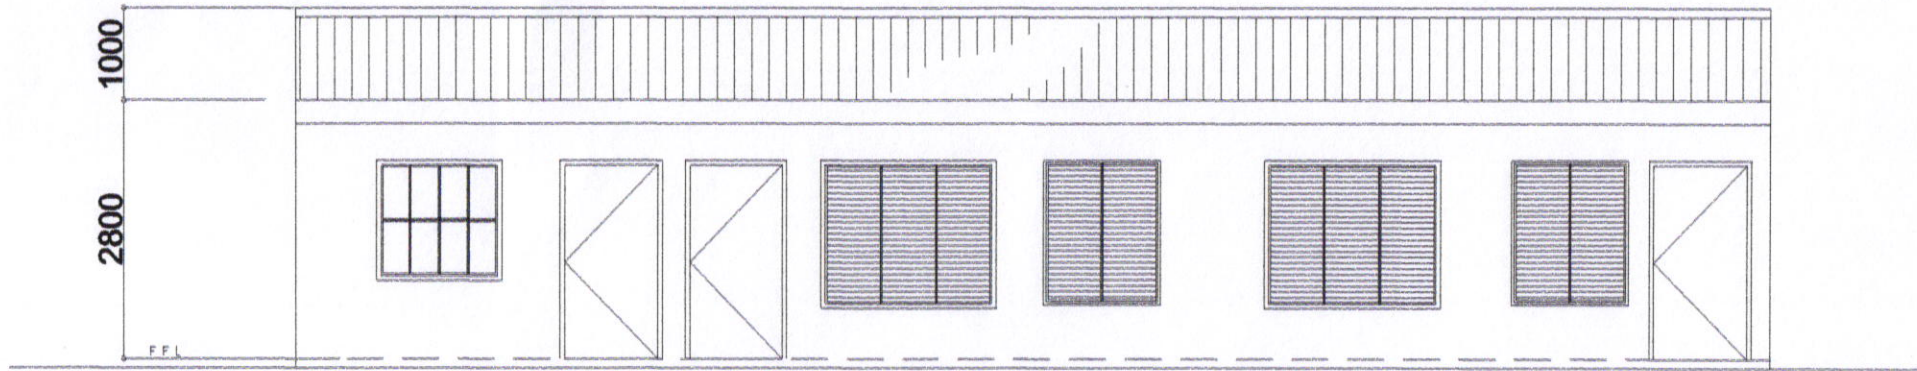

FRONT ELEVATION
SCALE: 1/25M.T.S.

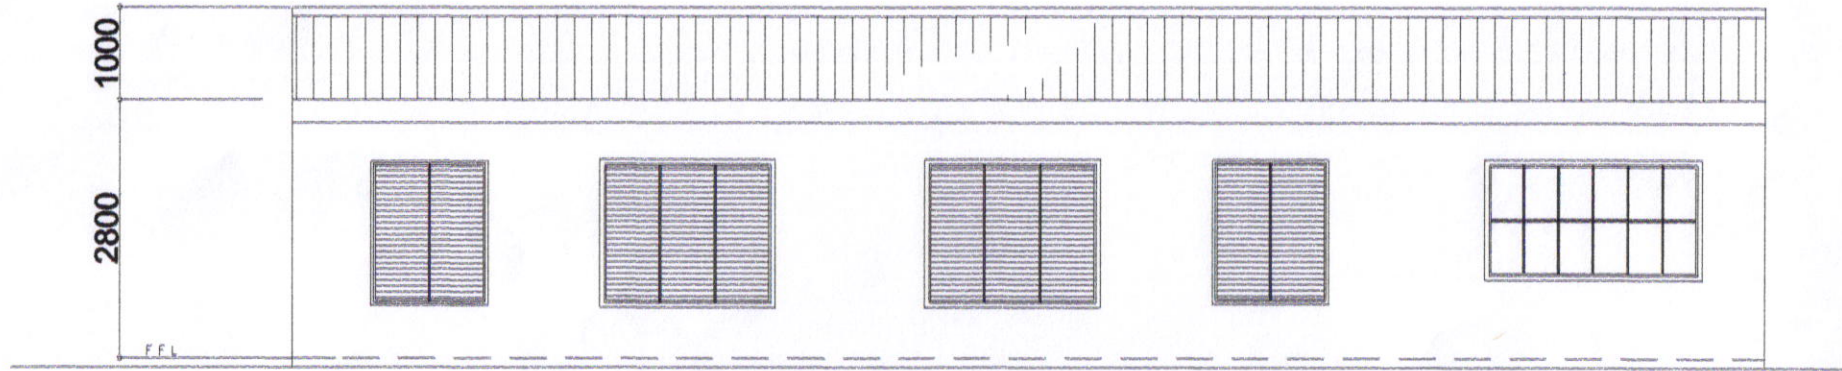


REAR ELEVATION
SCALE: 1/25M.T.S.




CITY ENGINEER'S
O F F I C E

PROJECT TITLE:	DRAWN BY:	RECOMMENDING APPROVAL :	APPROVED BY:
REPAIR/IMPROV. OF MULTI-PURPOSE HALL (MARCOS TYPE), STA. CRUZ ES			
LOC: BRGY. STA. CRUZ, BACON DISTRICT SORSOGON CITY	MaPamela Legaspi DRAFTING AIDE	ROEL D. DOMER, C.E./RMP CITY ENGINEER	MA. ESTER E. HAMOR CITY MAYOR

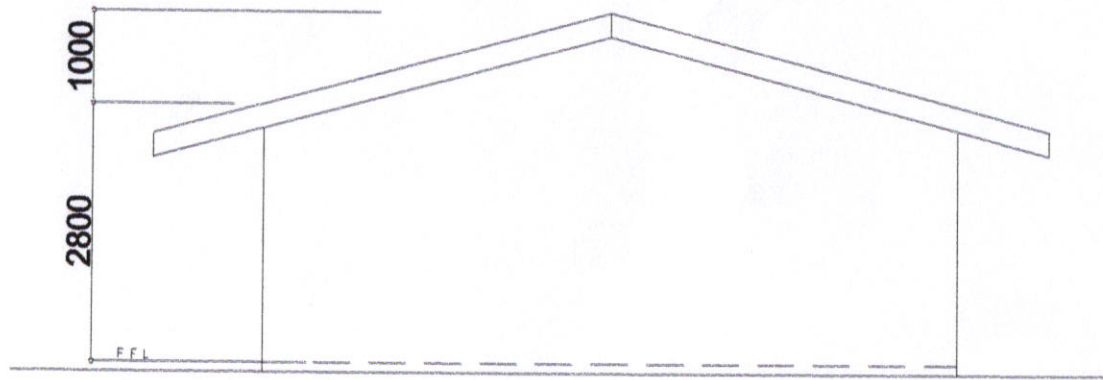

RIGHT SIDE ELEV.
SCALE: 1:25MTS

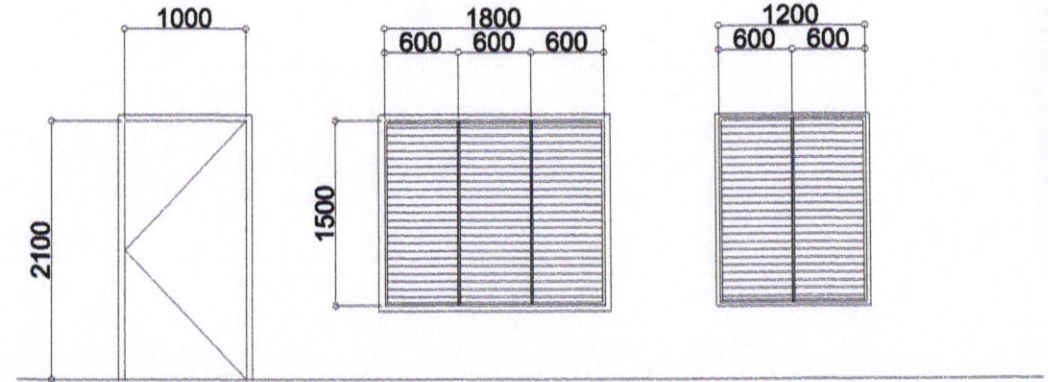


(D1)
FLUSH DOOR
SETS 2


(W1)
GLASS JALOUSIE WINDOW
SETS 6

(W2)
GLASS JALOUSIE WINDOW
SETS 2

DOORS & WINDOWS SCHEDULE
SCALE: 1:25MTS

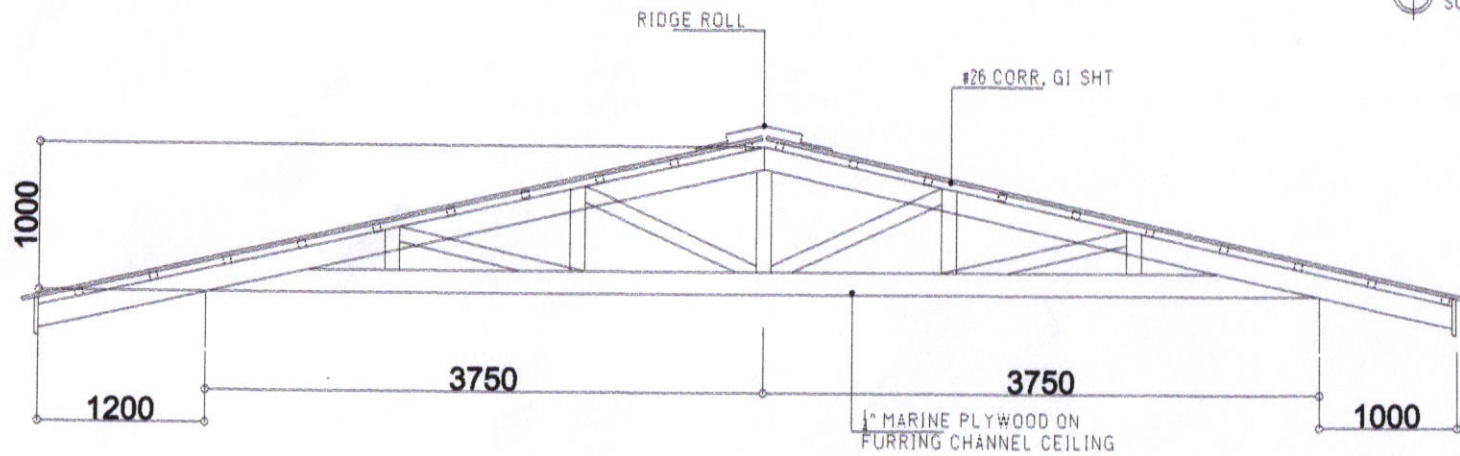

TRUSS DET.
SCALE: 1:25MTS

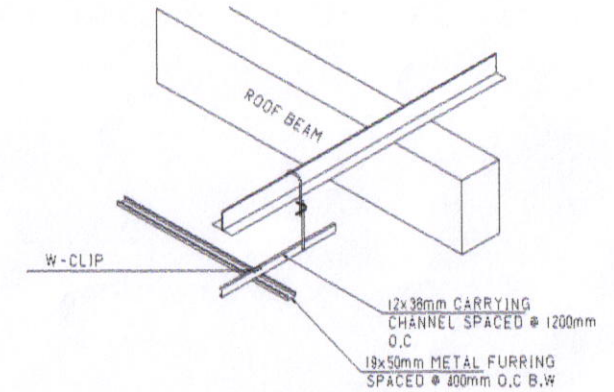


ISOMETRIC DRAWING



CITY ENGINEER'S
OFFICE

PROJECT TITLE:	DRAWN BY:	RECOMMENDING APPROVAL :	APPROVED BY:
REPAIR/IMPROV. OF MULTI-PURPOSE HALL (MARCOS TYPE), STA. CRUZ ES			
LOC: BRGY. STA. CRUZ, BACON DISTRICT SORSOGON CITY	Ma Pamela Legaspi DRAFTING AIDE	ROEL D. BOMER, C.E./RMP OIC-CITY ENGINEER	MA. ESTER E. HAMOR CITY MAYOR

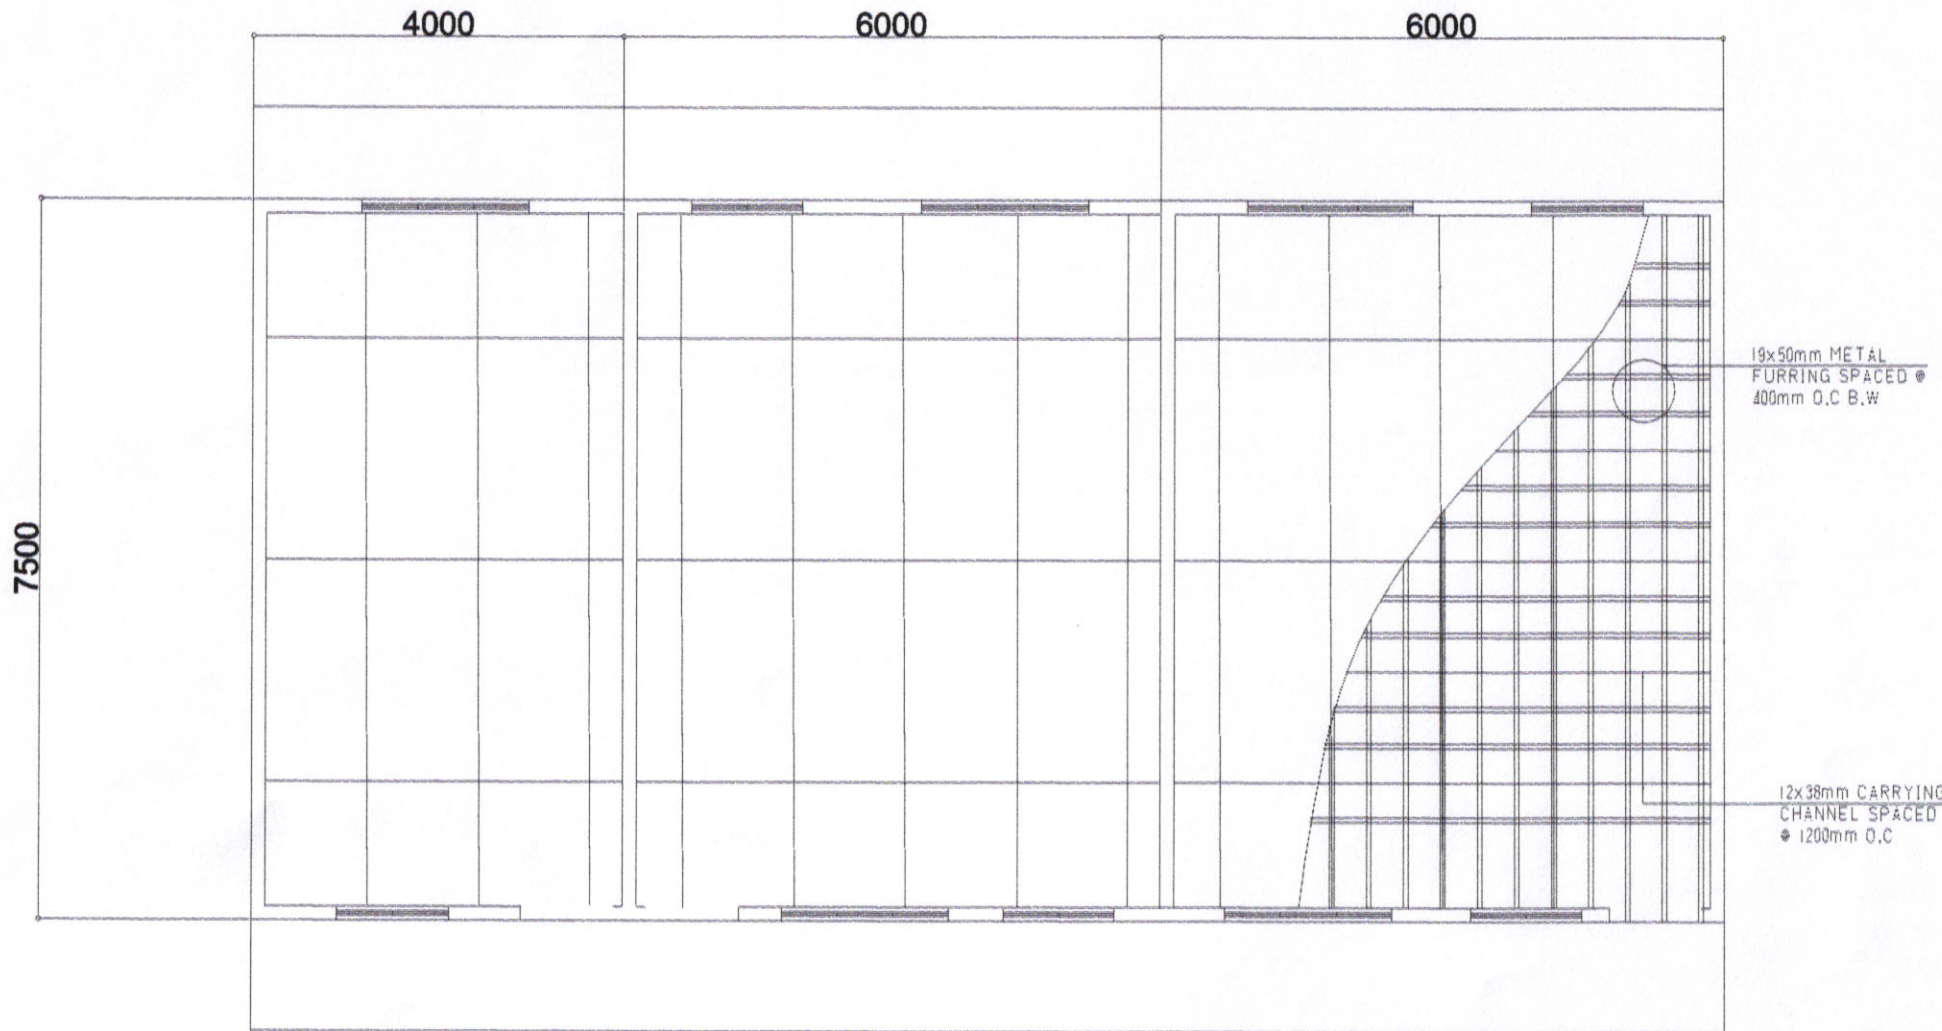


ROOF PLAN
SCALE: 1:250



CITY ENGINEER'S
OFFICE


PROJECT TITLE:	DRAWN BY:	RECOMMENDING APPROVAL :	APPROVED BY:
REPAIR/IMPROV. OF MULTI-PURPOSE HALL (MARCOS TYPE), STA. CRUZ ES			
LOC: BRGY. STA. CRUZ, BACON DISTRICT SORSOGON CITY	Ma Pamela Legaspi DRAFTING AIDE	ROEL D. BOMER, C.E./RMP CITY ENGINEER	MA. ESTER E. HAMOR CITY MAYOR

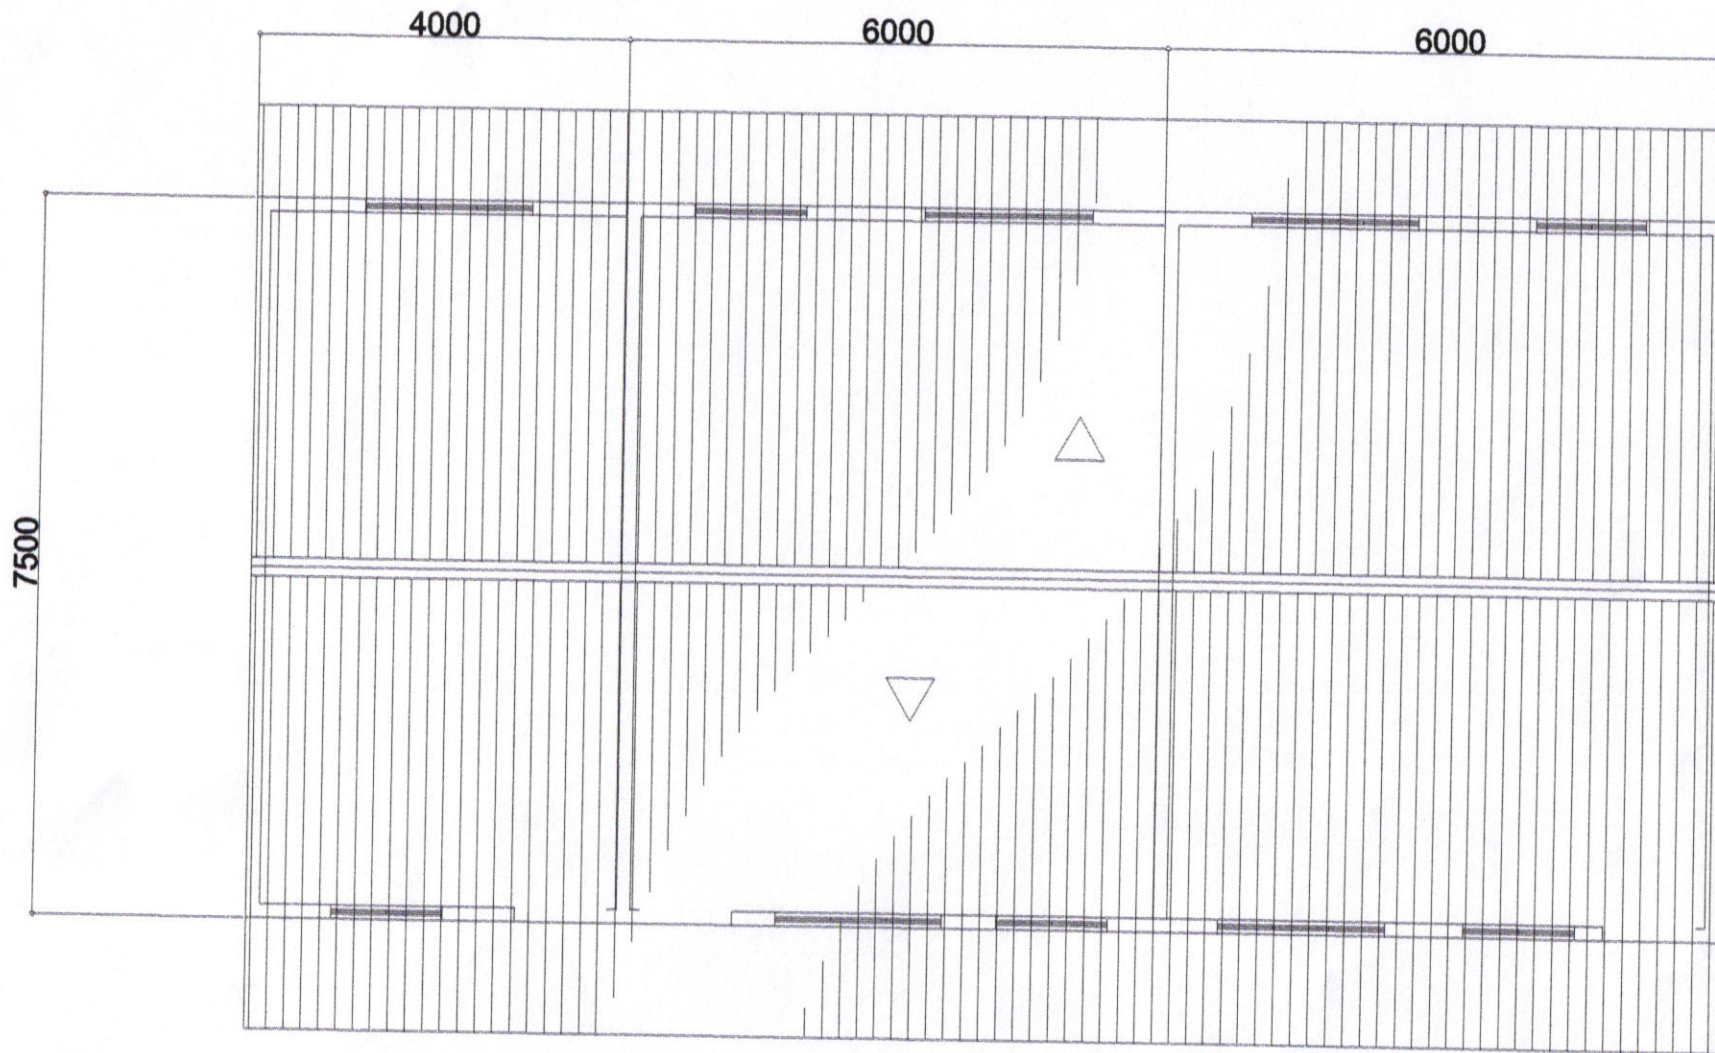


ROOF PLAN
 SCALE: 1:250



**CITY ENGINEER'S
 OFFICE**

PROJECT TITLE: REPAIR/IMPROV. OF MULTI-PURPOSE HALL (MARCOS TYPE), STA. CRUZ ES	DRAWN BY: 	RECOMMENDING APPROVAL : 	APPROVED BY: 
LOC: BRGY. STA. CRUZ, BACON DISTRICT SORSOGON CITY	Ma Pamela Legaspi DRAFTING AIDE	ROEL D. DOMER, C.E./RMP CIVIL CITY ENGINEER	MA. ESTER E. HAMOR CITY MAYOR

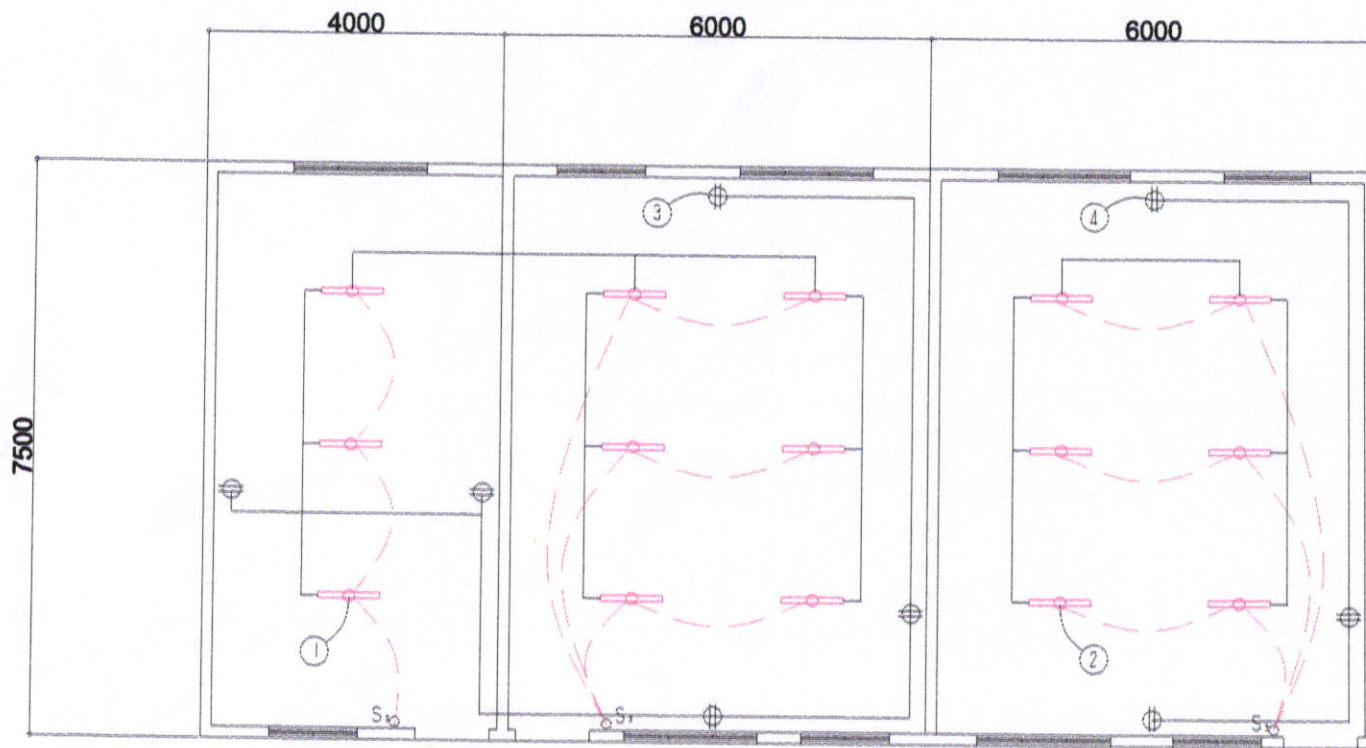

ELECTRICAL NOTES

ALL ELECTRICAL WORKS SHALL BE DONE IN ACCORDANCE WITH THE LATEST RULES AND REGULATIONS OF THE PHIL. ELECTRICAL CODE AS WELL AS THE LOCAL AUTHORITY CONCERNED AND THE LOCAL POWER COMPANY.

ALL ELECTRICAL MATERIALS TO BE USED SHALL BE NEED & APPROVED TYPE FOR LOCATION & PURPOSE

MOUNTING HEIGHTS SHALL BE AS FOLLOWS:

- a. LIGHT CONTROL SWITCH- 1.35M ABOVE FIN. FLR. LINE AT CENTER
- b. CONVENIENCE OUTLET-ABOVE 1.0M ABOVE FIN. FLR. LINE AT CENTER
- c. PANEL BOARD- 2.0 M ABOVE FIN. FLR. LINE

ALL ELECTRICAL WORKS SHALL BE UNDER THE DIRECT & IMMEDIATE SUPERVISION OF A DULY LICENSED ELECTRICAL ENGINEER OR REGISTERED MASTER ELECTRICIAN

ELECTRICAL PLAN
SCALE 1:200


SCHEDULE OF LOADS

CIRCUIT NO.	DESCRIPTION	NO. OF LOADS	VOLTS	WATTS	AMP	SIZE OF WIRE	SIZE OF CONDUIT
1	LIGHTING OUTLET	9	230	900	3.91	2-2.0mm ² THW	15mmØ
2	LIGHTING OUTLET	6	230	600	2.60	2-2.0mm ² THW	15mmØ
3	CONVENIENCE OUTLET	5	230	900	3.91	2-3.5mm ² THW	20mmØ
4	CONVENIENCE OUTLET	3	230	540	2.34	2-3.5mm ² THW	20mmØ
	TOTAL				12.76		



**CITY ENGINEER'S
OFFICE**

PROJECT TITLE: REPAIR/IMPROV. OF MULTI-PURPOSE HALL (MARCOS TYPE), STA. CRUZ ES	DRAWN BY: Ma Pamela Legaspi DRAFTING AIDE	RECOMMENDING APPROVAL : ROEL D. DOMER, C.E./RMP OIC-CITY ENGINEER	APPROVED BY: MA. ESTER E. HAMOR CITY MAYOR
LOC: BRGY. STA. CRUZ, BACON DISTRICT SORSOGON CITY			

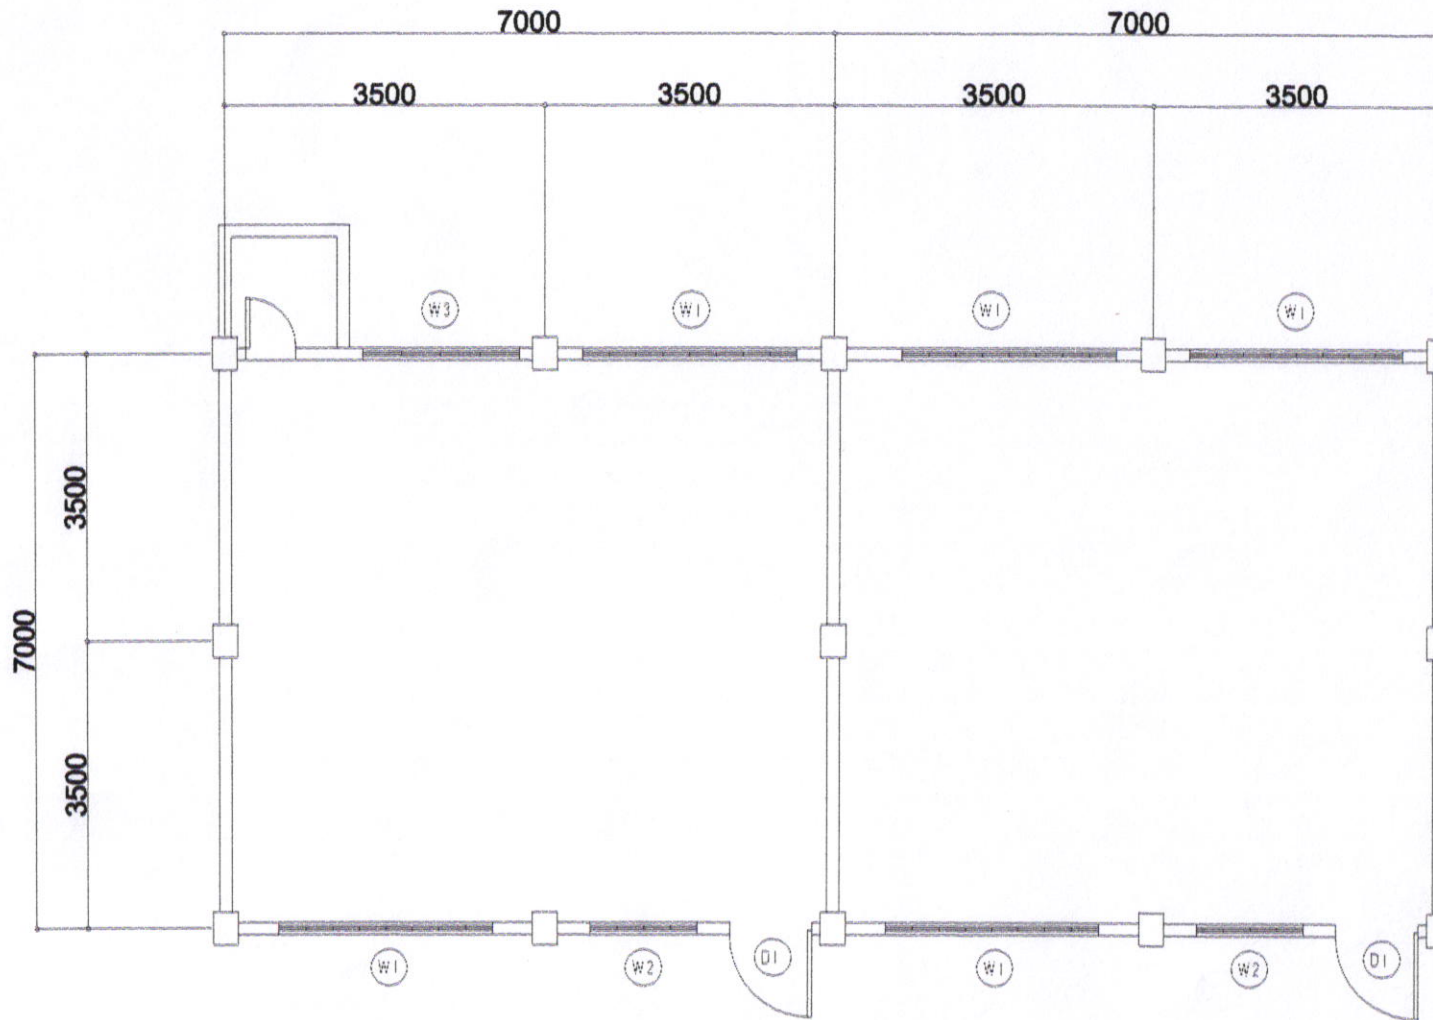


EXISTING FLOOR PLAN
SCALE: 1/20RTS




CITY ENGINEER'S
OFFICE

PROJECT TITLE:	DRAWN BY:	RECOMMENDING APPROVAL :	APPROVED BY:
REPAIR/IMPROV. OF MULTI-PURPOSE HALL (PHILIPPINES 2000), STA. CRUZ ES			
LOC: BRGY. STA. CRUZ, BACON DISTRICT SORSOGON CITY	MaPamela Legaspi DRAFTING AIDE	ROEL D. DOMER, C.E./RMP CITY ENGINEER	MA. ESTER E. HAMOR CITY MAYOR

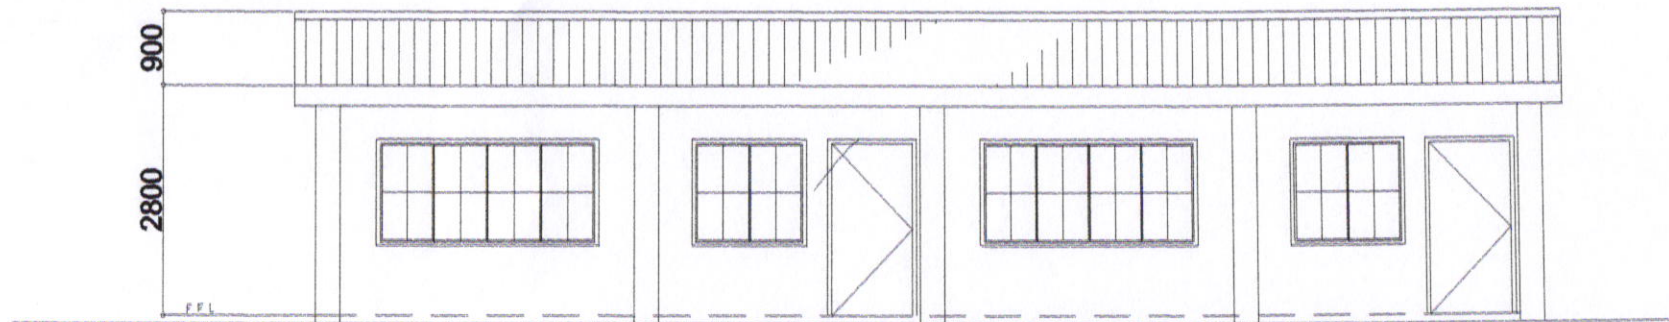

FRONT ELEVATION
SCALE: 1/25RTS

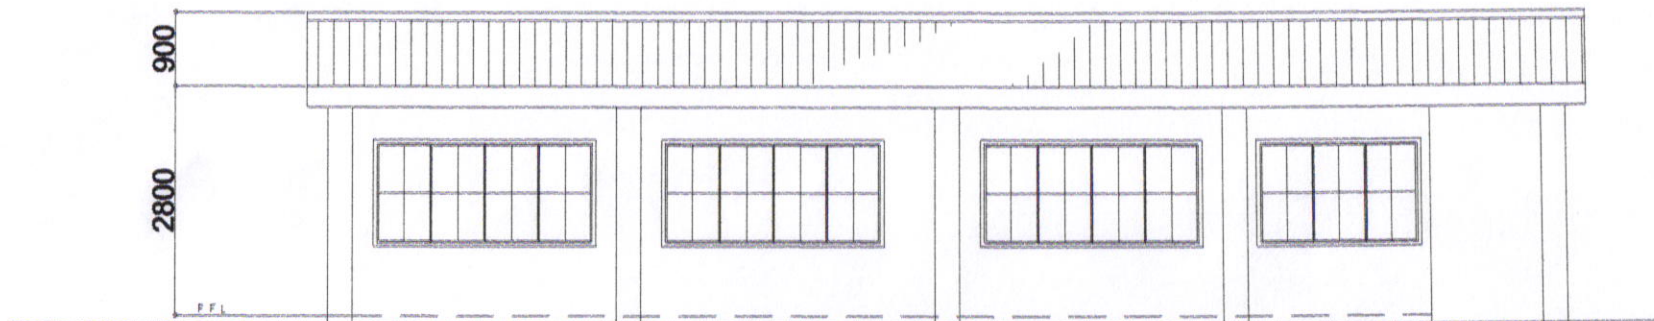

REAR ELEVATION
SCALE: 1/25RTS



CITY ENGINEER'S
OFFICE

PROJECT TITLE:

REPAIR/IMPROV. OF MULTI-PURPOSE HALL
(PHILIPPINES 2000), STA. CRUZ ES

LOC: BRGY. STA. CRUZ, BACON DISTRICT
SORSOGON CITY

DRAWN BY:




Ma Pamela Legaspi
DRAFTING AIDE

RECOMMENDING APPROVAL :

ROEL D. DOMER, C.E./RMP
OIC-CITY ENGINEER

APPROVED BY:

MA. ESTER E. HAMOR
CITY MAYOR

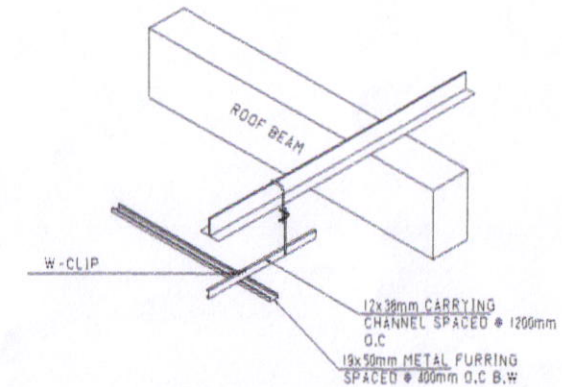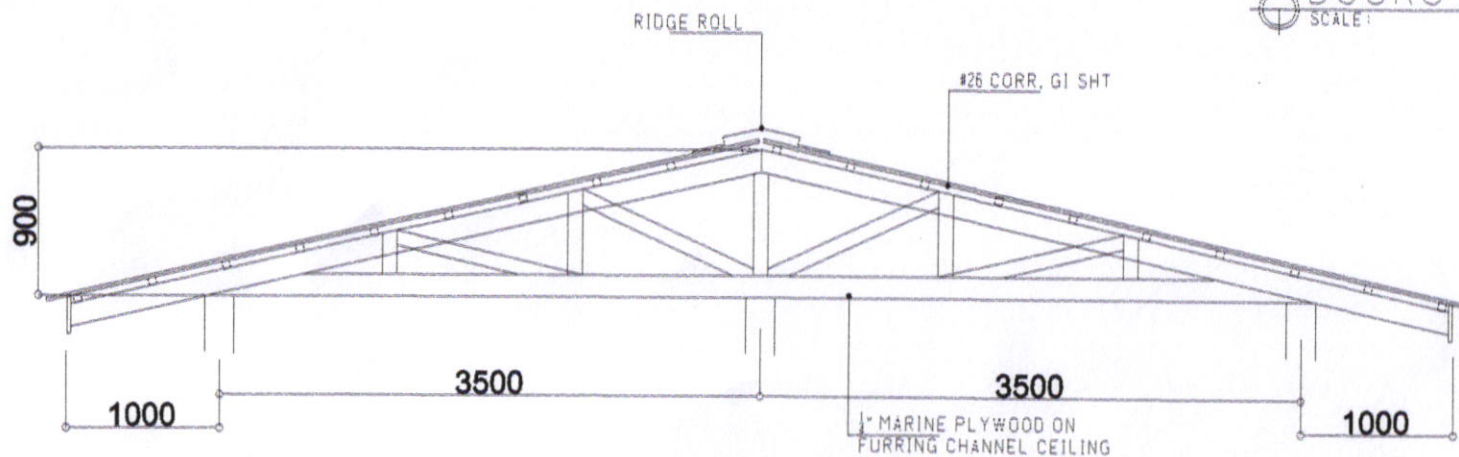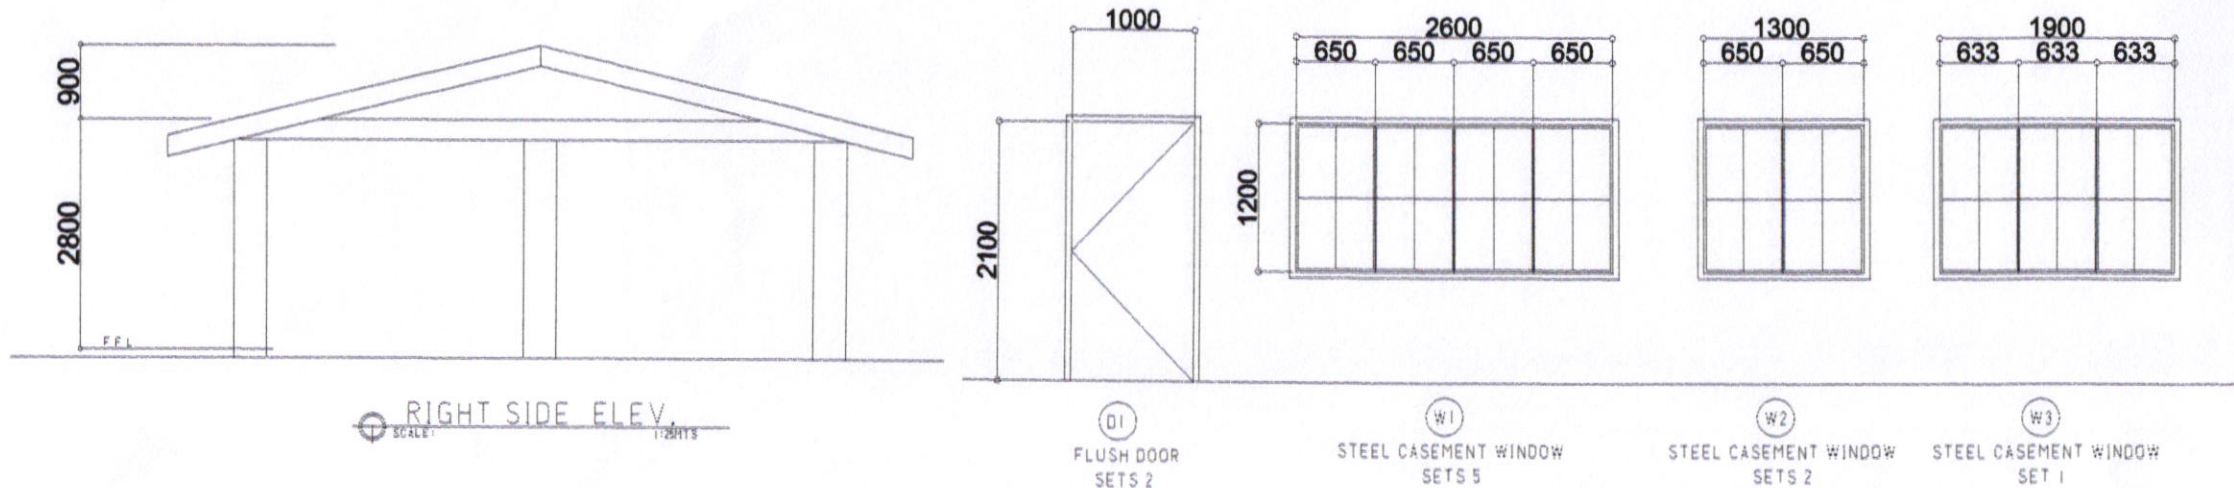

**CITY ENGINEER'S
OFFICE**

PROJECT TITLE:

REPAIR/IMPROV. OF MULTI-PURPOSE HALL
(PHILIPPINES 2000), STA. CRUZ ES

LOC: BRGY. STA. CRUZ, BACON DISTRICT

SORSOGON CITY

DRAWN BY:

Ma Pamela Legaspi

DRAFTING AIDE

RECOMMENDING APPROVAL:


ROEL D. DOMER, C.E./RMP

CITY ENGINEER

APPROVED BY:

MA. ESTER E. HAMCR

CITY MAYOR

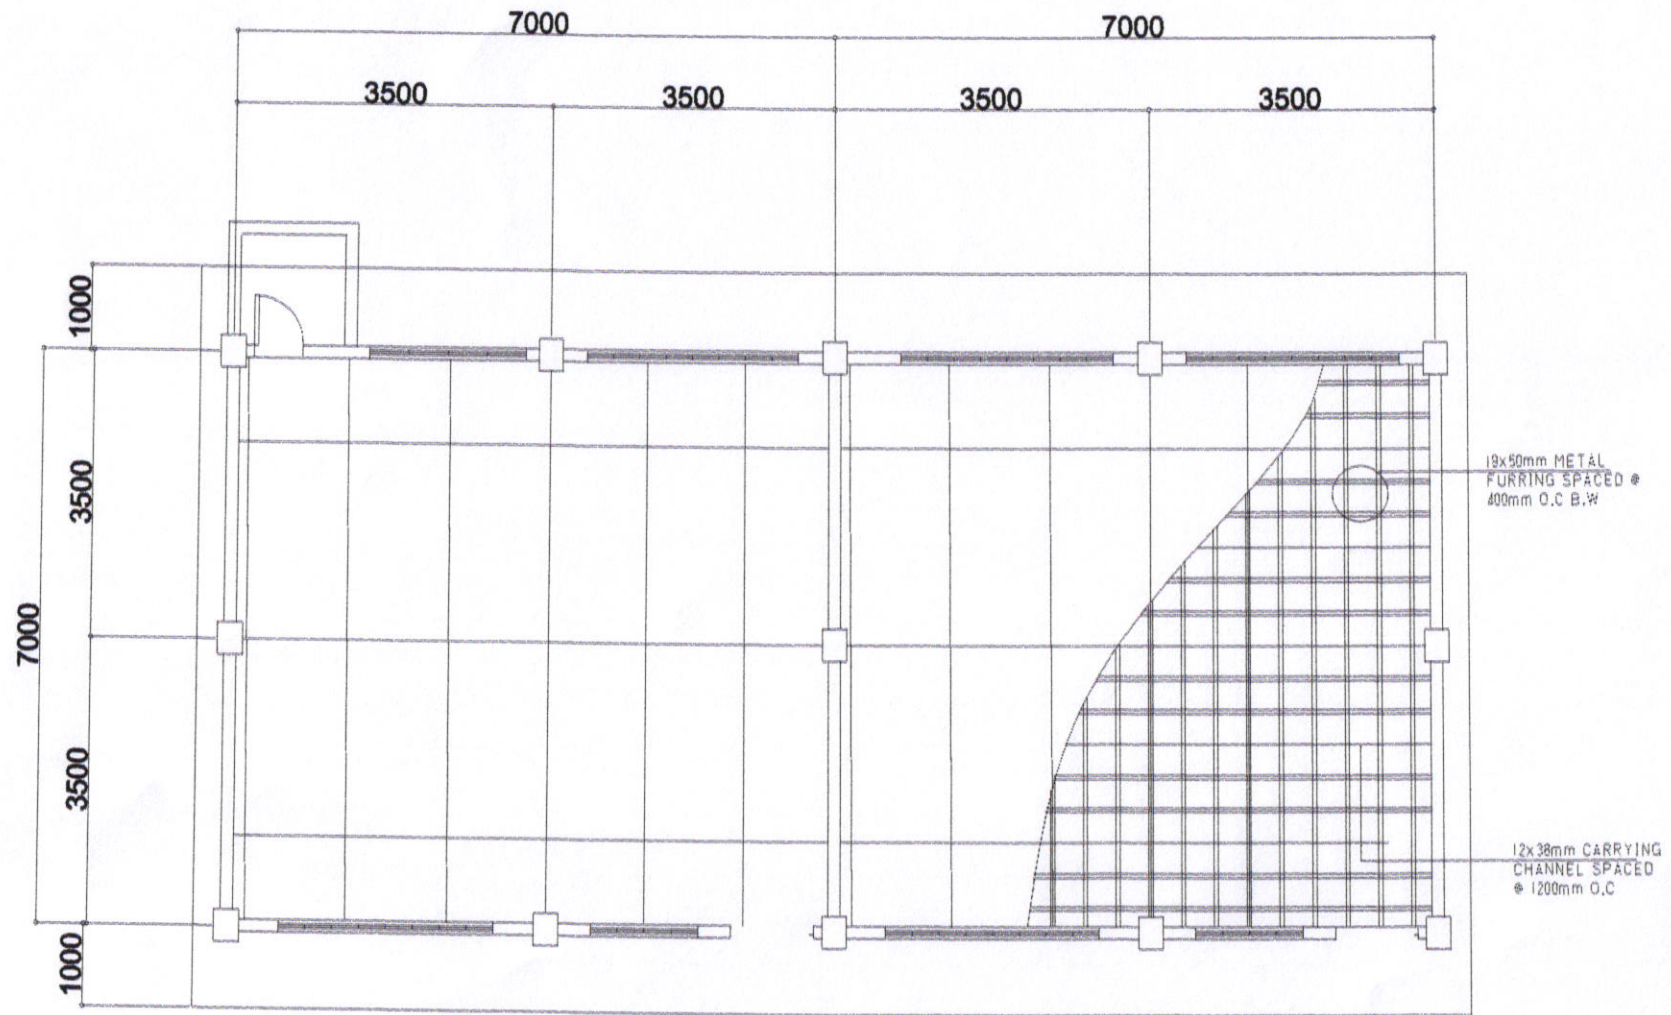


ROOF PLAN
SCALE: 1/25HTS



CITY ENGINEER'S
OFFICE

<p>PROJECT TITLE: REPAIR/IMPROV. OF MULTI-PURPOSE HALL (PHILIPPINES 2000), STA. CRUZ ES</p>	<p>DRAWN BY: Ma Pamela Legaspi</p>	<p>RECOMMENDING APPROVAL : ROEL D. DOMER, C.E./RMP CIC-CITY ENGINEER</p>	<p>APPROVED BY: MA. ESTER E. HAMOR CITY MAYOR</p>
<p>LOC: BRGY. STA. CRUZ, BACON DISTRICT SORSOGON CITY</p>	<p>DRAFTING AIDE</p>		

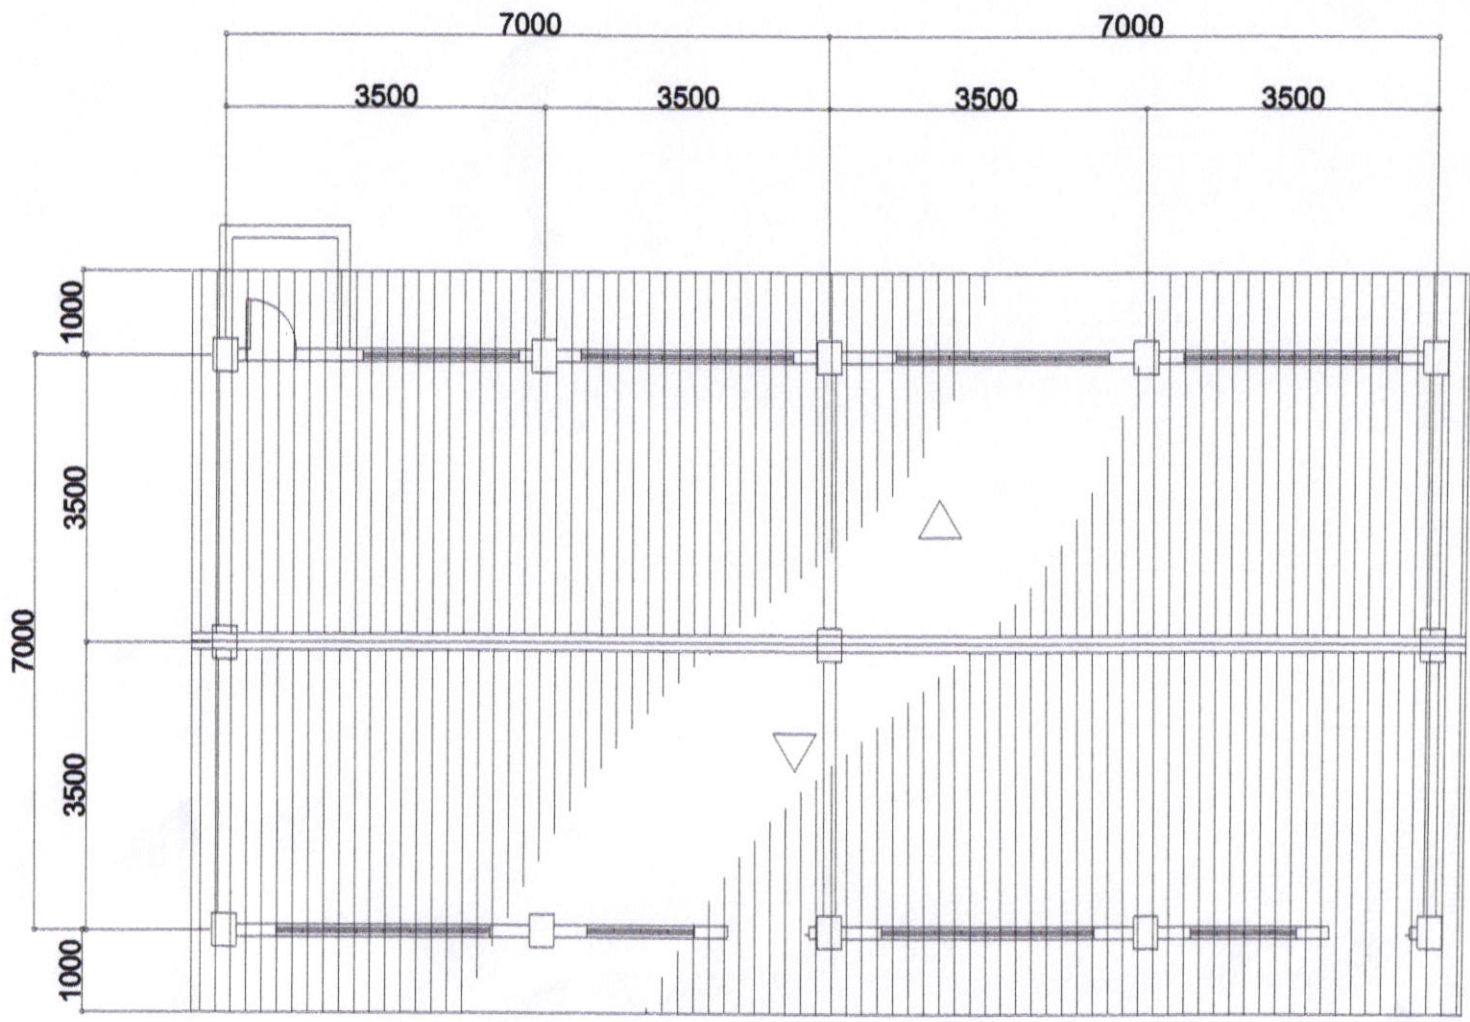


ROOF PLAN
SCALE: 1/25RTS



CITY ENGINEER'S
OFFICE

PROJECT TITLE: REPAIR/IMPROV. OF MULTI-PURPOSE HALL (PHILIPPINES 2000), STA. CRUZ ES	DRAWN BY: 	RECOMMENDING APPROVAL : 	APPROVED BY:
LOC: BRGY. STA. CRUZ, BACON DISTRICT SORSOGON CITY	Ma Pamela Legaspi DRAFTING AIDE	ROEL D. DOMER, C.E./RMP DIC-CITY ENGINEER	MA. ESTER E. HAMOR CITY MAYOR

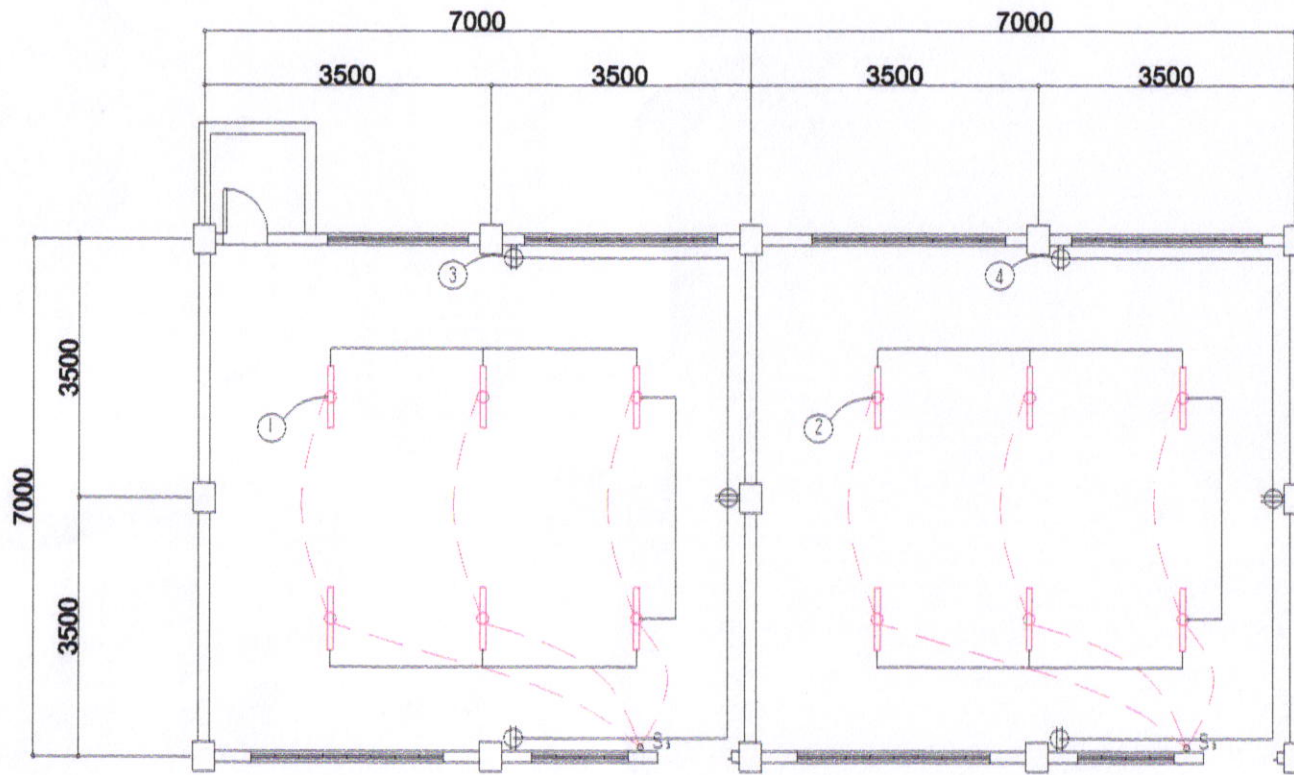

ELECTRICAL PLAN
SCALE 1/2500

ELECTRICAL NOTES

ALL ELECTRICAL WORKS SHALL BE DONE IN ACCORDANCE WITH THE LATEST RULES AND REGULATIONS OF THE PHIL. ELECTRICAL CODE AS WELL AS THE LOCAL AUTHORITY CONCERNED AND THE LOCAL POWER COMPANY.

ALL ELECTRICAL MATERIALS TO BE USED SHALL BE NEED & APPROVED TYPE FOR LOCATION & PURPOSE

MOUNTING HEIGHTS SHALL BE AS FOLLOWS:

- a. LIGHT CONTROL SWITCH- 1.35M ABOVE FIN. FLR. LINE AT CENTER
- b. CONVENIENCE OUTLET-ABOVE 1.0M ABOVE FIN. FLR. LINE AT CENTER
- c. PANEL BOARD- 2.0 M ABOVE FIN. FLR. LINE

ALL ELECTRICAL WORKS SHALL BE UNDER THE DIRECT & IMMEDIATE SUPERVISION OF A DULY LICENSED ELECTRICAL ENGINEER OR REGISTERED MASTER ELECTRICIAN

SCHEDULE OF LOADS

CIRCUIT NO.	DESCRIPTION	NO. OF LOADS	VOLTS	WATTS	AMP	SIZE OF WIRE	SIZE OF CONDUIT
1	LIGHTING OUTLET	6	230	600	2.60	2-2.0mm ² THW	15mmØ
2	LIGHTING OUTLET	6	230	600	2.60	2-2.0mm ² THW	15mmØ
3	CONVENIENCE OUTLET	3	230	540	2.34	2-3.5mm ² THW	20mmØ
4	CONVENIENCE OUTLET	3	230	540	2.34	2-3.5mm ² THW	20mmØ
	TOTAL				9.88		



**CITY ENGINEER'S
OFFICE**

PROJECT TITLE:

REPAIR/IMPROV. OF MULTI-PURPOSE HALL
(PHILIPPINES 2000), STA. CRUZ ES

LOC: BRGY. STA. CRUZ, BACON DISTRICT
SORSOGON CITY

DRAWN BY:

MaPamela Legaspi
DRAFTING AIDE

RECOMMENDING APPROVAL :


ROEL B. DOMER, C.E./RMP
CIC-CITY ENGINEER

APPROVED BY:

MA. ESTER E. HAMOR
CITY MAYOR

STA. CRUZ ELEMENTARY SCHOOL

PHILIPPINES 2000 BUILDING (2 UNITS)

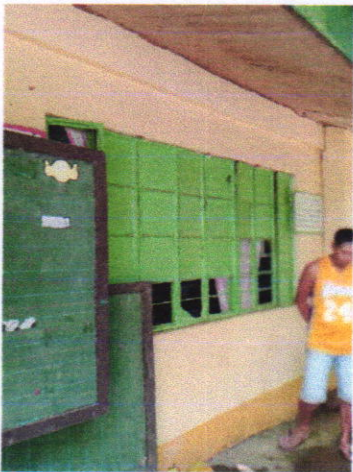

STA. CRUZ ELEMENTARY SCHOOL

BLSB BUILDING



STA. CRUZ ELEMENTARY SCHOOL

MARCOS TYPE BUILDING

