

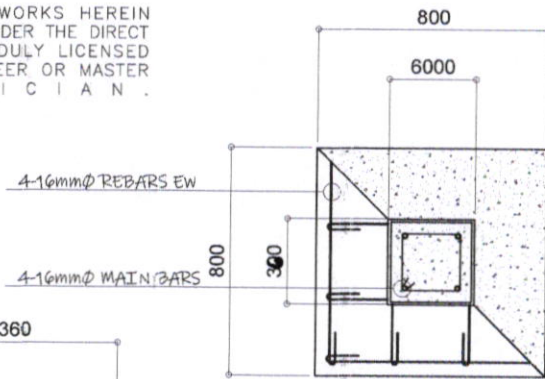


**ELECTRICAL NOTES**


1. ALL ELECTRICAL WORKS HEREIN SHALL BE DONE IN ACCORDANCE WITH THE LATEST EDITION OF THE PHILIPPINE ELECTRICAL CODE, THE NATIONAL BUILDING CODE, RULES AND REGULATIONS ORDINANCE OF THE LOCAL GOVERNMENT UNIT CONCERNED, AND THE POLICIES AND REQUIREMENTS OF THE LOCAL UTILITY COMPANY.
2. ALL MATERIALS THAT SHALL BE USED MUST BE OF STANDARD QUALITY, NEW, AND APPROVED TYPE FOR LOCATION AND PURPOSE.
3. ALTERATION IN THE DESIGN SPECIFICATIONS IN THE ELECTRICAL PLAN ESPECIALLY DURING INSTALLATION SHOULD BE BROUGHT TO THE ATTENTION OF THE DESIGNER FOR CHECKING AND DOCUMENTATION.
4. ALL ELECTRICAL WORKS HEREIN SHALL BE DONE UNDER THE DIRECT SUPERVISION OF DULY LICENSED ELECTRICAL ENGINEER OR MASTER ELECTRICIAN.

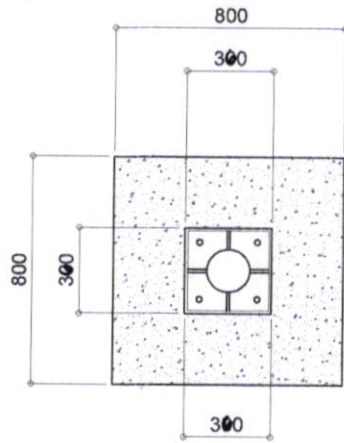



**PLAN**  
SCALE N.T.S.

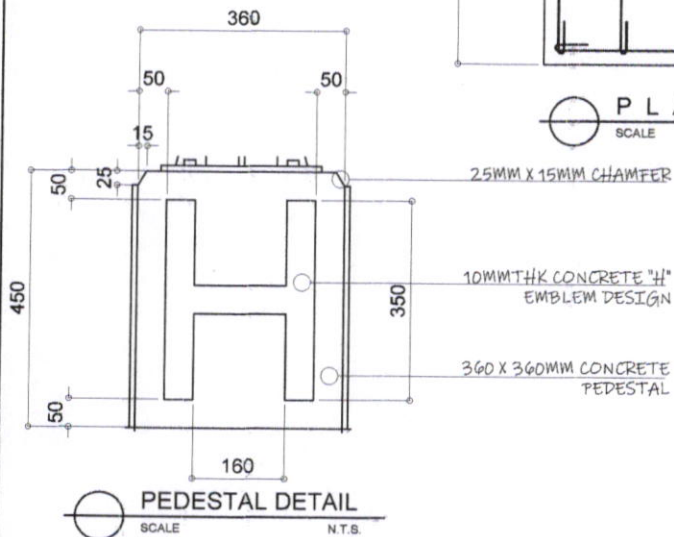



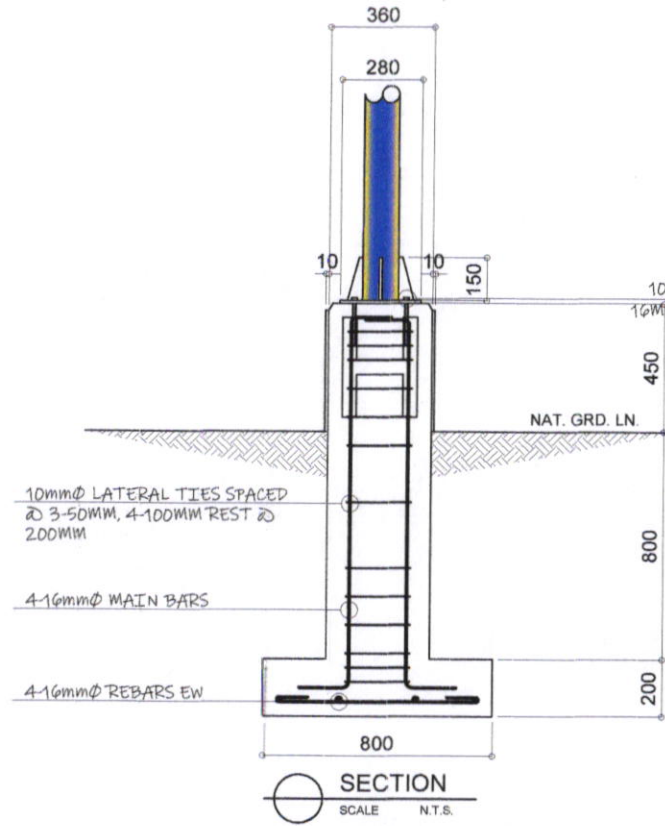


**PEDESTAL DETAIL**  
SCALE N.T.S.

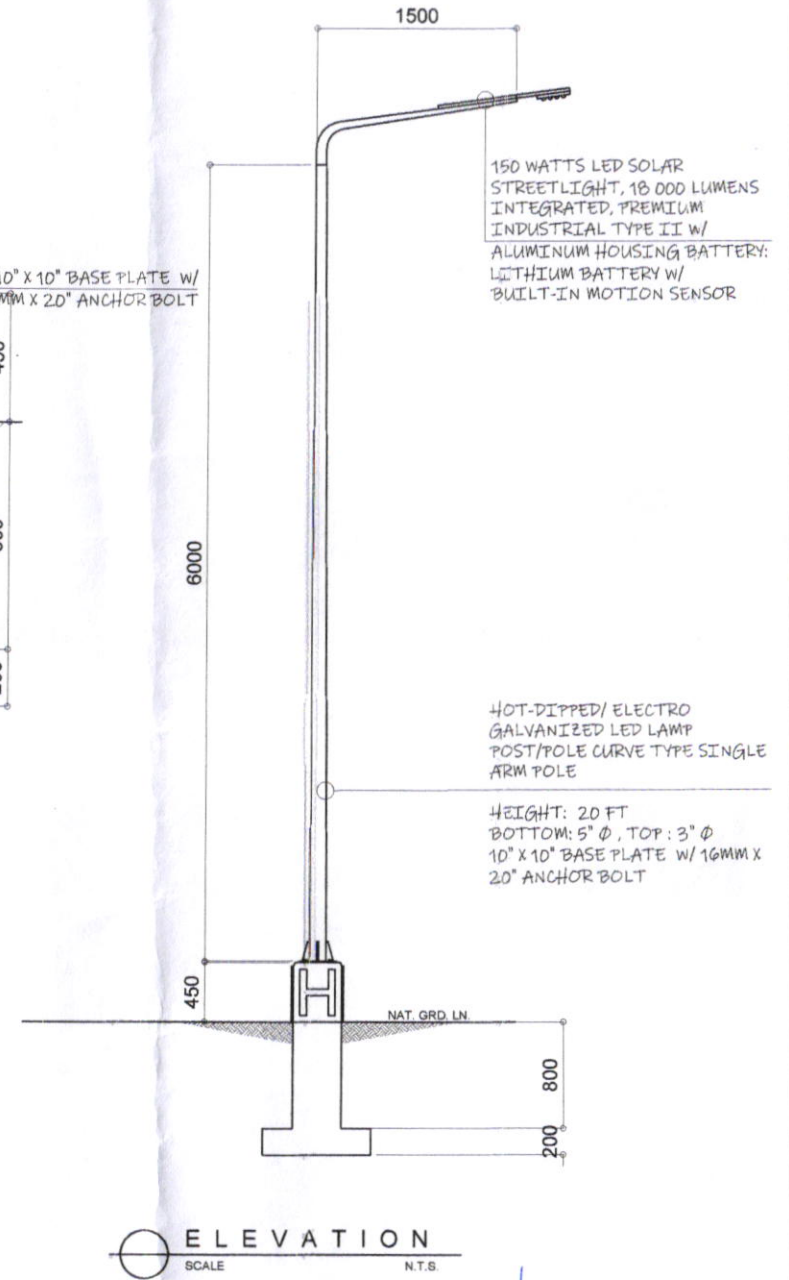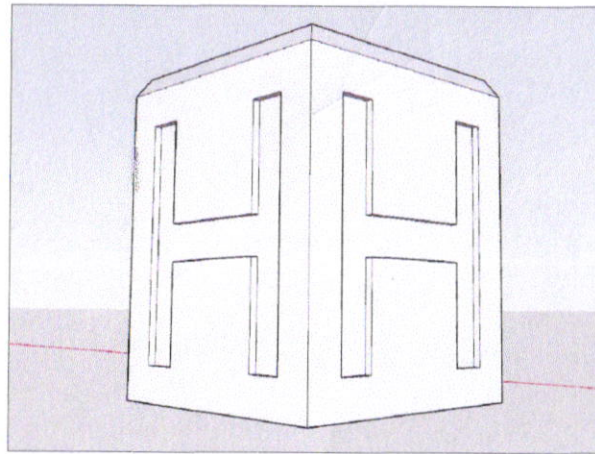


**SECTION**  
SCALE N.T.S.



**ELEVATION**  
SCALE N.T.S.

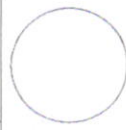

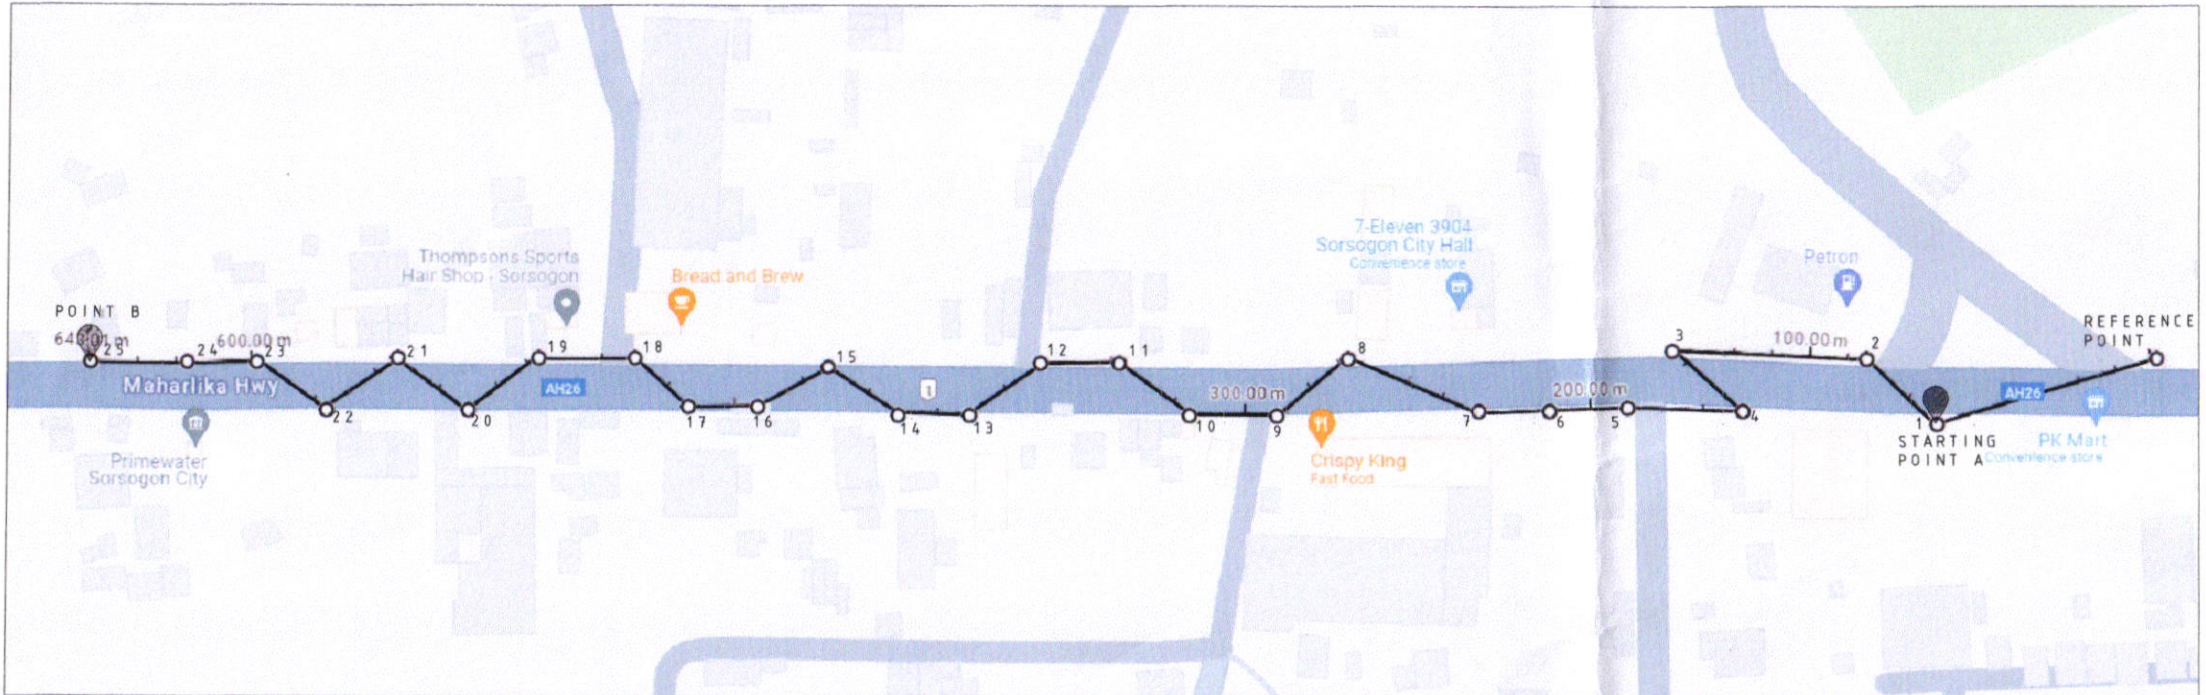


PREPARED FROM	PROJECT TITLE:	DRAWN BY:	RECOMMENDED BY:	APPROVED BY:	SHEET NO.
 SORSOGON CITY CITY ENGINEER'S OFFICE	CONSTRUCTION AND INSTALLATION OF STREETLIGHTS	 M. A. GONZALEZ, UAP ARCHITECTURAL ASSISTANT	 ROEL D. HAMOR, RMP CITY ENGINEER	 HON. MA. ESTER E. HAMOR CITY MAYOR	
LOCATION: ALONG BRGY. CABID-AN, ABUYOG TO MARINAS, EAST DIST., SORSOGON CITY					





LOCATION MAP  
SCALE N.T.S.

## 25 UNITS OF SOLAR STREETLIGHTS @ 20 METERS SPACING





 
PREPARED FROM	PROJECT TITLE:	DRAWN BY:	RECOMMENDED BY:	APPROVED BY:	SHEET NO.
 SORSOGON CITY CITY ENGINEER'S OFFICE	CONSTRUCTION AND INSTALLATION OF STREETLIGHTS (ALONG BRGY. CABID-AN) LOCATION: ALONG BRGY. CABID-AN, ABUYOG TO MARINAS, EAST DIST. SORSOGON CITY	 m.m.d.g. Zalgo, uap ARCHITECTURAL ASSISTANT	 RODEL B. BACHER, DR./RMP CITY ENGINEER	 HON. MA. ESTER E. HAMOR CITY MAYOR	






LOCATION MAP  
SCALE N.T.S.

45 UNITS OF SOLAR STREETLIGHTS @ 20 METERS SPACING (900 METERS)



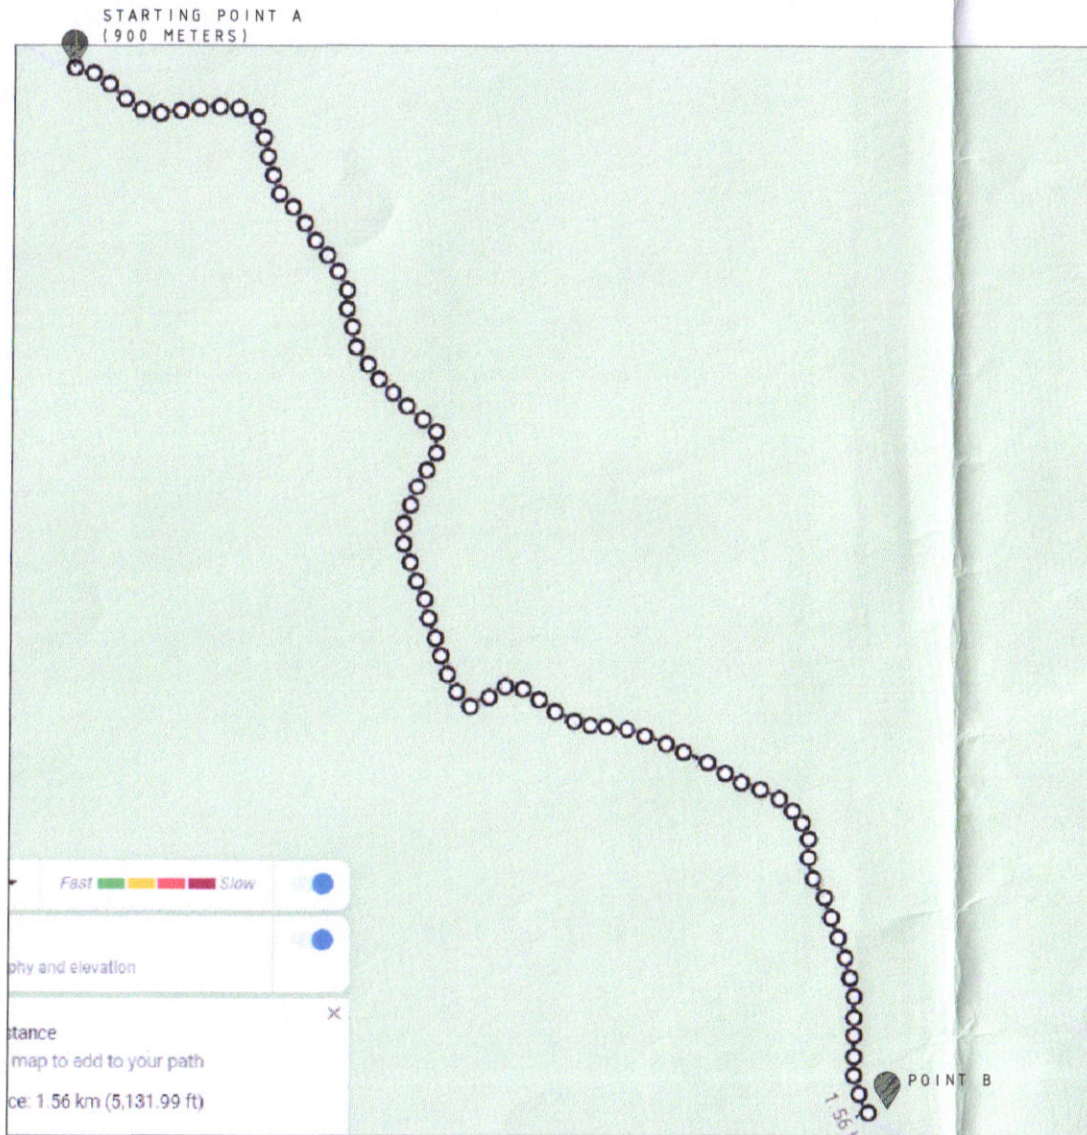

PREPARED FROM:	PROJECT TITLE:	DRAWN BY:	RECOMMENDED BY:	APPROVED BY:	SHEET NO.
 SORSOGON CITY CITY ENGINEER'S OFFICE	CONSTRUCTION AND INSTALLATION OF STREETLIGHTS (ABUYOG-MARINAS ROAD) LOCATION: ALONG BRGY. CABID-AN, ABUYOG TO MARINAS, EAST DIST. SORSOGON CITY	 m.a.gorzalen, uap ARCHITECTURAL ASSISTANT	 ROEL D. BOMER, C.E. RMP CITY ENGINEER	 HON. MA. ESTER E. HAMOR CITY MAYOR	





78 UNITS OF SOLAR STREETLIGHTS @  
20 METERS SPACING (1560 METERS)

LOCATION MAP  
SCALE N.T.S.

PREPARED FROM	PROJECT TITLE	DRAWN BY	RECOMMENDED BY	APPROVED BY	SHEET NO.
 SORSOGON CITY CITY ENGINEER'S OFFICE	CONSTRUCTION AND INSTALLATION OF STREETLIGHTS (ABUYOG - MARINAS ROAD) LOCATION: ALONG BRGY. CABID-AN, ABUYOG TO MARINAS, EAST DIST. SORSOGON CITY	 m.m.a.gonzales, uap ARCHITECTURAL ASSISTANT	 ROEL D. DIMER, CRMP CITY ENGINEER	 HON. MA. VER E. HAMOR CITY MAYOR	