

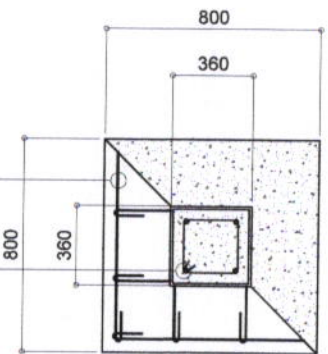


ELECTRICAL NOTES


1. ALL ELECTRICAL WORKS HEREIN SHALL BE DONE IN ACCORDANCE WITH THE LATEST EDITION OF THE PHILIPPINE ELECTRICAL CODE, THE NATIONAL BUILDING CODE, RULES AND REGULATIONS ORDNANCE OF THE LOCAL GOVERNMENT UNIT CONCERNED, AND THE POLICIES AND REQUIREMENTS OF THE LOCAL UTILITY COMPANY.
2. ALL MATERIALS THAT SHALL BE USED MUST BE OF STANDARD QUALITY, NEW, AND APPROVED TYPE FOR LOCATION AND PURPOSE.
3. ALTERATION IN THE DESIGN SPECIFICATIONS IN THE ELECTRICAL PLAN ESPECIALLY DURING INSTALLATION SHOULD BE BROUGHT TO THE ATTENTION OF THE DESIGNER FOR CHECKING AND DOCUMENTATION
4. ALL ELECTRICAL WORKS HEREIN SHALL BE DONE UNDER THE DIRECT SUPERVISION OF DULY LICENSED ELECTRICAL ENGINEER OR MASTER ELECTRICIAN.

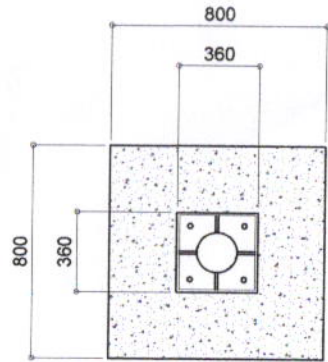



PLAN
SCALE N.T.S.

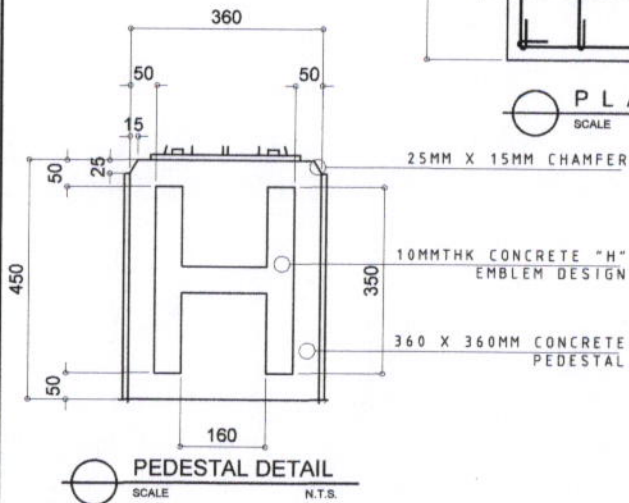

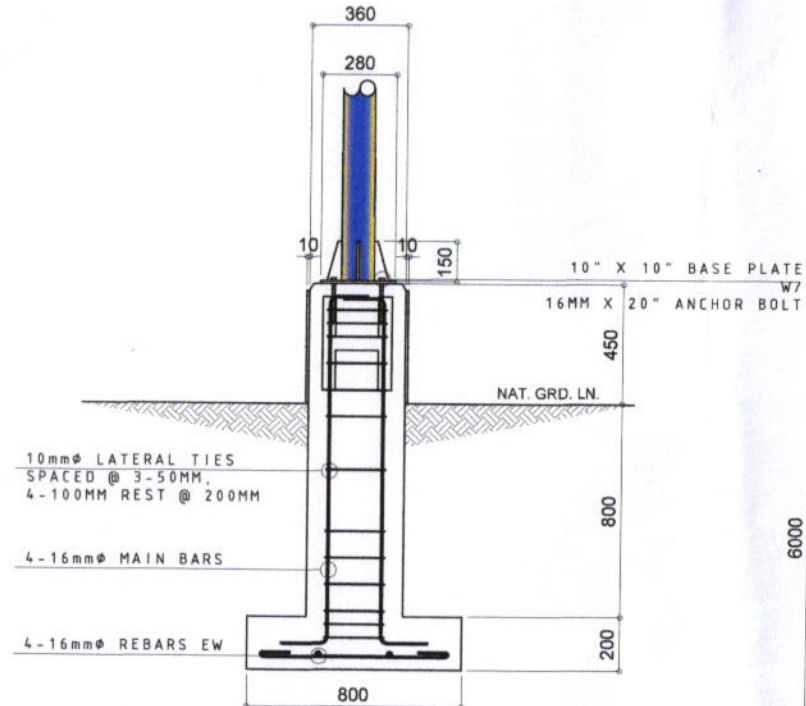




PEDESTAL DETAIL
SCALE N.T.S.

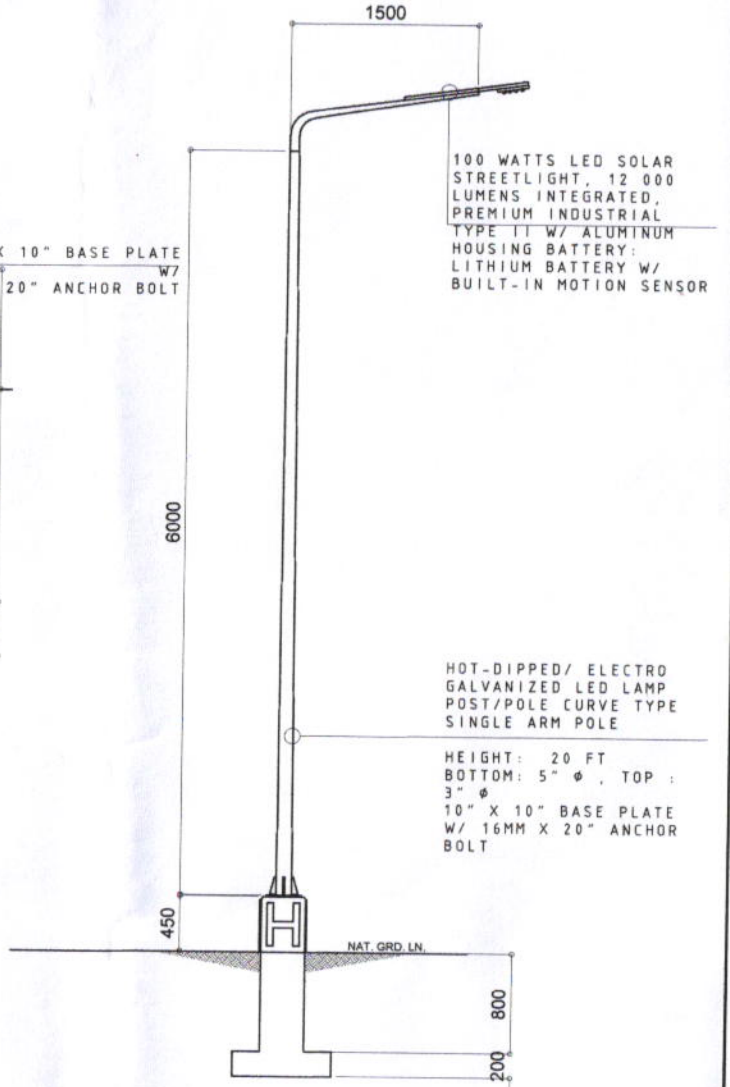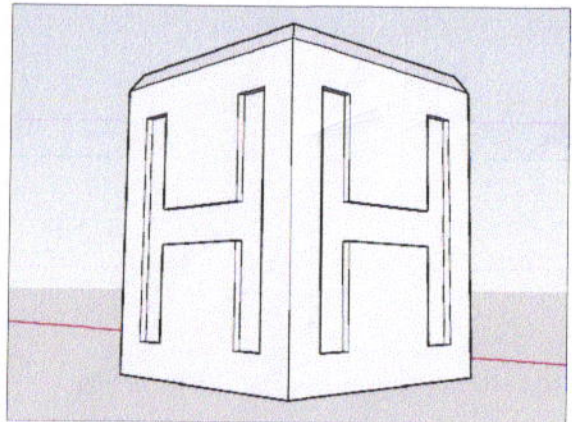


SECTION
SCALE N.T.S.





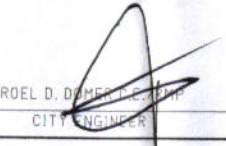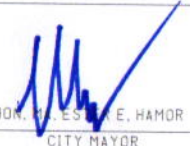

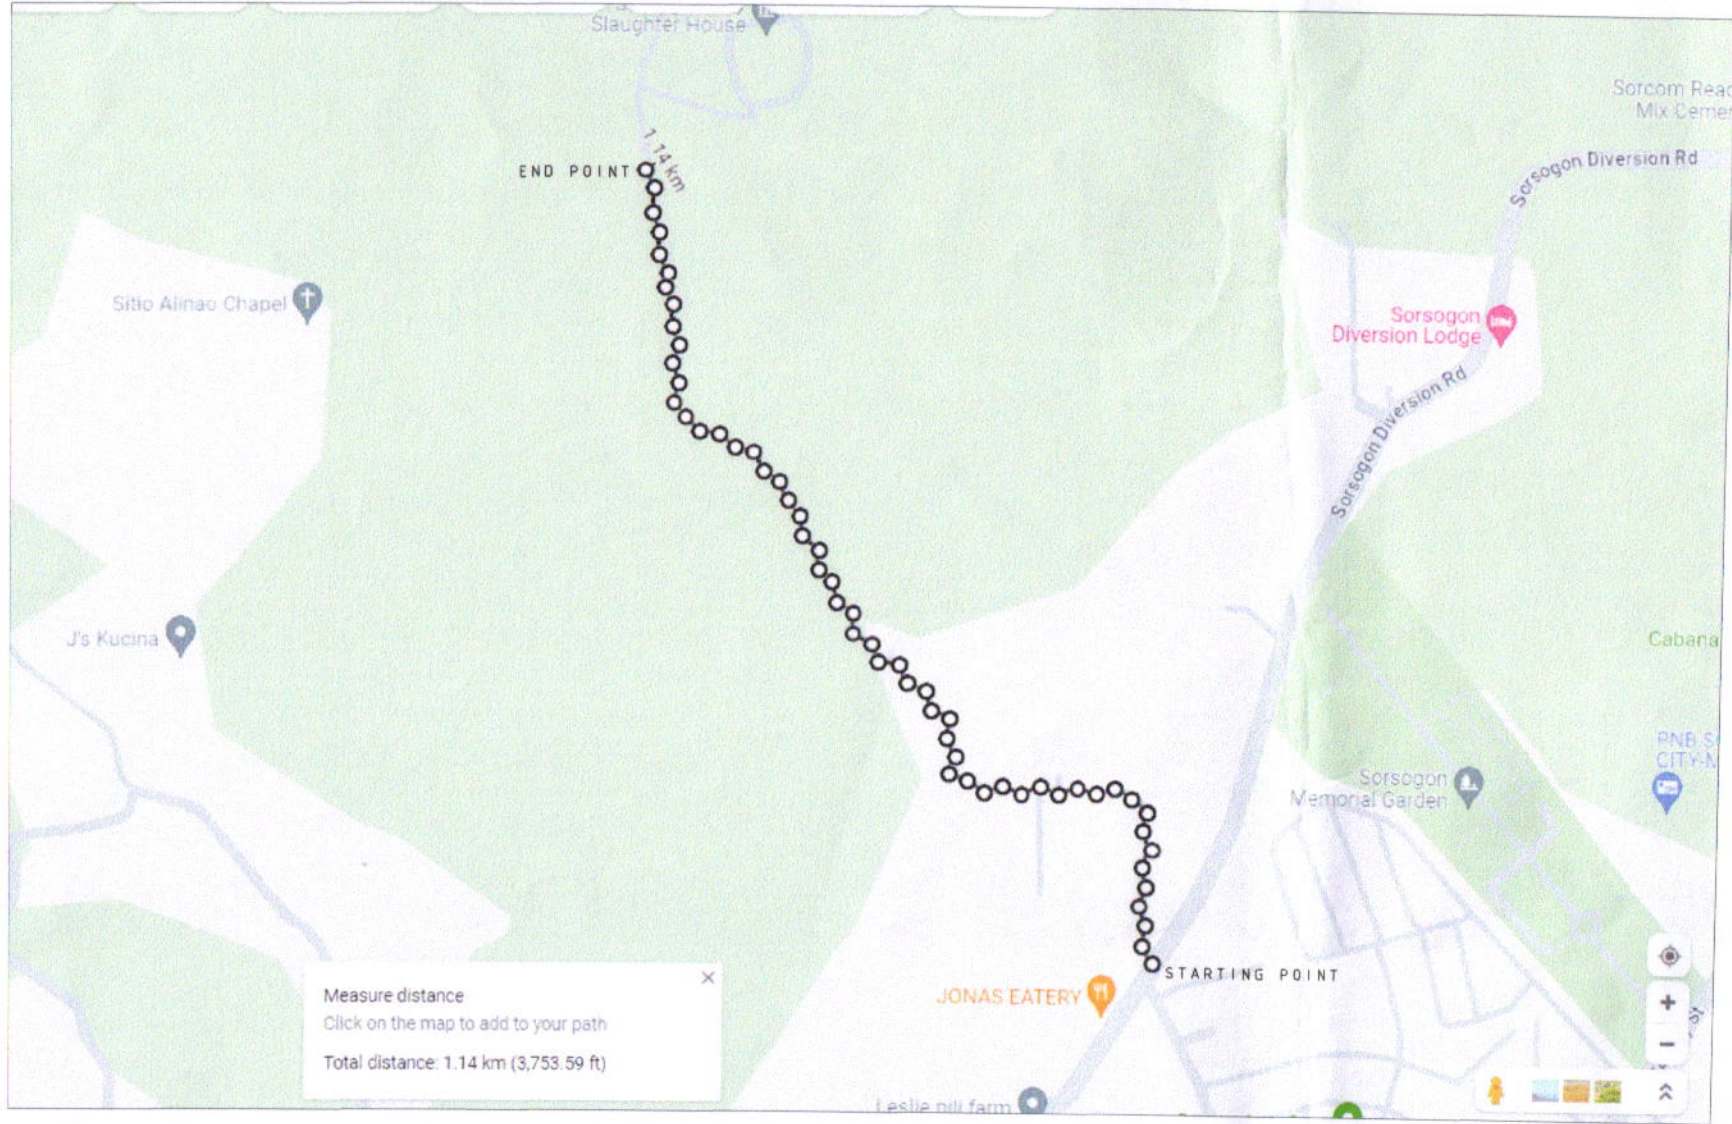
ELEVATION
SCALE N.T.S.

PREPARED FROM: 	PROJECT TITLE: CONSTRUCTION AND INSTALLATION OF SOLAR STREETLIGHTS	DRAWN BY:  M.M. GONZALES, UAP ARCHITECTURAL ASSISTANT	RECOMMENDED BY:  ROEL D. DEMERIT, UAP CITY ENGINEER	APPROVED BY:  HON. M. ESTEBAN HAMOR CITY MAYOR	SHEET NO. 
LOCATION: SITIO MADAN-AN, BRGY. BIBINCAHAN, EAST DIST. SORSOGON CITY					









LOCATION MAP
SCALE N.T.S.


57 UNITS OF SOLAR STREETLIGHTS @ 20 METERS SPACING (1140 METERS)

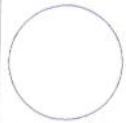
PREPARED FROM	PROJECT TITLE:	DRAWN BY:	RECOMMENDED BY:	APPROVED BY:	SHEET NO.
 SORSOGON CITY CITY ENGINEER'S OFFICE	CONSTRUCTION / INSTALLATION OF SOLAR STREETLIGHTS LOCATION: SITIO MADAN - AN, BRGY. BIBINCAHAN EAST DIST. SORSOGON CITY	 m.m.a.gonzalvo, uap ARCHITECTURAL ASSISTANT	 ROEL D. OMER, C.E./RMP CITY ENGINEER	 HON. MA. ESTER E. HAMOR CITY MAYOR	

ELECTRICAL NOTES

1. ALL ELECTRICAL WORKS HEREIN SHALL BE DONE IN ACCORDANCE WITH THE LATEST EDITION OF THE PHILIPPINE ELECTRICAL CODE, THE NATIONAL BUILDING CODE, RULES AND REGULATIONS OR DINANCE OF THE LOCAL GOVERNMENT UNIT CONCERNED, AND THE POLICIES AND REQUIREMENTS OF THE LOCAL UTILITY COMPANY.
2. ALL MATERIALS THAT SHALL BE USED MUST BE OF STANDARD QUALITY, NEW, AND APPROVED TYPE FOR LOCATION AND PURPOSE.
3. ALTERATION IN THE DESIGN SPECIFICATIONS IN THE ELECTRICAL PLAN ESPECIALLY DURING INSTALLATION SHOULD BE BROUGHT TO THE ATTENTION OF THE DESIGNER FOR CHECKING AND DOCUMENTATION
4. ALL ELECTRICAL WORKS HEREIN SHALL BE DONE UNDER THE DIRECT SUPERVISION OF DULY LICENSED ELECTRICAL ENGINEER OR MASTER ELECTRICIAN.

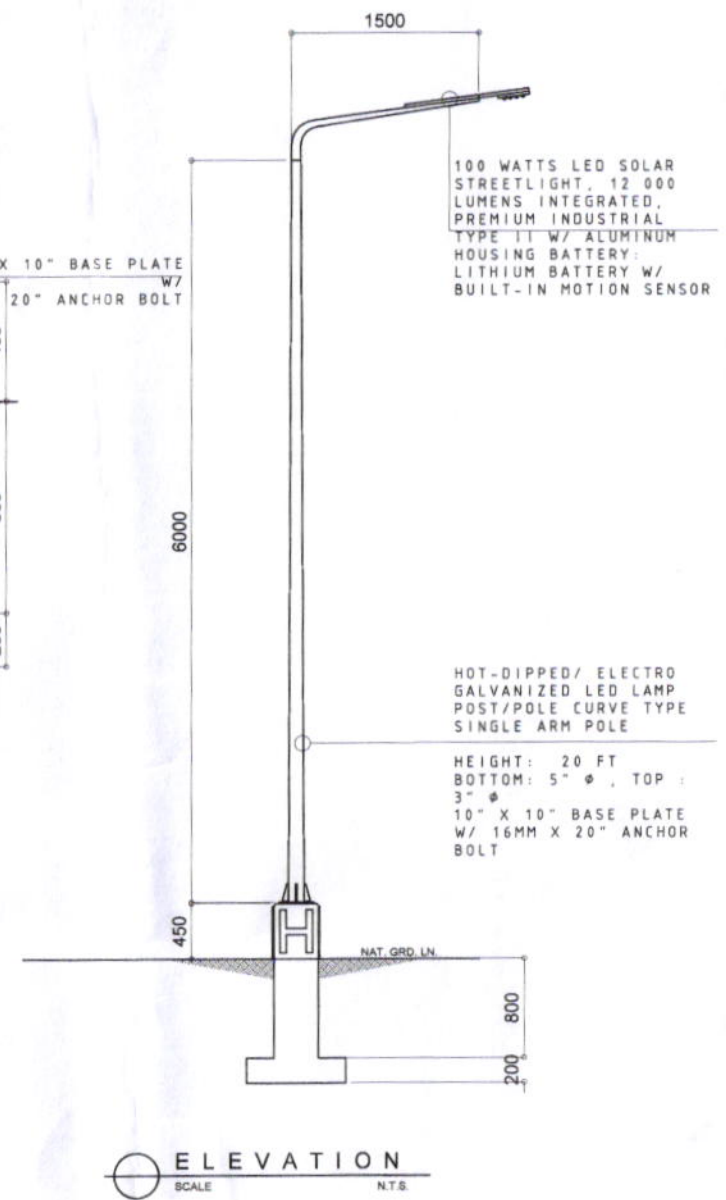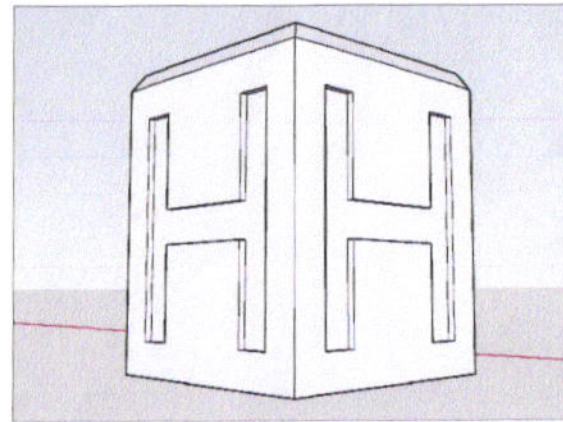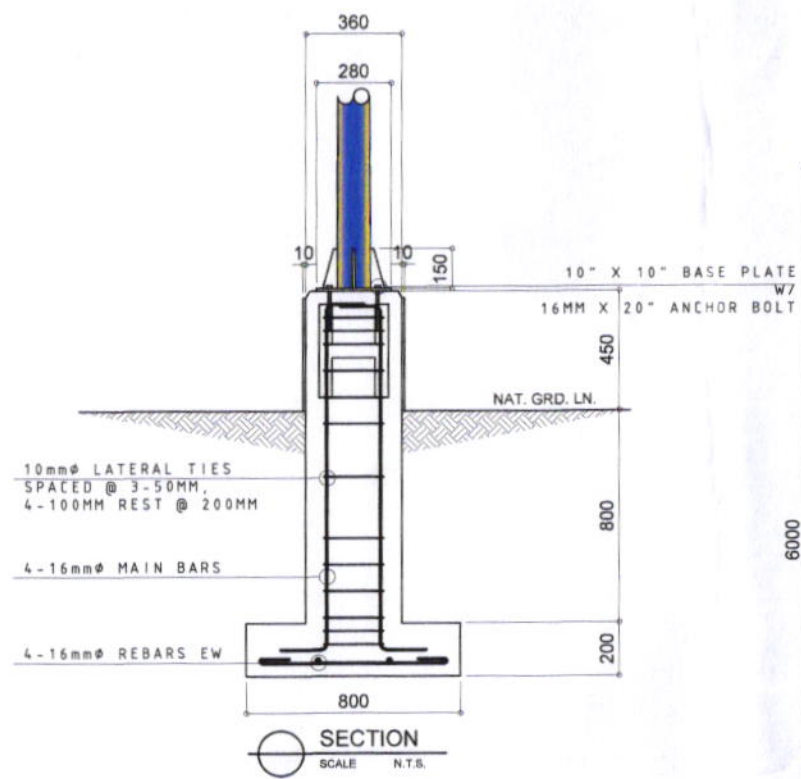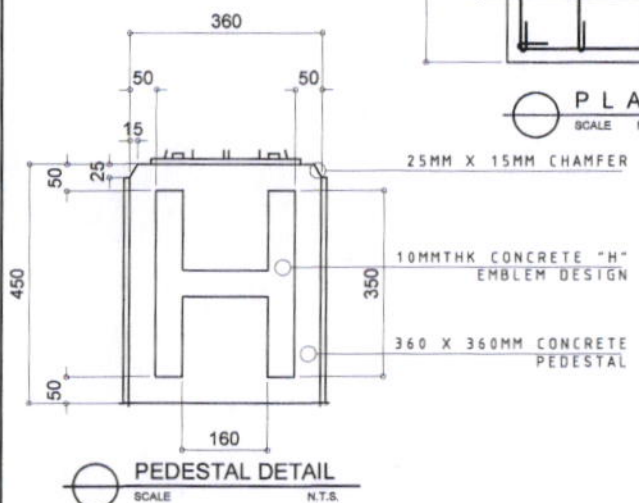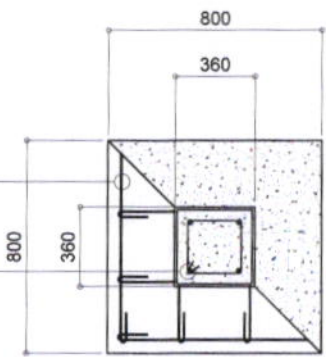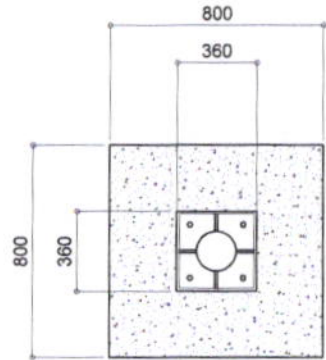



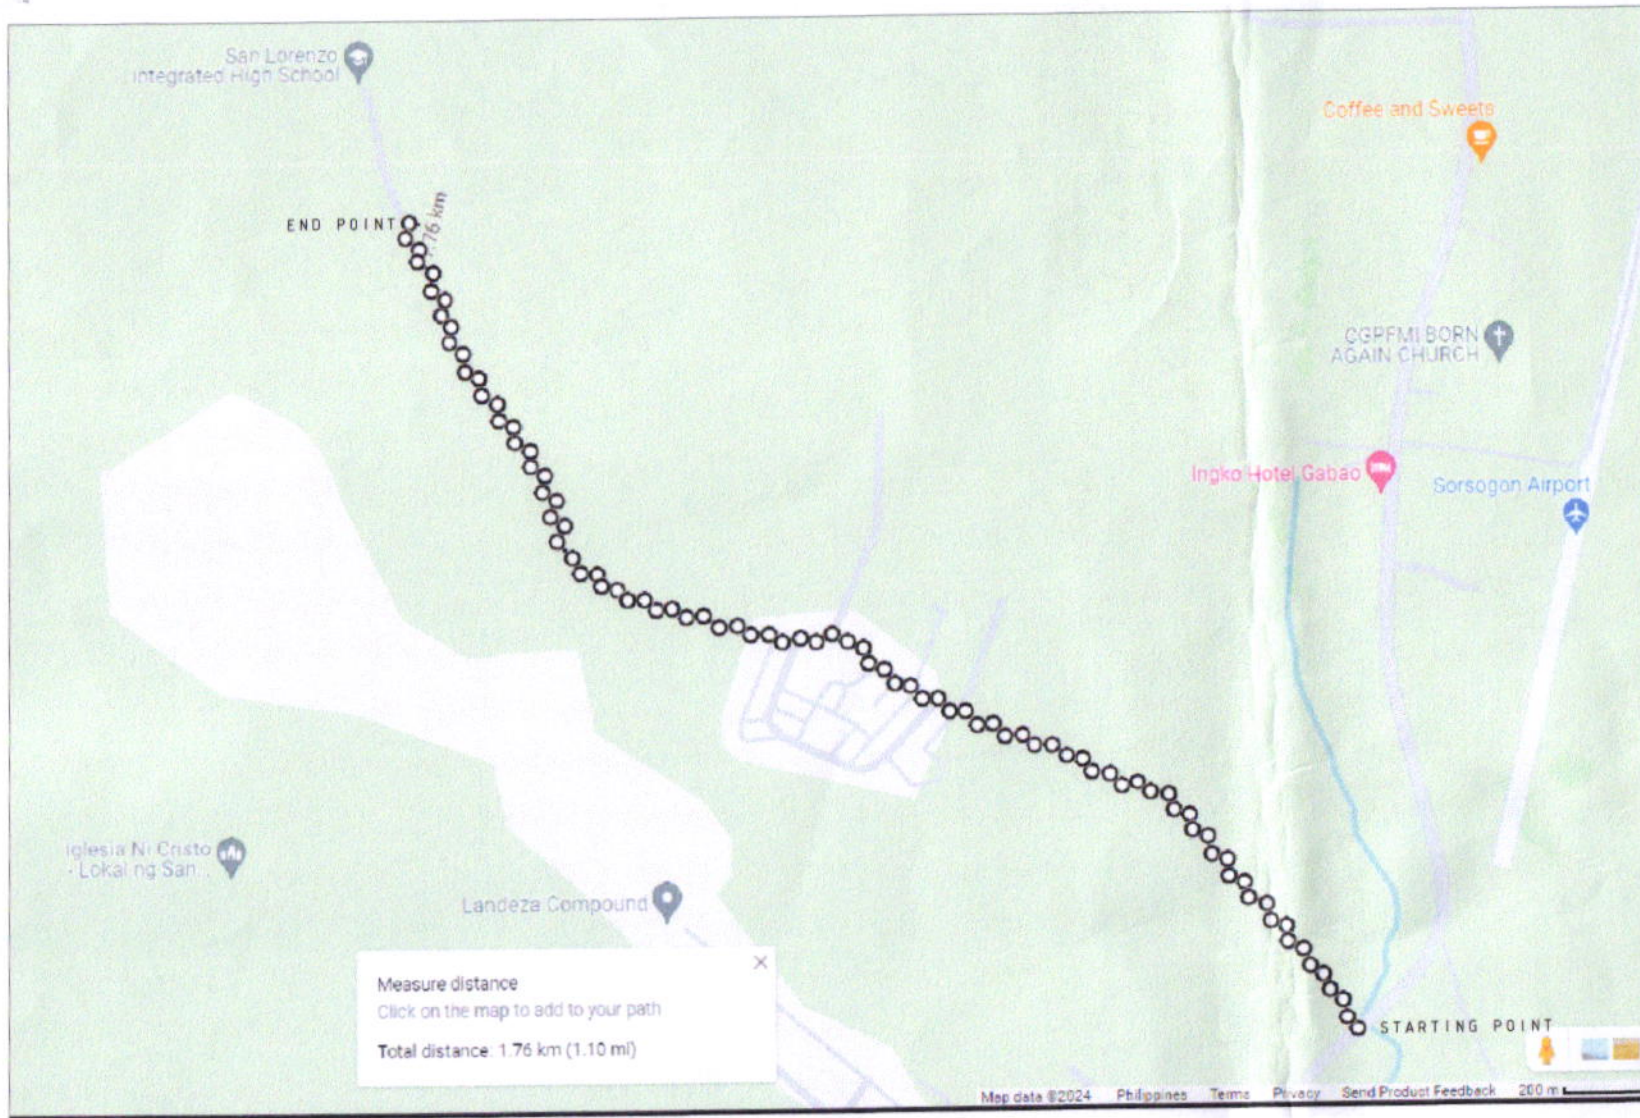


<p>PREPARED FROM:</p>  <p>SORSOGON CITY CITY ENGINEER'S OFFICE</p>	<p>PROJECT TITLE:</p> <p>CONSTRUCTION AND INSTALLATION OF SOLAR STREETLIGHTS</p> <p>LOCATION: SITIO SAN LORENZO, BRGY. BIBINCAHAN, EAST DIST. SORSOGON CITY</p>	<p>DRAWN BY:</p> <p><i>[Signature]</i></p> <p>m.m.d. gonza go, udp ARCHITECTURAL ASSISTANT</p>	<p>RECOMMENDED BY:</p> <p><i>[Signature]</i></p> <p>ROEL D. RAMER, C.E., R.M.P. CITY ENGINEER</p>	<p>APPROVED BY:</p> <p><i>[Signature]</i></p> <p>HON. MA. ESTER E. HAMOR CITY MAYOR</p>	<p>SHEET NO.</p> <p>○</p>
---	---	--	---	---	---------------------------



LOCATION MAP
SCALE N.T.S.

88 UNITS OF SOLAR STREETLIGHTS @ 20 METERS SPACING (1760 METERS)

PREPARED FROM	PROJECT TITLE	DRAWN BY	RECOMMENDED BY	APPROVED BY	SHEET NO.
 SORSOGON CITY CITY ENGINEER'S OFFICE	CONSTRUCTION / INSTALLATION OF SOLAR STREETLIGHTS	 m.m.d.gonzalvo, uap ARCHITECTURAL ASSISTANT	 ROEL EDMER CITY ENGINEER	 HON. MA. ESTER E. HAMOR CITY MAYOR	
LOCATION: SITIO SAN LORENZO, BRGY. BIBINCAHAN EAST DIST, SORSOGON CITY					