

GENERAL NOTES :

1. DRAWINGS ARE NOT TO BE SCALED, DIMENSIONS SHALL HAVE PREFERENCE OVER SCALE AND SHALL BE VERIFIED ON SITE AND COORDINATED WITH THE WORK OF ALL TRADES. IF A DIMENSION REPRESENTATIVE FOR CLARIFICATION BEFORE PROCEEDING.
2. THE INTENT OF DRAWINGS AND SPECIFICATIONS IS TO PROVIDE FOR A PLUMB, LEVEL AND SQUARE UNLESS OTHERWISE NOTED.
3. THE CONTRACTOR SHALL VERIFY ALL DIMENSIONS AND EXISTING CONDITION THAT PERTAIN TO THE WORK OF INDIVIDUAL TRADES. DISCREPANCIES BETWEEN DRAWINGS AND SITE CONDITIONS SHALL BE BROUGHT TO THE ATTENTION OF THE ARCHITECT/DESIGNER/OWNER'S REPRESENTATIVE BEFORE COMMENCEMENT OR RESUMPTION OF THE WORK.
4. DETAILS SHOWN ARE TYPICAL CONDITIONS UNLESS OTHERWISE NOTED.
5. DRAWINGS INDICATE DETAILS OF GENERAL DESIGN INTENT, DETAILS INTENDED TO SHOW GENERAL MANNER OF ACCOMPLISHING WORK. MINOR MODIFICATIONS MAYBE ALLOWED/REQUIRED TO SUIT THE JOB DIMENSION OR CONDITIONS AND ARE INCLUDED AS PART OF THE WORK. THE CONTRACTOR SHALL OBTAIN APPROVAL OF MODIFICATIONS FROM THE DESIGNER/OWNER'S REPRESENTATIVE.
6. THE CONTRACTOR SHALL COORDINATE SIZES, LOCATION AND CONSTRUCTION OF ALL OPENINGS TO SATISFY THE STRUCTURAL REQUIREMENTS AND MAINTAIN THE REQUIRED FIRE SEPARATION.
7. THE CONTRACTOR SHALL TAKE THE NECESSARY PRECAUTION TO AVOID DAMAGE TO EXISTING SITE AREA AND FEATURES INCLUDING LANDSCAPE, SIDEWALKS, ROADWAYS, CURBS, PLANTERS, UNDERGROUND UTILITIES. THE CONTRACTOR SHALL REPAIR TO ORIGINAL CONDITIONS AT NO ADDITIONAL COST TO THE OWNER.
8. SEE STRUCTURAL, SANITARY, ELECTRICAL, FIRE PROTECTION, MECHANICAL AND OTHER CONSULTANT DRAWINGS FOR ADDITIONAL GENERAL NOTES APPLICABLE TO SCOPE OF CONSTRUCTION WORK WHICH MAY NOT BE NOTED HEREWITH.



PERSPECTIVE



Republic of the Philippines
PROVINCE OF SORSOGON
CITY OF SORSOGON
Office of the Building Official

LAND USE AND ZONING

LINE AND GRADE

ARCHITECTURAL

CIVIL / STRUCTURAL

ELECTRICAL

SANITARY

PLUMBING

MECHANICAL

ELECTRONICS

PREPARED FROM:

PROJECT TITLE:

DRAWN:

RECOMMENDED BY:

APPROVED BY:

SHEET NO.



RENOVATION OF DRRMO / EOC BUILDING


LOCATION: CITY HALL COMPOUND, BRGY. CABID-AN, EAST DIST. SORSOGON CITY.


DRAFTSMAN III

ROEL D. DOMESALUMP
CITY ENGINEER

HON. MA. ESTER E. HAMOR
CITY MAYOR



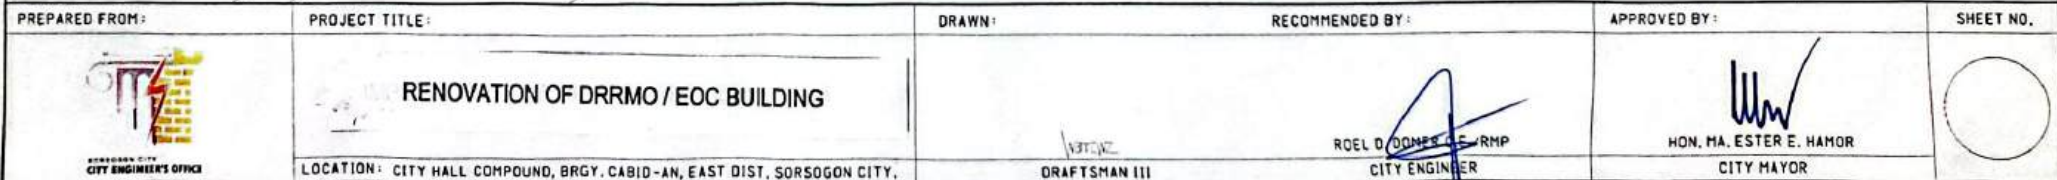

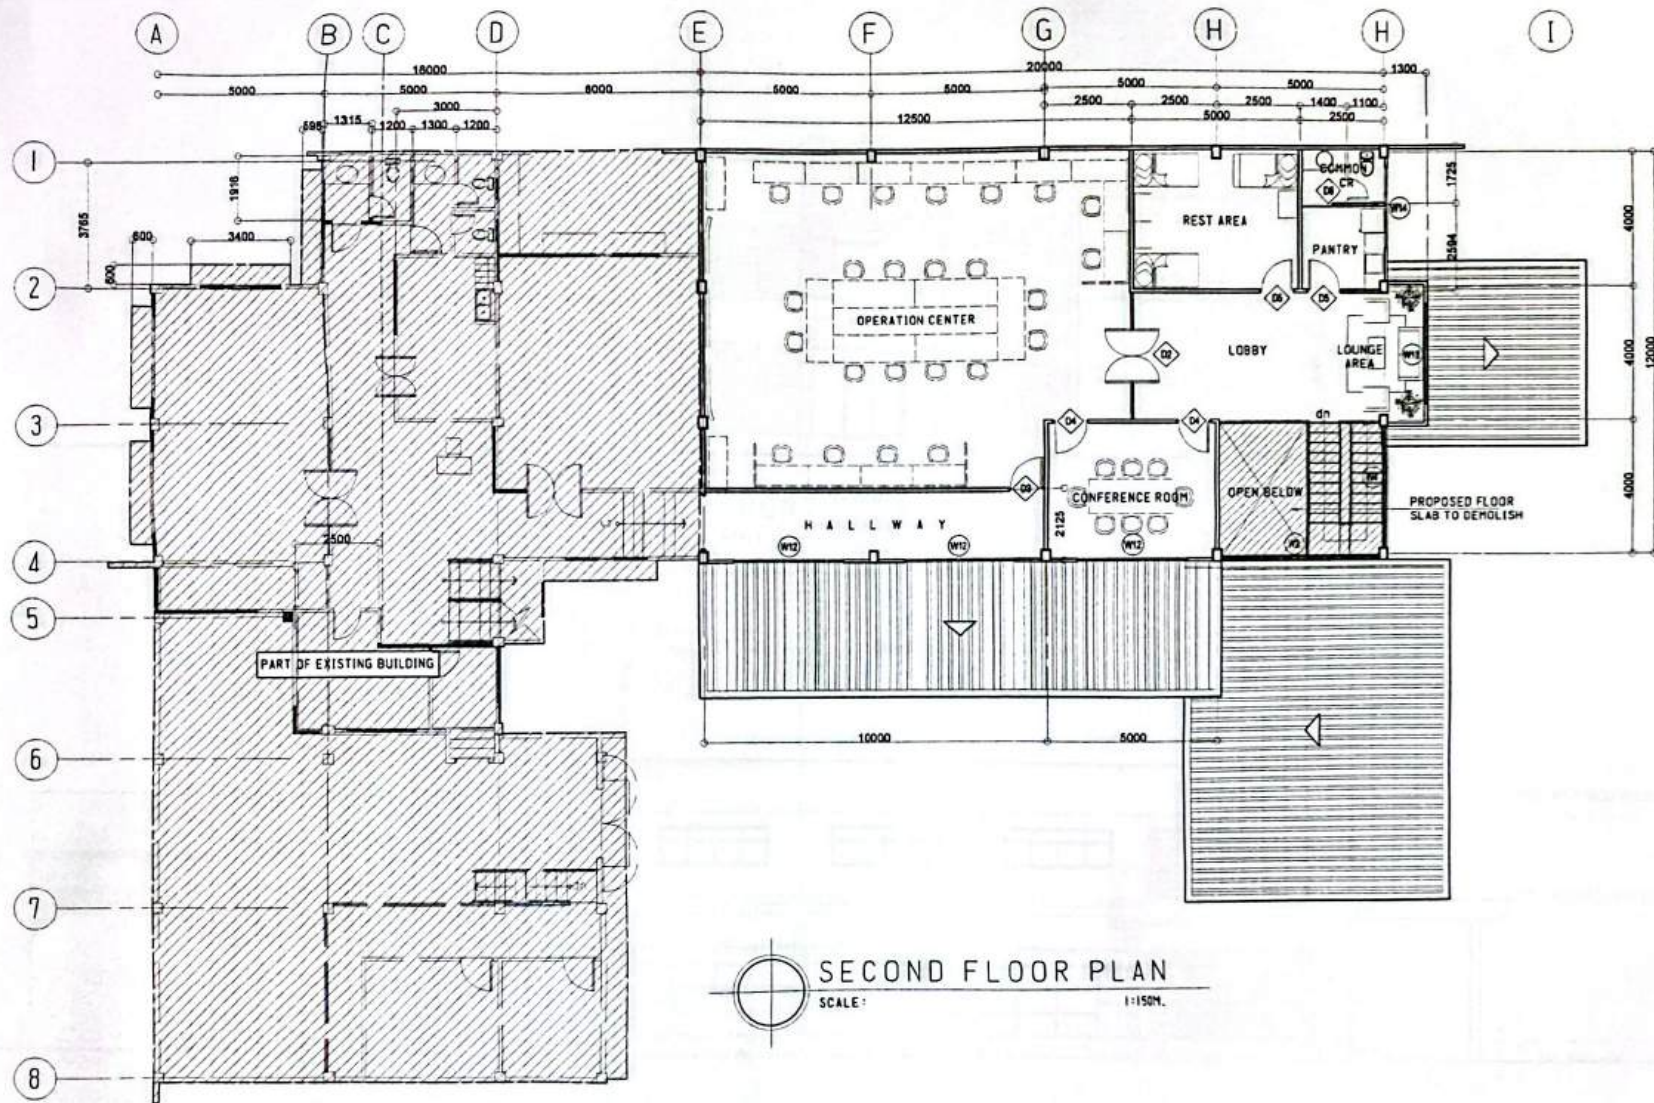

PREPARED FROM:

PROJECT TITLE:

DRAWN:

RECOMMENDED BY:

APPROVED BY:

SHEET NO.



SORSOGON CITY
CITY ENGINEER'S OFFICE

RENOVATION OF DRRMO / EOC BUILDING


LOCATION: CITY HALL COMPOUND, BRGY. CABID-AN, EAST DIST. SORSOGON CITY.

DRAFTSMAN III

ROEL D. GONER, JR., FMP
CITY ENGINEER


HON. MA. ESTER E. HAMOR
CITY MAYOR



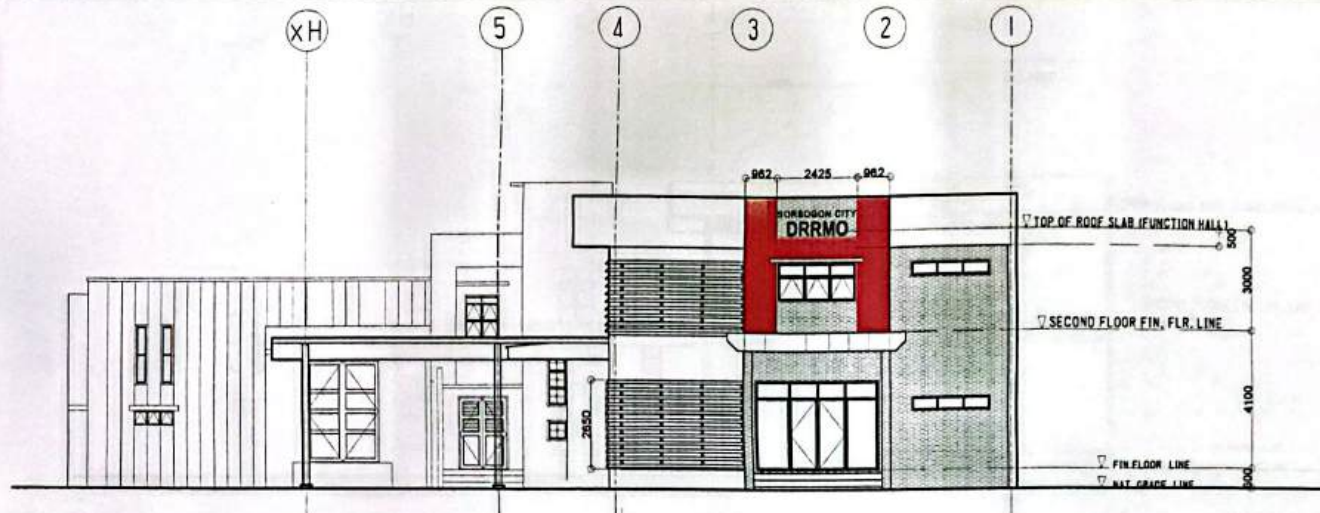

FRONT ELEVATION

SCALE: 1:150M.

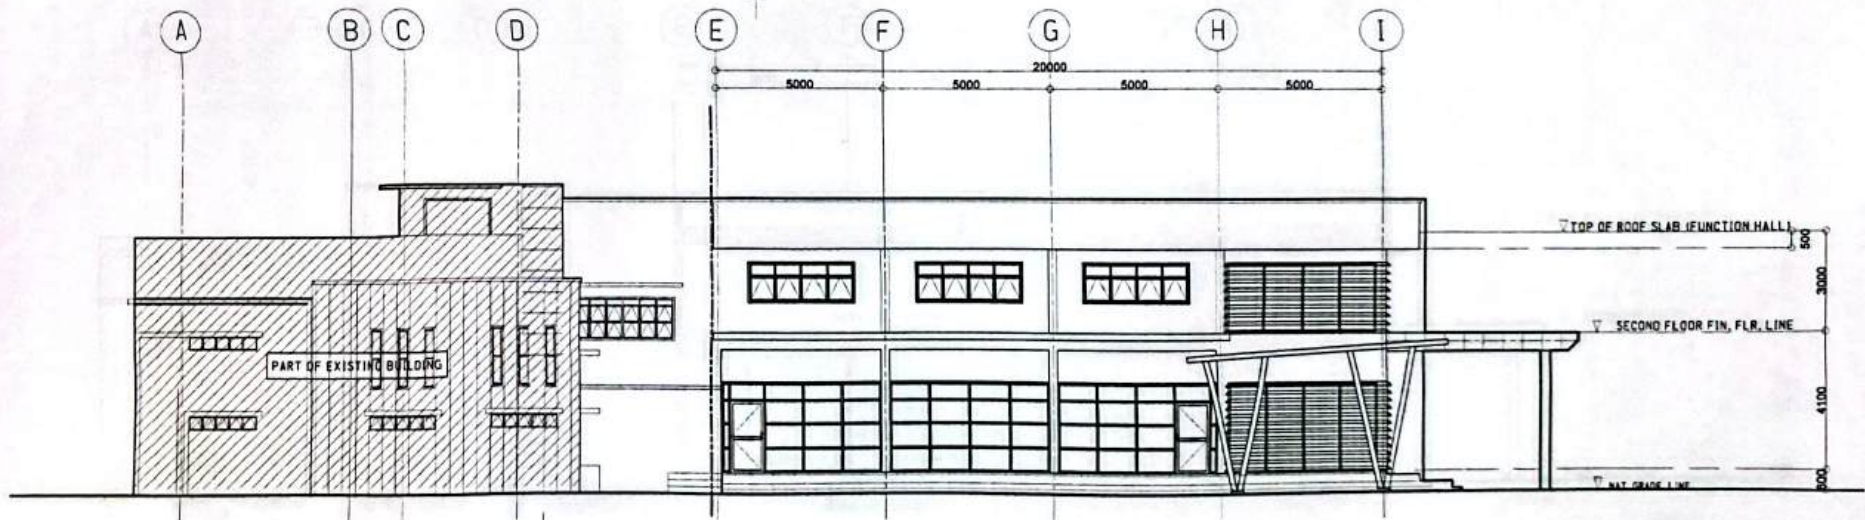

LEFT SIDE ELEVATION

SCALE: 1:150M.

PREPARED FROM:

PROJECT TITLE:

DRAWN:

RECOMMENDED BY:

APPROVED BY:

SHEET NO.



SORSOGON CITY
CITY ENGINEER'S OFFICE

RENOVATION OF DRRMO / EOC BUILDING


LOCATION: CITY HALL COMPOUND, BRGY. CABID-AN, EAST DIST. SORSOGON CITY.

DRAFTSMAN III


ROEL D. DAVILA
CITY ENGINEER

HON. MA. ESTER E. HAMOR
CITY MAYOR




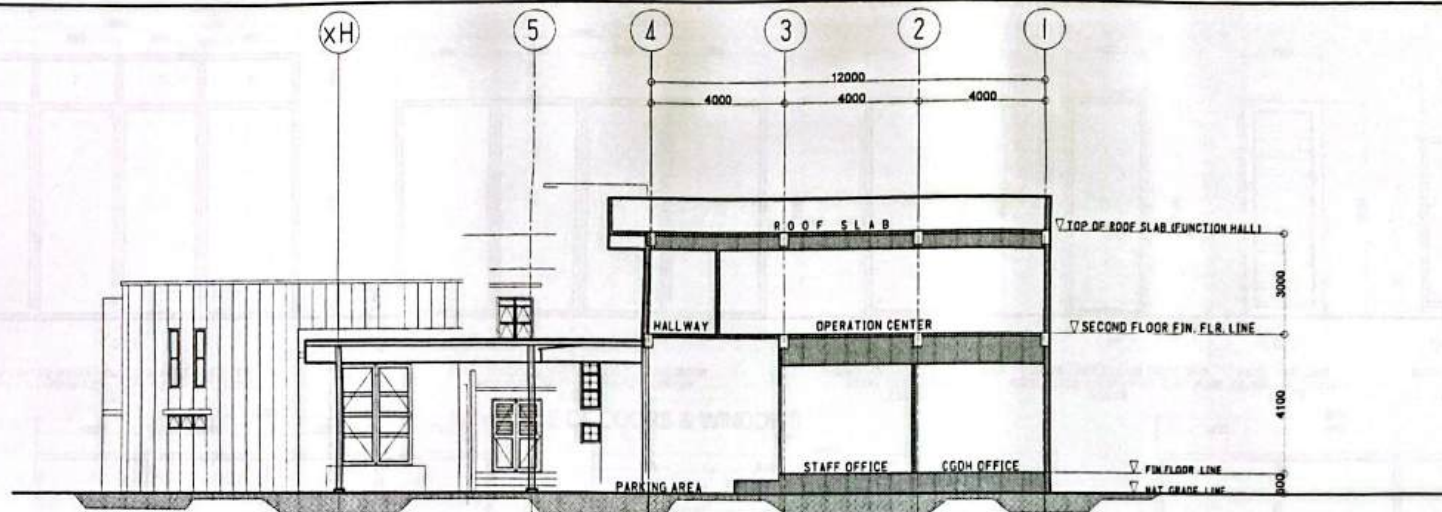


CROSS SECTION
SCALE: 1:150M.

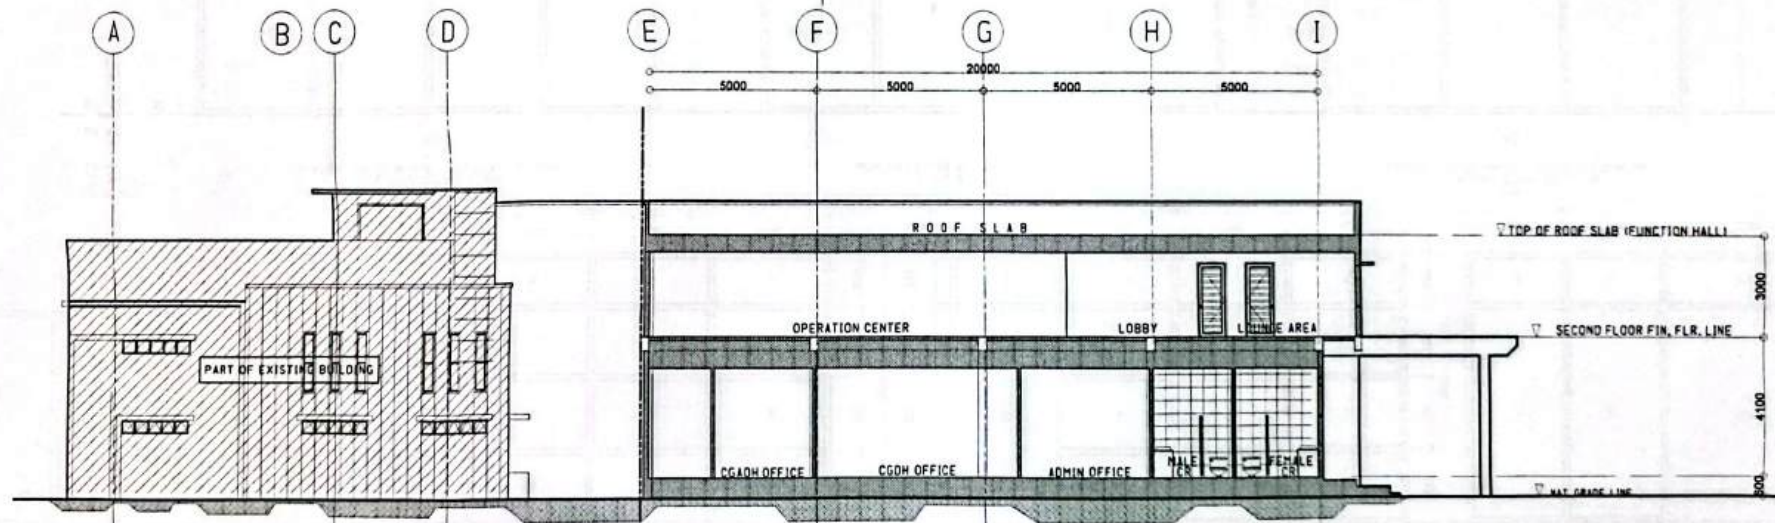



LONGITUDINAL SECTION
SCALE: 1:150M.

 PREPARED FROM:	PROJECT TITLE:	DRAWN:	RECOMMENDED BY:	APPROVED BY:	SHEET NO.
 SORSOGON CITY CITY ENGINEERS' OFFICE	RENOVATION OF DRRMO / EOC BUILDING LOCATION: CITY HALL COMPOUND, BRGY. CABID-AN, EAST DIST. SORSOGON CITY.	 DRAFTSMAN III	 ROEL D. ROMERO JR. RMP CITY ENGINEER	 HON. MA. ESTER E. HAMOR CITY MAYOR	

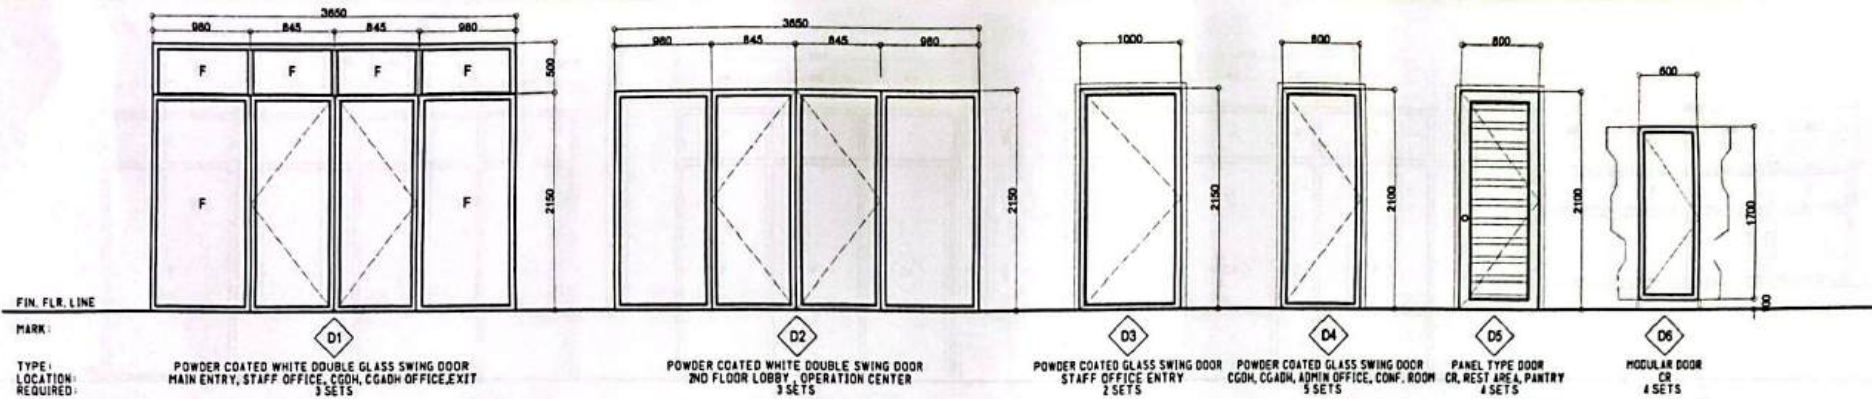


SCHEDULE OF DOORS & WINDOWS

SCALE: 1:50M.

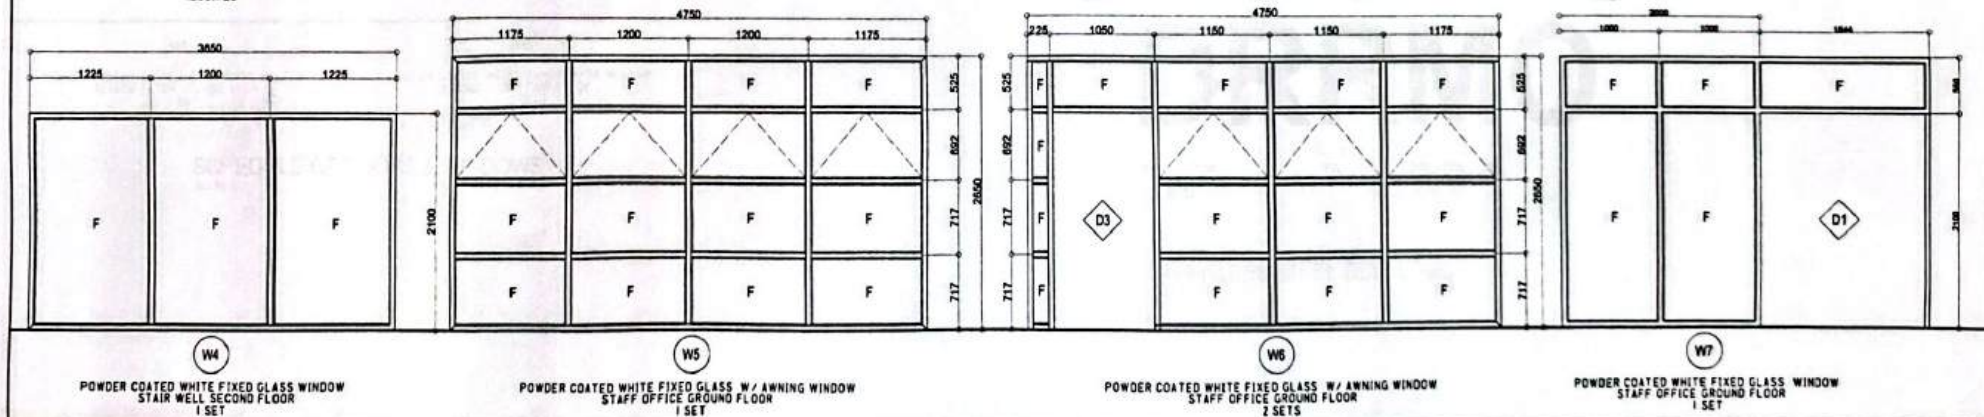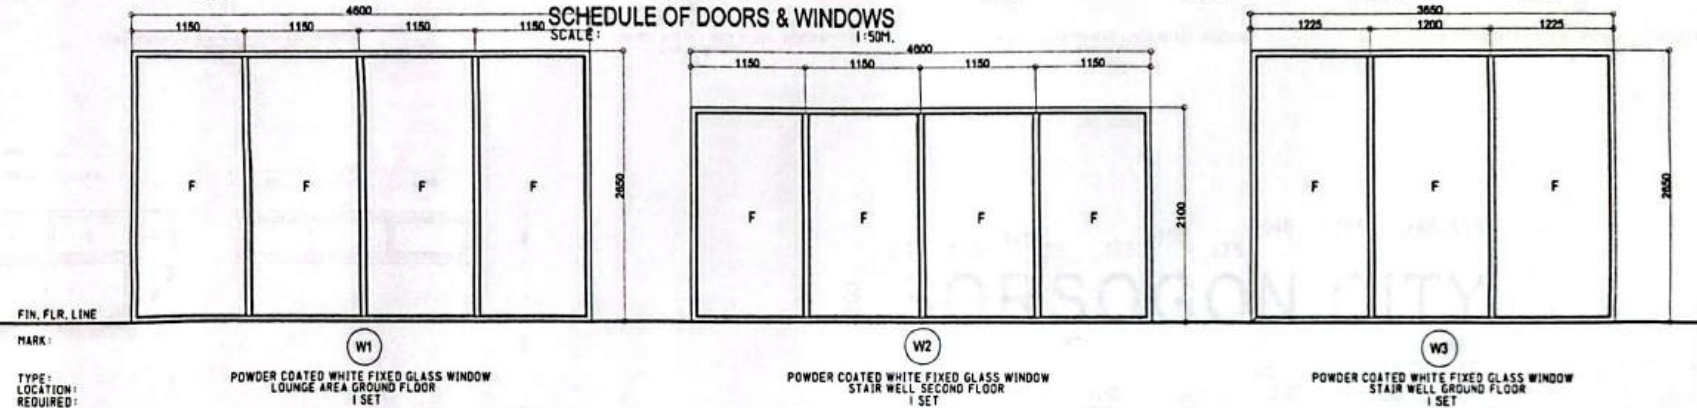

PREPARED FROM:	PROJECT TITLE:	DRAWN:	RECOMMENDED BY:	APPROVED BY:	SHEET NO.
	RENOVATION OF DRRMO / EOC BUILDING				
LOCATION: CITY HALL COMPOUND, BRGY. CABID-AN, EAST DIST. SORSOGON CITY.		DRAFTSMAN III		CITY ENGINEER	
				CITY MAYOR	

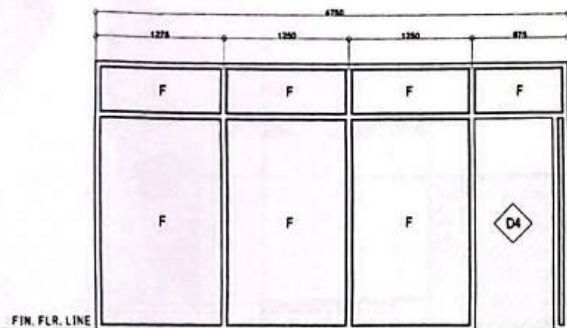


FIN. FLR. LINE

MARK:

TYPE:
LOCATION:
REQUIRED:


W8

POWDER COATED WHITE FIXED GLASS WINDOW
CGOH OFFICE
1 SET

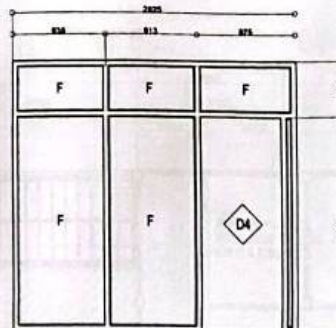

W9


POWDER COATED WHITE FIXED GLASS WINDOW
CGOH OFFICE
1 SET

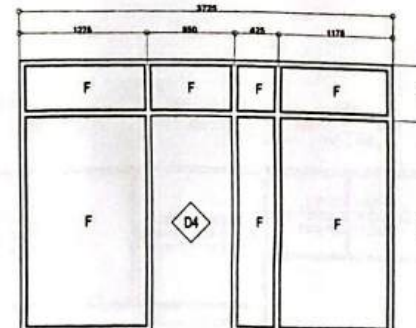

W10


POWDER COATED WHITE FIXED GLASS WINDOW
ADMIN. OFFICE
1 SET

W11

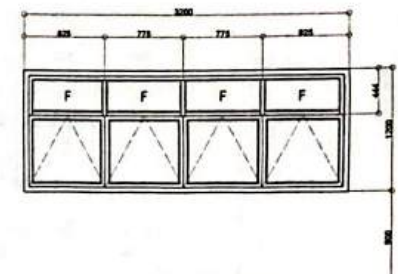


W12

POWDER COATED WHITE AWNING TYPE WINDOW
CONFERENCE ROOM, HALLWAY
3 SETS

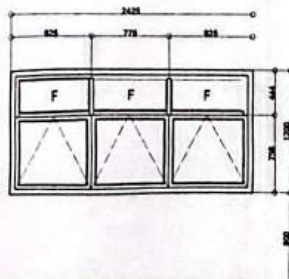

W13


POWDER COATED WHITE AWNING TYPE WINDOW
SECOND FLOOR LOUNGE AREA
1 SET

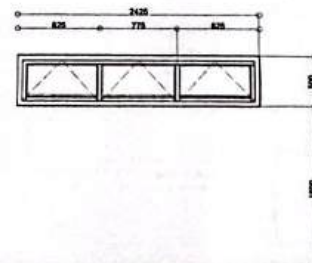

W14


POWDER COATED WHITE AWNING TYPE WINDOW
SECOND FLOOR PANTRY, CR
2 SETS


SCHEDULE OF DOORS & WINDOWS
SCALE: 1:50M.

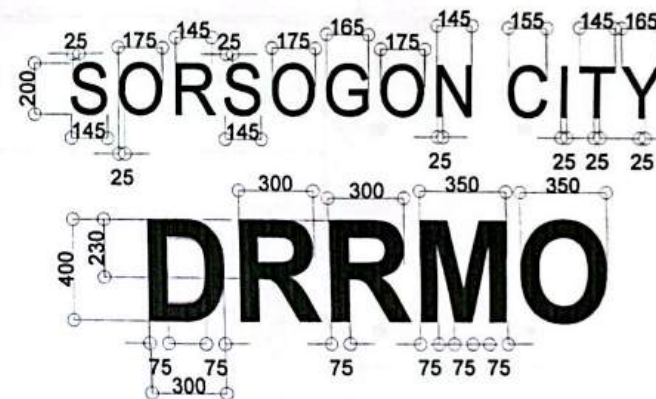


STAINLESS STEEL TEXT LOGO
SCALE: 1:20M.

PREPARED FROM:	PROJECT TITLE:	DRAWN:	RECOMMENDED BY:	APPROVED BY:	SHEET NO.
 SORSOGON CITY CITY ENGINEER'S OFFICE	RENOVATION OF DRRMO / EOC BUILDING LOCATION: CITY HALL COMPOUND, BRGY. CABID-AN, EAST DIST. SORSOGON CITY.	DRAFTSMAN III	ROEL D. DOMER, C.E., RMP CITY ENGINEER	HON. MA. ESTER E. HAMOR CITY MAYOR	

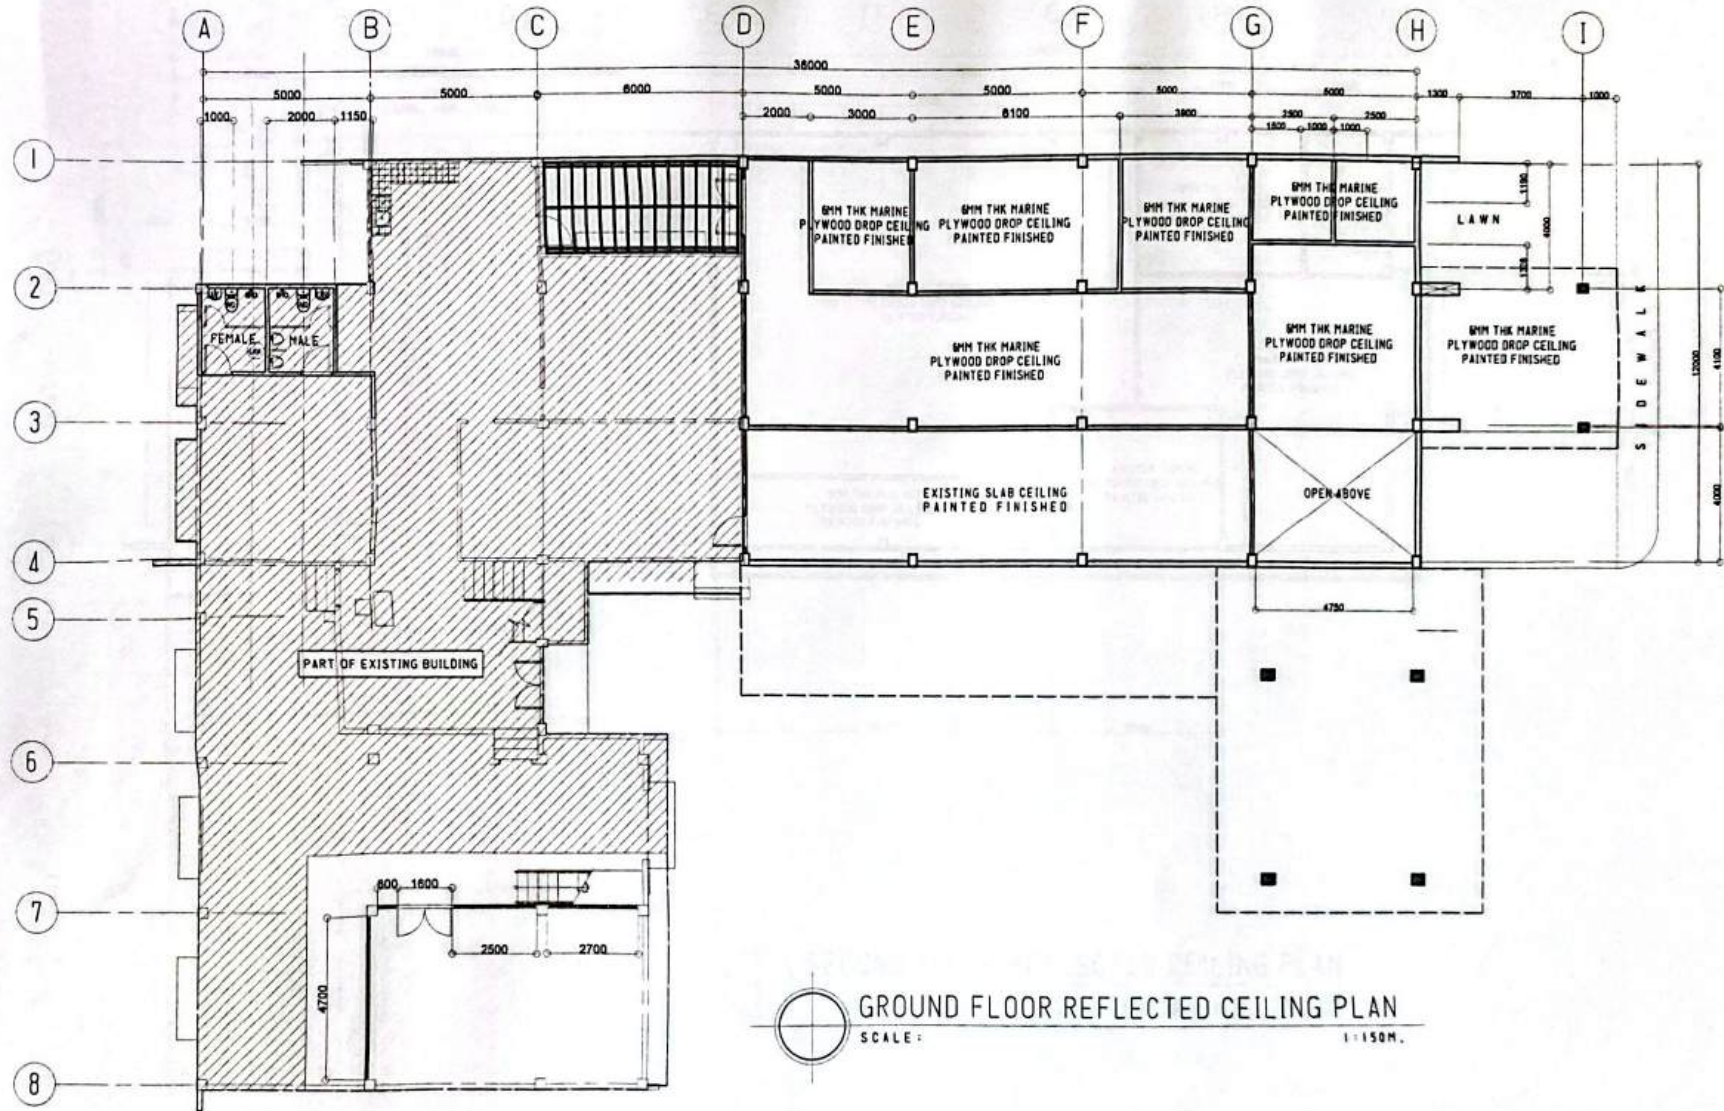


 
PREPARED FROM:	PROJECT TITLE:	DRAWN:	RECOMMENDED BY:	APPROVED BY:	SHEET NO.
 SORSOGON CITY CITY ENGINEER'S OFFICE	RENOVATION OF DRRMO / EOC BUILDING LOCATION: CITY HALL COMPOUND, BRGY. CABIO-AN, EAST DIST. SORSOGON CITY.	 DRAFTSMAN III	 ROEL DOMER C.E./RMP CITY ENGINEER	 HON. MA. ESTER E. HAMOR CITY MAYOR	

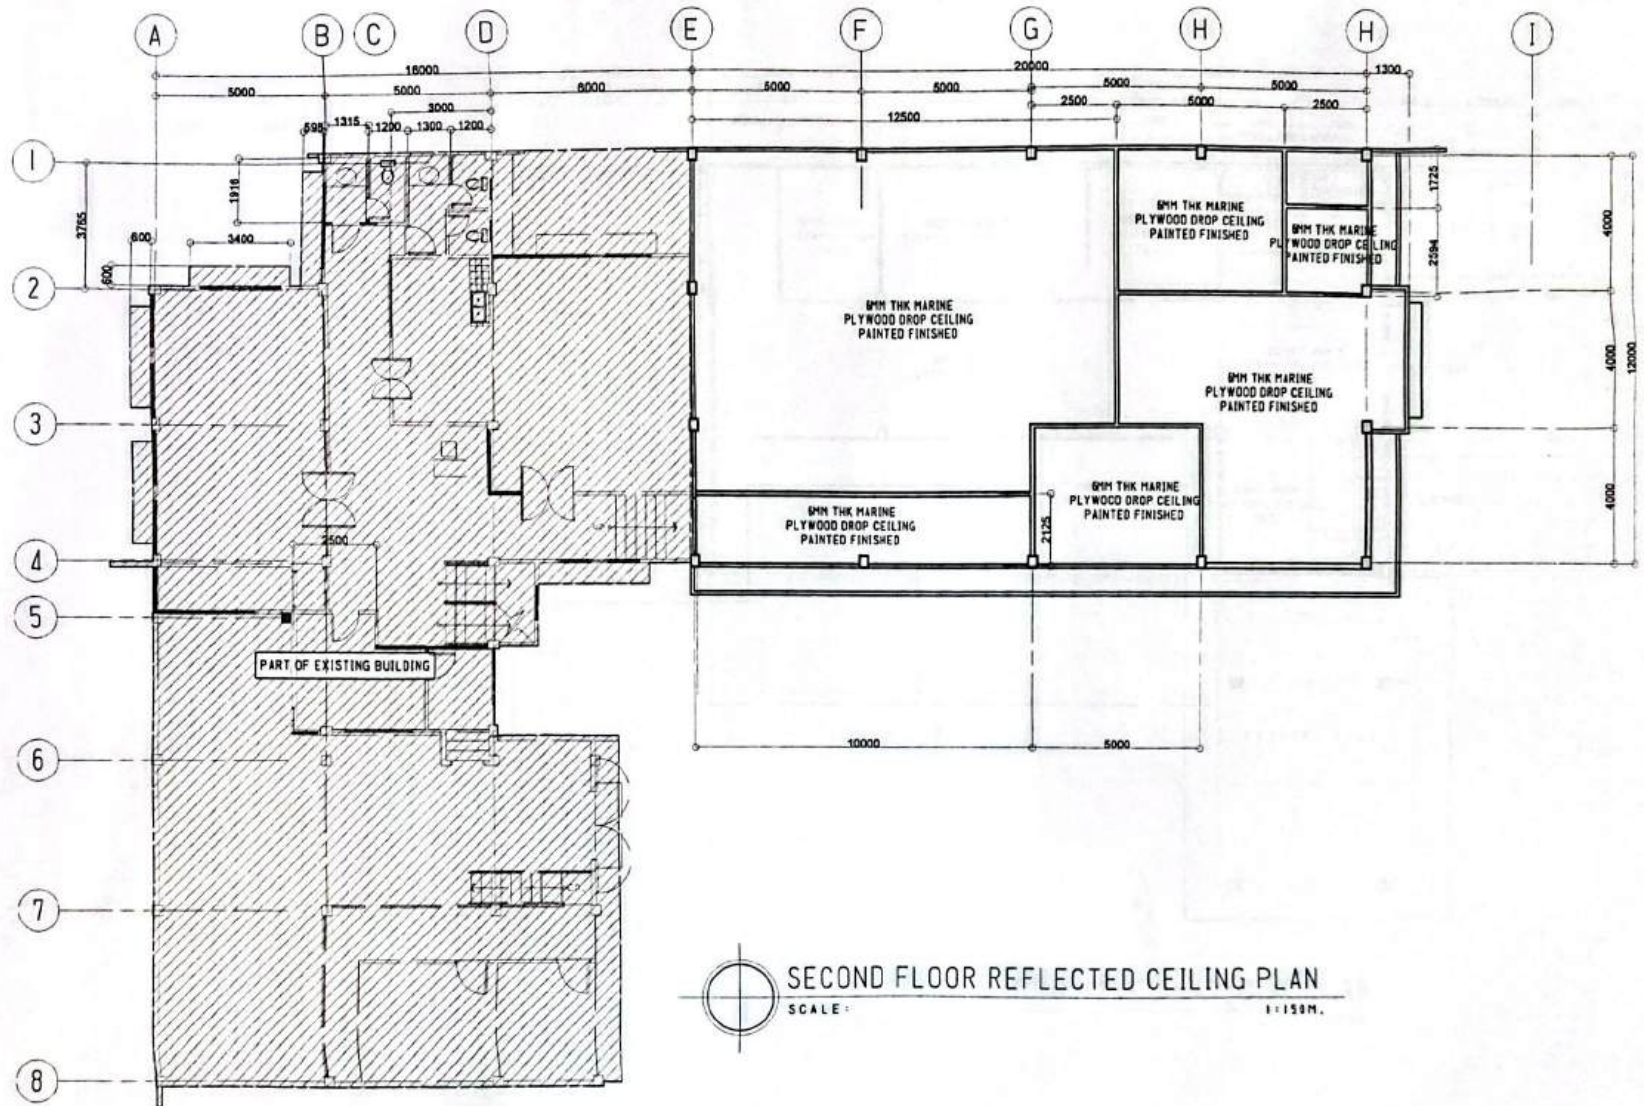

SECOND FLOOR REFLECTED CEILING PLAN

 SCALE: 1:150M.

PREPARED FROM:	PROJECT TITLE:	DRAWN:	RECOMMENDED BY:	APPROVED BY:	SHEET NO.
 SORSOGON CITY CITY ENGINEER'S OFFICE	RENOVAION OF DRRMO / EOC BUILDING LOCATION: CITY HALL COMPOUND, BRGY. CABID-AN, EAST DIST. SORSOGON CITY.	 DRAFTSMAN III	 ROEL D. BERNER, C.E., R.M.P. CITY ENGINEER	 HON. MA. ESTEN E. HAMOR CITY MAYOR	

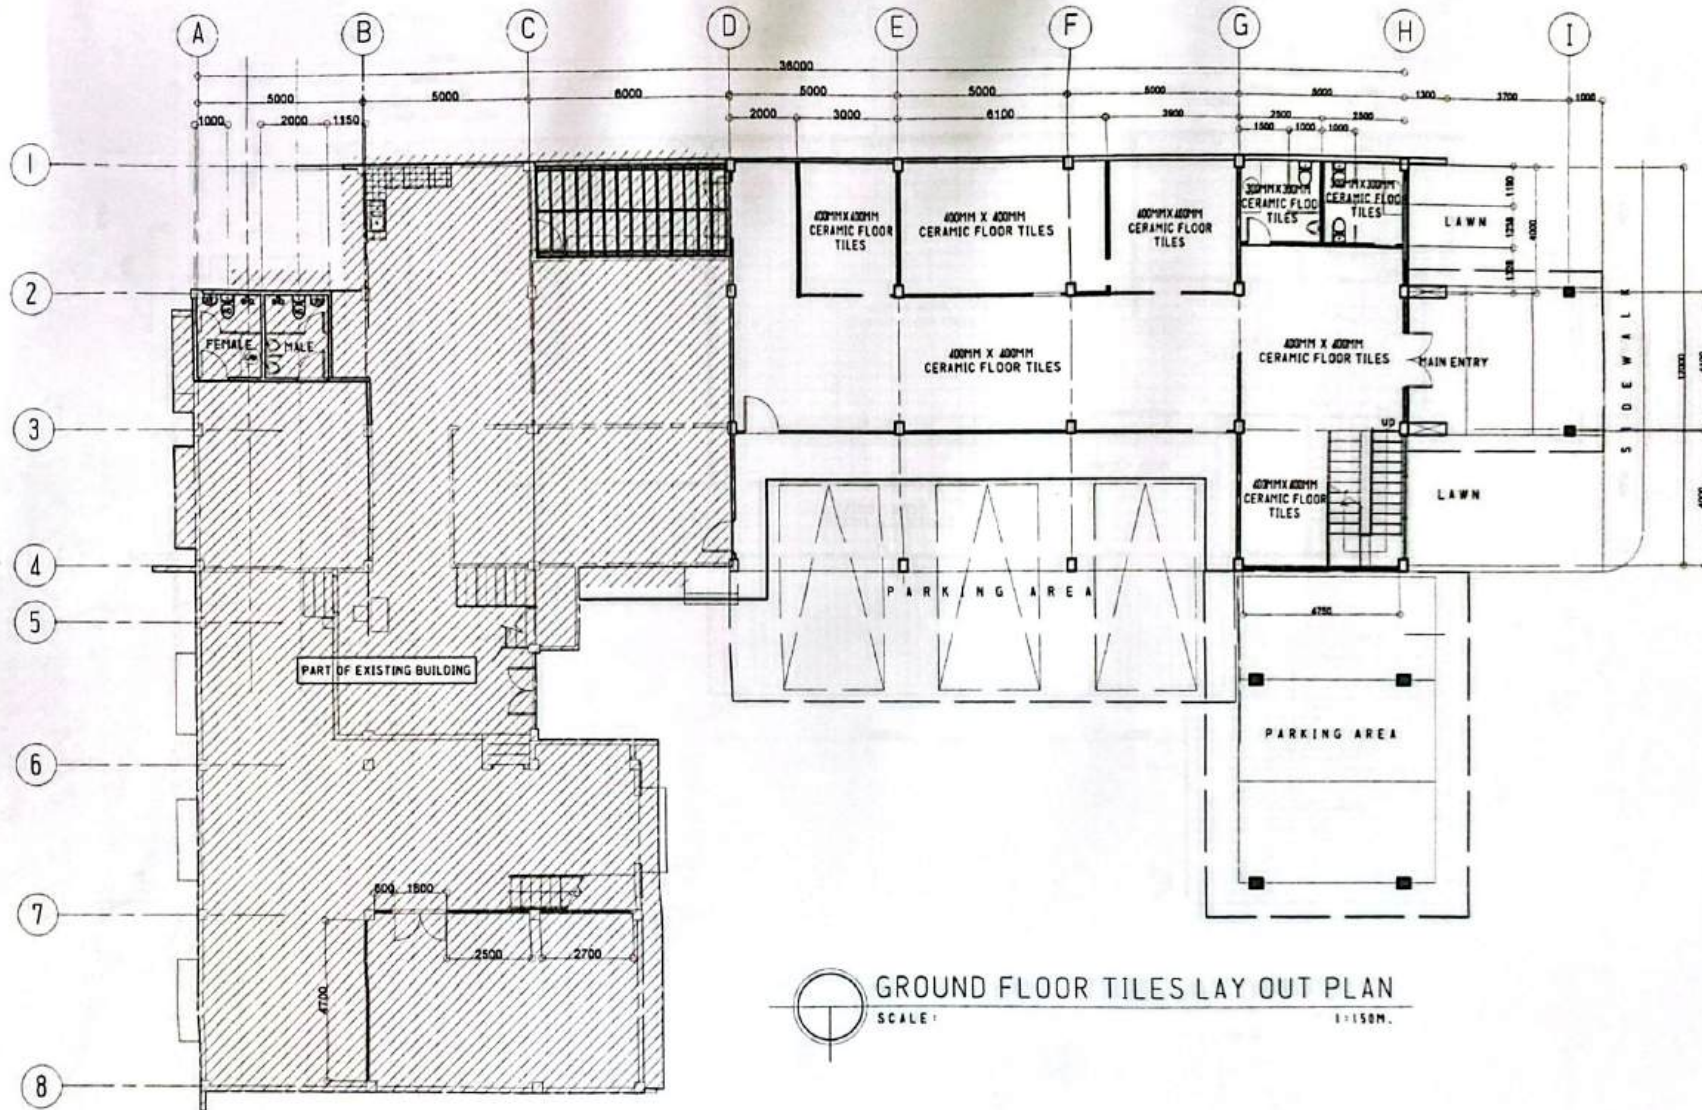

PREPARED FROM:

PROJECT TITLE:

DRAWN:

RECOMMENDED BY:

APPROVED BY:

SHEET NO.




RENOVATION OF DRRMO / EOC BUILDING


LOCATION: CITY HALL COMPOUND, BRGY. CABIO-AN, EAST DIST. SORSOGON CITY.

DRAFTSMAN III


ROEL D. SOMER C.E./RMP
CITY ENGINEER

 HON. MA. ESTER E. HAMOR
CITY MAYOR




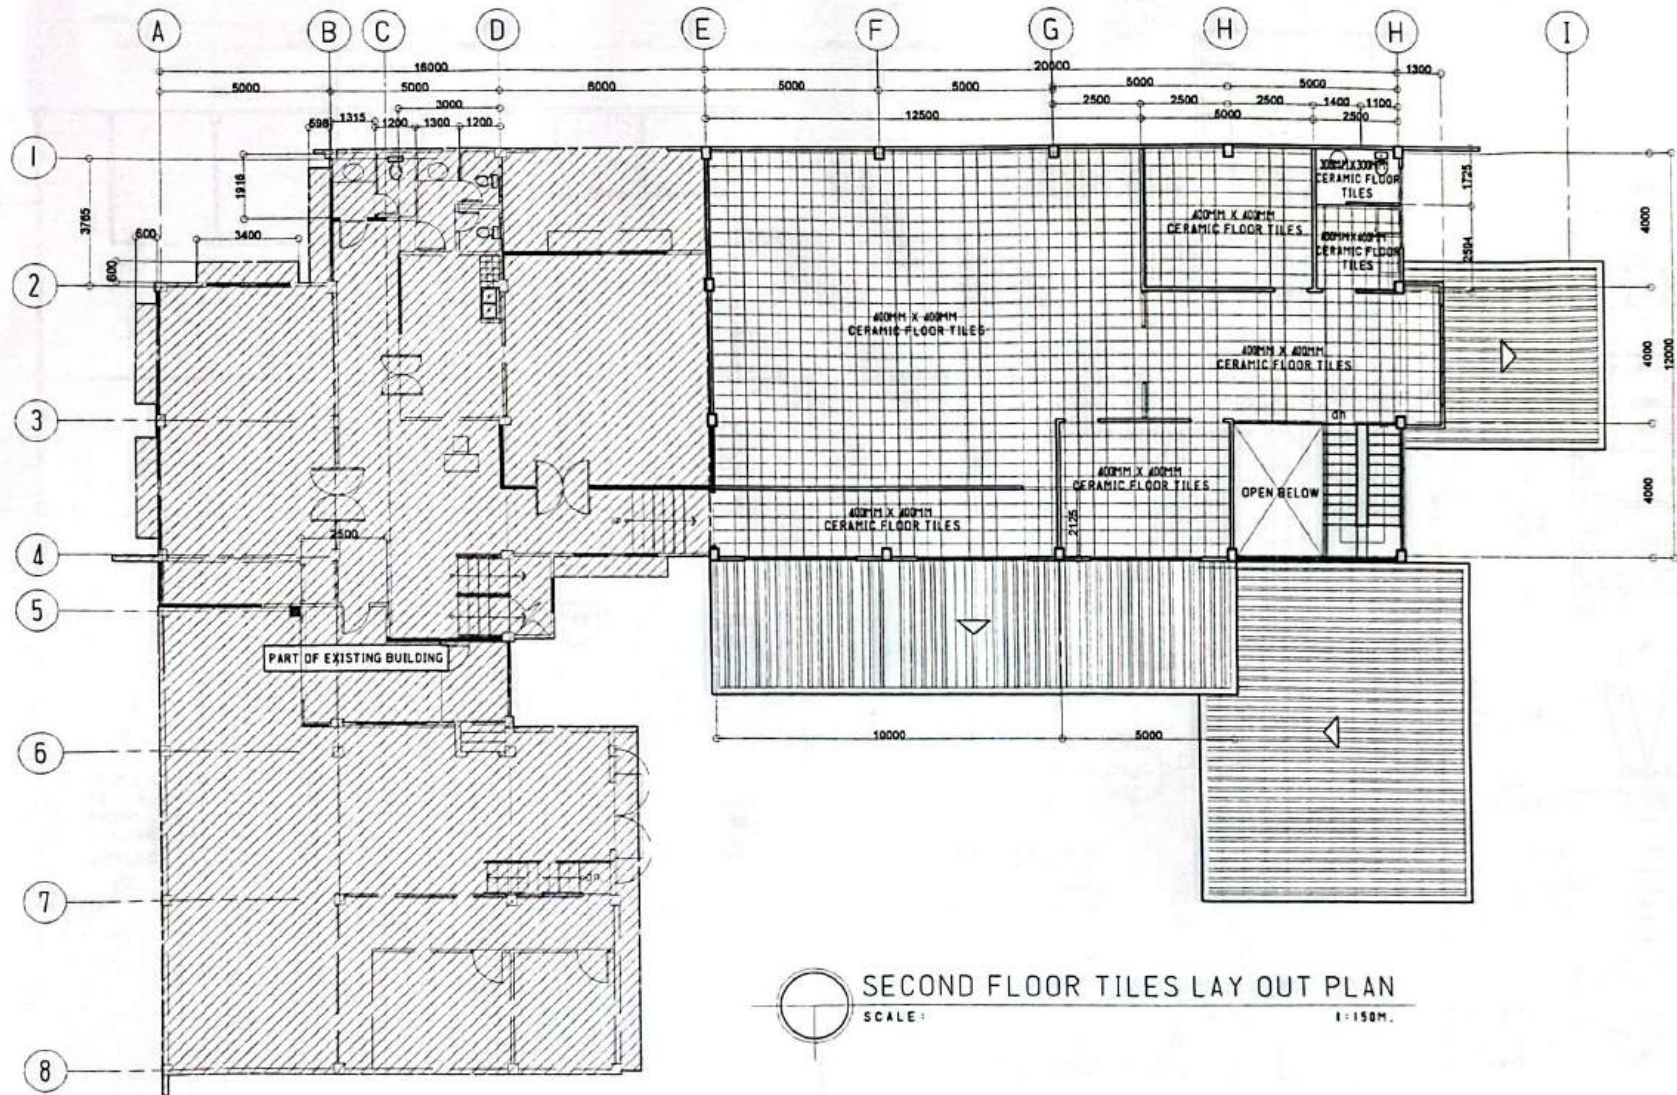

PREPARED FROM:	PROJECT TITLE:	DRAWN:	RECOMMENDED BY:	APPROVED BY:	SHEET NO.
 SORSOGON CITY CITY ENGINEER'S OFFICE	RENOVATION OF DRRMO / EOC BUILDING LOCATION: CITY HALL COMPOUND, BRGY. CABID-AN, EAST DIST. SORSOGON CITY.	DRAFTSMAN III	 ROEL D. SOLER C.E./RMP CITY ENGINEER	 HON. MA. ESTER E. HAMOR CITY MAYOR	

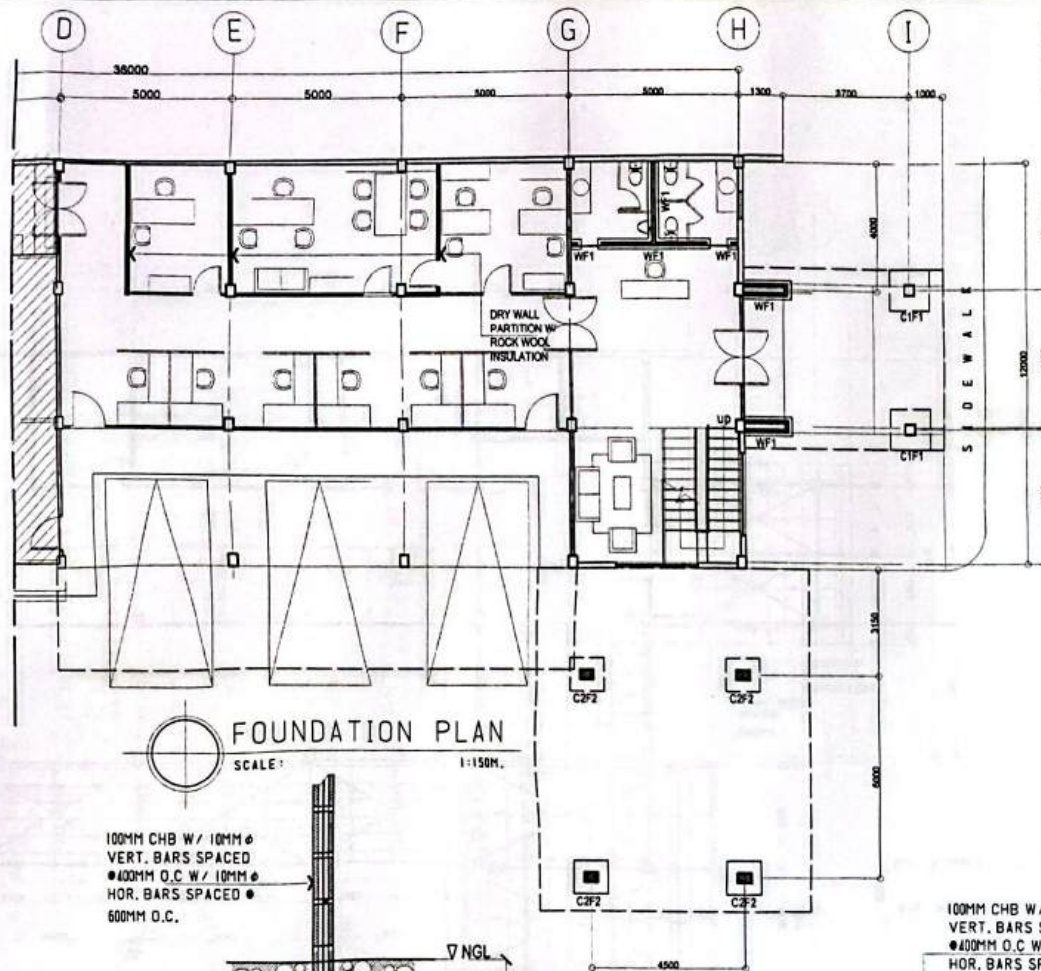


100MM CHB W/ 10MM ϕ VERT. BARS SPACED ϕ 400MM O.C W/ 10MM ϕ HOR. BARS SPACED ϕ 600MM O.C.

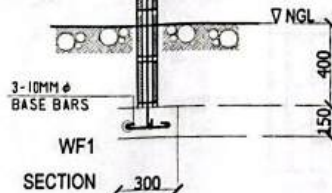

WALL / FOOTING DETAIL
SCALE: 1:25M.


8-16mm ϕ VERT. BARS W/ 10MM ϕ DOUBLE LAT. TIES SPACED ϕ 50, ϕ 100, ϕ 150 AND REST ϕ 200MM O.C.

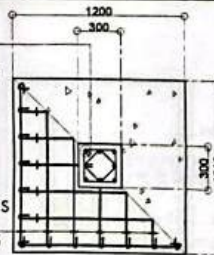

7-16mm ϕ BASE BARS SPACED EQ. ON CENTER BOTHWAYS




8-16mm ϕ VERT. BARS W/ 10MM ϕ DOUBLE LAT. TIES SPACED ϕ 50, ϕ 100, ϕ 150 AND REST ϕ 200MM O.C.

7-16mm ϕ BASE BARS SPACED EQ. ON CENTER BOTHWAYS

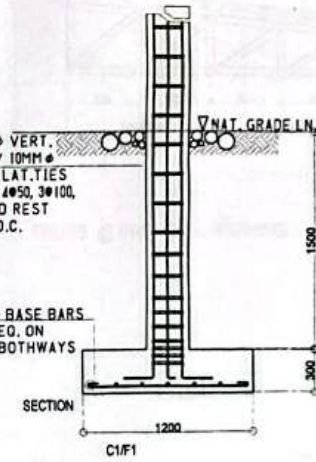


COLUMN / FOOTING DETAIL
SCALE: 1:35M.

100MM CHB W/ 12MM ϕ VERT. BARS SPACED ϕ 400MM O.C W/ 10MM ϕ HOR. BARS SPACED ϕ 600MM O.C.

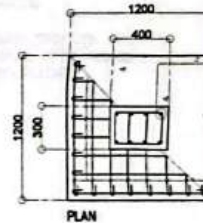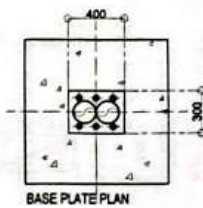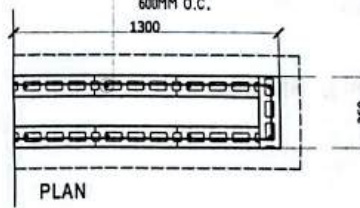

8-16mm ϕ VERT. BARS W/ 10MM DOUBLE LAT. TIES SPACED ϕ 50MM, ϕ 100MM, ϕ 150MM AND REST ϕ 200MM ON CENTER.

8-16mm ϕ BASE BARS SPACED EQ. ON CENTER BOTHWAYS

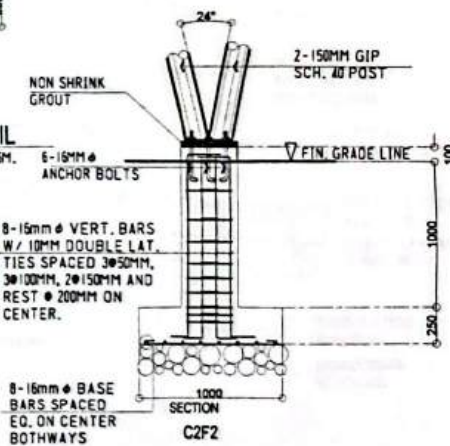

8-16mm ϕ VERT. BARS W/ 10MM DOUBLE LAT. TIES SPACED ϕ 50MM, ϕ 100MM, ϕ 150MM AND REST ϕ 200MM ON CENTER.

8-16mm ϕ BASE BARS SPACED EQ. ON CENTER BOTHWAYS

PREPARED FROM:

PROJECT TITLE:

DRAWN:

RECOMMENDED BY:

APPROVED BY:

SHEET NO.




RENOVATION OF DRRMO / EOC BUILDING


LOCATION: CITY HALL COMPOUND, BRGY. CABID-AN, EAST DIST. SORSOGON CITY.

DRAFTSMAN III





ROEL D. JONER, C.E., R.M.P.
CITY ENGINEER

  HON. MA. ESTER E. HAMOR
CITY MAYOR








PREPARED FROM:	PROJECT TITLE:	DRAWN:	RECOMMENDED BY:	APPROVED BY:	SHEET NO.
 DEPARTMENT OF PUBLIC WORKS AND HIGHWAYS OFFICE OF THE CITY ENGINEER	 RENOVATION OF DRRMO / EOC BUILDING	 DRAFTSMAN III	 ROEL D. DOMER, C.E./RMP CITY ENGINEER	 HON. MA. ESTER E. HAMOR CITY MAYOR	
LOCATION: CITY HALL COMPOUND BRGY. CARID-AN, EAST DIST. SORSOGON CITY					

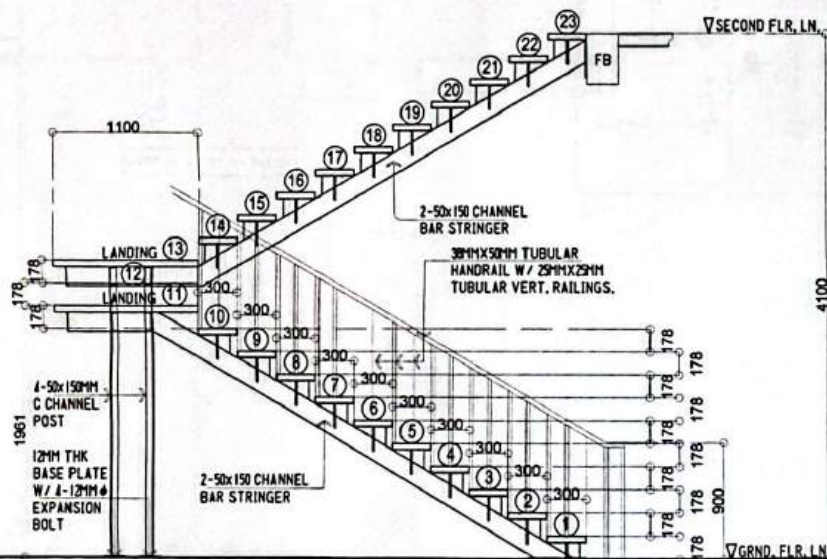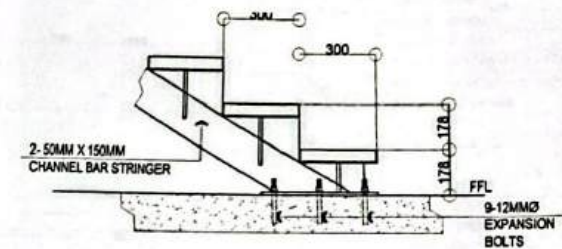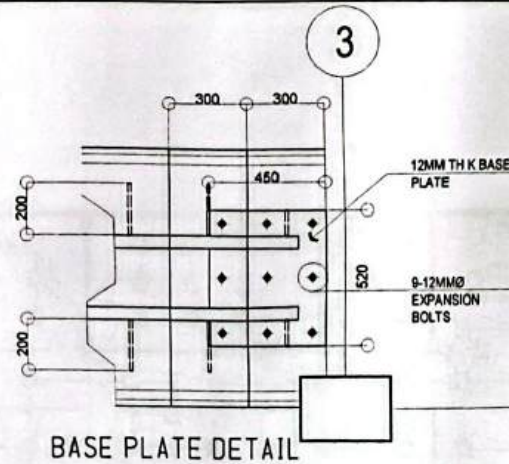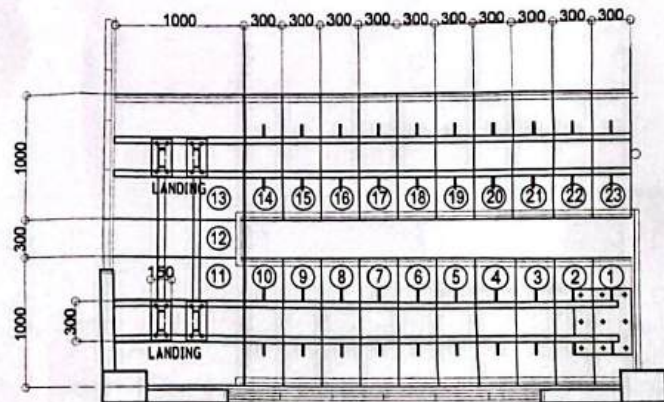


STAIR DETAIL
SCALE: 1:40M.

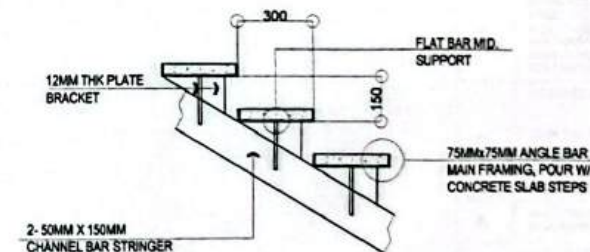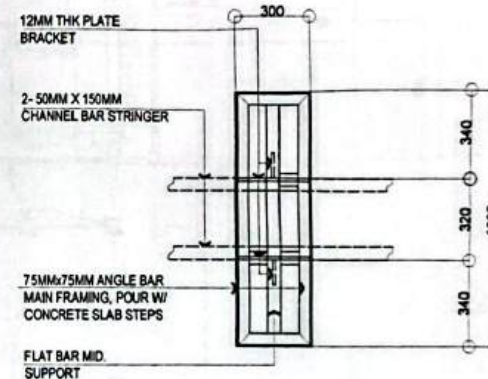


DETAIL OF STEPS
SCALE: 1:20M.

 PREPARED FROM:	PROJECT TITLE:	DRAWN:	RECOMMENDED BY:	APPROVED BY:	SHEET NO.
 SORSOGON CITY CITY ENGINEER'S OFFICE	RENOVATION OF DRRMO / EOC BUILDING LOCATION: CITY HALL COMPOUND, BRGY. CABID-AN, EAST DIST. SORSOGON CITY.	VITEZ DRAFTSMAN III	 ROEL O. DENTER CITY ENGINEER	 HON. MA. ESTER E. HAMOR CITY MAYOR	

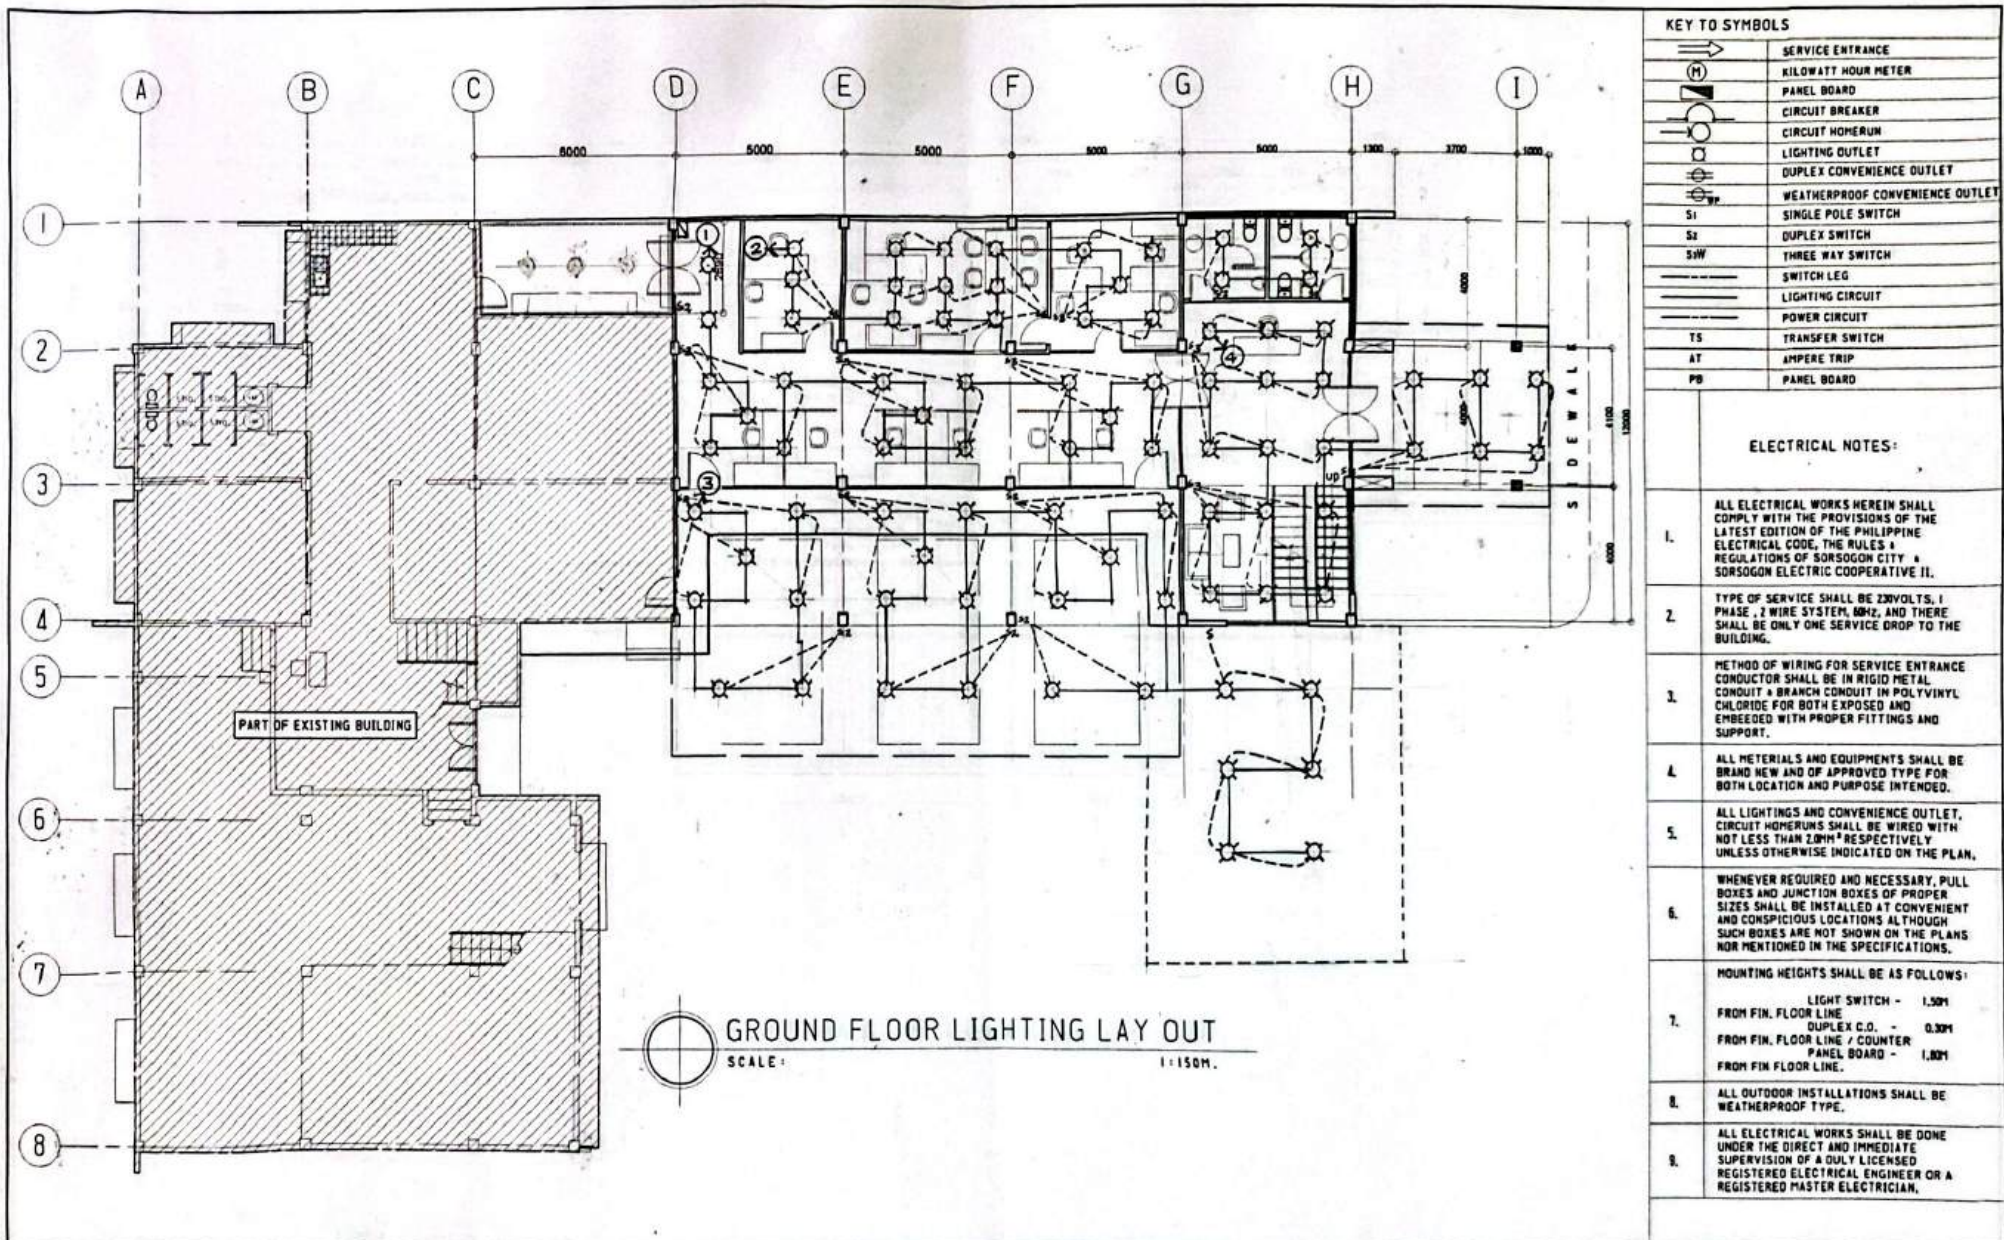

PREPARED FROM:	PROJECT TITLE:	DRAWN:	RECOMMENDED BY:	APPROVED BY:	SHEET NO.
	RENOVATION OF DRRMO / EOC BUILDING				
LOCATION: CITY HALL COMPOUND, BRGY. CABID-AN, EAST DIST. SORSOGON CITY.		ZONING OFFICER IV		CITY ENGINEER	CITY MAYOR

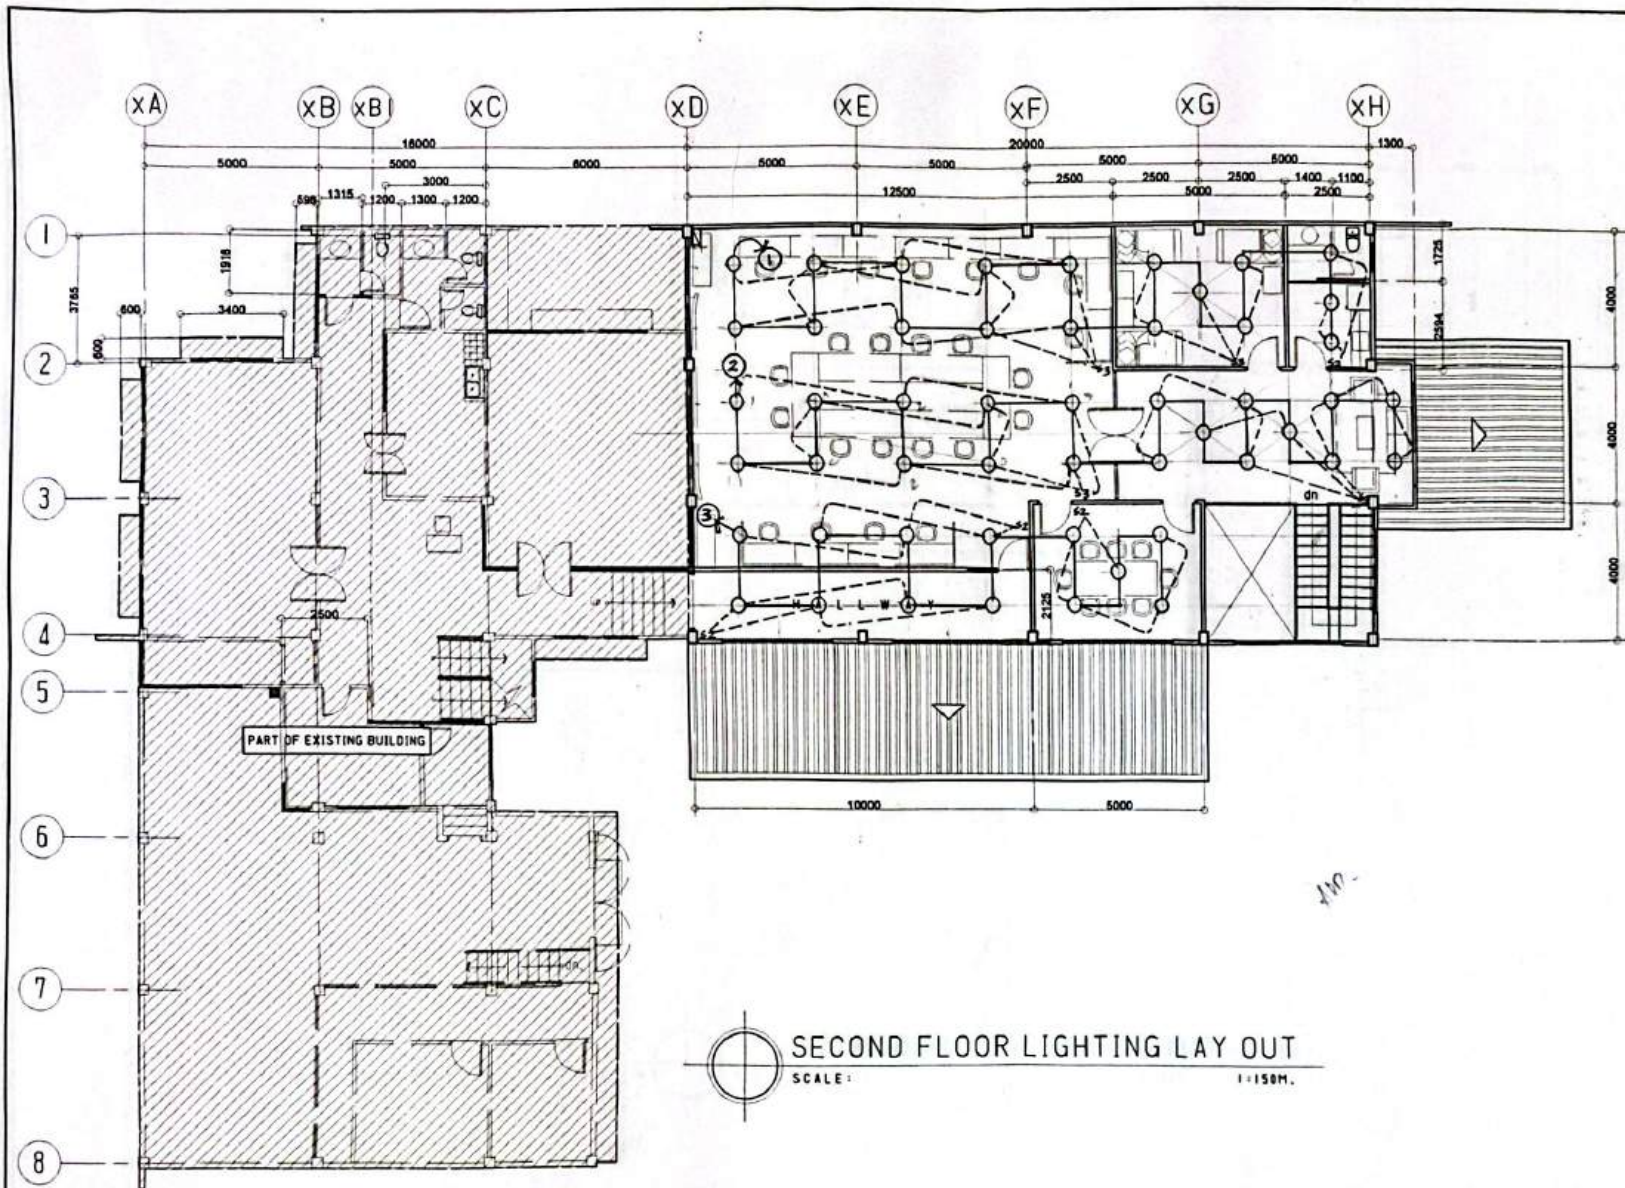


KEY TO SYMBOLS	
	SERVICE ENTRANCE
	KILOWATT HOUR METER
	PANEL BOARD
	CIRCUIT BREAKER
	CIRCUIT HOMERUN
	LIGHTING OUTLET
	DUPLEX CONVENIENCE OUTLET
	WEATHERPROOF CONVENIENCE OUTLET
	S1 SINGLE POLE SWITCH
	S2 DUPLEX SWITCH
	S3W THREE WAY SWITCH
	SWITCH LEG
	LIGHTING CIRCUIT
	POWER CIRCUIT
	TS TRANSFER SWITCH
	AT AMPERE TRIP
	PB PANEL BOARD

ELECTRICAL NOTES:


- ALL ELECTRICAL WORKS HEREIN SHALL COMPLY WITH THE PROVISIONS OF THE LATEST EDITION OF THE PHILIPPINE ELECTRICAL CODE, THE RULES & REGULATIONS OF SORSOGON CITY & SORSOGON ELECTRIC COOPERATIVE II.
- TYPE OF SERVICE SHALL BE 220VOLTS, 1 PHASE, 3 WIRE SYSTEM, 4W/2L AND THERE SHALL BE ONLY ONE SERVICE DROP TO THE BUILDING.
- METHOD OF WIRING FOR SERVICE ENTRANCE CONDUCTOR SHALL BE IN RIGID METAL CONDUIT & BRANCH CONDUIT IN POLYVINYL CHLORIDE FOR BOTH EXPOSED AND EMBEDED WITH PROPER FITTINGS AND SUPPORT.
- ALL MATERIALS AND EQUIPMENTS SHALL BE BRAND NEW AND OF APPROVED TYPE FOR BOTH LOCATION AND PURPOSE INTENDED.
- ALL LIGHTINGS AND CONVENIENCE OUTLET, CIRCUIT HOMERUNS SHALL BE WIRED WITH NOT LESS THAN 20MM² RESPECTIVELY UNLESS OTHERWISE INDICATED ON THE PLAN.
- WHENEVER REQUIRED AND NECESSARY, PULL BOXES AND JUNCTION BOXES OF PROPER SIZES SHALL BE INSTALLED AT CONVENIENT AND CONSPICUOUS LOCATIONS ALTHOUGH SUCH BOXES ARE NOT SHOWN ON THE PLANS NOR MENTIONED IN THE SPECIFICATIONS.
- MOUNTING HEIGHTS SHALL BE AS FOLLOWS:
 LIGHT SWITCH - 1.50M
 FROM FIN. FLOOR LINE
 DUPLEX C.O. - 0.30M
 FROM FIN. FLOOR LINE / COUNTER
 PANEL BOARD - 1.80M
 FROM FIN. FLOOR LINE.
- ALL OUTDOOR INSTALLATIONS SHALL BE WEATHERPROOF TYPE.
- ALL ELECTRICAL WORKS SHALL BE DONE UNDER THE DIRECT AND IMMEDIATE SUPERVISION OF A DULY LICENSED REGISTERED ELECTRICAL ENGINEER OR A REGISTERED MASTER ELECTRICIAN.

SECOND FLOOR LIGHTING LAY OUT
SCALE: 1:150M.

PREPARED FROM:	PROJECT TITLE:	DRAWN:	RECOMMENDED BY:	APPROVED BY:	SHEET NO.
 SORSOGON CITY CITY ENGINEER'S OFFICE	RENOVATION OF DRRMO / EOC BUILDING LOCATION: CITY HALL COMPOUND, BRGY. CABIO-AN, EAST DIST. SORSOGON CITY.	 ZONING OFFICER IV	 ROEL D. GOMEZ, JR. / RMP CITY ENGINEER	 HON. MA. ESTER E. HAMOR CITY MAYOR	

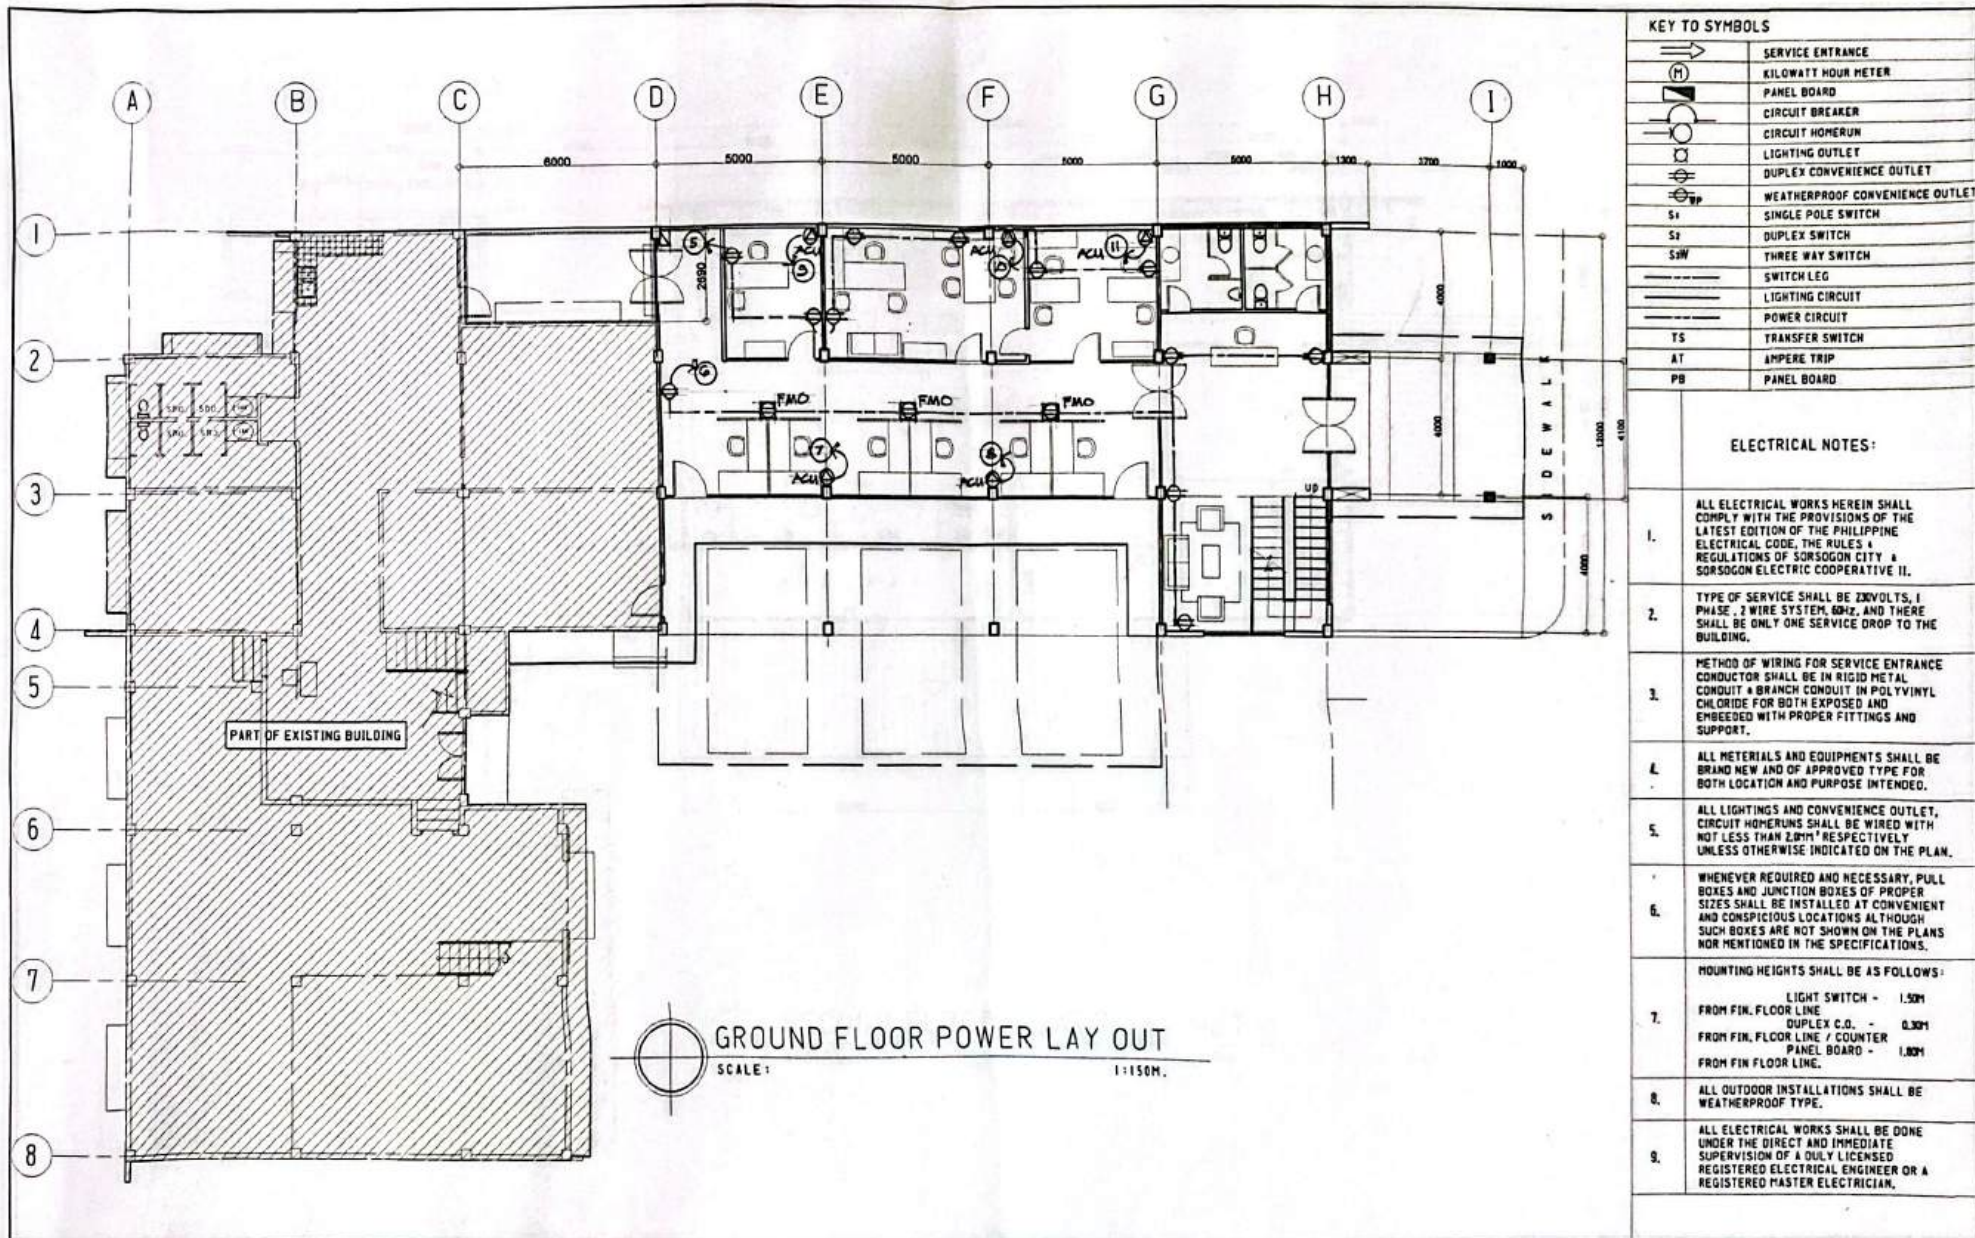


PREPARED FROM:	PROJECT TITLE:	DRAWN:	RECOMMENDED BY:	APPROVED BY:	SHEET NO.
 SORSOGON CITY CITY ENGINEER'S OFFICE	RENOVATION OF DRRMO / EOC BUILDING LOCATION: CITY HALL COMPOUND, BRGY. CABIO-AN, EAST DIST. SORSOGON CITY.	 ZONING OFFICER IV	 ROEL D. AMER C. RMP CITY ENGINEER	 HON. MA. ESTER E. HAMOR CITY MAYOR	

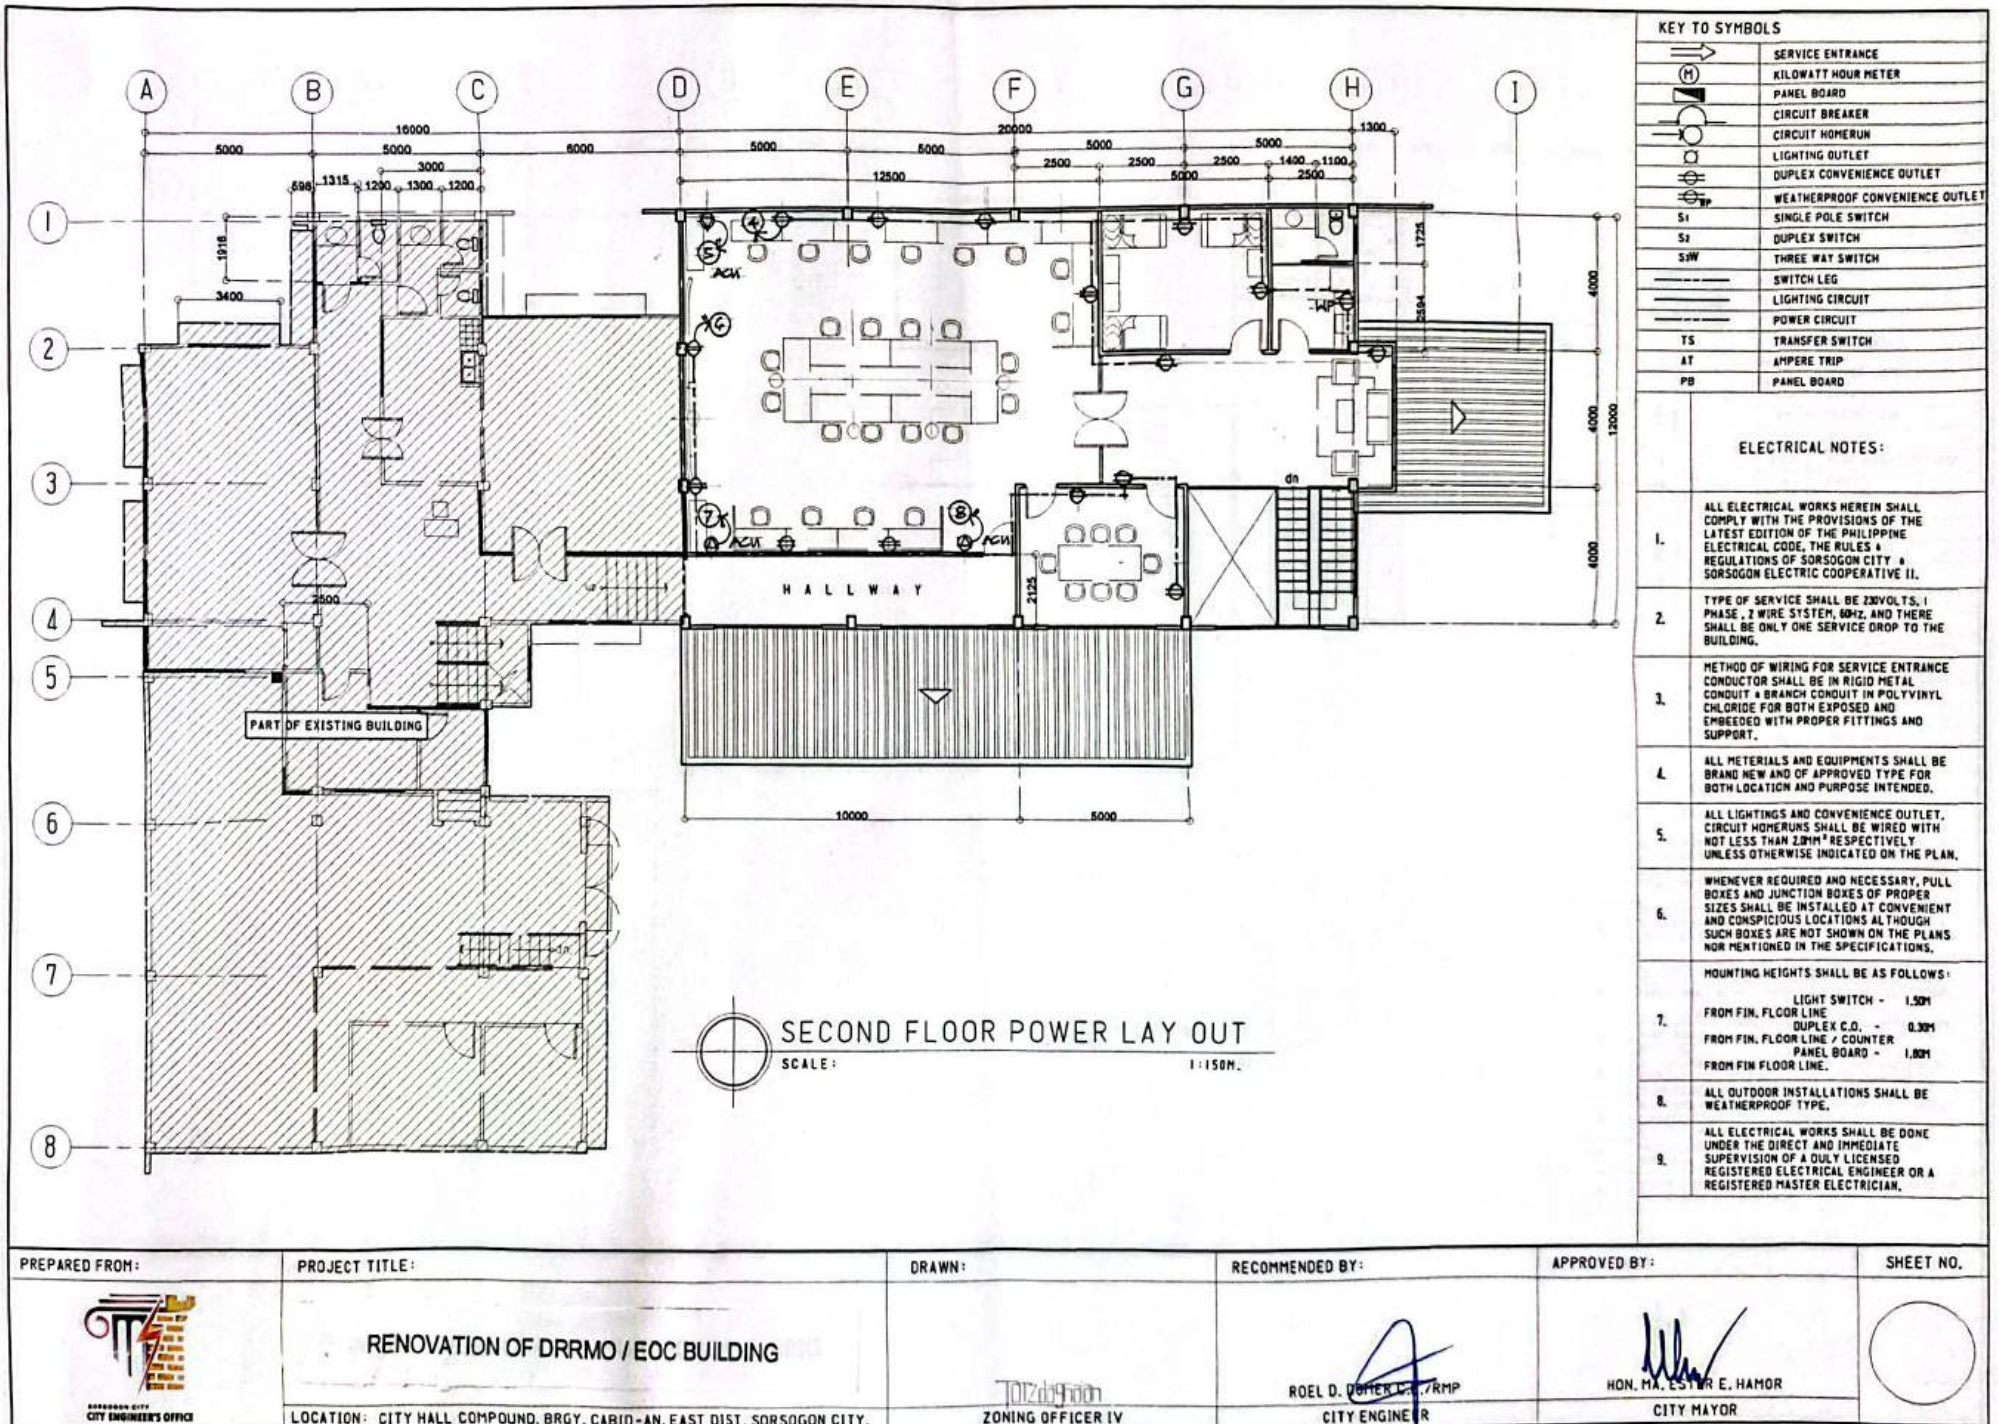

KEY TO SYMBOLS	
	SERVICE ENTRANCE
	KILOWATT HOUR METER
	PANEL BOARD
	CIRCUIT BREAKER
	CIRCUIT HOMERUN
	LIGHTING OUTLET
	DUPLEX CONVENIENCE OUTLET
	WEATHERPROOF CONVENIENCE OUTLET
	S1 SINGLE POLE SWITCH
	S2 DUPLEX SWITCH
	SW THREE WAY SWITCH
	SWITCH LEG
	LIGHTING CIRCUIT
	POWER CIRCUIT
	TS TRANSFER SWITCH
	AT AMPERE TRIP
	PB PANEL BOARD

ELECTRICAL NOTES:	
1.	ALL ELECTRICAL WORKS HEREIN SHALL COMPLY WITH THE PROVISIONS OF THE LATEST EDITION OF THE PHILIPPINE ELECTRICAL CODE, THE RULES & REGULATIONS OF SORSOGON CITY & SORSOGON ELECTRIC COOPERATIVE II.
2.	TYPE OF SERVICE SHALL BE 220VOLTS, 1 PHASE, 3 WIRE SYSTEM, 60HZ, AND THERE SHALL BE ONLY ONE SERVICE DROP TO THE BUILDING.
3.	METHOD OF WIRING FOR SERVICE ENTRANCE CONDUCTOR SHALL BE IN RIGID METAL CONDUIT & BRANCH CONDUIT IN POLYVINYL CHLORIDE FOR BOTH EXPOSED AND EMBEDDED WITH PROPER FITTINGS AND SUPPORT.
4.	ALL MATERIALS AND EQUIPMENTS SHALL BE BRAND NEW AND OF APPROVED TYPE FOR BOTH LOCATION AND PURPOSE INTENDED.
5.	ALL LIGHTINGS AND CONVENIENCE OUTLET, CIRCUIT HOMERUNS SHALL BE WIRED WITH NOT LESS THAN 2.0MM ² RESPECTIVELY UNLESS OTHERWISE INDICATED ON THE PLAN.
6.	WHENEVER REQUIRED AND NECESSARY, PULL BOXES AND JUNCTION BOXES OF PROPER SIZES SHALL BE INSTALLED AT CONVENIENT AND CONSPICUOUS LOCATIONS ALTHOUGH SUCH BOXES ARE NOT SHOWN ON THE PLANS NOR MENTIONED IN THE SPECIFICATIONS.
MOUNTING HEIGHTS SHALL BE AS FOLLOWS:	
7.	LIGHT SWITCH - 1.50M FROM FIN. FLOOR LINE DUPLEX C.O. - 0.30M FROM FIN. FLOOR LINE / COUNTER PANEL BOARD - 1.80M FROM FIN FLOOR LINE.
8.	ALL OUTDOOR INSTALLATIONS SHALL BE WEATHERPROOF TYPE.
9.	ALL ELECTRICAL WORKS SHALL BE DONE UNDER THE DIRECT AND IMMEDIATE SUPERVISION OF A DULY LICENSED REGISTERED ELECTRICAL ENGINEER OR A REGISTERED MASTER ELECTRICIAN.

PREPARED FROM:	PROJECT TITLE:	DRAWN:	RECOMMENDED BY:	APPROVED BY:	SHEET NO.
 SORSOGON CITY CITY ENGINEER'S OFFICE	RENOVATION OF DRRMO / EOC BUILDING LOCATION: CITY HALL COMPOUND, BRGY. CABID-AN, EAST DIST. SORSOGON CITY.	 ZONING OFFICER IV	 ROEL D. DOMER, L.A., RMP CITY ENGINEER	 HON. MA. ESTHER E. HAMOR CITY MAYOR	

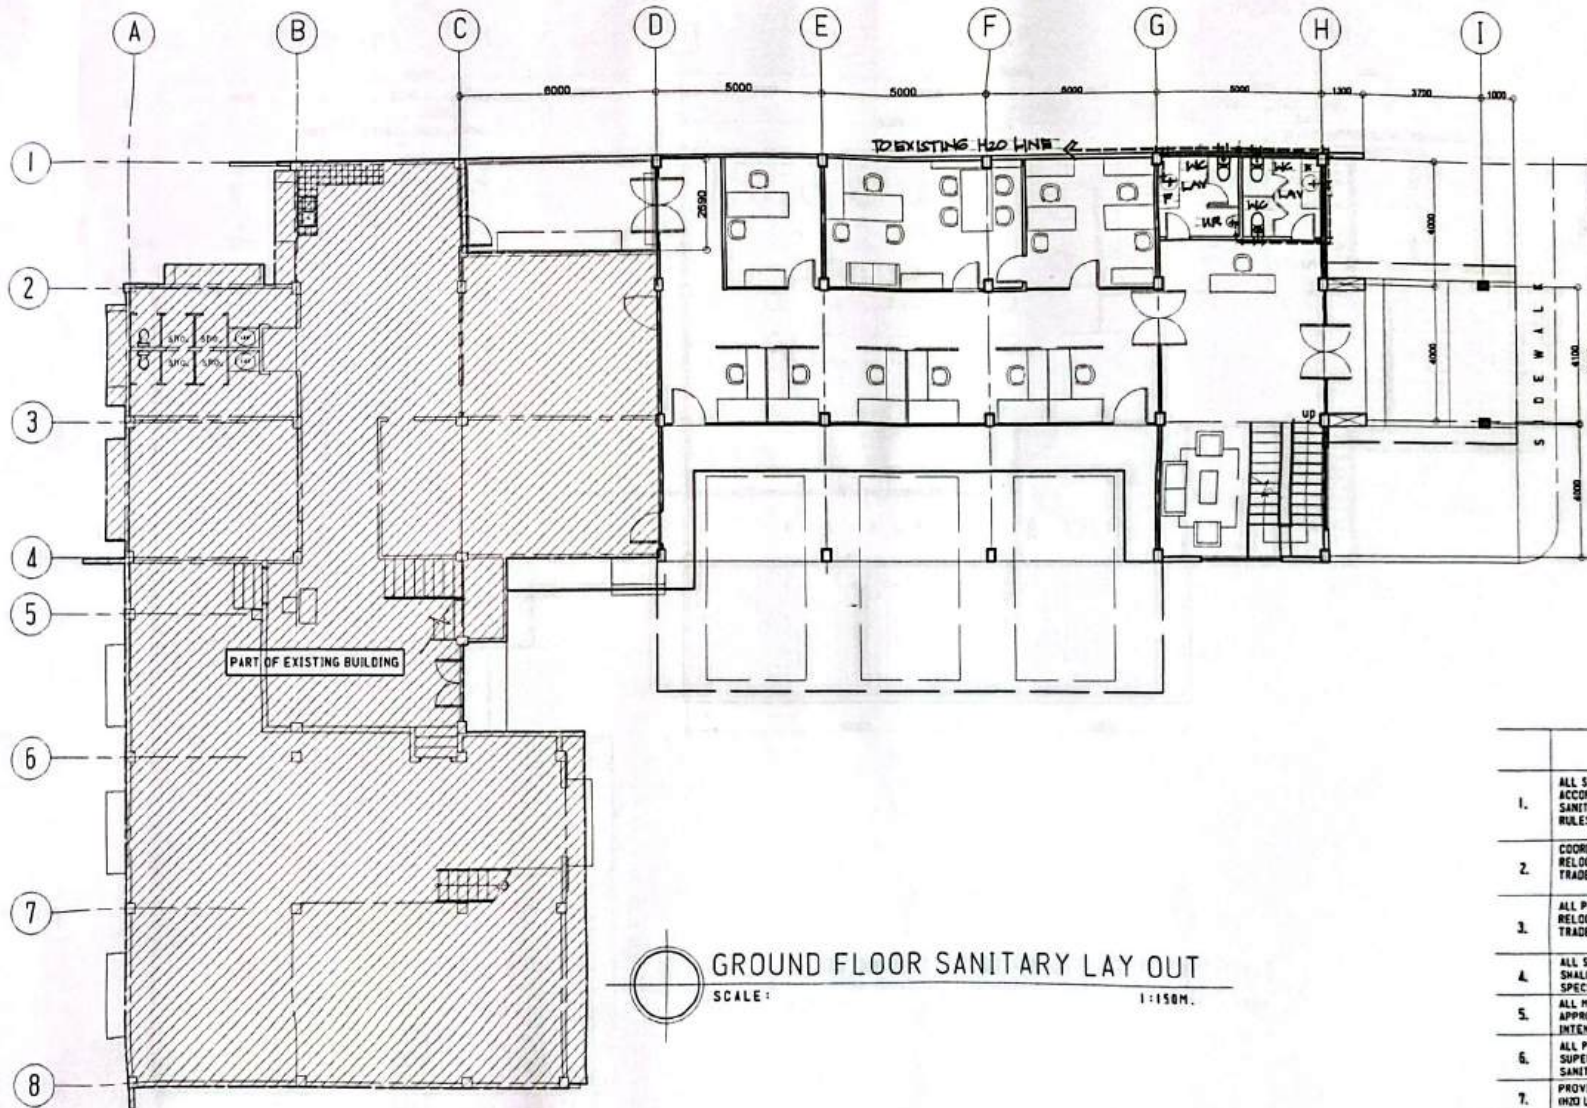

KEY TO SYMBOLS

WC	WATER CLOSET
LAV	LAVATORY
FD	FLOOR DRAIN
CO	CLEAN OUT
VSTR	VENT STACK THRU ROOF
F	FAUCET
MH	MAN HOLE
DS	DOWN SPOUT
GV	GATE VALVE
CV	CHECK VALVE
CWL	COLD WATER LINE
WPL	WASTE PIPE LINE
GIP	GALVANIZED IRON PIPE
PVC	POLYVINYL CHLORIDE
KS	KITCHEN SINK
CB	CATCH BASIN
RD	ROOF DRAIN
ST	SEPTIC TANK
WM	WATER METER

PLUMBING / SANITARY NOTES

- ALL SANITARY WORKS INCLUDED HEREIN SHALL BE EXECUTED ACCORDING TO THE PROVISION OF THE PHILIPPINE NATIONAL SANITATION CODE, THE NATIONAL BUILDING CODE AND THE RULES AND REGULATION OF SORSOGON CITY.
- COORDINATE THE DRAWINGS WITH OTHER INDICATED. ANY RELOCATION REQUIRED FOR PROPER EXECUTION OF OTHER TRADES SHALL BE WITH PRIOR APPROVAL OF THE DESIGNER.
- ALL PIPES SHALL BE INSTALLED AS INDICATED. ANY RELOCATED REQUIRED FOR PROPER EXECUTION OF OTHER TRADES SHALL BE WITH PRIOR APPROVAL OF THE DESIGNER.
- ALL SLOPES FOR HORIZONTAL DRAINAGE AND SEWER LINES SHALL MAINTAIN 1% MINIMUM SLOPE UNLESS OTHER WISE SPECIFIED.
- ALL MATERIALS TO BE USED SHALL BE BRAND NEW AND OF APPROVED TYPE APPROPRIATE FOR BOTH LOCATION AND INTENDED USE.
- ALL PLUMBING INSTALLATION SHALL BE UNDER THE DIRECT SUPERVISION OF A DULY LICENSED MASTER PLUMBER / SANITARY ENGINEER.
- PROVIDE ISOLATION VALVE FOR EVERY TOILET ROOM (H2O LINE).
- SEPTIC TANK CONSTRUCTION MUST FOLLOW SECTION 230 OF THE NATIONAL BUILDING CODE.

PREPARED FROM:



PROJECT TITLE:

RENOVATION OF DRRMO / EOC BUILDING

LOCATION: CITY HALL COMPOUND, BRGY. CABID-AN, EAST DIST. SORSOGON CITY.

CADD BY:

JOYCE G. GONZALES
ZONING OFFICER IV

RECOMMENDED BY:


ROEL D. DOMEREE, RMP
CITY ENGINEER

APPROVED BY:

HON. MA. ESTER E. HAMOR
CITY MAYOR

SHEET NO.



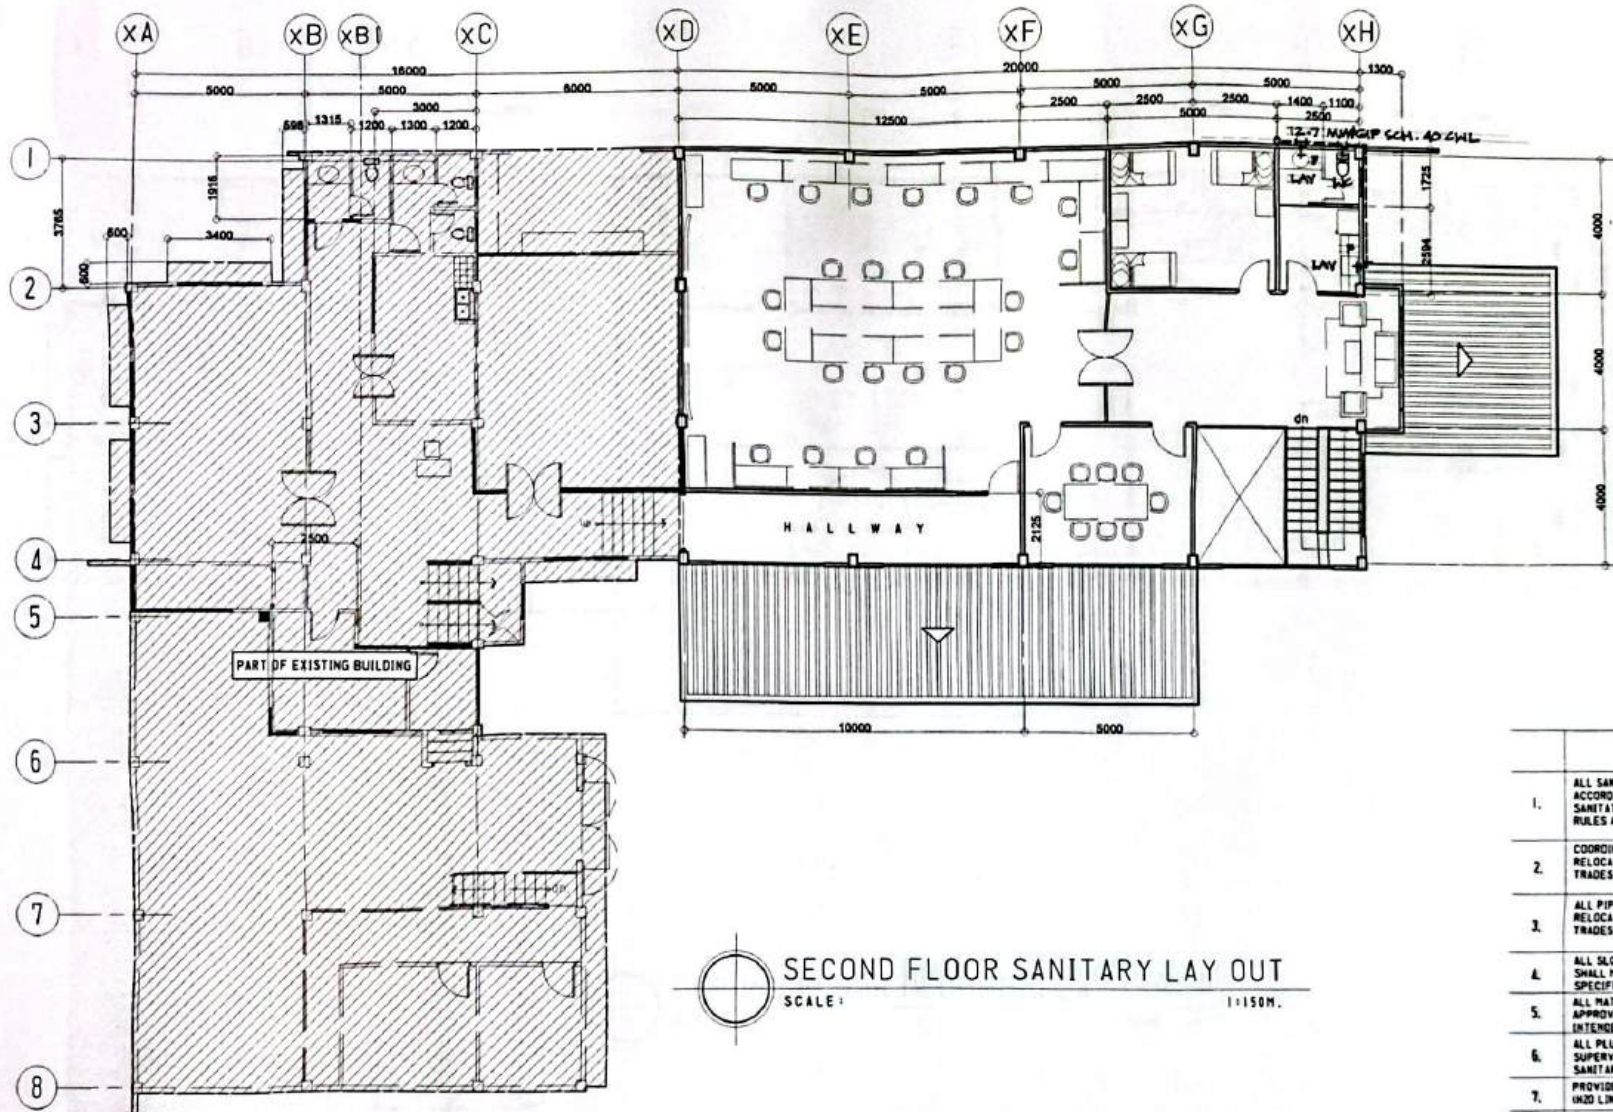


KEY TO SYMBOLS	
WC	WATER CLOSET
LAV	LAVATORY
FD	FLOOR DRAIN
CD	CLEAN OUT
VSTR	VENT STACK THRU ROOF
F	FAUCET
MH	MAN HOLE
DS	DOWN SPOUT
GV	GATE VALVE
CV	CHECK VALVE
CWL	COLD WATER LINE
WPL	WASTE PIPE LINE
GIP	GALVANIZED IRON PIPE
PVC	POLYVINYL CHLORIDE
KS	KITCHEN SINK
CB	CATCH BASIN
RD	ROOF DRAIN
ST	SEPTIC TANK
WM	WATER METER


PLUMBING / SANITARY NOTES

- ALL SANITARY WORKS INCLUDED HEREIN SHALL BE EXECUTED ACCORDING TO THE PROVISIONS OF THE PHILIPPINE NATIONAL SANITATION CODE, THE NATIONAL BUILDING CODE AND THE RULES AND REGULATION OF SORSOGON CITY.
- COORDINATE THE DRAWINGS WITH OTHER INDICATED, ANY RELOCATION REQUIRED FOR PROPER EXECUTION OF OTHER TRADES SHALL BE WITH PRIOR APPROVAL OF THE DESIGNER.
- ALL PIPES SHALL BE INSTALLED AS INDICATED, ANY RELOCATION REQUIRED FOR PROPER EXECUTION OF OTHER TRADES SHALL BE WITH PRIOR APPROVAL OF THE DESIGNER.
- ALL SLOPES FOR HORIZONTAL DRAINAGE AND SEWER LINES SHALL MAINTAIN A MINIMUM SLOPE UNLESS OTHERWISE SPECIFIED.
- ALL MATERIALS TO BE USED SHALL BE BRAND NEW AND OF APPROVED TYPE APPROPRIATE FOR BOTH LOCATION AND INTENDED USE.
- ALL PLUMBING INSTALLATION SHALL BE UNDER THE DIRECT SUPERVISION OF A DULY LICENSED MASTER PLUMBER / SANITARY ENGINEER.
- PROVIDE ISOLATION VALVE FOR EVERY TOILET ROOM INK2 LINE1.
- SEPTIC TANK CONSTRUCTION MUST FOLLOW SECTION 233 OF THE NATIONAL BUILDING CODE.

SECOND FLOOR SANITARY LAY OUT

 SCALE: 1:150M.

PREPARED FROM:	PROJECT TITLE:	DRAWN:	RECOMMENDED BY:	APPROVED BY:	SHEET NO.
 SORSOGON CITY CITY ENGINEER'S OFFICE	RENOVATION OF DRRMO / EOC BUILDING LOCATION: CITY HALL COMPOUND, BRGY. CABIO-AN, EAST DIST. SORSOGON CITY.	 ZONING OFFICER IV	 ROEL D. SOMER, JR. / RMP CITY ENGINEER	 HON. MA. ESTER E. HAMOR CITY MAYOR	

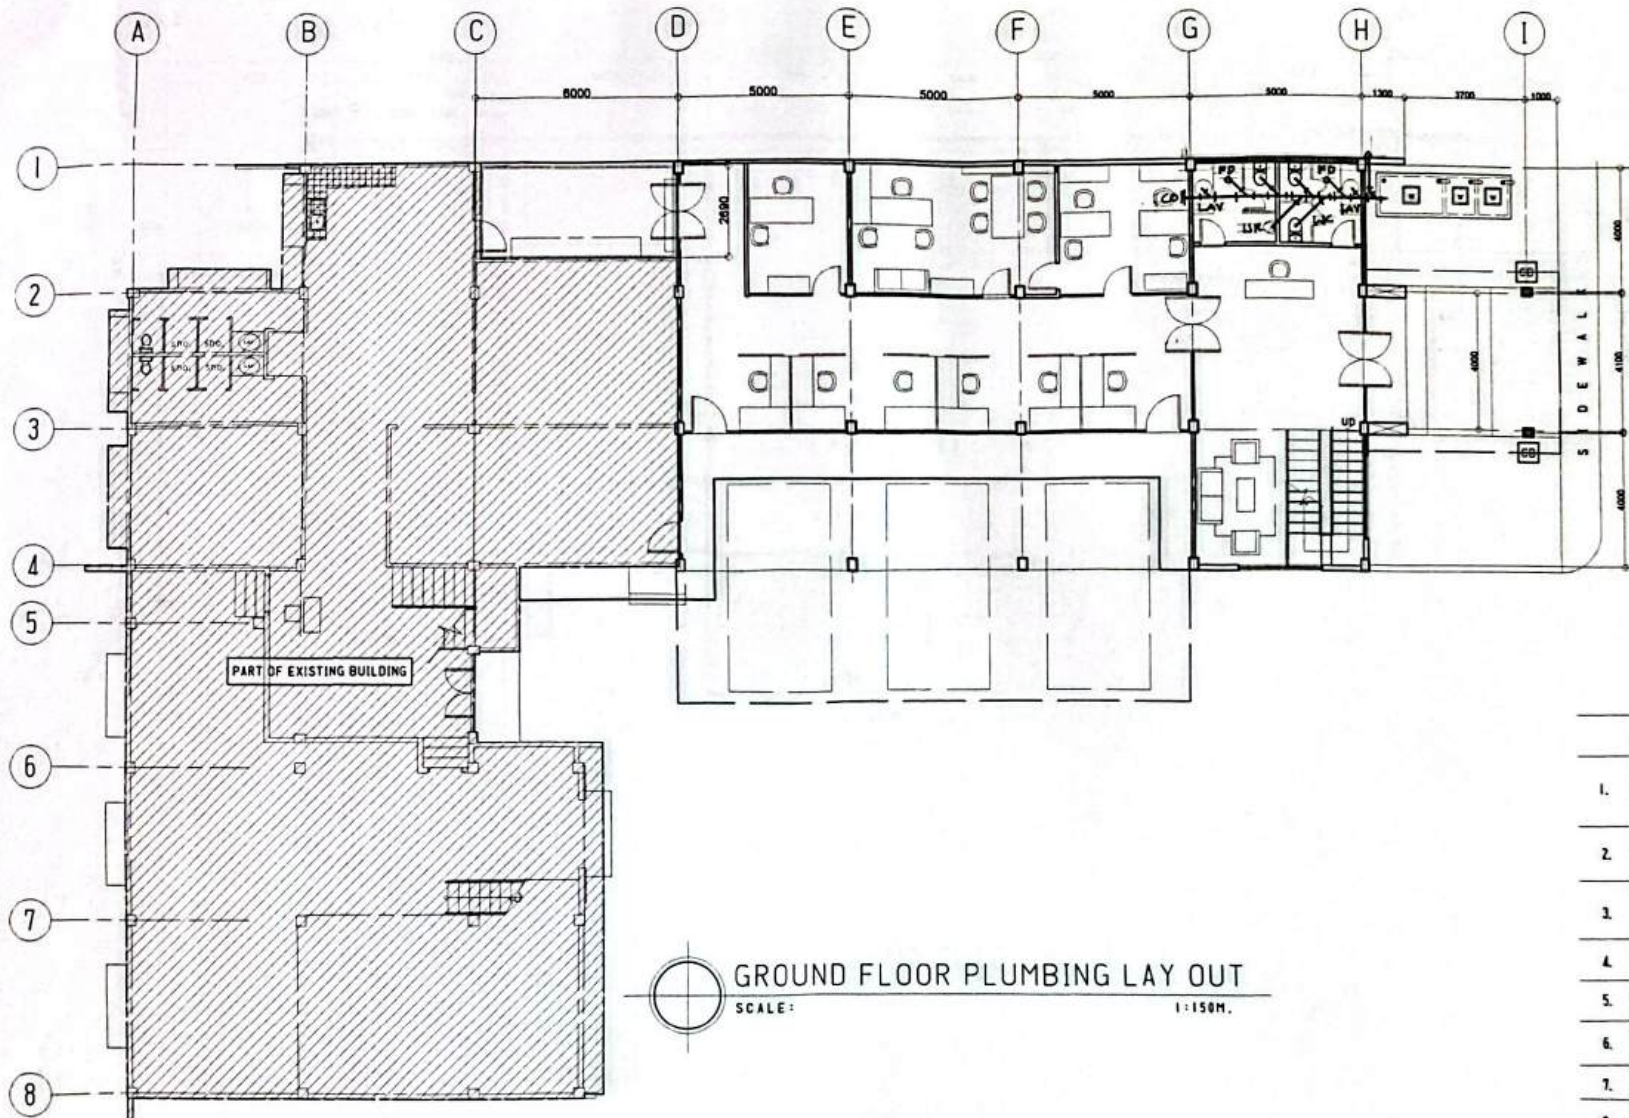


KEY TO SYMBOLS	
WC	WATER CLOSET
LAV	LAVATORY
FD	FLOOR DRAIN
CO	CLEAN OUT
VSTR	VENT STACK THRU ROOF
F	FAUCET
MH	MAN HOLE
DS	DOWN SPOUT
GV	GATE VALVE
CV	CHECK VALVE
CWL	COLD WATER LINE
WPL	WASTE PIPE LINE
GIP	GALVANIZED IRON PIPE
PVC	POLYVINYL CHLORIDE
KS	KITCHEN SINK
CB	CATCH BASIN
RD	ROOF DRAIN
ST	SEPTIC TANK
WM	WATER METER

PLUMBING / SANITARY NOTES

- ALL SANITARY WORKS INCLUDED HEREIN SHALL BE EXECUTED ACCORDING TO THE PROVISION OF THE PHILIPPINE NATIONAL SANITATION CODE: THE NATIONAL BUILDING CODE AND THE RULES AND REGULATION OF SORSOGON CITY.
- COORDINATE THE DRAWINGS WITH OTHER INDICATED. ANY RELOCATION REQUIRED FOR PROPER EXECUTION OF OTHER TRADES SHALL BE WITH PRIOR APPROVAL OF THE DESIGNER.
- ALL PIPES SHALL BE INSTALLED AS INDICATED. ANY RELOCATED REQUIRED FOR PROPER EXECUTION OF OTHER TRADES SHALL BE WITH PRIOR APPROVAL OF THE DESIGNER.
- ALL SLOPES FOR HORIZONTAL DRAINAGE AND SEWER LINES SHALL MAINTAIN 1% MINIMUM SLOPE UNLESS OTHERWISE SPECIFIED.
- ALL MATERIALS TO BE USED SHALL BE BRAND NEW AND OF APPROVED TYPE APPROPRIATE FOR BOTH LOCATION AND INTENDED USE.
- ALL PLUMBING INSTALLATION SHALL BE UNDER THE DIRECT SUPERVISION OF A DULY LICENSED MASTER PLUMBER / SANITARY ENGINEER.
- PROVIDE ISOLATION VALVE FOR EVERY TOILET ROOM (H2O LINE).
- SEPTIC TANK CONSTRUCTION MUST FOLLOW SECTION 230 OF THE NATIONAL BUILDING CODE.

PREPARED FROM:	PROJECT TITLE:	CADD BY:	RECOMMENDED BY:	APPROVED BY:	SHEET NO.
 SORSOGON CITY CITY ENGINEER'S OFFICE	RENOVAION OF DRRMO / EOC BUILDING LOCATION: CITY HALL COMPOUND, BRGY. CABID-AN, EAST DIST. SORSOGON CITY.	 ZONING OFFICER IV	 ROEL D. LAMER, RMP CITY ENGINEER	 HON. MA. ESTER E. NAMOR CITY MAYOR	

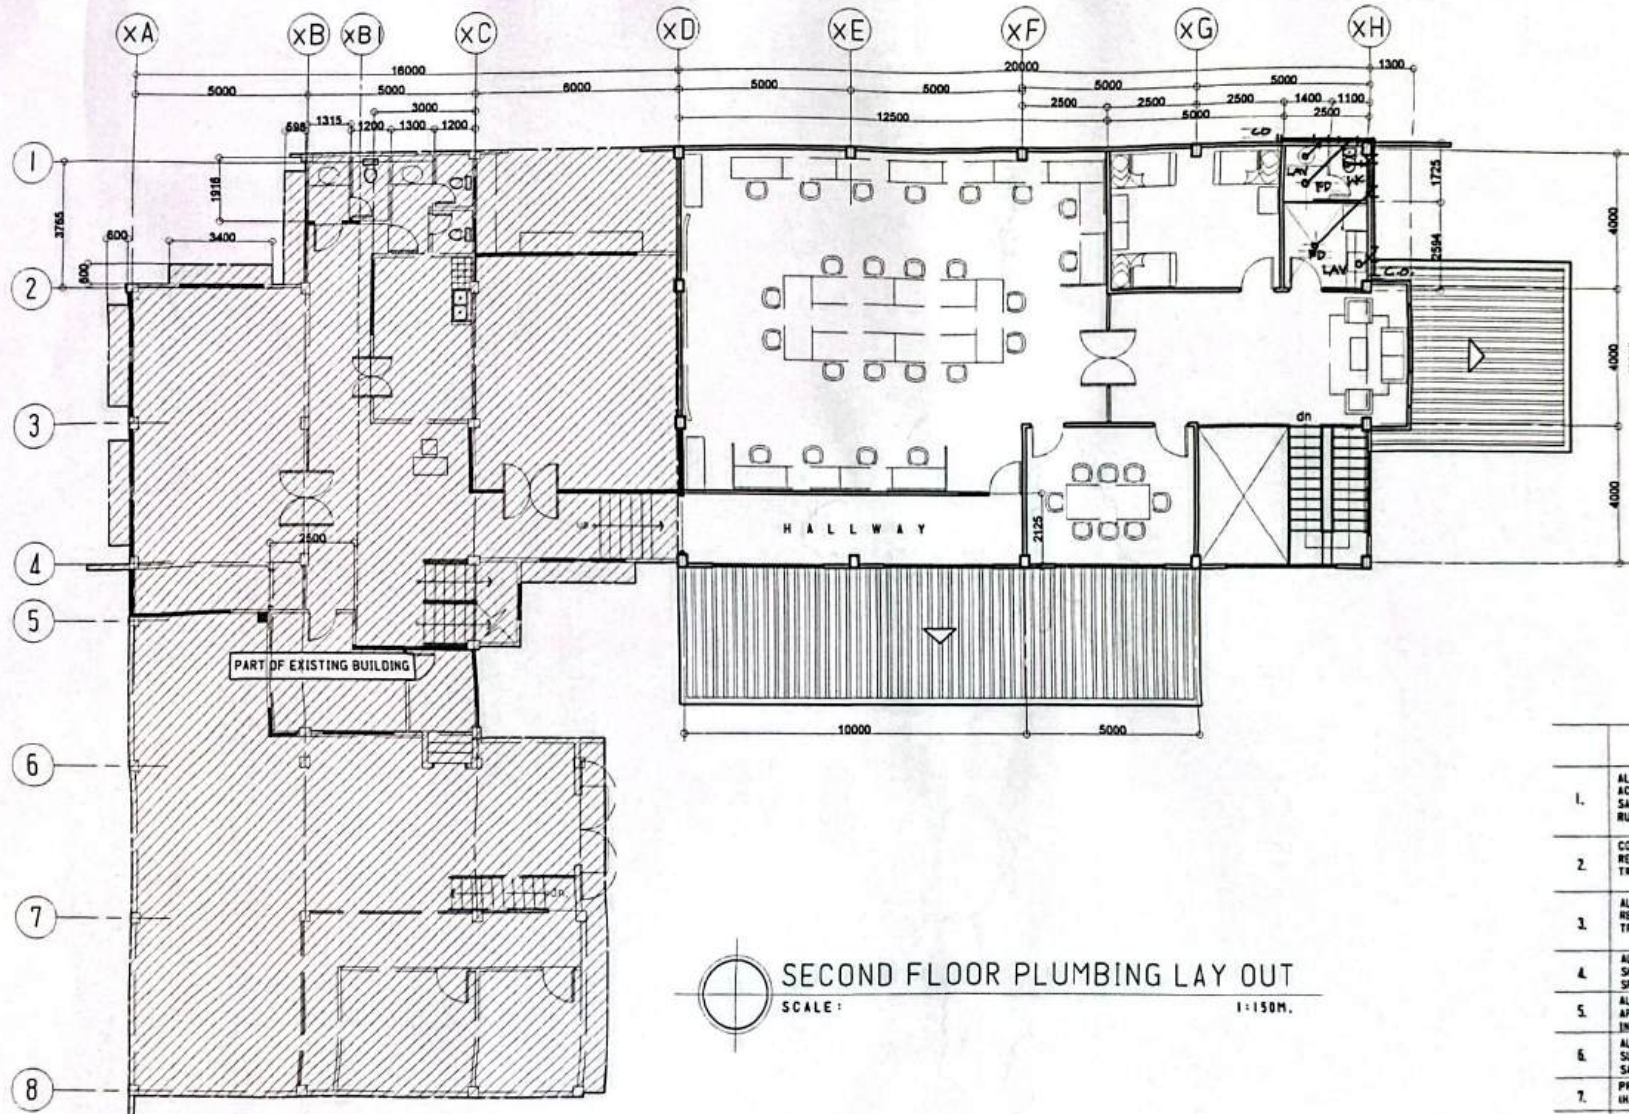

KEY TO SYMBOLS	
WC	WATER CLOSET
LAV	LAVATORY
FD	FLOOR DRAIN
CO	CLEAN OUT
VSTR	VENT STACK THRU ROOF
F	FAUCET
MH	MAN HOLE
DS	DOWN SPOUT
GV	GATE VALVE
CV	CHECK VALVE
CWL	COLD WATER LINE
WPL	WASTE PIPE LINE
GIP	GALVANIZED IRON PIPE
PVC	POLYVINYL CHLORIDE
KS	KITCHEN SINK
CB	CATCH BASIN
RD	ROOF DRAIN
ST	SEPTIC TANK
WM	WATER METER

PLUMBING / SANITARY NOTES

- ALL SANITARY WORKS INCLUDED HEREIN SHALL BE EXECUTED ACCORDING TO THE PROVISIONS OF THE PHILIPPINE NATIONAL SANITATION CODE, THE NATIONAL BUILDING CODE AND THE RULES AND REGULATION OF SORSOGON CITY.
- COORDINATE THE DRAWINGS WITH OTHER INDICATED. ANY RELOCATION REQUIRED FOR PROPER EXECUTION OF OTHER TRADES SHALL BE WITH PRIOR APPROVAL OF THE DESIGNER.
- ALL PIPES SHALL BE INSTALLED AS INDICATED. ANY RELOCATION REQUIRED FOR PROPER EXECUTION OF OTHER TRADES SHALL BE WITH PRIOR APPROVAL OF THE DESIGNER.
- ALL SLOPES FOR HORIZONTAL DRAINAGE AND SEWER LINES SHALL MAINTAIN 1/8" MINIMUM SLOPE UNLESS OTHERWISE SPECIFIED.
- ALL MATERIALS TO BE USED SHALL BE BRAND NEW AND OF APPROVED TYPE APPROPRIATE FOR BOTH LOCATION AND INTENDED USE.
- ALL PLUMBING INSTALLATION SHALL BE UNDER THE DIRECT SUPERVISION OF A DULY LICENSED MASTER PLUMBER / SANITARY ENGINEER.
- PROVIDE ISOLATION VALVE FOR EVERY TOILET ROOM (W20 LINE).
- SEPTIC TANK CONSTRUCTION MUST FOLLOW SECTION 23 OF THE NATIONAL BUILDING CODE.

SECOND FLOOR PLUMBING LAY OUT

SCALE: 1:150M.

PREPARED FROM:



SORSOGON CITY
CITY ENGINEER'S OFFICE

PROJECT TITLE:

RENOVATION OF DRRMO / EOC BUILDING

LOCATION: CITY HALL COMPOUND, BRGY. CABID-AN, EAST DIST. SORSOGON CITY.

DRAWN:

TOTZADGON
ZONING OFFICER IV

RECOMMENDED BY:

ROEL D. HAMER, P.E. / RMP
CITY ENGINEER

APPROVED BY:

HON. MA. ESTER E. HAMOR
CITY MAYOR

SHEET NO.

