

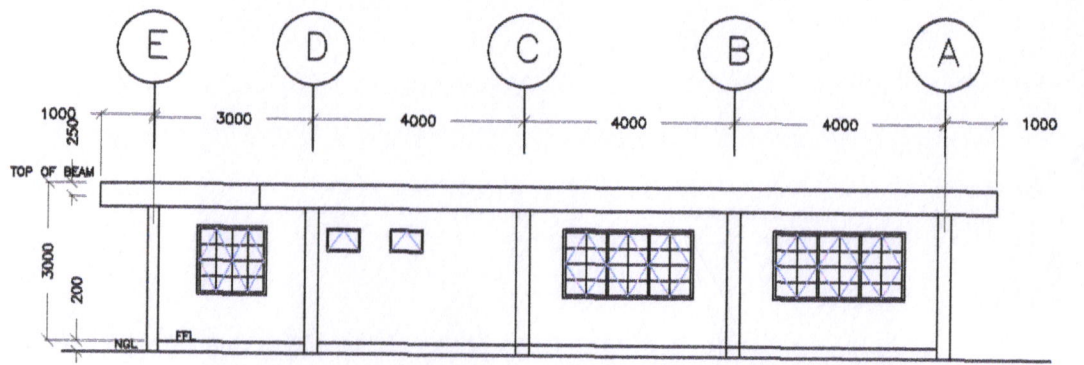

 **FLOOR PLAN**
SCALE: 1:100MTS

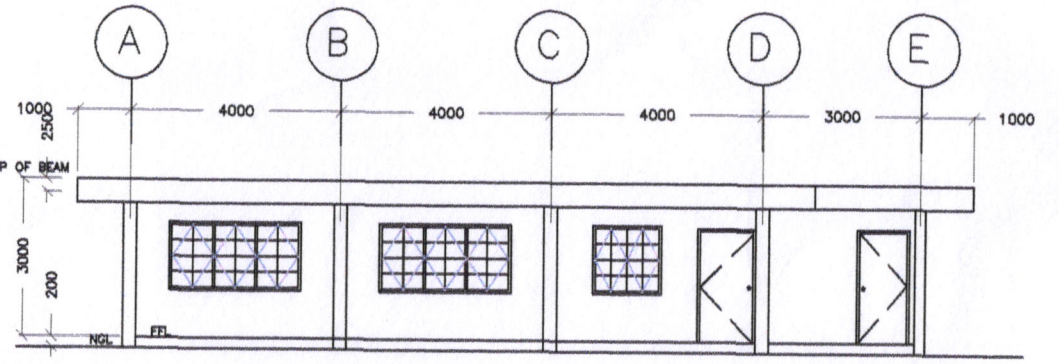


 **FRONT ELEVATION**
SCALE: 1:100MTS




 **REAR ELEVATION**
SCALE: 1:100MTS




SORSOGON CITY
CITY ENGINEER'S OFFICE


PROJECT TITLE:	DRAWN BY:	RECOMMENDING APPROVAL:	APPROVED BY:
CONSTRUCTION OF MULTI-PURPOSE HALL (Evacuation Center)			
LOCATION: BRGY. TUGOS	Pamela Legaspi	ROEL D. DOMER, CE	MA. ESTER HAMOR
WEST DISTRICT, SORSOGON CITY	DRAFTING AIDE	CITY ENGINEER	CITY MAYOR

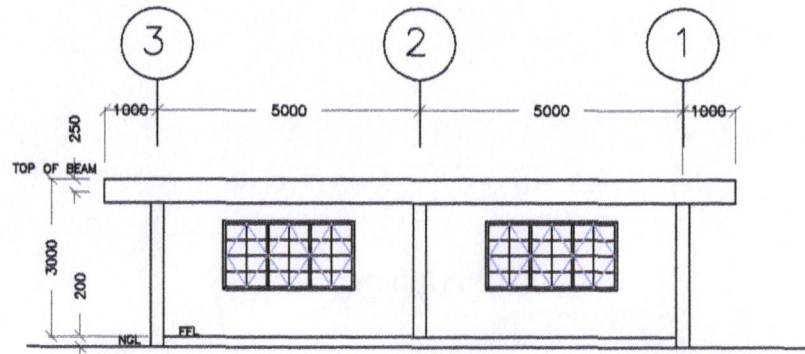

LEFT SIDE ELEVATION
SCALE: 1:100MTS

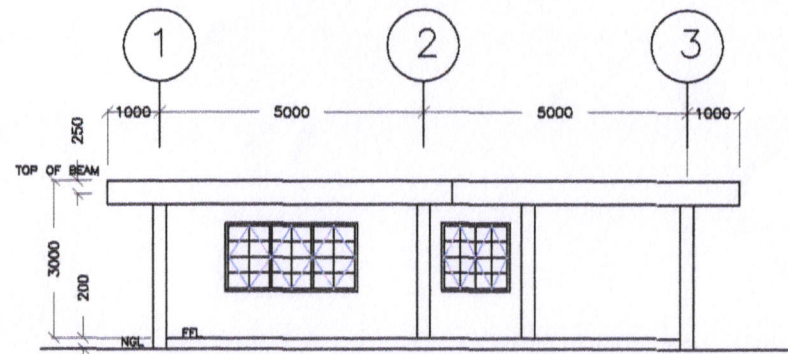

RIGHT SIDE ELEVATION
SCALE: 1:100MTS

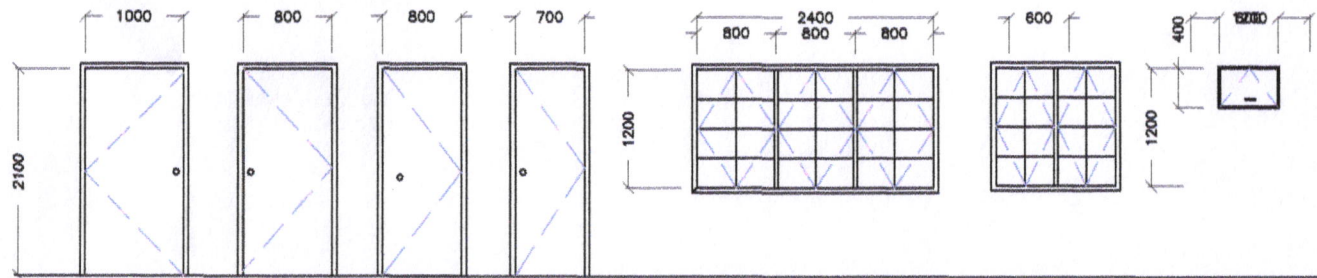

D1	D2	D3	D4
1 SET	1 SET	1 SET	2 SETS
PANEL DOOR	PANEL DOOR	EXT. ENGINEERED FLUSH DOOR	EXT. ENGINEERED FLUSH DOOR
ENTRANCE	EXIT	EXIT	TOILETS


W1	W2	W3
7 SETS	3 SETS	2 SETS
STEEL CASEMENT WINDOW	STEEL CASEMENT WINDOW	AWNING WINDOW
		TOILET

DOORS & WINDOWS SCHEDULE
SCALE: 1:100MTS






SORSOGON CITY
CITY ENGINEER'S OFFICE

PROJECT TITLE:	DRAWN BY:	RECOMMENDING APPROVAL:	APPROVED BY:
CONSTRUCTION OF MULTI-PURPOSE HALL (Evacuation Center)			
LOCATION: BRGY. TUGOS WEST DISTRICT, SORSOGON CITY	Pamela Legaspi DRAFTING AIDE	ROEL D. DOMER, CE CITY ENGINEER	MA. ESTER HAMOR CITY MAYOR

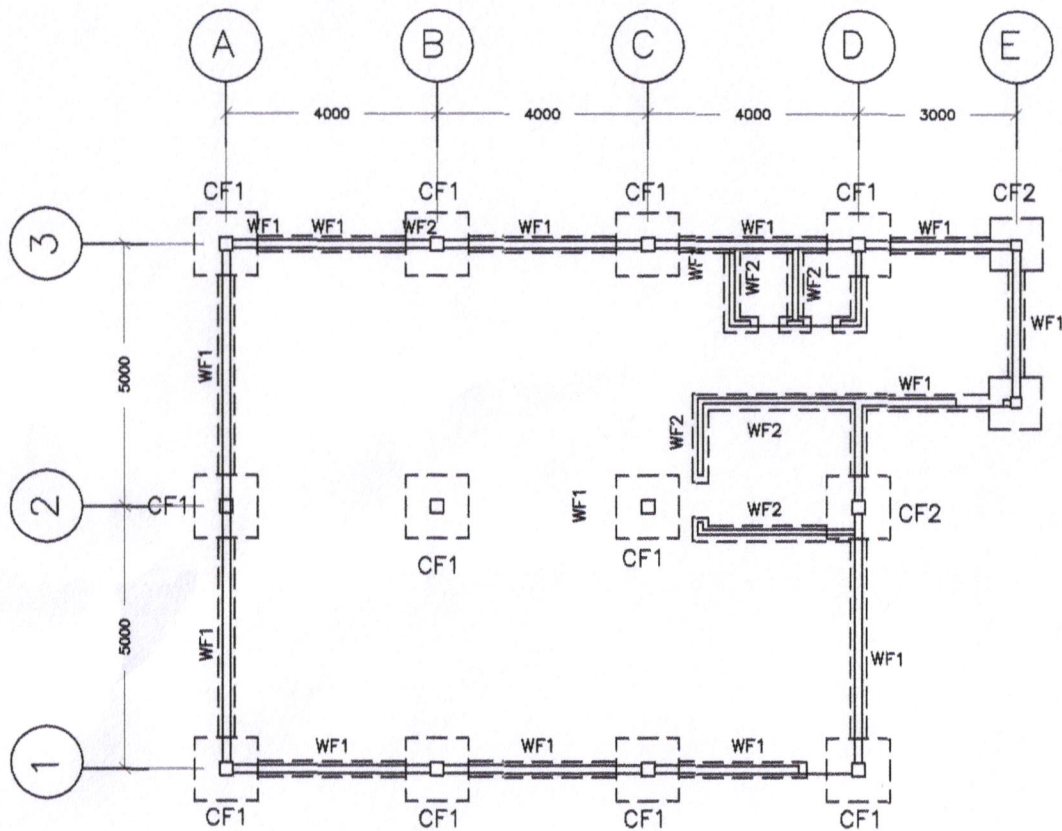


FOUNDATION PLAN
SCALE: 1:100MTS

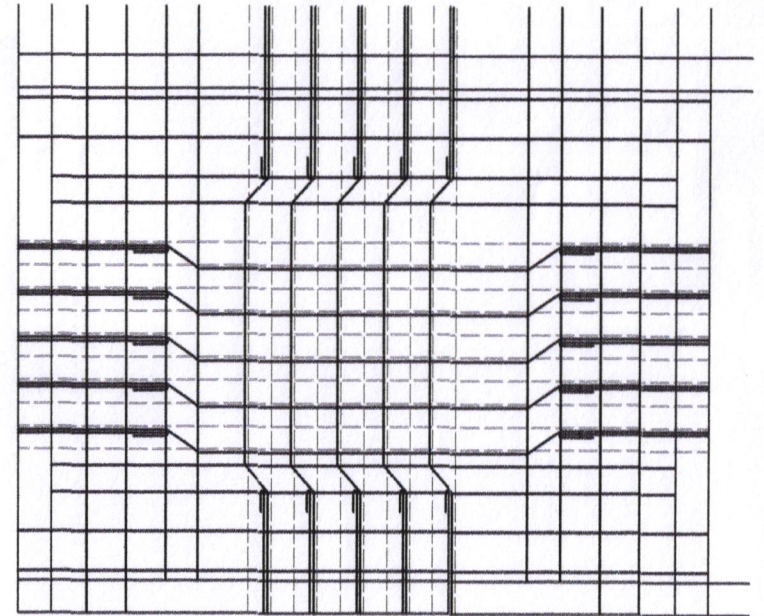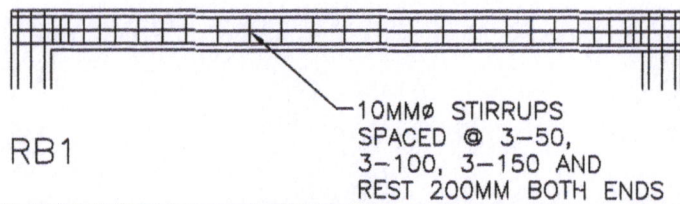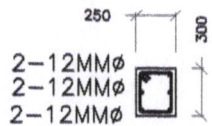


TWO-WAY SLAB DET.
SCALE: 1:50MTS

USE 10MM ϕ ALTERNATE
STRAIGHT & BEND BAR SPACED
@200mm O.C. B.W.

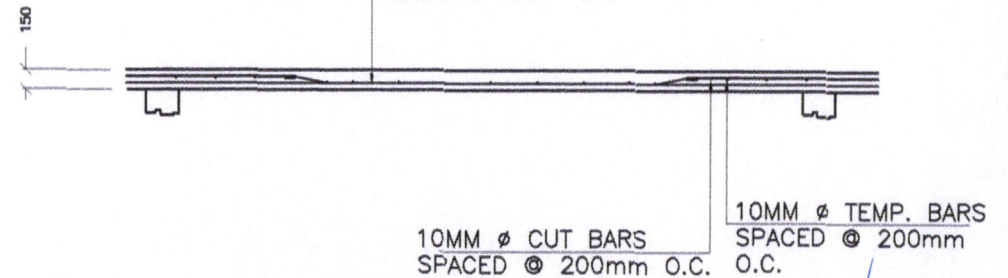


SORSOGON CITY
CITY ENGINEER'S OFFICE


PROJECT TITLE:	DRAWN BY:	RECOMMENDING APPROVAL:	APPROVED BY:
CONSTRUCTION OF MULTI-PURPOSE HALL (Evacuation Center)			
LOCATION: BRGY. TUGOS WEST DISTRICT, SORSOGON CITY	Pamela Legaspi DRAFTING AIDE	ROEL D. DOMER, CE CITY ENGINEER	MA. ESTER HAMOR CITY MAYOR

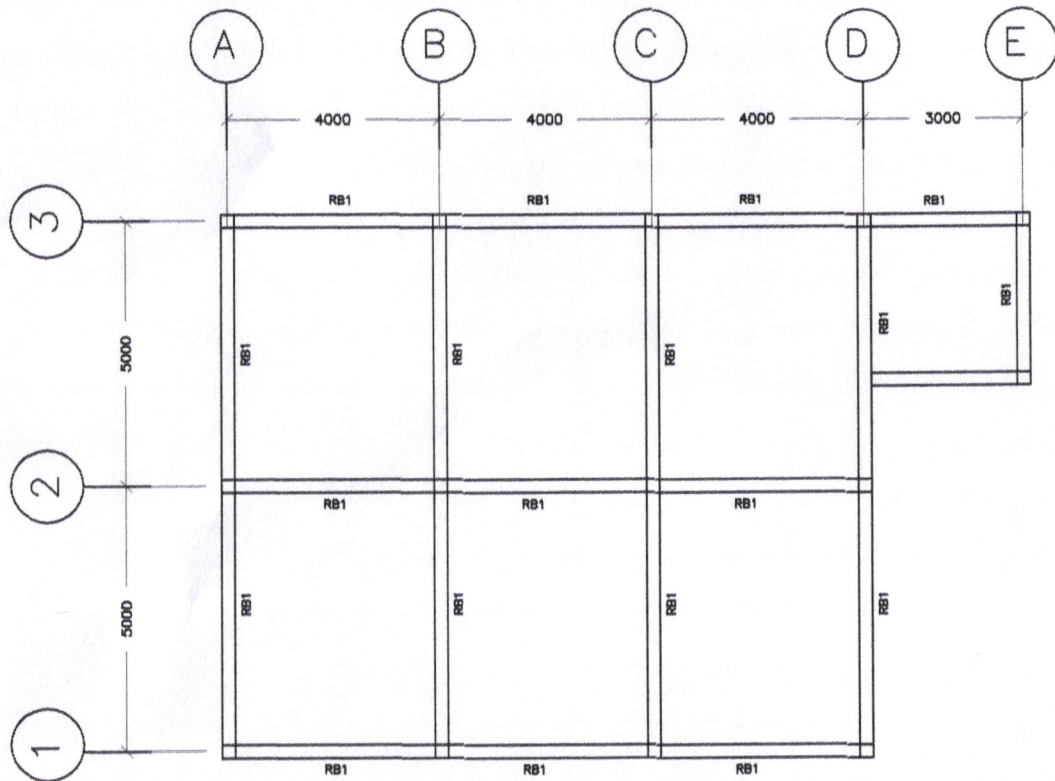

ROOF BEAM LAYOUT
SCALE: 1:100MTS

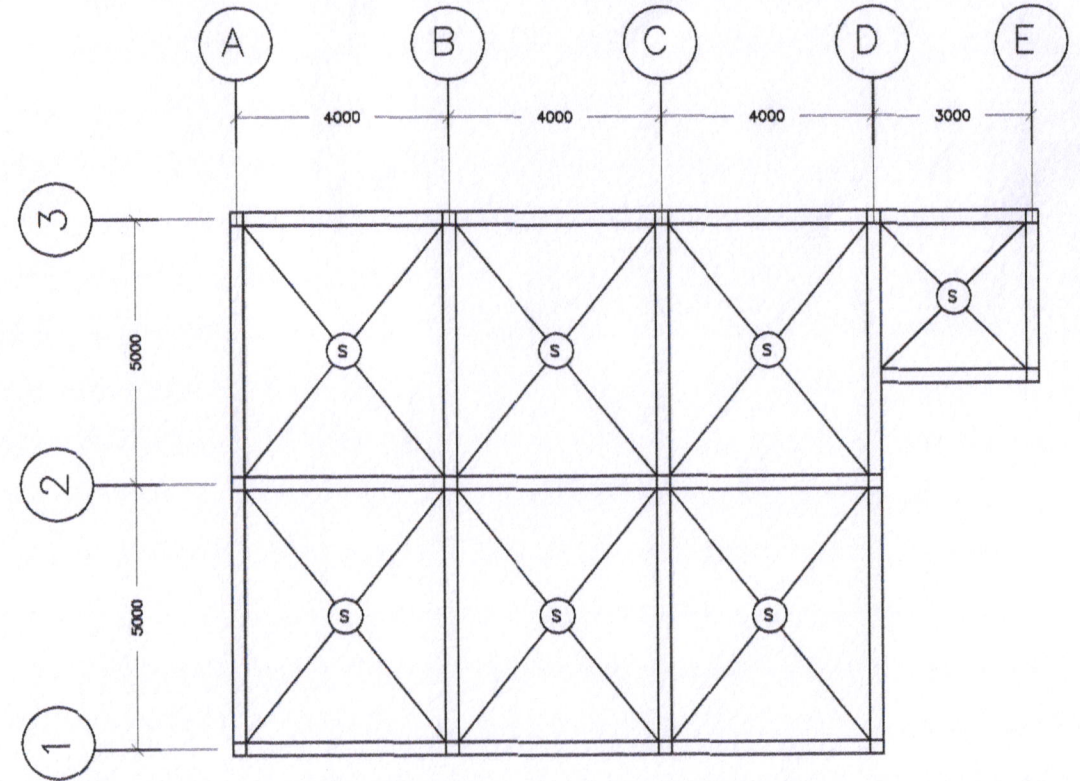

ROOF SLAB LAYOUT
SCALE: 1:100MTS

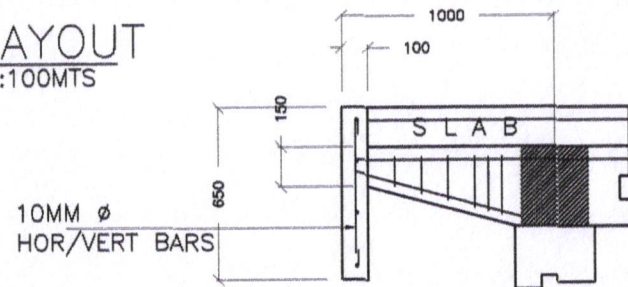

LENTEL BEAM DET.
SCALE: 1:30MTS



SORSOGON CITY
CITY ENGINEER'S OFFICE

PROJECT TITLE:

CONSTRUCTION OF MULTI-PURPOSE
HALL (Evacuation Center)

LOCATION: BRGY. TUGOS

WEST DISTRICT, SORSOGON CITY

DRAWN BY:






Pamela Legaspi
DRAFTING AIDE

RECOMMENDING APPROVAL:

ROEL D. DOMER, CE
CITY ENGINEER


APPROVED BY:

MA. ESTER HAMOR
CITY MAYOR

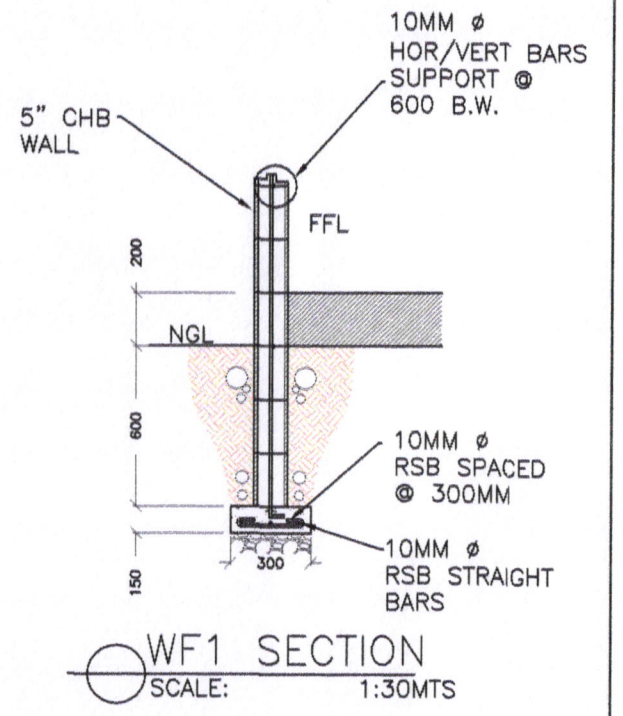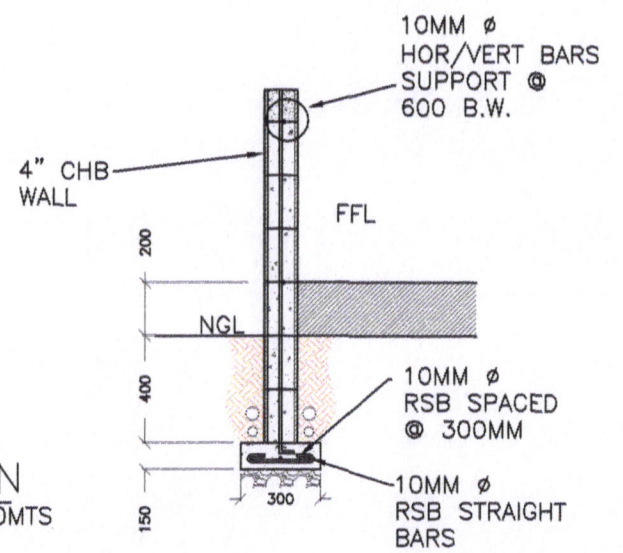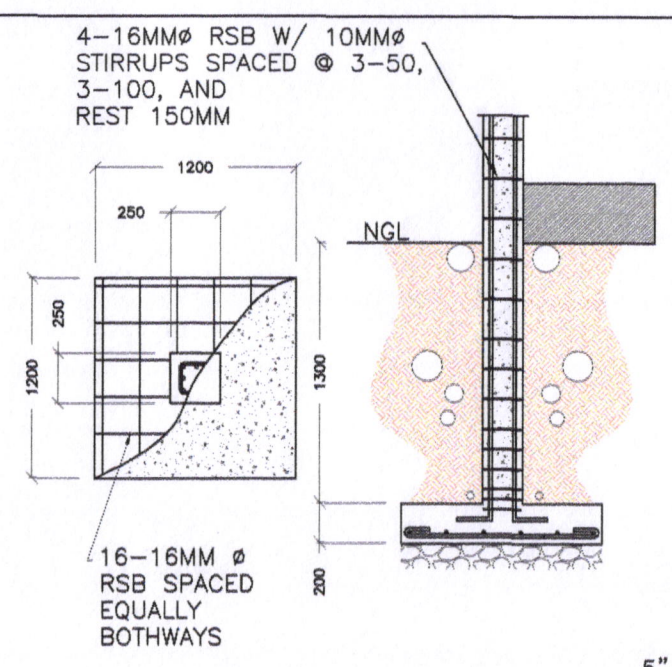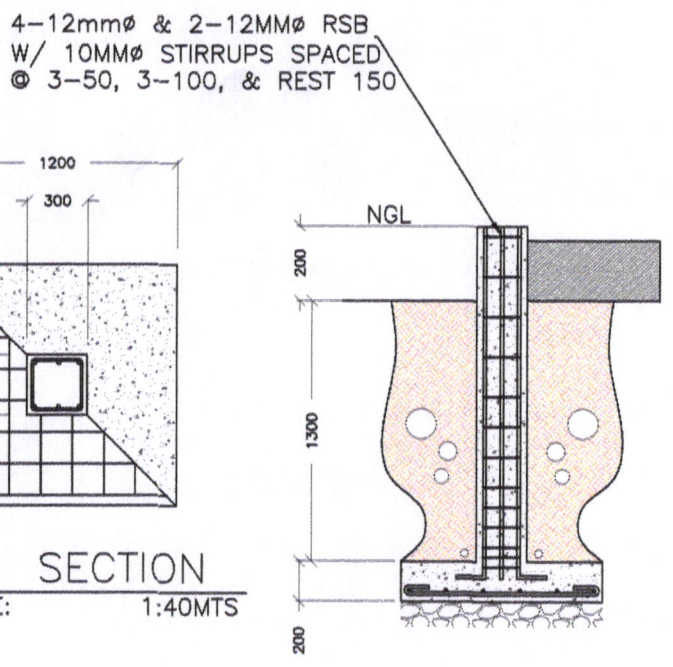
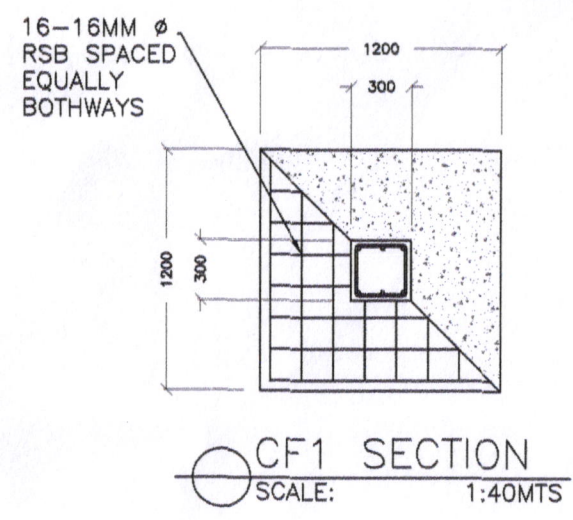


SORSOGON CITY
CITY ENGINEER'S OFFICE

PROJECT TITLE:	DRAWN BY:	RECOMMENDING APPROVAL:	APPROVED BY:
CONSTRUCTION OF MULTI-PURPOSE HALL (Evacuation Center)			
LOCATION: BRGY. TUGOS	Pamela Leqaspi	ROEL D. DOMER, CE	MA. ESTER HAMOR
WEST DISTRICT, SORSOGON CITY	DRAFTING AIDE	CITY ENGINEER	CITY MAYOR

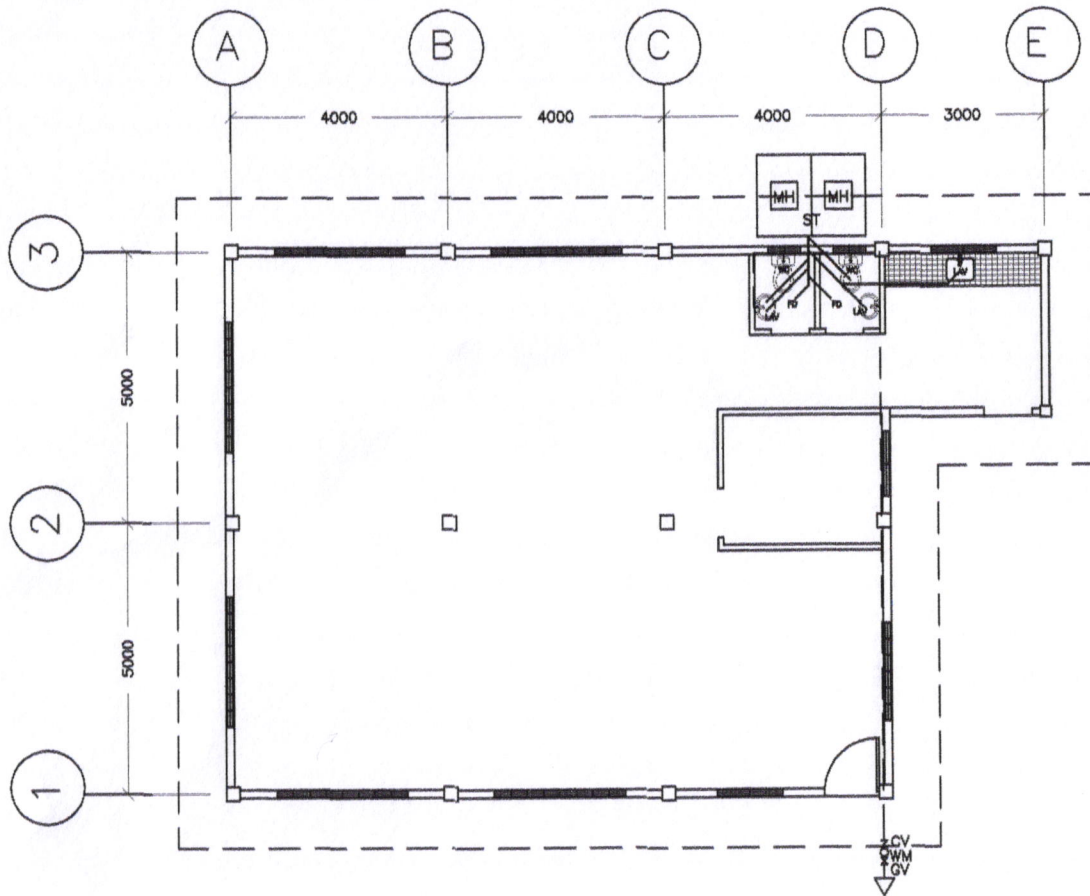


 
 
PLUMBING LAYOUT
SCALE: 1:100MTS

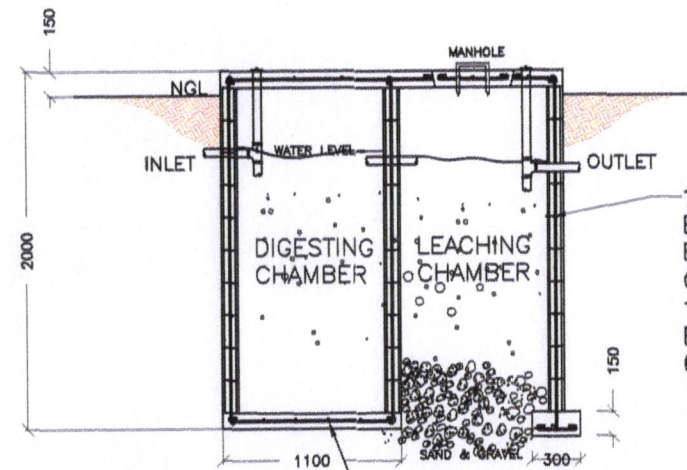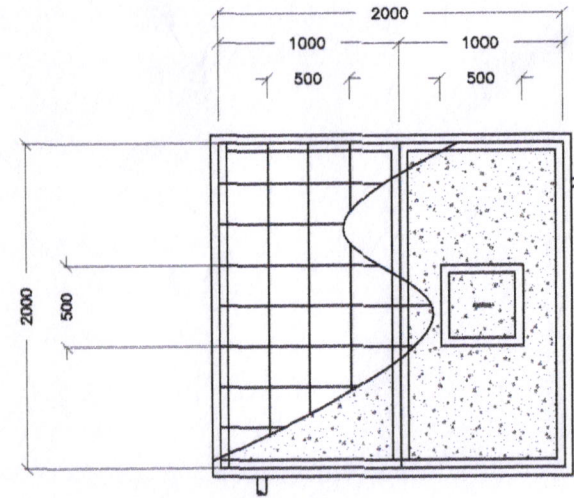


10mm \varnothing HOR. BARS SPACED @ EVERY 3 LAYERS OF CHB w/ 10mm \varnothing VERT. BARS SPACED @ 600mm O.C.


10mm \varnothing BASE BARS SPACED @ 250mm O.C. B.W.

SEPTIC TANK DET.
SCALE: 1:50MTS


 <p>SORSOGON CITY CITY ENGINEER'S OFFICE</p>	PROJECT TITLE:	DRAWN BY:	RECOMMENDING APPROVAL:	APPROVED BY:	
	CONSTRUCTION OF MULTI-PURPOSE HALL (Evacuation Center)				
	LOCATION: BRGY. TUGOS	Pamela Legaspi	ROEL D. DOMER, CE	MA. ESTER HAMOR	
	WEST DISTRICT, SORSOGON CITY	DRAFTING AIDE	CITY ENGINEER	CITY MAYOR	

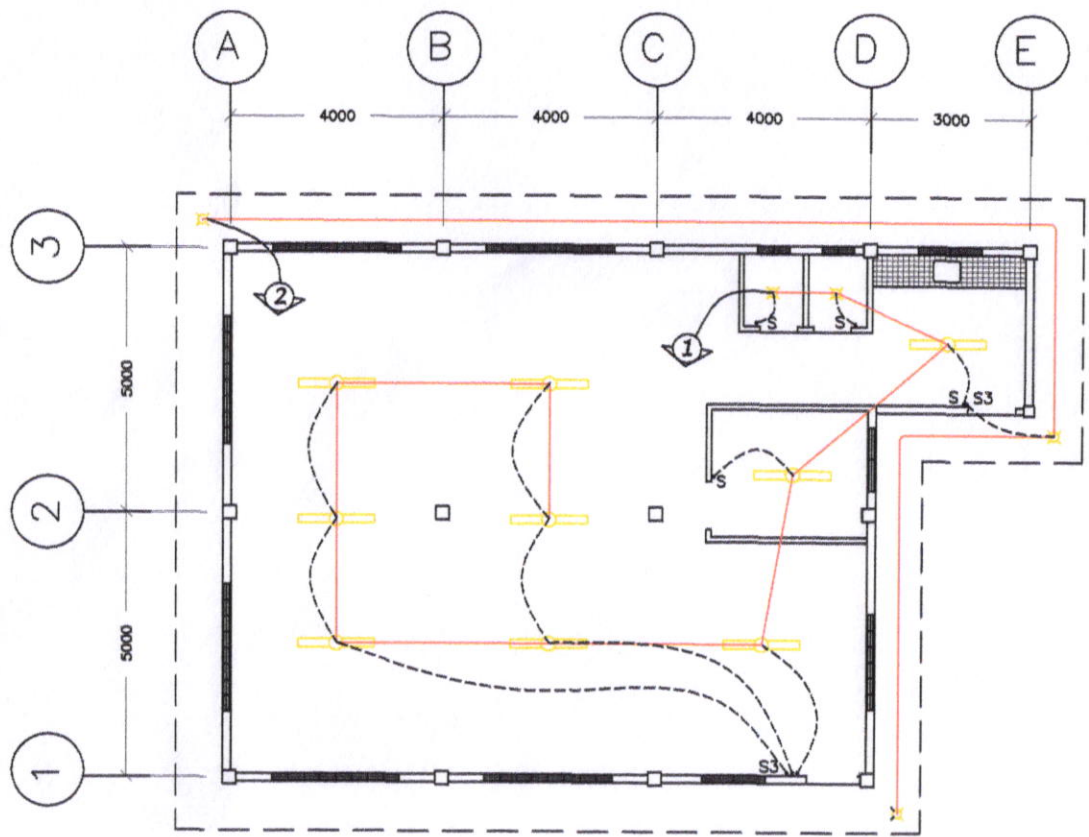

○ LIGHTING LAYOUT
SCALE: 1:100MTS

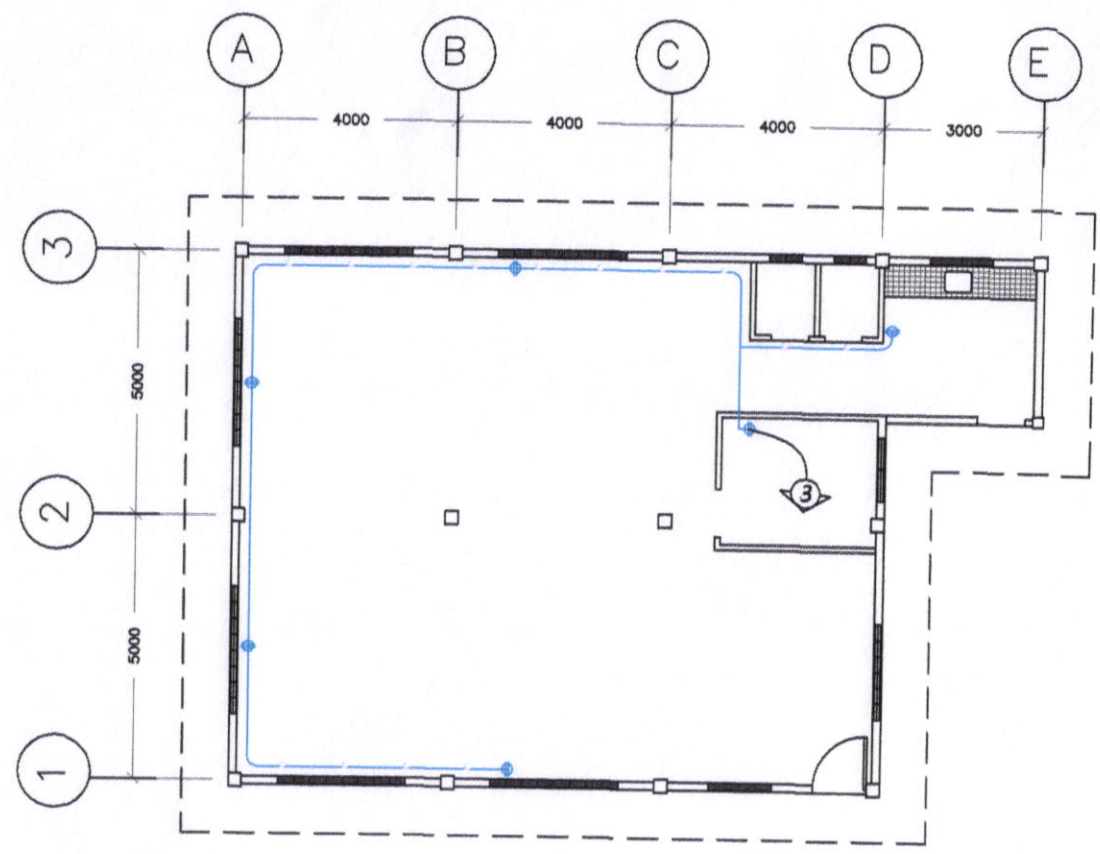

○ POWER LAYOUT
SCALE: 1:100MTS

 <p>SORSOGON CITY CITY ENGINEER'S OFFICE</p>	PROJECT TITLE:	DRAWN BY:	RECOMMENDING APPROVAL:	APPROVED BY:
	CONSTRUCTION OF MULTI-PURPOSE HALL (Evacuation Center)			
	LOCATION: BRGY. TUGOS WEST DISTRICT, SORSOGON CITY	Pamela Legaspi DRAFTING AIDE	ROEL D. DOMER, CE CITY ENGINEER	MA. ESTER HAMOR CITY MAYOR

ELECTRICAL NOTES


ALL ELECTRICAL WORKS SHALL BE DONE IN ACCORDANCE WITH THE LATEST RULES AND REGULATIONS OF THE PHIL. ELECTRICAL CODE AS WELL AS THE LOCAL AUTHORITY CONCERNED AND THE LOCAL POWER COMPANY.

ALL ELECTRICAL MATERIALS TO BE USED SHALL BE NEED & APPROVED TYPE FOR LOCATION & PURPOSE

MOUNTING HEIGHTS SHALL BE AS FOLLOWS:

- a. LIGHT CONTROL SWITCH- 1.35M ABOVE FIN. FLR. LINE AT CENTER
- b. CONVENIENCE OUTLET-ABOVE 1.0M ABOVE FIN. FLR. LINE AT CENTER
- c. PANEL BOARD- 2.0 M ABOVE FIN. FLR. LINE

ALL ELECTRICAL WORKS SHALL BE UNDER THE DIRECT & IMMEDIATE SUPERVISION OF A DULY LICENSED ELECTRICAL ENGINEER OR REGISTERED MASTER ELECTRICIAN

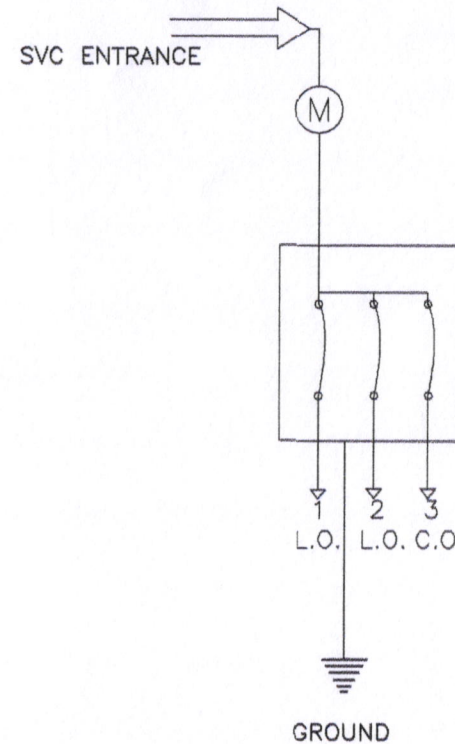

RISER DIAGRAM

SCHEDULE OF LOADS					
CIRCUIT NO.	DESCRIPTION	NO. OF LOADS	VOLTS	WATTS	AMP
1	LIGHTING OUTLET	11	230	1100	4.78
2	LIGHTING OUTLET	3	230	300	1.30
3	CONVENIENCE OUTLET	6	230	1080	4.69
	TOTAL				10.77



SORSOGON CITY
CITY ENGINEER'S OFFICE

PROJECT TITLE:	DRAWN BY:	RECOMMENDING APPROVAL:	APPROVED BY:
CONSTRUCTION OF MULTI-PURPOSE HALL (Evacuation Center)			
LOCATION: BRGY. TUGOS	Pamela Legaspi	ROEL D. DOMER, CE	MA. ESTER HAMOR
WEST DISTRICT, SORSOGON CITY	DRAFTING AIDE	CITY ENGINEER	CITY MAYOR