



**FRONT ELEVATION**

SCALE: 1:100 MTS.

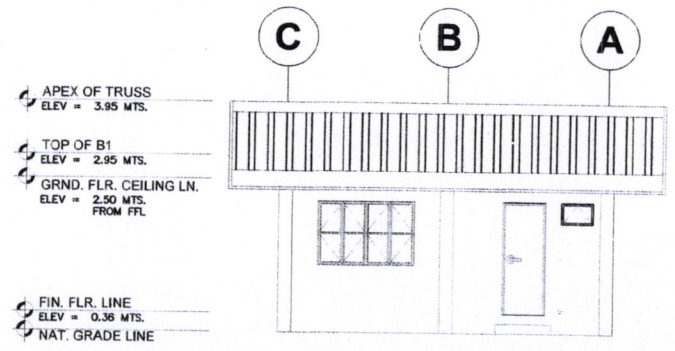


**FRONT ELEVATION**

SCALE: 1:100 MTS.

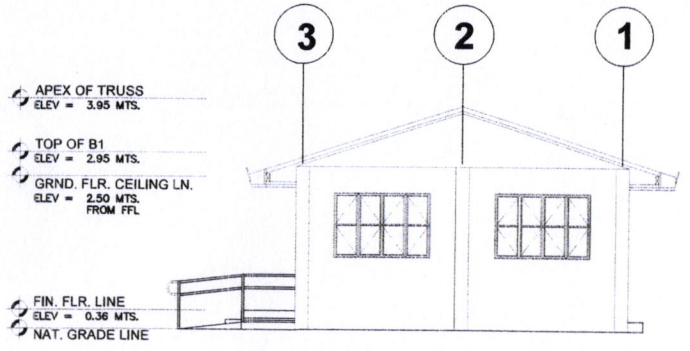

**RIGHT SIDE ELEVATION**

SCALE: 1:100 MTS.

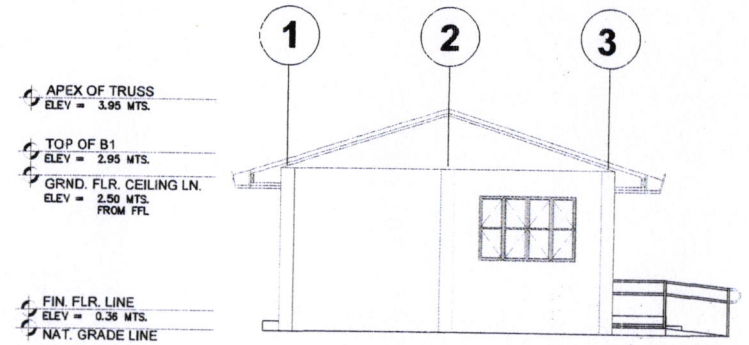

**LEFT SIDE ELEVATION**


SCALE: 1:100 MTS.



SORSOGON CITY  
CITY ENGINEER'S OFFICE


PROJECT TITLE:	DRAWN BY:	NOTED BY:	APPROVED BY:
CONSTRUCTION OF HEALTH CENTER,	<i>Geraldine E. Fan</i>		
LOCATION: SAN JUAN, (Puro) EAST DISTRICT, SORSOGON CITY	<i>Geraldine E. Fan, uap</i> BUILDING INSPECTOR	ROEL D. DOMER CITY ENGINEER	<i>MA ESTER E. HANOR</i> CITY MAYOR



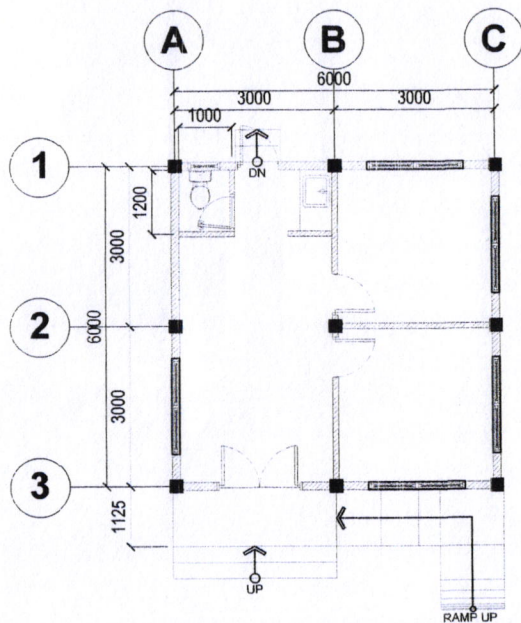


**FLOOR PLAN**

SCALE: 1:100 MTS.

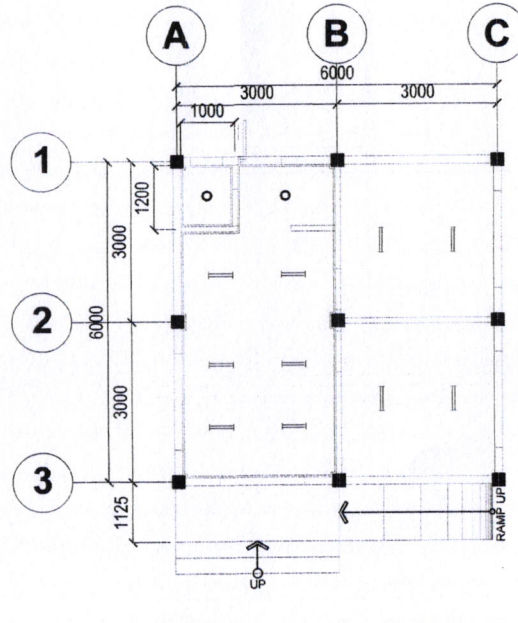






**REFLECTED CEILING PLAN**

SCALE: 1:100 MTS.

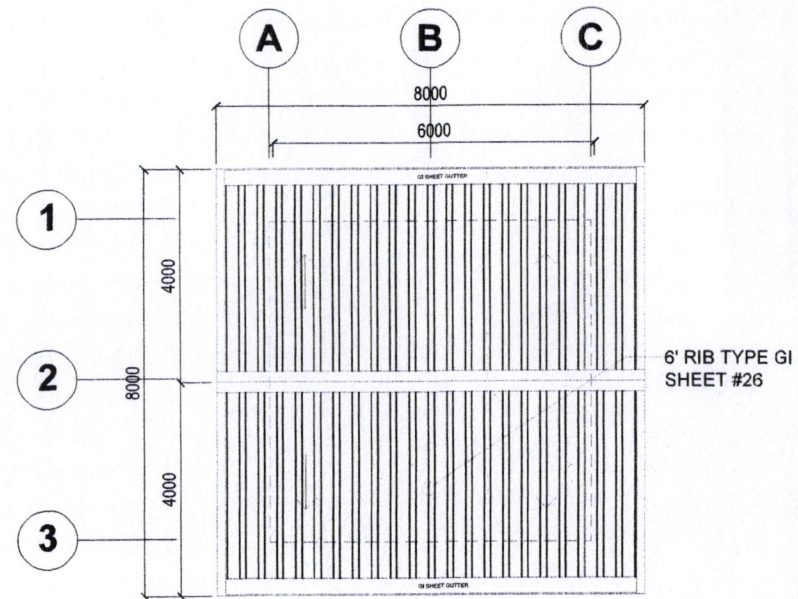

**ROOF PLAN**

SCALE: 1:100 MTS.

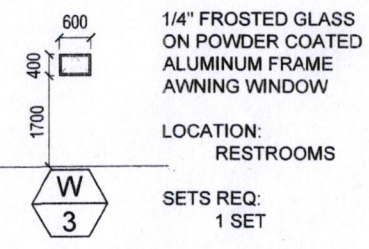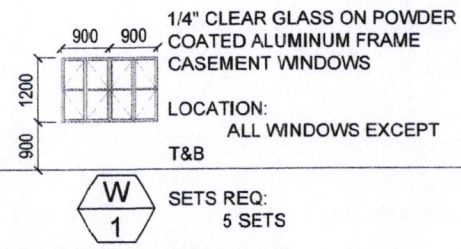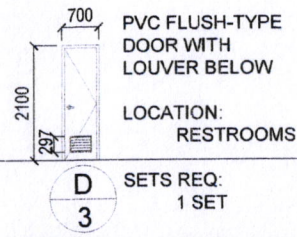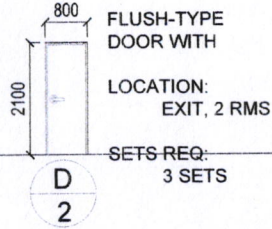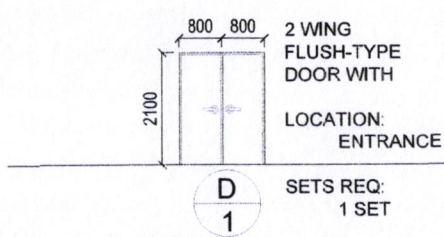




**DOORS AND WINDOW SCHEDULE**


SCALE: 1:100 MTS.




PROJECT TITLE:	DRAWN BY:	NOTED BY:	APPROVED BY:
CONSTRUCTION OF HEALTH CENTER	<i>Geraldine E. Tan</i>		
LOCATION: SAN JUAN (RORO), EAST DIST	<i>Geraldine E. Tan, nap</i>	ROEL D. DOMER	<i>MA ESTER E. HAMON</i>
SORSOGON CITY	BUILDING INSPECTOR	CITY ENGINEER	CITY MAYOR






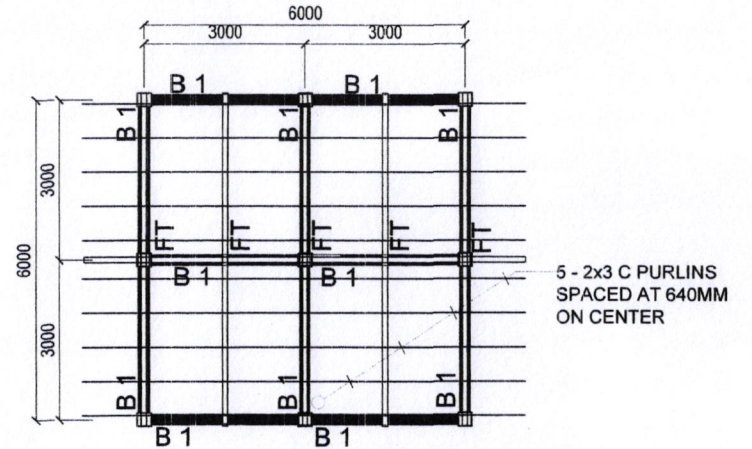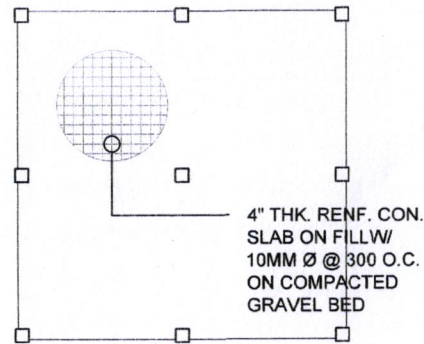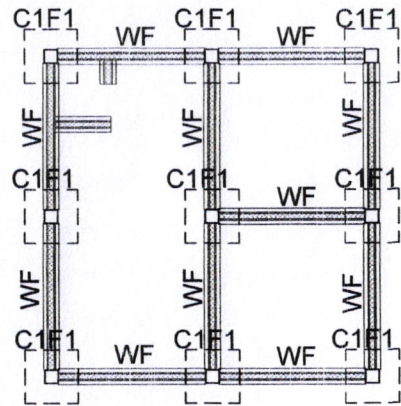


 **FOUNDATION PLAN**  
SCALE: 1:100 MTS.

    **ROOF FRAMING PLAN**  
SCALE: 1:100 MTS.




PROJECT TITLE:	DRAWN BY:	NOTED BY:	APPROVED BY:
CONSTRUCTION OF HEALTH CENTER			
LOCATION: SAN JUAN, (P.O.D.) EAST DISTRICT, SORSOGON CITY	Geraldine E. Tan, <i>naf</i> BUILDING INSPECTOR	ROEL D. DOMER CITY-ENGINEER	MA ESTER E. HAMOR CITY MAYOR



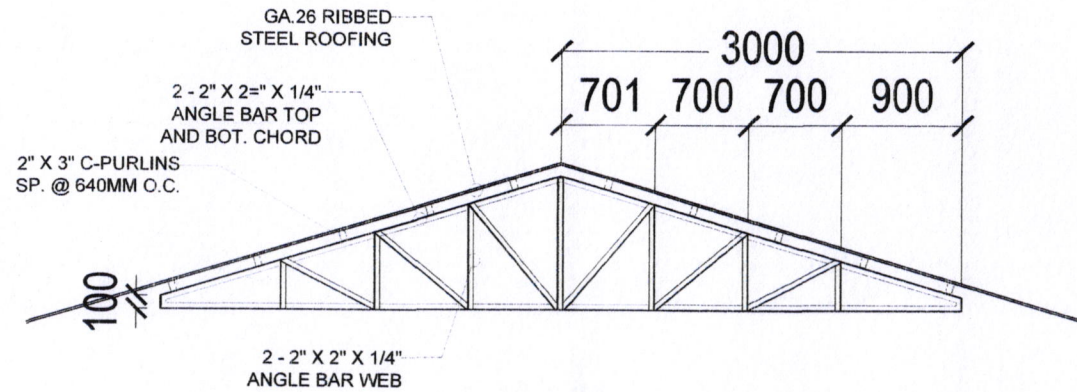

**DETAIL OF FULL TRUSS**  
 SCALE: 1:40 MTS.

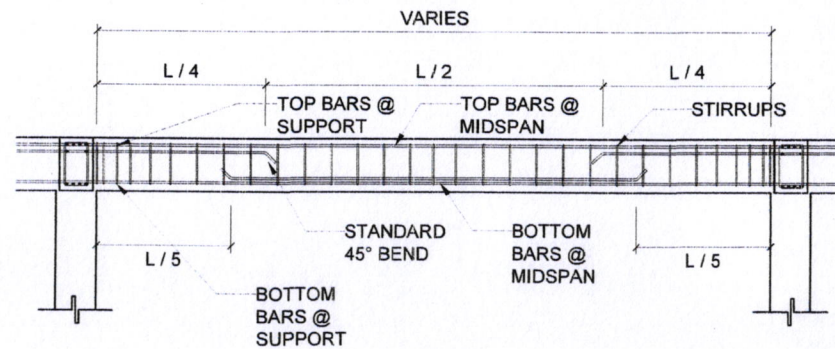


**TYPICAL DETAIL OF RC BEAM**  
 SCALE: 1:40 MTS.




PROJECT TITLE:	DRAWN BY:	NOTED BY:	APPROVED BY:
CONSTRUCTION OF HEALTH CENTER	<i>Geraldine E. Tan, uap</i>		<i>MA. ESTER E. HAMDOR</i>
LOCATION: SAN JUAN (RORO), EAST DIST SORSOGON CITY	Geraldine E. Tan, uap BUILDING INSPECTOR	ROEL D. DOMER CITY ENGINEER	MA. ESTER E. HAMDOR CITY MAYOR




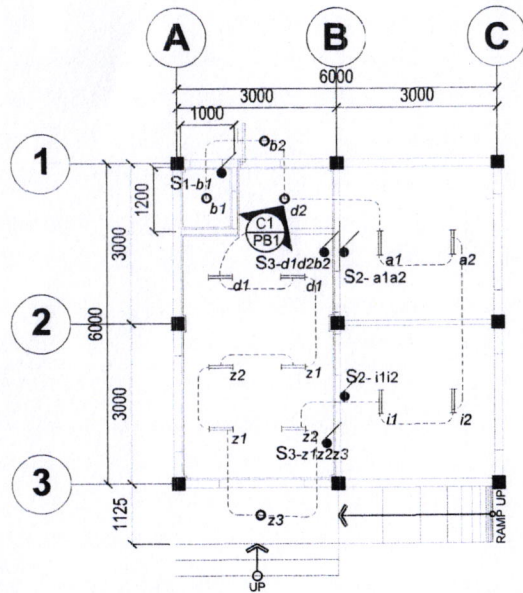

**LIGHTING LAYOUT**  
SCALE: 1:100 MTS.

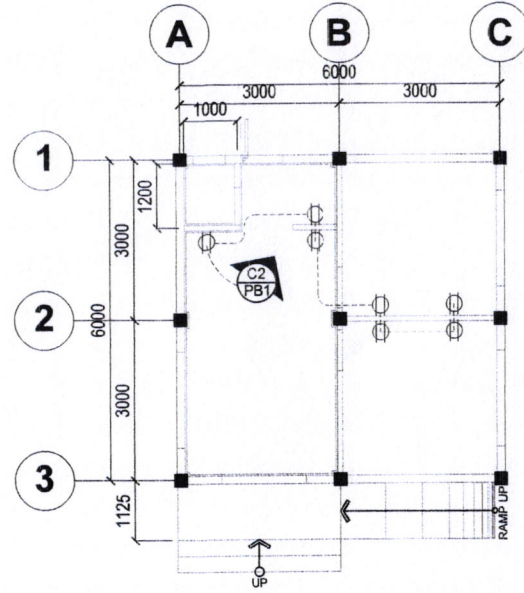

**POWER LAYOUT**  
SCALE: 1:100 MTS.

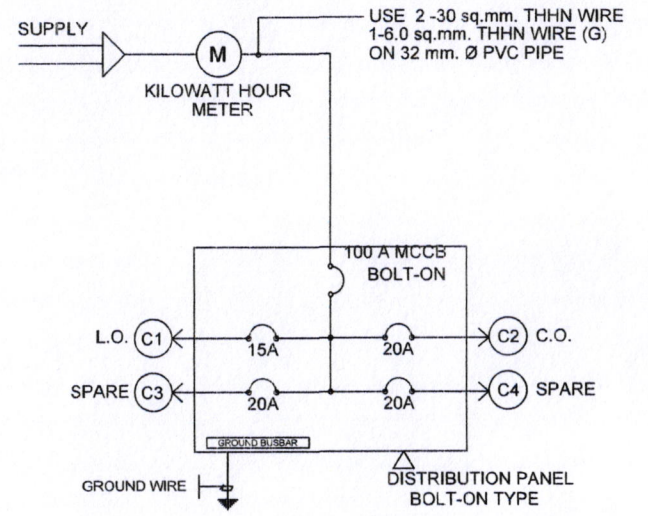

PROJECT TITLE:  
**CONSTRUCTION OF HEALTH CENTER**


LOCATION: SAN JUAN, (P.R.D) EAST DISTRICT,  
SORSOGON CITY

DRAWN BY:  
*Geraldine E. Tan, uap*  
Geraldine E. Tan, uap  
BUILDING INSPECTOR


RECOMMENDING APPROVAL:  
*Roel D. Domer*  
ROEL D. DOMER  
CITY ENGINEER

APPROVED BY:  
*Ma. Ester E. Hamor*  
MA. ESTER E. HAMOR  
CITY MAYOR




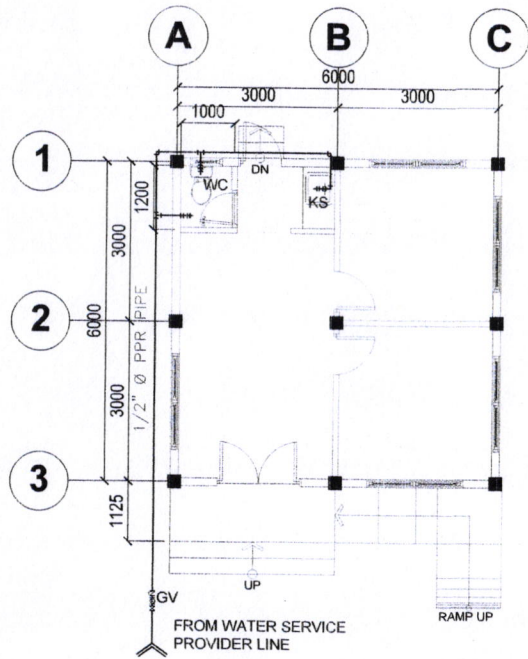

**CLEAN WATER LAYOUT**  
 SCALE: 1:100 MTS.

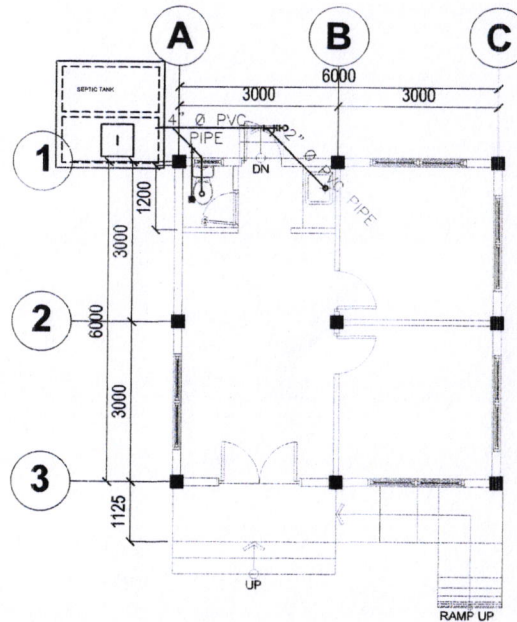

**SANITARY LAYOUT**  
 SCALE: 1:100 MTS.

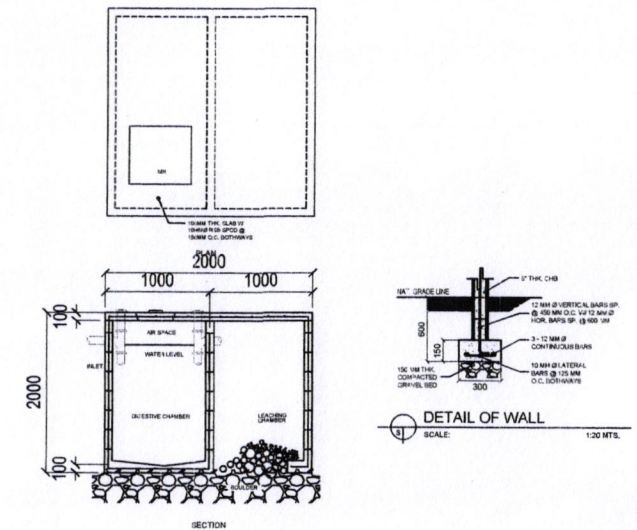

**DETAIL OF SEPTIC TANK**  
 SCALE: 1:30 MTS.



PROJECT TITLE:	DRAWN BY:	RECOMMENDING APPROVAL:	APPROVED BY:
<b>CONSTRUCTION OF HEALTH CENTER</b>	<i>Gerardine E. Tan, uap</i>		
LOCATION: SAN JUAN, (Rd) EAST DISTRICT, SORSOGON CITY	<i>Gerardine E. Tan, uap</i> BUILDING INSPECTOR	ROELD D. DOMER CITY ENGINEER	MA. ESTER E. HAMOR CITY MAYOR