




1 SITE PLAN
S-01 SCALE 1:100 MTS

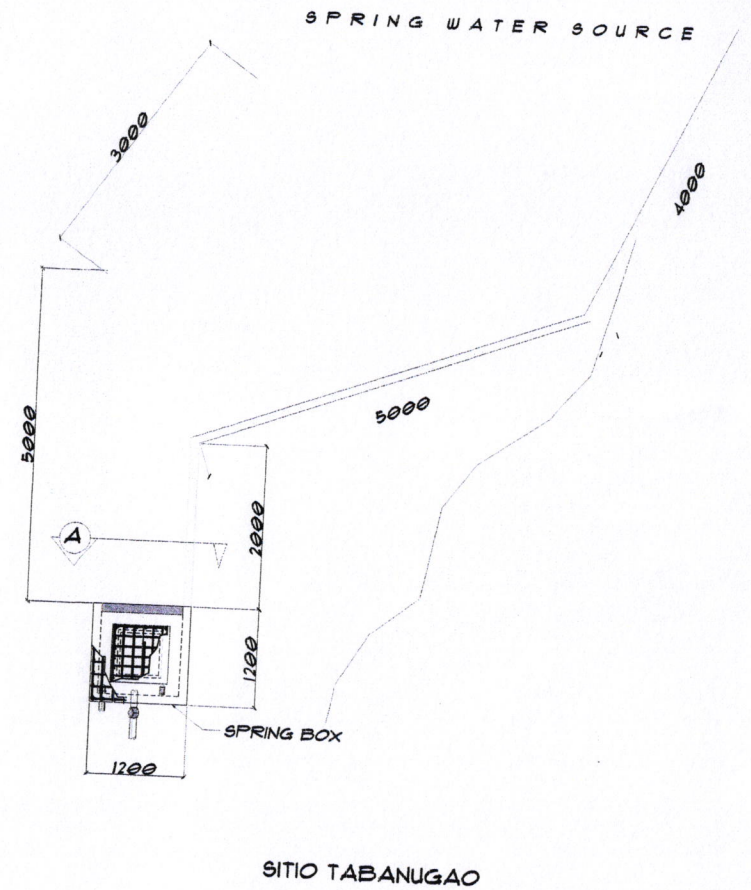


2 SITE PLAN
S-01 SCALE 1:100 MTS

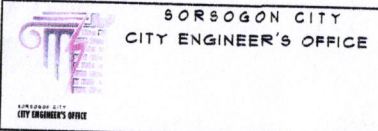


PROJECT TITLE: REHABILITATION/IMPROVEMENT OF LEVEL II WATER SUPPLY SYSTEM	DRAWN BY: <i>[Signature]</i> NOMER D. DIG REVIT ARCHT'L ASSISTANT	RECOMMENDED BY: <i>[Signature]</i> ROEL D. DUMIER, C.E./RMP CITY ENGINEER	APPROVED BY: <i>[Signature]</i> HON. MA. ESTER E. HAMOR CITY MAYOR	SHEET CONTENT: AS SHOWN	SHEET NO. 9 1
	LOCATION: CABARBUHAN, BACON DISTRICT, SORSOGON CITY				

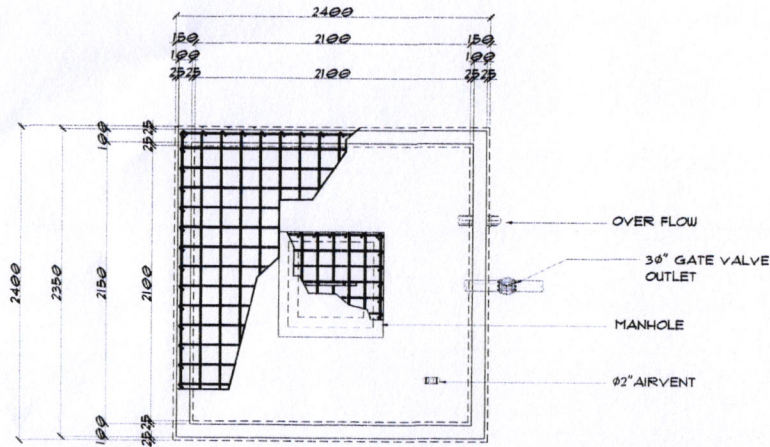


PLAN

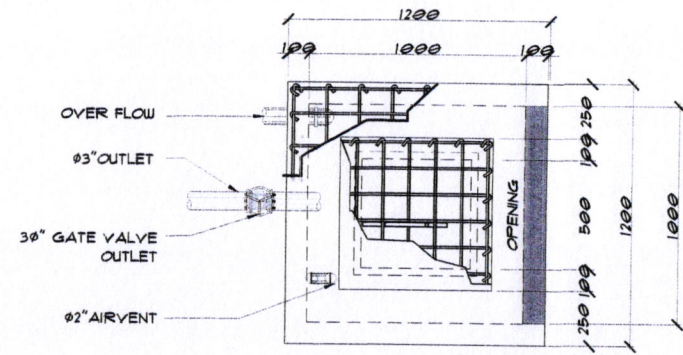

PLAN

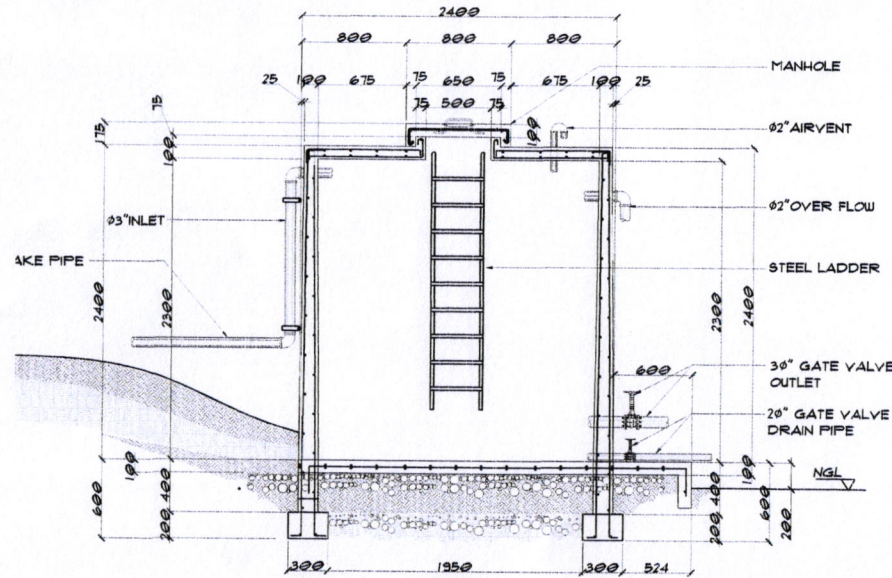

SECTION

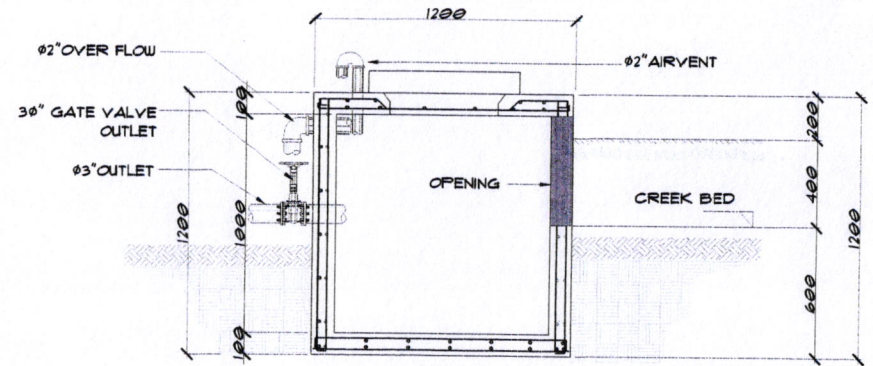

SECTION

1 TYP. WATER TANK DETAIL
S-02 SCALE 1:50 MTS

2 TYP. SPRING BOX DETAIL
S-02 SCALE 1:50 MTS



SORSOGON CITY
CITY ENGINEER'S OFFICE

PROJECT TITLE:
REHABILITATION/IMPROVEMENT OF LEVEL II
WATER SUPPLY SYSTEM

LOCATION: CABARBUHAN, BACON DISTRICT, SORSOGON CITY

DRAWN BY:

Nomer D. Dig
NOMER D. DIG
REVIT ARCHIT'L ASSISTANT

RECOMMENDED BY:

Roel D. Romer
ROEL D. ROMER, C.E./RMP
CITY ENGINEER

APPROVED BY:


Hon. Mayor Ester E. Hamor
HON. MAESTER E. HAMOR
CITY MAYOR

SHEET CONTENT:


AS SHOWN

SHEET NO.

5
2

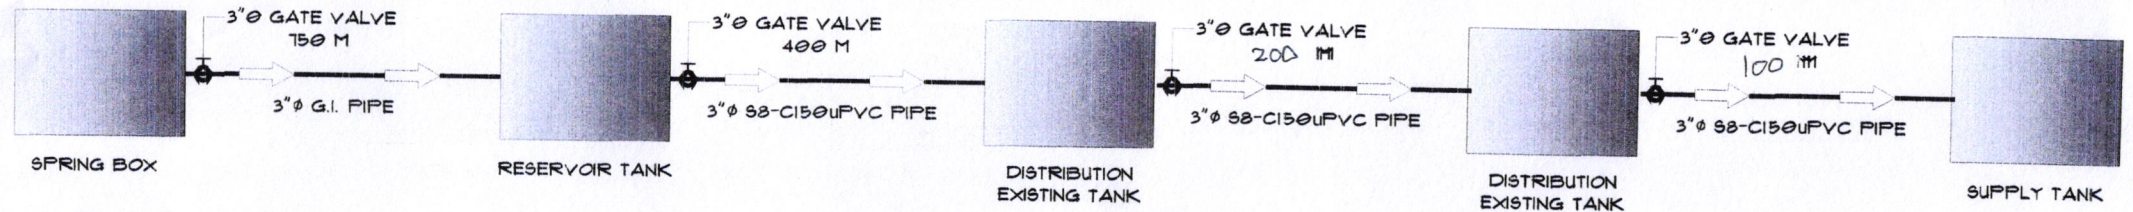

WATER SYSTEM DIAGRAM
(SITIO IRAYA)

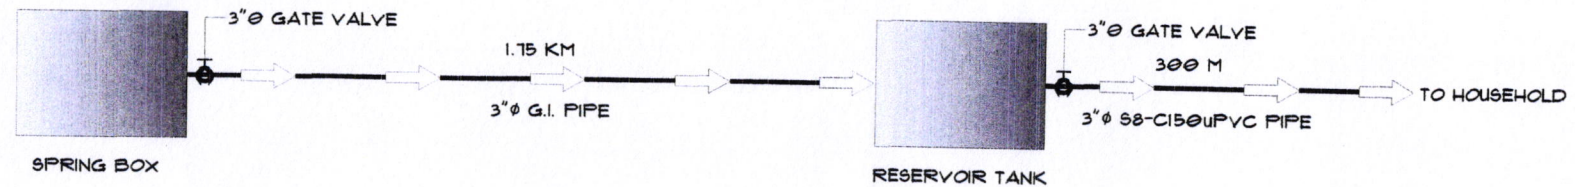

WATER SYSTEM DIAGRAM
(SITIO TABANUGAO)



SORSOGON CITY
CITY ENGINEER'S OFFICE

PROJECT TITLE:	DRAWN BY:	RECOMMENDED BY:	APPROVED BY:	SHEET CONTENT:	SHEET NO.
REHABILITATION/IMPROVEMENT OF LEVEL II WATER SUPPLY SYSTEM				AS SHOWN	9
LOCATION: CABARBUHAN, BACON DISTRICT, SORSOGON CITY	NOMER D. DIG REVIT ARCHIT'L ASSISTANT	ROEL D. DOMEZ, C.E./RMP CITY ENGINEER	HON. MA. ESTER EHAMOR CITY MAYOR		3