



FOUNDATION PLAN
SCALE: 1:65M.

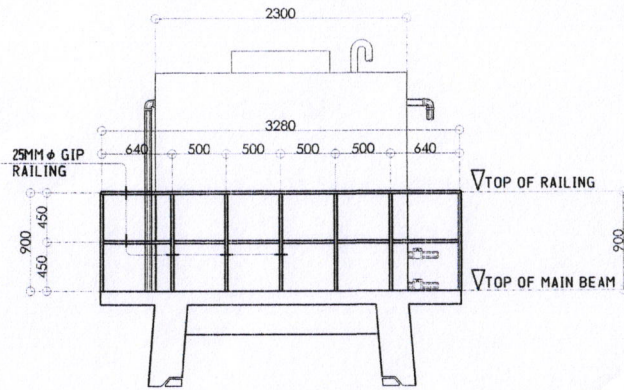


RC TANK RAILING DETAIL
SCALE: 1:50M.

8-16MM ϕ VERT. BARS.
W/ 10MM ϕ LAT. TIES
SPACED @ 50MM,
@ 100MM, @ 150MM AND
REST @ 300MM ON
CENTER.

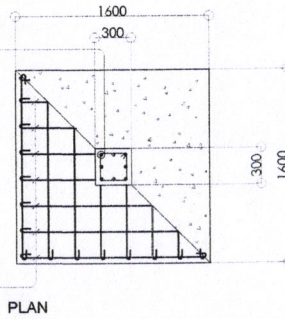


8-16MM ϕ BASE BARS
SPACED EQUALLY ON
CENTER BOTHWAYS.

8-16MM ϕ VERT. BARS.
W/ 10MM ϕ LAT. TIES
SPACED @ 50MM,
@ 100MM, @ 150MM AND
REST @ 300MM ON
CENTER.

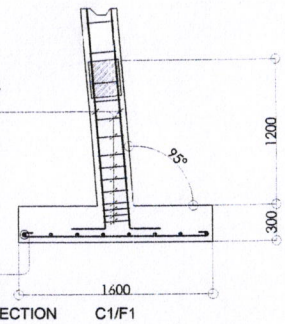

8-16MM ϕ BASE BARS
SPACED EQUALLY ON
CENTER BOTHWAYS.

COLUMN/FOOTING DETAIL
SCALE: 1:45M.

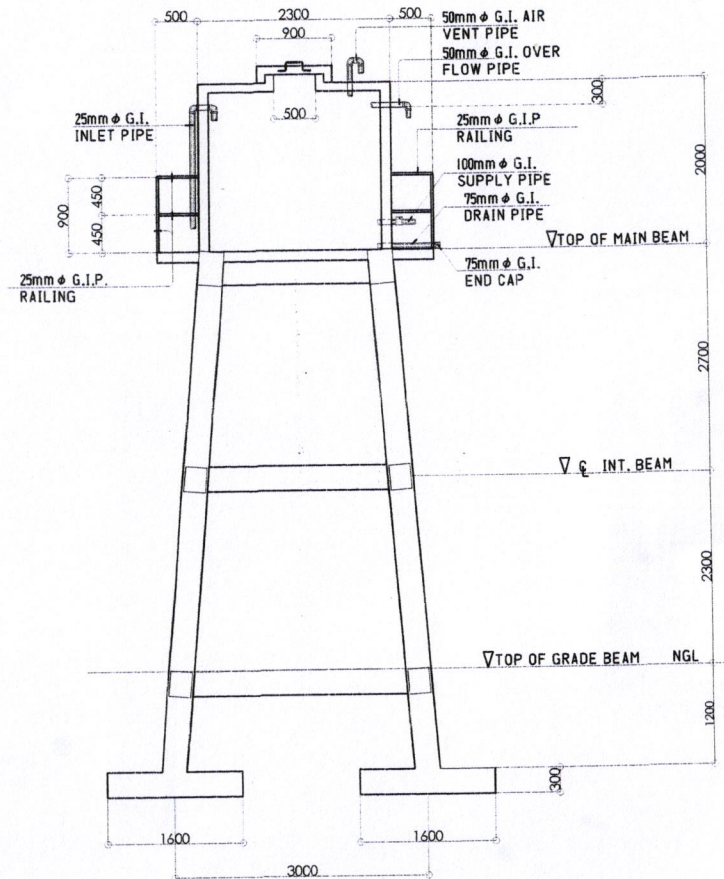

SECTIONAL ELEVATION
SCALE: 1:65M.

PREPARED FROM:

PROJECT TITLE:

CADD BY:

RECOMMENDED BY:

APPROVED BY:

SHEET NO.



**REHABILITATION/IMPROVEMENT OF LEVEL II
WATER SUPPLY SYSTEM**


LOCATION: BRGY. SAWANGA, BACON DISTRICT, SORSOGON CITY.

Rowan Marbella
ROWAN MARBELLA
DRAFTSMAN III


ROEL D. DOMER C.E./RMP
CITY ENGINEER

Hon. Mx. Ester E. Hamor
HON. MX. ESTER E. HAMOR
CITY MAYOR




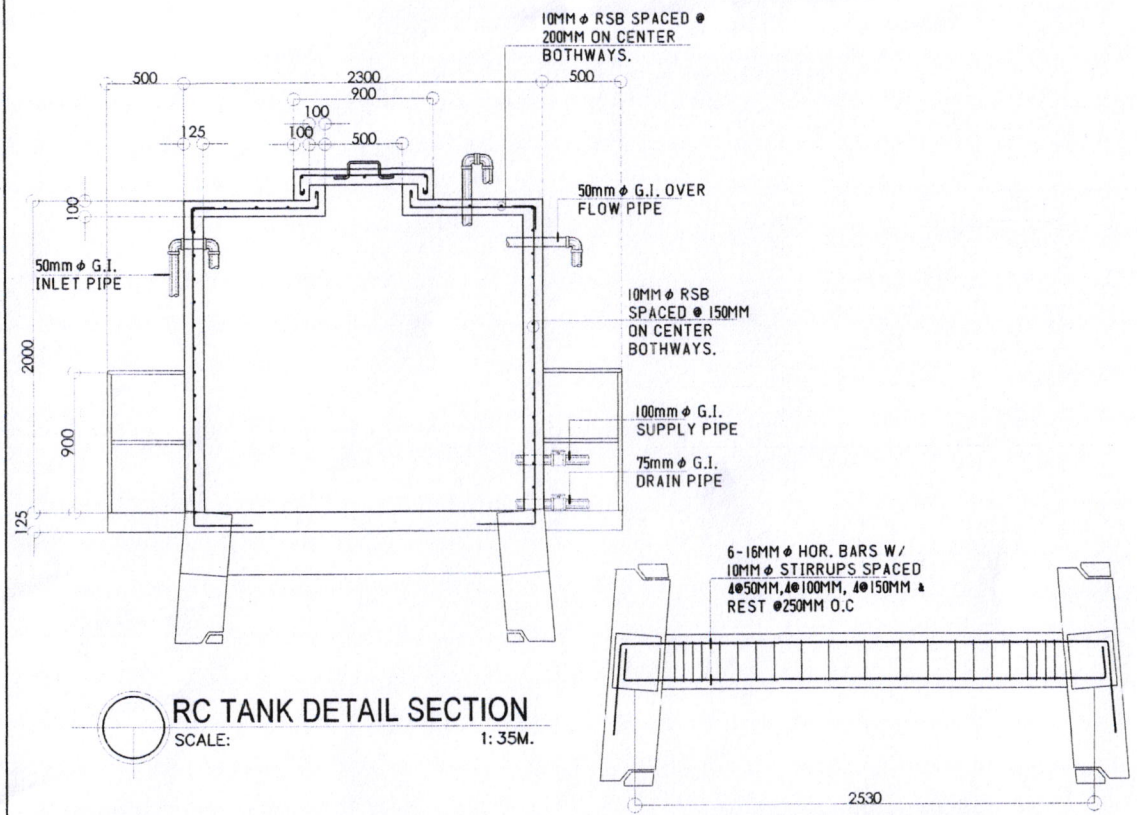


RC TANK DETAIL SECTION
SCALE: 1:35M.

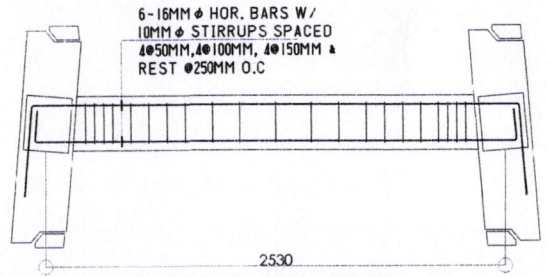


DETAIL OF INT. BEAM
SCALE: 1:30M.

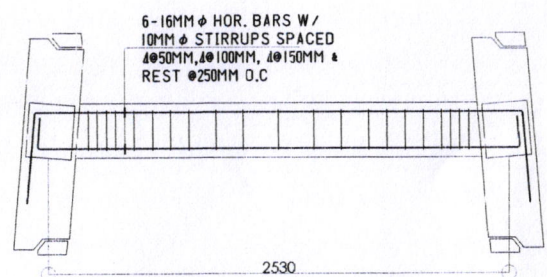


DETAIL OF INT. BEAM
SCALE: 1:30M.

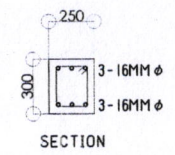


SECTION

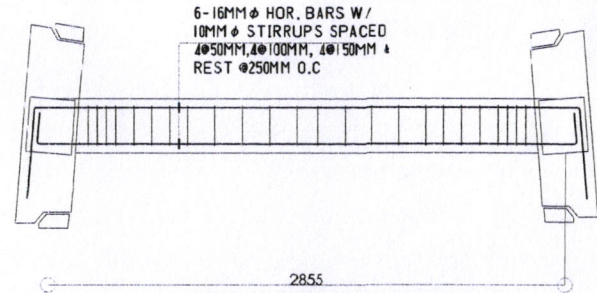

DETAIL OF GRADE BEAM
SCALE: 1:30M.

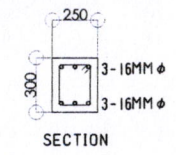

SECTION

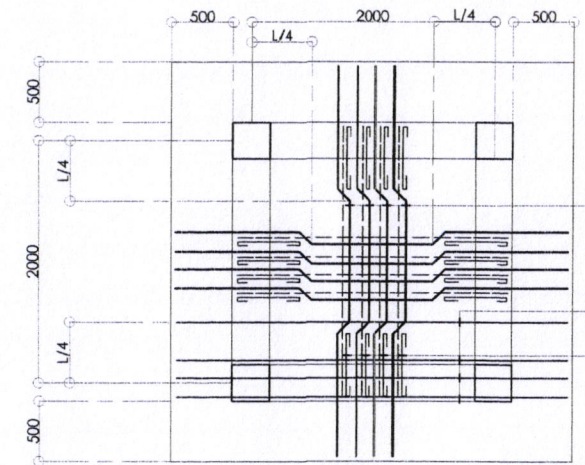


 



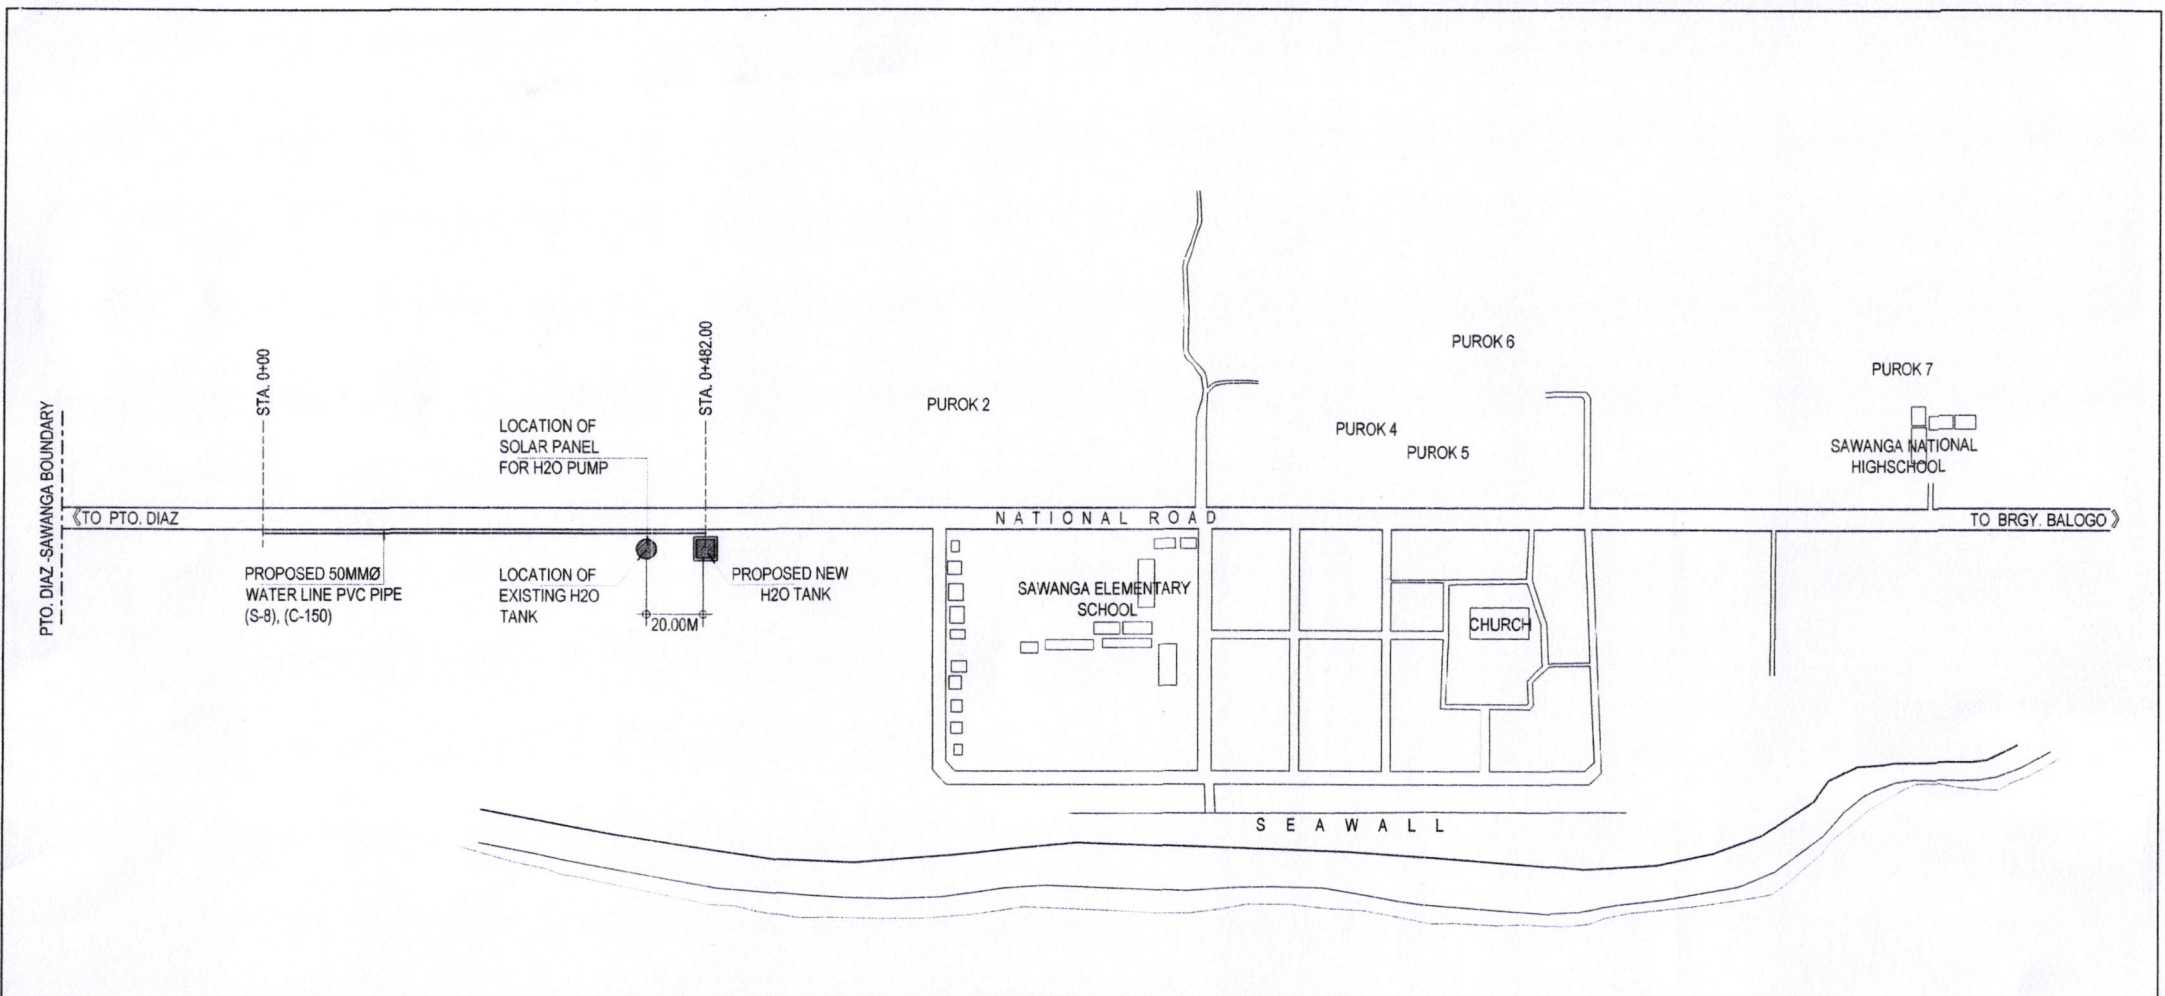
PLAN

12MM ϕ BENT UP BARS ALTERNATE W/ STRAIGHT SPACED @ 150MM ON CENTER.
10MM ϕ TEMP. BARS SPACED @ 150MM ON CENTER.
12MM ϕ CUT BARS SPACED @ 150MM ON CENTER.



SECTION




TWO-WAY SLAB DETAIL
SCALE: 1:45M.

PREPARED FROM:	PROJECT TITLE:	CADD BY:	RECOMMENDED BY:	APPROVED BY:	SHEET NO.
	REHABILITATION/IMPROVEMENT OF LEVEL II WATER SUPPLY SYSTEM LOCATION: BRGY. SAWANGA, BACON DISTRICT, SORSOGON CITY.	 ROWAN MARBELLA DRAFTSMAN III	 ROEL D. DIMER, C.E./RMP CITY ENGINEER	 HON. MA. ESTER E. HAMOR CITY MAYOR	








WATER DISTRIBUTION LINE LAY OUT
 SCALE: NTS.

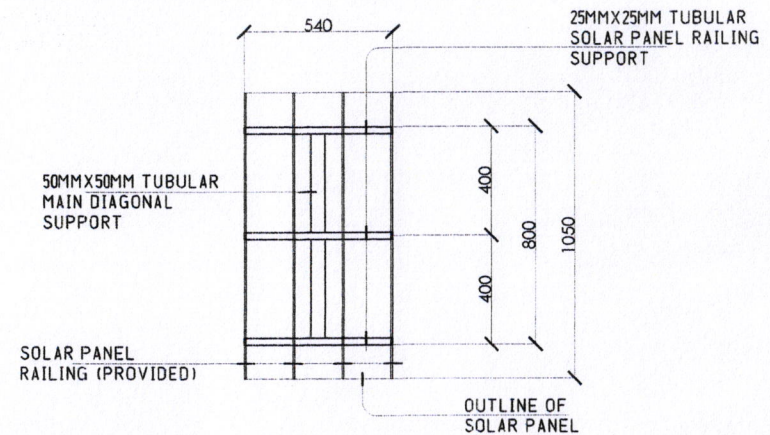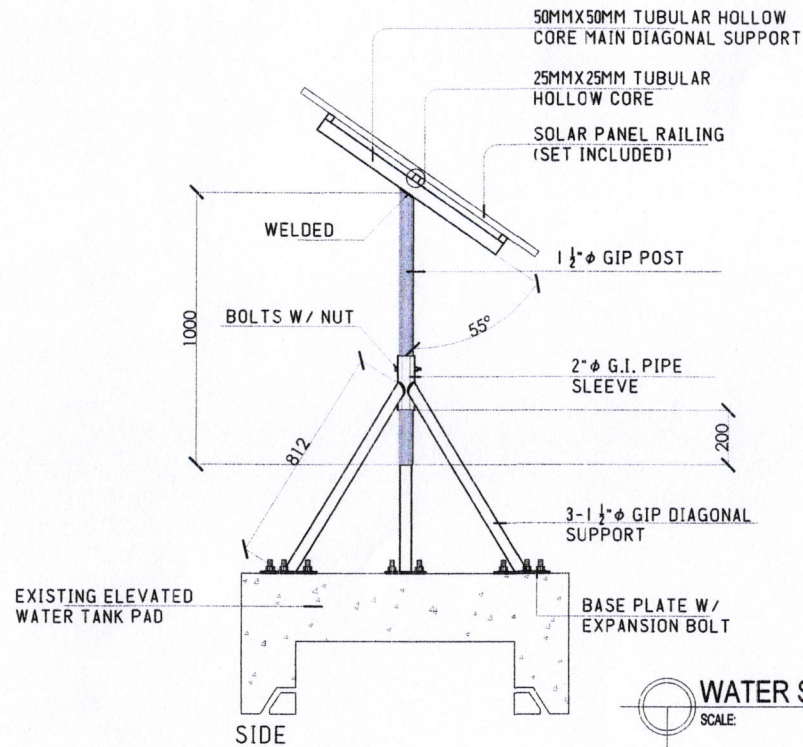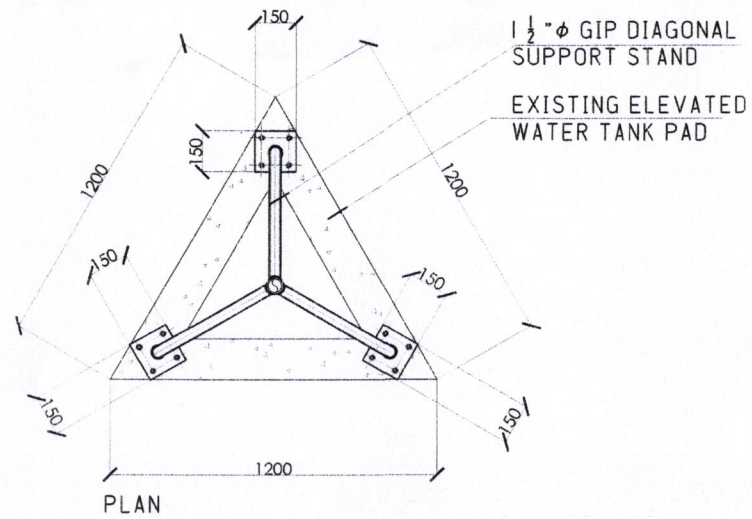
PREPARED FROM:	PROJECT TITLE:	CADD BY:	RECOMMENDED BY:	APPROVED BY:	SHEET NO.
 <p>SORSOGON CITY ENGINEER'S OFFICE</p>	<p>REHABILITATION/IMPROVEMENT OF LEVEL II WATER SUPPLY SYSTEM</p> <p>LOCATION: BRGY. SAWANGA, BACON DISTRICT, SORSOGON CITY.</p>	<p><i>Rowan Marbella</i> ROWAN MARBELLA DRAFTSMAN III</p>	<p><i>Roel D. Domer</i> ROEL D. DOMER C.E./RMP CITY ENGINEER</p>	<p><i>Hon. Ma. Ester E. Hamor</i> HON. MA. ESTER E. HAMOR CITY MAYOR</p>	



SOLAR PANEL FRAMING DETAIL

  WATER SYSTEM SOLAR PANEL MOUNTING STRUCTURE
SCALE: 1:20M.

PREPARED FROM:	PROJECT TITLE:	CADD BY:	RECOMMENDED BY:	APPROVED BY:	SHEET NO.
 SORSOGON CITY ENGINEER'S OFFICE	REHABILITATION/IMPROVEMENT OF LEVEL II WATER SUPPLY SYSTEM LOCATION: BRGY. SAWANGA, BACON DISTRICT, SORSOGON CITY.	 ROWAN HARBELLA DRAFTSMAN III	 ROEL D. DOMER, C.E./RMP CITY ENGINEER	 HON. MA. ESTER E. HAMOR CITY MAYOR	

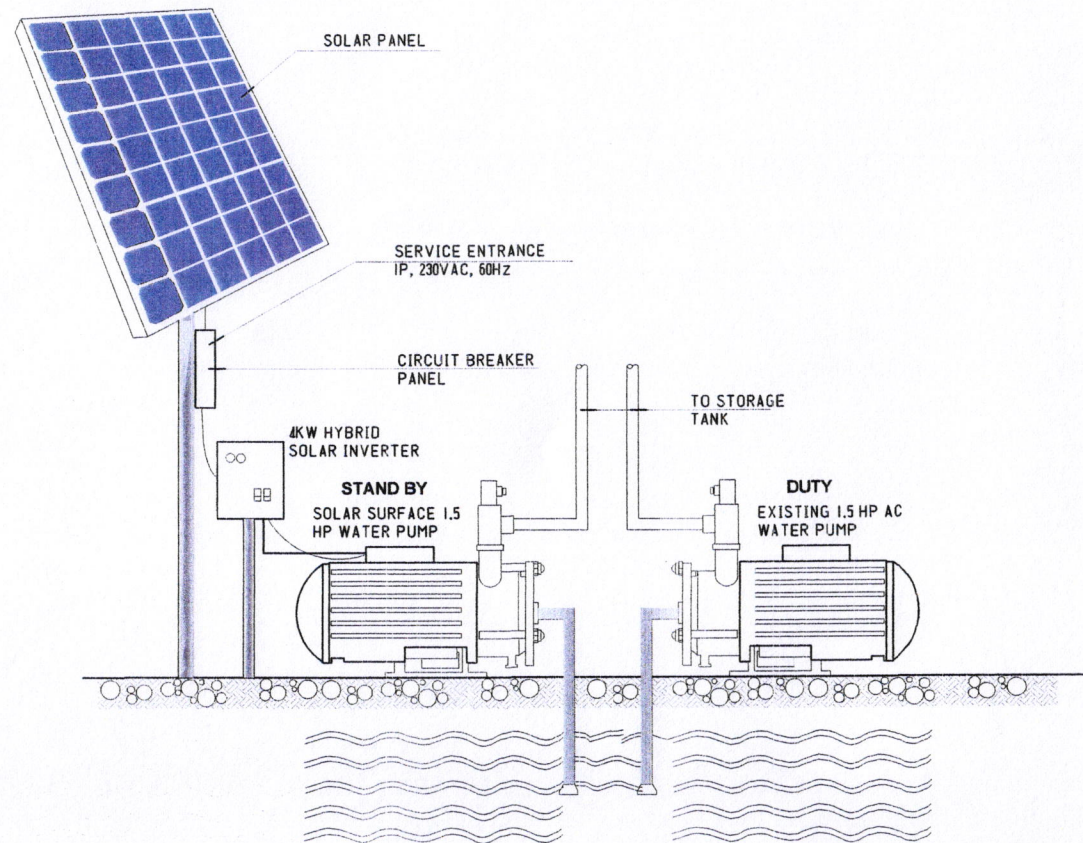

SOLAR PANEL - WATER PUMP DIAGRAM
 SCALE: _____ NTS.

PREPARED FROM:	PROJECT TITLE:	CADD BY:	RECOMMENDED BY:	APPROVED BY:	SHEET NO.
	REHABILITATION/IMPROVEMENT OF LEVEL II WATER SUPPLY SYSTEM	 ROWAN MARBELLA DRAFTSMAN III	 ROEL D. DIMER C.E./RMP CITY ENGINEER	 HON. MA. ESTER E. HAMOR CITY MAYOR	
LOCATION: BRGY. SAWANGA, BACON DISTRICT, SORSOGON CITY.					