



2 STOREY  
MULTI-PURPOSE  
BUILDING


PROPOSED BRGY.  
HEALTH CENTER


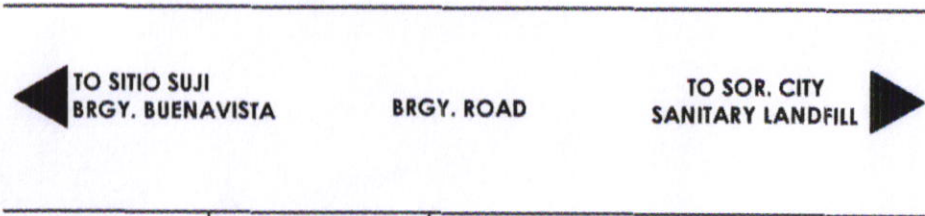



LOCATION MAP  
AD-00 SCALE N.T.S.

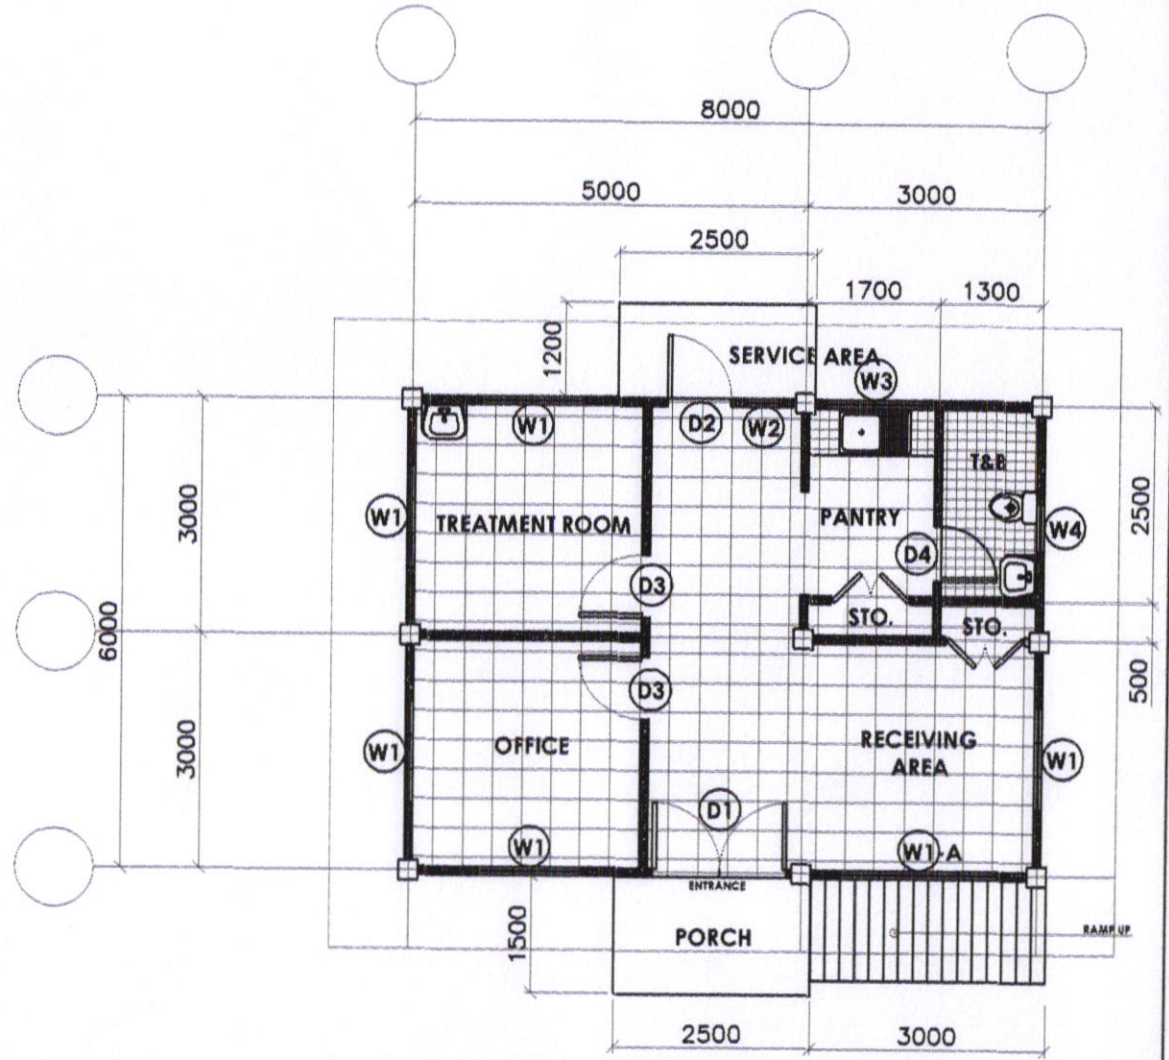


FLOOR PLAN  
AD-00 SCALE N.T.S.

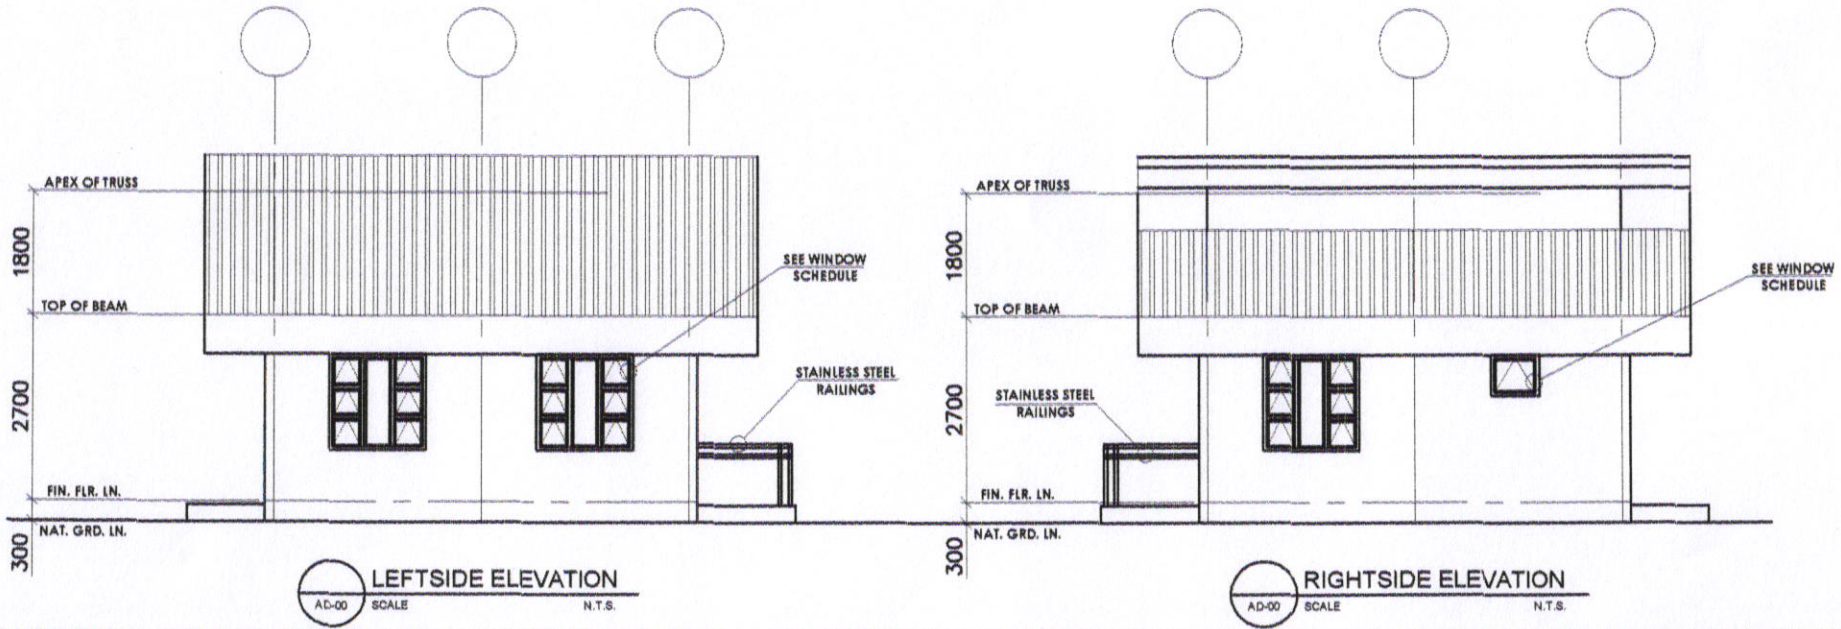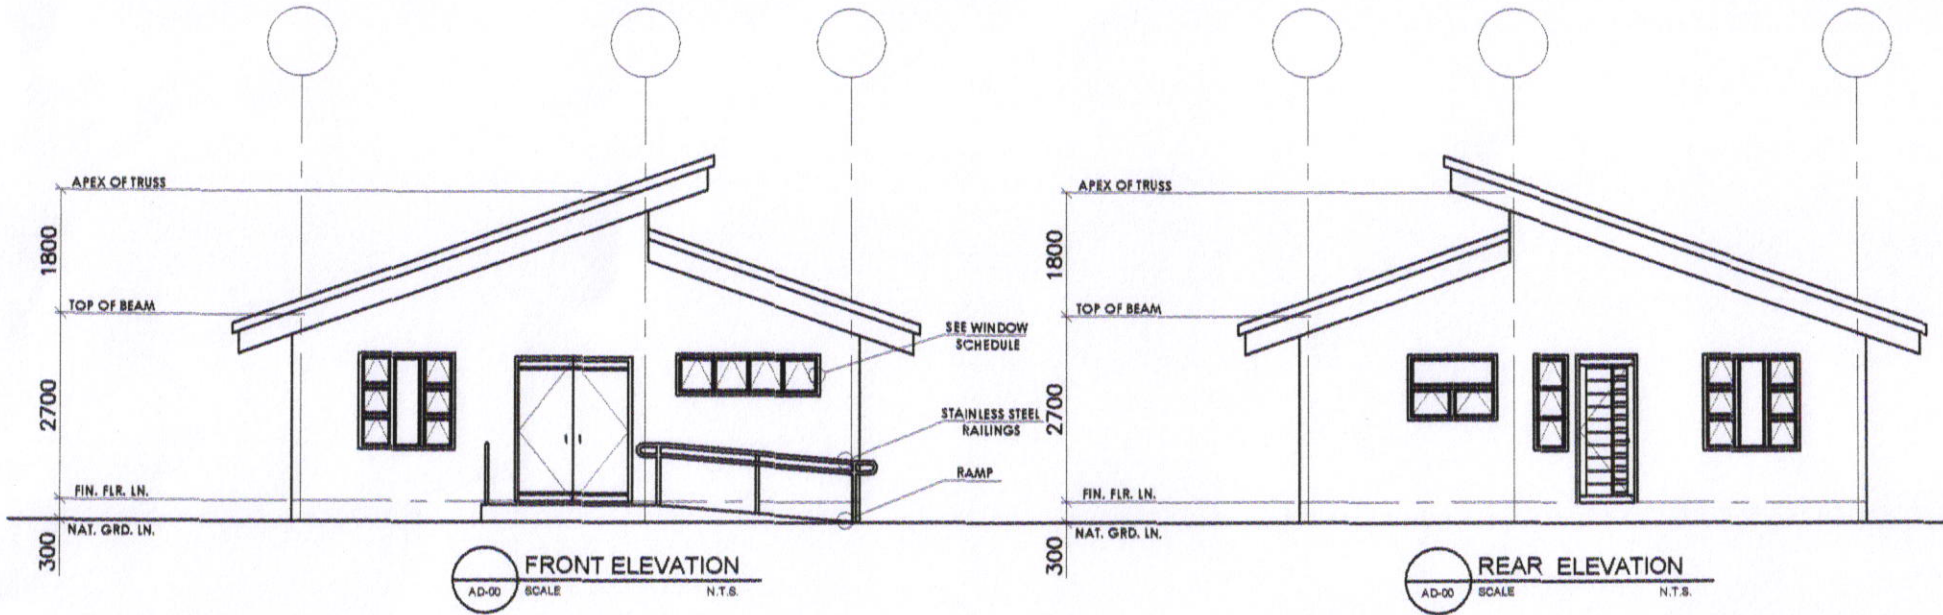


 <p>SORSOGON CITY <b>CITY ENGINEER'S OFFICE</b></p>	PROJECT TITLE:	DRAWN BY:	RECOMMENDING APPROVAL	APPROVED BY:	SHEET CONTENT:	SHEET NO.
	CONSTRUCTION OF BRGY. HEALTH CENTER				A S - S H O W N	
	LOCATION : BRGY. BUENAVISTA WEST DIST. SORSOGON CITY	MINDEE MAE A. GONZALGO ARCHITECTURAL ASST.	ROEL D. DOMER, C.E./RMP CITY ENGINEER	HON. MA. ESTER E. HAMOR CITY MAYOR		




 <p>SORSOGON CITY CITY ENGINEER'S OFFICE</p>	PROJECT TITLE:	DRAWN BY:	RECOMMENDING APPROVAL	APPROVED BY:	SHEET CONTENT:	SHEET NO.
	CONSTRUCTION OF BRGY. HEALTH CENTER				A S - S H O W N	
	LOCATION : BRGY. BUENAVISTA WEST DIST. SORSOGON CITY	MINDEE MAE A. GONZALGO ARCHITECTURAL ASST.	ROEL D. COMER, C.E./RMP CITY ENGINEER	HON. MA. ESTER E. HAMOR CITY MAYOR		


D1	D2	D3	D4	
DOUBLE SWING GLASS DOOR ON STANDARD POWDER COATED ALUMINUM FRAME	SINGLE SWING TYPE WOOD PANEL DOOR	SINGLE SWING TYPE WOOD HOLLOW CORE LITE FLUSH DOOR	SINGLE SWING TYPE MARINE PLY. HOLLOW CORE FLUSH DOOR	
1 SET	1 SET	2 SET	1 SET	
ENTRANCE	SERVICE AREA	TREATMENT ROOM/ OFFICE	T&B	
W1	W1-A	W2	W3	W4
POWDER COATED ALUMINUM AWNING TYPE WINDOW	POWDER COATED ALUMINUM AWNING TYPE HIGH WINDOW	POWDER COATED ALUMINUM AWNING TYPE WINDOW	POWDER COATED ALUMINUM AWNING TYPE WINDOW	POWDER COATED ALUMINUM AWNING TYPE WINDOW
5 SETS	1 SET	1 SET	1 SET	1 SET


**DOORS & WINDOW SCHEDULE**  
 SCALE N.T.S.


 <p style="text-align: center;"> <b>SORSOGON CITY</b>  <b>CITY ENGINEER'S</b>  <b>OFFICE</b> </p>	PROJECT TITLE:	DRAWN BY:	RECOMMENDING APPROVAL	APPROVED BY:	SHEET CONTENT:	SHEET NO.
	CONSTRUCTION OF BRGY. HEALTH CENTER					<b>A S - S H O W N</b>
	LOCATION : BRGY. BUENAVISTA WEST DIST. SORSOGON CITY	MINDEE MAE A. GONZALGO ARCHITECTURAL ASST.	ROEL D. BOMER, C.E./RMP CITY ENGINEER	HON. MA. ESTER E. HAMOR CITY MAYOR		

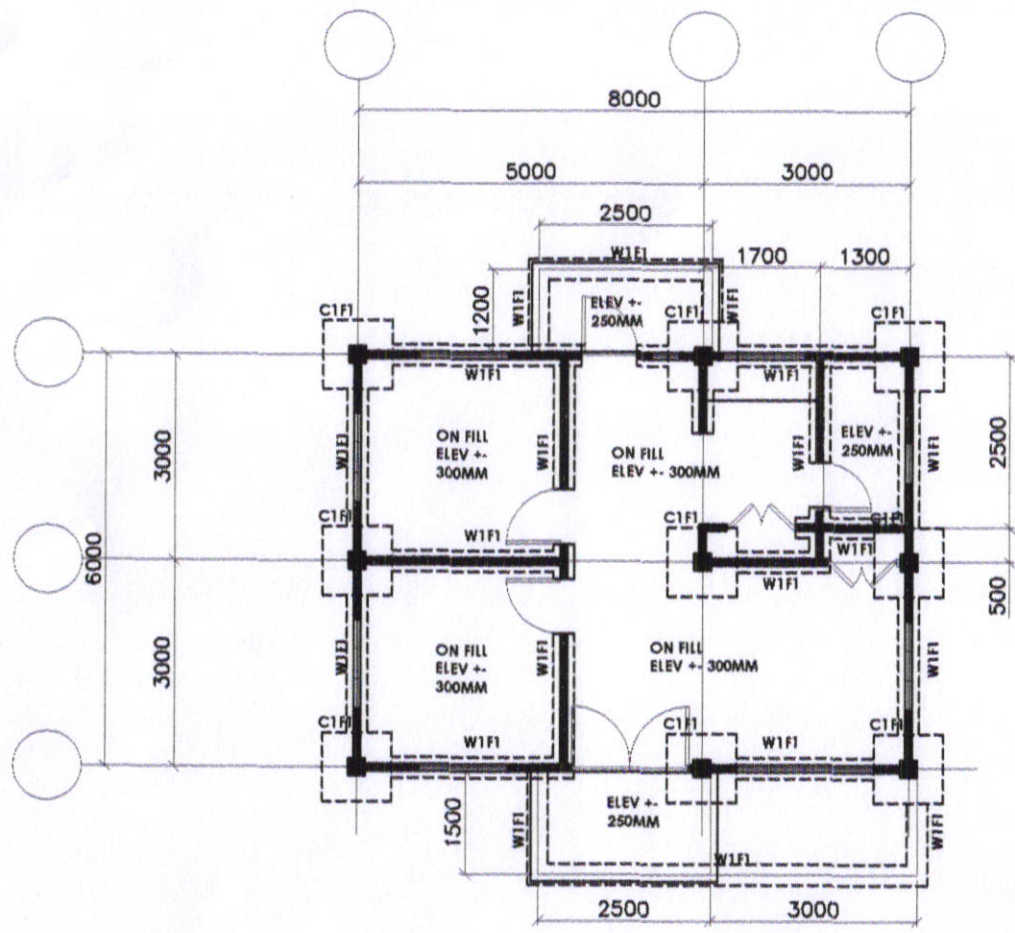


FOUNDATION PLAN  
AD-00 SCALE N.T.S.


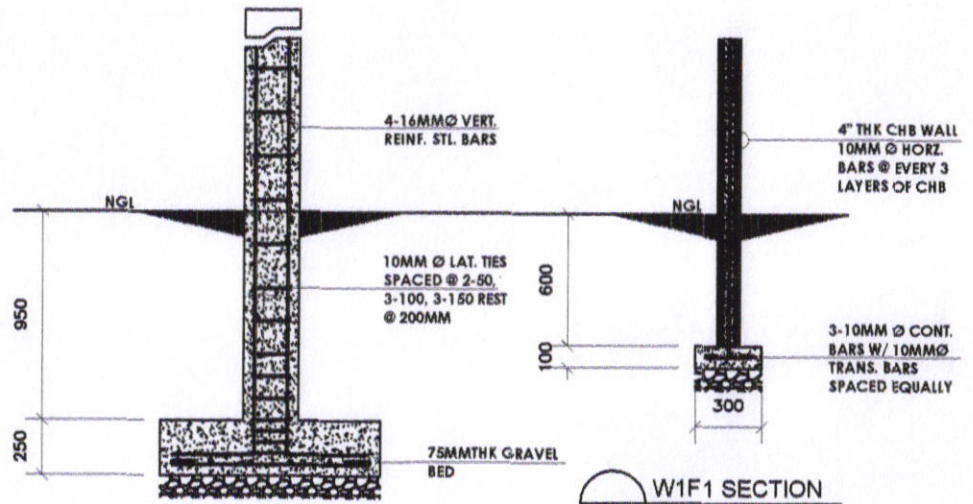


W1F1 SECTION  
AD-00 SCALE N.T.S.

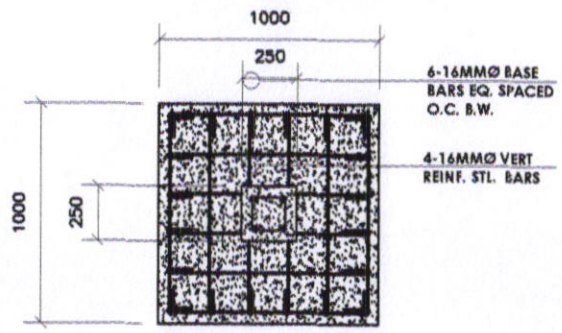


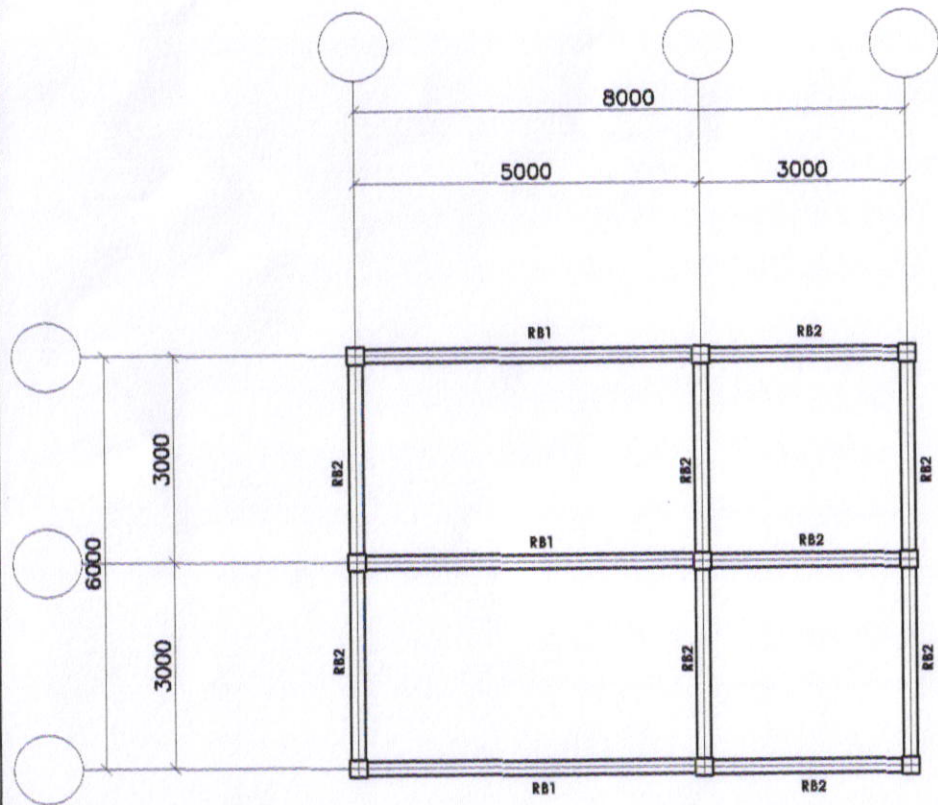
C1F1 PLAN & SECTION  
AD-00 SCALE N.T.S.

 <p>SORSOGON CITY <b>CITY ENGINEER'S OFFICE</b></p>	PROJECT TITLE:	DRAWN BY:	RECOMMENDING APPROVAL	APPROVED BY:	SHEET CONTENT:	SHEET NO.
	CONSTRUCTION OF BRGY. HEALTH CENTER				AS - SHOWN	
	LOCATION : BRGY. BUENAVISTA WEST DIST. SORSOGON CITY	MINDEE MAE A. GONZALGO ARCHITECTURAL ASST.	ROEL D. BOMER, C.E./RMP CITY ENGINEER	HON. MA. ESTER E. HAMOR CITY MAYOR		

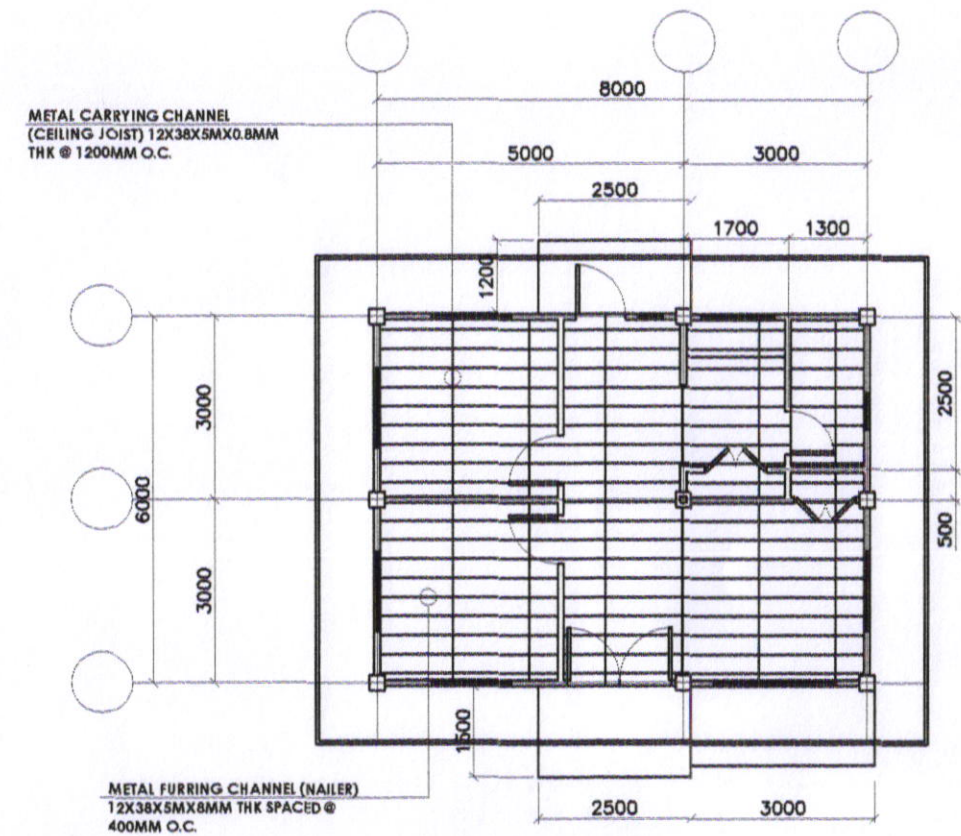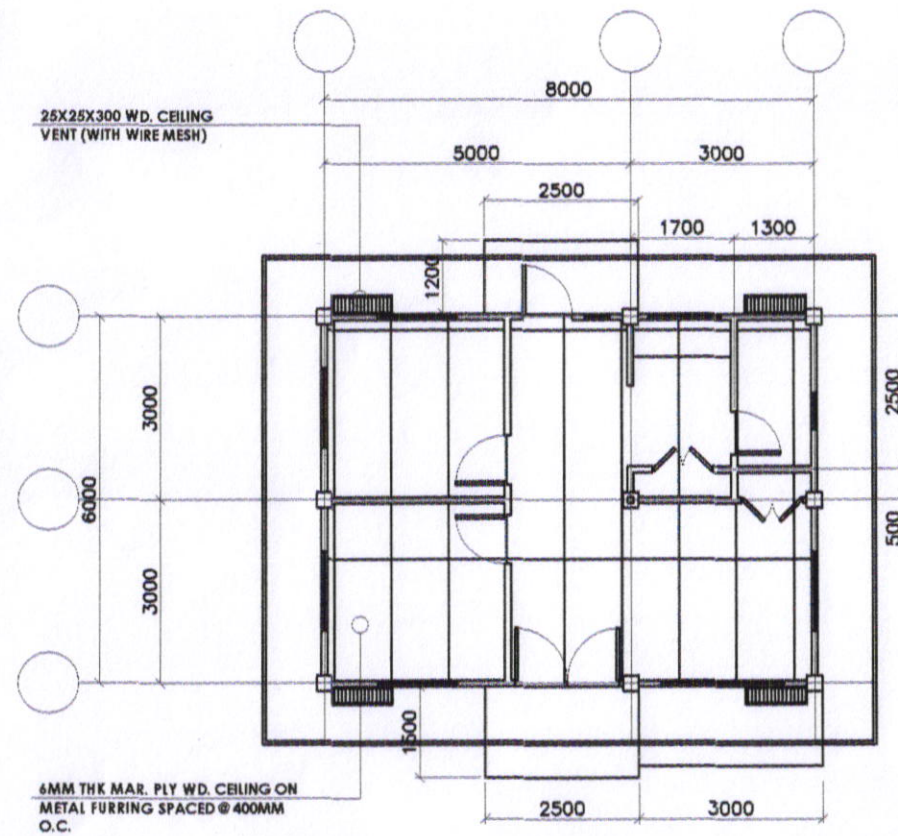


REFLECTED CEILING PLAN  
 AD-00 SCALE N.T.S.


 <p>SORSOGON CITY  <b>CITY ENGINEER'S OFFICE</b></p>	PROJECT TITLE:	DRAWN BY:	RECOMMENDING APPROVAL	APPROVED BY:	SHEET CONTENT:	SHEET NO.
	CONSTRUCTION OF BRGY. HEALTH CENTER				AS - SHOWN	
	LOCATION : BRGY. BUENAVISTA WEST DIST. SORSOGON CITY	MINDEE MAE A. GONZALGO ARCHITECTURAL ASST.	ROEL D. DOMER, C.E./RMP CITY ENGINEER	HON. MA. ESTER E. HAMOR CITY MAYOR		




3 DETAILED SECTION  
AD-04 SCALE N.T.S.

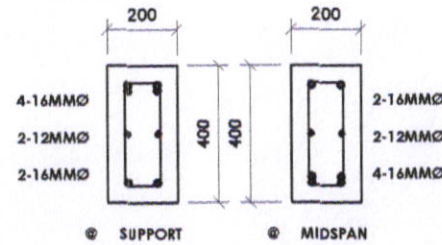


RB1 PLAN  
AD-00 SCALE N.T.S.

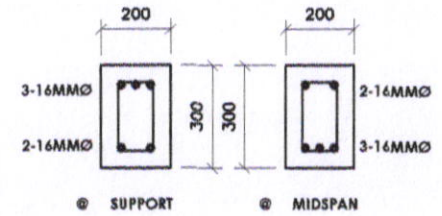


RB2 PLAN  
AD-00 SCALE N.T.S.

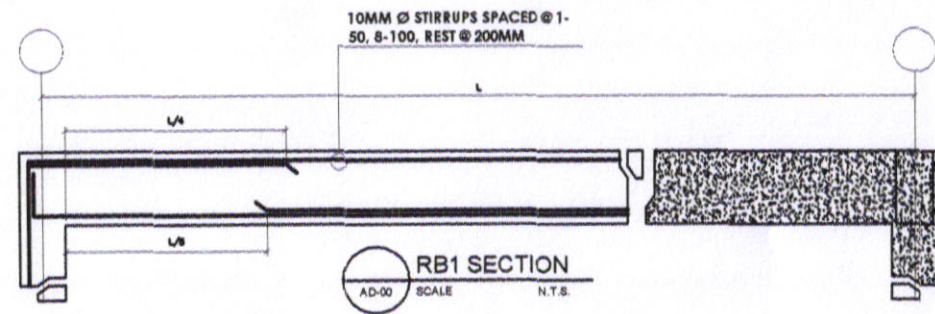


RB1 SECTION  
AD-00 SCALE N.T.S.

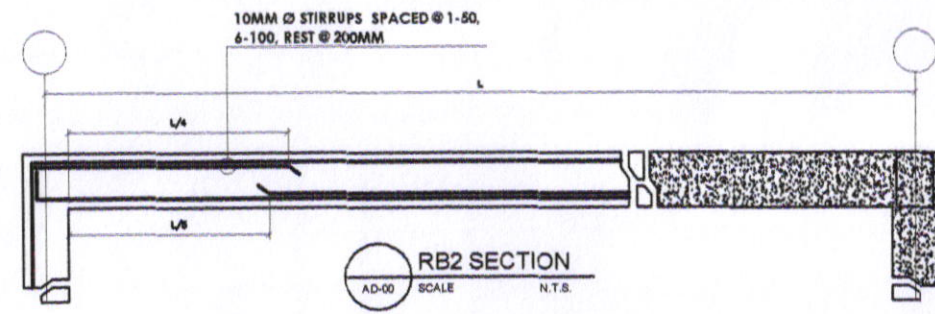


RB2 SECTION  
AD-00 SCALE N.T.S.

 <p>SORSOGON CITY CITY ENGINEER'S OFFICE</p>	PROJECT TITLE:	DRAWN BY:	RECOMMENDING APPROVAL	APPROVED BY:	SHEET CONTENT:	SHEET NO.
	CONSTRUCTION OF BRGY. HEALTH CENTER				A S - S H O W N	
	LOCATION: BRGY. BUENAVISTA WEST DIST. SORSOGON CITY	MINDEE MAE A. GONZALGO ARCHITECTURAL ASST.	ROEL D. BOMER, C.E./RMP CITY ENGINEER	HON. MA. ESTER E. HAMOR CITY MAYOR		

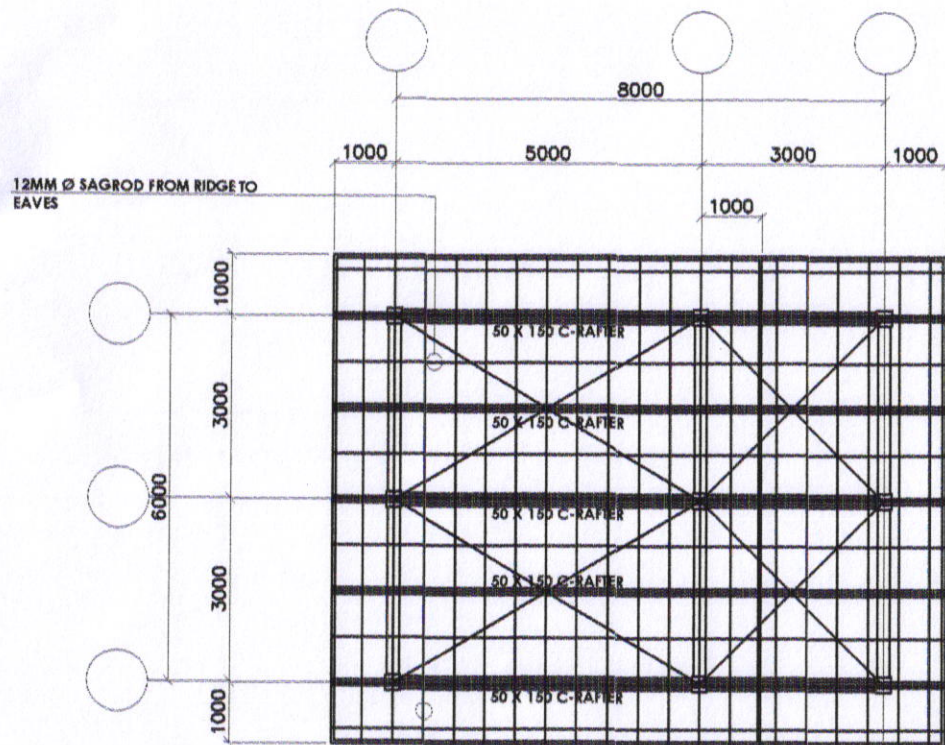


(2"x3") 50X75MM C-PURLINS SPACED @ 500MM O.C. W/ 5MM X 25 X 25 X 100MM BOLSTER


**ROOF FRAMING PLAN**  
AD-00 SCALE N.T.S.

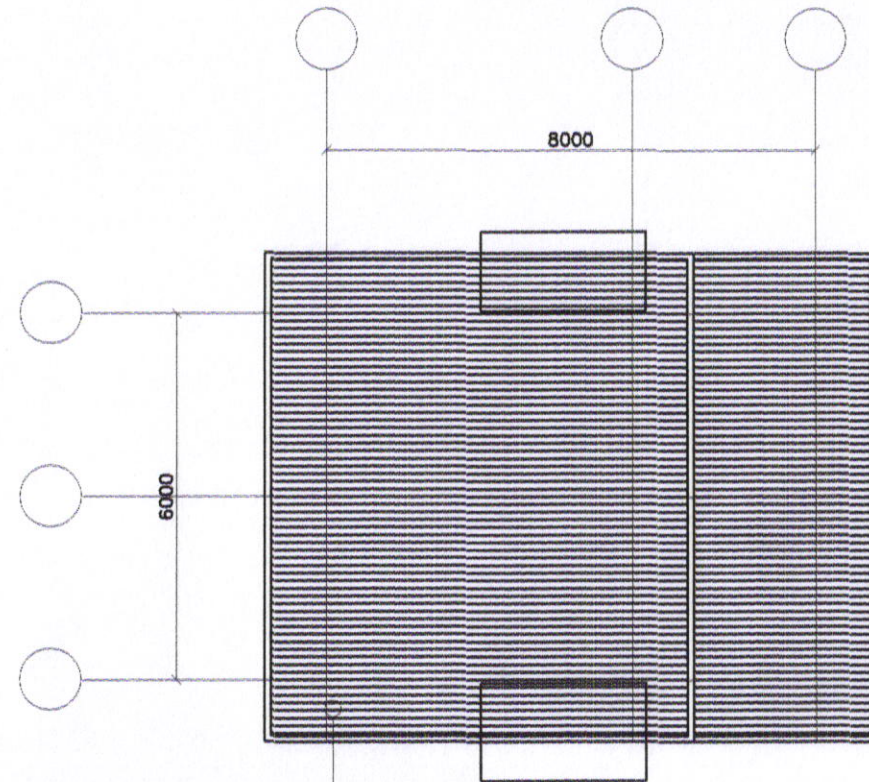


PRE-PAINTED LONG SPAN RIB TYPW ROOFING SHEET

**ROOF PLAN**  
AD-00 SCALE N.T.S.

 <p>SORSOGON CITY <b>CITY ENGINEER'S OFFICE</b></p>	PROJECT TITLE:	DRAWN BY:	RECOMMENDING APPROVAL	APPROVED BY:	SHEET CONTENT:	SHEET NO.
	CONSTRUCTION OF BRGY. HEALTH CENTER				A S - S H O W N	
	LOCATION : BRGY. BUENAVISTA WEST DIST. SORSOGON CITY	MINDEE MAE A. GONZALGO ARCHITECTURAL ASST.	ROEL D. DOMER, C.E./RMP CITY ENGINEER	HON. MA. ESTER E. HAMOR CITY MAYOR		

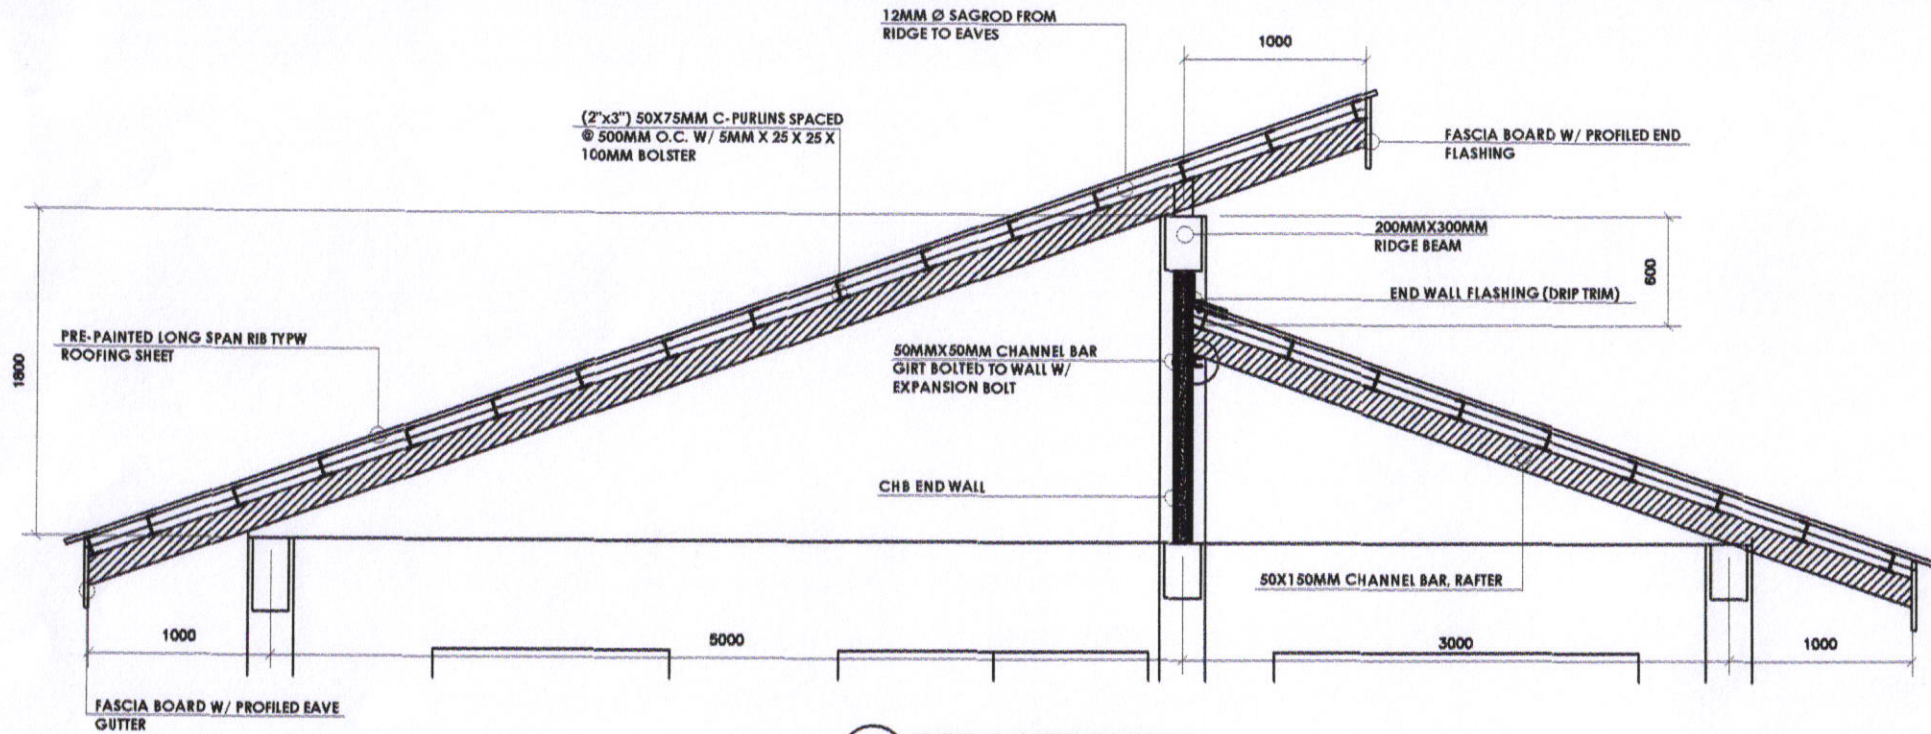


TYPICAL RAFTER DESIGN  
 AD-00 SCALE N.T.S.

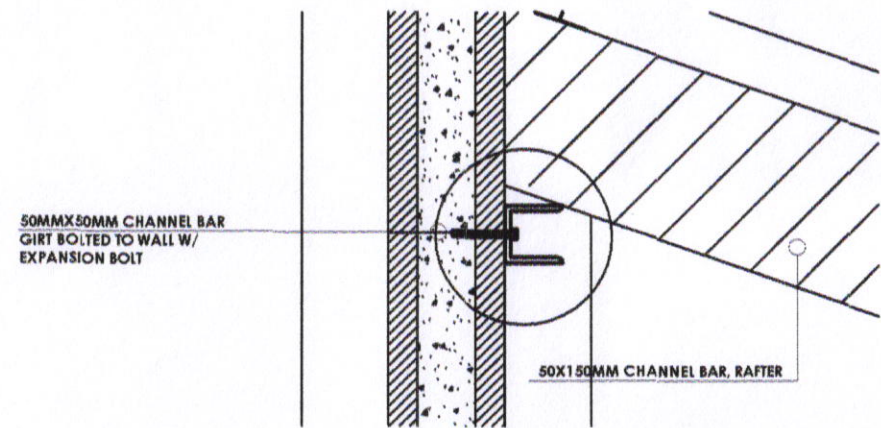


SORSOGON CITY  
**CITY ENGINEER'S  
 OFFICE**

PROJECT TITLE:	DRAWN BY:	RECOMMENDING APPROVAL	APPROVED BY:	SHEET CONTENT:	SHEET NO.
CONSTRUCTION OF BRGY. HEALTH CENTER				A S - S H O W N	
LOCATION: BRGY. BUENAVISTA WEST DIST. SORSOGON CITY	MINDEE MAE A. GONZALGO ARCHITECTURAL ASST.	ROEL D. DOMER, C.E./RMP CITY ENGINEER	HON. MA. ESTER E. HAMOR CITY MAYOR		



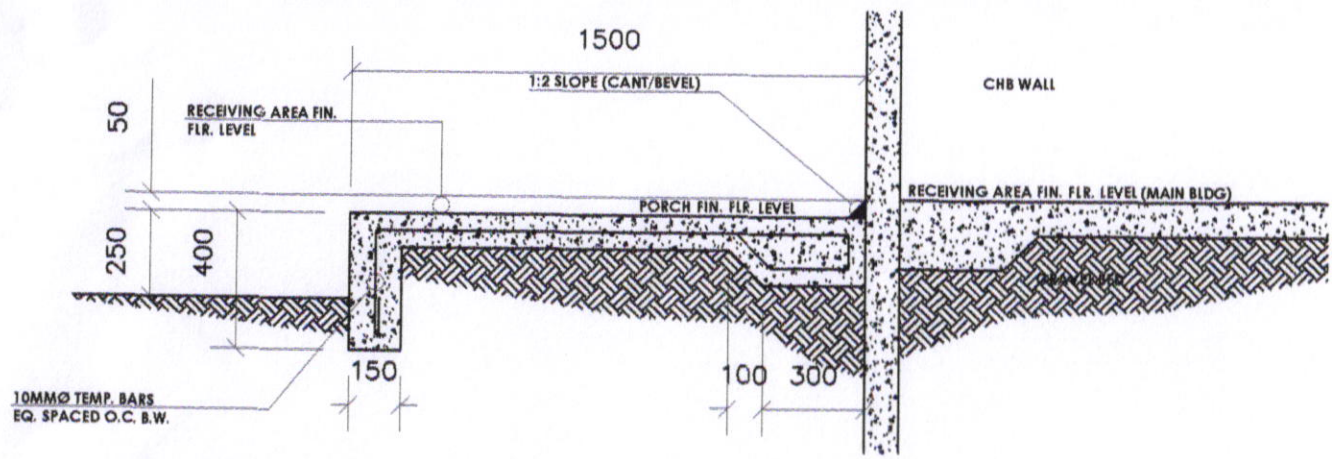

DET. SECTION OF PORCH  
AD-00 SCALE N.T.S.

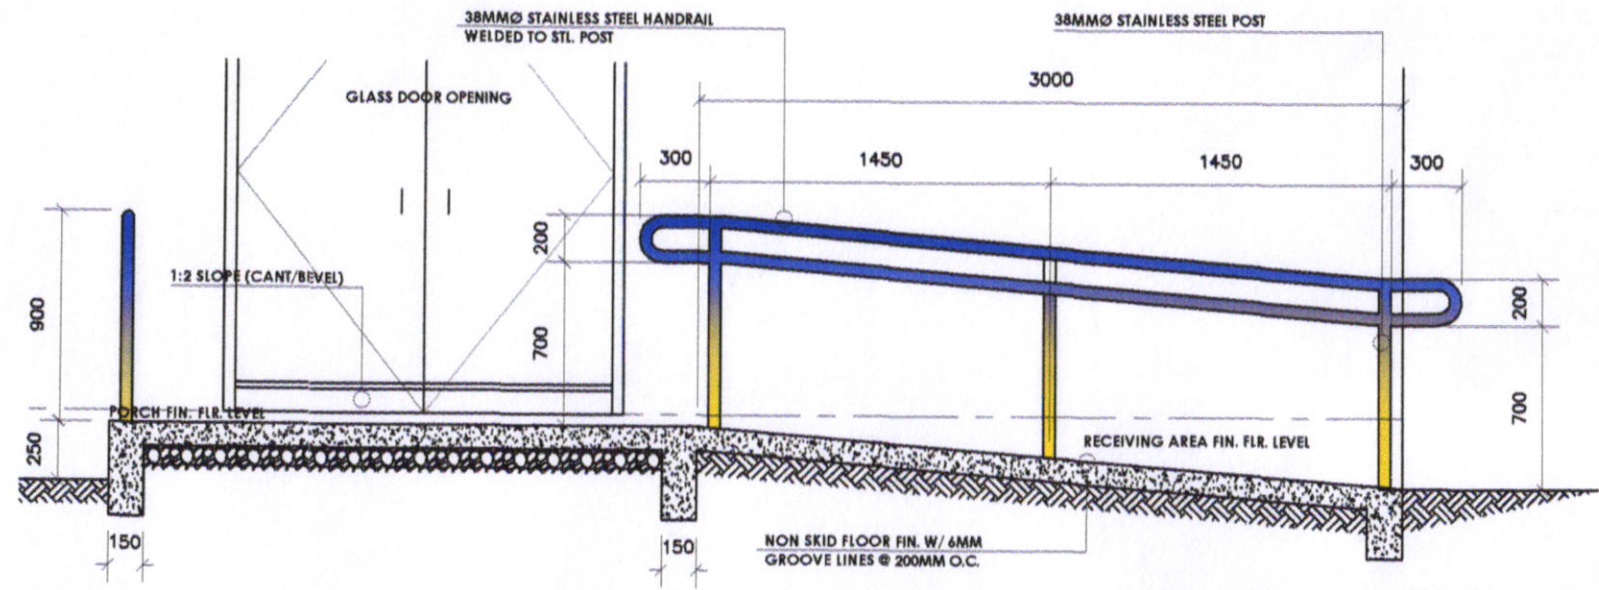



DET. SECTION OF RAMP & PORCH  
AD-00 SCALE N.T.S.





SORSOGON CITY  
CITY ENGINEER'S  
OFFICE


PROJECT TITLE:	DRAWN BY:	RECOMMENDING APPROVAL	APPROVED BY:	SHEET CONTENT:	SHEET NO.
CONSTRUCTION OF BRGY. HEALTH CENTER				A S - S H O W N	
LOCATION : BRGY. BUENAVISTA WEST DIST. SORSOGON CITY	MINDEE MAE A. GONZALGO ARCHITECTURAL ASST.	ROEL D. DOMER, C.E./RMP CITY ENGINEER	HON. MA. ESTER E. HAMOR CITY MAYOR		

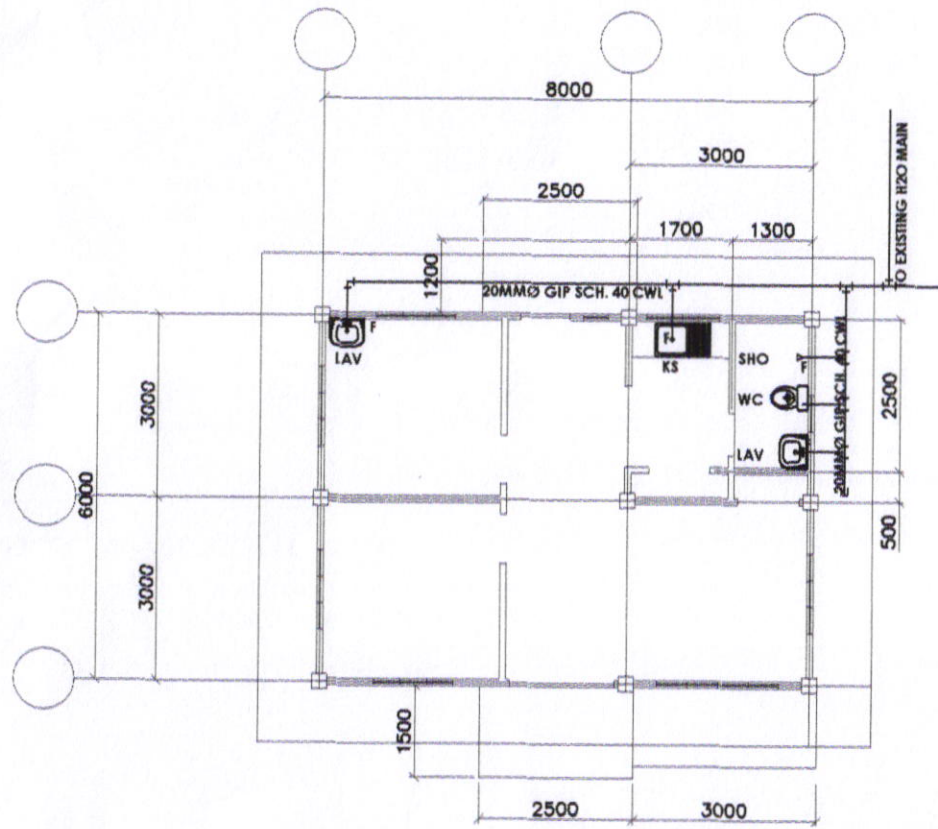


  
**WATERLINE LAYOUT**  
 AD-00 SCALE N.T.S.

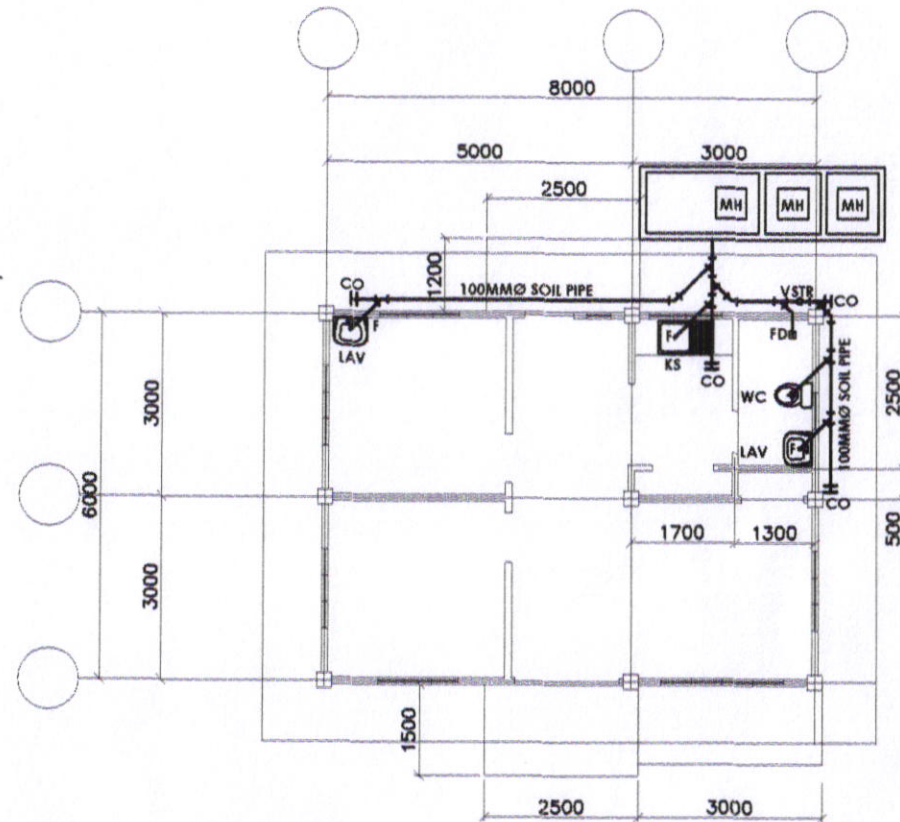



**SEWAGE LINE LAYOUT**  
 AD-00 SCALE N.T.S.


 <p> <b>SORSOGON CITY</b>  <b>CITY ENGINEER'S</b>  <b>OFFICE</b> </p>	PROJECT TITLE:	DRAWN BY:	RECOMMENDING APPROVAL	APPROVED BY:	SHEET CONTENT:	SHEET NO.
	CONSTRUCTION OF BRGY. HEALTH CENTER				<b>A S - S H O W N</b>	
	LOCATION : BRGY. BUENAVISTA WEST DIST. SORSOGON CITY	MINDEE MAE A. GONZALGO ARCHITECTURAL ASST.	ROEL D. DOMER, C.E./RMP CITY ENGINEER	HON. MA. ESTER E. HAMOR CITY MAYOR		

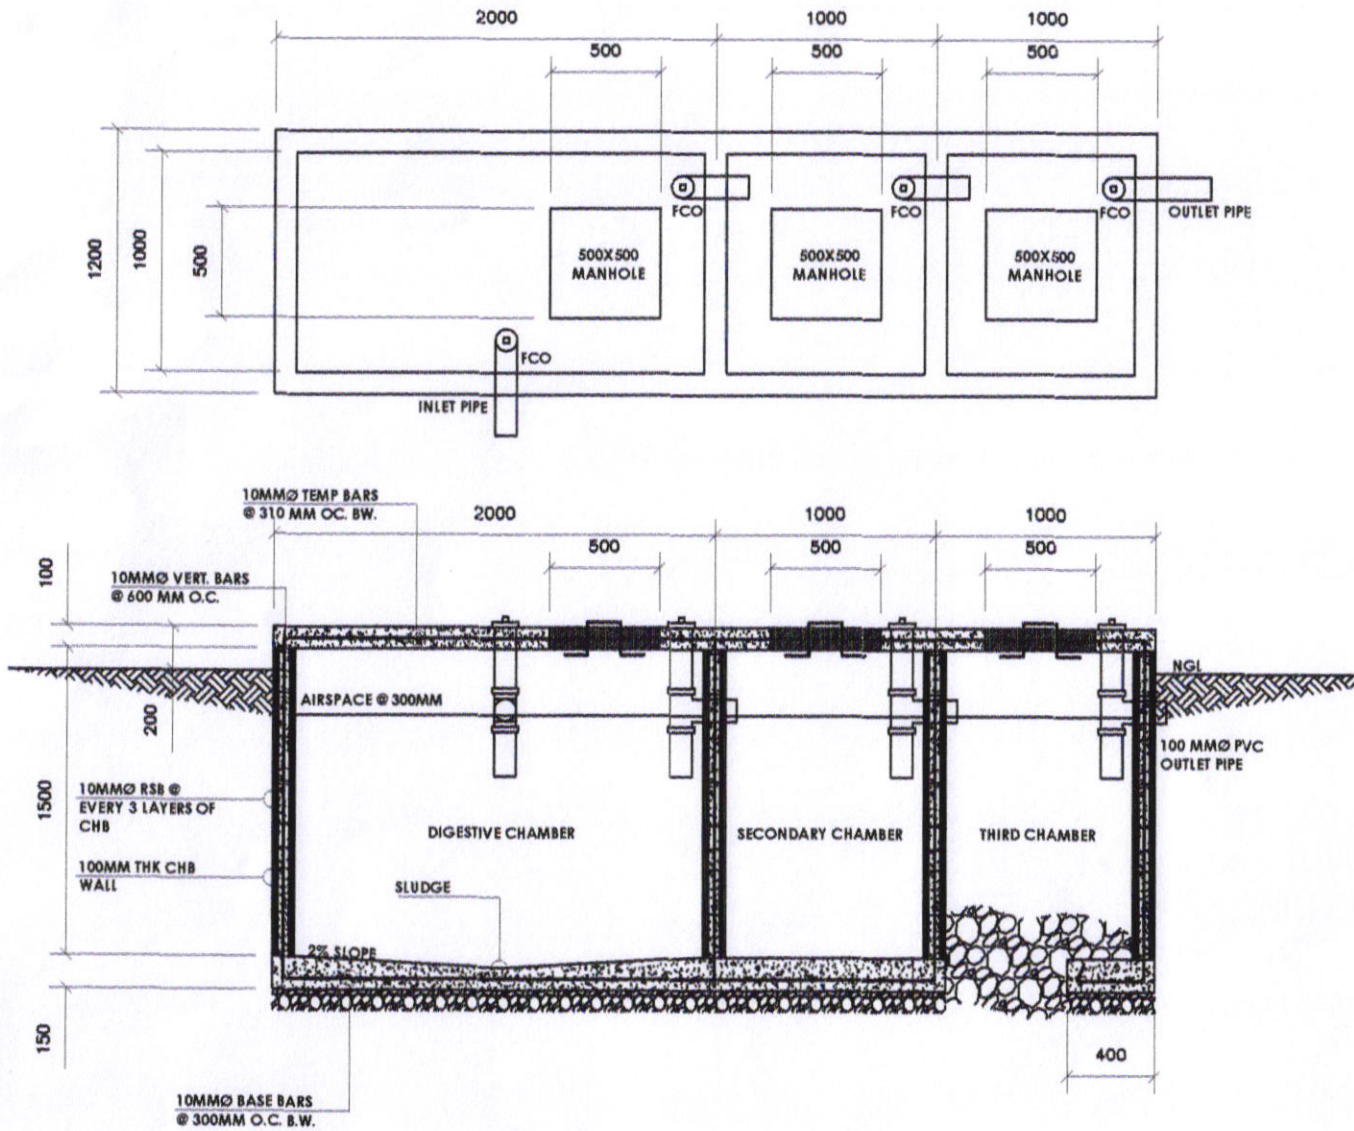


SEPTIC VAULT PLAN & SECTION  
AD-00 SCALE N.T.S.

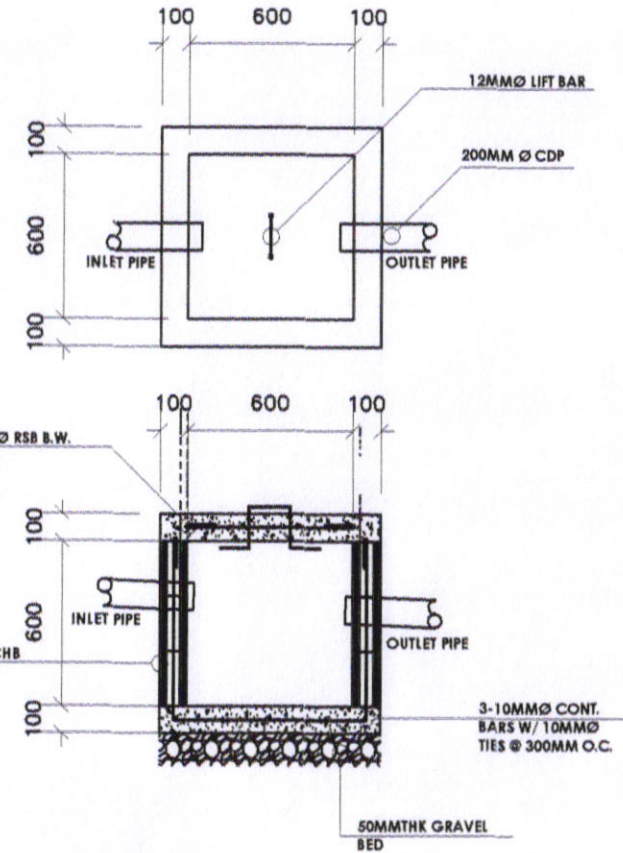


CATCH BASIN PLAN & SECTION  
AD-00 SCALE N.T.S.


 <p>SORSOGON CITY CITY ENGINEER'S OFFICE</p>	PROJECT TITLE:	DRAWN BY:	RECOMMENDING APPROVAL	APPROVED BY:	SHEET CONTENT:	SHEET NO.:
	CONSTRUCTION OF BRGY. HEALTH CENTER				AS - SHOWN	
	LOCATION : BRGY. BUENAVISTA WEST DIST. SORSOGON CITY	MINDEE MAE A. GONZALGO ARCHITECTURAL ASST.	ROEL D. ROMER, C.E./RMP CITY ENGINEER	HON. MA. ESTER E. HAMOR CITY MAYOR		

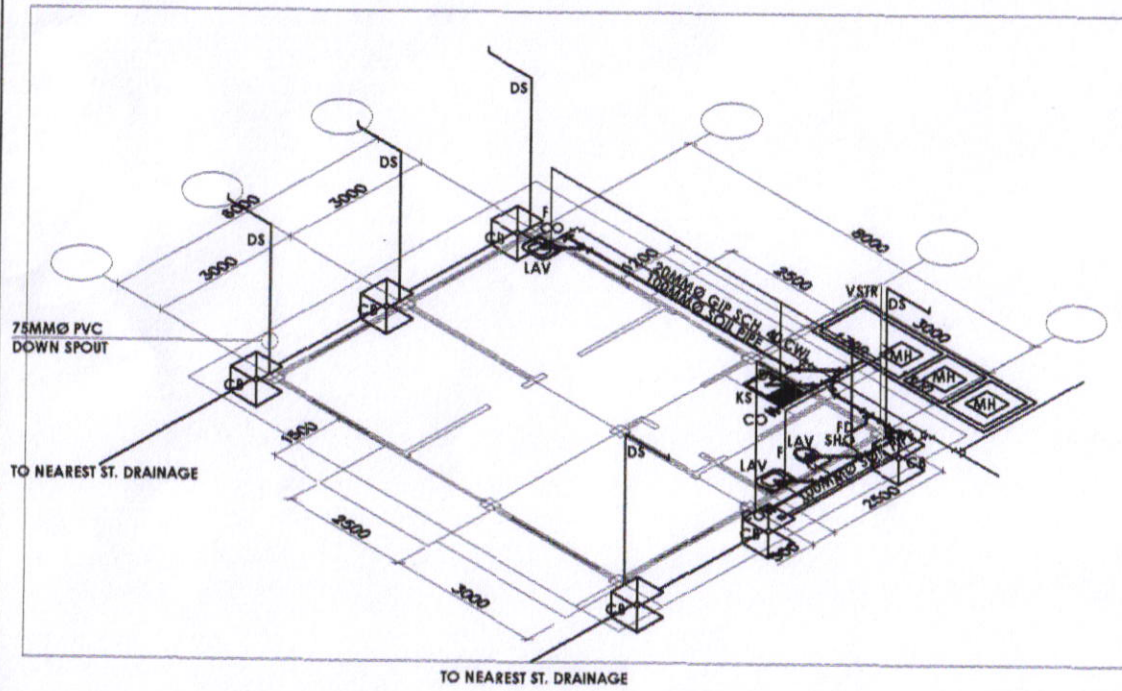


ISOMETRIC LAYOUT  
AD-00 SCALE N.T.S.

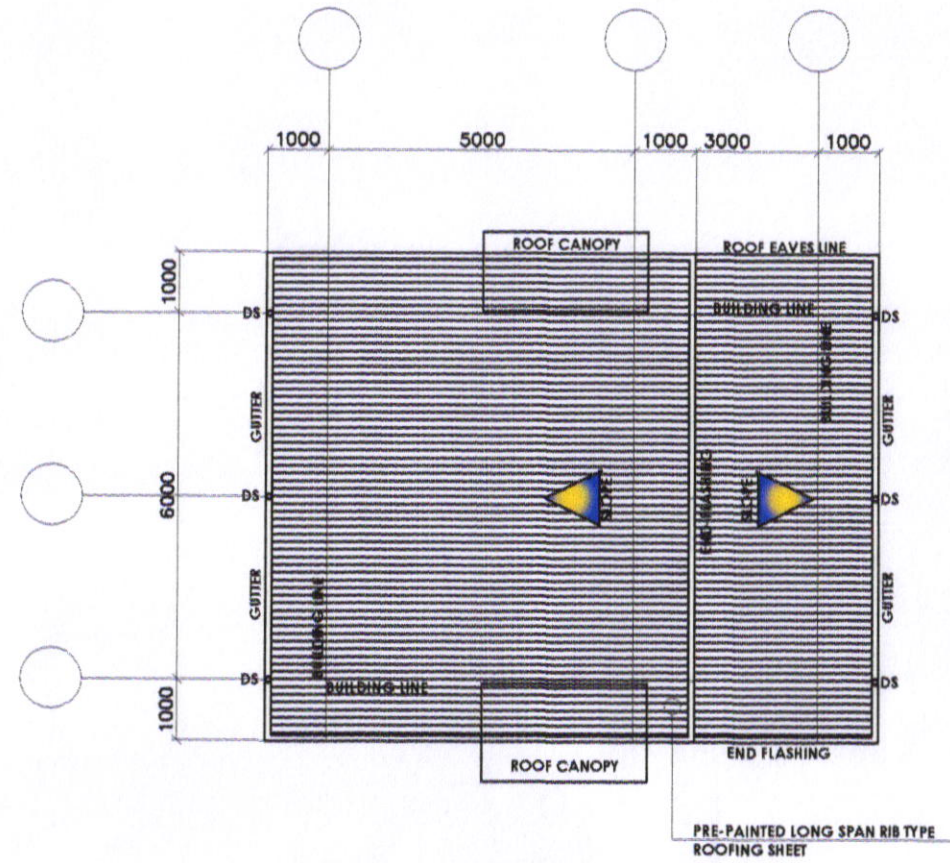


ROOF PLAN/ STORM WATER LAYOUT  
AD-00 SCALE N.T.S.


 <p>SORSOGON CITY CITY ENGINEER'S OFFICE</p>	PROJECT TITLE:	DRAWN BY:	RECOMMENDING APPROVAL	APPROVED BY:	SHEET CONTENT:	SHEET NO.
	CONSTRUCTION OF BRGY. HEALTH CENTER				A S - S H O W N	
	LOCATION : BRGY. BUENAVISTA WEST DIST. SORSOGON CITY	MINDEE MAE A. GONZALGO ARCHITECTURAL ASST.	ROEL D. DOMER, P.E./RMP CITY ENGINEER	HON. MA. ESTER E. HAMOR CITY MAYOR		

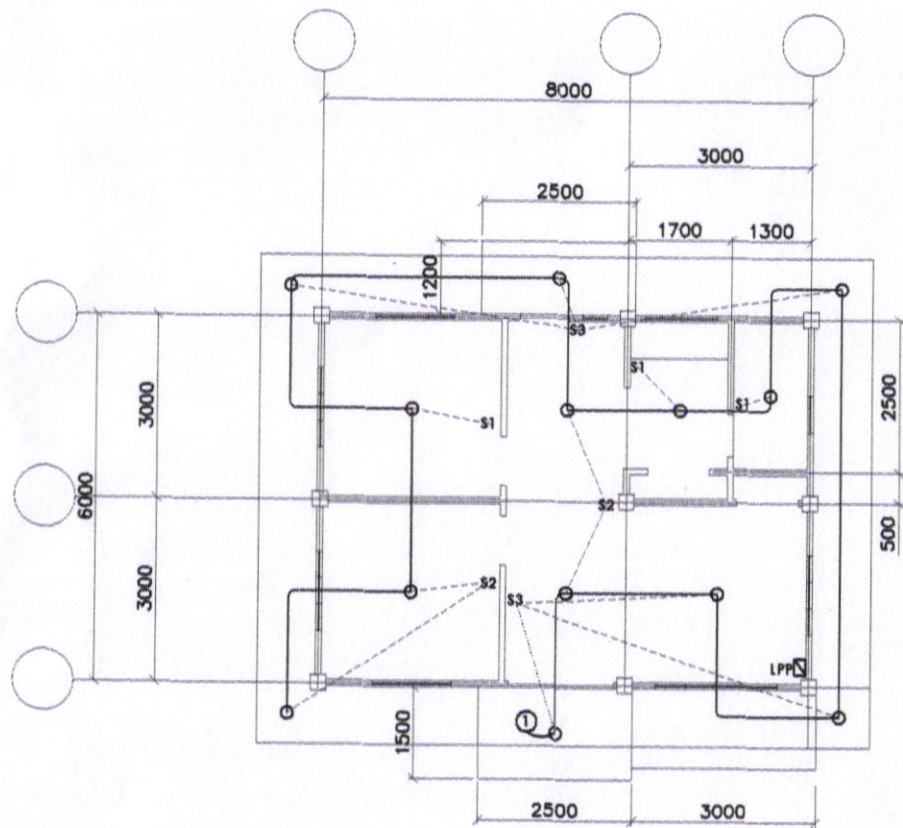

**LIGHTING LAYOUT**  
AD-00 SCALE N.T.S.

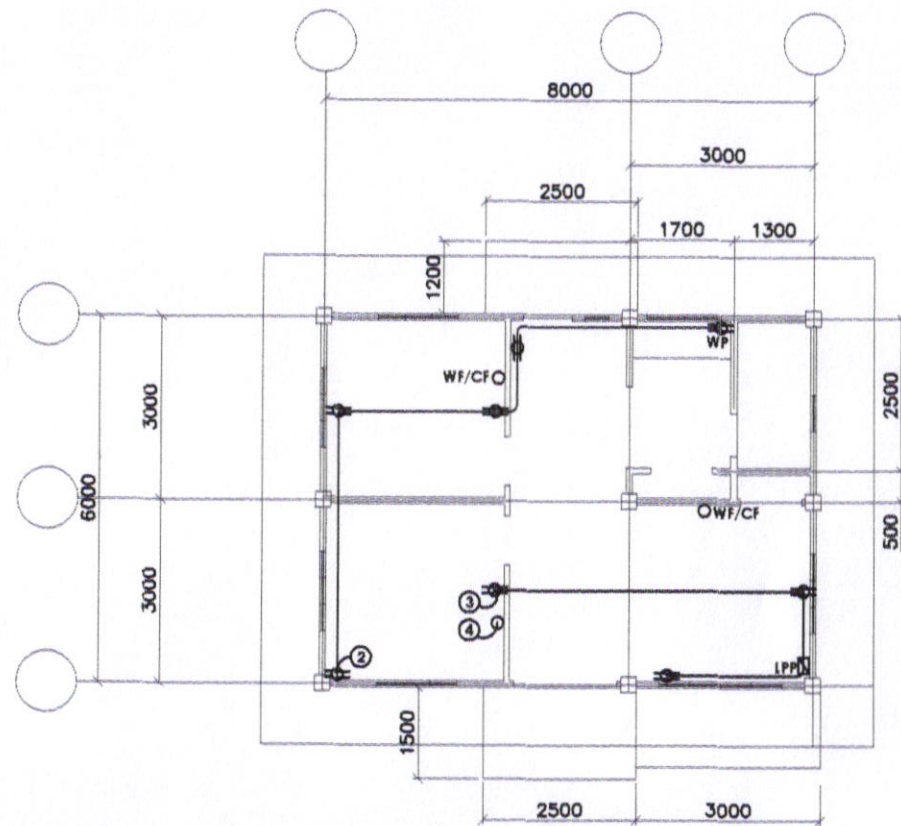

**POWER LAYOUT**  
AD-00 SCALE N.T.S.

 SORSOGON CITY <b>CITY ENGINEER'S          OFFICE</b>	PROJECT TITLE:	DRAWN BY:	RECOMMENDING APPROVAL	APPROVED BY:	SHEET CONTENT:	SHEET NO.
	CONSTRUCTION OF BRGY. HEALTH CENTER				<b>A S - S H O W N</b>	
	LOCATION : BRGY. BUENAVISTA WEST DIST. SORSOGON CITY	MINDEE MAE A. GONZALGO ARCHITECTURAL ASST.	ROEL D. DOMERTIC 2./RMP CITY ENGINEER	HON. MA. ESTER E. HAMOR CITY MAYOR		


# SCHEDULE OF LOADS

CKT NO.	DESCRIPTION	VOLT-AMPERE	VOLTAGE	AMPERE	NO. OF POLES	CKT PROTECTION	SIZE OF HOMERUN (WIRE CONDUIT)
CKT 1	LIGHTING OUTLET	650	230	2.82	2	15AT	2-2.0MM <sup>2</sup> THWN/THHN IN 20MMØ PVC
CKT 2	CONVENIENCE OUTLET	900	230	3.91	2	20AT	2-3.5MM <sup>2</sup> THWN/THHN IN 20MMØ PVC 1-3.5MM <sup>2</sup> EGC
CKT 3	CONVENIENCE OUTLET	540	230	2.35	2	20 AT	2-3.5MM <sup>2</sup> THWN/THHN IN 20MMØ PVC 1-3.5MM <sup>2</sup> EGC
CKT 4	WALL FAN/CEILING FAN	1500	230	6.52	2	20AT	2-3.5MM <sup>2</sup> THWN/THHN IN 20MMØ PVC 1-3.5MM <sup>2</sup> EGC
TOTAL		3590	230	MACB: 50 AF, 2P, 230V, 40AT, 10KAIC			


IL @ 100% DF (3590/ 230) 100= 15.61 A USE 2-8.0 MM<sup>2</sup> THWN IN 25MMØ PVC

KEY TO SYMBOLS	
	SERVICE ENTRANCE
	KILOWATT HOUR METER
	PANEL BOARD
	CIRCUIT BREAKER
	CIRCUIT HOMERUN
	LIGHTING OUTLET
	DUPLEX UNIVERSAL W/ GROUND WEATHERPROOF
	ONE-BANG SWITCH
	TWO-BANG SWITCH
	THREE BANG SWITCH
	SWITCH LEG
	LIGHTING CIRCUIT
	POWER CIRCUIT
	PANEL BOARD
	A.C.J.L.
	GENERATOR SET

OVERHEAD SERVICE ENTRANCE,  
230V, 1Ø, 2W, 60HZ, AC WITH  
25MMØ TYPE "F" CONDULET  
WEATHERHEAD

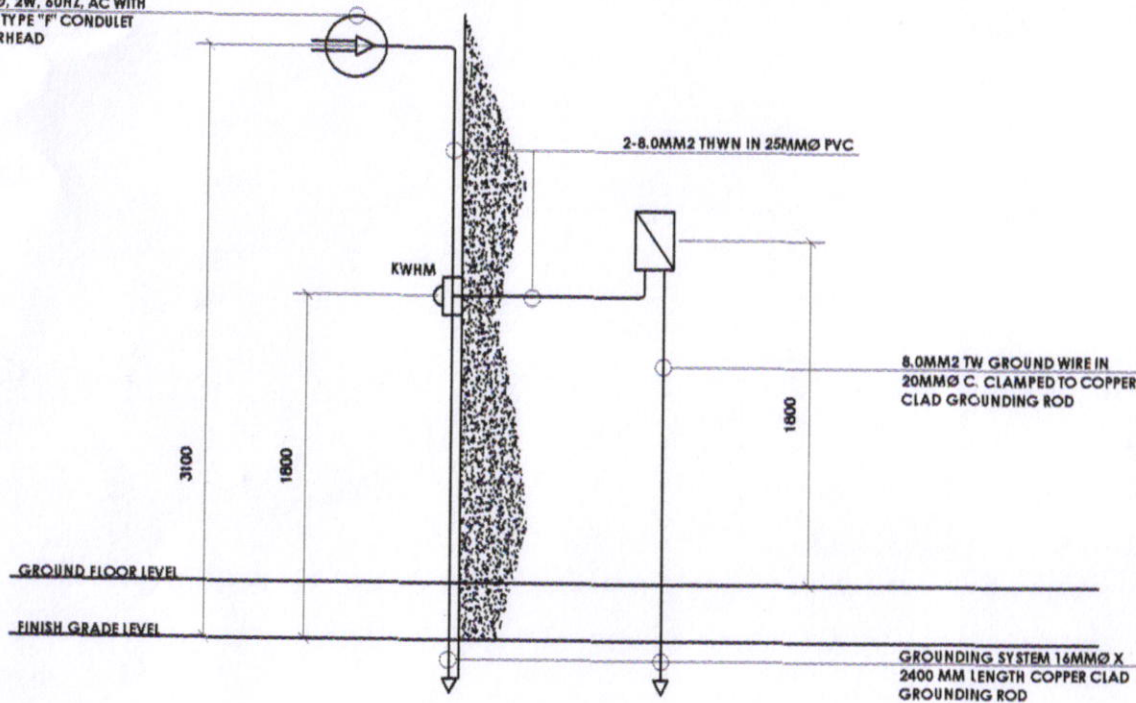

**RISER DIAGRAM**  
AD-00 SCALE N.T.S.

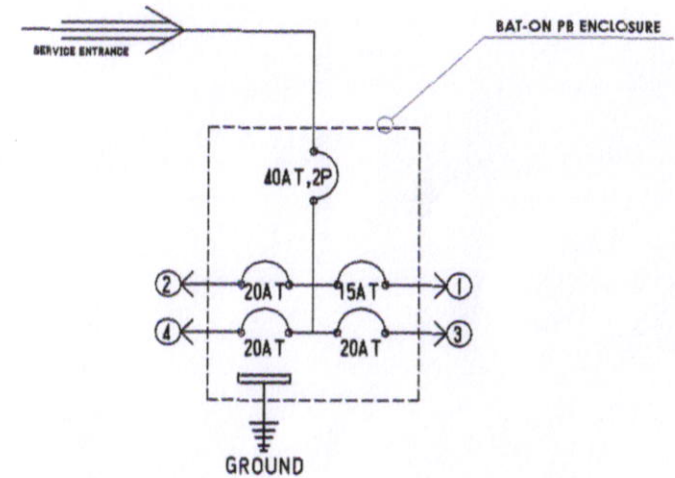

**SINGLE LINE DIAGRAM**  
AD-00 SCALE N.T.S.

<p>SORSOGON CITY CITY ENGINEER'S OFFICE</p>	PROJECT TITLE:	DRAWN BY:	RECOMMENDING APPROVAL	APPROVED BY:	SHEET CONTENT:	SHEET NO.
	CONSTRUCTION OF BRGY. HEALTH CENTER				A S - S H O W N	
	LOCATION : BRGY. BUENAVISTA WEST DIST. SORSOGON CITY	MINDEE MAE A. GONZALGO ARCHITECTURAL ASST.	ROEL D. BOMER, C.E./RMP CITY ENGINEER	HON. MA. ESTER E. HAMOR CITY MAYOR		