


1 FLOOR PLAN
SCALE 1:250 M

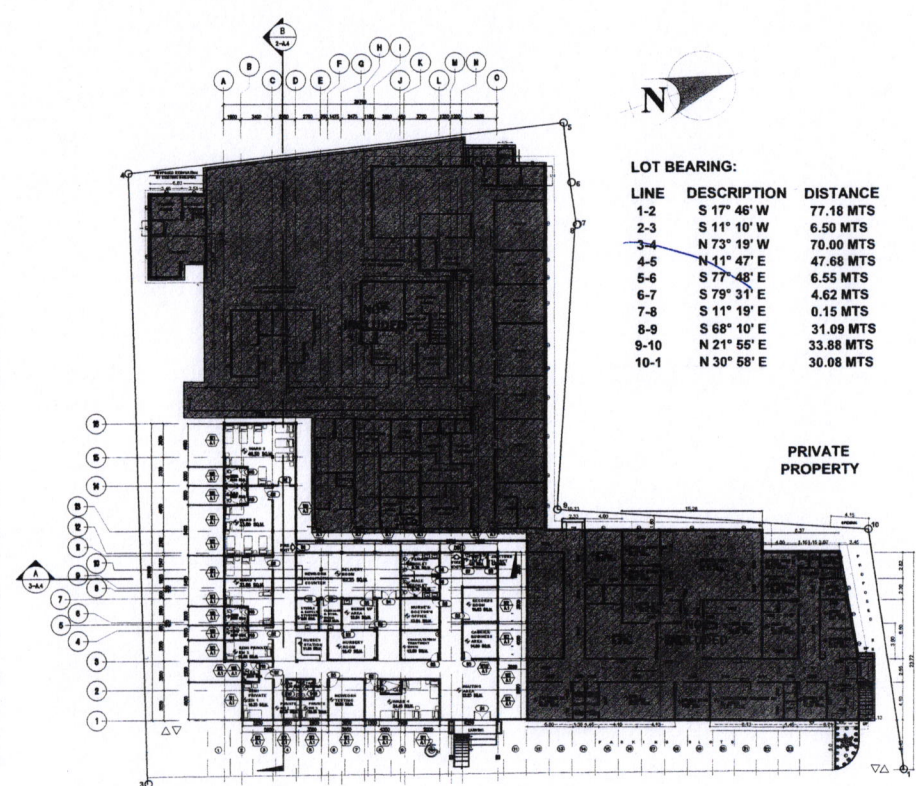

LOT BEARING:

LINE	DESCRIPTION	DISTANCE
1-2	S 17° 46' W	77.18 MTS
2-3	S 11° 10' W	6.50 MTS
3-4	N 73° 19' W	70.00 MTS
4-5	N 11° 47' E	47.68 MTS
5-6	S 77° 48' E	6.55 MTS
6-7	S 79° 31' E	4.62 MTS
7-8	S 11° 19' E	0.15 MTS
8-9	S 68° 10' E	31.09 MTS
9-10	N 21° 56' E	33.88 MTS
10-1	N 30° 58' E	30.08 MTS

2 SITE DEVELOPMENT PLAN
SCALE 1:800 M

PORTIA D. REUILLE
CIVIL ENGINEER

PRC. NO. : 0062782
 VALIDITY : OCT. 22, 2024
 PTR. NO. : GOVERNMENT EMPLOYEE
 ISSUED ON :
 ISSUED AT :
 TN. : 124 660 225

REPUBLIC ACT 9266
 DRAWINGS AND SPECIFICATIONS ONLY SIGNED, STAMPED OR SEALED AS INSTRUMENT OF SERVICE ARE THE PROPERTIES AND DOCUMENTS OF THE ARCHITECT OR AUTHOR WHETHER THE OBJECT FOR WHICH THEY ARE MADE IS EXECUTED OR NOT. IT SHALL BE UNLAWFUL FOR ANY PERSON, WITHOUT THE WRITTEN CONSENT OF THE ARCHITECT OR AUTHOR OF SAID DOCUMENTS TO DUPLICATE OR TO MAKE COPIES OF SAID DOCUMENTS FOR USE IN THE REPETITION OF AND FOR OTHER PROJECTS OR BUILDING, WHETHER EXECUTED PARTLY OR IN WHOLE.

REVISION :	
DATE	REVISOR BY


PROJECT TITLE :
SORSOGON CITY CENTRAL BIRTHING HOME
SORSOGON CITY, SORSOGON

APPROVED BY :


HON. MA. ESTER E. HAMOR
 CITY MAYOR

SHEET CONTENT'S :	DESIGNED :


SHEET NO. :

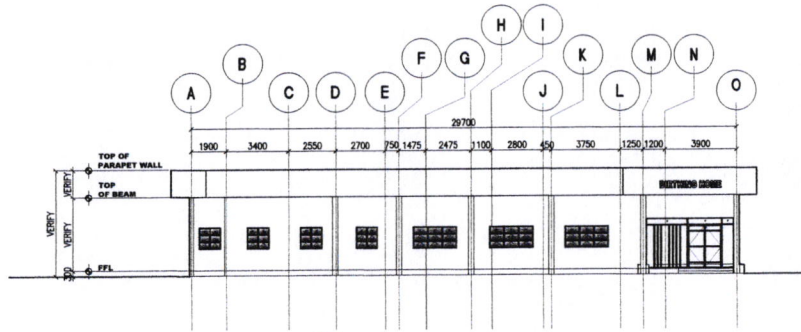


1 FRONT ELEVATION
SCALE 1:300 M
A2

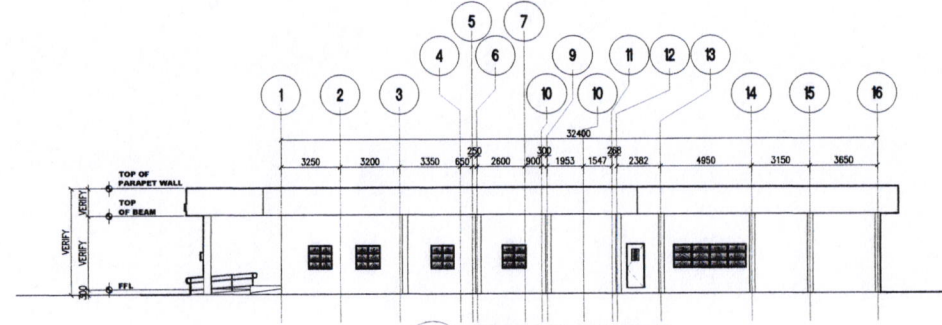


3 RIGHT ELEVATION
SCALE 1:300 M
A2

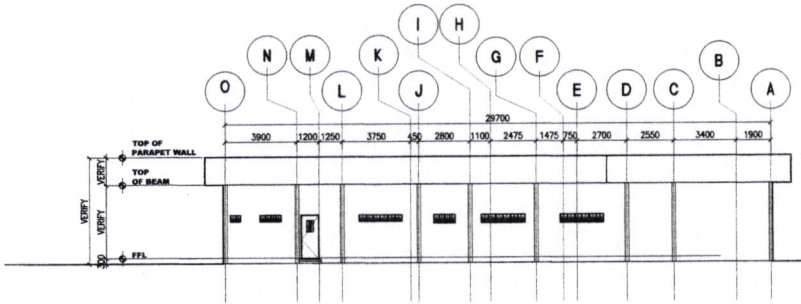


2 REAR ELEVATION
SCALE 1:300 M
A2

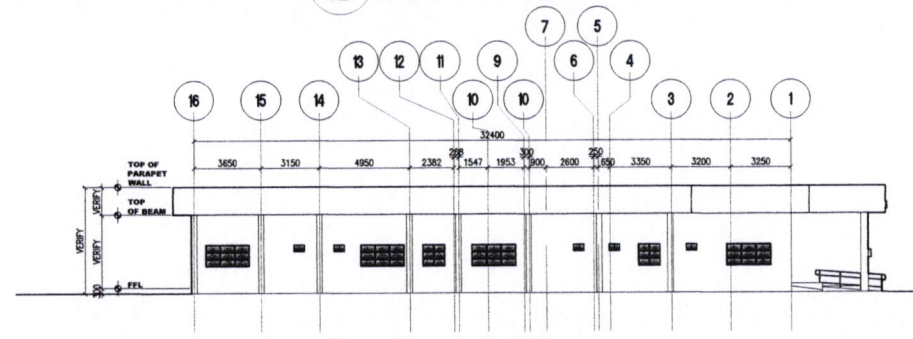


4 LEFT ELEVATION
SCALE 1:300 M
A2

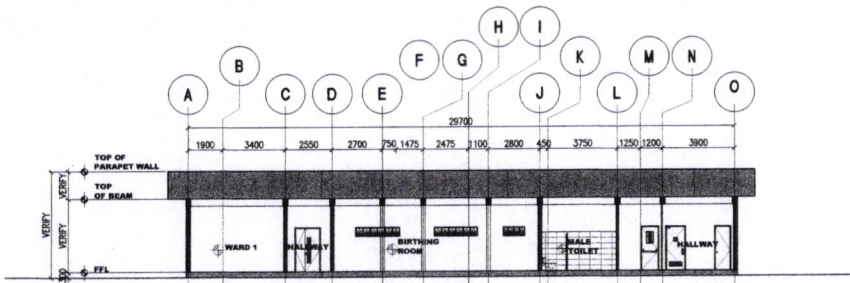


5 SECTION THRU-A
SCALE 1:300 M
A2

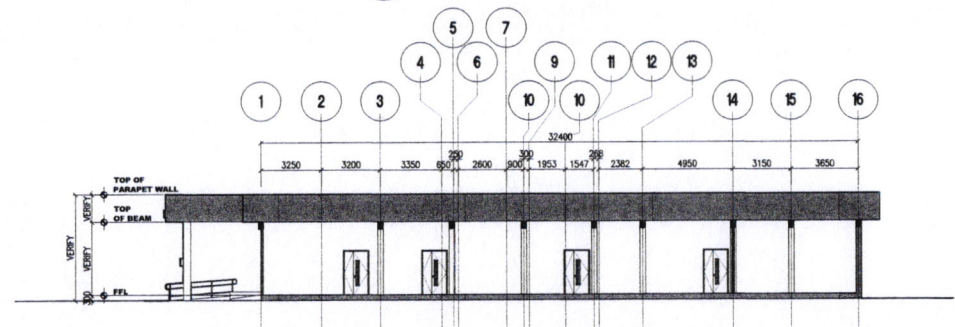


6 SECTION THRU-B
SCALE 1:300 M
A2

 
PORTIA D. REUILLE CIVIL ENGINEER	PRC. NO. : 0062782 VALIDITY : OCT. 22, 2024 PTR. NO. : GOVERNMENT EMPLOYEE ISSUED ON : ISSUED AT : TIN : 124 690 225	REPUBLIC ACT 9266 DRAWINGS AND SPECIFICATIONS DULY SIGNED, STAMPED OR SEALED AS INSTRUMENT OF SERVICE ARE THE PROPERTIES AND DOCUMENTS OF THE ARCHITECT OR AUTHOR WHETHER THE OBJECT FOR WHICH THEY ARE MADE IS EXECUTED OR NOT. IT SHALL BE UNLAWFUL FOR ANY PERSON, WITHOUT THE WRITTEN CONSENT OF THE ARCHITECT OR AUTHOR OF SAID DOCUMENTS TO DUPLICATE OR TO MAKE COPIES OF SAID DOCUMENTS FOR USE IN THE REPEITION OF AND FOR OTHER PROJECTS OR BUILDING, WHETHER EXECUTED PARTLY OR IN WHOLE.	REVISION : <table border="1"> <thead> <tr> <th>NO.</th> <th>DATE</th> <th>REVISED BY</th> </tr> </thead> <tbody> <tr><td> </td><td> </td><td> </td></tr> <tr><td> </td><td> </td><td> </td></tr> <tr><td> </td><td> </td><td> </td></tr> <tr><td> </td><td> </td><td> </td></tr> </tbody> </table>	NO.	DATE	REVISED BY													PROJECT TITLE : SORSOGON CITY CENTRAL BIRTHING HOME SORSOGON CITY, SORSOGON	APPROVED BY :  HON. MA. ESTER E. HAMOR CITY MAYOR	SHEET CONTENTS : DESIGNED : DRAWN : CHECKED : DATE : PROJECT NO. :	SHEET NO. :
	NO.	DATE	REVISED BY																			
(Empty space for additional notes or revisions)																						

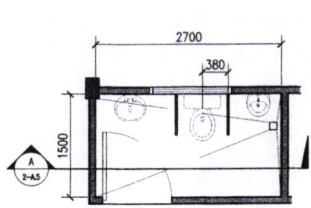


1 PWD TOILET PLAN
SCALE 1:16 M

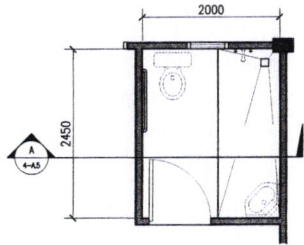


3 WARD TOILET PLAN
SCALE 1:16 M

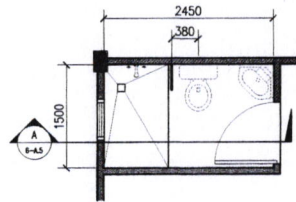


5 SEMI-PRIV. TOILET PLAN
SCALE 1:16 M

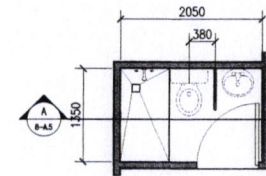


7 PRIVATE TOILET PLAN
SCALE 1:16 M

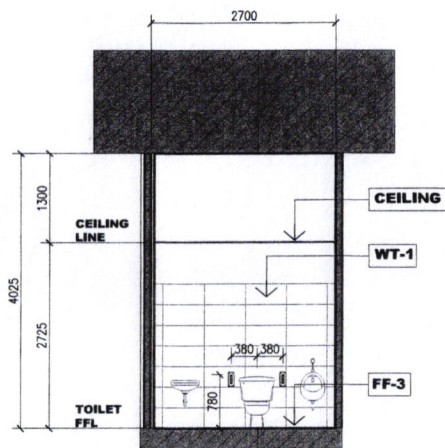


2 PWD TOILET SECTION
SCALE 1:80 M

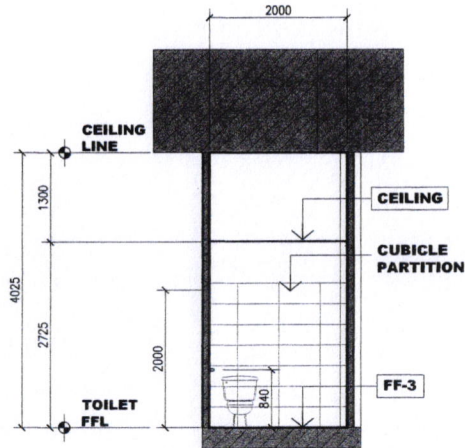

4 WARD TOILET SECTION
SCALE 1:80 M

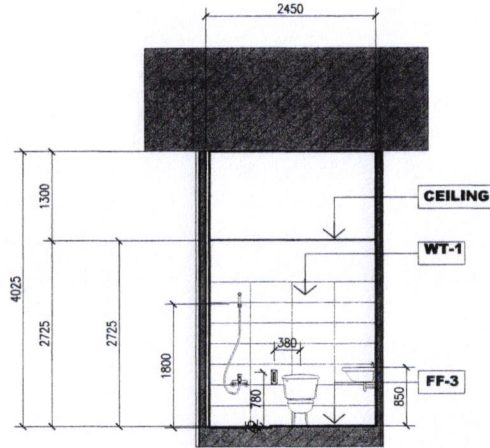

6 SEMI-PRIV. TOILET SECTION
SCALE 1:80 M

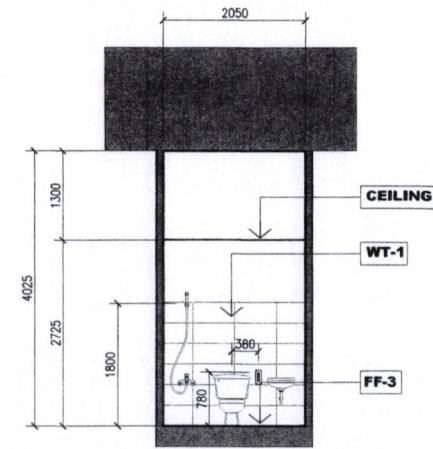

8 PRIVATE TOILET SECTION
SCALE 1:80 M

PORTIA D. REUILLE
CIVIL ENGINEER

PRC. NO. : 0062782
VALIDITY : OCT. 22, 2024
PTR NO. : GOVERNMENT EMPLOYEE
ISSUED ON :
ISSUED AT :
TN. : 124 690 225

REPUBLIC ACT 9266
DRAWINGS AND SPECIFICATIONS DULY SIGNED, STAMPED OR SEALED AS INSTRUMENT OF SERVICE ARE THE PROPERTIES AND DOCUMENTS OF THE ARCHITECT OR AUTHOR WHETHER THE OBJECT FOR WHICH THEY ARE MADE IS EXECUTED OR NOT. IT SHALL BE UNLAWFUL FOR ANY PERSON, WITHOUT THE WRITTEN CONSENT OF THE ARCHITECT OR AUTHOR OF SAID DOCUMENTS TO DUPLICATE OR TO MAKE COPIES OF SAID DOCUMENTS FOR USE IN THE REPETITION OF AND FOR OTHER PROJECTS OR BUILDING, WHETHER EXECUTED PARTLY OR IN WHOLE.


REVISION :	DATE	REMOVED BY

PROJECT TITLE :
SORSOGON CITY CENTRAL BIRTHING HOME
SORSOGON CITY, SORSOGON


APPROVED BY :
HON. MA. ESTER E. HAMOR
CITY MAYOR

SHEET CONTENT'S :
DESIGNED :
DRAWN :
CHECKED :
DATE :
PROJECT NO. :

SHEET NO. :

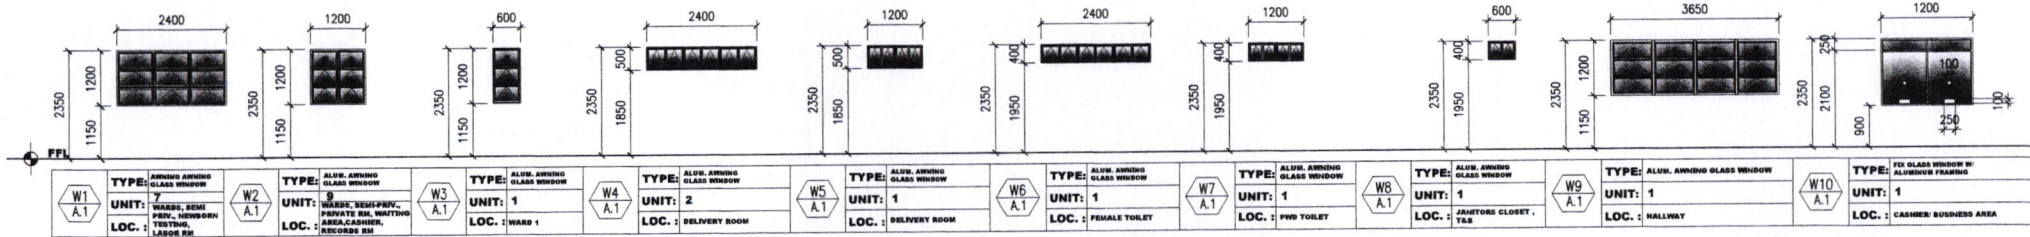


1 WINDOW SCHEDULE
SCALE 1:20 M

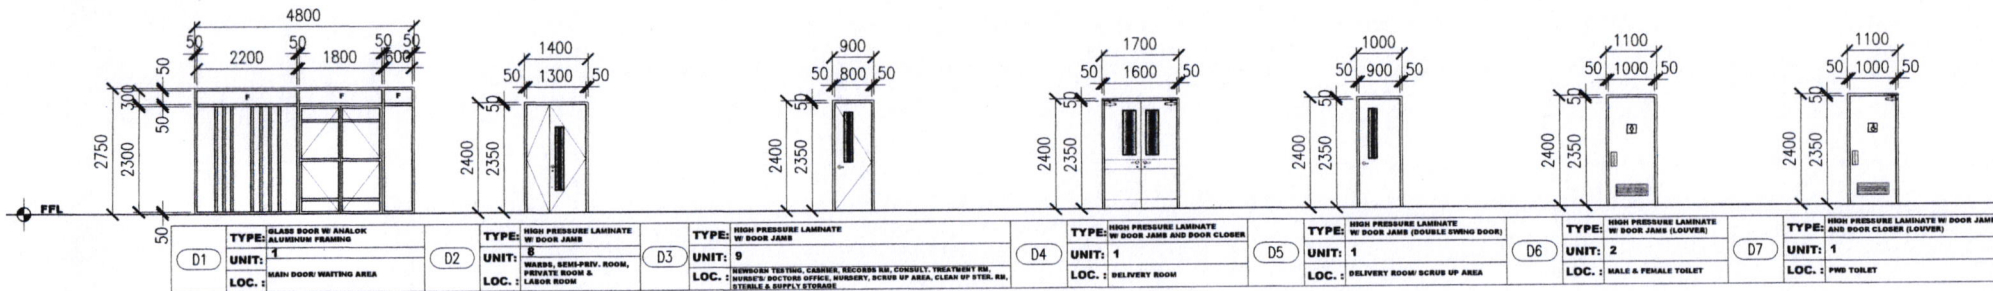


2 DOOR SCHEDULE
SCALE 1:20 M


PORTIA D. REUILLE CIVIL ENGINEER	PRC. NO. : 0062782 VALIDITY : OCT. 22, 2024 PTR. NO. : GOVERNMENT EMPLOYEE ISSUED ON : ISSUED AT : TEL. : 124 690 225	REPUBLIC ACT 6266 DRAWINGS AND SPECIFICATIONS DULY SIGNED, STAMPED OR SEALED AS INSTRUMENT OF SERVICE ARE THE PROPERTIES AND DOCUMENTS OF THE ARCHITECT OR AUTHOR WHETHER THE OBJECT FOR WHICH THEY ARE MADE IS EXECUTED OR NOT. IT SHALL BE UNLAWFUL FOR ANY PERSON, WITHOUT THE WRITTEN CONSENT OF THE ARCHITECT OR AUTHOR OF SAID DOCUMENTS TO DUPLICATE OR TO MAKE COPIES OF SAID DOCUMENTS FOR USE IN THE REPEITION OF AND FOR OTHER PROJECTS OR BUILDING, WHETHER EXECUTED PARTLY OR IN WHOLE	REVISION : <table border="1"> <thead> <tr> <th>NO.</th> <th>DATE</th> <th>REVISION BY</th> </tr> </thead> <tbody> <tr><td> </td><td> </td><td> </td></tr> <tr><td> </td><td> </td><td> </td></tr> <tr><td> </td><td> </td><td> </td></tr> <tr><td> </td><td> </td><td> </td></tr> </tbody> </table>	NO.	DATE	REVISION BY													PROJECT TITLE : SORSOGON CITY CENTRAL BIRTHING HOME SORSOGON CITY, SORSOGON	APPROVED BY : HON. MA. ESTER E. HAMOR CITY MAYOR	SHEET CONTENT'S : DESIGNED : DRAWN : CHECKED : DATE : PROJECT NO. :	SHEET NO. :
	NO.	DATE	REVISION BY																			

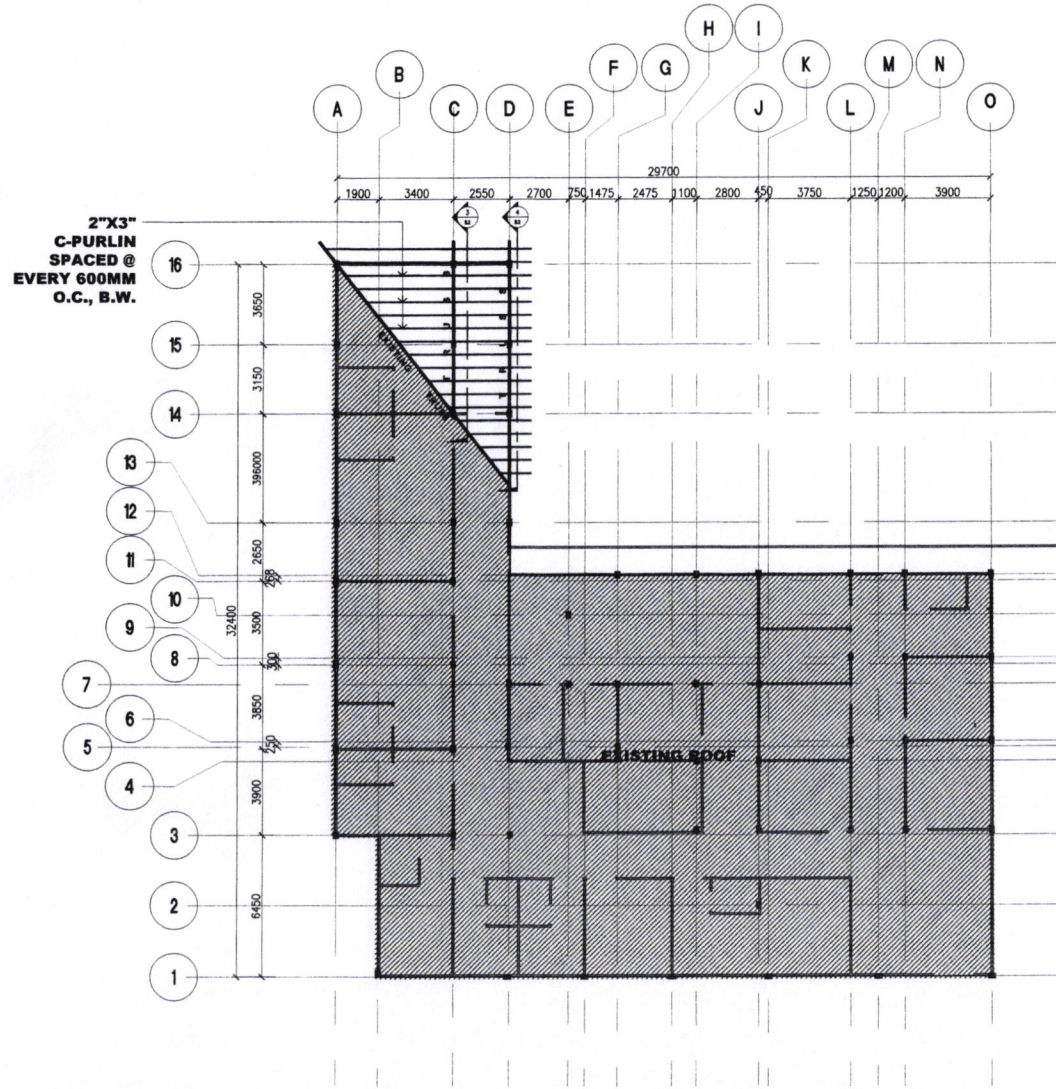


1 FOUNDATION PLAN
SCALE 1:1250 M

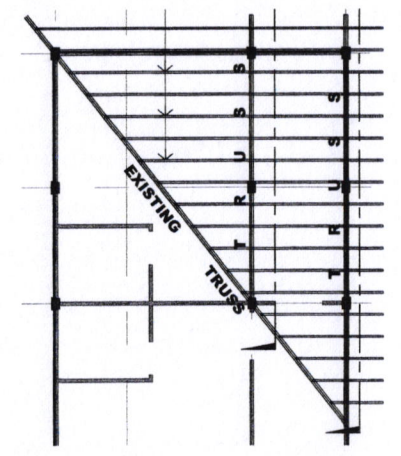

2 ROOF PLAN (BLOW-UP)
SCALE 1:150 M

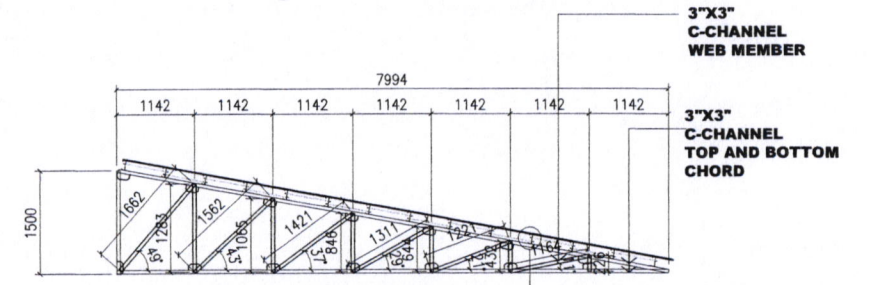


3 TRUSS DETAIL
SCALE 1:180 M

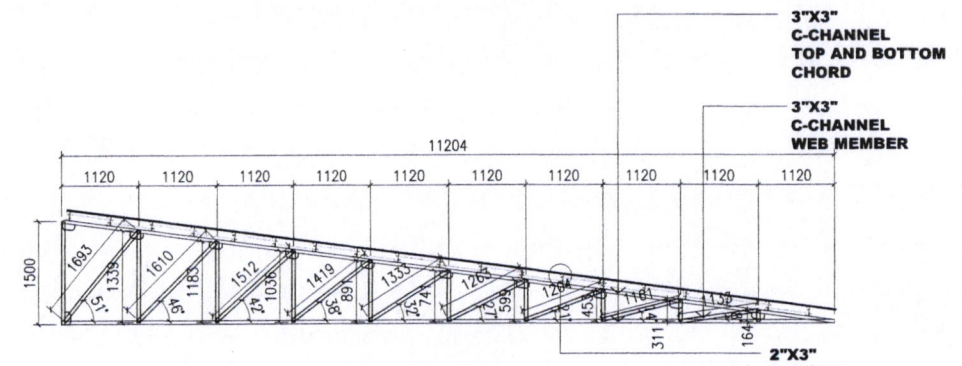


3 TRUSS DETAIL
SCALE 1:180 M

PORTIA D. REVILLE CIVIL ENGINEER	PRC. NO. : 0062782 VALIDITY : OCT. 22, 2024 PTR. NO. : GOVERNMENT EMPLOYEE ISSUED ON : ISSUED AT : TEL. : 124 690 225	REPUBLIC ACT 9266 DRAWINGS AND SPECIFICATIONS DULY SIGNED, STAMPED OR SEALED AS INSTRUMENT OF SERVICE ARE THE PROPERTIES AND DOCUMENTS OF THE ARCHITECT OR AUTHOR WHOSE THE OBJECT FOR WHICH THEY ARE MADE IS EXECUTED OR NOT. IT SHALL BE UNLAWFUL FOR ANY PERSON, WITHOUT THE WRITTEN CONSENT OF THE ARCHITECT OR AUTHOR OF SAID DOCUMENTS TO DUPLICATE OR TO MAKE COPIES OF SAID DOCUMENTS FOR USE IN THE REPEITION OF AND FOR OTHER PROJECTS OR BUILDING, WHETHER EXECUTED PARTLY OR IN WHOLE.	REVISION : <table border="1"> <thead> <tr> <th>NO.</th> <th>DATE</th> <th>REVISED BY</th> </tr> </thead> <tbody> <tr><td> </td><td> </td><td> </td></tr> <tr><td> </td><td> </td><td> </td></tr> <tr><td> </td><td> </td><td> </td></tr> </tbody> </table>	NO.	DATE	REVISED BY										PROJECT TITLE : SORSOGON CITY CENTRAL BIRTHING HOME SORSOGON CITY, SORSOGON	APPROVED BY : HON. MA. ESTER E. HAMOR CITY MAYOR	SHEET CONTENTS : DESIGNED : DRAWN : CHECKED : DATE : PROJECT NO.	SHEET NO. :
	NO.	DATE	REVISED BY																

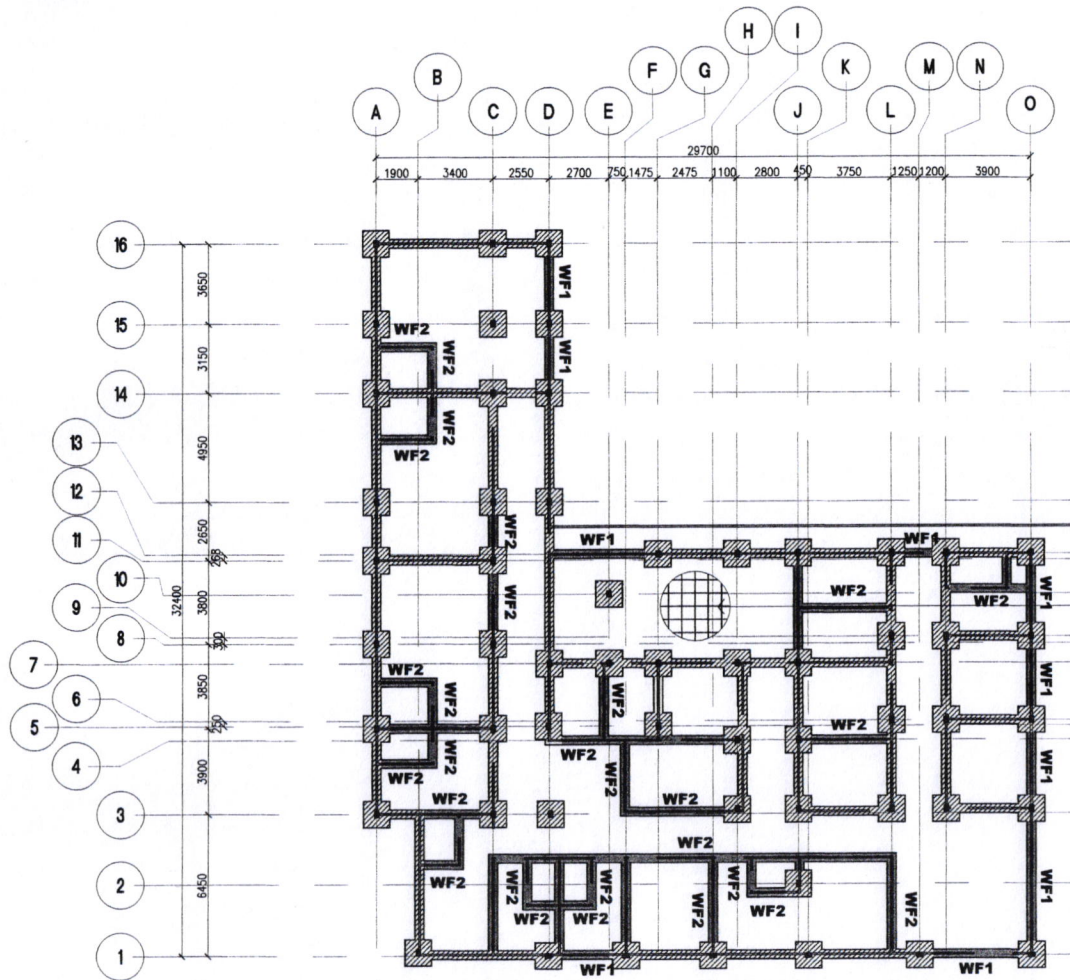


1 FOUNDATION PLAN
SCALE 1:250 M

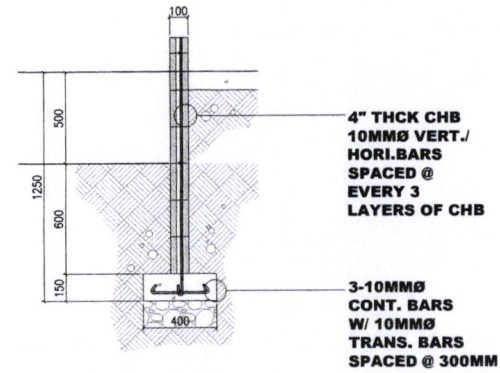

2 WF1 DETAIL
SCALE 1:30 M

100MM THK S.O.G.
W/ 10MMØ RSB
SPACED @ 100MM
O.C., B.W.

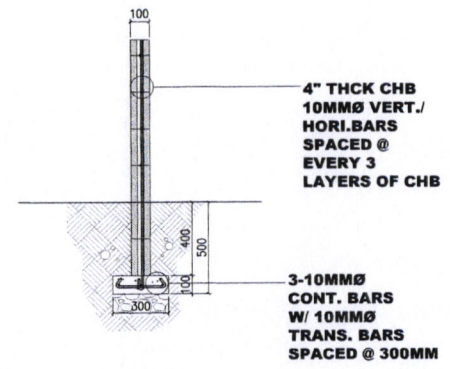


3 WF2 DETAIL
SCALE 1:30 M


LEGEND:

	EXISTING
	FOR CONSTRUCTION


PORTIA D. REVILLE CIVIL ENGINEER	PRC. NO. : 0062782 VALIDITY : OCT. 22, 2024 PTR. NO. : GOVERNMENT EMPLOYEE ISSUED ON : ISSUED AT : TEL. : 124 690 225	REPUBLIC ACT 9266 DRAWINGS AND SPECIFICATIONS DULY SIGNED, STAMPED OR SEALED AS INSTRUMENT OF SERVICE ARE THE PROPERTIES AND DOCUMENTS OF THE ARCHITECT OR AUTHOR WHETHER THE OBJECT FOR WHICH THEY ARE MADE IS EXECUTED OR NOT. IT SHALL BE UNLAWFUL FOR ANY PERSON, WITHOUT THE WRITTEN CONSENT OF THE ARCHITECT OR AUTHOR OF SAID DOCUMENTS TO DUPLICATE OR TO MAKE COPIES OF SAID DOCUMENTS FOR USE IN THE REPEITION OF AND FOR OTHER PROJECTS OR BUILDING, WHETHER EXECUTED PARTLY OR IN WHOLE	REVISION : <table border="1"> <thead> <tr> <th>NO.</th> <th>DATE</th> <th>REVISED BY</th> </tr> </thead> <tbody> <tr> <td> </td> <td> </td> <td> </td> </tr> </tbody> </table>	NO.	DATE	REVISED BY				PROJECT TITLE : SORSOGON CITY CENTRAL BIRTHING HOME SORSOGON CITY, SORSOGON	APPROVED BY : HON. MR. ESTER E. HAMOR CITY MAYOR	SHEET CONTENTS : DESIGNED : DRAWN : CHECKED : DATE : PROJECT NO. :	SHEET NO. :
	NO.	DATE	REVISED BY										

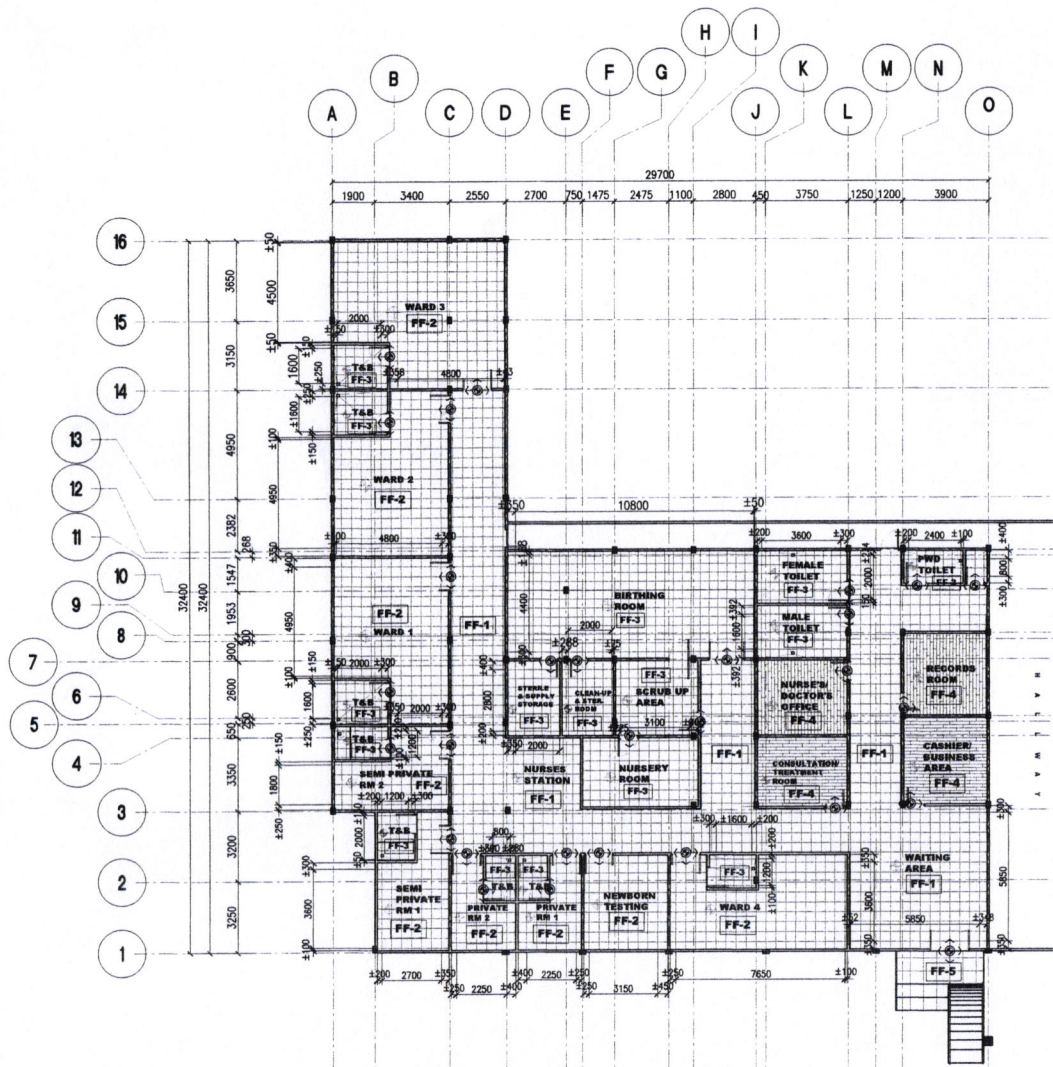


1 TILE SETTING-OUT PLAN
SCALE 1:250 M

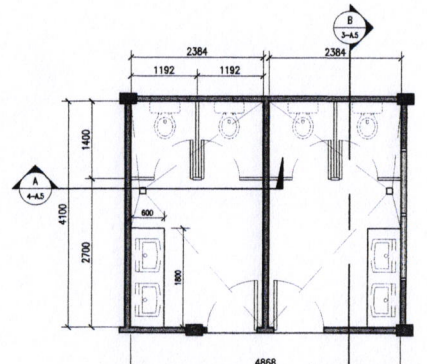


2 MALE/ FEMALE TOILET PLAN
SCALE 1:30 M

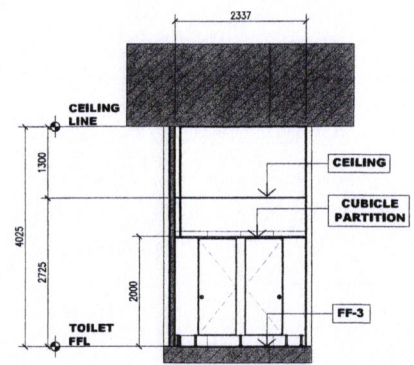

3 SECTION A
SCALE 1:30 M

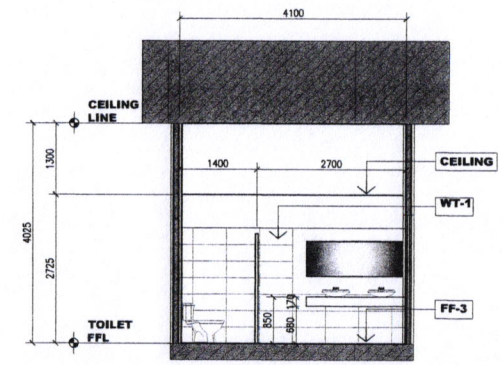


4 SECTION B
SCALE 1:30 M

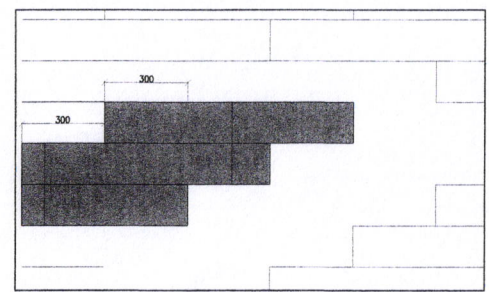


LEGEND:	
	TILE SETTING OUT POINT
FF-1	450MM x 450MM QUARTZ LVT (LUXURY VINYL TILE) -HALLWAYS
FF-2	450MM x 450MM WOOD LVT (LUXURY VINYL TILE) -PRIVATE RM, SEMI-PRIVATE RM & WARDS
FF-3	400MM x 400MM NON-SLIP CERAMIC TILES-BIRTHING RM, STERILE AND SUPPLY STORAGE, CLEAN UP STER. RM, SCRUB-UP AREA, NURSERY RM AND TOILETS
FF-4	900MM x 160MM WOOD PLANK LVT (LUXURY VINYL TILE) -RECORDS RM, CASHIER/ BUSINESS AREA, NURSES/ DOCTORS OFFICE & CONSULTATION RM
FF-5	600MM x 600MM CERAMIC TILE OUTDOOR (ROUGH SURFACE)
WT-1	300MM x 600MM CERAMIC TILE WALL TILE (GLOSSY)

PORTIA D. REUILLE CIVIL ENGINEER	PRC. NO. : 0062782	REPUBLIC ACT 9266	REVISION :	PROJECT TITLE :	APPROVED BY :	SHEET CONTENT'S :	DESIGNED :	SHEET NO. :
	VALIDITY : OCT. 22, 2024	DRAWINGS AND SPECIFICATIONS DULY SIGNED, STAMPED OR SEALED AS INSTRUMENT OF SERVICE ARE THE PROPERTIES AND DOCUMENTS OF THE ARCHITECT OR AUTHOR WHETHER THE OBJECT FOR WHICH THEY ARE MADE IS EXECUTED OR NOT. IT SHALL BE UNLAWFUL FOR ANY PERSON, WITHOUT THE WRITTEN CONSENT OF THE ARCHITECT OR AUTHOR OF SAID DOCUMENTS TO DUPLICATE OR TO MAKE COPIES OF SAID DOCUMENTS FOR USE IN THE REPEITION OF AND FOR OTHER PROJECTS OR BUILDING, WHETHER EXECUTED PARTLY OR IN WHOLE	DATE REVISOR BY	SORSOGON CITY CENTRAL BIRTHING HOME		HON. MA. ESTER E. HAMOR	DRAWN :	
	PTIR NO. : GOVERNMENT EMPLOYEE			SORSOGON CITY, SORSOGON	CITY MAYOR	CHECKED :		
	ISSUED ON :					DATE :		
	ISSUED AT :					PROJECT NO. :		
TIN. : 124 690 225								

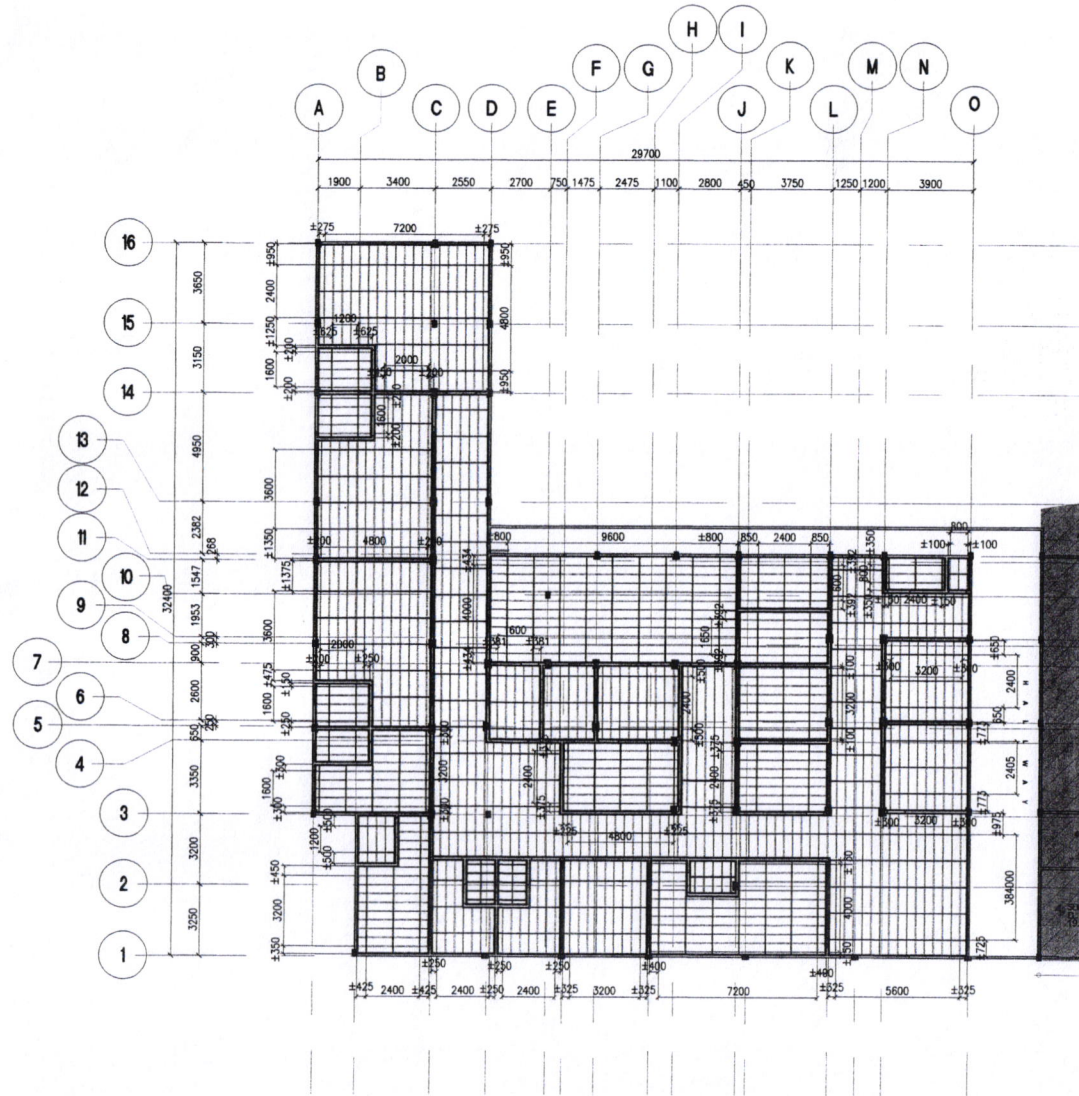

1
A6
CEILING FRAMING PLAN
SCALE
1:250 M

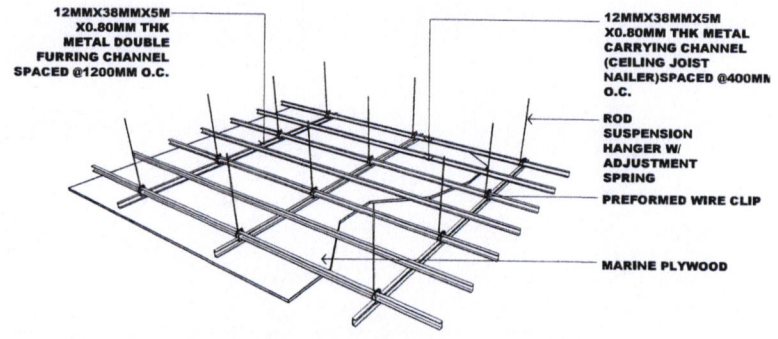

2
A6
CEILING FRAMING DETAIL
SCALE
NTS


PORTIA D. REUILLE CIVIL ENGINEER	PRC. NO. : 0062782 VALIDITY : OCT. 22, 2024 PTR. NO. : GOVERNMENT EMPLOYEE ISSUED ON : ISSUED AT : TIN : 124 680 225	REPUBLIC ACT 9286 DRAWINGS AND SPECIFICATIONS DULY SIGNED, STAMPED OR SEALED AS INSTRUMENT OF SERVICE ARE THE PRIORITIES AND DOCUMENTS OF THE ARCHITECT OR AUTHOR WHETHER THE OBJECT FOR WHICH THEY ARE MADE IS EXECUTED OR NOT. IT SHALL BE UNLAWFUL FOR ANY PERSON, WITHOUT THE WRITTEN CONSENT OF THE ARCHITECT OR AUTHOR OF SAID DOCUMENTS TO DUPLICATE OR TO MAKE COPIES OF SAID DOCUMENTS FOR USE IN THE REPETITION OF AND FOR OTHER PROJECTS OR BUILDING, WHETHER EXECUTED PARTLY OR IN WHOLE.	REVISION : <table border="1"> <thead> <tr> <th>DATE</th> <th>REVISION BY</th> </tr> </thead> <tbody> <tr><td> </td><td> </td></tr> <tr><td> </td><td> </td></tr> <tr><td> </td><td> </td></tr> </tbody> </table>	DATE	REVISION BY							PROJECT TITLE : SORSOGON CITY CENTRAL BIRTHING HOME SORSOGON CITY, SORSOGON	APPROVED BY : HON. MA. ESTER E. HAMOR CITY MAYOR	SHEET CONTENTS : DESIGNED : DRAWN : CHECKED : DATE : PROJECT NO. :	SHEET NO. :
	DATE	REVISION BY													

KEY TO SYMBOLS

	SERVICE ENTRANCE
	KILOWATT HOUR METER
	PANEL BOARD
	CIRCUIT BREAKER
	CIRCUIT HOMERUN
	LIGHTING OUTLET
	DUPLEX CONVENIENCE OUTLET
	WEATHERPROOF CONVENIENCE OUTLET
S1	SINGLE POLE SWITCH
S2	DUPLEX SWITCH
S3	THREE WAY SWITCH
---	SWITCH LEG
---	LIGHTING CIRCUIT
---	POWER CIRCUIT
TS	TRANSFER SWITCH
AT	AMPERE TRIP
PB	PANEL BOARD

ELECTRICAL NOTES:

- ALL ELECTRICAL WORKS HEREIN SHALL COMPLY WITH THE PROVISIONS OF THE LATEST EDITION OF THE PHILIPPINE ELECTRICAL CODE, THE RULES & REGULATIONS OF SORSOGON CITY & SORSOGONELECTRIC COOPERATIVE II.
- TYPE OF SERVICE SHALL BE 230VOLTS, 1 PHASE, 2 WIRE SYSTEM, 60HZ, AND THERE SHALL BE ONLY ONE SERVICE DROP TO THE BUILDING.
- METHOD OF WIRING FOR SERVICE ENTRANCE CONDUCTOR SHALL BE IN RIGID METAL CONDUIT & BRANCH CONDUIT IN POLYVINYL CHLORIDE FOR BOTH EXPOSED AND EMBEDDED WITH PROPER FITTINGS AND SUPPORT.
- ALL MATERIALS AND EQUIPMENTS SHALL BE BRAND NEW AND OF APPROVED TYPE FOR BOTH LOCATION AND PURPOSE INTENDED.
- ALL LIGHTINGS AND CONVENIENCE OUTLET, CIRCUIT HOMERUNS SHALL BE WIRED WITH NOT LESS THAN 2.8MM² RESPECTIVELY UNLESS OTHERWISE INDICATED ON THE PLAN.
- WHENEVER REQUIRED AND NECESSARY, PULLBOXES AND JUNCTION BOXES OF PROPER SIZES SHALL BE INSTALLED AT CONVENIENT AND CONSPICUOUS LOCATIONS ALTHOUGH SUCH BOXES ARE NOT SHOWN ON THE PLANS NOR MENTIONED IN THE SPECIFICATIONS.
- MOUNTING HEIGHTS SHALL BE AS FOLLOWS:
LIGHT SWITCH - 1.50M FROM FIN. FLOOR LINE
DUPLEX C.O. - 0.30M FROM FIN. FLOOR LINE / COUNTER
PANEL BOARD - 1.80M FROM FIN. FLOOR LINE.
- ALL OUTDOOR INSTALLATIONS SHALL BE WEATHERPROOF TYPE.
- ALL ELECTRICAL WORKS SHALL BE DONE UNDER THE DIRECT AND IMMEDIATE SUPERVISION OF A DULY LICENSED REGISTERED ELECTRICAL ENGINEER OR A REGISTERED MASTER ELECTRICIAN.

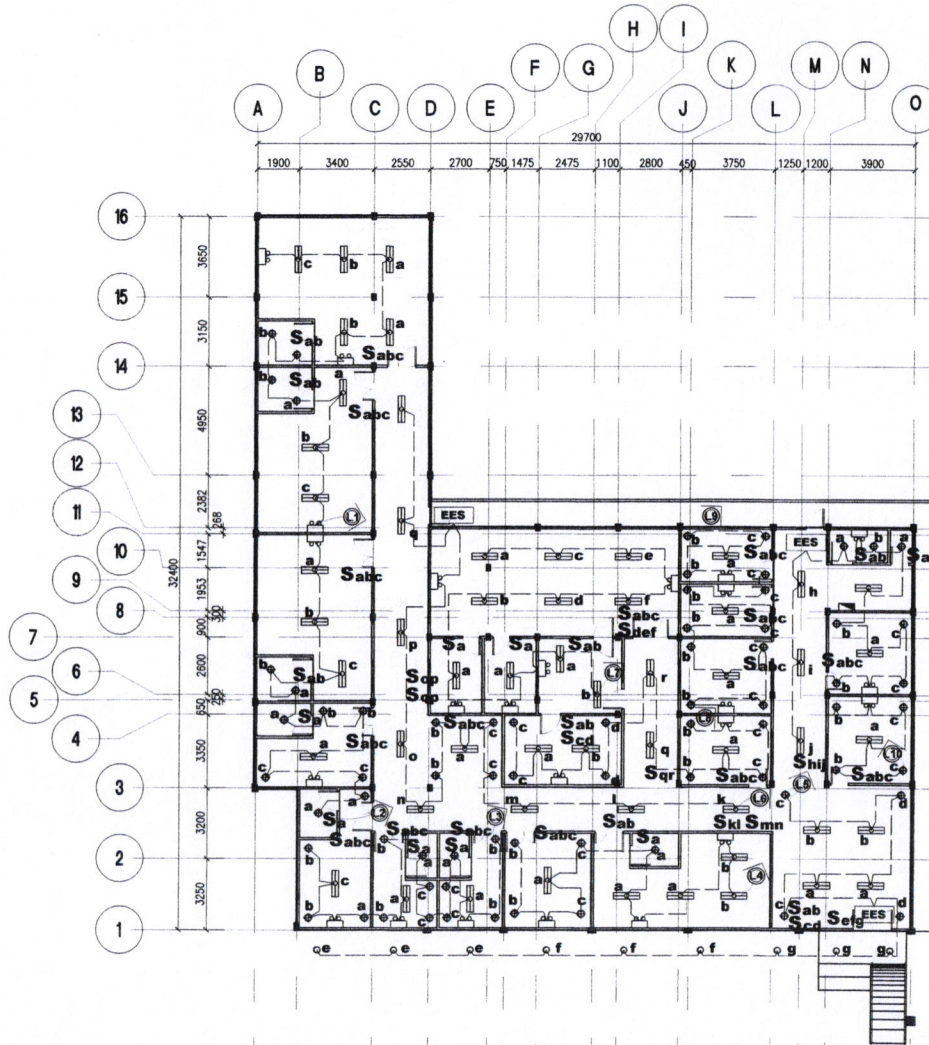

1 LIGHTING LAYOUT PLAN
E1 SCALE 1:250 M



Figure 1



Figure 2



Figure 4



Figure 5



Figure 3

LEGEND:

	PINLIGHT, RECESSED INDOOR LIGHTING, SEE FIG.1
	PINLIGHT, OUTDOOR LIGHTING, SEE FIG.2
	2 X T8 TUBE LIGHT W/ 2X40 LOUVER HOUSING RECESSED 12"X48", 300MM X 1200MM, SEE FIG. 3
	EMERGENCY EXIT SIGNAGE, SEE FIG. 4
	EMERGENCY LIGHT RECHARGEABLE, SEE FIG. 5

PROFESSIONAL ELECTRICAL ENGINEER	PRC. NO. : 0062782
	VALIDITY : OCT. 22, 2024
	PTR. NO. :
	ISSUED ON :
	ISSUED AT :
	TN. :

REPUBLIC ACT 9266
DRAWINGS AND SPECIFICATIONS DULY SIGNED, STAMPED OR SEALED AS INSTRUMENT OF SERVICE ARE THE PROPERTIES AND DOCUMENTS OF THE ARCHITECT OR AUTHOR WHETHER THE OBJECT FOR WHICH THEY ARE MADE IS EXECUTED OR NOT. IT SHALL BE UNLAWFUL FOR ANY PERSON, WITHOUT THE WRITTEN CONSENT OF THE ARCHITECT OR AUTHOR OF SAID DOCUMENTS TO DUPLICATE OR TO MAKE COPIES OF SAID DOCUMENTS FOR USE IN THE REPEITION OF AND FOR OTHER PROJECTS OR BUILDING, WHETHER EXECUTED PARTLY OR IN WHOLE

REVISION :	DATE	REVISED BY

PROJECT TITLE :
SORSOGON CITY CENTRAL BIRTHING HOME
SORSOGON CITY, SORSOGON

APPROVED BY :

HON. MA. ESTER E. HAMOR
CITY MAYOR

SHEET CONTENT'S :	DESIGNED :
	DRAWN :
	CHECKED :
	DATE :
	PROJECT NO. :


SHEET NO. :

KEY TO SYMBOLS

	SERVICE ENTRANCE
	KILOWATT HOUR METER
	PANEL BOARD
	CIRCUIT BREAKER
	CIRCUIT HOMERUN
	LIGHTING OUTLET
	DUPLEX CONVENIENCE OUTLET
	WEATHERPROOF CONVENIENCE OUTLET
S1	SINGLE POLE SWITCH
S2	DUPLEX SWITCH
S3	THREE WAY SWITCH
---	SWITCH LEG
---	LIGHTING CIRCUIT
---	POWER CIRCUIT
TS	TRANSFER SWITCH
AT	AMPERE TRIP
PB	PANEL BOARD

ELECTRICAL NOTES:

- ALL ELECTRICAL WORKS HEREIN SHALL COMPLY WITH THE PROVISIONS OF THE LATEST EDITION OF THE PHILIPPINE ELECTRICAL CODE, THE RULES & REGULATIONS OF SORSOGON CITY & SORSOGON ELECTRIC COOPERATIVE II.
- TYPE OF SERVICE SHALL BE 230VOLTS, 1 PHASE, 2 WIRE SYSTEM, 60HZ, AND THERE SHALL BE ONLY ONE SERVICE DROP TO THE BUILDING.
- METHOD OF WIRING FOR SERVICE ENTRANCE CONDUCTOR SHALL BE IN RIGID METAL CONDUIT & BRANCH CONDUIT IN POLYVINYL CHLORIDE FOR BOTH EXPOSED AND EMBEDDED WITH PROPER FITTINGS AND SUPPORT.
- ALL MATERIALS AND EQUIPMENTS SHALL BE BRAND NEW AND OF APPROVED TYPE FOR BOTH LOCATION AND PURPOSE INTENDED.
- ALL LIGHTINGS AND CONVENIENCE OUTLET, CIRCUIT HOMERUNS SHALL BE WIRED WITH NOT LESS THAN 2.0MM² RESPECTIVELY UNLESS OTHERWISE INDICATED ON THE PLAN.
- WHENEVER REQUIRED AND NECESSARY, PULL BOXES AND JUNCTION BOXES OF PROPER SIZES SHALL BE INSTALLED AT CONVENIENT AND CONSPICUOUS LOCATIONS ALTHOUGH SUCH BOXES ARE NOT SHOWN ON THE PLANS NOR MENTIONED IN THE SPECIFICATIONS.
- MOUNTING HEIGHTS SHALL BE AS FOLLOWS:
LIGHT SWITCH - 1.50M FROM FIN. FLOOR LINE
DUPLEX C.O. - 0.30M FROM FIN. FLOOR LINE / COUNTER
PANEL BOARD - 1.80M FROM FIN. FLOOR LINE.
- ALL OUTDOOR INSTALLATIONS SHALL BE WEATHERPROOF TYPE.
- ALL ELECTRICAL WORKS SHALL BE DONE UNDER THE DIRECT AND IMMEDIATE SUPERVISION OF A DULY LICENSED REGISTERED ELECTRICAL ENGINEER OR A REGISTERED MASTER ELECTRICIAN.

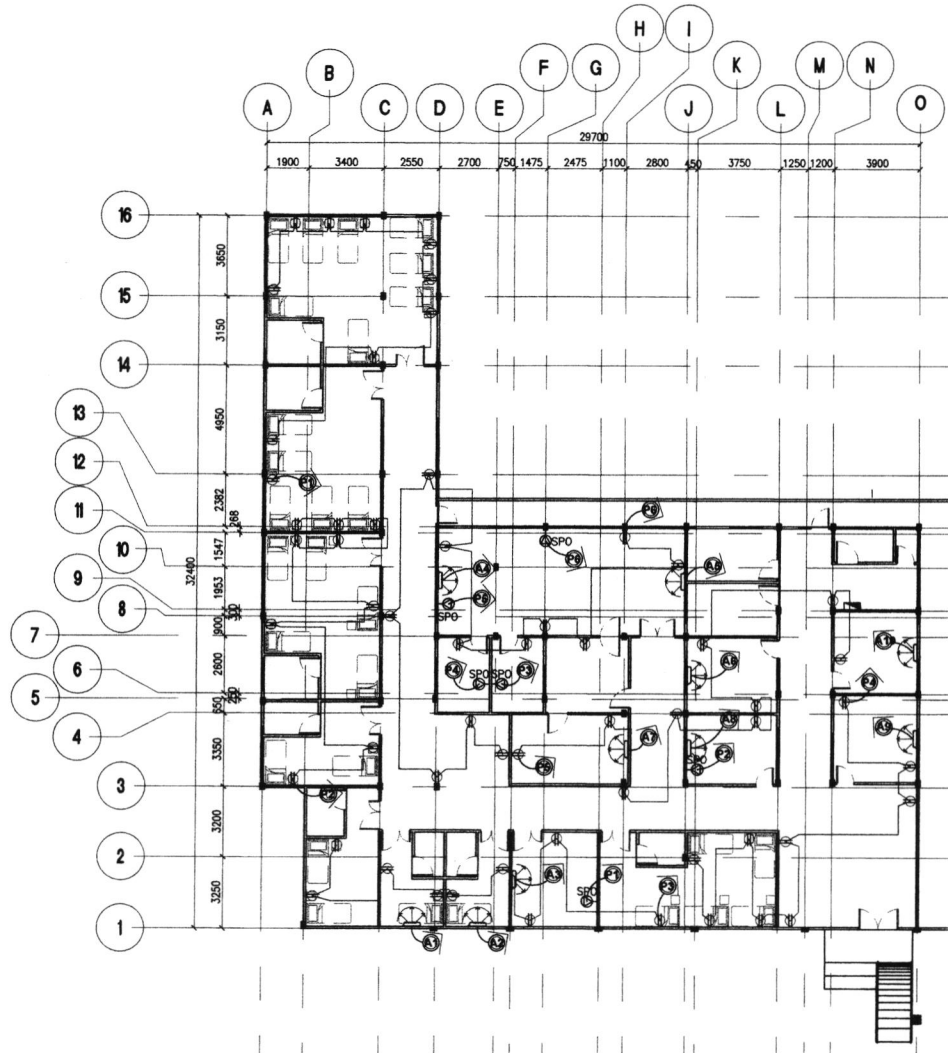

1 POWER LAYOUT PLAN
SCALE 1:250 M

CCT NO.	DESCRIPTION	NO. OF OUTLETS			POWER	CURRENT RATING	CB RATING		WIRES AND CONDUITS SIZE
		L.O.	C.O.	BYC			AT	P	
L1	LIGHTING OUTLET	16			120	0.82	16	2	2-0.8MM ² THHN-CU STRANDED WIRE GROUND, BMT THINWALL, 1-0.8MM ² THHN-CU GROUNDING WIRE GROUND BMT THINWALL
L2	LIGHTING OUTLET	16			120	0.82	16	2	2-0.8MM ² THHN-CU STRANDED WIRE GROUND, BMT THINWALL, 1-0.8MM ² THHN-CU GROUNDING WIRE GROUND BMT THINWALL
L3	LIGHTING OUTLET	19			102	0.66	16	2	2-0.8MM ² THHN-CU STRANDED WIRE GROUND, BMT THINWALL, 1-0.8MM ² THHN-CU GROUNDING WIRE GROUND BMT THINWALL
L4	LIGHTING OUTLET	13			104	0.60	16	2	2-0.8MM ² THHN-CU STRANDED WIRE GROUND, BMT THINWALL, 1-0.8MM ² THHN-CU GROUNDING WIRE GROUND BMT THINWALL
L5	LIGHTING OUTLET	16			144	0.82	16	2	2-0.8MM ² THHN-CU STRANDED WIRE GROUND, BMT THINWALL, 1-0.8MM ² THHN-CU GROUNDING WIRE GROUND BMT THINWALL
L6	LIGHTING OUTLET	16			120	0.82	16	2	2-0.8MM ² THHN-CU STRANDED WIRE GROUND, BMT THINWALL, 1-0.8MM ² THHN-CU GROUNDING WIRE GROUND BMT THINWALL
L7	LIGHTING OUTLET	14			112	0.60	16	2	2-0.8MM ² THHN-CU STRANDED WIRE GROUND, BMT THINWALL, 1-0.8MM ² THHN-CU GROUNDING WIRE GROUND BMT THINWALL
L8	LIGHTING OUTLET	16			120	0.82	16	2	2-0.8MM ² THHN-CU STRANDED WIRE GROUND, BMT THINWALL, 1-0.8MM ² THHN-CU GROUNDING WIRE GROUND BMT THINWALL
L9	LIGHTING OUTLET	16			144	0.82	16	2	2-0.8MM ² THHN-CU STRANDED WIRE GROUND, BMT THINWALL, 1-0.8MM ² THHN-CU GROUNDING WIRE GROUND BMT THINWALL
L10	LIGHTING OUTLET	21			108	0.73	16	2	2-0.8MM ² THHN-CU STRANDED WIRE GROUND, BMT THINWALL, 1-0.8MM ² THHN-CU GROUNDING WIRE GROUND BMT THINWALL
P1	CONVENIENCE OUTLET	10			1000	7.62	20	2	2-3.0MM ² THHN-CU STRANDED WIRE GROUND, BMT THINWALL, 1-3.0MM ² THHN-CU GROUNDING WIRE GROUND BMT THINWALL
P2	CONVENIENCE OUTLET	9			1020	7.64	20	2	2-3.0MM ² THHN-CU STRANDED WIRE GROUND, BMT THINWALL, 1-3.0MM ² THHN-CU GROUNDING WIRE GROUND BMT THINWALL
P3	CONVENIENCE OUTLET	9			1020	7.64	20	2	2-3.0MM ² THHN-CU STRANDED WIRE GROUND, BMT THINWALL, 1-3.0MM ² THHN-CU GROUNDING WIRE GROUND BMT THINWALL
P4	CONVENIENCE OUTLET	9			1020	7.64	20	2	2-3.0MM ² THHN-CU STRANDED WIRE GROUND, BMT THINWALL, 1-3.0MM ² THHN-CU GROUNDING WIRE GROUND BMT THINWALL
P5	CONVENIENCE OUTLET	9			1020	7.64	20	2	2-3.0MM ² THHN-CU STRANDED WIRE GROUND, BMT THINWALL, 1-3.0MM ² THHN-CU GROUNDING WIRE GROUND BMT THINWALL
P6	CONVENIENCE OUTLET	12			2160	8.30	20	2	2-3.0MM ² THHN-CU STRANDED WIRE GROUND, BMT THINWALL, 1-3.0MM ² THHN-CU GROUNDING WIRE GROUND BMT THINWALL

1" = 127.44 MM = 4.99 IN A
230 V

USE 100AT, 2P, 60HZ, BOLT-ON
2-0.8MM² THHN-CU CONDUCTOR
@ 41MM² PVC 1-0.8 EGC


CCT NO.	DESCRIPTION	NO. OF OUTLETS			POWER	CURRENT RATING	CB RATING		WIRES AND CONDUITS SIZE
		L.O.	C.O.	BYC			AT	P	
P1	CONVENIENCE OUTLET	1			1000	4.34	20	2	2-3.0MM ² THHN-CU STRANDED WIRE GROUND, BMT THINWALL, 1-3.0MM ² THHN-CU GROUNDING WIRE GROUND BMT THINWALL
P2	CONVENIENCE OUTLET	1			1000	4.34	20	2	2-3.0MM ² THHN-CU STRANDED WIRE GROUND, BMT THINWALL, 1-3.0MM ² THHN-CU GROUNDING WIRE GROUND BMT THINWALL
P3	AUTO CLAVE MACHINE	1			3300	12.91	40	2	2-6.0MM ² THHN-CU STRANDED WIRE GROUND, BMT THINWALL, 1-6.0MM ² THHN-CU GROUNDING WIRE GROUND BMT THINWALL
P4	CONVENIENCE OUTLET	1			1000	4.34	20	2	2-3.0MM ² THHN-CU STRANDED WIRE GROUND, BMT THINWALL, 1-3.0MM ² THHN-CU GROUNDING WIRE GROUND BMT THINWALL
P5	CONVENIENCE OUTLET	1			1000	4.34	20	2	2-3.0MM ² THHN-CU STRANDED WIRE GROUND, BMT THINWALL, 1-3.0MM ² THHN-CU GROUNDING WIRE GROUND BMT THINWALL
P6	CONVENIENCE OUTLET	1			1000	4.34	20	2	2-3.0MM ² THHN-CU STRANDED WIRE GROUND, BMT THINWALL, 1-3.0MM ² THHN-CU GROUNDING WIRE GROUND BMT THINWALL
A1	ACU OUTLET	1			910	3.90	30	2	2-4.0MM ² THHN-CU STRANDED WIRE GROUND, BMT THINWALL, 1-4.0MM ² THHN-CU GROUNDING WIRE GROUND BMT THINWALL
A2	ACU OUTLET	1			910	3.90	30	2	2-4.0MM ² THHN-CU STRANDED WIRE GROUND, BMT THINWALL, 1-4.0MM ² THHN-CU GROUNDING WIRE GROUND BMT THINWALL
A3	ACU OUTLET	1			910	3.90	30	2	2-4.0MM ² THHN-CU STRANDED WIRE GROUND, BMT THINWALL, 1-4.0MM ² THHN-CU GROUNDING WIRE GROUND BMT THINWALL
A4	ACU OUTLET	1			910	3.90	30	2	2-4.0MM ² THHN-CU STRANDED WIRE GROUND, BMT THINWALL, 1-4.0MM ² THHN-CU GROUNDING WIRE GROUND BMT THINWALL
A5	ACU OUTLET	1			910	3.90	30	2	2-4.0MM ² THHN-CU STRANDED WIRE GROUND, BMT THINWALL, 1-4.0MM ² THHN-CU GROUNDING WIRE GROUND BMT THINWALL
A6	ACU OUTLET	1			910	3.90	30	2	2-4.0MM ² THHN-CU STRANDED WIRE GROUND, BMT THINWALL, 1-4.0MM ² THHN-CU GROUNDING WIRE GROUND BMT THINWALL
A7	ACU OUTLET	1			910	3.90	30	2	2-4.0MM ² THHN-CU STRANDED WIRE GROUND, BMT THINWALL, 1-4.0MM ² THHN-CU GROUNDING WIRE GROUND BMT THINWALL
A8	ACU OUTLET	1			910	3.90	30	2	2-4.0MM ² THHN-CU STRANDED WIRE GROUND, BMT THINWALL, 1-4.0MM ² THHN-CU GROUNDING WIRE GROUND BMT THINWALL
A9	ACU OUTLET	1			910	3.90	30	2	2-4.0MM ² THHN-CU STRANDED WIRE GROUND, BMT THINWALL, 1-4.0MM ² THHN-CU GROUNDING WIRE GROUND BMT THINWALL
A10	ACU OUTLET	1			910	3.90	30	2	2-4.0MM ² THHN-CU STRANDED WIRE GROUND, BMT THINWALL, 1-4.0MM ² THHN-CU GROUNDING WIRE GROUND BMT THINWALL

1" = 127.00 MM = 5.0 (200) IN A
230 V

USE 100AT, 2P, 60HZ, BOLT-ON
2-3.0MM² THHN-CU CONDUCTOR
@ 41MM² PVC

1" TOTAL = 1.0MM² (3000)
= 0.30MM² = 0.30MM²
= 0.30MM²

USE 100AT, 2P, 60HZ
2-3.0MM² THHN-CU @ 41MM² PVC
@ 23.0 EGC

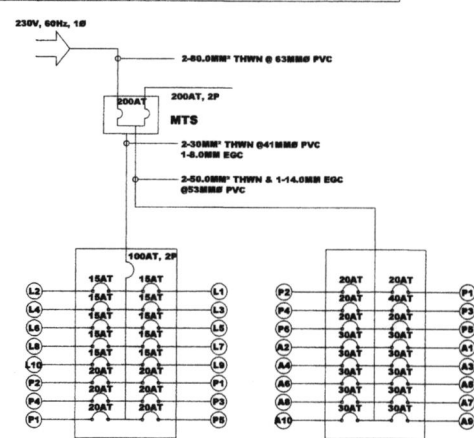

PROFESSIONAL ELECTRICAL ENGINEER

PRC. NO. : 0062782
VALIDITY : OCT. 22, 2024
PTR. NO. :
ISSUED ON :
ISSUED AT :
TN :

REPUBLIC ACT 9266
DRAWINGS AND SPECIFICATIONS DULY SIGNED, STAMPED OR SEALED AS INSTRUMENT OF SERVICE ARE THE PROPERTIES AND DOCUMENTS OF THE ARCHITECT OR AUTHOR WHETHER THE OBJECT FOR WHICH THEY ARE MADE IS EXECUTED OR NOT. IT SHALL BE UNLAWFUL FOR ANY PERSON, WITHOUT THE WRITTEN CONSENT OF THE ARCHITECT OR AUTHOR OF SAID DOCUMENTS TO DUPLICATE OR TO MAKE COPIES OF SAID DOCUMENTS FOR USE IN THE REPEITION OF AND FOR OTHER PROJECTS OR BUILDING, WHETHER EXECUTED PARTLY OR IN WHOLE.

REVISION :	DATE	REVISOR BY

PROJECT TITLE :
SORSOGON CITY CENTRAL BIRTHING HOME
SORSOGON CITY, SORSOGON

APPROVED BY :
HON. MRS. ESTER E. HAMOR
CITY MAYOR

SHEET CONTENTS :

DESIGNED :
DRAWN :
CHECKED :
DATE :
PROJECT NO.


SHEET NO. :

KEY TO SYMBOLS

WC	WATER CLOSET
LAV	LAVATORY
FD	FLOOR DRAIN
CO	CLEAN OUT
VSTR	VENT STACK THRU ROOF
F	FAUCET
MH	MAN HOLE
DS	DOWN SPOUT
GV	GATE VALVE
CV	CHECK VALVE
CWL	COLD WATER LINE
WPL	WASTE PIPE LINE
GIP	GALVANIZED IRON PIPE
PVC	POLYVINYL CHLORIDE
KS	KITCHEN SINK
CB	CATCH BASIN
RD	ROOF DRAIN
ST	SEPTIC TANK
WM	WATER METER

PLUMBING / SANITARY NOTES

- ALL SANITARY WORKS INCLUDED HEREIN SHALL BE EXECUTED ACCORDING TO THE PROVISION OF THE PHILIPPINE NATIONAL SANITATION CODE; THE NATIONAL BUILDING CODE AND THE RULES AND REGULATION OF SORSOGON CITY.
- COORDINATE THE DRAWINGS WITH OTHER INDICATED, ANY RELOCATION REQUIRED FOR PROPER EXECUTION OF OTHER TRADES SHALL BE WITH PRIOR APPROVAL OF THE DESIGNER.
- ALL PIPES SHALL BE INSTALLED AS INDICATED, ANY RELOCATED REQUIRED FOR PROPER EXECUTION OF OTHER TRADES SHALL BE WITH PRIOR APPROVAL OF THE DESIGNER.
- ALL SLOPES FOR HORIZONTAL DRAINAGE AND SEWER LINES SHALL MAINTAIN A MINIMUM SLOPE UNLESS OTHERWISE SPECIFIED
- ALL MATERIALS TO BE USED SHALL BE BRAND NEW AND OF APPROVED TYPE APPROPRIATE FOR BOTH LOCATION AND INTENDED USE
- ALL PLUMBING INSTALLATION SHALL BE UNDER THE DIRECT SUPERVISION OF A DULY LICENSED MASTER PLUMBER / SANITARY ENGINEER.
- PROVIDE ISOLATION VALVE FOR EVERY TOILET ROOM (H2O LINE).
- SEPTIC TANK CONSTRUCTION MUST FOLLOW SECTION 233 OF THE NATIONAL BUILDING CODE.

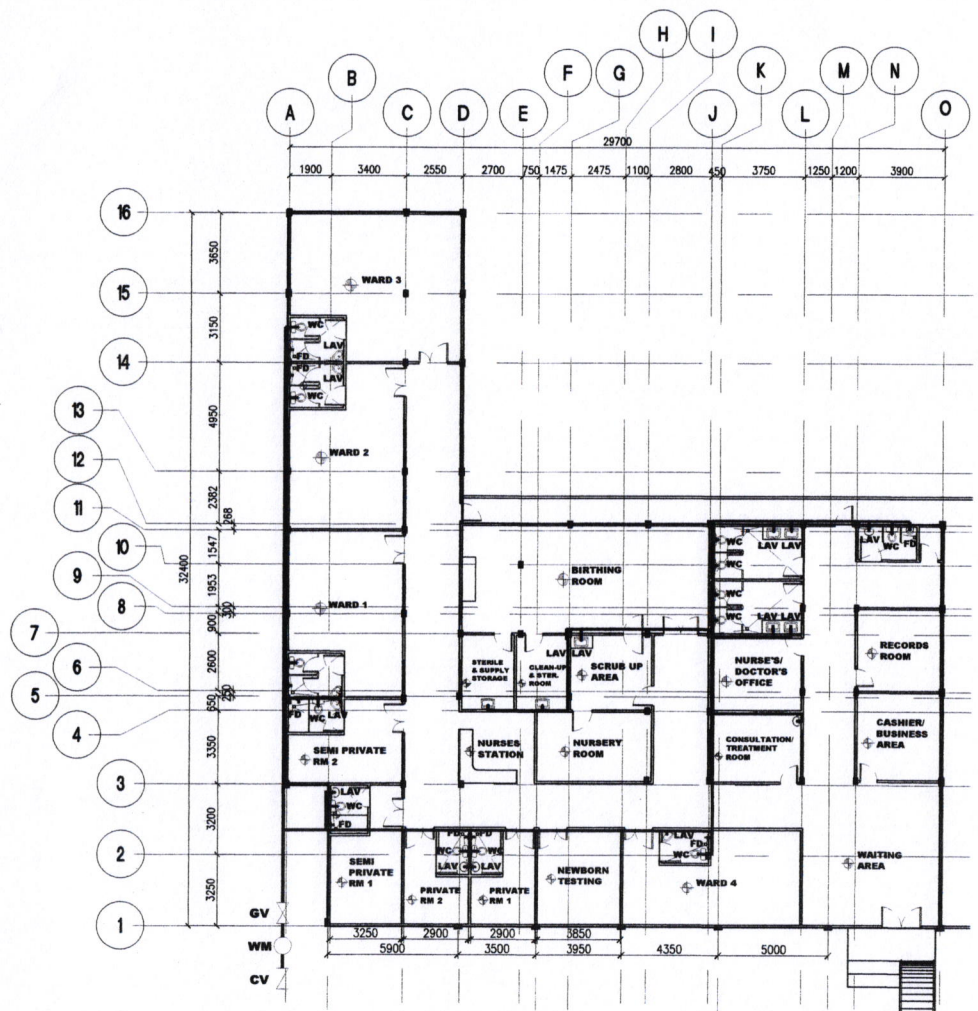

1 WATER LAYOUT PLAN
P-1 SCALE 1:250M


REG. NO. : VALIDITY : JAPON NO. : VALIDITY : PTR NO. : ISSUED ON : ISSUED AT : TIN :	REPUBLIC ACT 9266 DRAWINGS AND SPECIFICATIONS DULY SIGNED, STAMPED OR SEALED AS INSTRUMENT OF SERVICE ARE THE PROPERTIES AND DOCUMENTS OF THE ARCHITECT OR AUTHOR WHETHER THE OBJECT FOR WHICH THEY ARE MADE IS EXECUTED OR NOT. IT SHALL BE UNLAWFUL FOR ANY PERSON, WITHOUT THE WRITTEN CONSENT OF THE ARCHITECT OR AUTHOR OF SAID DOCUMENTS TO DUPLICATE OR TO MAKE COPIES OF SAID DOCUMENTS FOR USE IN THE REPEITION OF AND FOR OTHER PROJECTS OR BUILDING, WHETHER EXECUTED PARTLY OR IN WHOLE	REVISION : <table border="1"> <tr><th>NO.</th><th>DATE</th><th>REVISION</th></tr> <tr><td> </td><td> </td><td> </td></tr> <tr><td> </td><td> </td><td> </td></tr> <tr><td> </td><td> </td><td> </td></tr> </table>	NO.	DATE	REVISION										PROJECT TITLE : SORSOGON CITY CENTRAL BIRTHING HOME SORSOGON CITY, SORSOGON	APPROVED BY : HON. MA. ESTER E. HAMOR CITY MAYOR	SHEET CONTENT'S : DESIGNED : DRAWN : CHECKED : DATE : PROJECT NO. :	SHEET NO. :
	NO.	DATE	REVISION															
REGISTERED MASTER PLUMBER																		

KEY TO SYMBOLS

WC	WATER CLOSET
LAV	LAVATORY
FD	FLOOR DRAIN
CD	CLEAN OUT
VSTR	VENT STACK THRU ROOF
F	FAUCET
MH	MAN HOLE
DS	DOWN SPOUT
GV	GATE VALVE
CV	CHECK VALVE
CWL	COLD WATER LINE
WPL	WASTE PIPE LINE
GIP	GALVANIZED IRON PIPE
PVC	POLYVINYL CHLORIDE
KS	KITCHEN SINK
CB	CATCH BASIN
RD	ROOF DRAIN
ST	SEPTIC TANK
WM	WATER METER

PLUMBING / SANITARY NOTES

- ALL SANITARY WORKS INCLUDED HEREIN SHALL BE EXECUTED ACCORDING TO THE PROVISION OF THE PHILIPPINE NATIONAL SANITATION CODE: THE NATIONAL BUILDING CODE AND THE RULES AND REGULATION OF SORSOGON CITY.
- COORDINATE THE DRAWINGS WITH OTHER INDICATED, ANY RELOCATION REQUIRED FOR PROPER EXECUTION OF OTHER TRADES SHALL BE WITH PRIOR APPROVAL OF THE DESIGNER.
- ALL PIPES SHALL BE INSTALLED AS INDICATED, ANY RELOCATED REQUIRED FOR PROPER EXECUTION OF OTHER TRADES SHALL BE WITH PRIOR APPROVAL OF THE DESIGNER.
- ALL SLOPES FOR HORIZONTAL DRAINAGE AND SEWER LINES SHALL MAINTAIN 1/8" MINIMUM SLOPE UNLESS OTHERWISE SPECIFIED
- ALL MATERIALS TO BE USED SHALL BE BRAND NEW AND OF APPROVED TYPE APPROPRIATE FOR BOTH LOCATION AND INTENDED USE
- ALL PLUMBING INSTALLATION SHALL BE UNDER THE DIRECT SUPERVISION OF A DULY LICENSED MASTER PLUMBER / SANITARY ENGINEER.
- PROVIDE ISOLATION VALVE FOR EVERY TOILET ROOM (H2O LINE).
- SEPTIC TANK CONSTRUCTION MUST FOLLOW SECTION 233 OF THE NATIONAL BUILDING CODE.

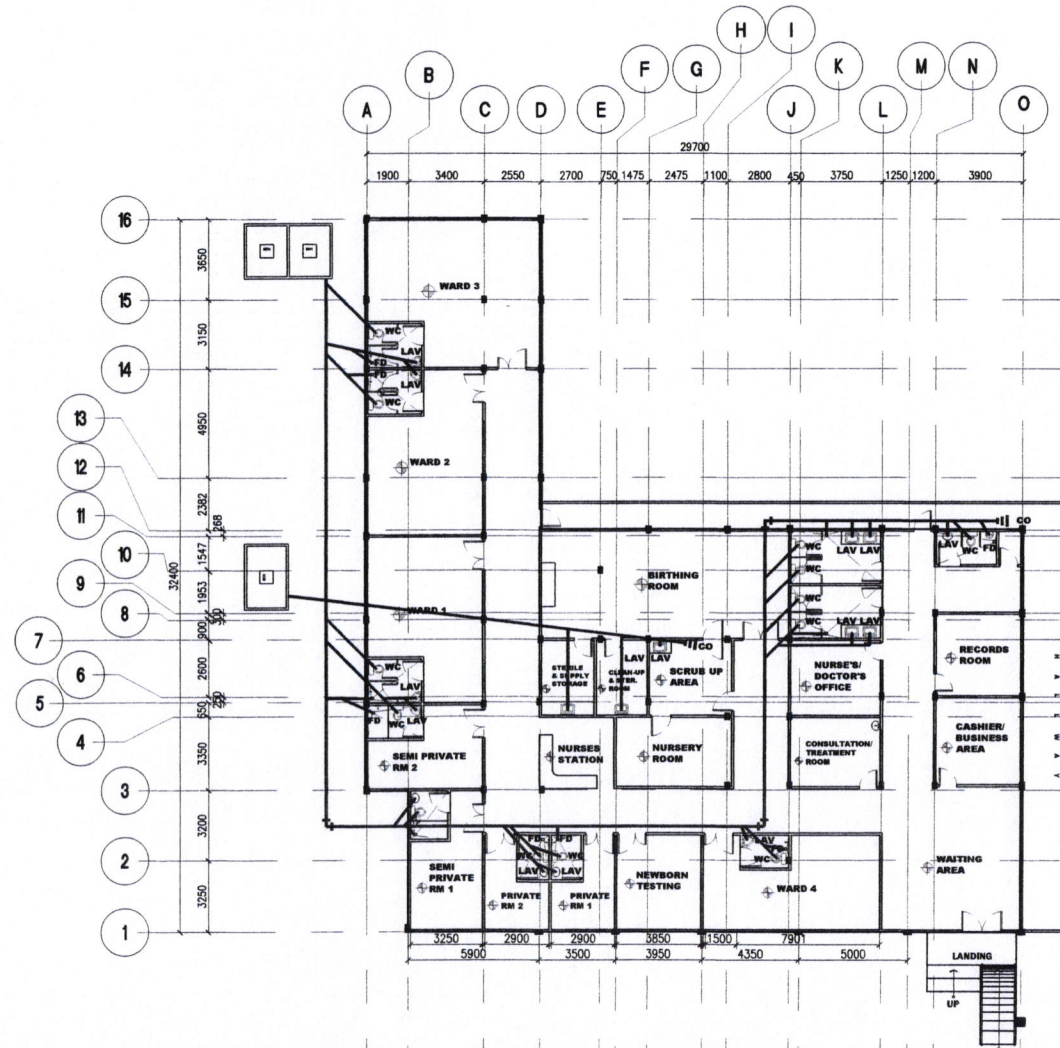

1 SANITARY LAYOUT PLAN
SCALE 1:250M


REGISTERED MASTER PLUMBER PRC. NO. : VALIDITY : IAPDA NO. : VALIDITY : PTR. NO. : ISSUED ON : ISSUED AT : TIN :	REPUBLIC ACT 9266 DRAWINGS AND SPECIFICATIONS DULY SIGNED, STAMPED OR SEALED AS INSTRUMENT OF SERVICE ARE THE PROPERTIES AND DOCUMENTS OF THE ARCHITECT OR AUTHOR WHETHER THE OBJECT FOR WHICH THEY ARE MADE IS EXECUTED OR NOT. IT SHALL BE UNLAWFUL FOR ANY PERSON, WITHOUT THE WRITTEN CONSENT OF THE ARCHITECT OR AUTHOR OF SAID DOCUMENTS TO DUPLICATE OR TO MAKE COPIES OF SAID DOCUMENTS FOR USE IN THE REPEITION OF AND FOR OTHER PROJECTS OR BUILDING, WHETHER EXECUTED PARTLY OR IN WHOLE.	REVISION : <table border="1"> <thead> <tr><th>NO.</th><th>DATE</th><th>REVISION BY</th></tr> </thead> <tbody> <tr><td> </td><td> </td><td> </td></tr> <tr><td> </td><td> </td><td> </td></tr> <tr><td> </td><td> </td><td> </td></tr> </tbody> </table>	NO.	DATE	REVISION BY										PROJECT TITLE : SORSOGON CITY CENTRAL BIRTHING HOME SORSOGON CITY, SORSOGON	APPROVED BY : HON. MA. ESMERALDA HAMOR CITY MAYOR	SHEET CONTENT'S : DESIGNED : DRAWN : CHECKED : DATE : PROJECT NO.	SHEET NO. :
	NO.	DATE	REVISION BY															

KEY TO SYMBOLS


WC	WATER CLOSET
LAV	LAVATORY
FD	FLOOR DRAIN
CO	CLEAN OUT
VSTR	VENT STACK THRU ROOF
F	FAUCET
MH	MAN HOLE
DS	DOWN SPOUT
GV	GATE VALVE
CV	CHECK VALVE
CWL	COLD WATER LINE
WPL	WASTE PIPE LINE
GIP	GALVANIZED IRON PIPE
PVC	POLYVINYL CHLORIDE
KS	KITCHEN SINK
CB	CATCH BASIN
RD	ROOF DRAIN
ST	SEPTIC TANK
WM	WATER METER

PLUMBING / SANITARY NOTES


- ALL SANITARY WORKS INCLUDED HEREIN SHALL BE EXECUTED ACCORDING TO THE PROVISIONS OF THE PHILIPPINE NATIONAL SANITATION CODE: THE NATIONAL BUILDING CODE AND THE RULES AND REGULATION OF SORSOGON CITY. COORDINATE THE DRAWINGS WITH OTHER INDICATED, ANY RELOCATION REQUIRED FOR PROPER EXECUTION OF OTHER TRADES SHALL BE WITH PRIOR APPROVAL OF THE DESIGNER.
- ALL PIPES SHALL BE INSTALLED AS INDICATED, ANY RELOCATED REQUIRED FOR PROPER EXECUTION OF OTHER TRADES SHALL BE WITH PRIOR APPROVAL OF THE DESIGNER.
- ALL SLOPES FOR HORIZONTAL DRAINAGE AND SEWER LINES SHALL MAINTAIN 1% MINIMUM SLOPE UNLESS OTHERWISE SPECIFIED
- ALL MATERIALS TO BE USED SHALL BE BRAND NEW AND OF APPROVED TYPE APPROPRIATE FOR BOTH LOCATION AND INTENDED USE
- ALL PLUMBING INSTALLATION SHALL BE UNDER THE DIRECT SUPERVISION OF A DULY LICENSED MASTER PLUMBER / SANITARY ENGINEER.
- PROVIDE ISOLATION VALVE FOR EVERY TOILET ROOM (H2O LINE).
- SEPTIC TANK CONSTRUCTION MUST FOLLOW SECTION 233 OF THE NATIONAL BUILDING CODE.

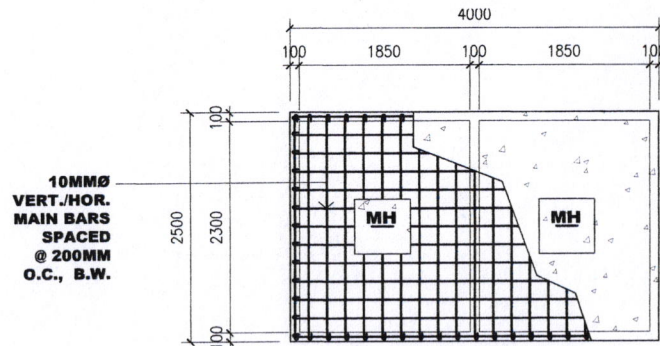


1 SEPTIC TANK PLAN
SCALE 1:60M

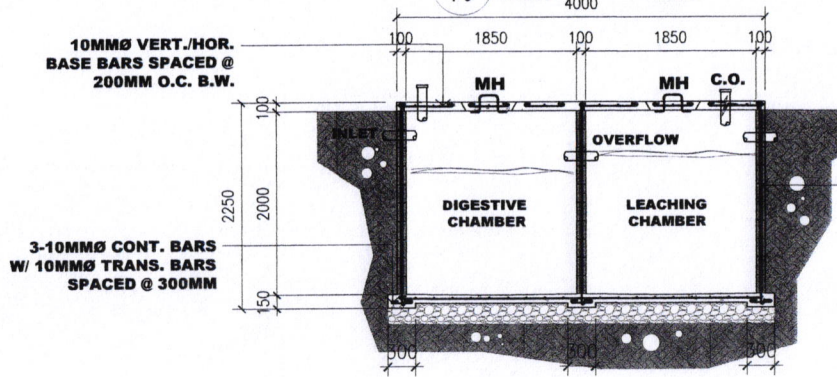

1 SEPTIC TANK SECTION
SCALE 1:60M

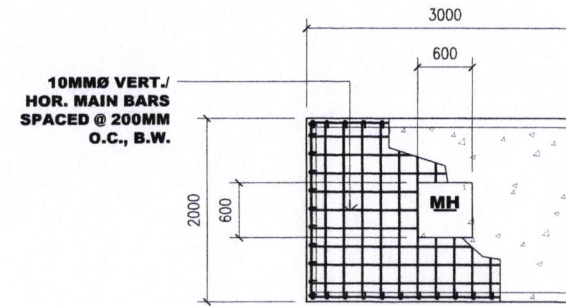

3 HAZMAT PLAN
SCALE 1:60M

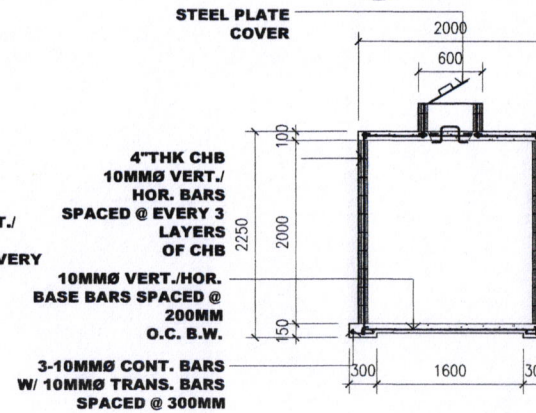

2 HAZMAT SECTION
SCALE 1:60M

REGISTERED MASTER PLUMBER PRC. NO. : VALIDITY : JAPDA NO. : VALIDITY : PTR NO. : ISSUED ON : ISSUED AT : TN. :	REPUBLIC ACT 9266 DRAWINGS AND SPECIFICATIONS DULY SIGNED, STAMPED OR SEALED AS INSTRUMENT OF SERVICE ARE THE PROPERTIES AND DOCUMENTS OF THE ARCHITECT OR AUTHOR WHETHER THE OBJECT FOR WHICH THEY ARE MADE OR EXECUTED OR NOT. IT SHALL BE UNLAWFUL FOR ANY PERSON, WITHOUT THE WRITTEN CONSENT OF THE ARCHITECT OR AUTHOR OF SAID DOCUMENTS TO DUPLICATE OR TO MAKE COPIES OF SAID DOCUMENTS FOR USE IN THE REPEATITION OF AND FOR OTHER PROJECTS OR BUILDING, WHETHER EXECUTED PARTLY OR IN WHOLE	REVISION : <table border="1"> <tr><th>NO.</th><th>DATE</th><th>REVISION BY</th></tr> <tr><td> </td><td> </td><td> </td></tr> <tr><td> </td><td> </td><td> </td></tr> <tr><td> </td><td> </td><td> </td></tr> </table>	NO.	DATE	REVISION BY										PROJECT TITLE : SORSOGON CITY CENTRAL BIRTHING HOME SORSOGON CITY, SORSOGON	APPROVED BY : HON. MAESTRO E. HAMOR CITY MAYOR	SHEET CONTENT'S : DESIGNED : DRAWN : CHECKED : DATE : PROJECT NO.	SHEET NO. :
	NO.	DATE	REVISION BY															