


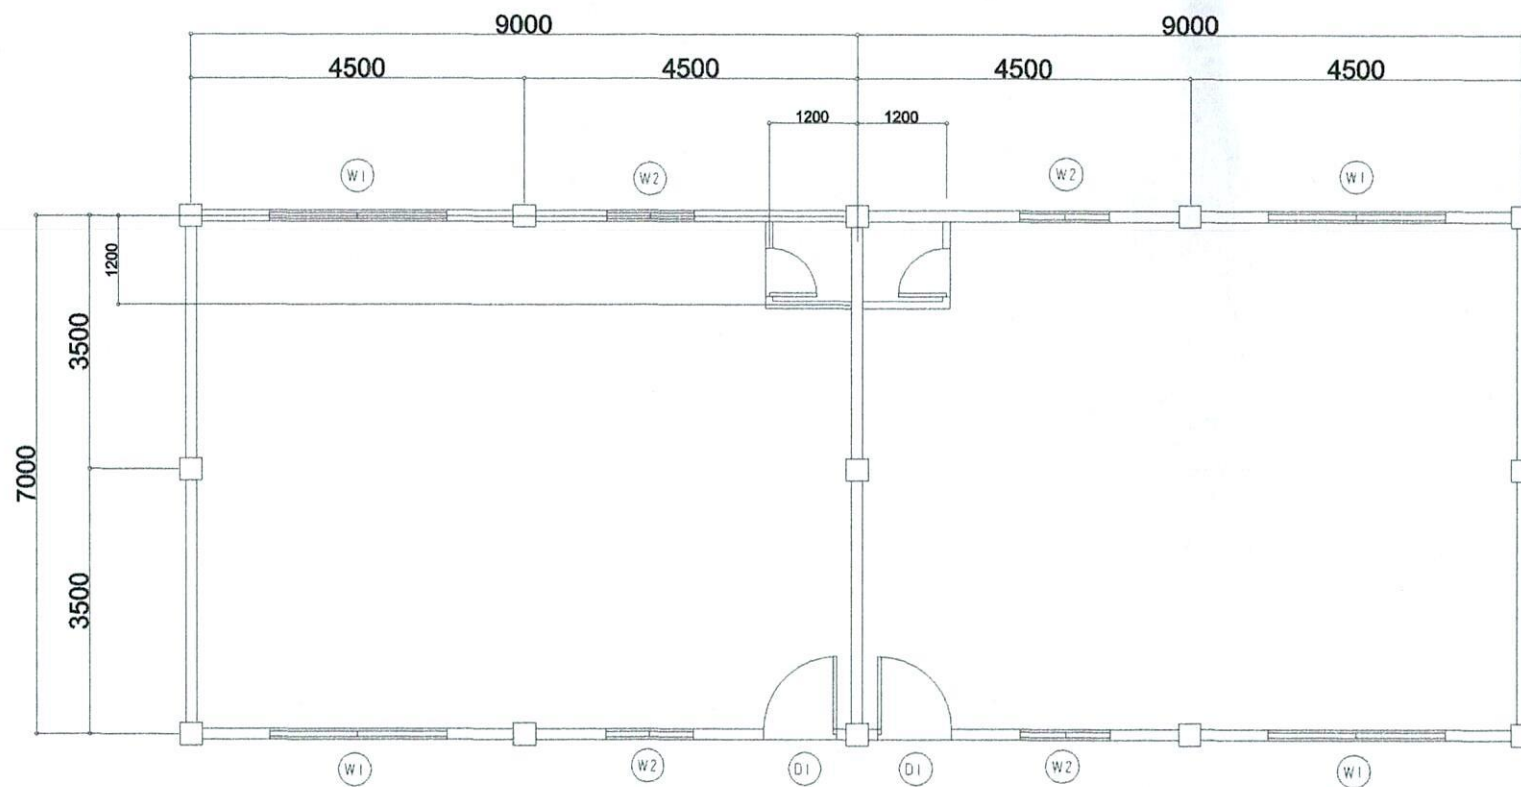

EXISTING FLOOR PLAN
SCALE: 1:200



CITY ENGINEER'S
O F F I C E

PROJECT TITLE:

CONST. OF MULTI PURPOSE HALL
(CLASSROOM)

LOC: BRGY. PANGPANG, WEST DISTRICT
SORSOGON CITY

DRAWN BY:


Ma Pamela Legaspi
DRAFTING AIDE

RECOMMENDING APPROVAL:


ROEL D. DOMER, C.E./RMP
CITY ENGINEER

APPROVED BY:

MA. ESTER E. HAMOR
CITY MAYOR

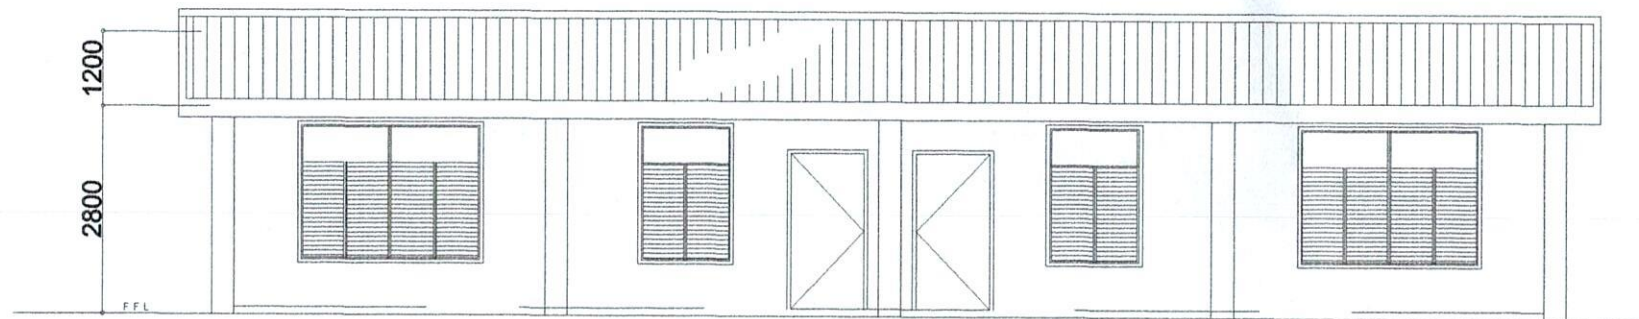

FRONT ELEVATION
SCALE: 1/250

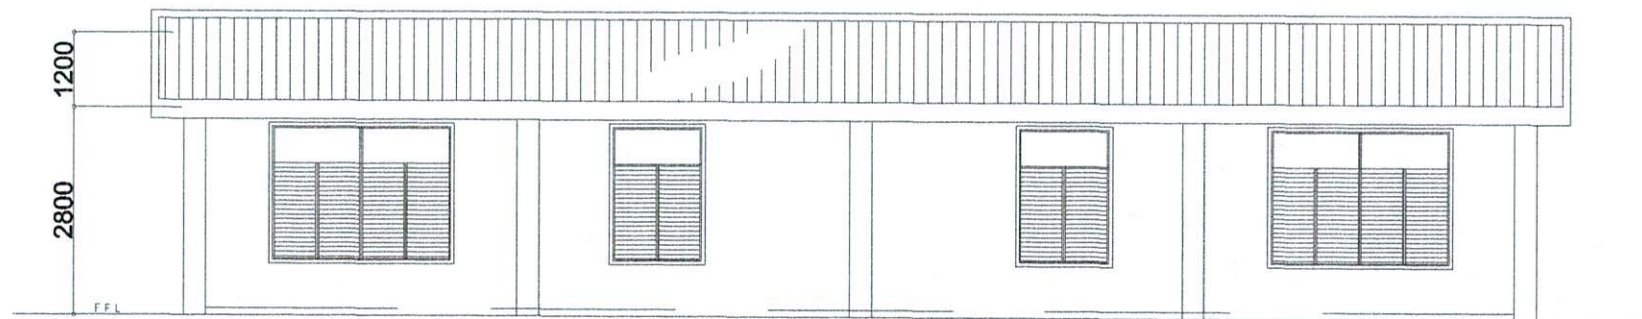

REAR ELEVATION
SCALE: 1/250



CITY ENGINEER'S
OFFICE

PROJECT TITLE:

CONST. OF MULTI PURPOSE HALL
(CLASSROOM)

LOC: BRGY. PANGPANG, WEST DISTRICT
SORSOGON CITY

DRAWN BY:







Ma Pamela Legaspi
DRAFTING AIDE

RECOMMENDING APPROVAL:

ROEL D. DOMER, C.E./RMP
CITY ENGINEER

APPROVED BY:

MA. ESTER E. HAMOR
CITY MAYOR

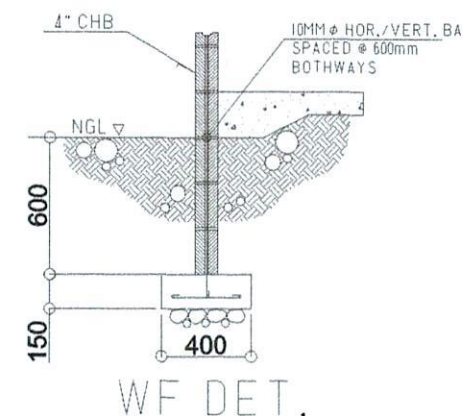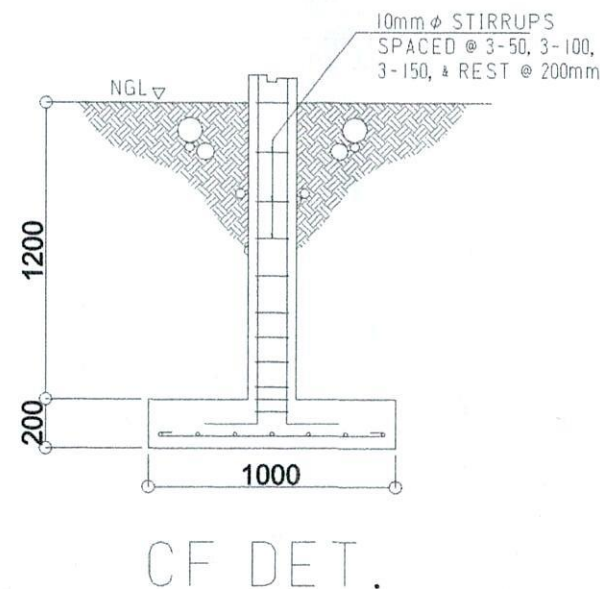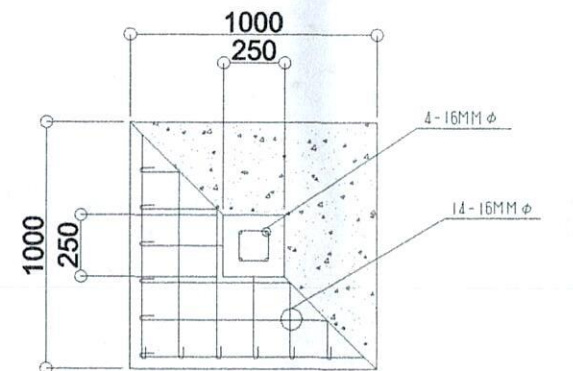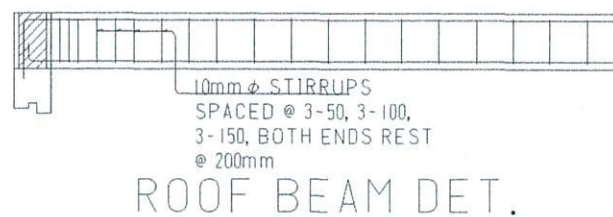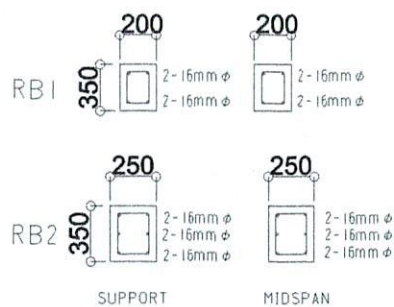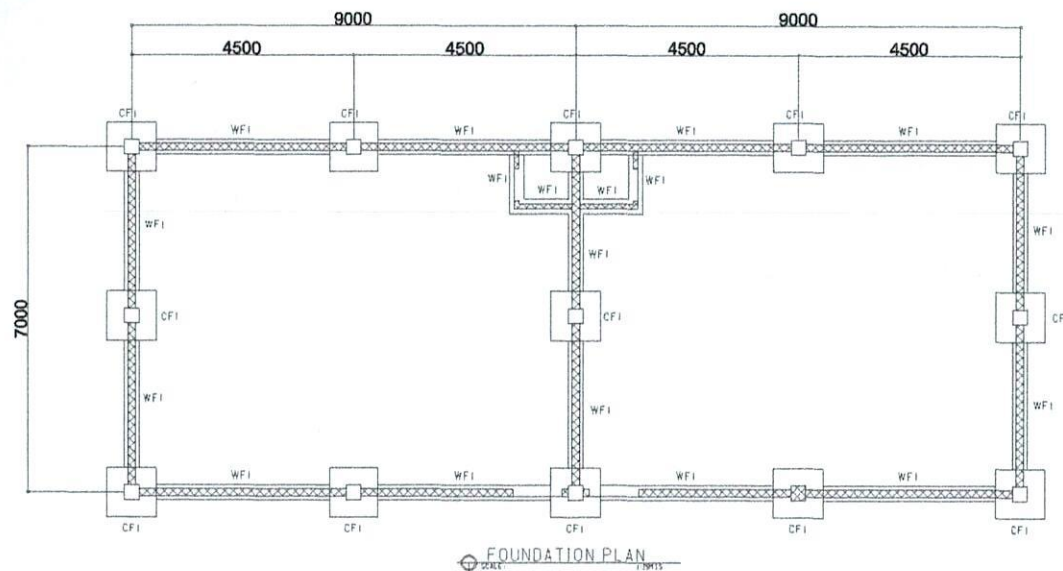

CITY ENGINEER'S
OFFICE

PROJECT TITLE:

CONST. OF MULTI PURPOSE HALL
(CLASSROOM)

LOC: BRGY. PANGPANG, WEST DISTRICT
SORSOGON CITY

DRAWN BY:




Ma Pamela Legaspi
DRAFTING AIDE

RECOMMENDING APPROVAL:



ROEL D. DOMER, C.E./RMP
CITY ENGINEER

APPROVED BY:


MA. ESTER E. HAMOR
CITY MAYOR

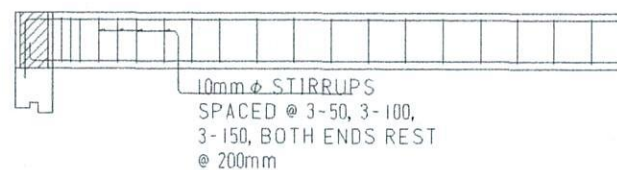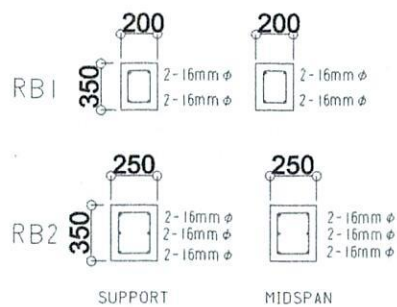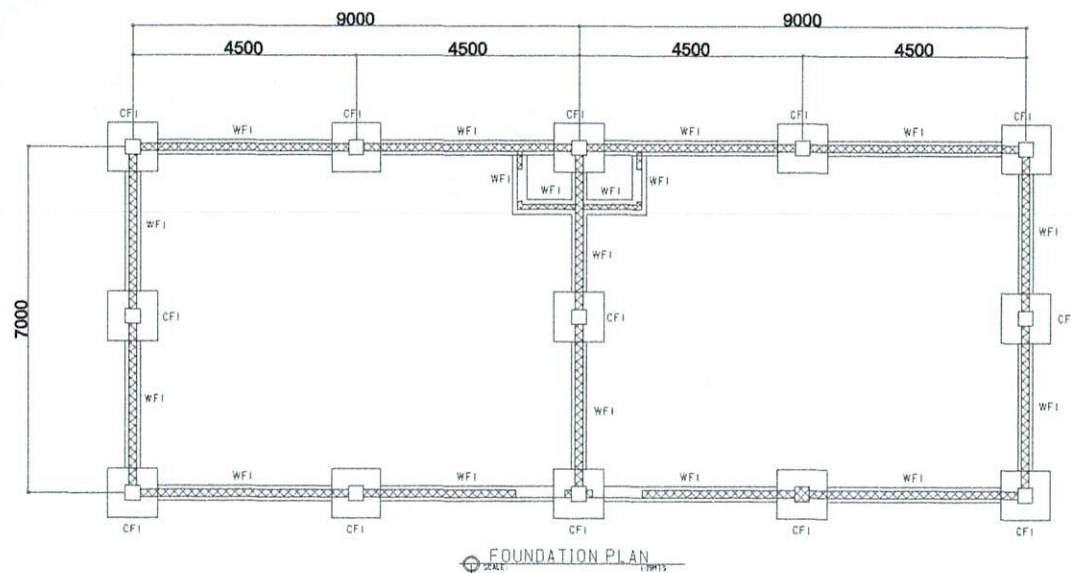

ROOF BEAM DET.

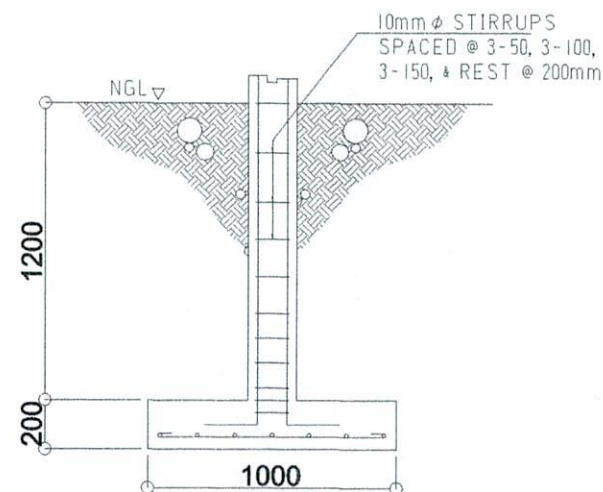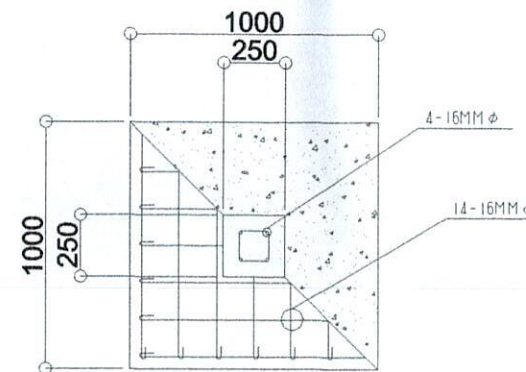

CF DET.

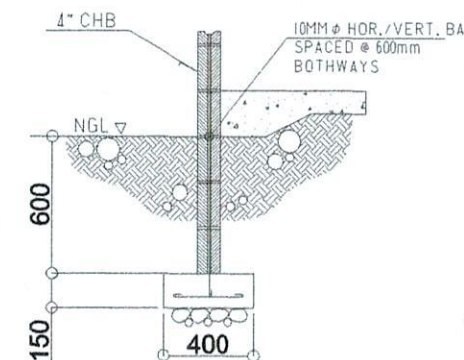

WF DET.



CITY ENGINEER'S
OFFICE

PROJECT TITLE:

CONST. OF MULTI PURPOSE HALL
(CLASSROOM)

LOC: BRGY. PANGPANG, WEST DISTRICT

SORSOGON CITY

DRAWN BY:

Ma Pamela Legaspi

DRAFTING AIDE

RECOMMENDING APPROVAL:


ROEL D. DOMER, C.E./RMP

CITY ENGINEER


APPROVED BY:

MA. ESTER E. HAMOR


CITY MAYOR

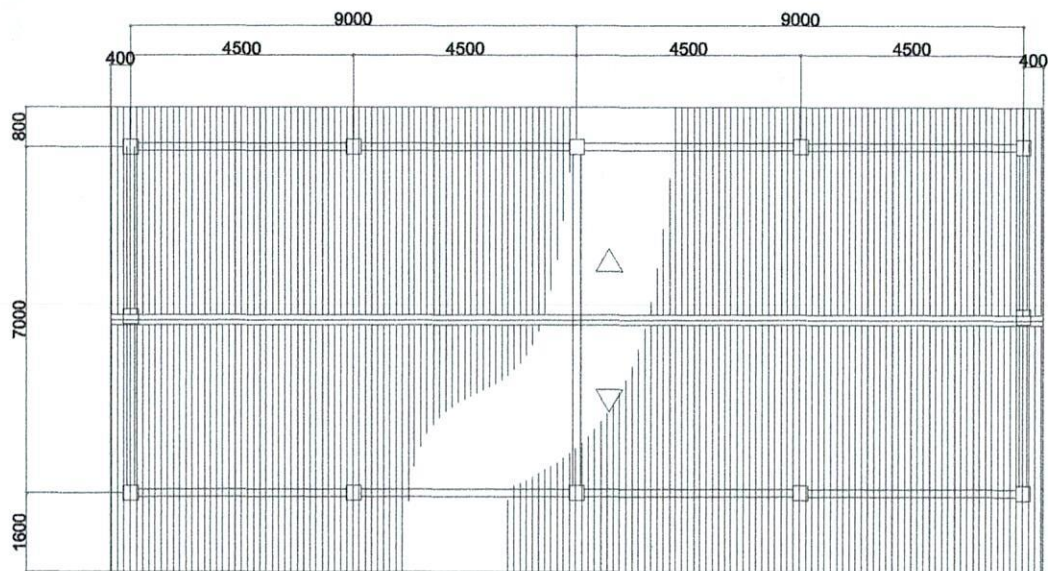

ROOF PLAN
SCALE: 1/200

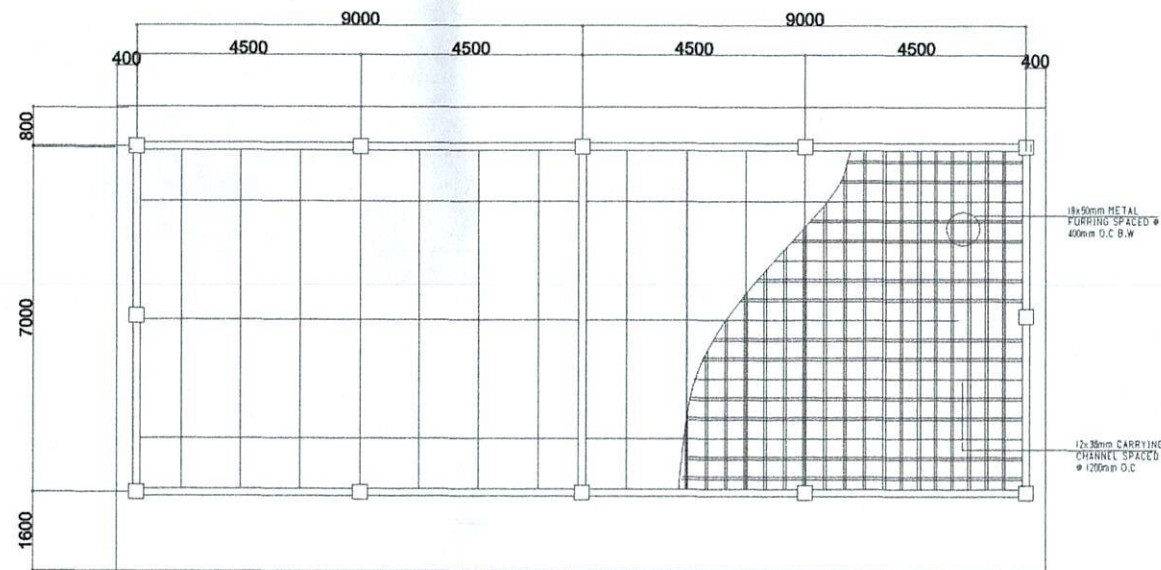

CEILING PLAN
SCALE: 1/200

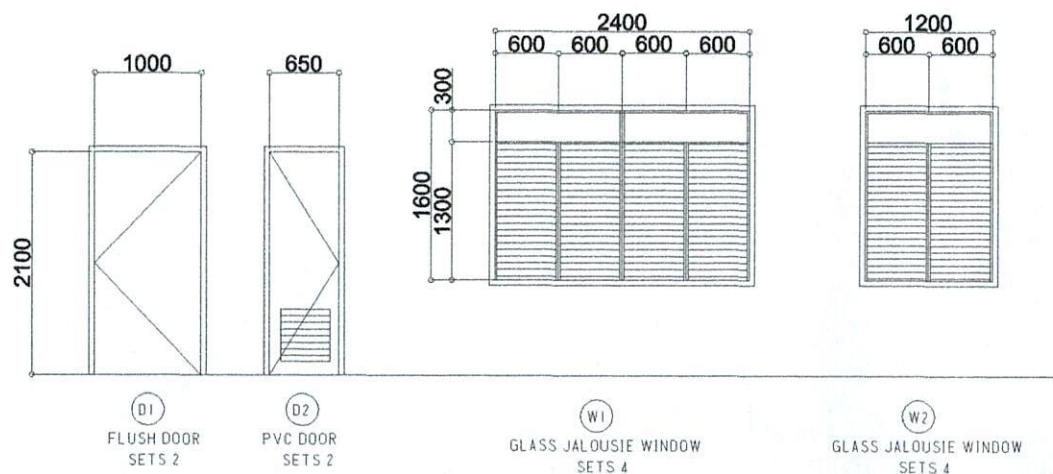

CITY ENGINEER'S
O F F I C E

PROJECT TITLE:

CONST. OF MULTI PURPOSE HALL
(CLASSROOM)

LOC: BRGY. PANGPANG, WEST DISTRICT
SORSOGON CITY

DRAWN BY:


MaPamelaLegaspi
DRAFTING AIDE

RECOMMENDING APPROVAL :


ROEL D. DOMER, C.E./RMP
CITY ENGINEER

APPROVED BY:

MA. ESTER E. HAMOR
CITY MAYOR

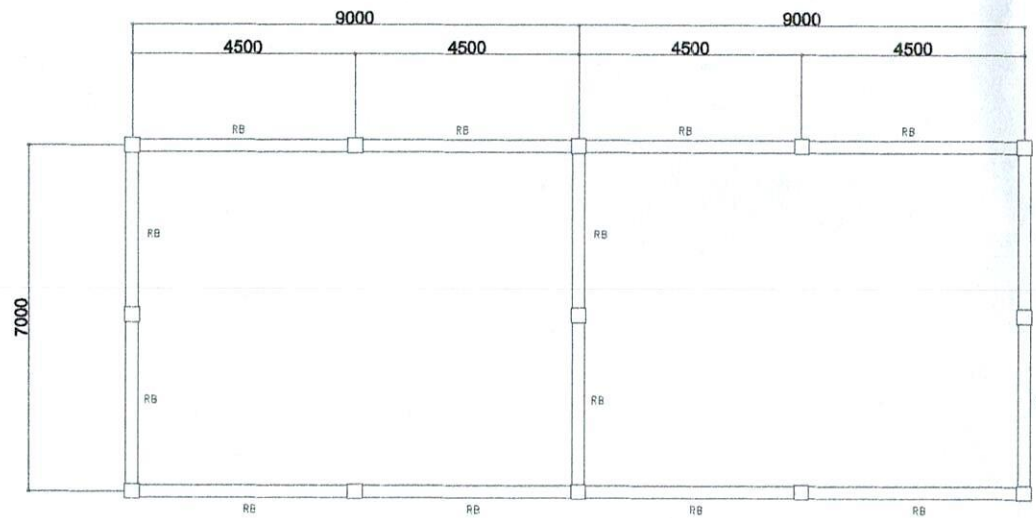

ROOF BEAM LAYOUT
SCALE: 1/8"=1'-0"

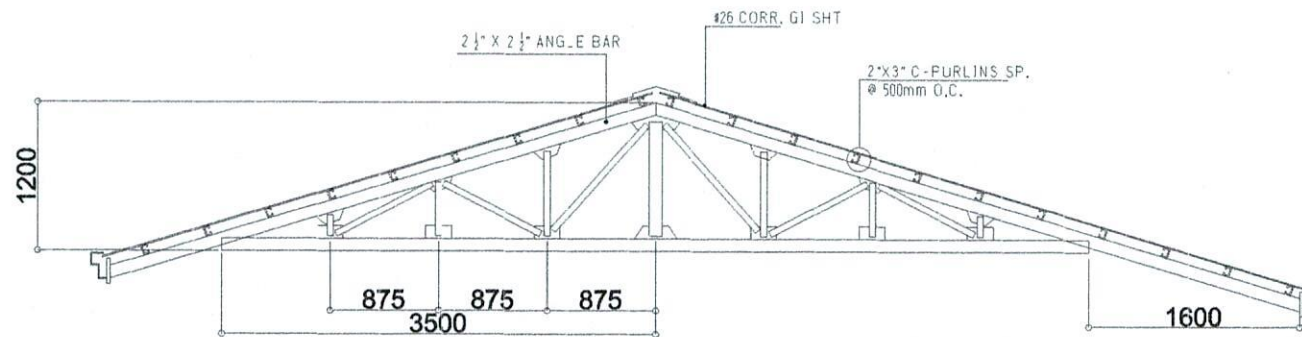

TRUSS DET.
SCALE: 3/8"=1'-0"



CITY ENGINEER'S
O F F I C E

PROJECT TITLE:

CONST. OF MULTI PURPOSE HALL
(CLASSROOM)

LOC: BRGY. PANGPANG, WEST DISTRICT

SORSOGON CITY

DRAWN BY:

Ma Pamela Legaspi


DRAFTING AIDE

RECOMMENDING APPROVAL:

ROEL D. ZOMER, C.E./RMP
CITY ENGINEER

APPROVED BY:

MA. ESTER E. HAMOR
CITY MAYOR

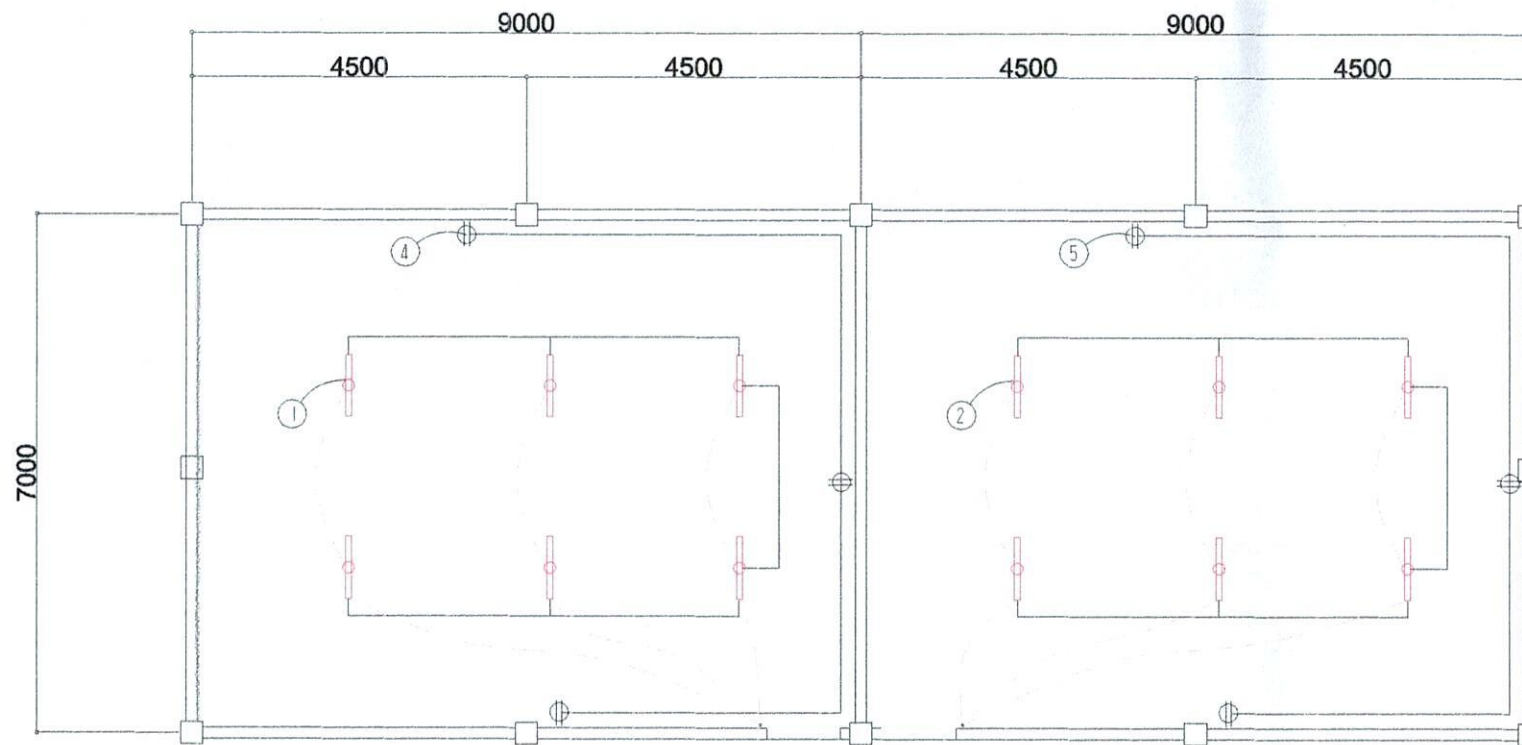

ELECTRICAL PLAN
SCALE: 1/25HTS

SCHEDULE OF LOADS

CIRCUIT NO.	DESCRIPTION	NO. OF LOADS	VOLTS	WATTS	AMP	SIZE OF WIRE	SIZE OF CONDUIT
1	LIGHTING OUTLET	6	230	600	2.60	2-2.0mm ² THW	15mmØ
2	LIGHTING OUTLET	6	230	600	2.60	2-2.0mm ² THW	15mmØ
3	CONVENIENCE OUTLET	3	230	540	2.34	2-3.5mm ² THW	20mmØ
4	CONVENIENCE OUTLET	3	230	540	2.34	2-3.5mm ² THW	20mmØ
	TOTAL				9.88		

ELECTRICAL NOTES

ALL ELECTRICAL WORKS SHALL BE DONE IN ACCORDANCE WITH THE LATEST RULES AND REGULATIONS OF THE PHIL. ELECTRICAL CODE AS WELL AS THE LOCAL AUTHORITY CONCERNED AND THE LOCAL POWER COMPANY.

ALL ELECTRICAL MATERIALS TO BE USED SHALL BE NEED & APPROVED TYPE FOR LOCATION & PURPOSE

MOUNTING HEIGHTS SHALL BE AS FOLLOWS:

- a. LIGHT CONTROL SWITCH- 1.35M ABOVE FIN. FLR. LINE AT CENTER
- b. CONVENIENCE OUTLET-ABOVE 1.0M ABOVE FIN. FLR. LINE AT CENTER
- c. PANEL BOARD- 2.0 M ABOVE FIN. FLR. LINE

ALL ELECTRICAL WORKS SHALL BE UNDER THE DIRECT & IMMEDIATE SUPERVISION OF A DULY LICENSED ELECTRICAL ENGINEER OR REGISTERED MASTER ELECTRICIAN



**CITY ENGINEER'S
OFFICE**

PROJECT TITLE:

CONST. OF MULTI PURPOSE HALL
(CLASSROOM)

LOC: BRGY. PANGPANG, WEST DISTRICT

SORSOGON CITY

DRAWN BY:

Ma Pamela Legaspi

DRAFTING AIDE

RECOMMENDING APPROVAL :



ROEL D. DOMER, C.E./RMP

CITY ENGINEER

APPROVED BY:

MA. ESTER E. HAMOR

CITY MAYOR

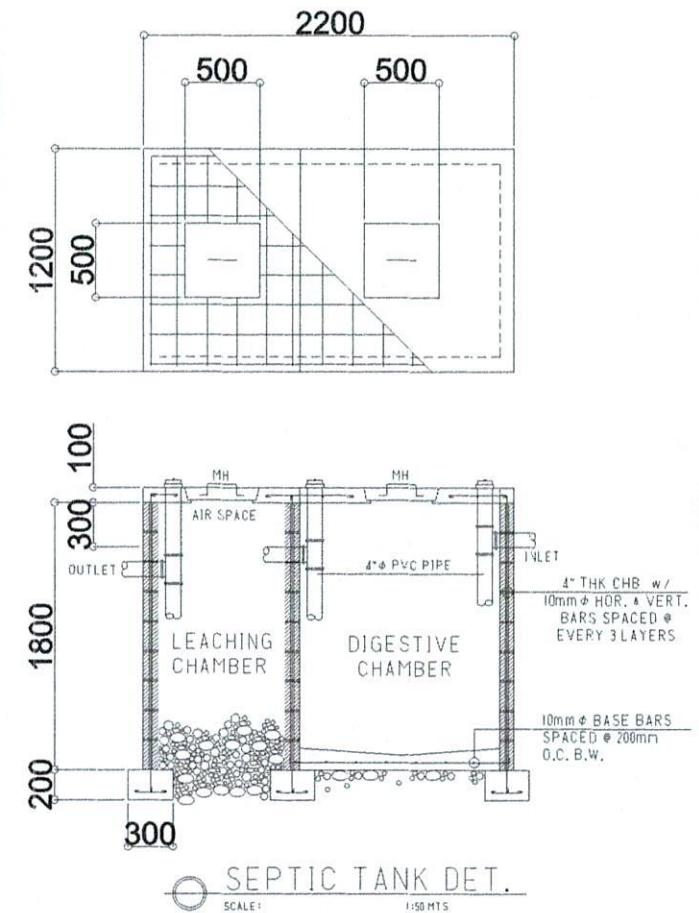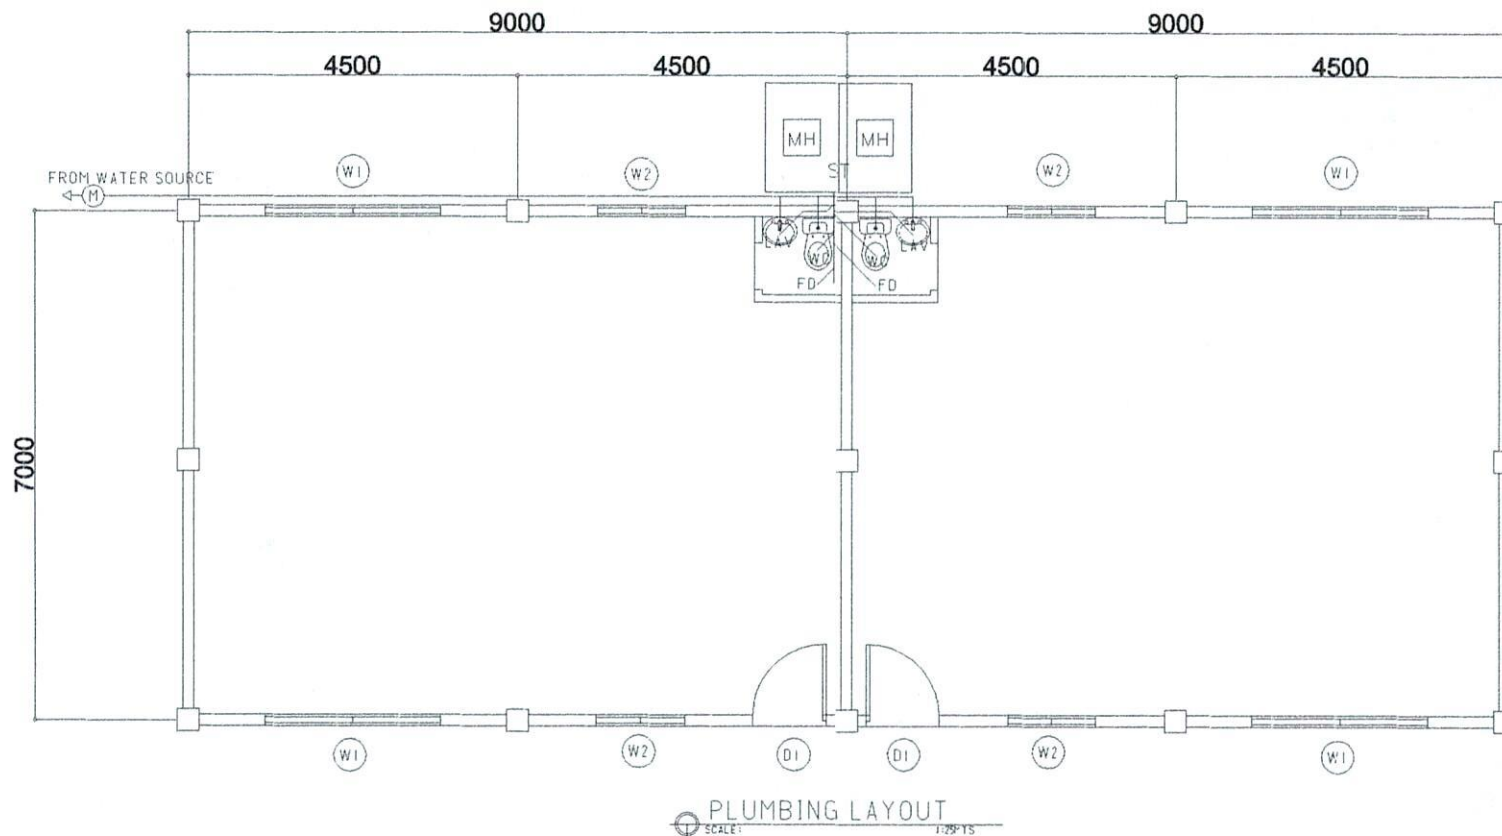

CITY ENGINEER'S
OFFICE

PROJECT TITLE:

CONST. OF MULTI PURPOSE HALL
(CLASSROOM)

LOC: BRGY. PANGPANG, WEST DISTRICT
SORSOGON CITY

DRAWN BY:

MaPamela Legaspi
DRAFTING AIDE

RECOMMENDING APPROVAL:

ROEL D. DOMER, C.E./RMP
CITY ENGINEER

APPROVED BY:

MA. ESTER E. HAMOR
CITY MAYOR